
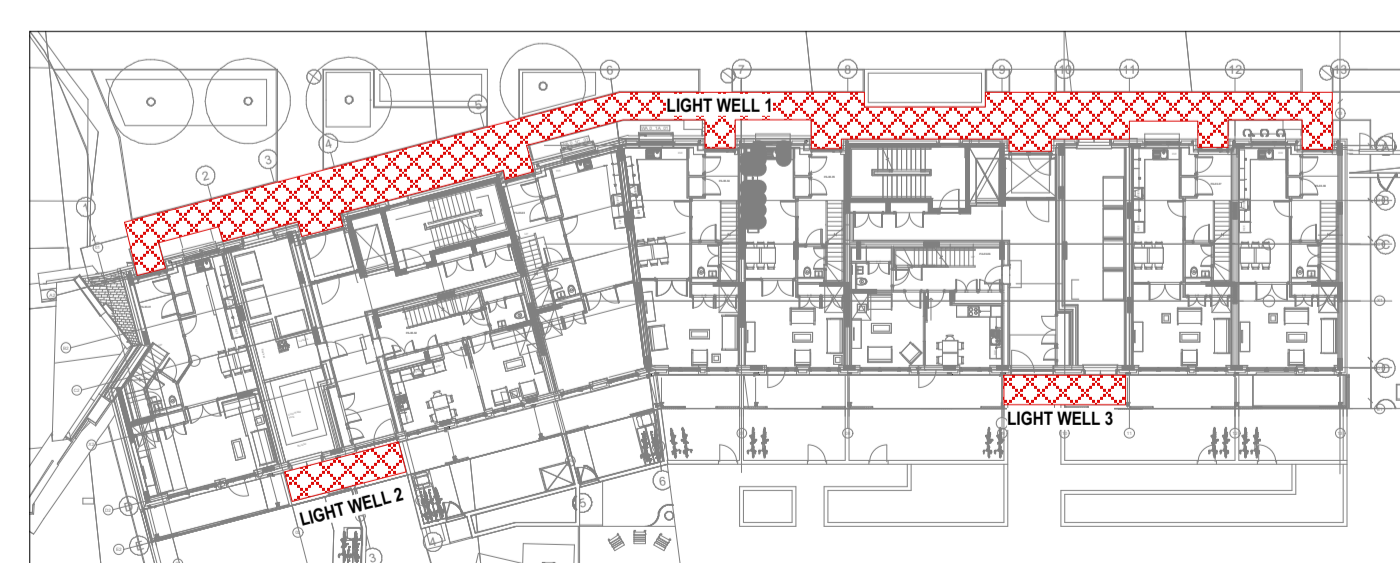


LEGEND:

- Ⓐ IP65 WALL MOUNTED DOWN LED LIGHT. MOUNTED AT 2400mm FROM AFL TO CENTRE OF LIGHT. TYPE AS SCHEDULE
- Ⓑ IP65 WALL MOUNTED UP/DOWN LED LIGHT. MOUNTED AT 3000mm FROM AFL TO CENTRE OF LIGHT. TYPE AS SCHEDULE
- Ⓔ EMERGENCY LIGHT CONVERSION UNIT ADDED TO LIGHT FITTING TO GIVE 3 HOURS DURATION BATTERY AND INVERTER CHARGER UNIT

Isolines

- 1.0 lx
- 2.0 lx
- 4.0 lx
- 6.0 lx
- 8.0 lx
- 10.0 lx
- 14.0 lx
- 16.0 lx
- 20.0 lx

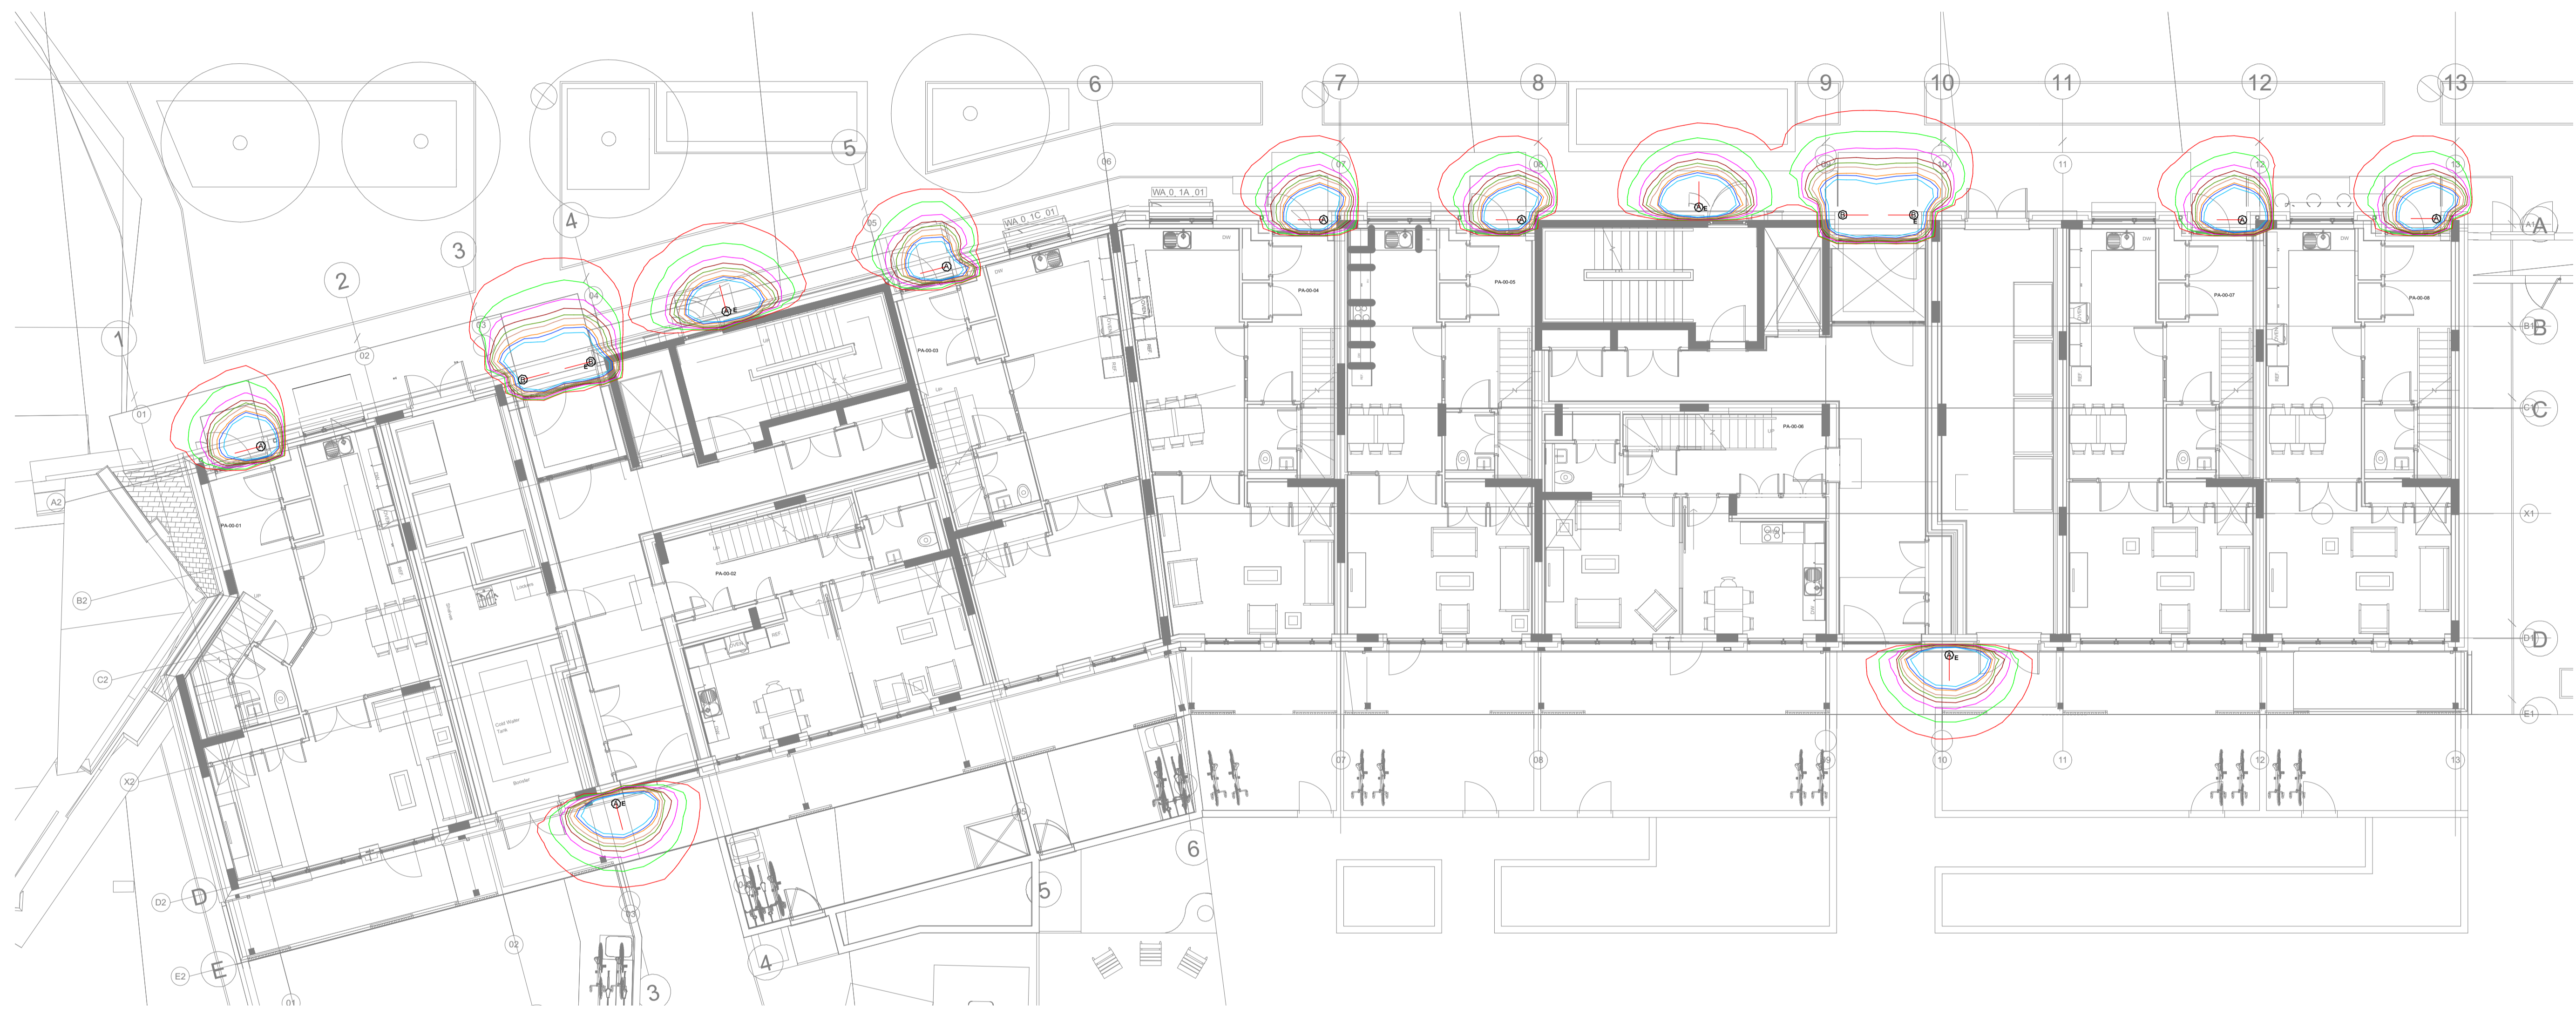

Ground Floor Key Plan

Revision	Amendment Details	Date	By



Job Name:
Agar Grove Block A

Title:
External Lighting Layout

Scale	Date	Checked	Drawn by	Approved
1:100 @ A1	Aug 15	M. R.	F. W.	M. R.
Drp. No:	RA5494/4003		Revision	-

ROBINSON ASSOCIATES
 CHARTERED BUILDING SERVICES ENGINEERS
 www.robinsonengineers.co.uk
 Telephone : 0203 637 1122
 Unit 1, 8 Enterprise Way
 London SW18 1FZ