
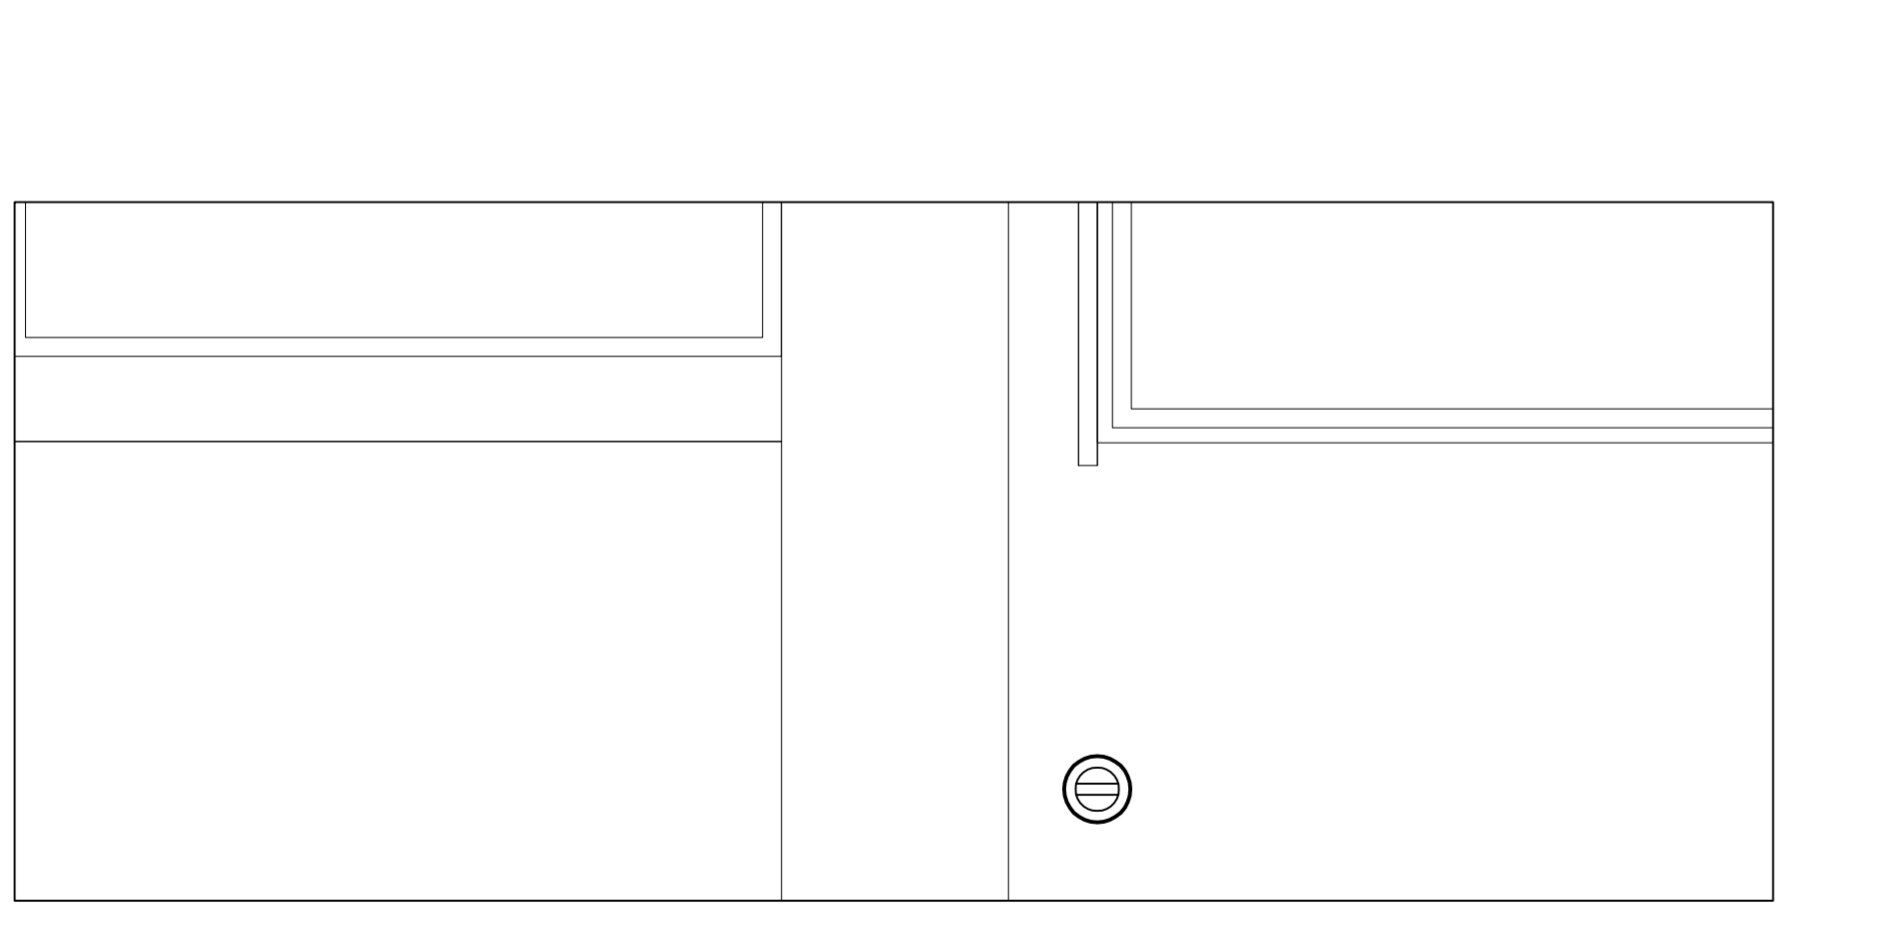
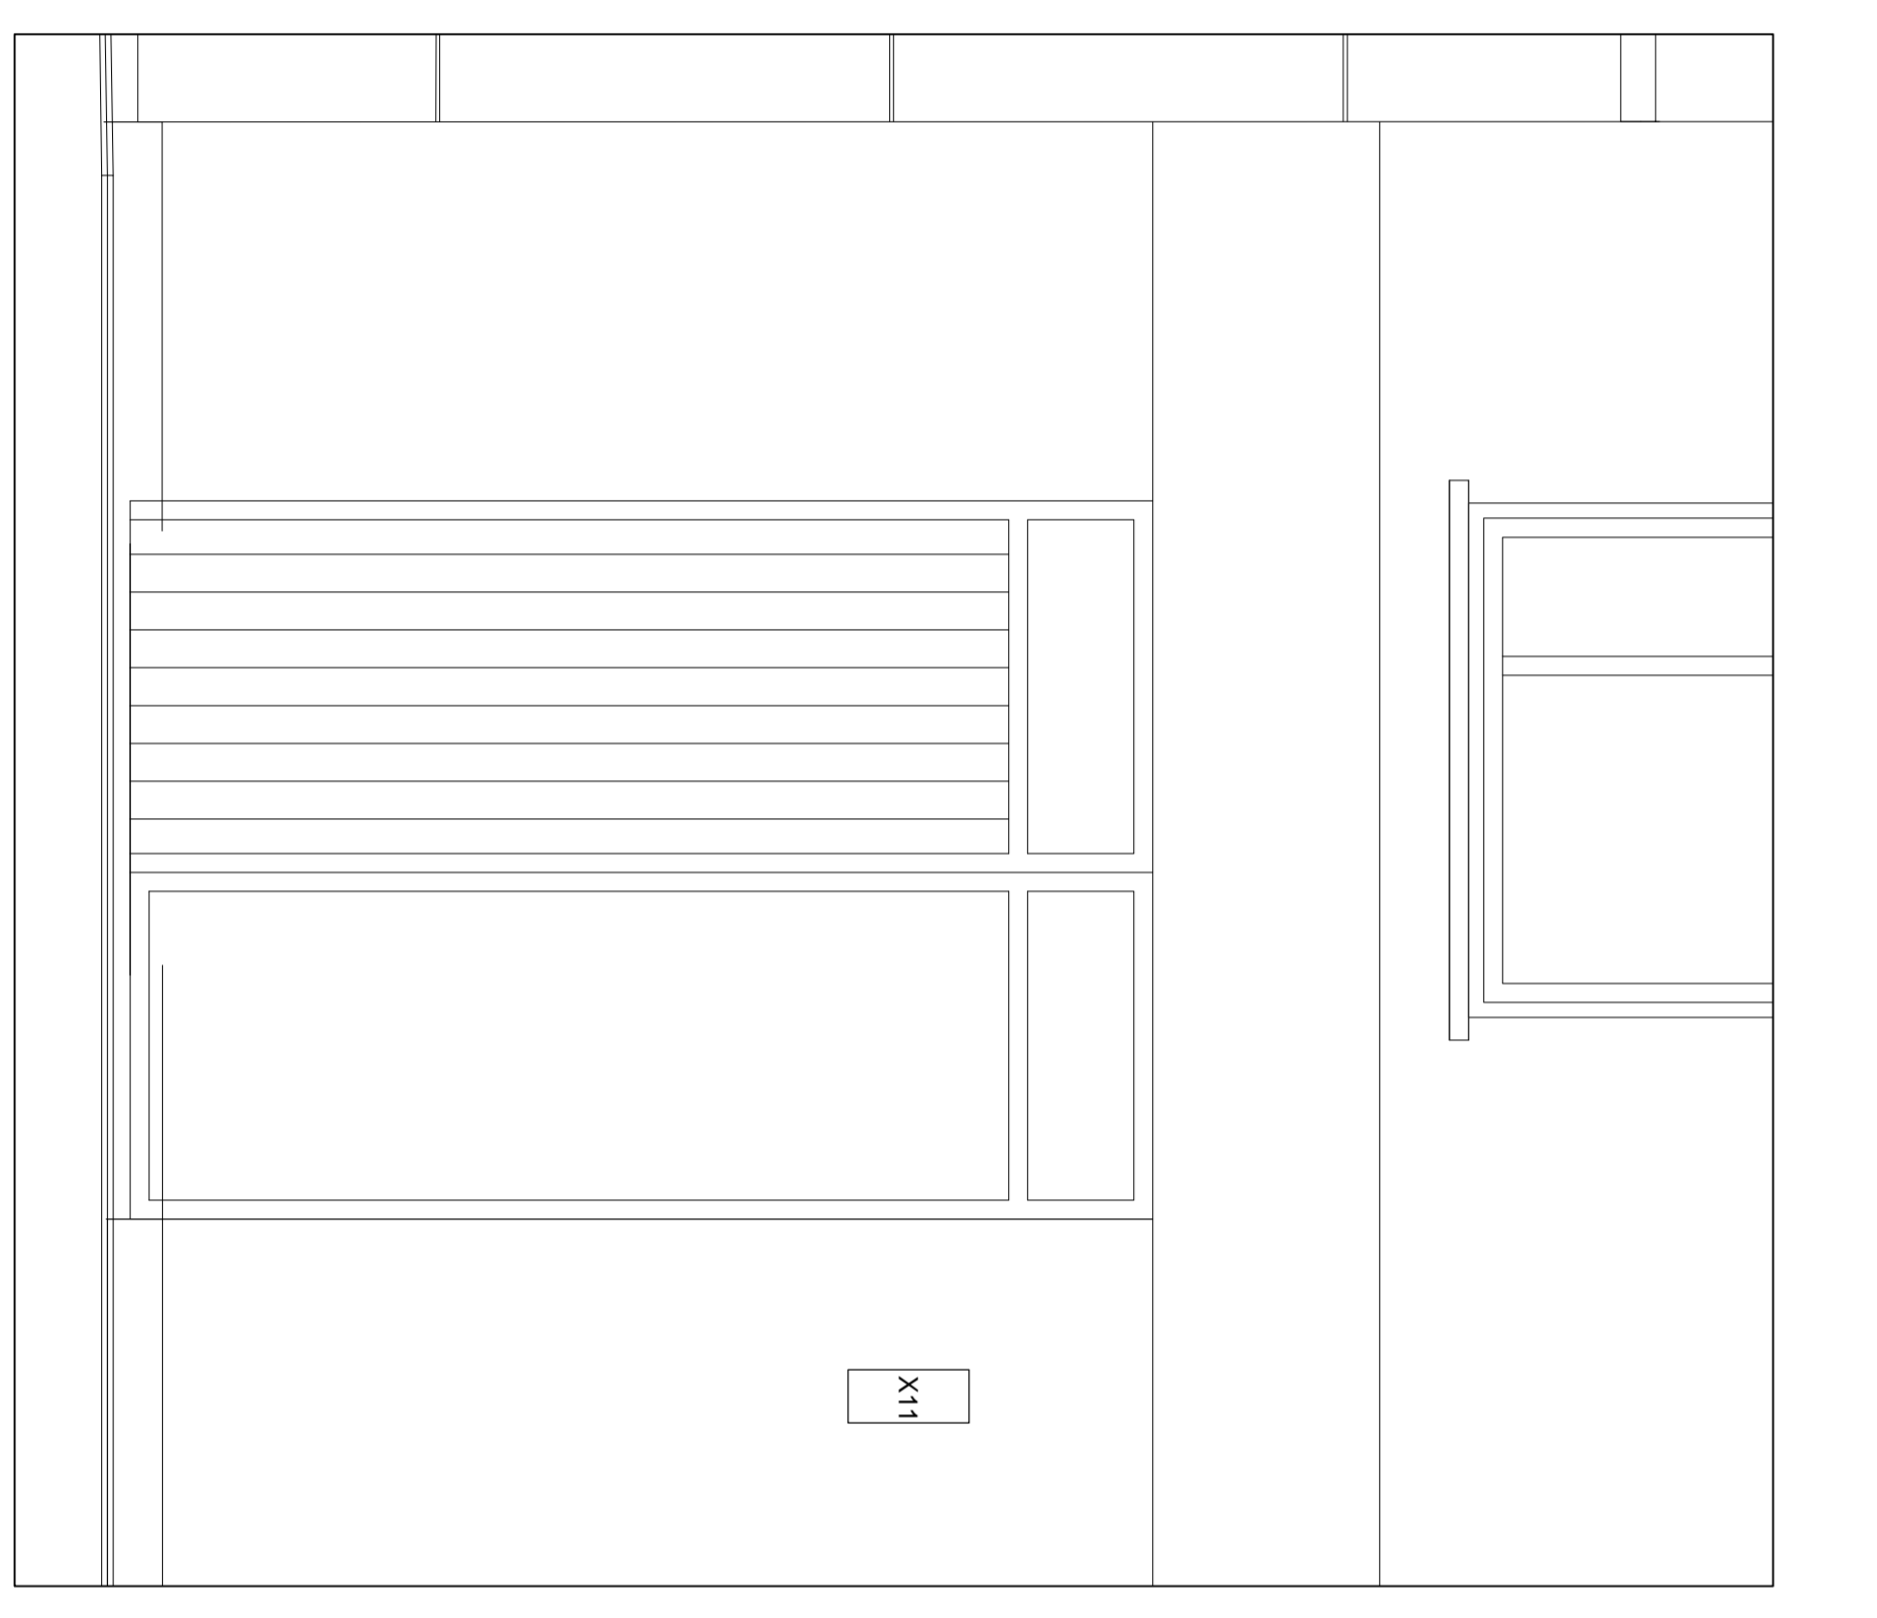
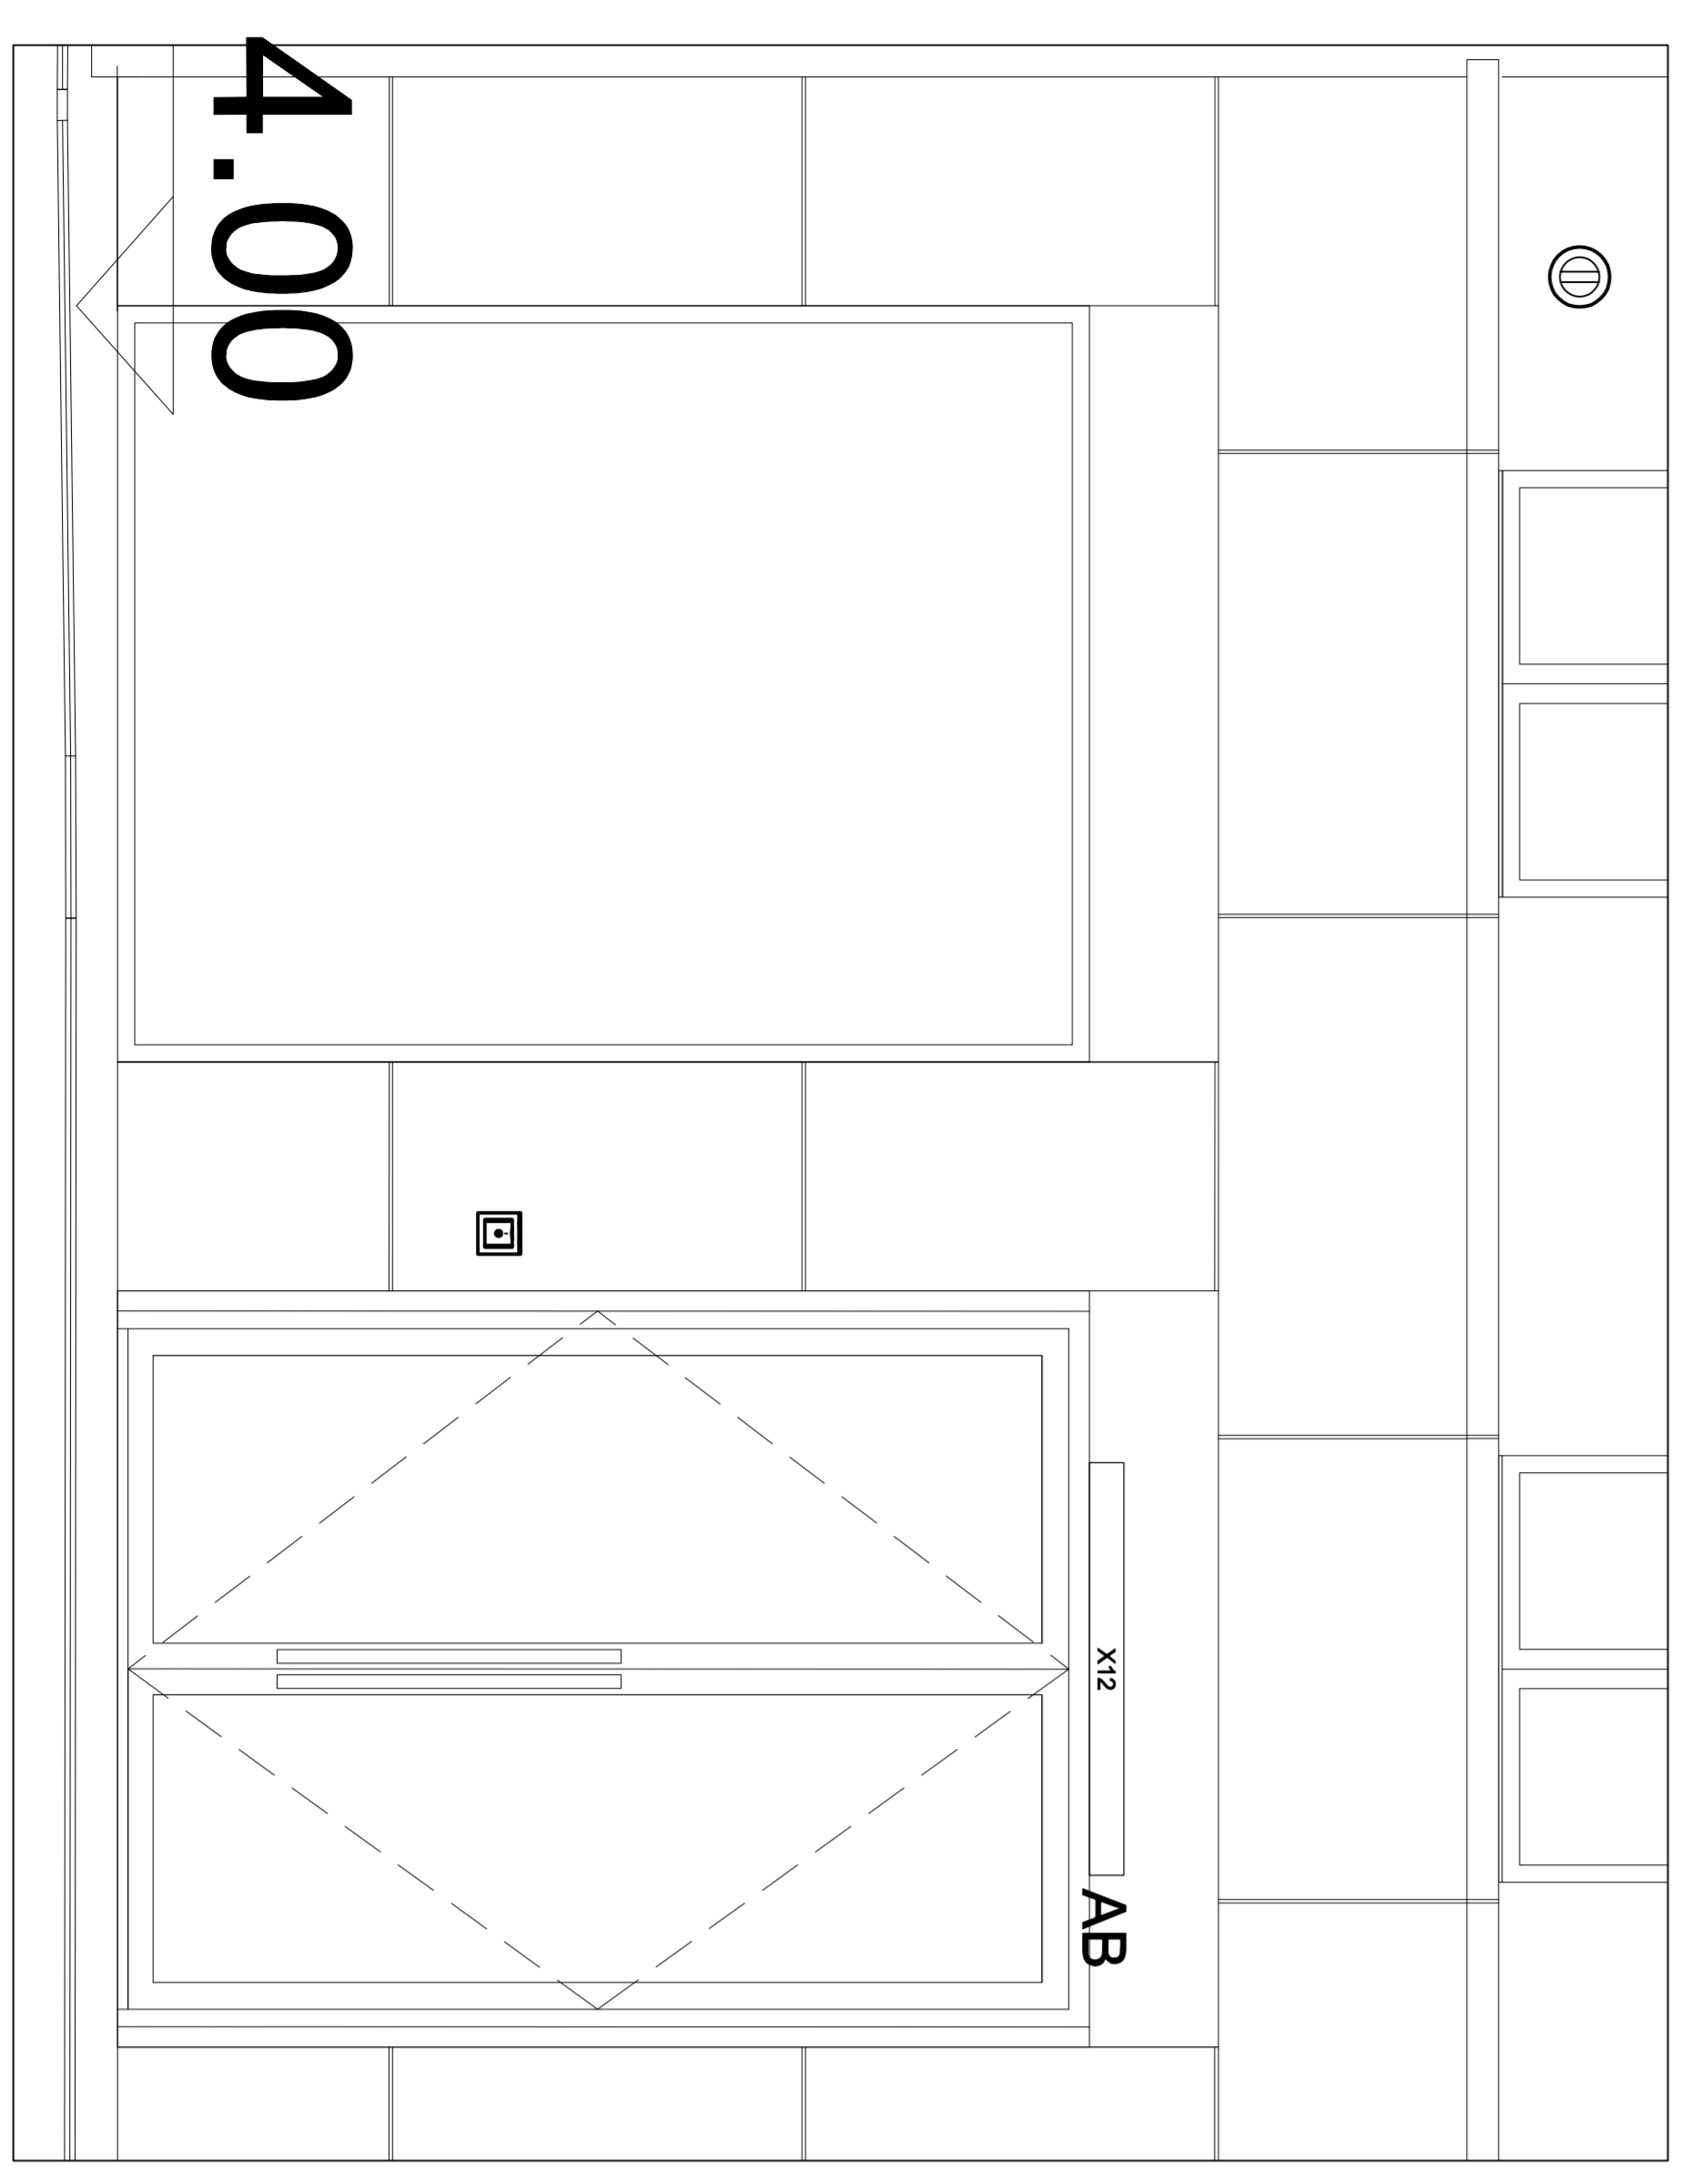
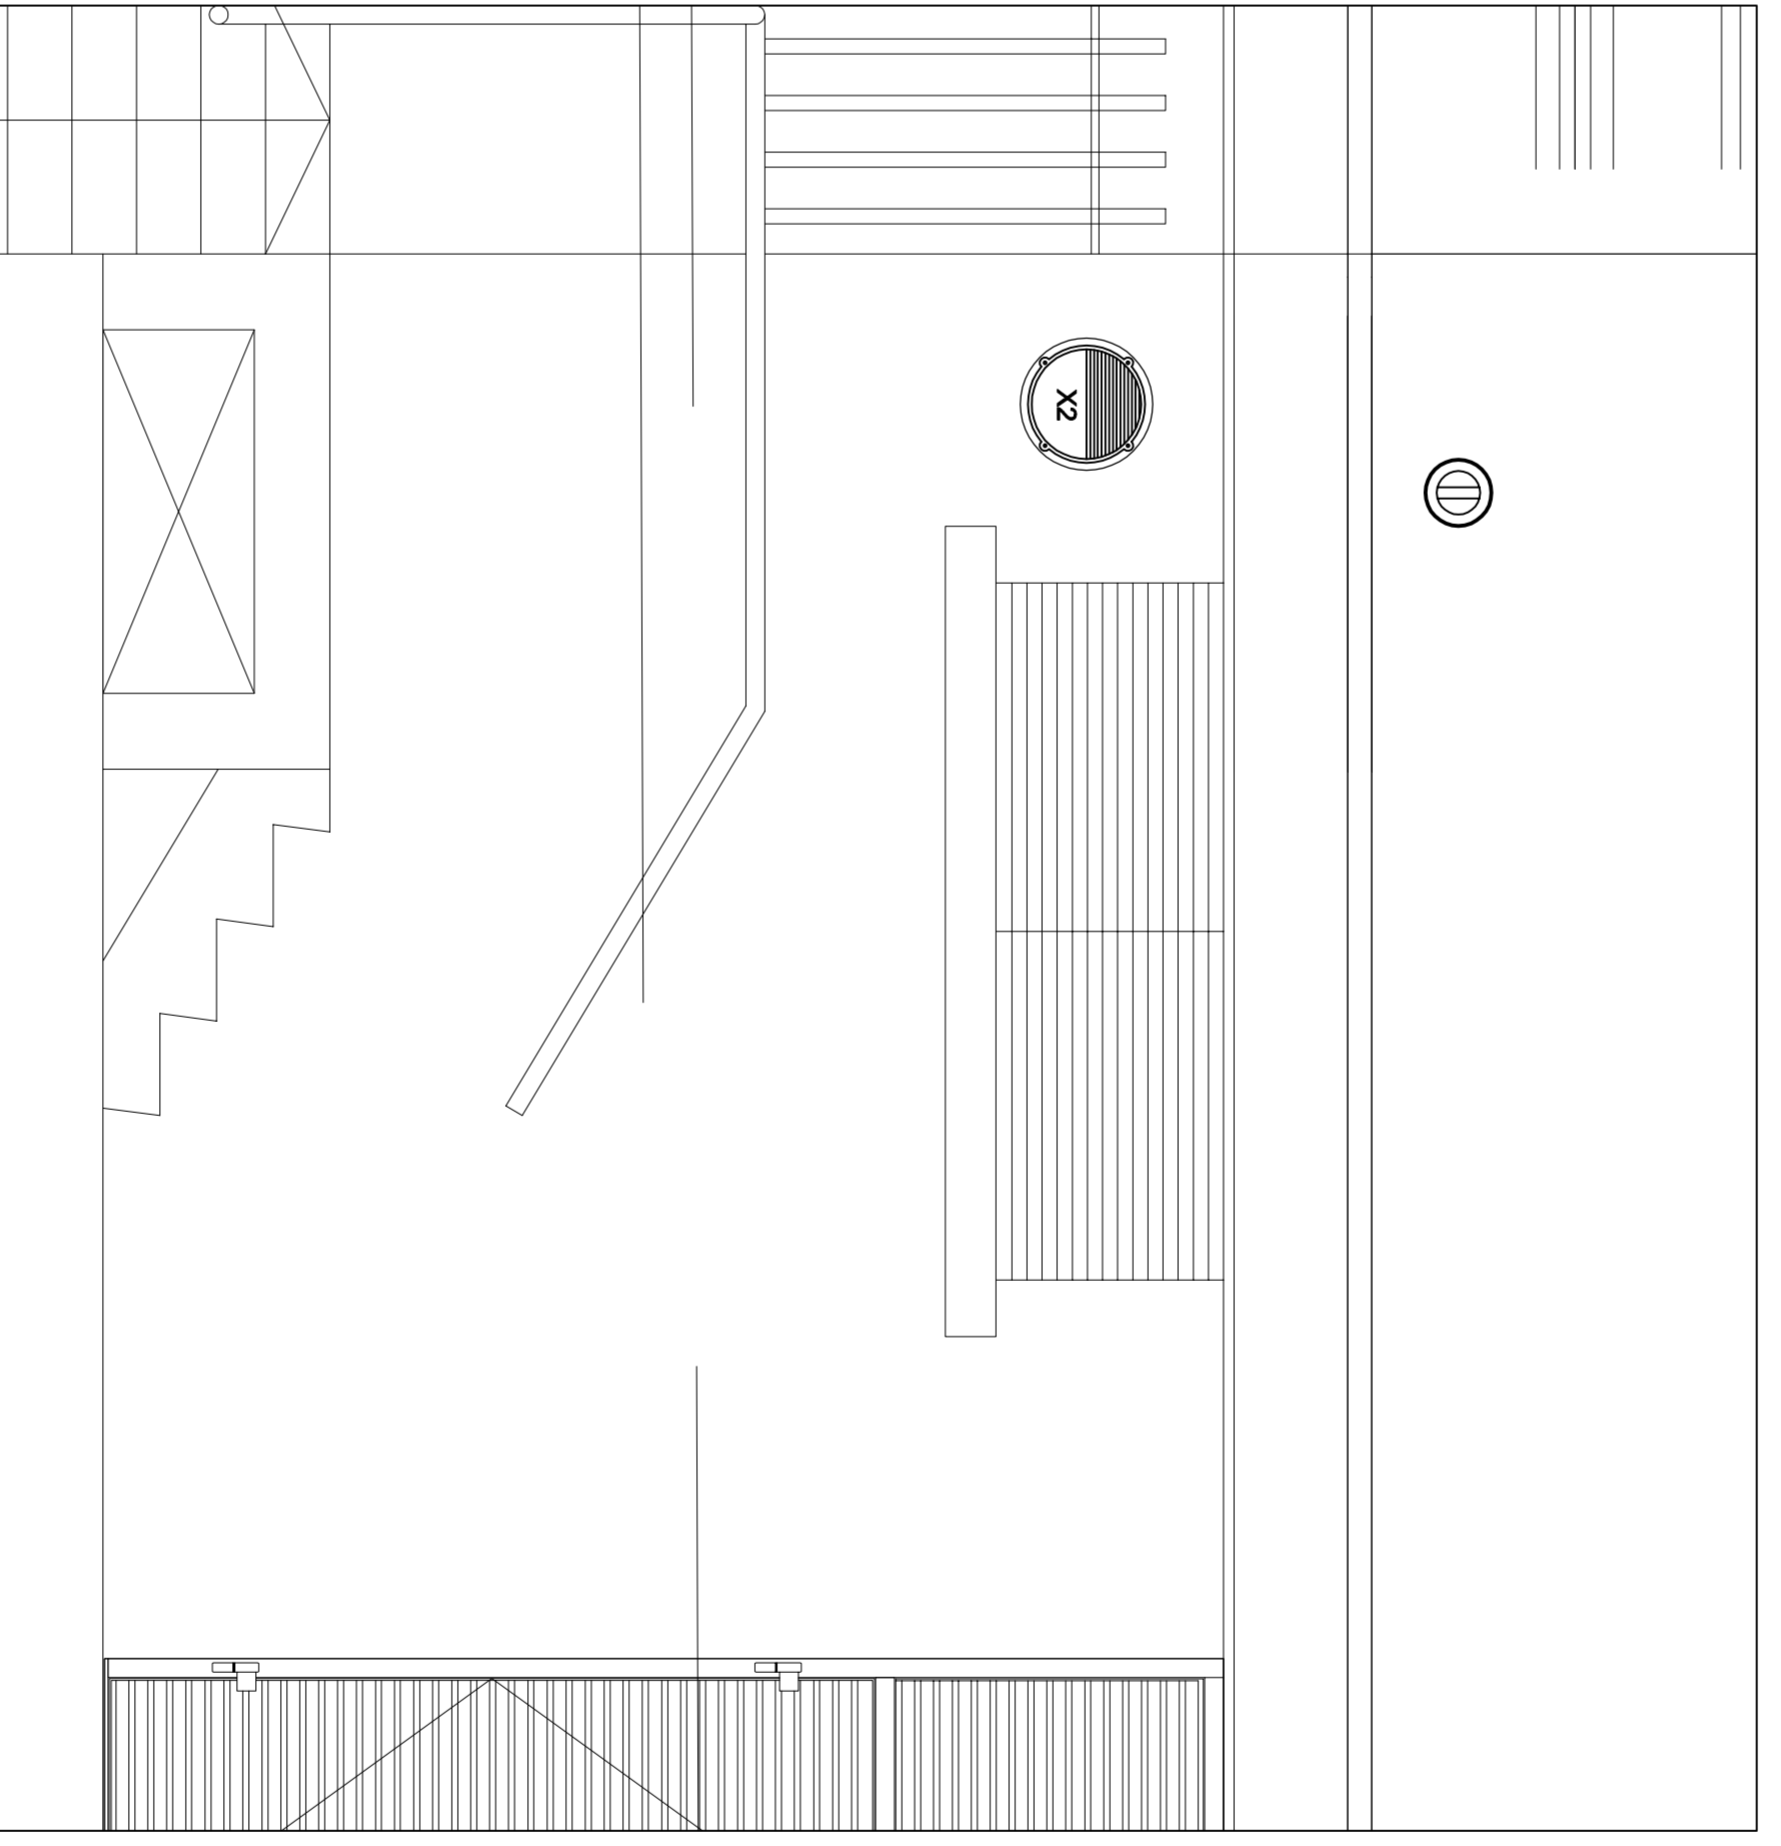
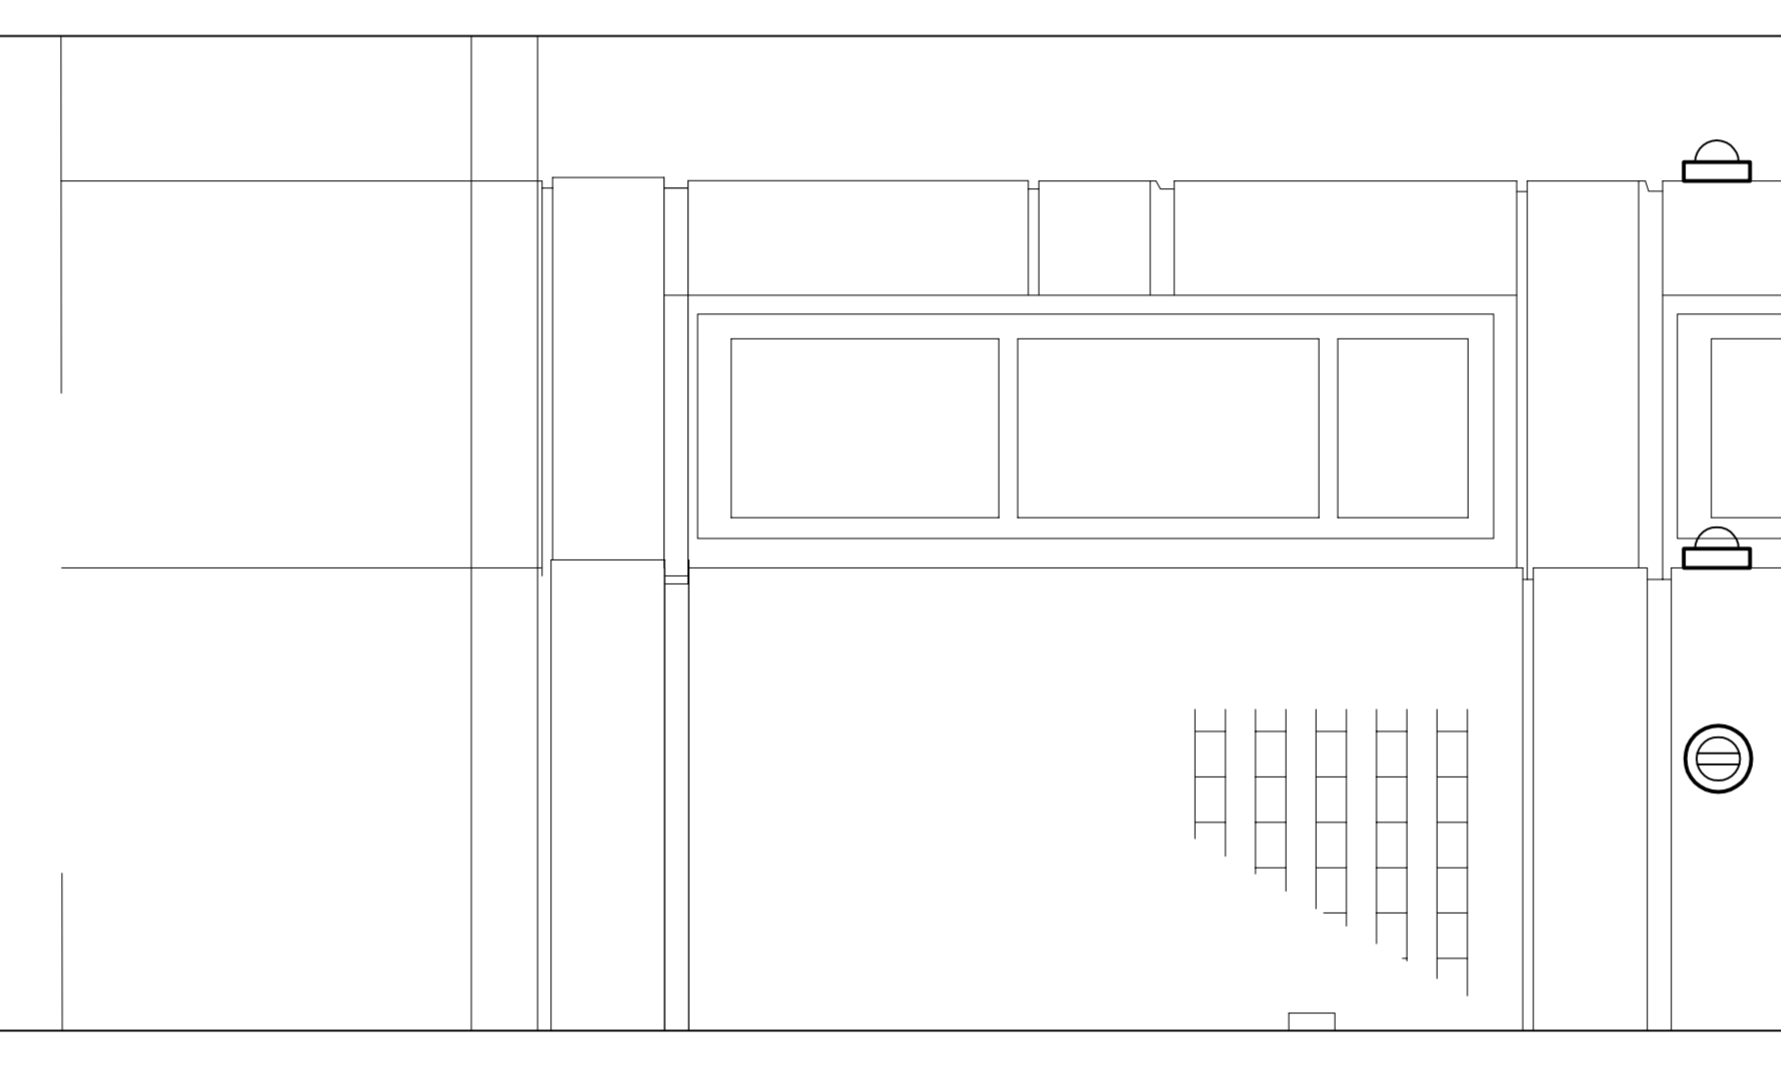
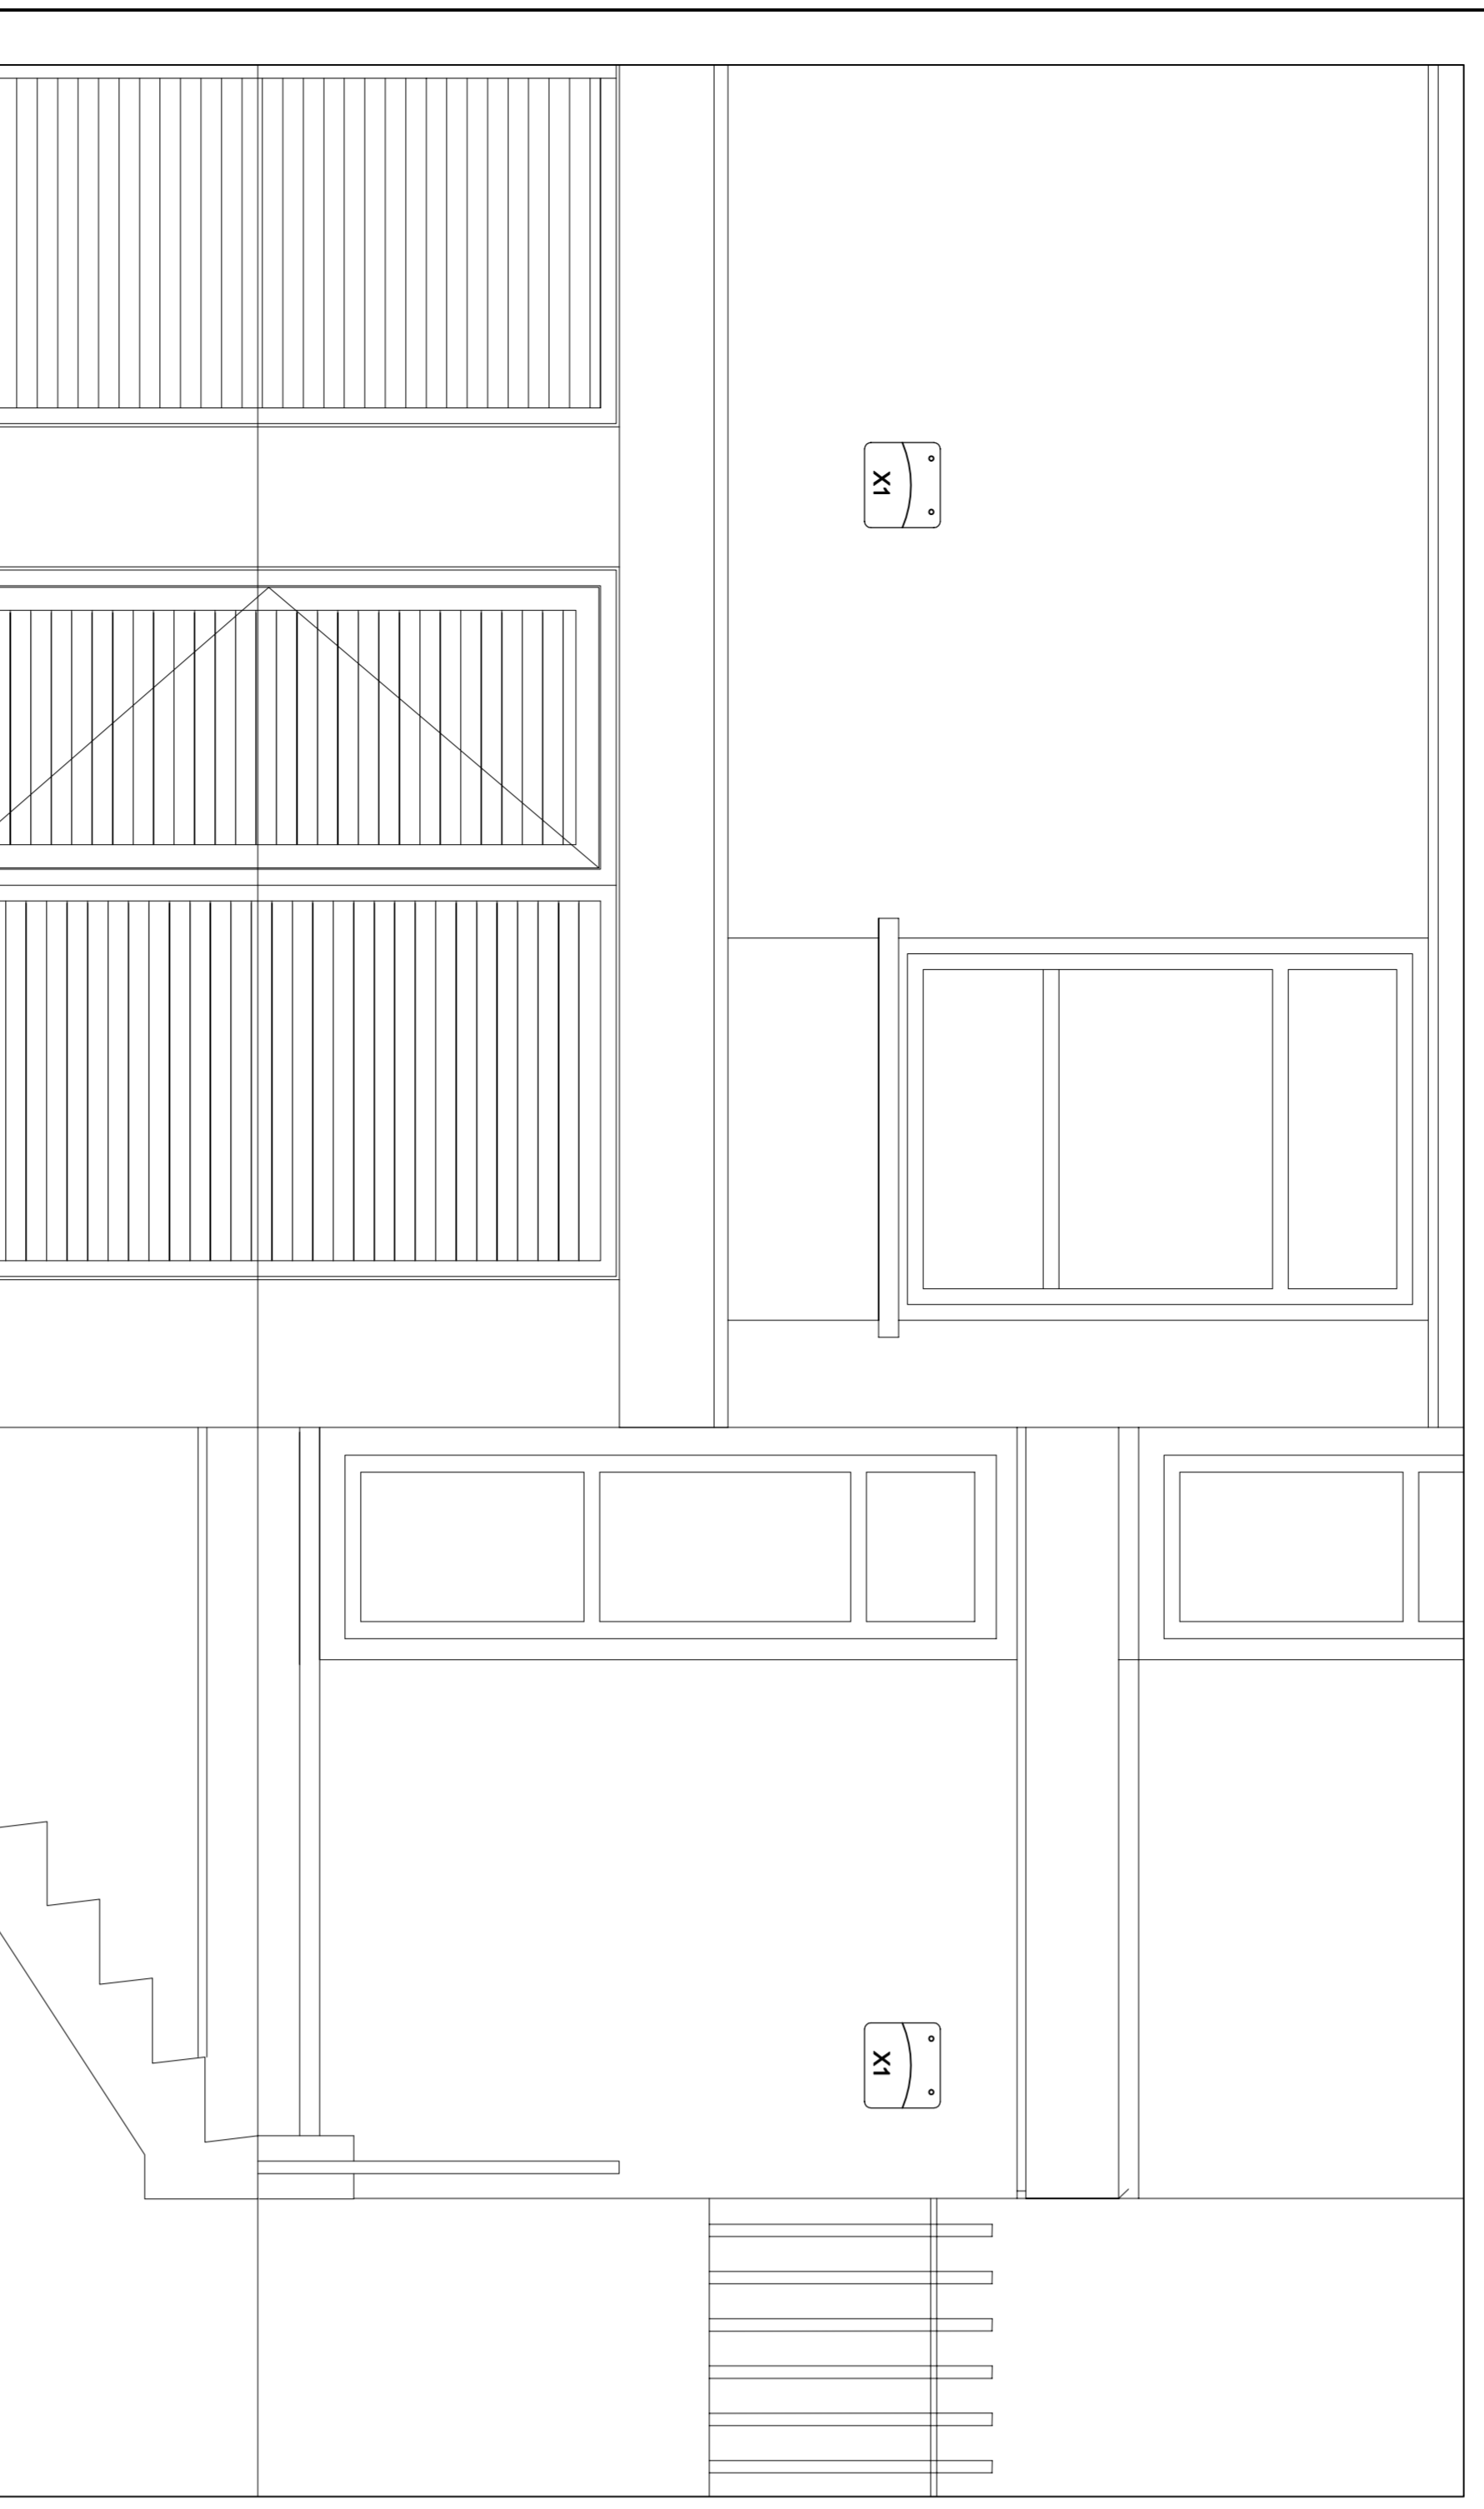
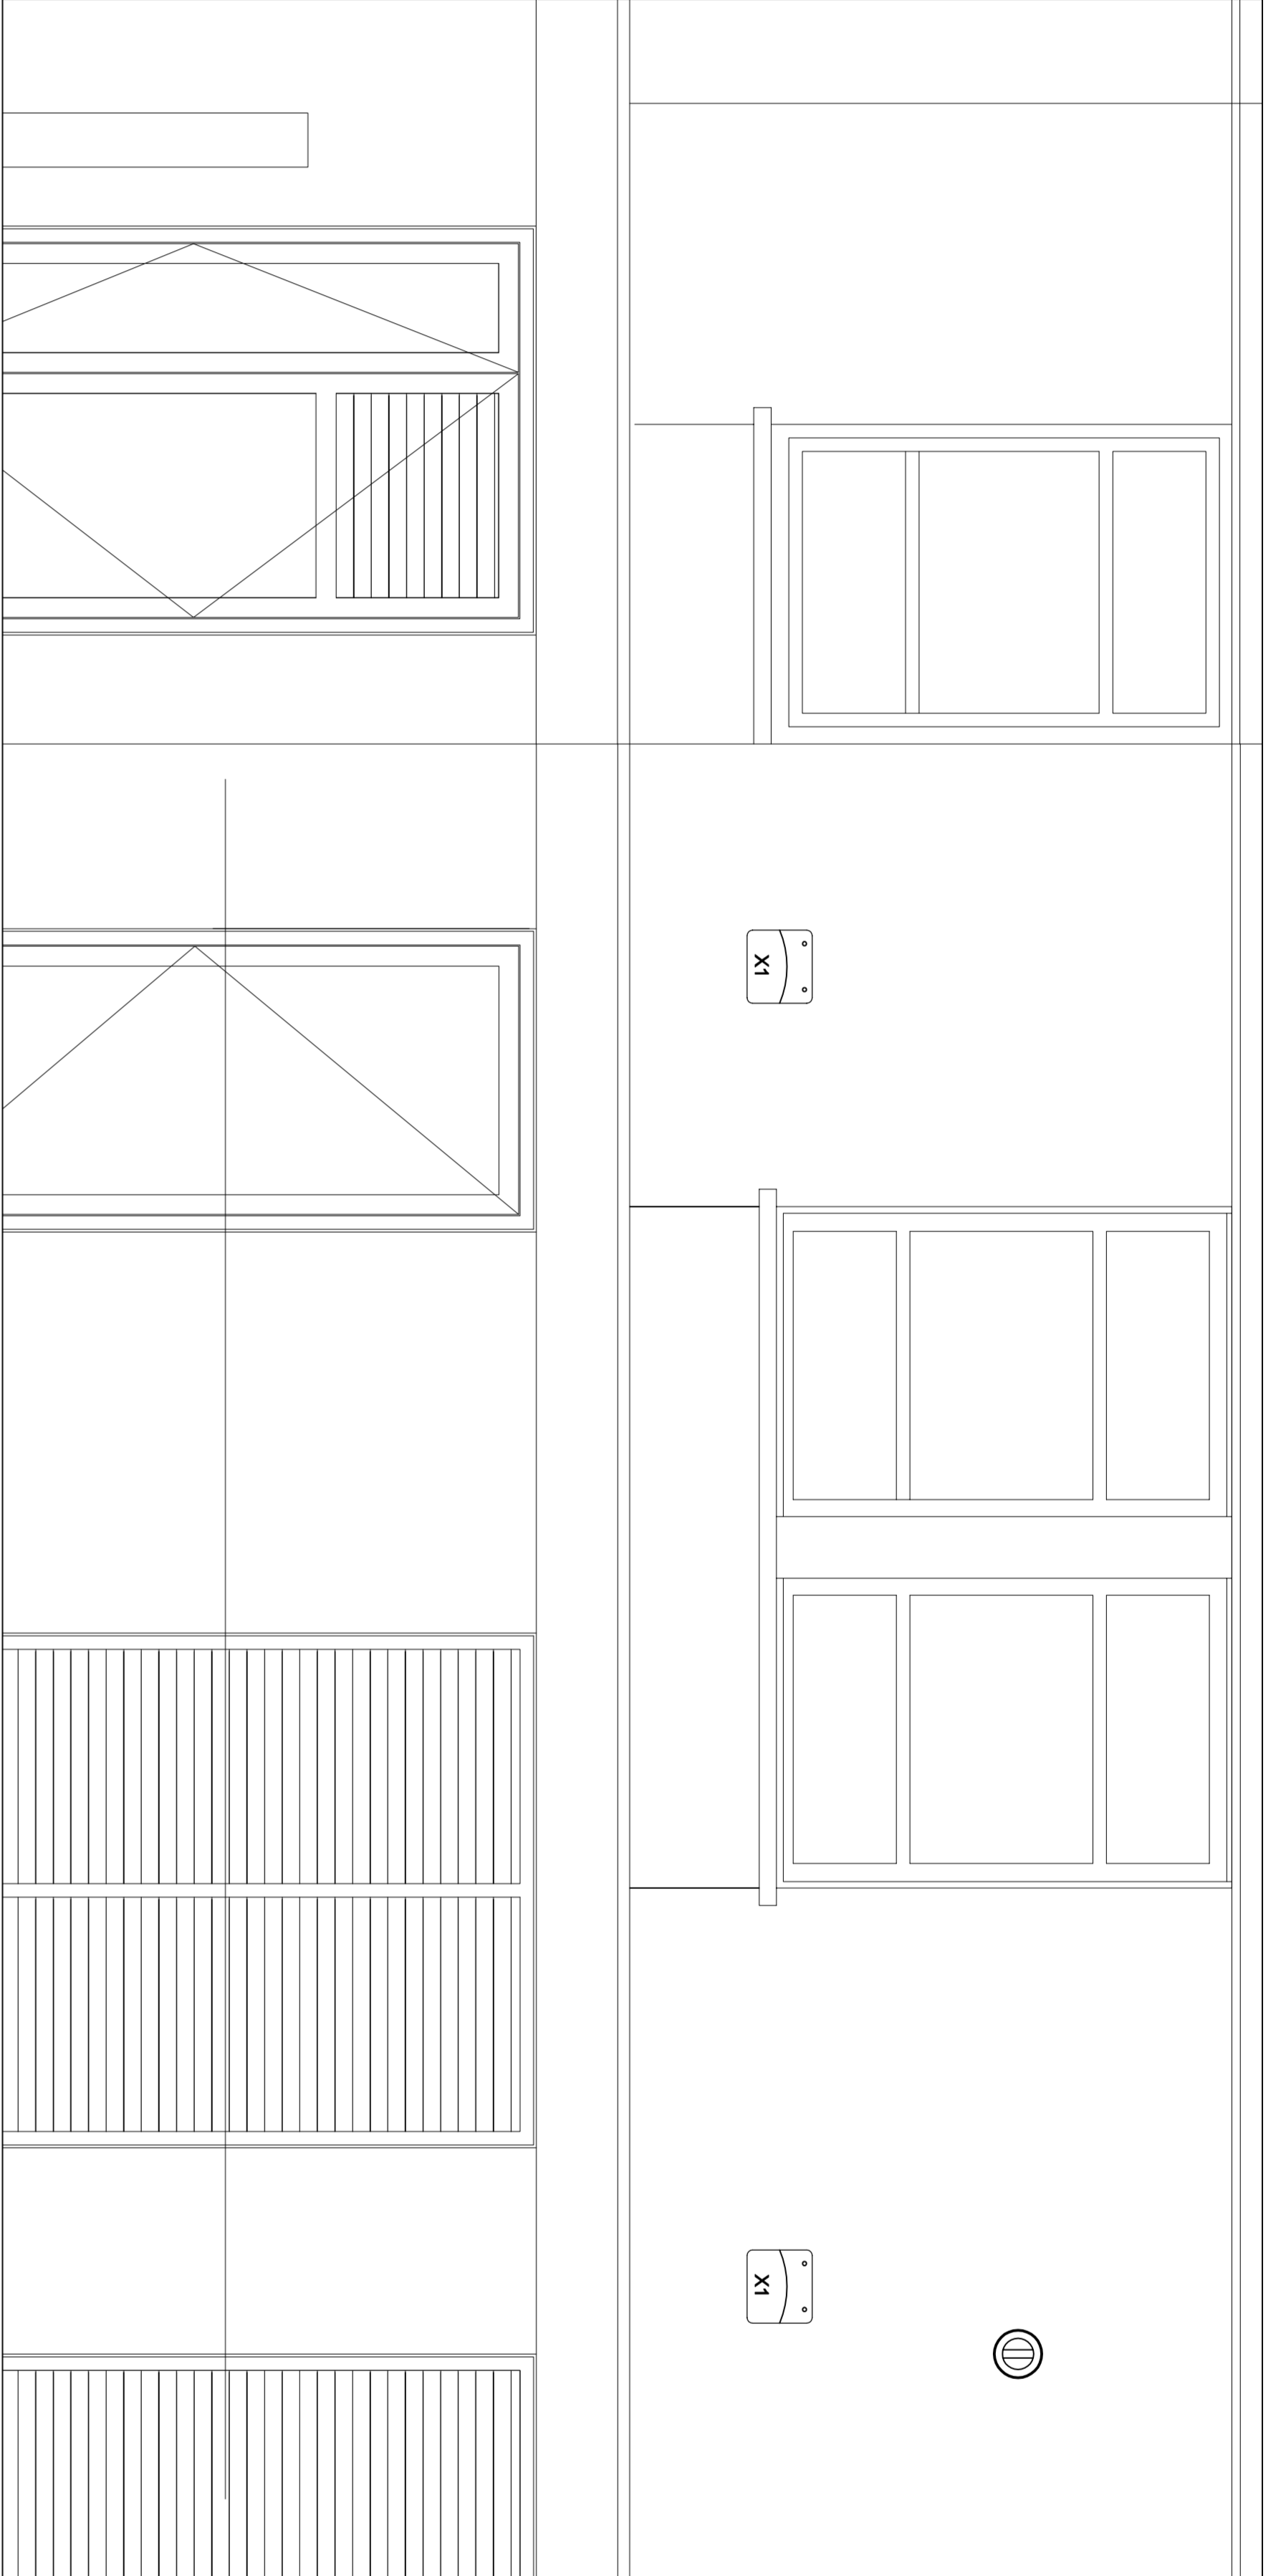
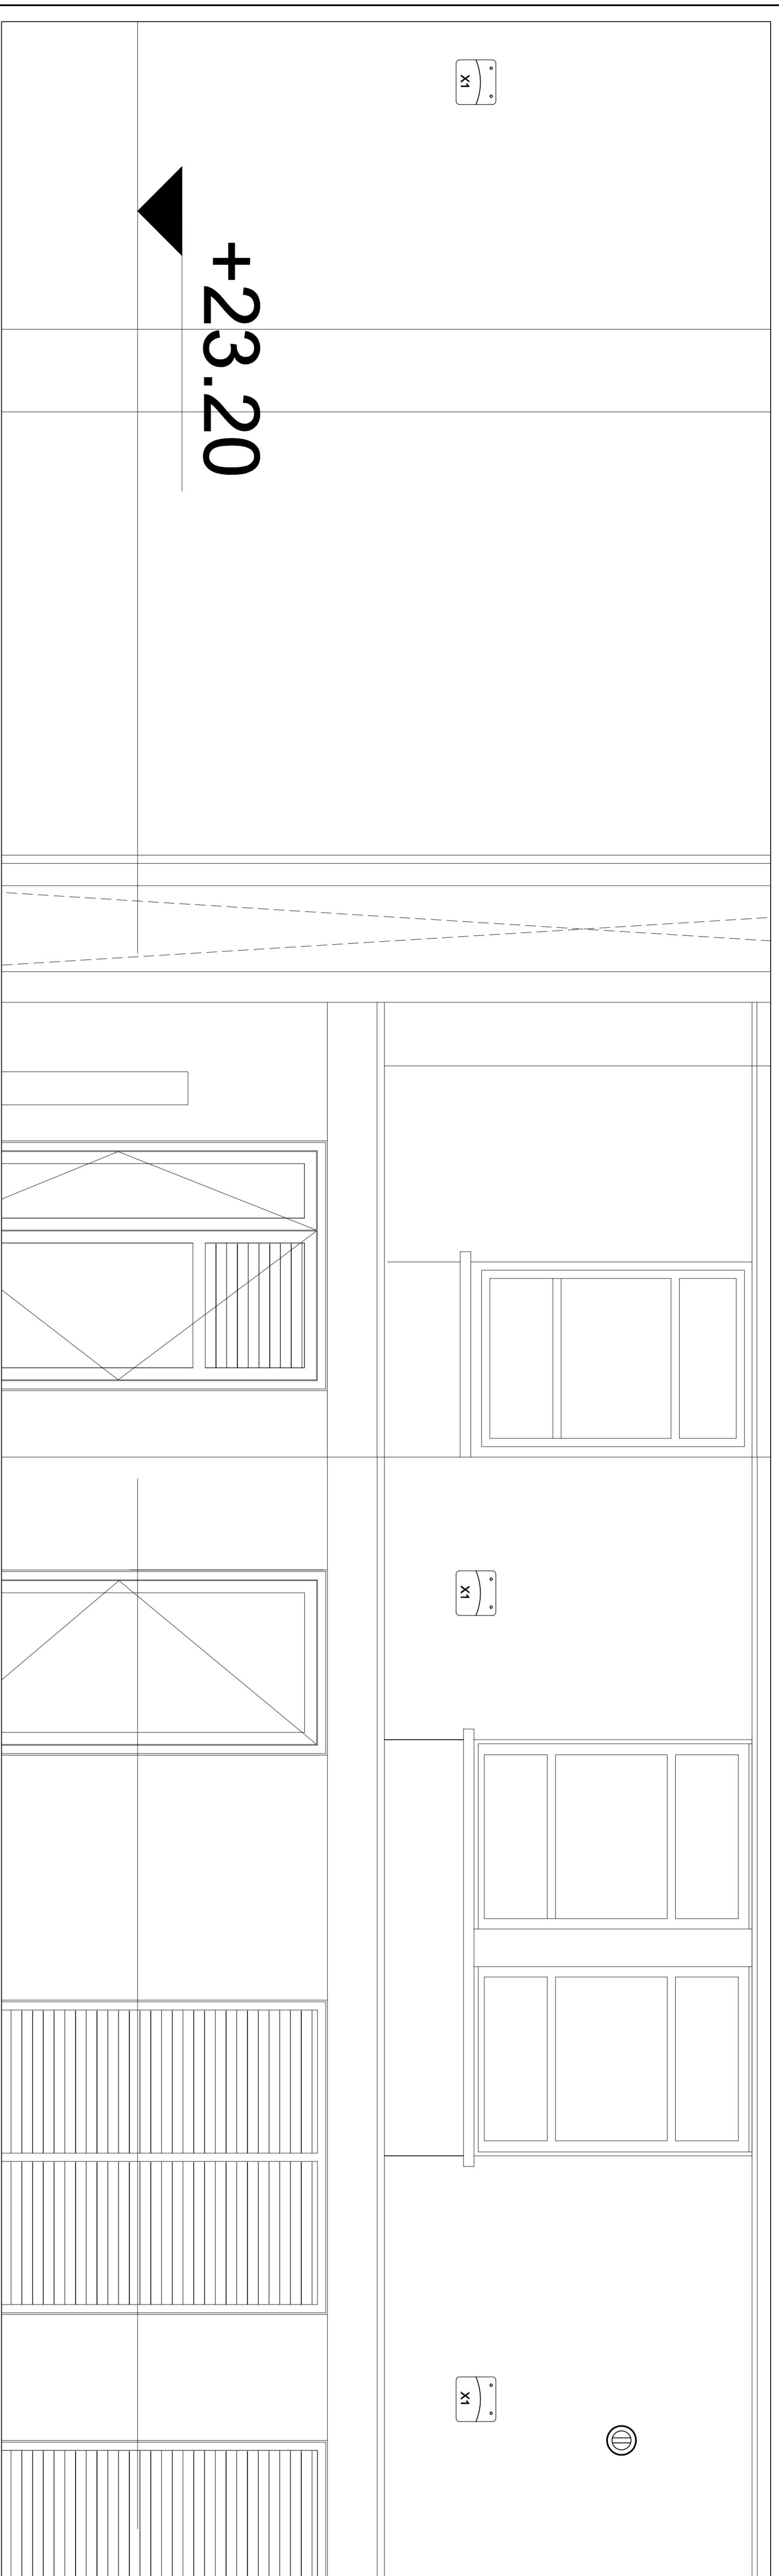


Building Outline Information

Architect's Drawing No. _____ Date _____

B&F PROJECT NUMBER: 3430

NOTES:
THIS DRAWING IS ISSUED FOR PLANNING PURPOSES ONLY

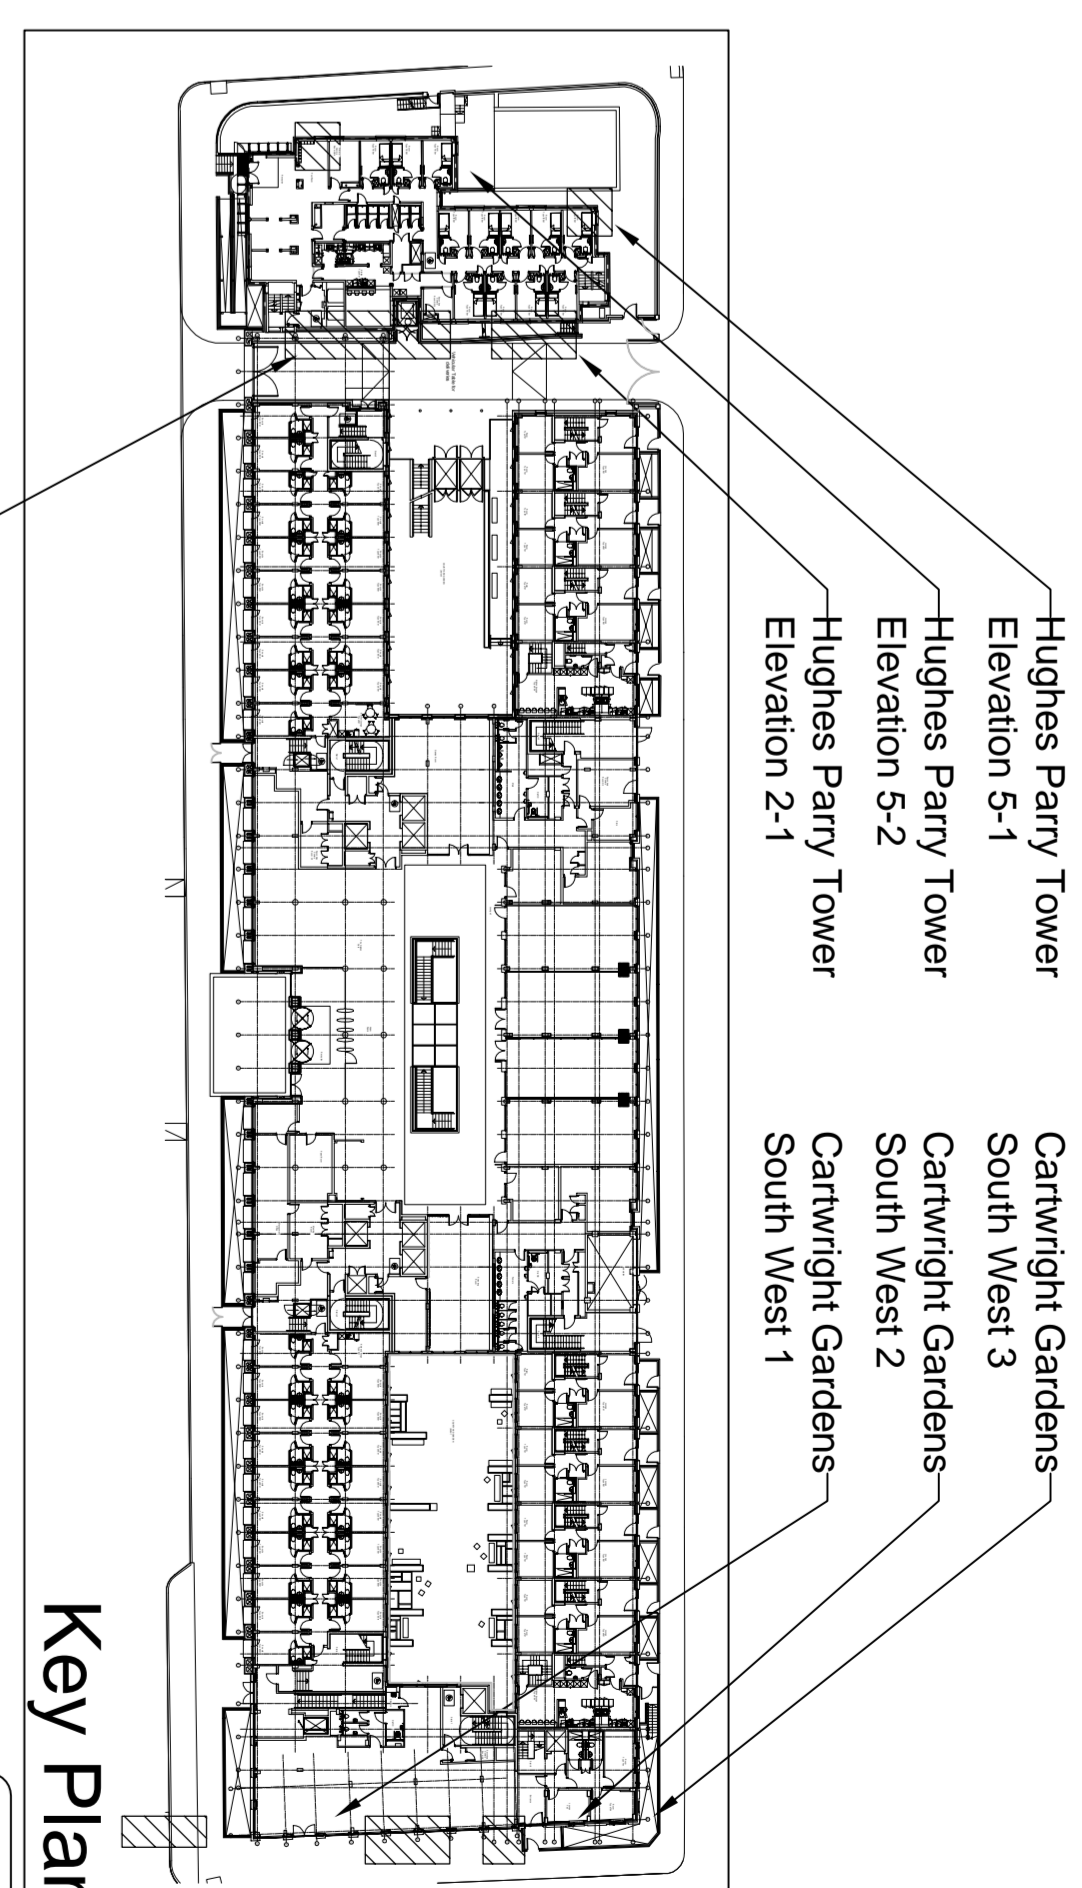

External Luminaire Schedule

Code	Image	Description
X1		ASD Lighting Stellar 270mm x 380mm with 24 LED 1800mA Luminaire finished in Black
X2		ASD Lighting Horizon Louvre 350mm LED luminaire finished in Black
X3		ASD Lighting Horizon Circle 350mm LED luminaire finished in Black
X4		Thorn Lighting Square 1000mm x 280mm with compact fluorescent lamp Luminaire finished in Black
X5		Thorn Lighting Jalor 300mm x 100mm LED luminaire finished in Black
X6		ASD Lighting Lincense Board 1000mm x 280mm LED luminaire finished in Black
X7		Main Entrance suspended luminaire supplied & installed by others
X8		Origin ORLUNCIOR floor recessed LED linear uplight with frosted lens
X9		Not used
X10		Bega 7066 Ground mounted 6.5W LED polelight 150mm dia x 100mm
X11		Design Plan Terminus 280mm x 180mm with LED array Luminaire finished in Black
X12		Bega 44408 Direct wall light approx 1220 x 105 x 32mm with 20W linear fluorescent lamp Luminaire finished in RAL 7008 colour to match framing of doors/windows - AB
X13		Bega 33339 Direct wall light approx 300 x 300mm LED luminaire finished in White - AB

Rev	Description	Issued for	By	Date
01	Issued for Construction	JAS	JIT	09/10/15
02	Revised details	AKA	JIT	09/09/15

Briggs & Forester MEP LTD
 Mechanical, Electrical & Plumbing Engineers
 1st Floor, 100 Brookfield Multiplex
 100 Brookfield Multiplex
 100 Brookfield Multiplex
 100 Brookfield Multiplex

Client: BROOKFIELD MULTIPLEX

Project: UNIVERSITY OF LONDON
 CARTWRIGHT GARDENS

Drawing Title: SOUTH EAST ELEVATION
 ARCHITECTURAL EXTERNAL SERVICES LAYOUT

Scale: 1:20 @ A0 Date: SEPTEMBER 2011

Drawn by: JT **Checked:** JG **Rev:**

Drawing Number: 6000/ES/SP/SL/0712 **02**

CONSTRUCTION

This drawing is copyright and shall remain the intellectual property of Briggs & Forester MEP LTD. No part of this drawing may be reproduced without the prior written permission from Briggs & Forester MEP LTD.

DO NOT SCALE OFF THIS DRAWING