


Building Outline Information

Architect's Drawing No. _____ Date _____

B&F PROJECT NUMBER: 3430


NOTES:
THIS DRAWING IS ISSUED FOR PLANNING PURPOSES ONLY.

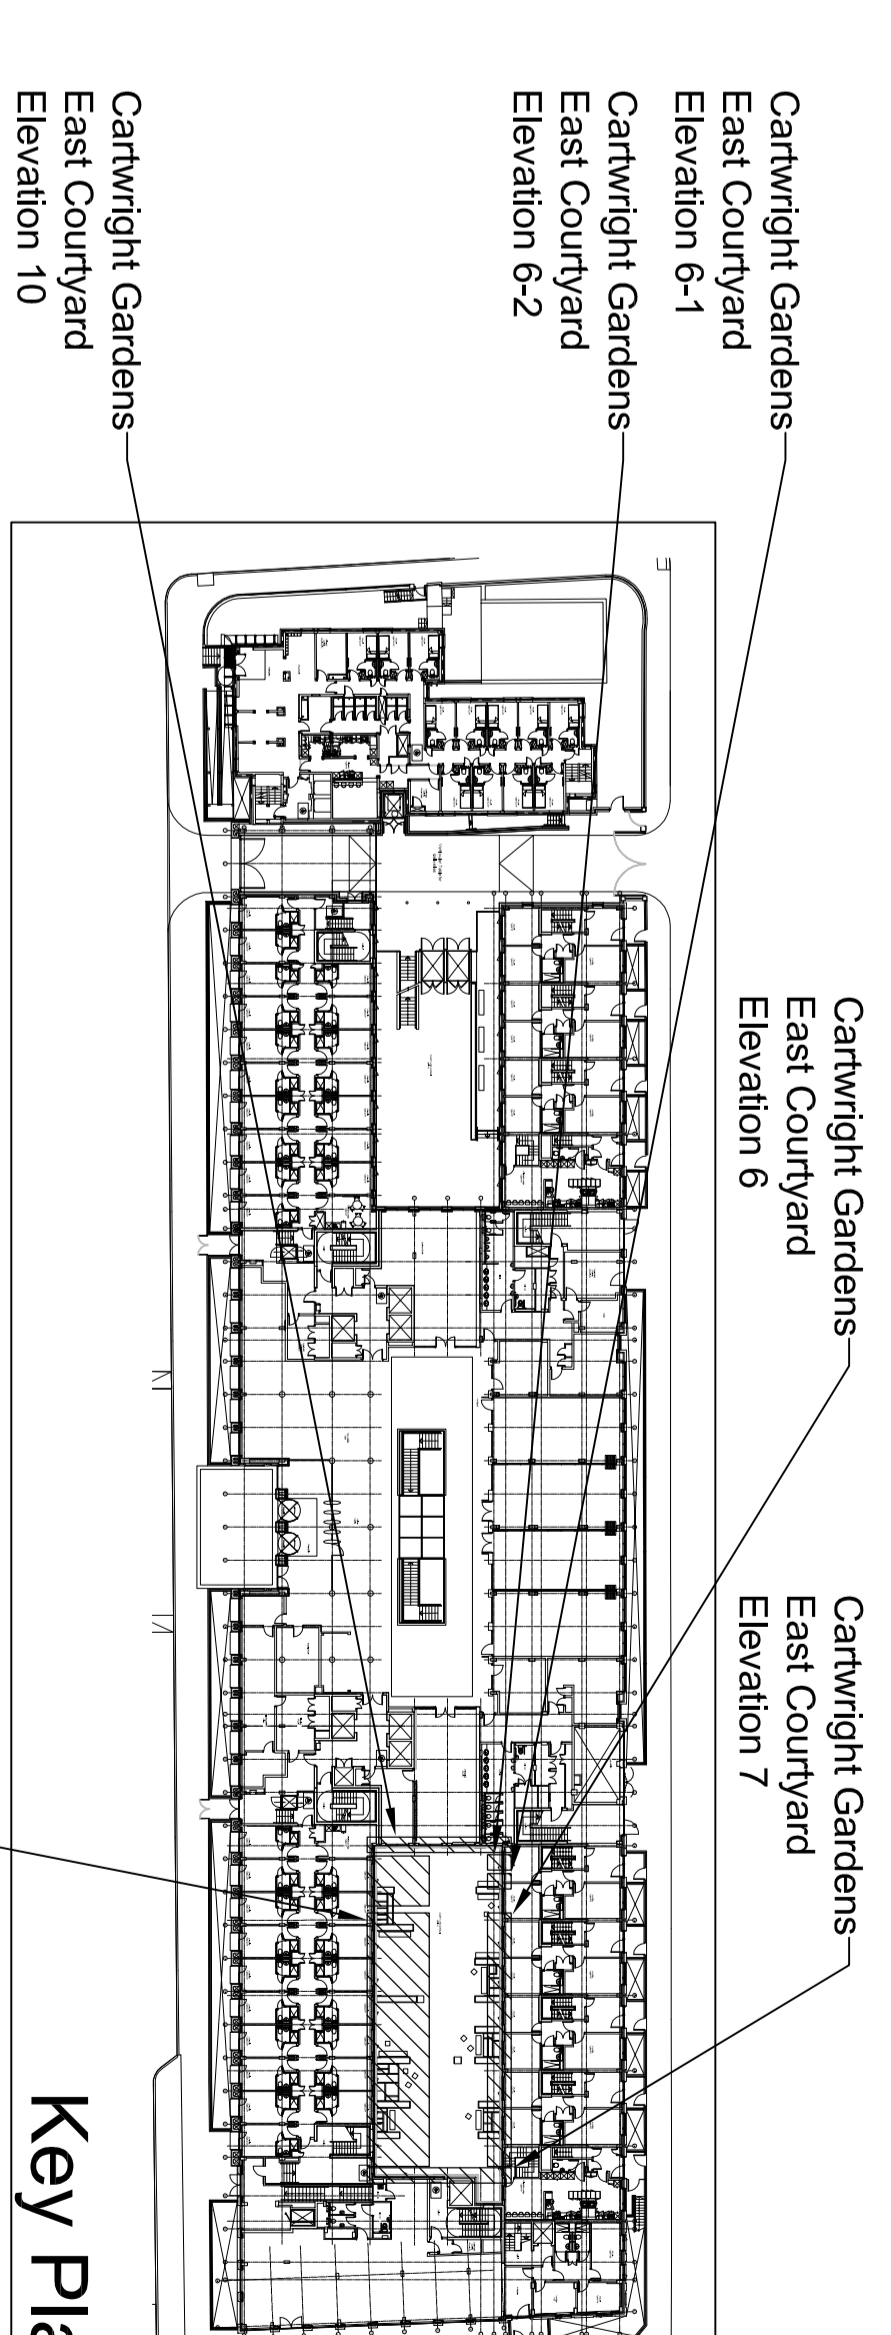


Key Plan

External Luminaire Schedule


Item	Description
X1	ASD Lighting 'Shear' 270mm x 240mm with 24 LED 1800mA Luminaire finished in Black
X2	ASD Lighting 'Horizon Louvre' 350mm Luminaire finished in Black
X3	ASD Lighting 'Hudson' 300mm Dia with compact fluorescent lamp Luminaire finished in Black
X4	Thorn Lighting Square '40' 1000mm x 200mm with compact fluorescent lamp Luminaire finished in Black
X5	Thorn Lighting 'Jalon' 300mm x 100mm with 1 x 20w TCO compact fluorescent lamp Luminaire finished in Black
X6	ASD Lighting 'Landscape Reflector' 1000mm x 200mm diameter with metal halide lamp Luminaire finished in Black
X7	Mass Entrance suspended luminaires supplied & installed by others
X8	Optical CONTROLUMINOZ Floor mounted LED linear uplight with frosted lens
X9	Not used
X10	Bega '7066' Ground mounted 6.5w LED projector approx 150mm Dia x 100mm
X11	Design Plan 'Terminator' 250mm x 180mm with LED array Luminaire finished in Black
X12	Bega '44408' Direct wall light approx 1200 x 100 x 120mm with 200w linear suspended lamp Luminaire finished in RAL 7008 colour to match framing of doors/windows - A/B
X13	Bega '32359' Direct wall light approx 300 x 55 x 100mm with LED light source Luminaire finished in White - A/B

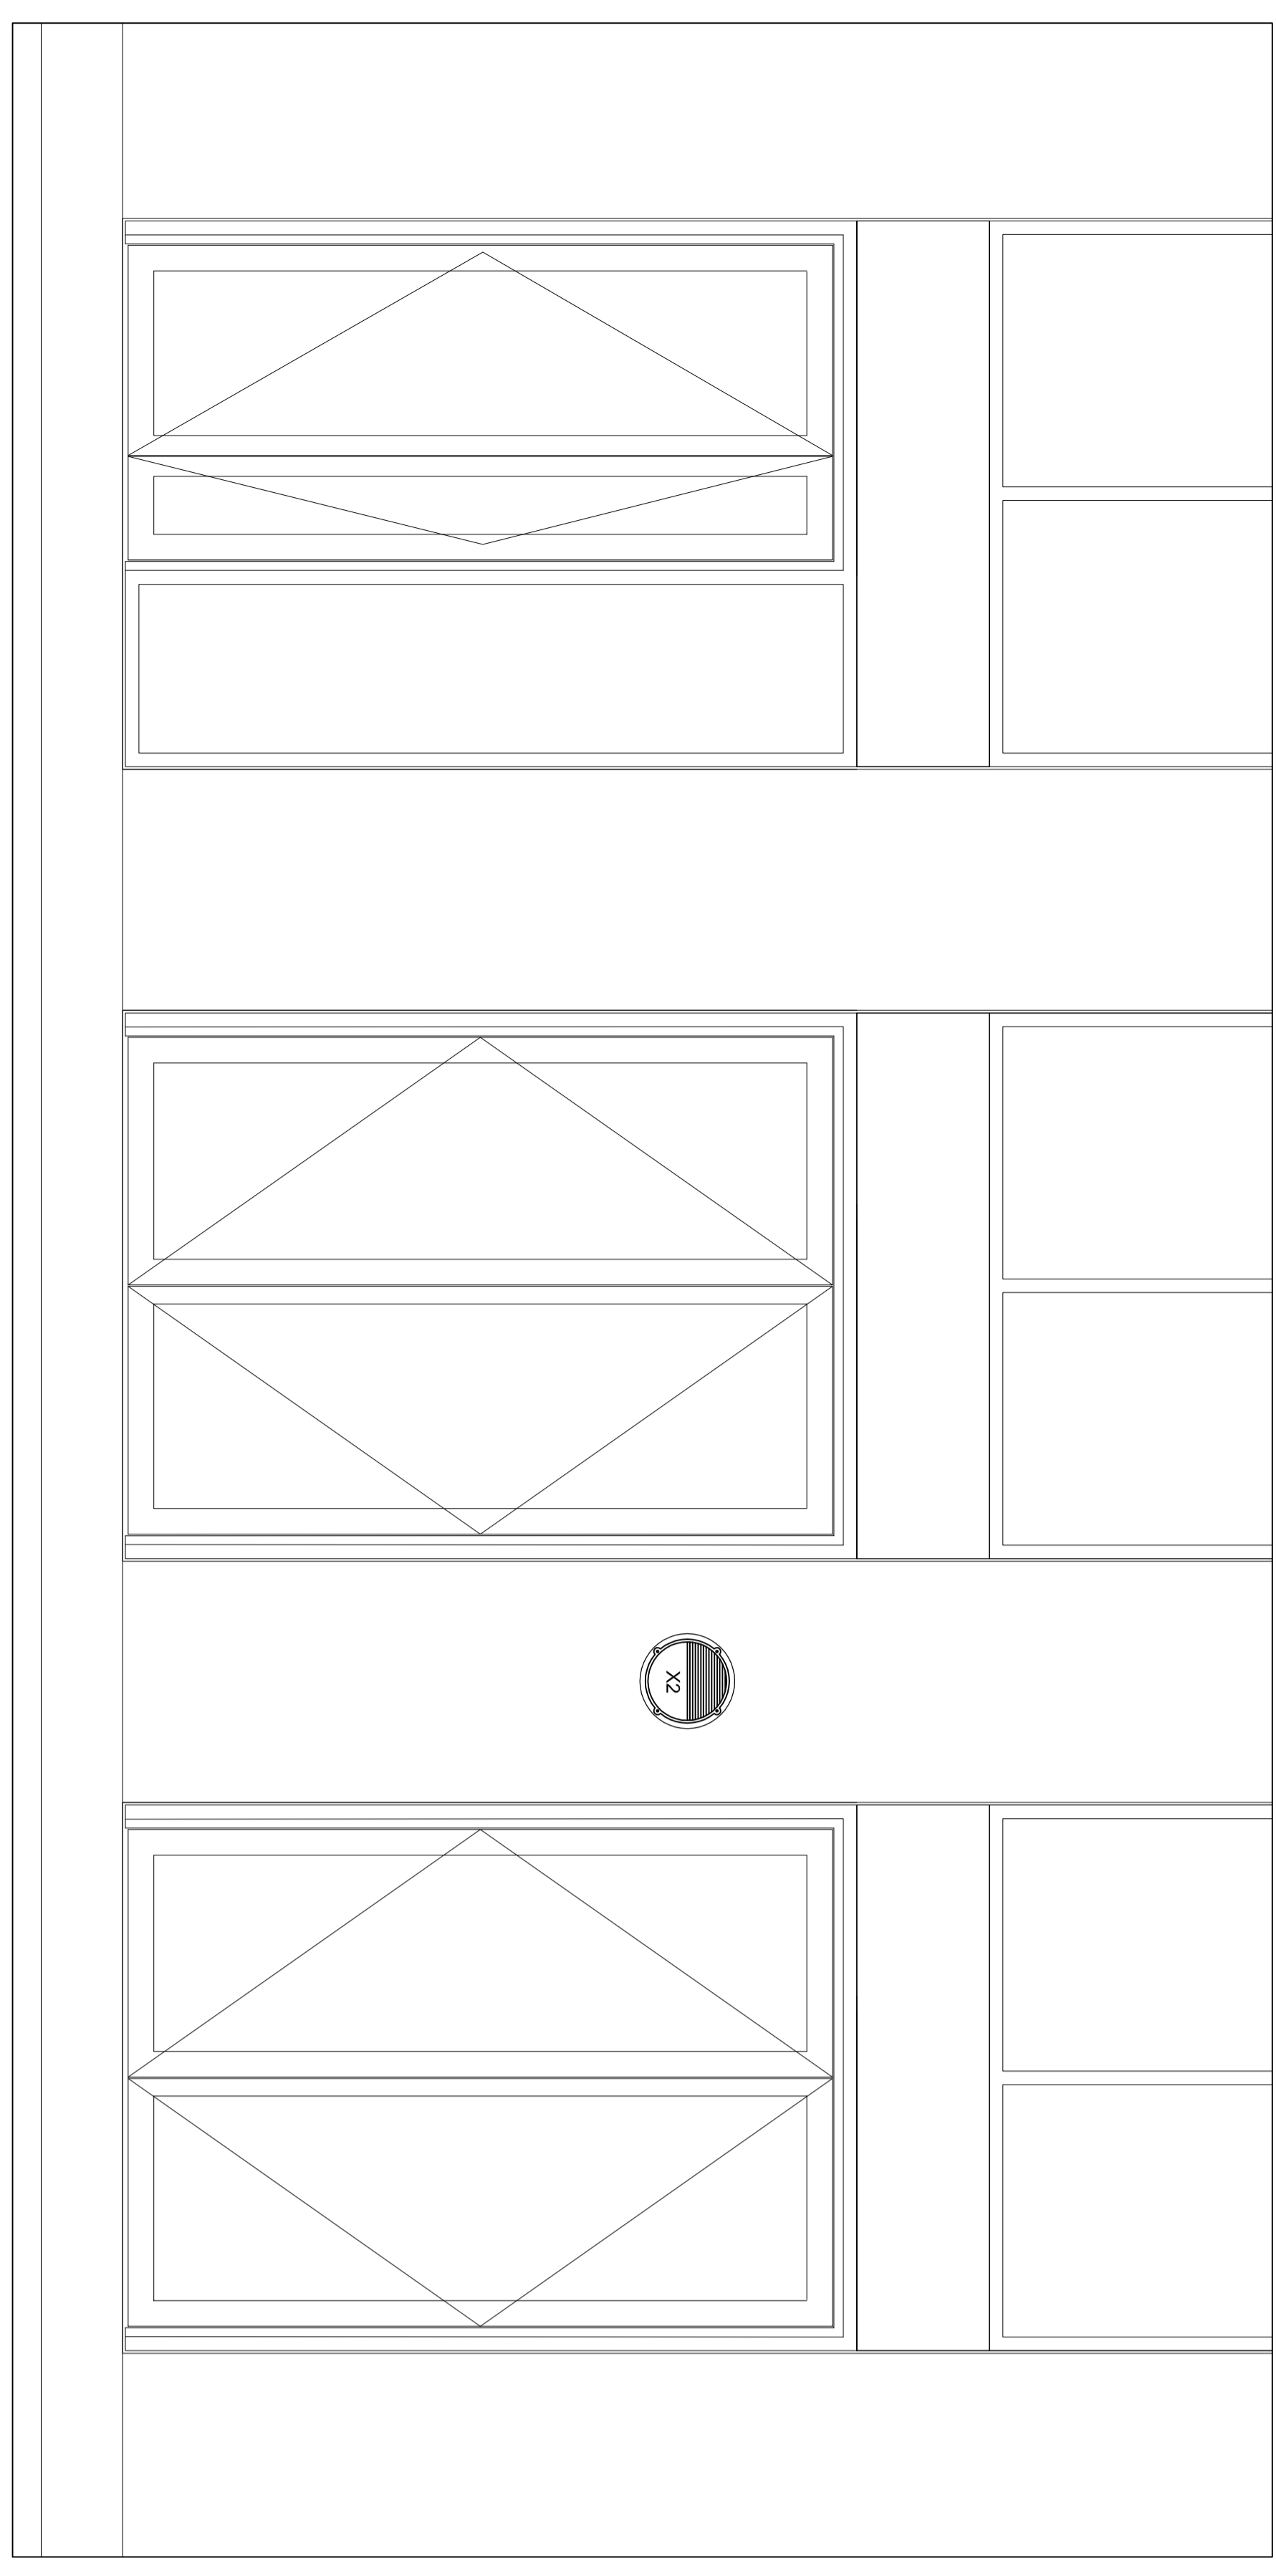

Cartwright Gardens East Courtyard Elevation 10

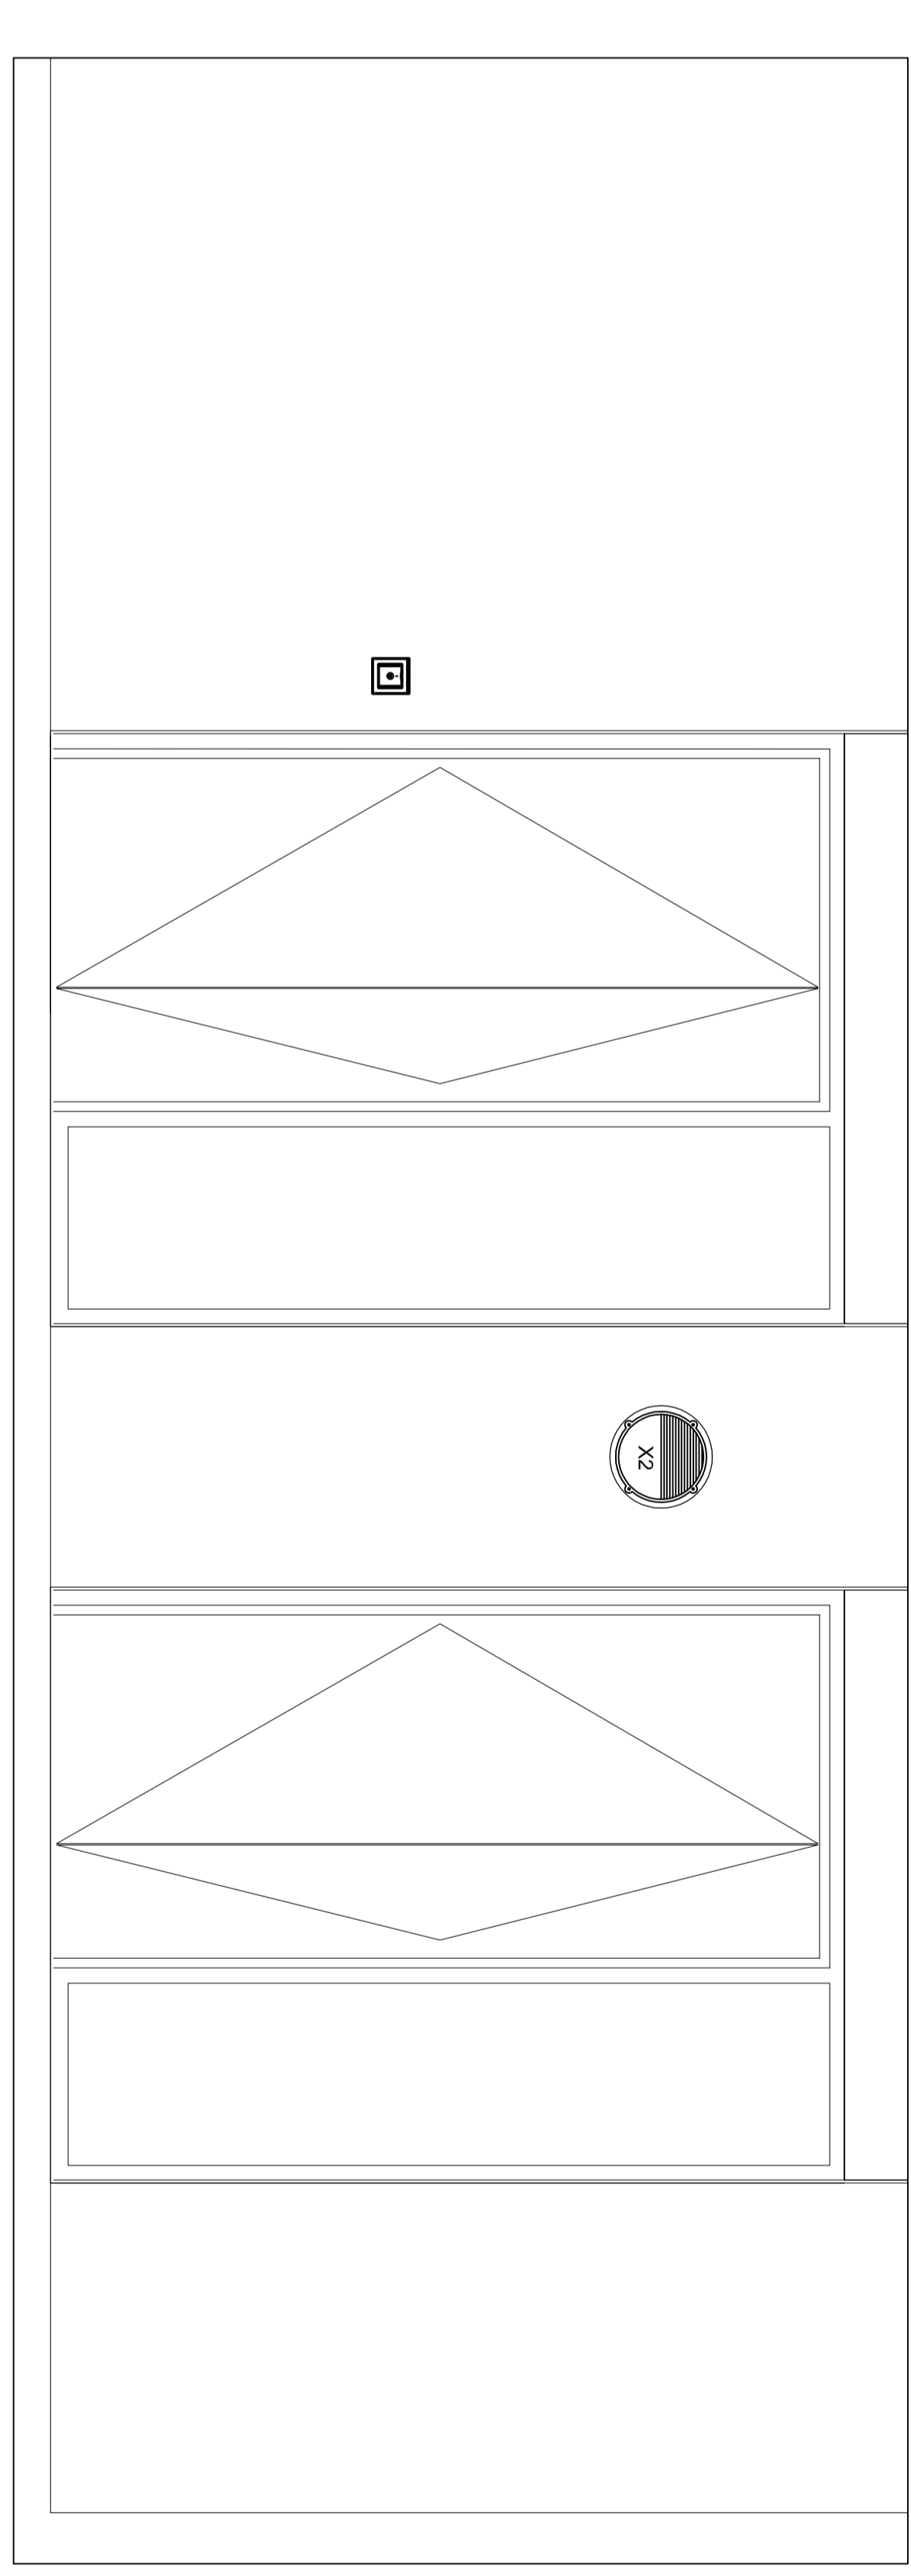


Cartwright Gardens East Courtyard Elevation 7

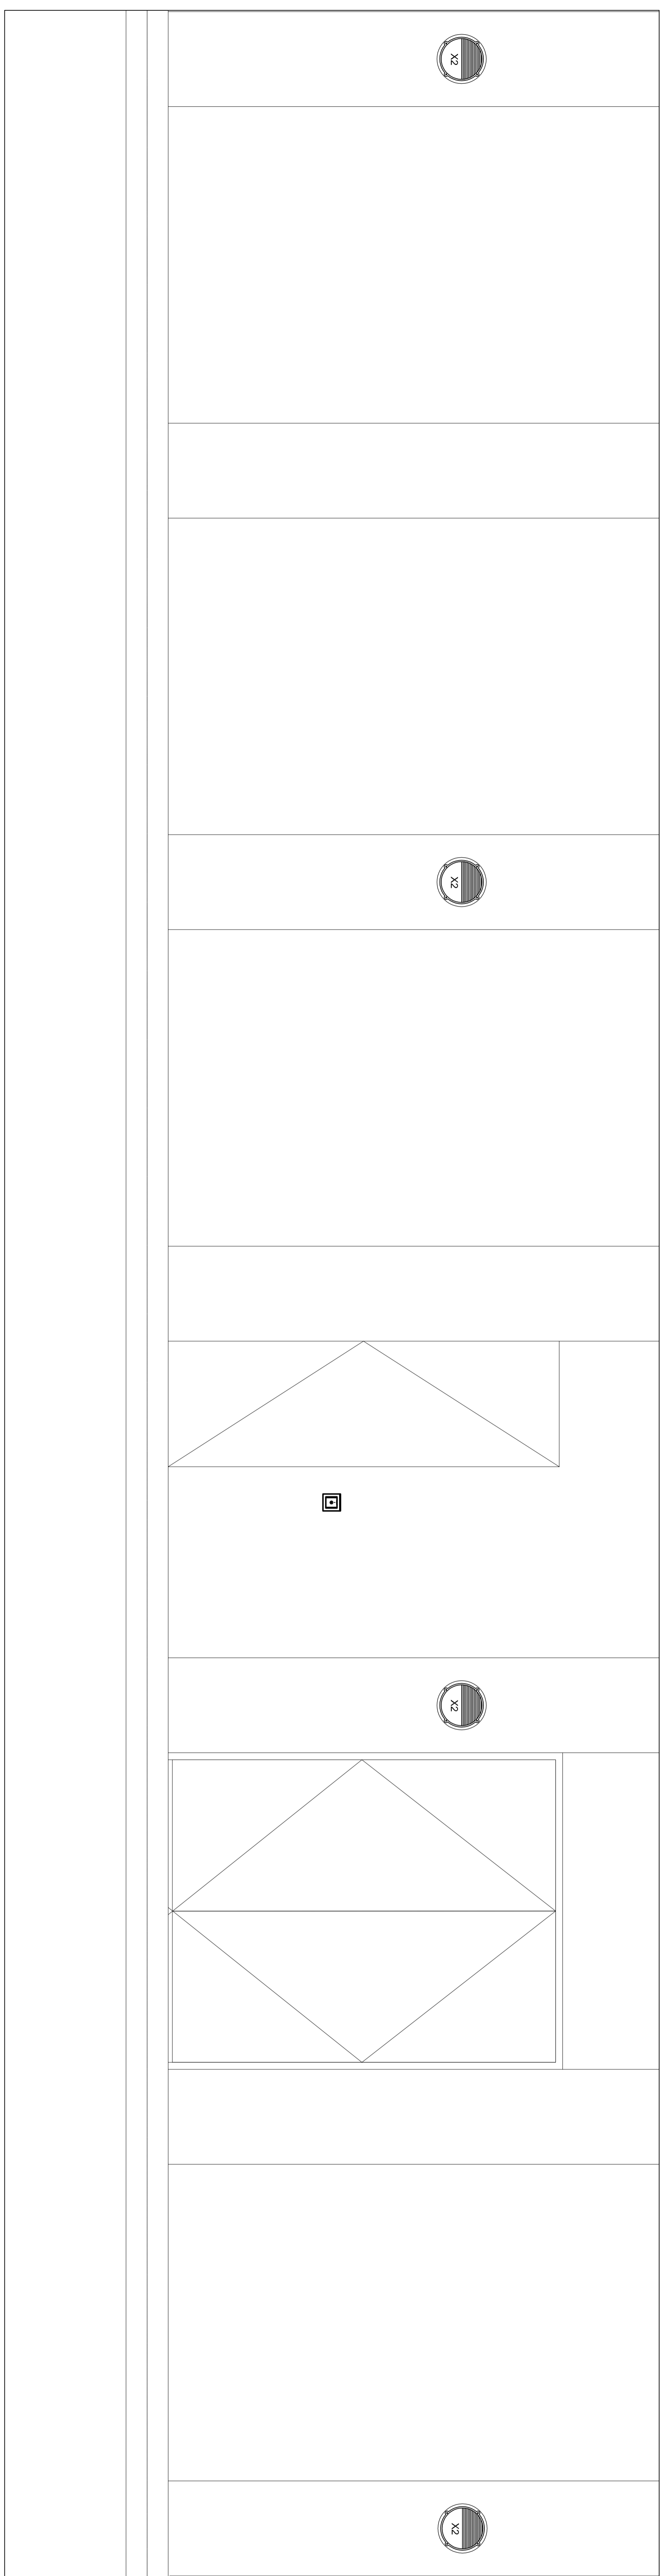

Cartwright Gardens East Courtyard Elevation 1

+24.00

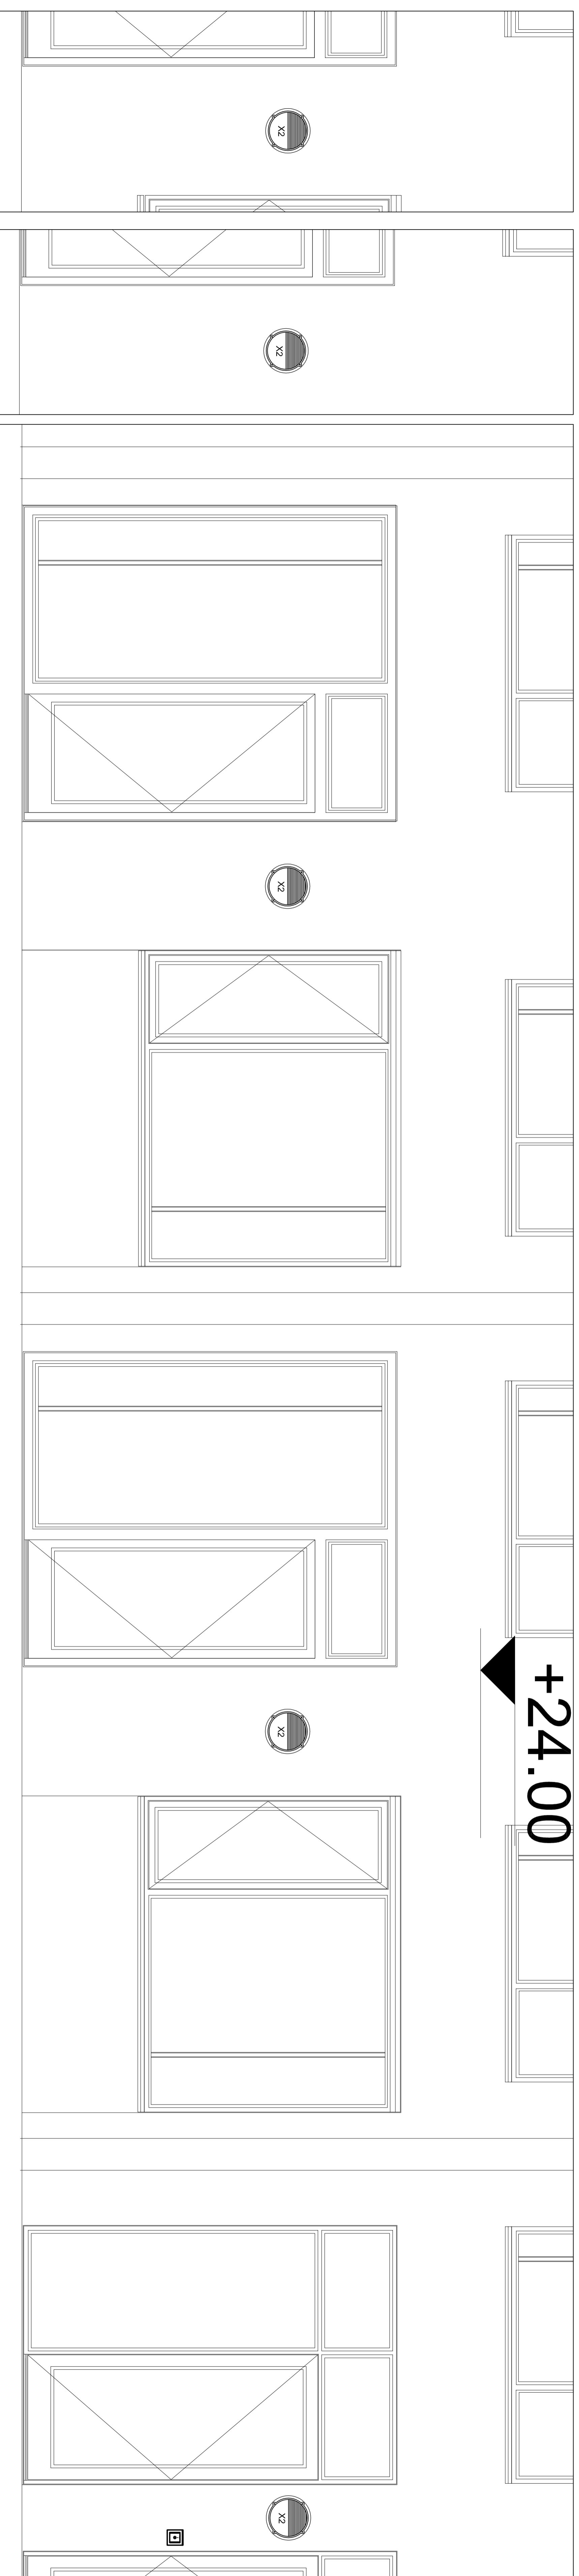

Cartwright Gardens East Courtyard Elevation 6

Cartwright Gardens East Courtyard Elevation 6-1

Cartwright Gardens East Courtyard Elevation 6-2

Client: **BROOKFIELD MULTIPLEX**

Project: **UNIVERSITY OF LONDON CARTWRIGHT GARDENS**

Drawing Title: **EAST COURTYARD EAST/EXTERNAL SERVICES LAYOUT**

Scale: **1:20 @ A0 Date: SEPTEMBER 2015**

Drawn by: **JT** Checked: **gg** Rec: **03**

Drawing Number: **6000/ES/SP/SL/0715**

CONSTRUCTION

The drawings are copyright and remain the intellectual property of B&F. No reproduction or use in any form is permitted without the written permission of B&F. B&F is not responsible for any errors or omissions in this drawing.

DO NOT SCALE OFF THIS DRAWING