




External Luminaire Schedule	
X1	AGD Lighting Smart 2500K x Luminaire with 24 LED 2000K Luminaire with 24 LED 2000K Luminaire with 24 LED 2000K
X2	AGD Lighting Tension Lower 200mm Luminaire with 24 LED 2000K Luminaire with 24 LED 2000K Luminaire with 24 LED 2000K
X3	AGD Lighting Tension Upper 200mm Luminaire with 24 LED 2000K Luminaire with 24 LED 2000K Luminaire with 24 LED 2000K
X4	3000K Lighting Square 400 x 1000mm x Luminaire with 24 LED 2000K Luminaire with 24 LED 2000K Luminaire with 24 LED 2000K
X5	3000K Lighting Square 400 x 1000mm x Luminaire with 24 LED 2000K Luminaire with 24 LED 2000K Luminaire with 24 LED 2000K
X6	AGD Lighting Tension Upper 200mm x Luminaire with 24 LED 2000K Luminaire with 24 LED 2000K Luminaire with 24 LED 2000K
X7	3000K Lighting Square 400 x 1000mm x Luminaire with 24 LED 2000K Luminaire with 24 LED 2000K Luminaire with 24 LED 2000K
X8	3000K Lighting Square 400 x 1000mm x Luminaire with 24 LED 2000K Luminaire with 24 LED 2000K Luminaire with 24 LED 2000K
X9	Not used
X10	3000K Lighting Square 400 x 1000mm x Luminaire with 24 LED 2000K Luminaire with 24 LED 2000K Luminaire with 24 LED 2000K
X11	3000K Lighting Square 400 x 1000mm x Luminaire with 24 LED 2000K Luminaire with 24 LED 2000K Luminaire with 24 LED 2000K
X12	3000K Lighting Square 400 x 1000mm x Luminaire with 24 LED 2000K Luminaire with 24 LED 2000K Luminaire with 24 LED 2000K
X13	3000K Lighting Square 400 x 1000mm x Luminaire with 24 LED 2000K Luminaire with 24 LED 2000K Luminaire with 24 LED 2000K

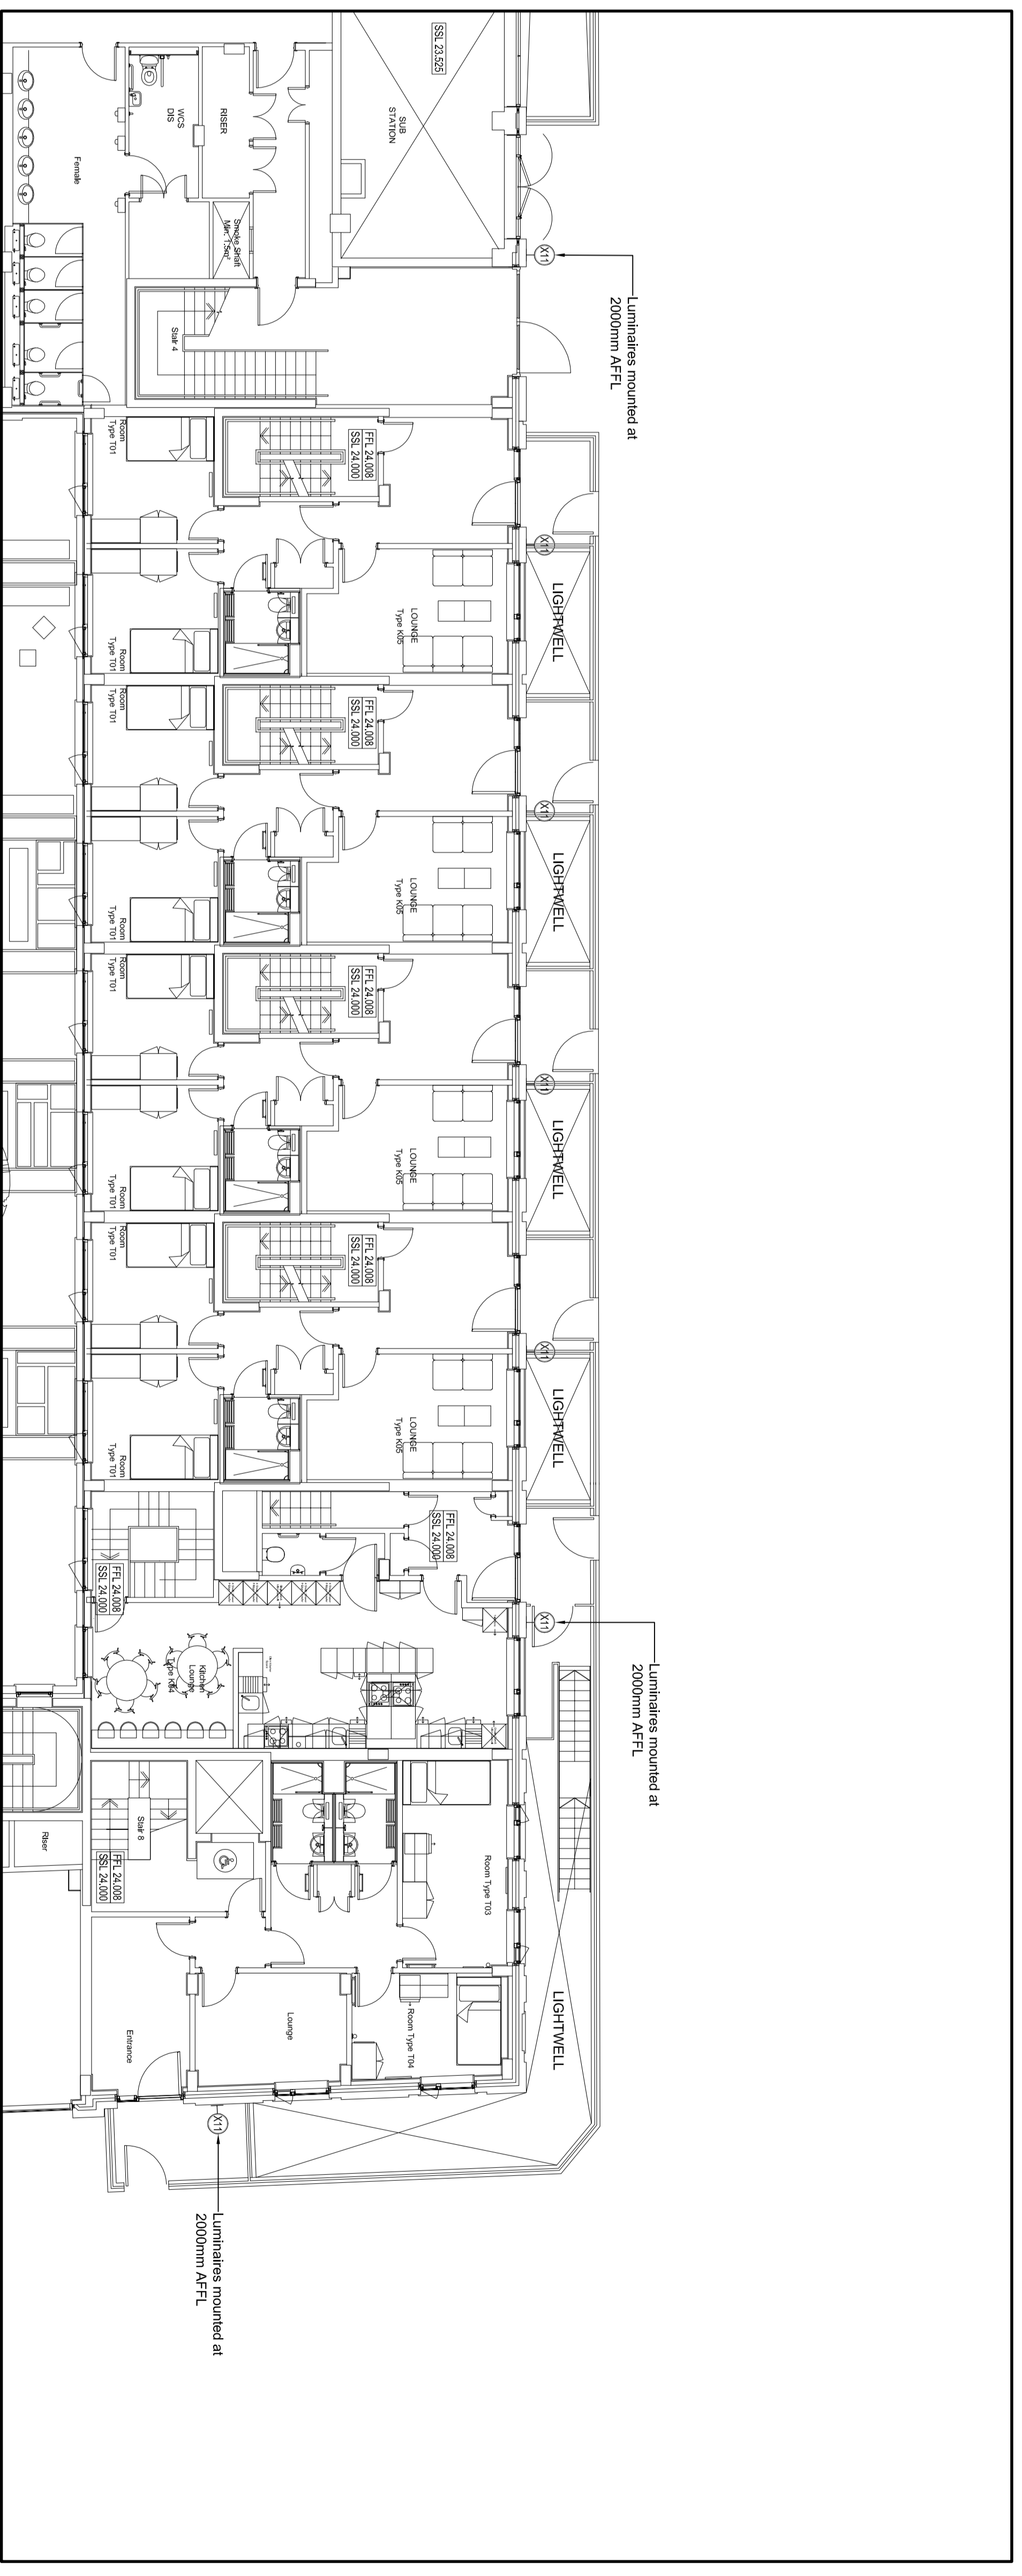


North East

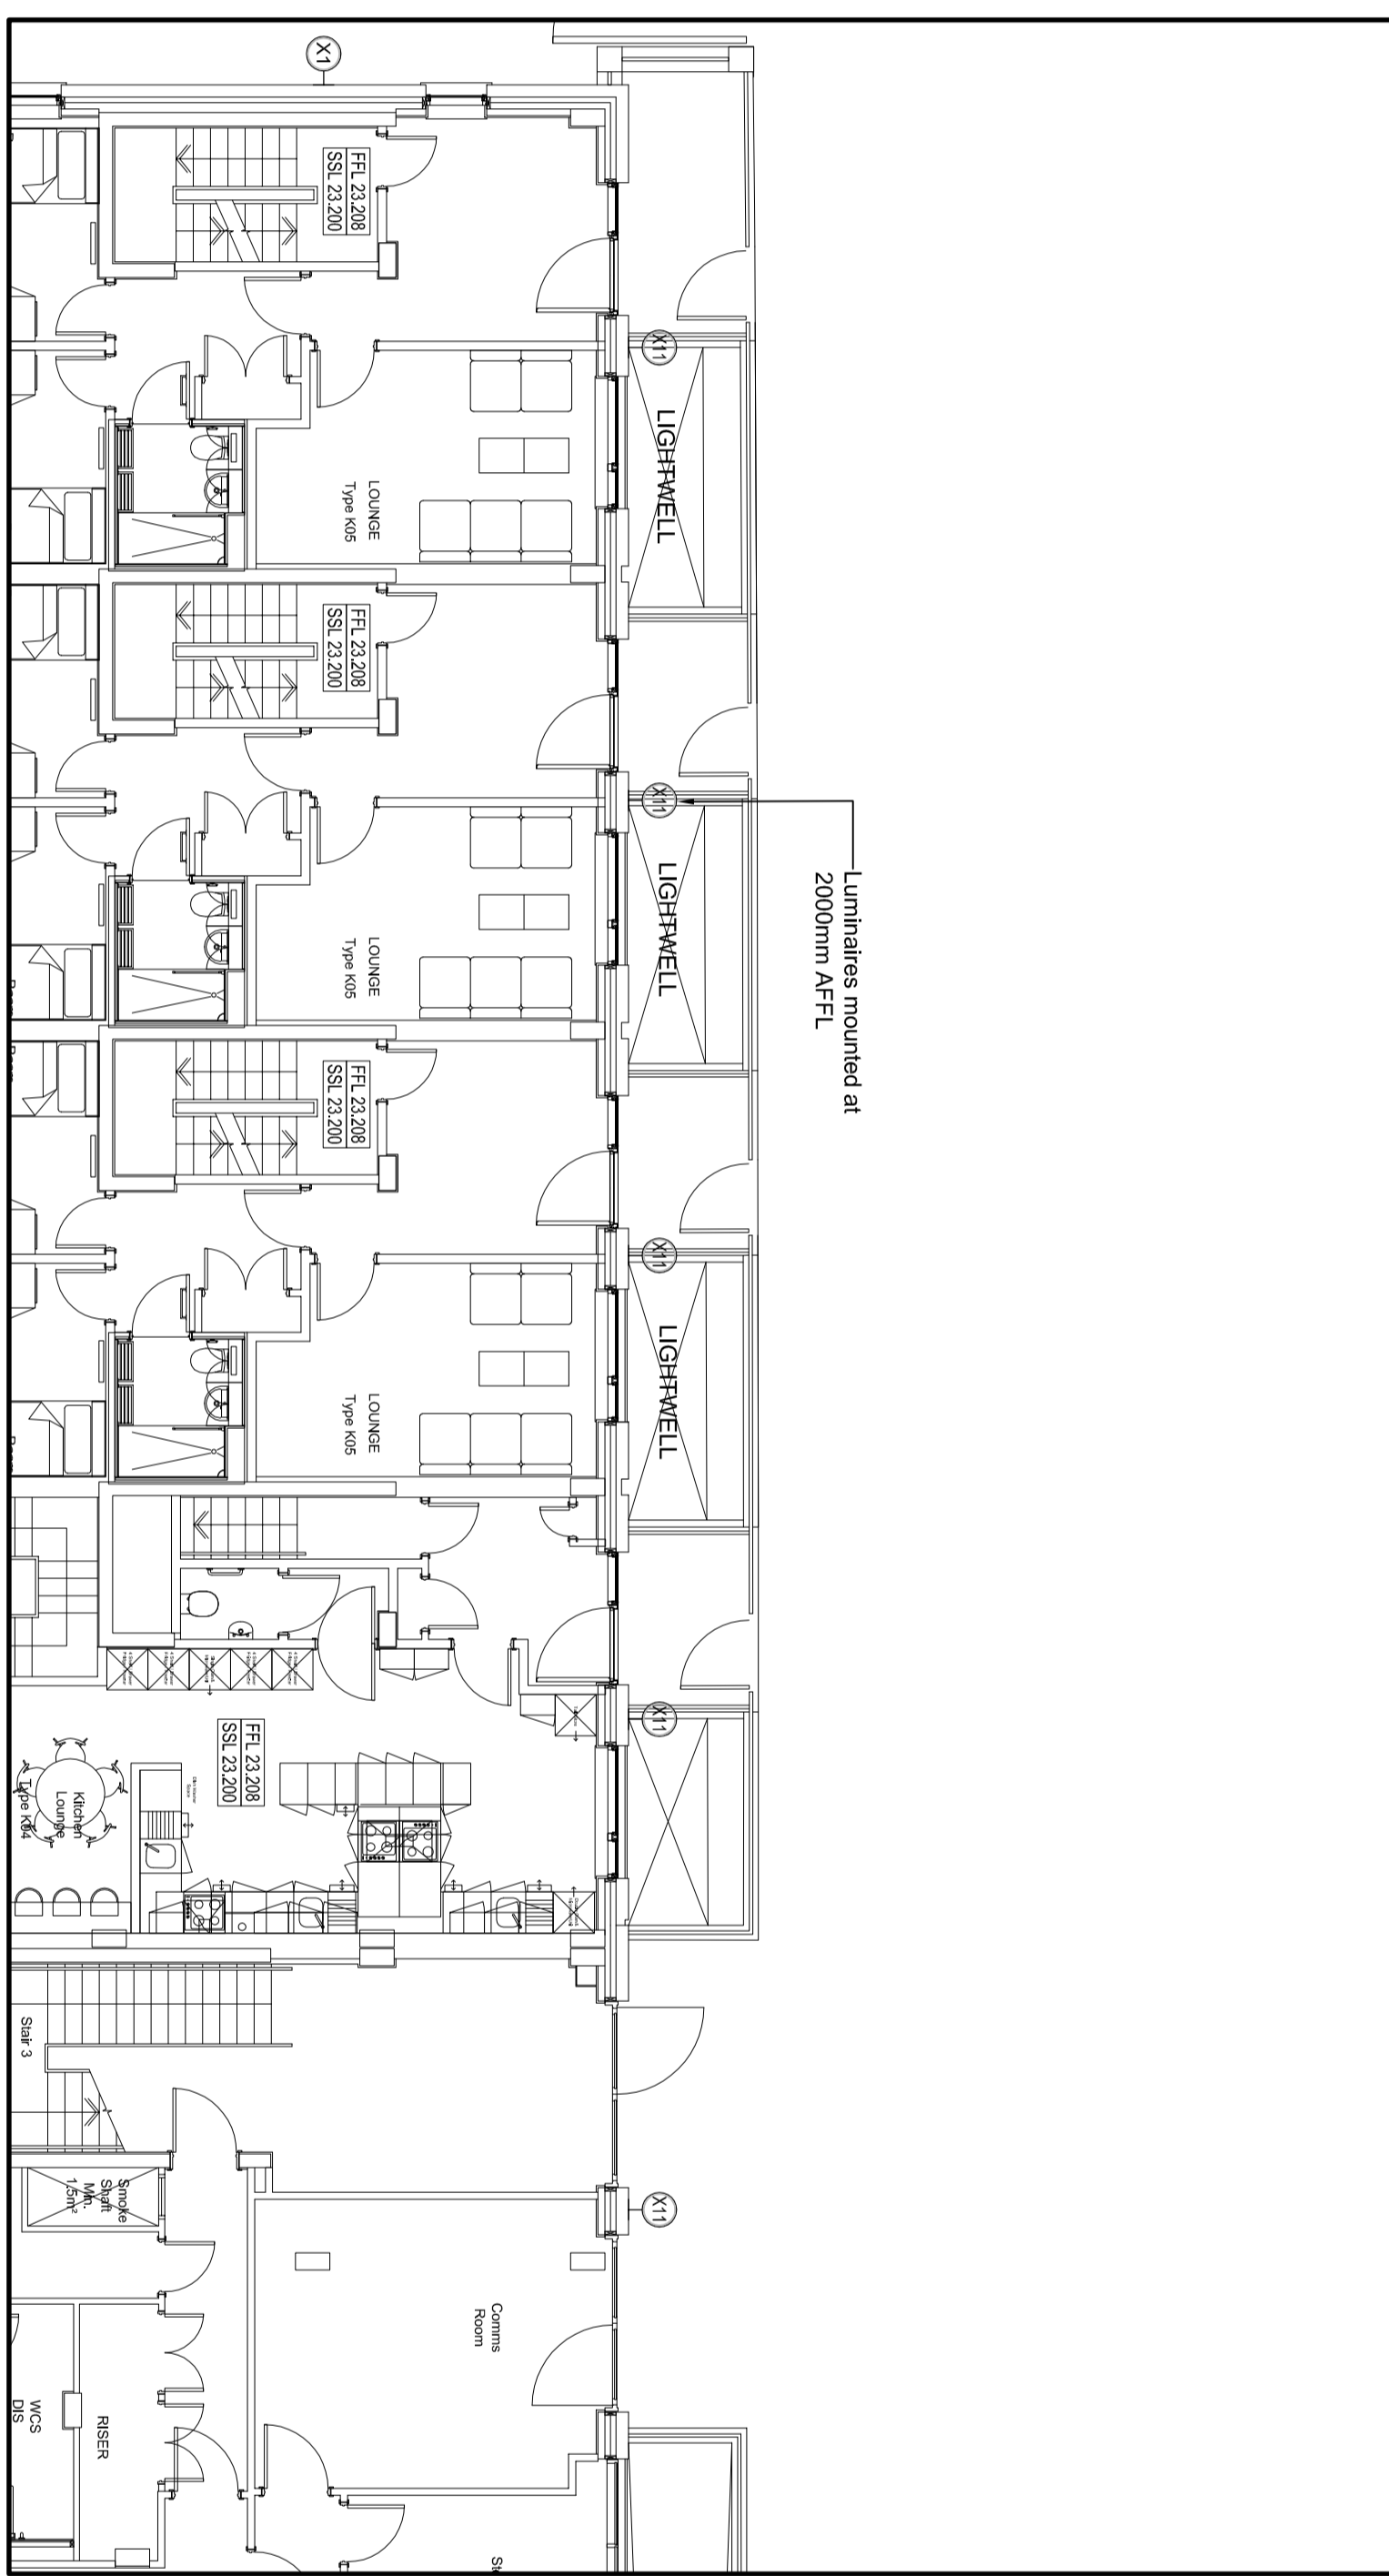


North West

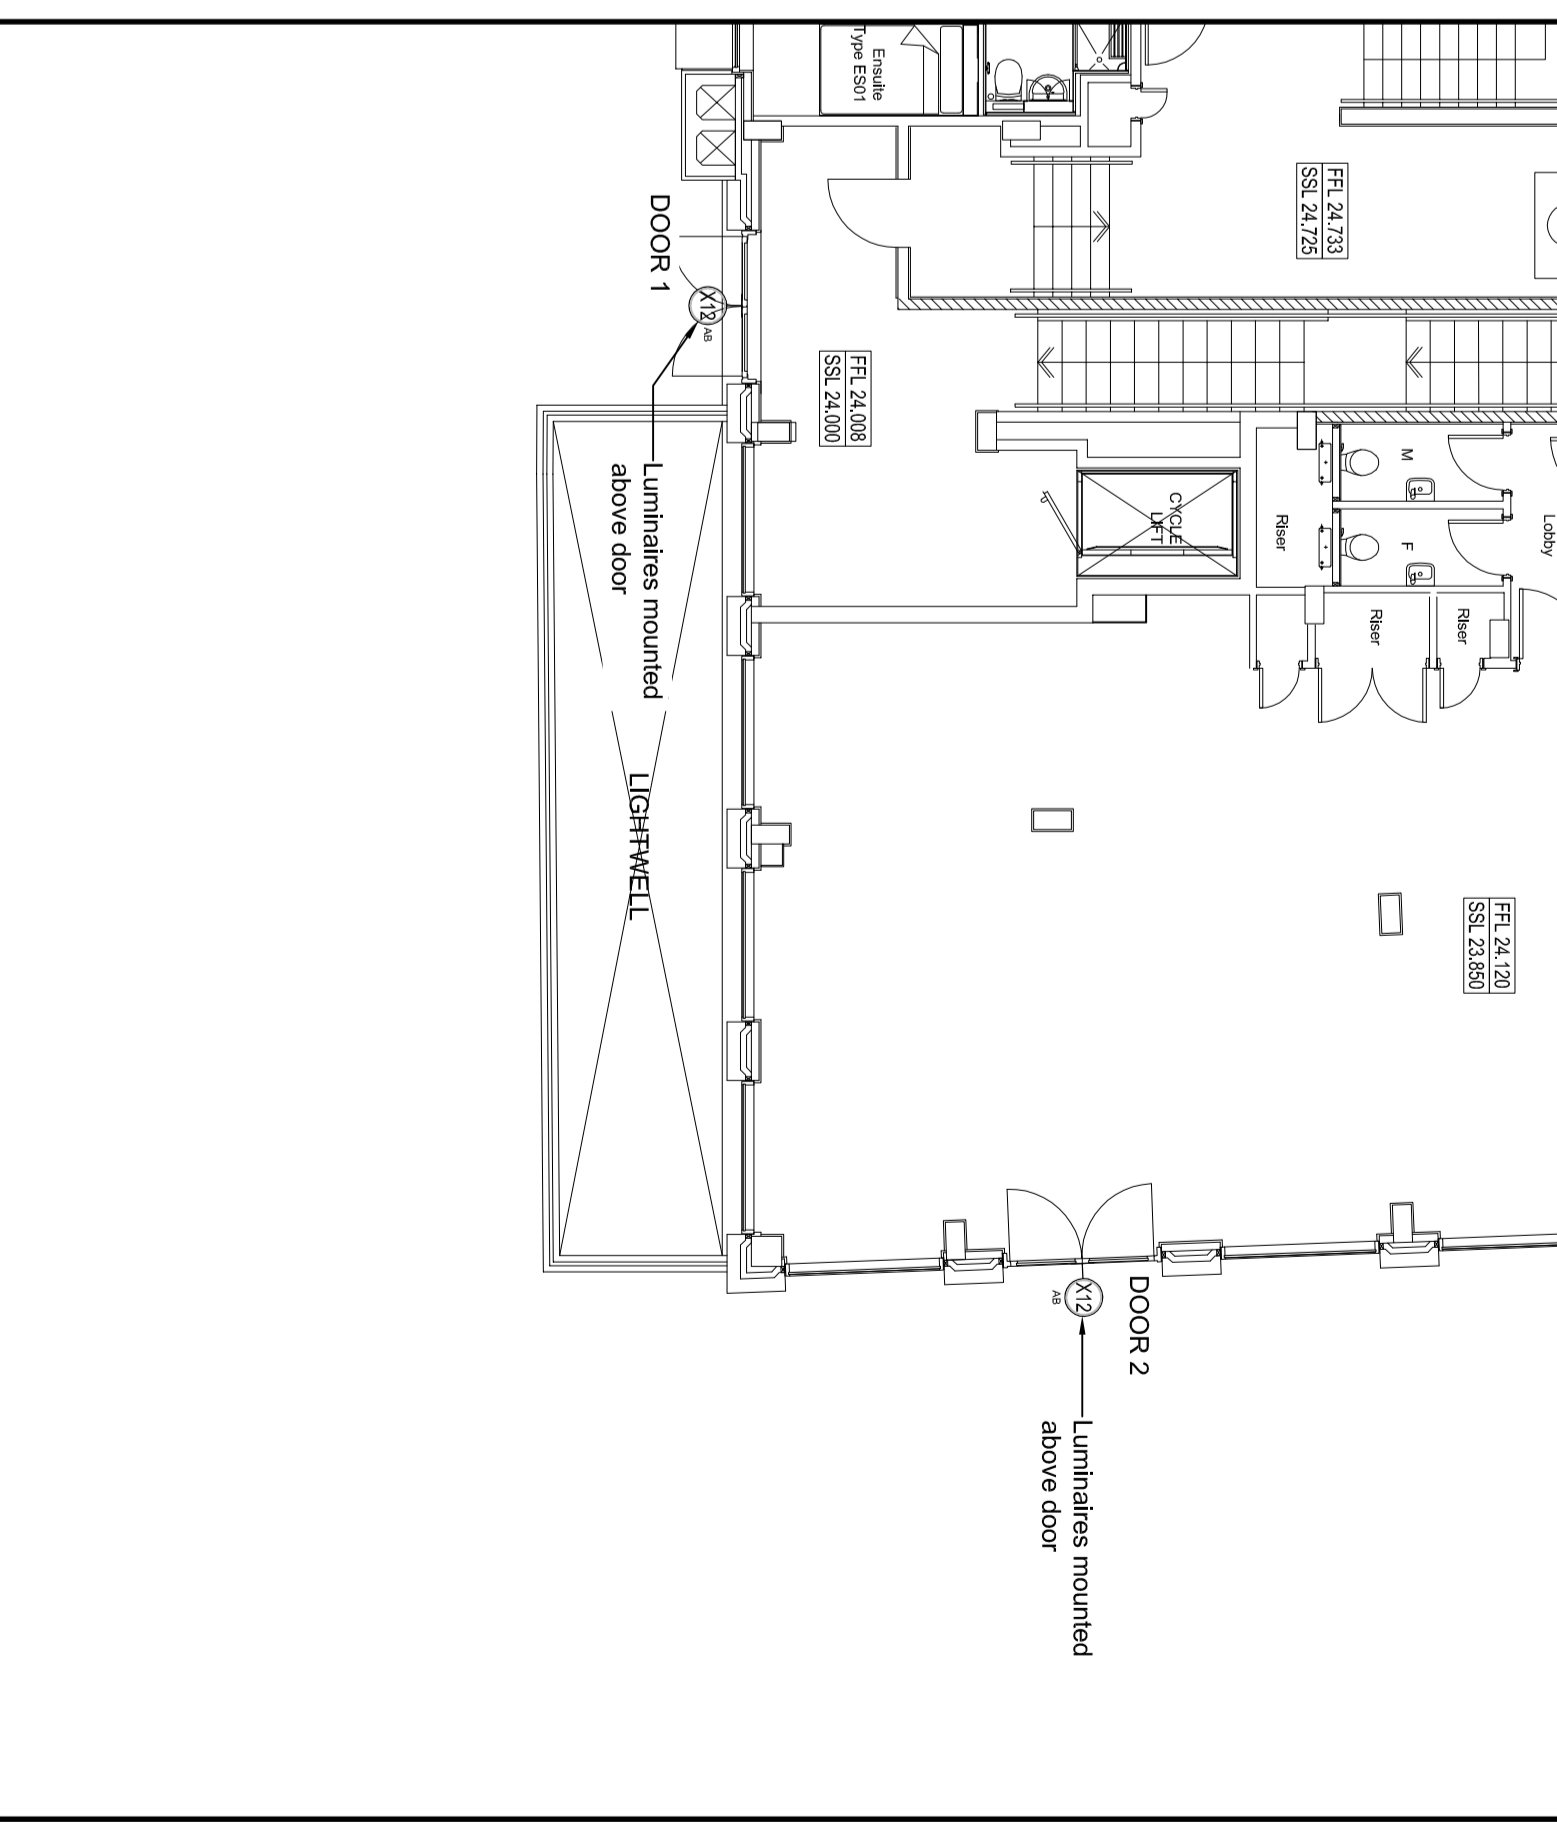


South East

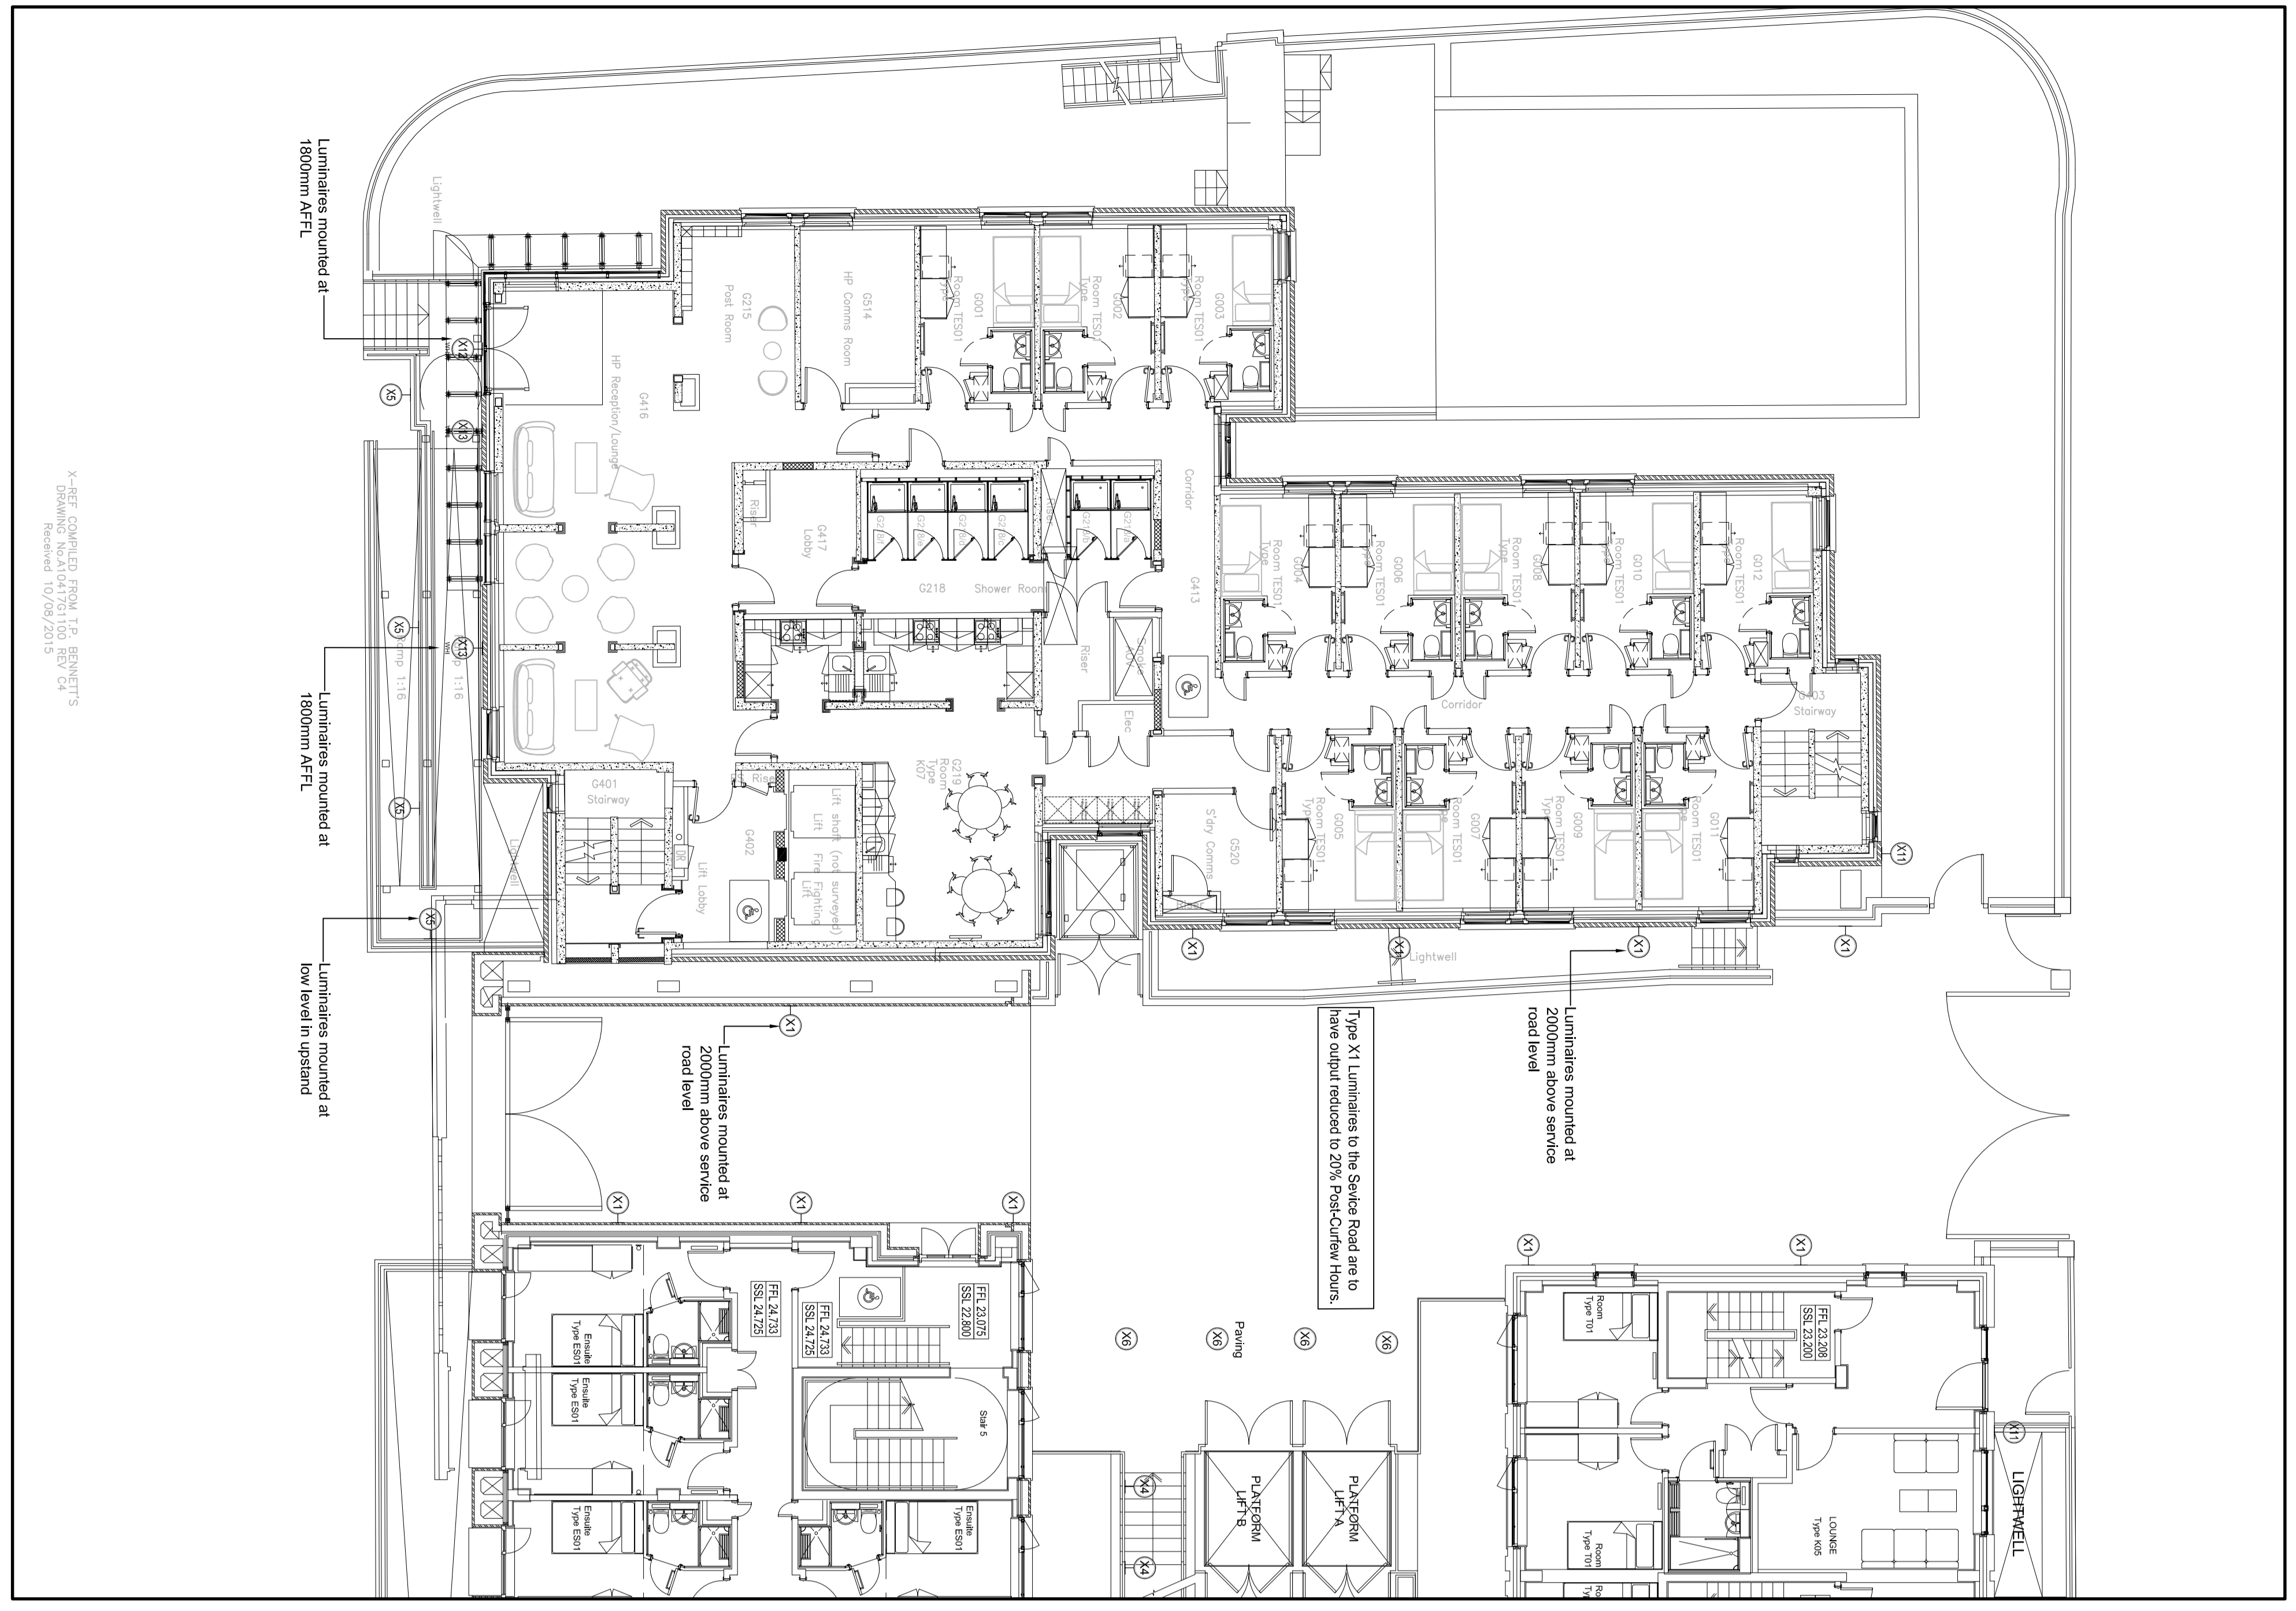

Service Road

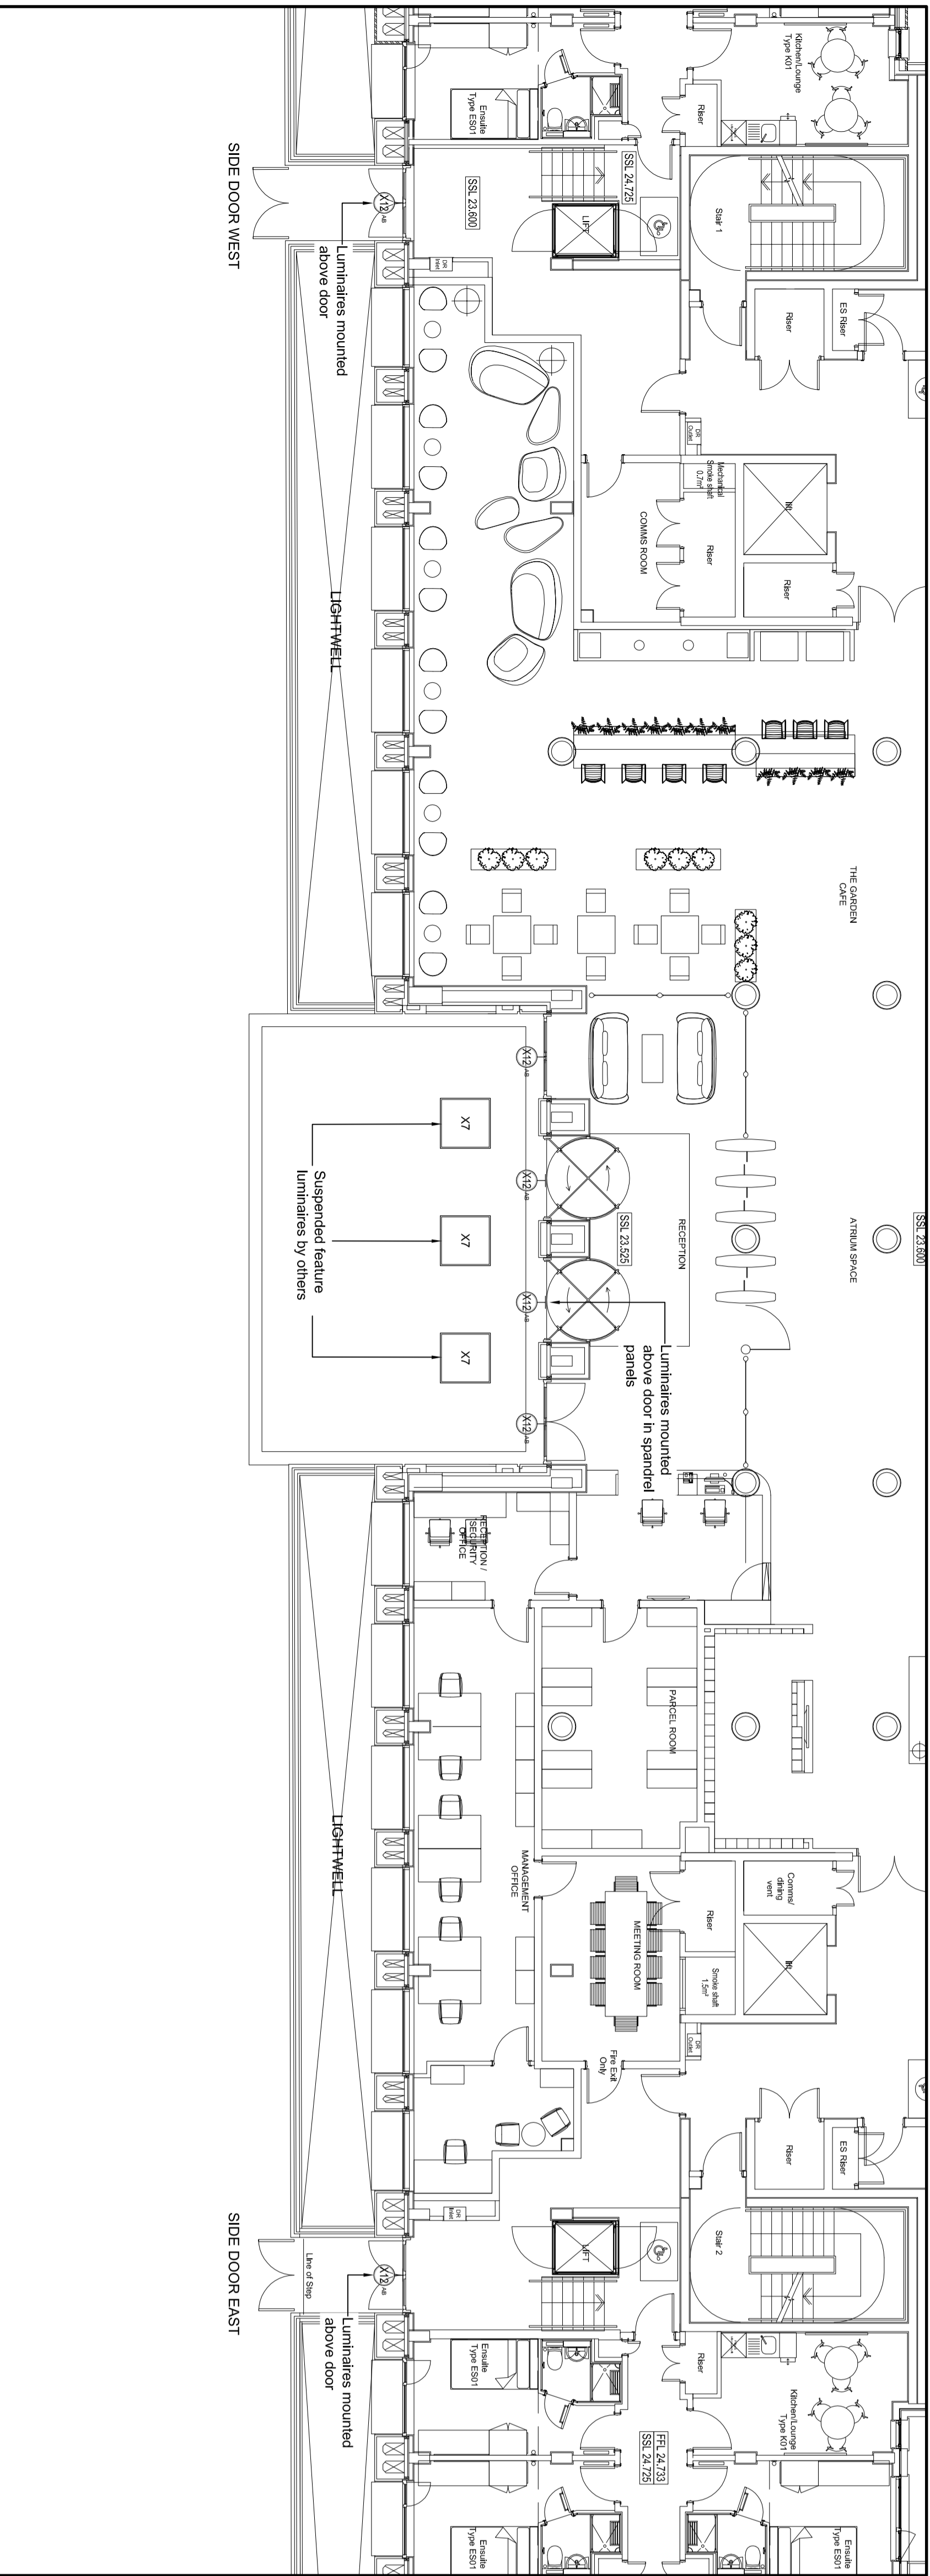

Main Entrance

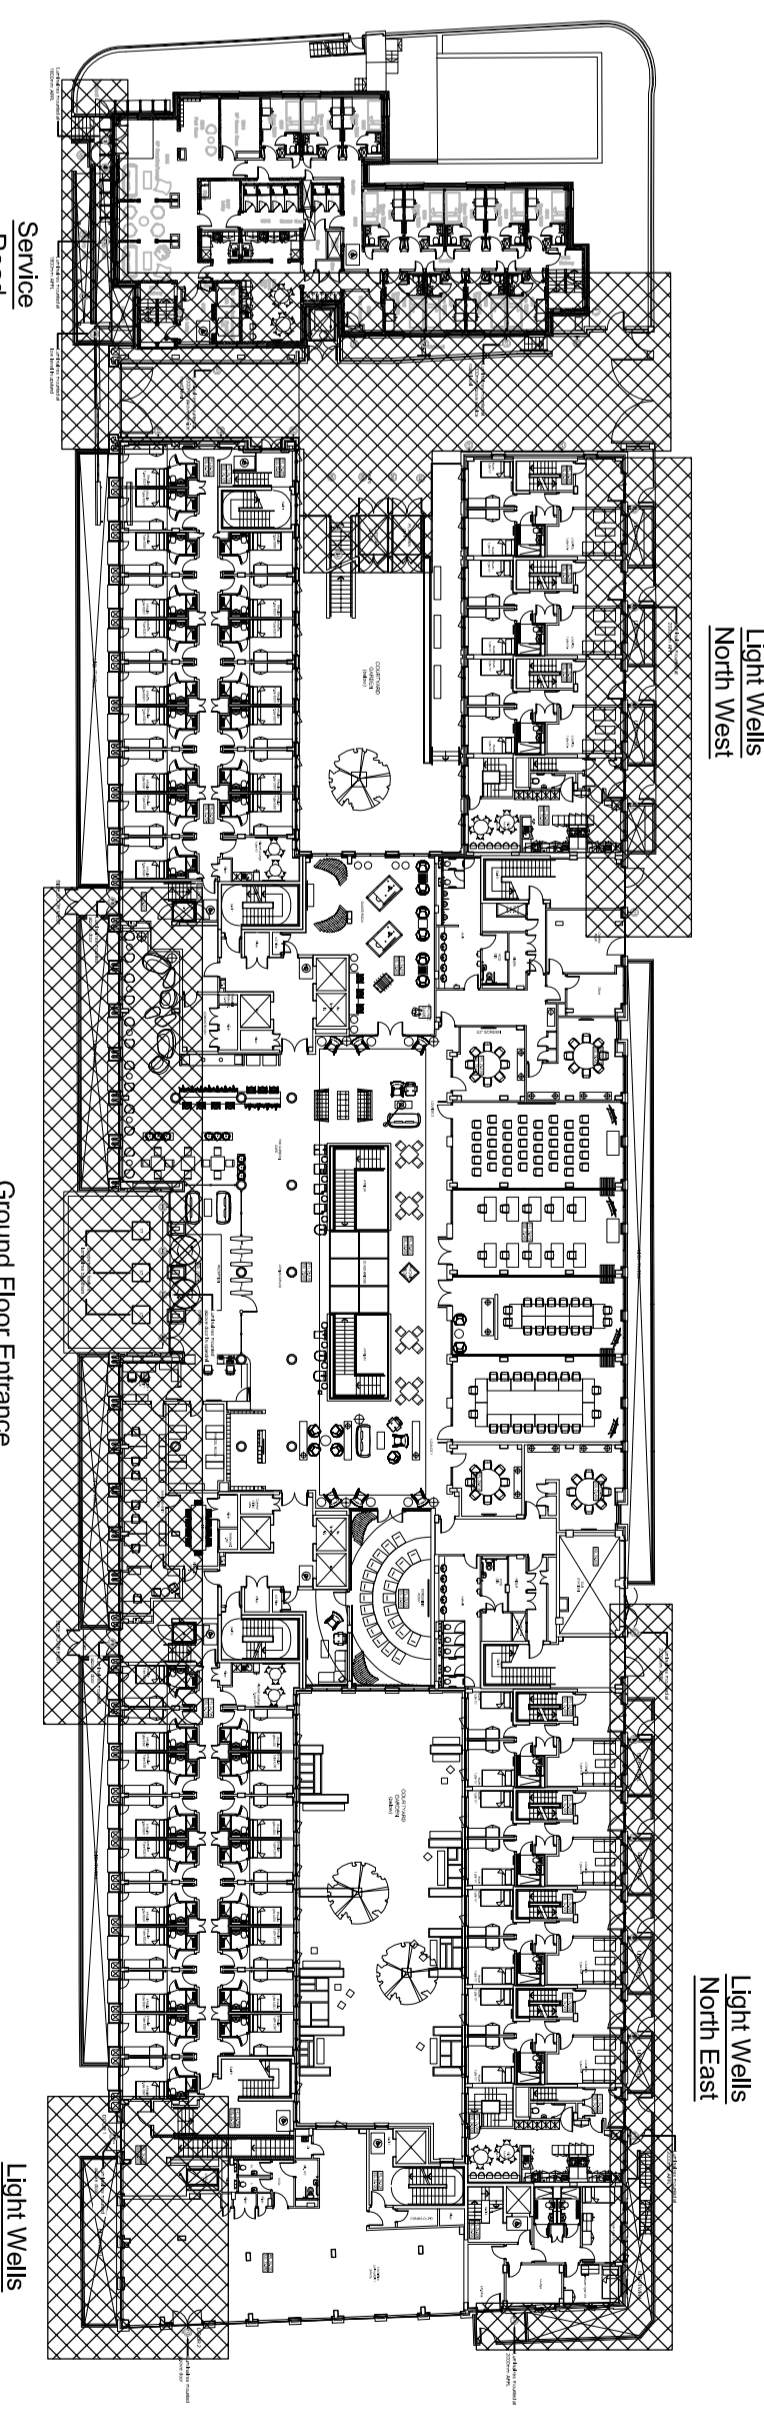

Ground Floor Key Plan

**BRIGGS & FORRESTER MEP LTD**  
 Registered Engineers  
 100, Brookfield Way, Brookfield, Essex, SS16 5LJ  
 Tel: 0202 700000  
 Fax: 0202 700001  
 Email: info@briggsandforrester.com

**BROOKFIELD MULTIPLEX**  
 Project:  
 UNIVERSITY OF LONDON  
 CARTWRIGHT GARDENS

Client:  
 BROOKFIELD MULTIPLEX

Scale: 1:100 @ A0 Date: JUNE 2015  
 Drawing Title: GROUND FLOOR EXTERNAL LIGHTING LAYOUT

Drawn by: JT  
 Checked: JF  
 Revised by: JT  
 Checked: JF

Project Number: 6000/ES/SP/00/4701  
 Revision: 05

DO NOT SCALE OFF THIS DRAWING

**CONSTRUCTION**

This drawing is copyright and may not be reproduced, stored in a retrieval system, or transmitted in any form or by any means, without written permission from Briggs & Forrester MEP LTD.

DO NOT SCALE OFF THIS DRAWING