
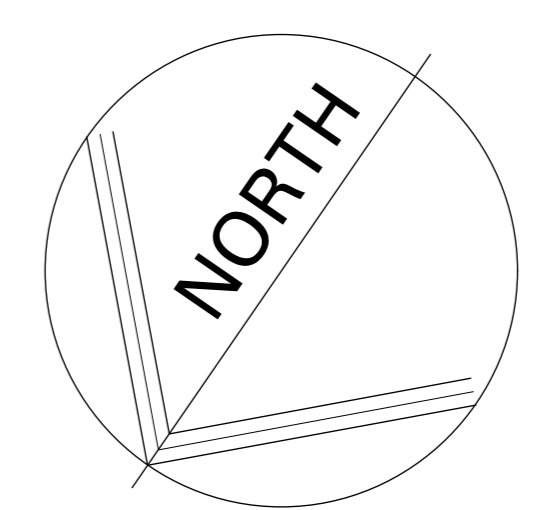


890mm high unit for Oliver Bonas
 1340mm high unit for Oliver Bonas

Roof Plan
 Scale 1:50

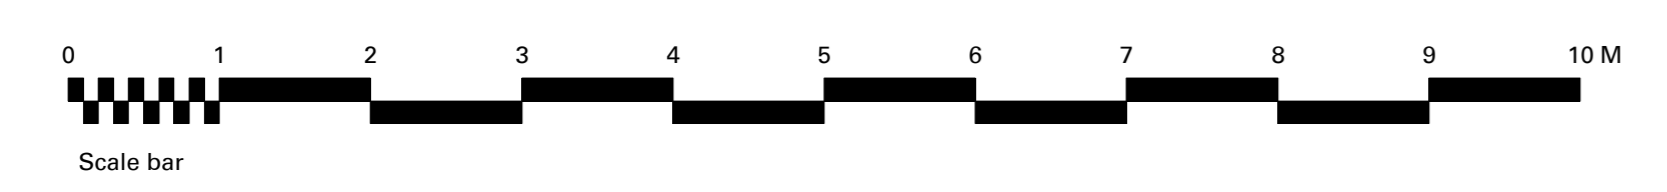

Rev	Date	Notes
-	07-12-2015	New Drawing

Project	
Oliver Bonas	
62-63 Tottenham Court Road	
1-3 Goodge Street	
Camden	
W1T 2EP	
Drawing	
Roof Plan	
Location of HVAC Plant	
Scale	Drawn by
1:50 @ A0	CP
Number	Revision
OBTCR-GA011	-

Do not scale from this drawing.
 All dimensions are in millimeters unless otherwise stated. All dimensions must be verified on site and any discrepancies reported to AMD.