



PROPOSED

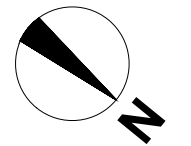

extract duct o/h and extract system as existing

rev amendments date by

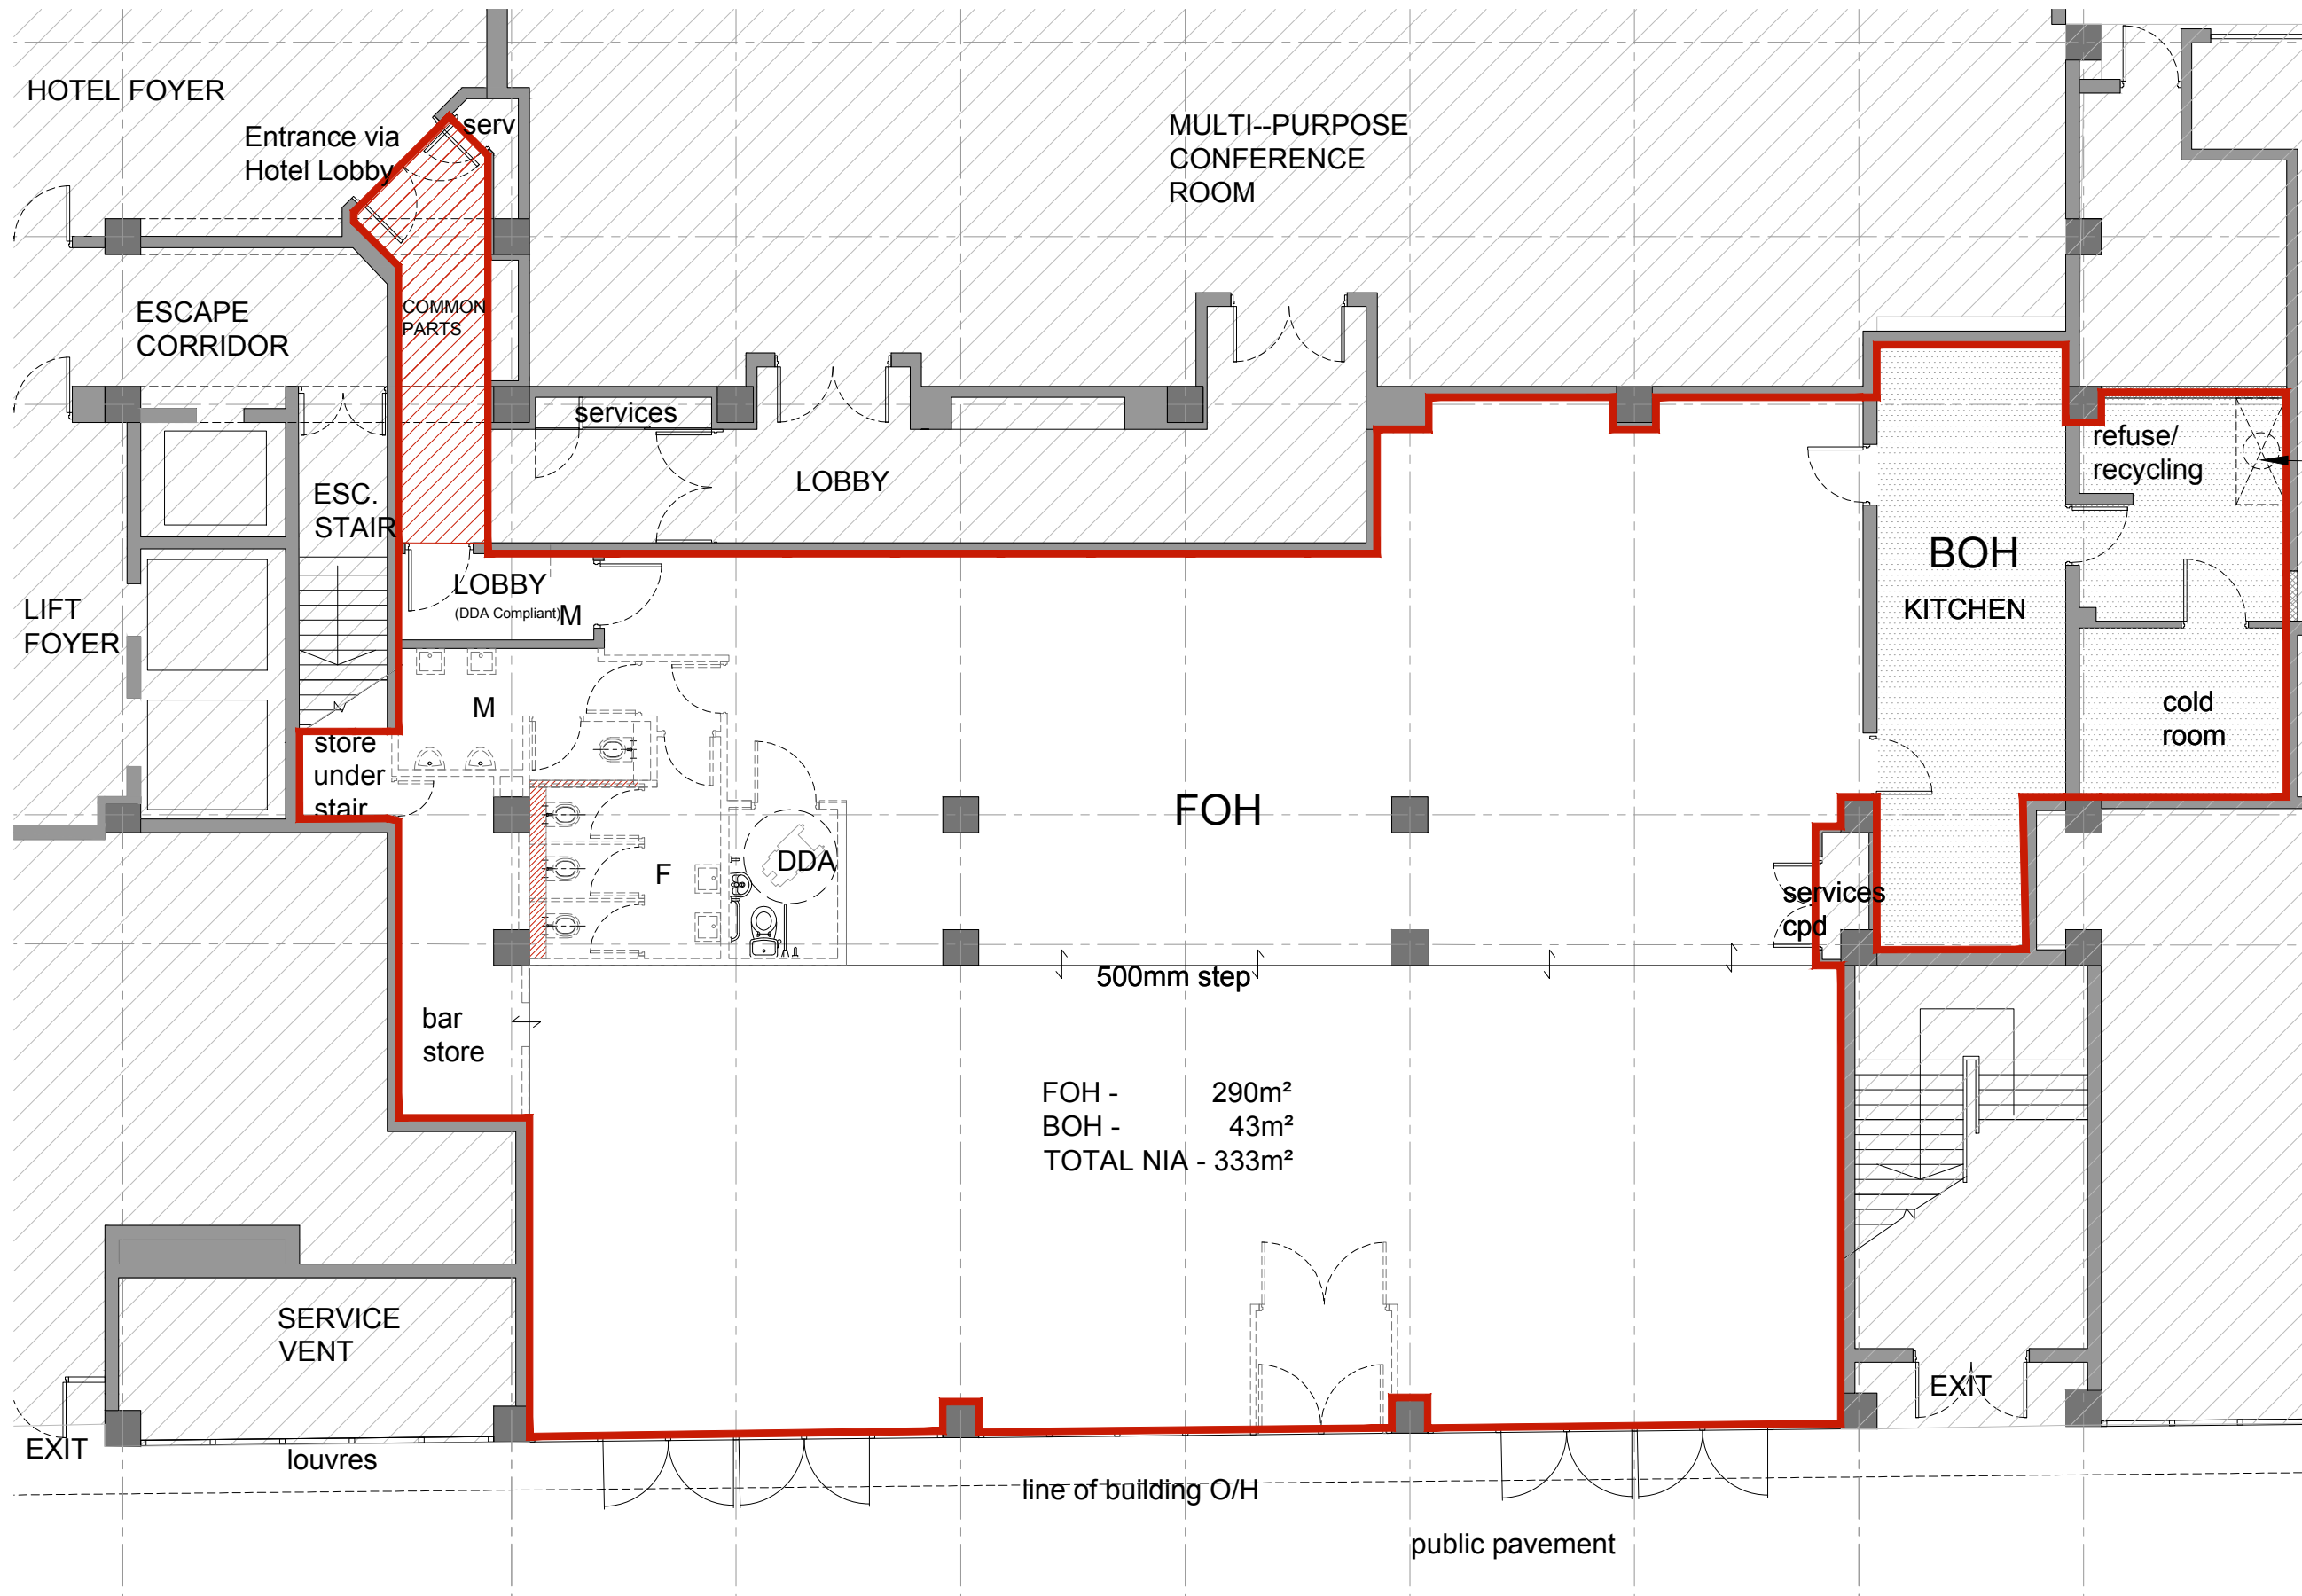

55 Kingstown Street
London NW1 8JP
T +44 (0) 20 7436 1133
W ipa-architects.com

Project
**ROYAL NTL. HOTEL
A3 UNIT
40-42 WOBURN PLC
LONDON, WC1H 0JX**

Drawing Title
**PROPOSED
GROUND FL PLAN**

Drawing Status
PLANNING

Date 22/12/2015 Drawn by RVW

Scale A3 @ 1:100 -/---

Drawing No. 14E8.LO.100 Rev 01

Cad File 14E8.LO.100-01.dwg

© IPA Architects: All rights reserved.

1 GROUND FLOOR PLAN

Scale: 1:100 @ A3

