




ELEVATION A - A

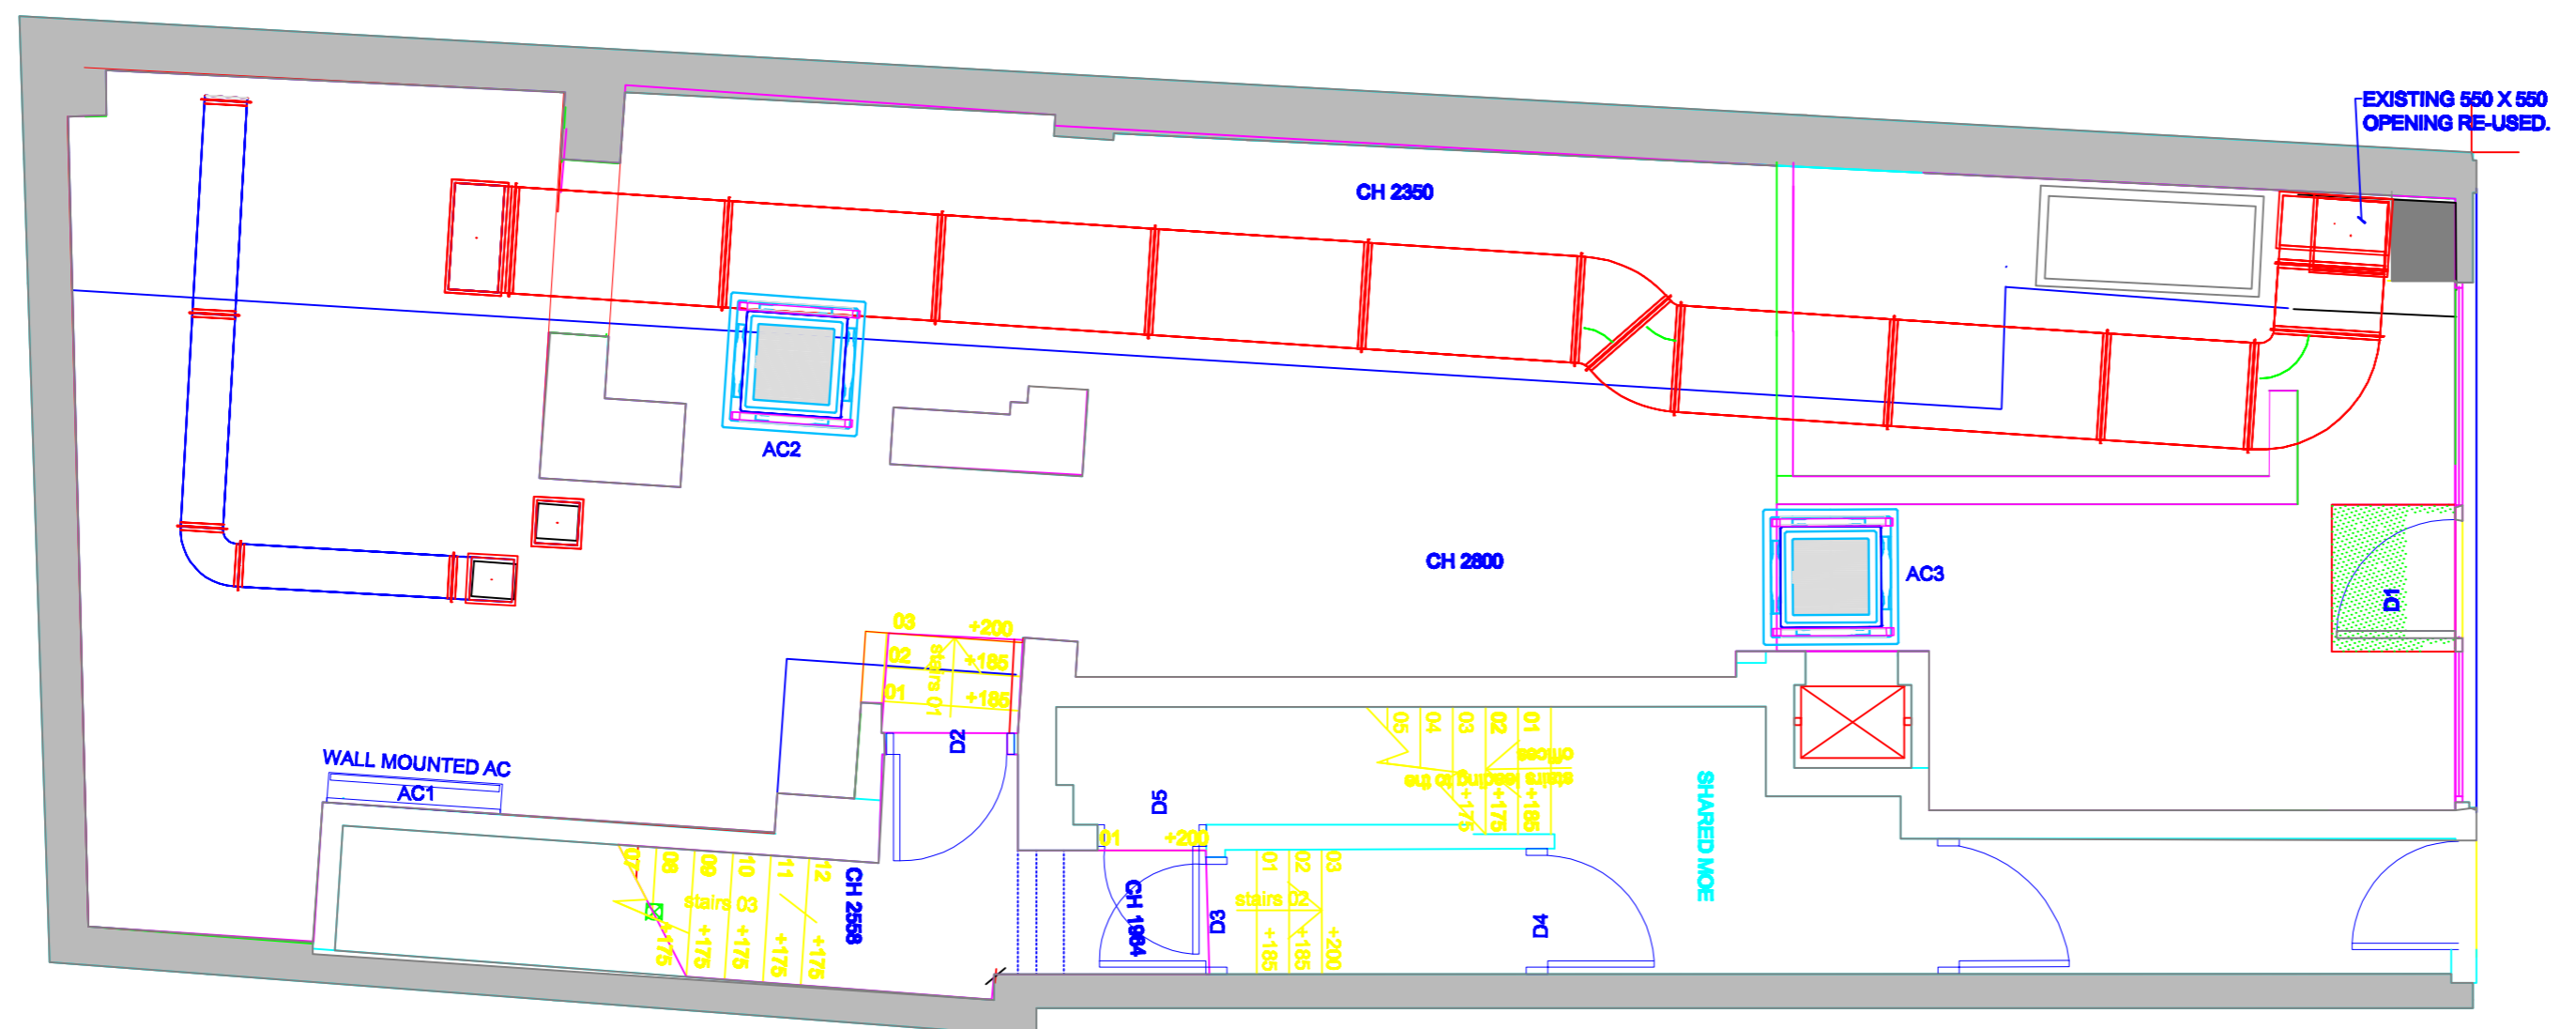

GROUND FLOOR LEVEL

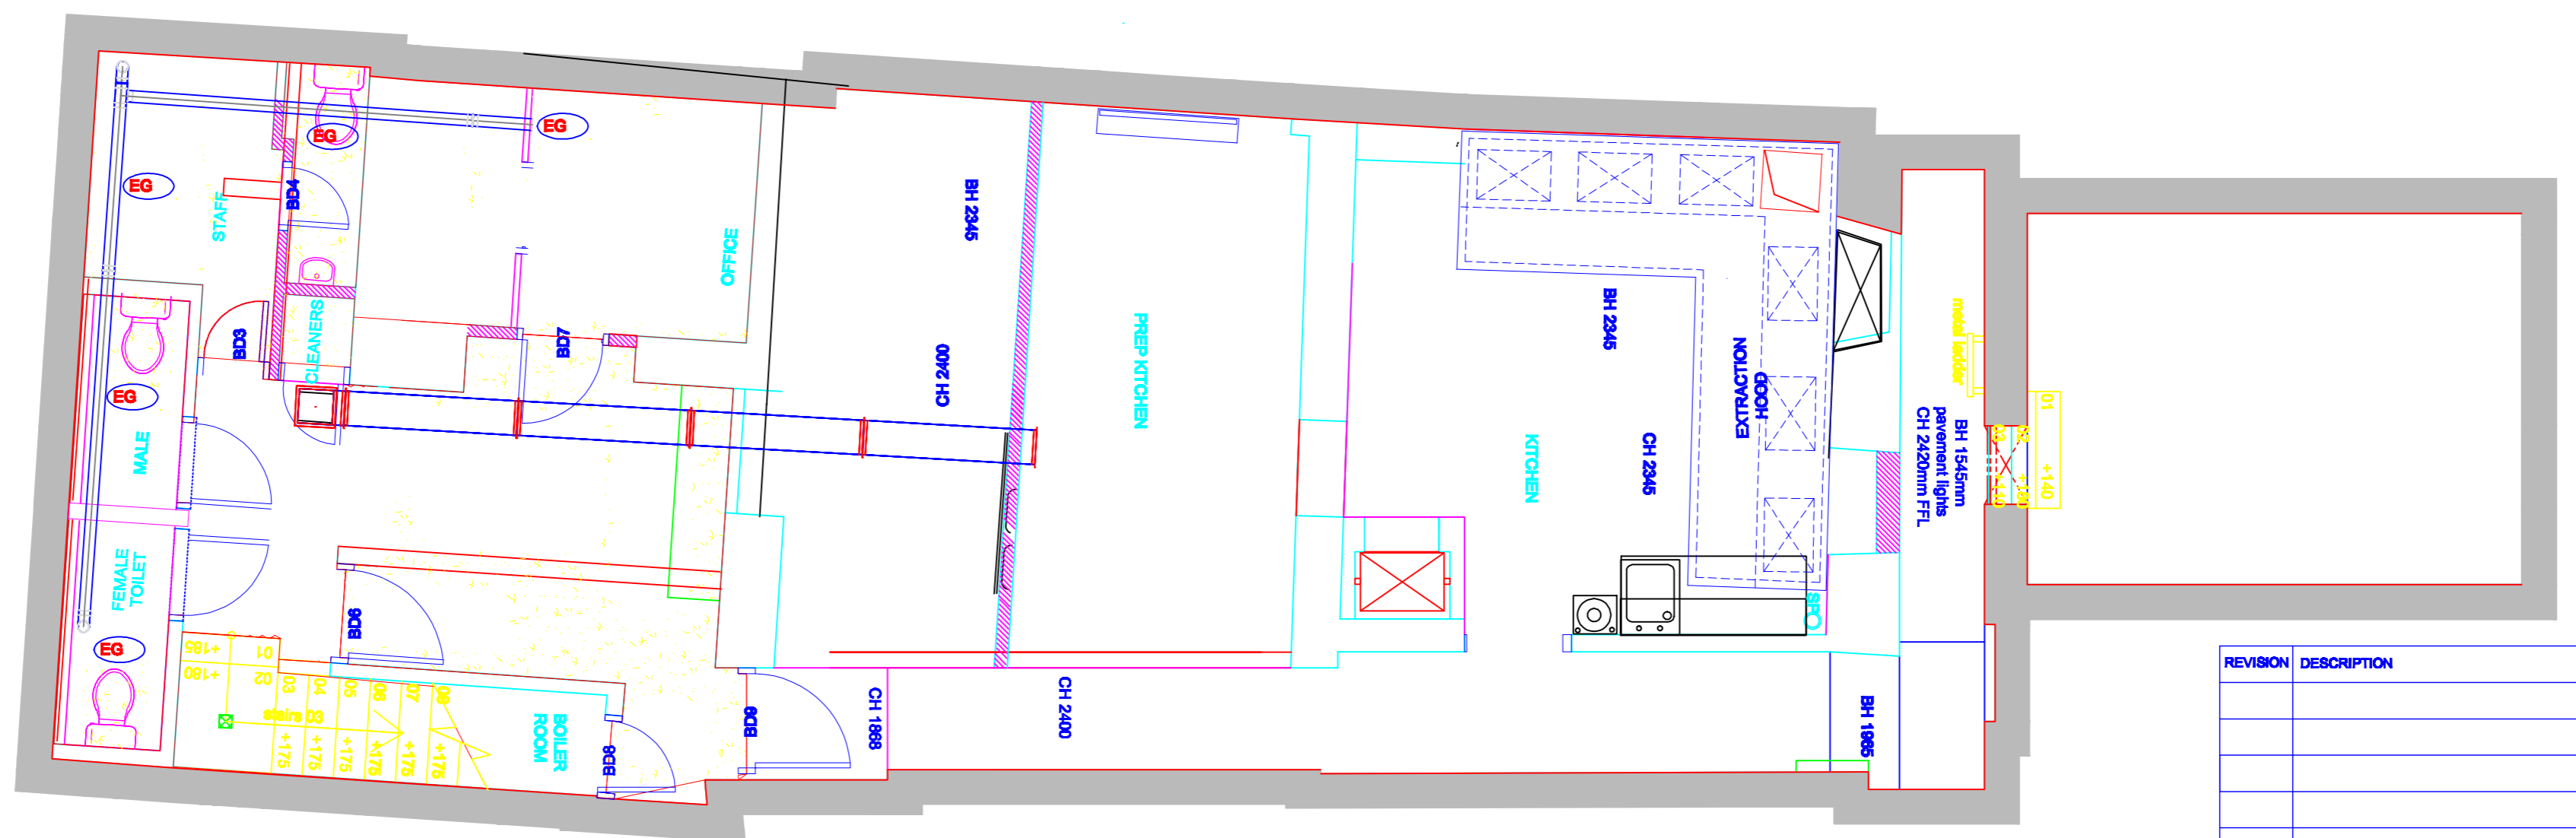

BASEMENT LEVEL

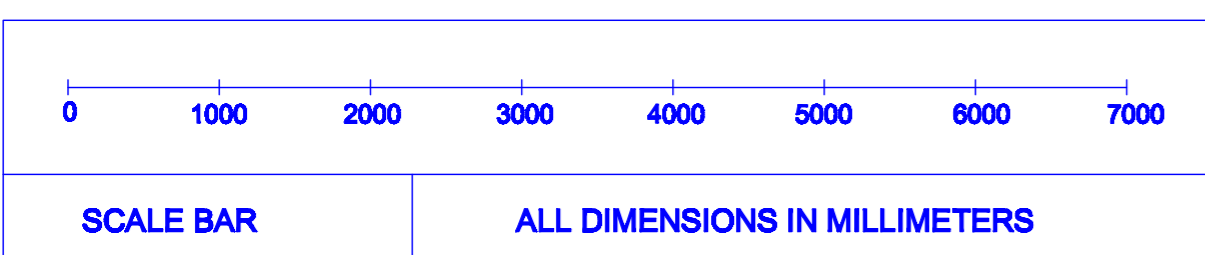

AIRCONDITIONING AND FAN DETAILS							
UNIT	POSITION	SIZE / MODEL	KGS	SIZE W X D X H	POWER	RA	FUSED
AC 1	RESTAURANT	MTRUBR#MSZ-GF80VE	30.0	1190 X 700 X 200	1PH 240V 14.5	20.0	
AC 2	RESTAURANT	MTRUBR#SLZ-KA25 VAG3	28.0	840 X 330 X 880	1PH 240V 16.6	20.0	
AC 3	RESTAURANT	MTRUBR#SLZ-KA25 VAG3	28.0	840 X 330 X 880	1PH 240V 16.6	20.0	
CU 1	REAR ROOF	MTRUBR#MUZ-GF80VE	30.0	1190 X 700 X 200	1PH 240V 14.5	20.0	
CU 2	REAR ROOF	MTRUBR#SUZ-KA25V4M	30.0	940 X 940 X 320	1PH 240V 7.4	10.0	
CU 3	REAR ROOF	MTRUBR#SUZ-KA25V4M	30.0	940 X 940 X 320	1PH 240V 7.4	10.0	

REVISION	DESCRIPTION	DATE

**ALPOLLO AIR LTD**  
Unit 4 Freeland Way  
Slade Green  
Erith, Kent  
DA8 2LQ.  
TEL: 01322 333687  
FAX: 01322 333638  
Mail: info@alpolloair.co.uk

CLIENT: SHORYU  
SITE LOCATION: 35 GREAT QUEEN ST WC2

TITLE: EXISTING AIR-CONDITIONING AND VENTILATION LAYOUTS

DRAWN	AJM	CHECKED	APPROVED

SCALE: 1:50@A1 1:100@A3 DATE: 16.10.15

DRAWING NO.	REVISION
ALPVENT/SHORVG08/01	D