
 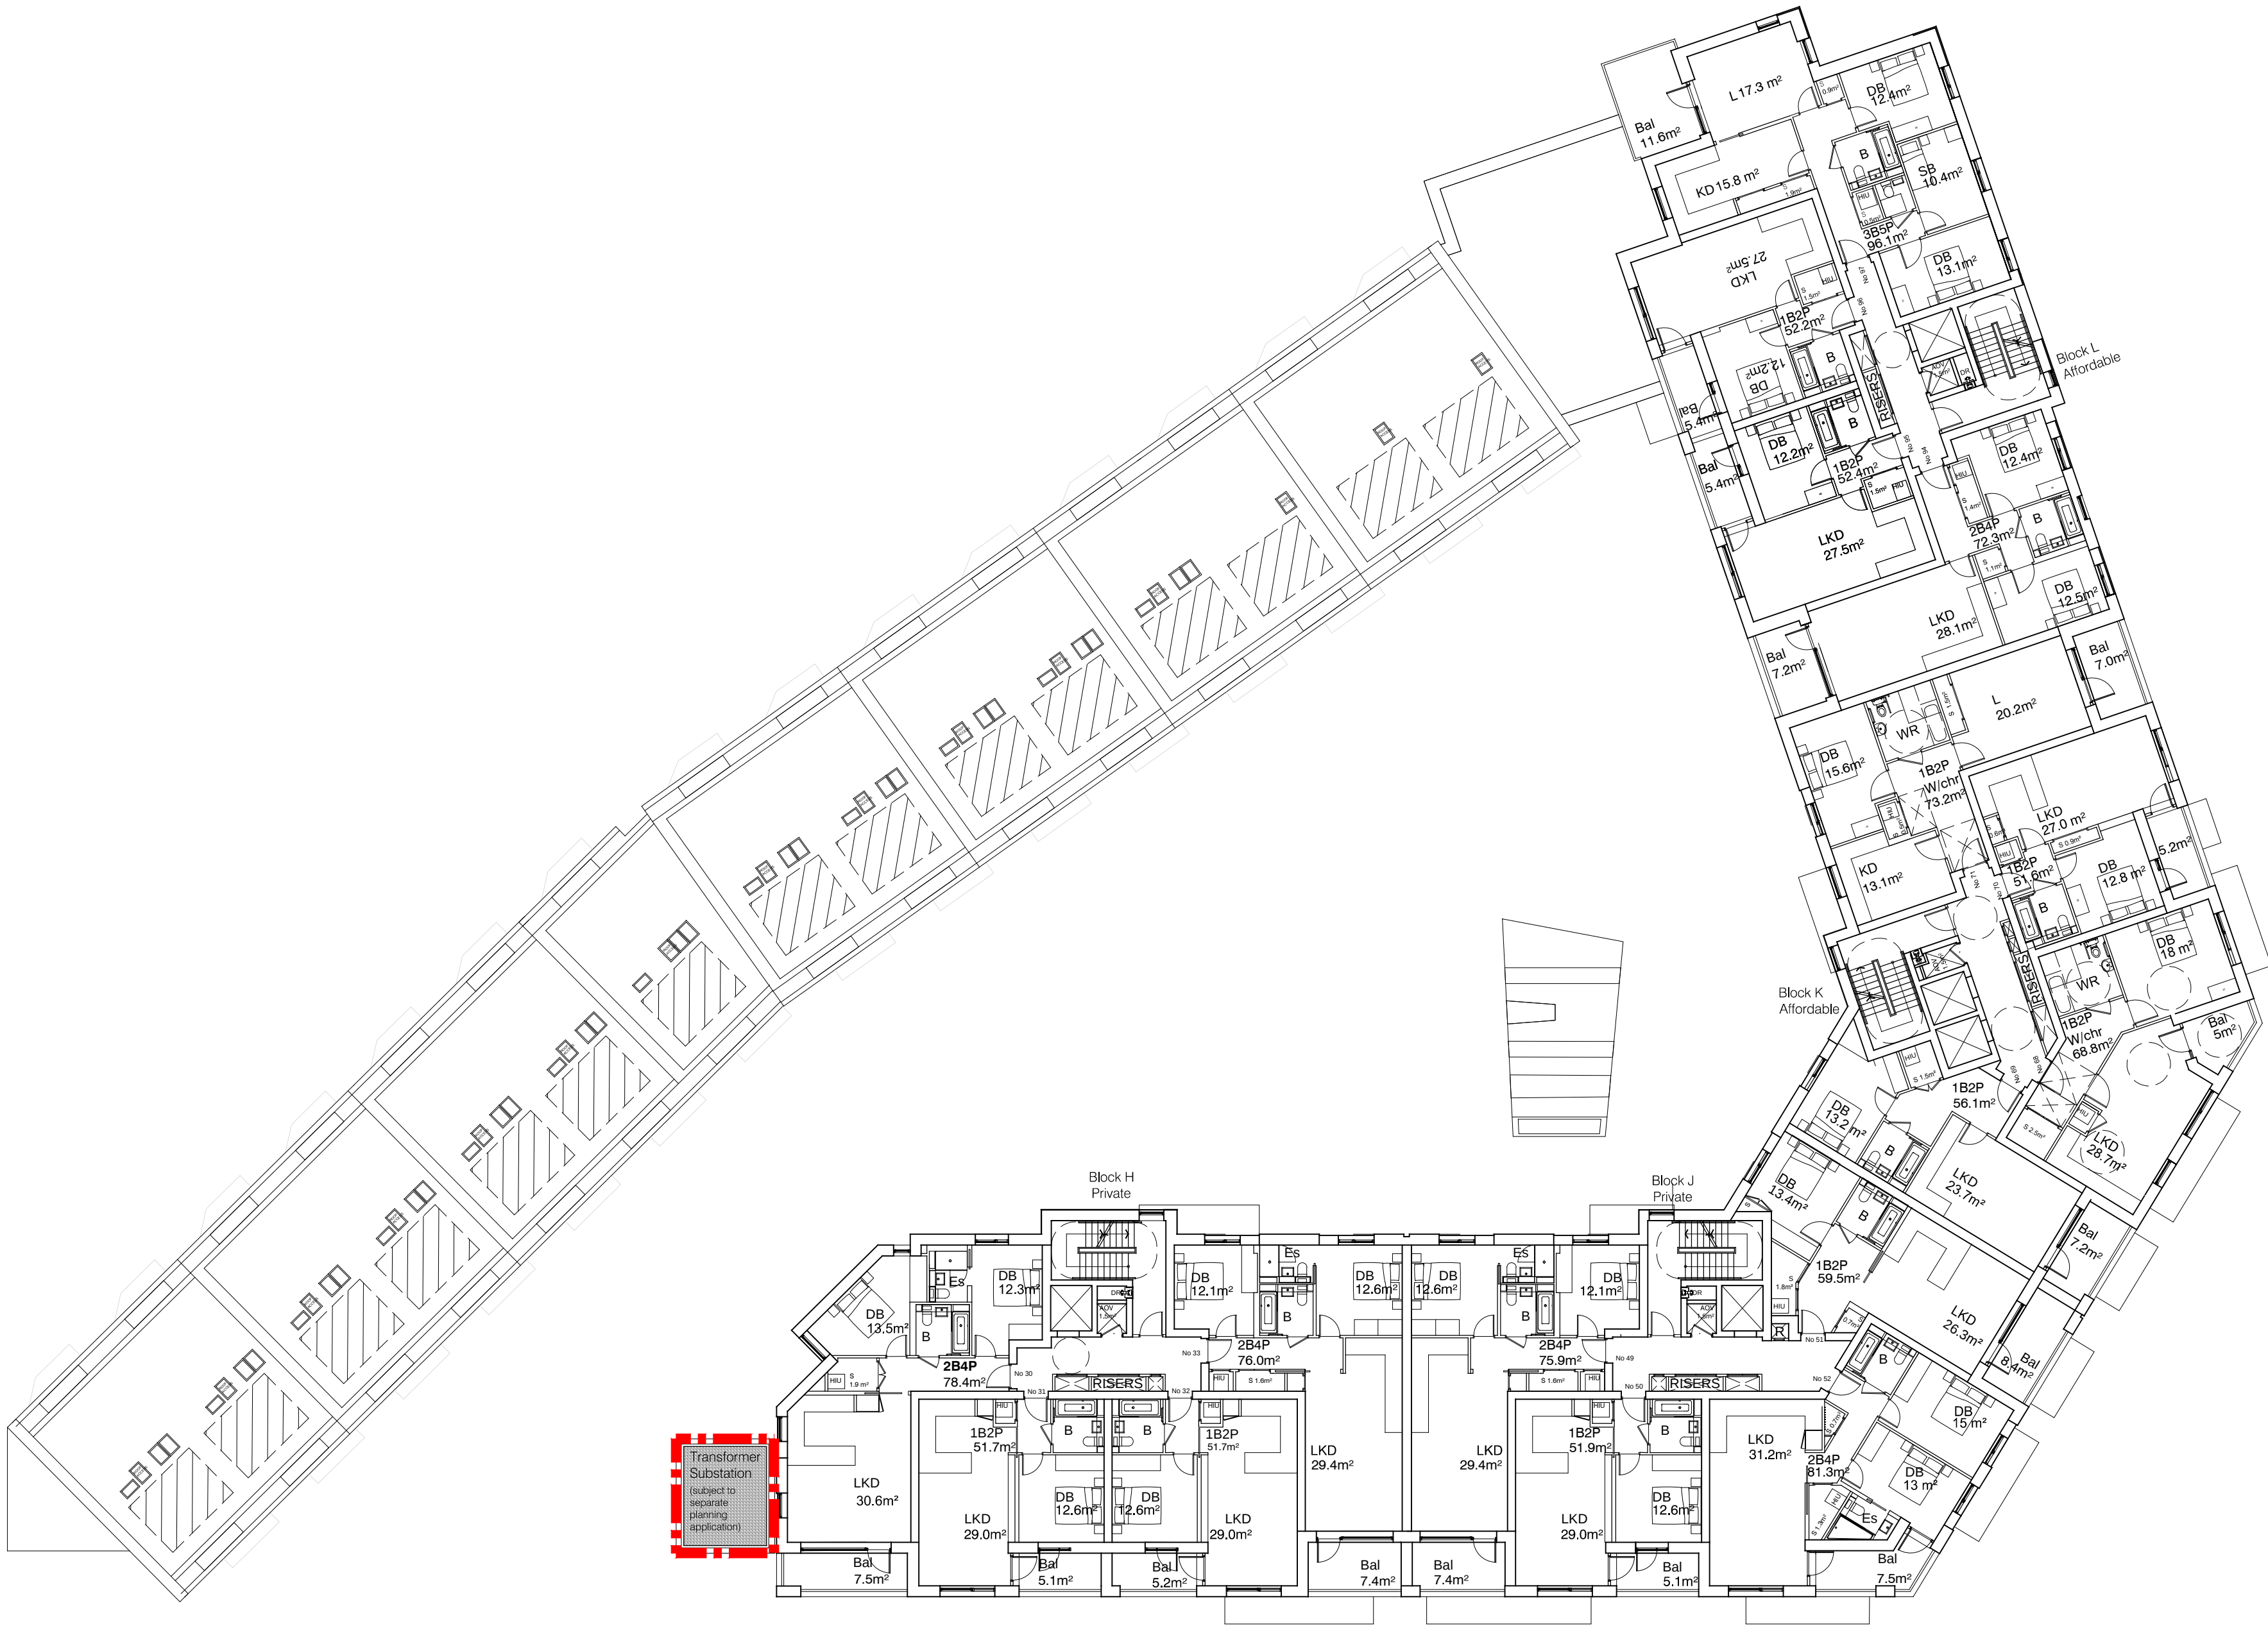



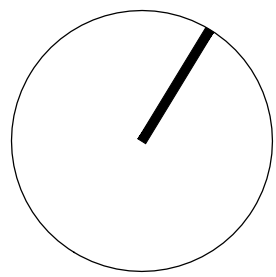

GENERAL NOTES		KEY:						
This drawing is © 2014 PTE architects		LKD	Combined living/kitchen/diner	B	Bathroom		CYL	Domestic hot water cylinder (to M.E specification)
Use figured dimensions only. DO NOT SCALE.		L	Living room	Es	En suite		Bo	Boiler (to M.E specification)
All dimensions are in millimetres unless noted otherwise		K	Kitchen	WC	Part M WC		Bal	Balcony
All levels are in metres above ordnance datum unless noted otherwise		D	Dining room	WR	Wet room		Ter	Terrace
This drawing must be read in conjunction with all other relevant drawings and specifications from the Architect and other consultants		DB	Double Bedroom	S	Storage		Gr	Garden
If in doubt, ask		SB	Single Bedroom	HIU	Heat Interface Unit/ Hot Water Supply (to M.E specification)			

rev	date	description	drawn	audited
1	14.08.15	ISSUED FOR PLANNING	EA	TP

PLANNING

Diespiker Wharf
38 Graham Street
London N1 8JX
020 7336 7777
forename.surname@ptea.co.uk
@ptearchitects
www.pollardthomasedwards.co.uk

Pollard
Thomas
Edwards

project	job no.	drawn	audited	scale	date
ABBEY ROAD REDEVELOPMENT London NW6	12-510-3	EA	TP	1:200@A1	JUL'15
drawing title	drawing number	revision			
General Arrangement Fourth Floor Plan	510-3_PL_104	-			

E:\12_510-3 ABBEY AREA REGENERATION\003_OUT\2015_08_14 PLANNING ISSUED\510-3_PL_104.DWG