


CEILING STRATEGY:

- NEW MF PLASTERBOARD CEILING*
- NEW 600X600 SUSPENDED CEILING SET AT 2700mm FROM FINISHED FLOOR LEVEL.
- NEW MF PLASTERBOARD CEILING WITH UPSTAND, HEIGHT SET AT 2700mm FROM FINISHED FLOOR LEVEL.

*IN TOILETS AREAS, THIS WILL BE MORTURE RESISTANT MF PLASTERBOARD AT 2700mm AFFL.
 *CEILING ABOVE WATER DISPENSER FLOOR TO MF PLASTERBOARD IS 2000mm.

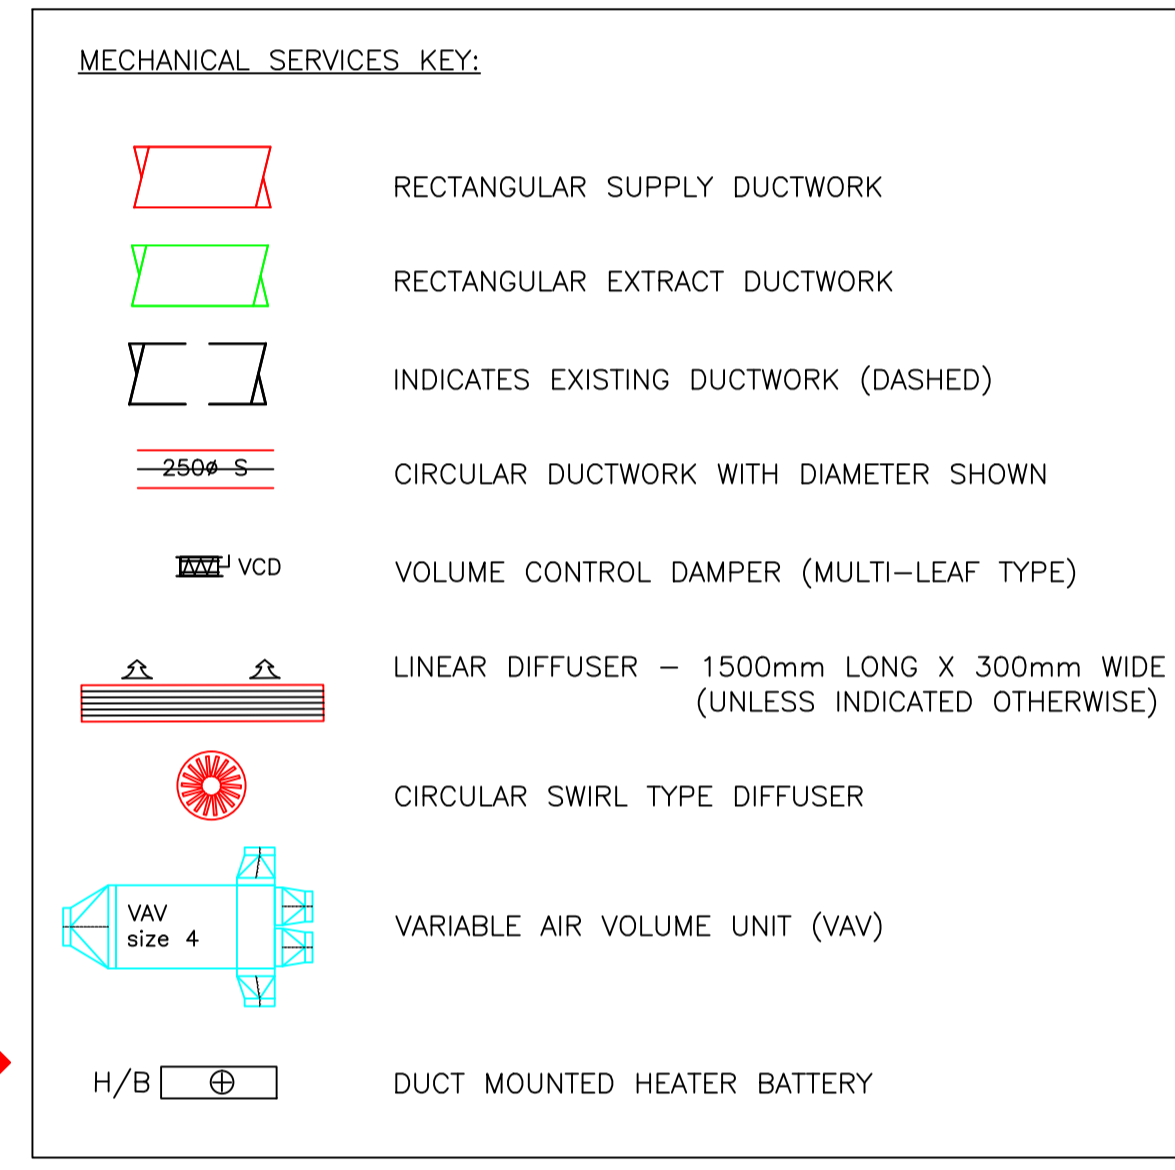

FOR CONTINUATION REFER TO DRG. Q5615-M300-3

STAIR 14

A/C PLANT

STAIR 7

REV	DATE	DESCRIPTION	CHK
R7	07.01.16	GENERAL REVISION	PM
R6	06.01.16	GENERAL REVISION	PM
R5	02.12.15	CHANGES TO VAV REFERENCES	PM
R4	16.12.15	CHANGES DUE TO DESIGN DEVELOPMENT	PM
R3	27.11.15	ISSUED FOR APPROVAL AND COMMENT	PM
R2	26.11.15	ISSUED FOR APPROVAL AND COMMENT	PM
R1	13.11.15	ISSUED FOR APPROVAL AND COMMENT	PM
REV	DATE	DESCRIPTION	CHK

KENTEX SERVICES
 Pilgrims House, Unit 3
 Links Business Centre
 Old Woking Road, Old Woking
 Surrey GU22 8BF
 Tel: 01483 712660
 Fax: 01483 712661
 E-mail: CA@kentex-group.com
 www.kentex-group.com

Client
WE WORK
 WATERHOUSE SQUARE
 HOLBORN BARS
 LONDON

Drawing title
SECOND FLOOR
 PROPOSED VENTILATION LAYOUT
 (SHEET 2 OF 2)

Drawing Status
 ISSUE FOR COMMENTS/APPROVAL

Job Ref.	Drawing Number	Revision
Q5615	M300-4	R7

Drawn by: S.L. Scale: 1:50
 Design Date: 13.11.15 Paper Size: A0
 Second Drawing Date: 13.11.15 Check: PM

