


NEW .550 x .780 VENT  
ROOF LIGHT

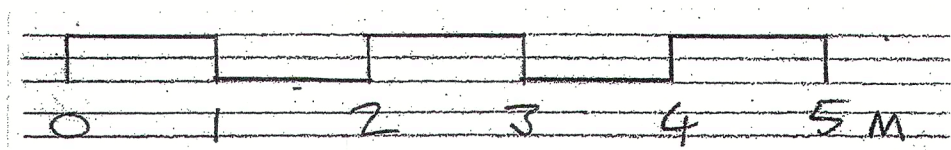

rev	
<b>STEVEN ADAMS RIBA ARCHITECTS</b>	
28b ENGLANDS LANE LONDON NW3 4UE Tel 020 7722 7664 Fax 7722 7652	
project	no
6 GREENWAY GARDENS LONDON NW3	695
drawing	no
ROOF PLAN PROPOSED	GA.04
scale 1:50	date 14.12.15
drawn MAA	checked