


FOR DETAILED SECTION, SEE 312.PL.015

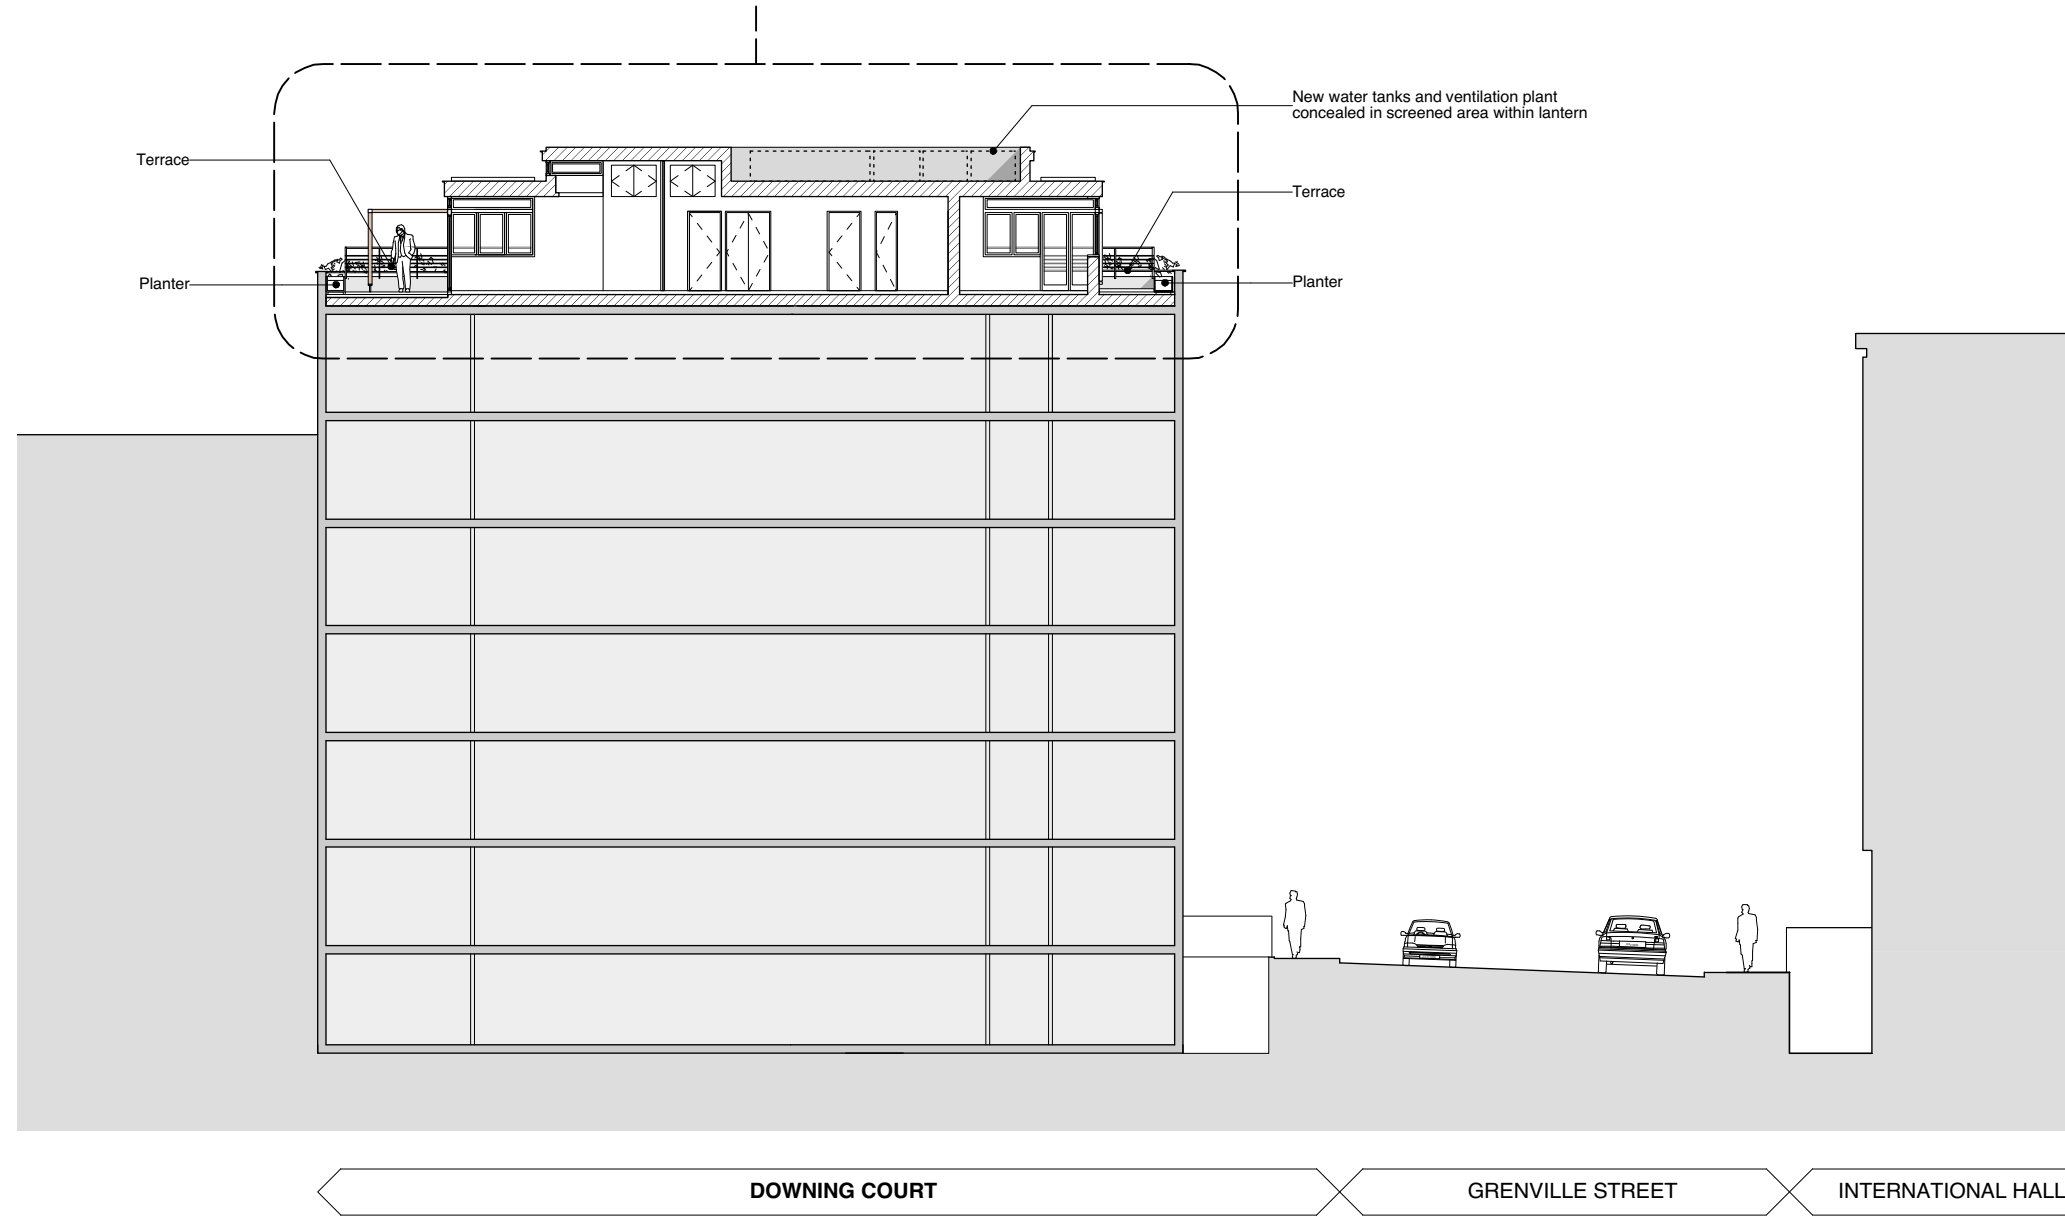

Terrace

Planter

New water tanks and ventilation plant
concealed in screened area within lantern

Terrace

Planter

DOWNING COURT

GRENVILLE STREET

INTERNATIONAL HALL

DRAWING: PROPOSED SECTION CC

CLIENT: PHILCOL PROPERTIES LTD.

PROJECT: DOWNING COURT, GRENVILLE STREET, LONDON, WC1N 1LX

0 2 5 M

DRAWING NO: 312.PL.012

SCALE: 1:200@A3 / 1:100@A3

DATE: MAY 2015

DRAWING STATUS: PLANNING

McDowell+Benedetti

34-35 Hatton Garden, London EC1N 8DX
email@McDowellBenedetti.com

t. 020 3475 7500
f. 020 3475 7501