


NOTES

THIS DRAWING IS TO BE READ IN CONJUNCTION WITH THE DRAWING KEY 5130-001.

© LIGHTING DESIGN INTERNATIONAL 2016.

DO NOT SCALE FROM THIS DRAWING. ANY DISCREPANCIES OR QUERIES ARE TO BE RAISED WITH LIGHTING DESIGN INTERNATIONAL FOR CLARIFICATION.

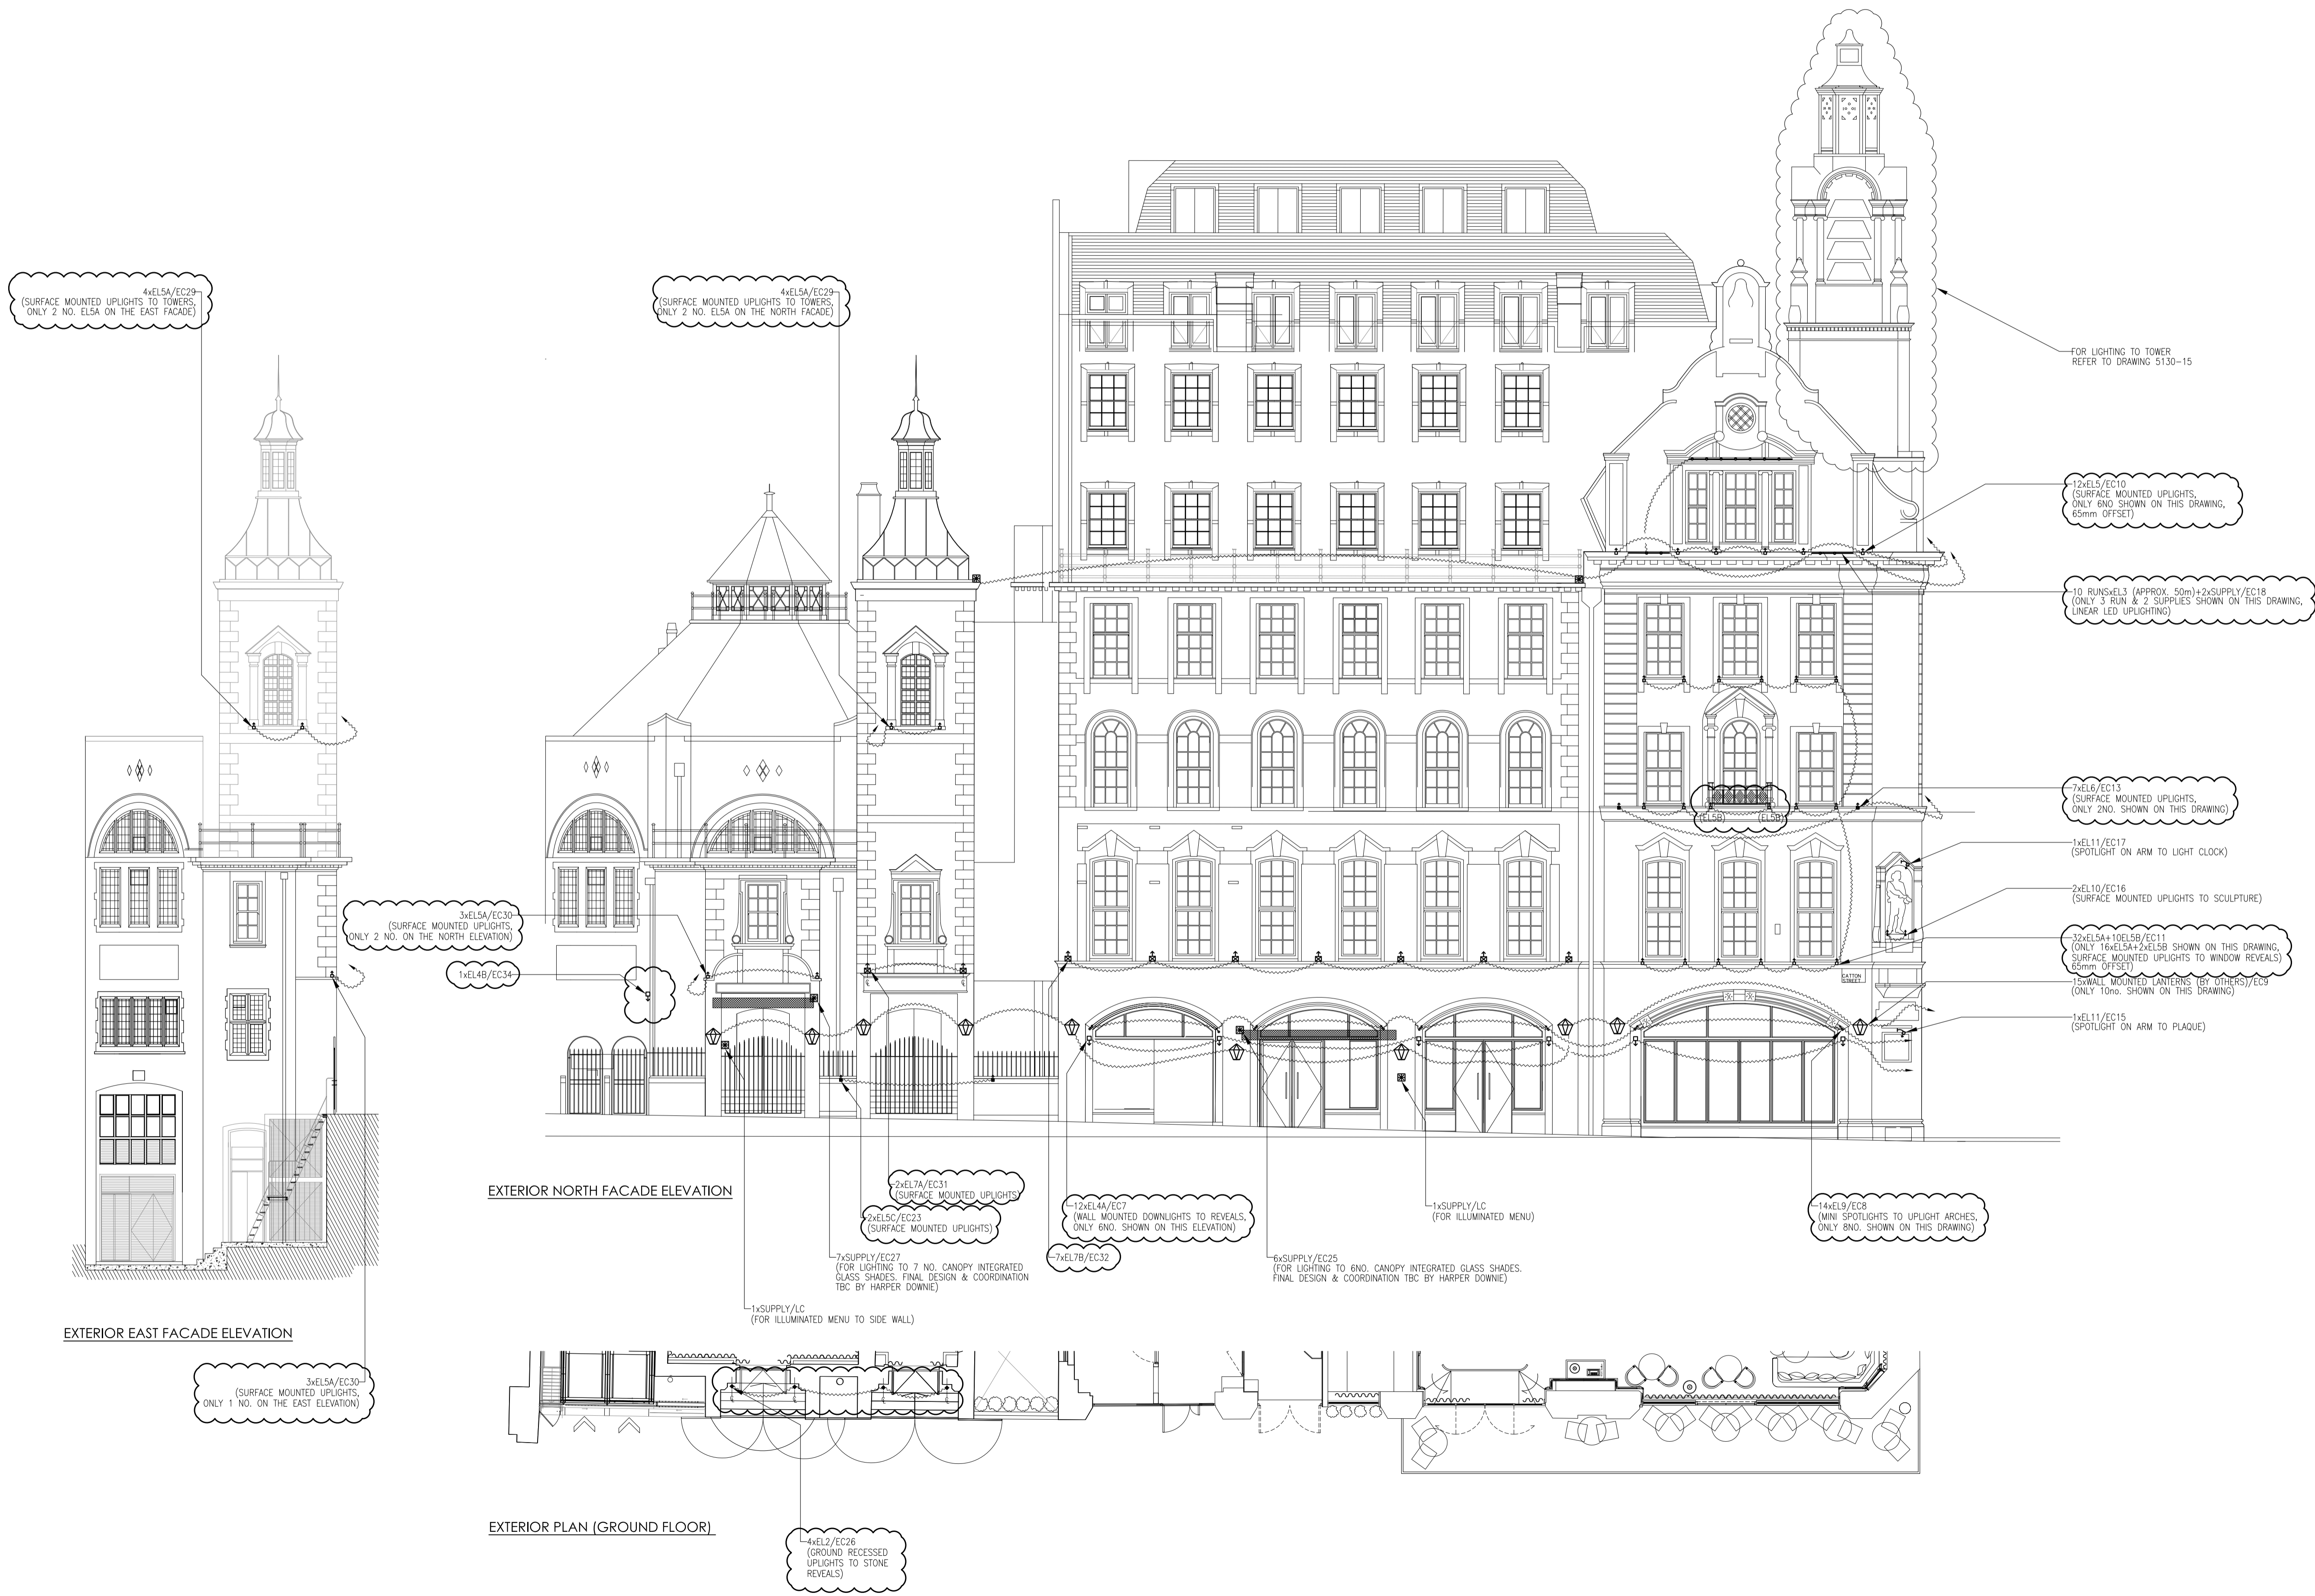

E	MINOR AMENDMENTS (CLOUDED)	15.01.2016
D	MINOR AMENDMENTS (CLOUDED)	16.10.2015
C	ISSUED FOR CONSTRUCTION	21.09.2015
B	ISSUED FOR CONSTRUCTION	23.07.2014
A	ISSUED FOR TENDER (T2 ISSUE)	09.08.2013
-	ISSUED FOR TENDER (T2 ISSUE)	16.05.2013
REV	PURPOSE/STATUS OF ISSUE	ISSUE DATE

PROJECT:
2-6 SOUTHAMPTON ROW

DRAWING TITLE:
PROPOSED LIGHTING LAYOUT TO
NORTH FACADE ELEVATION

BACKGROUND/REF FILE:	
PROJECT NUMBER: 5130	SCALE: 1:100
DRAWING NO: 5130-16	REV: E
DRAWING SEE: A1	