


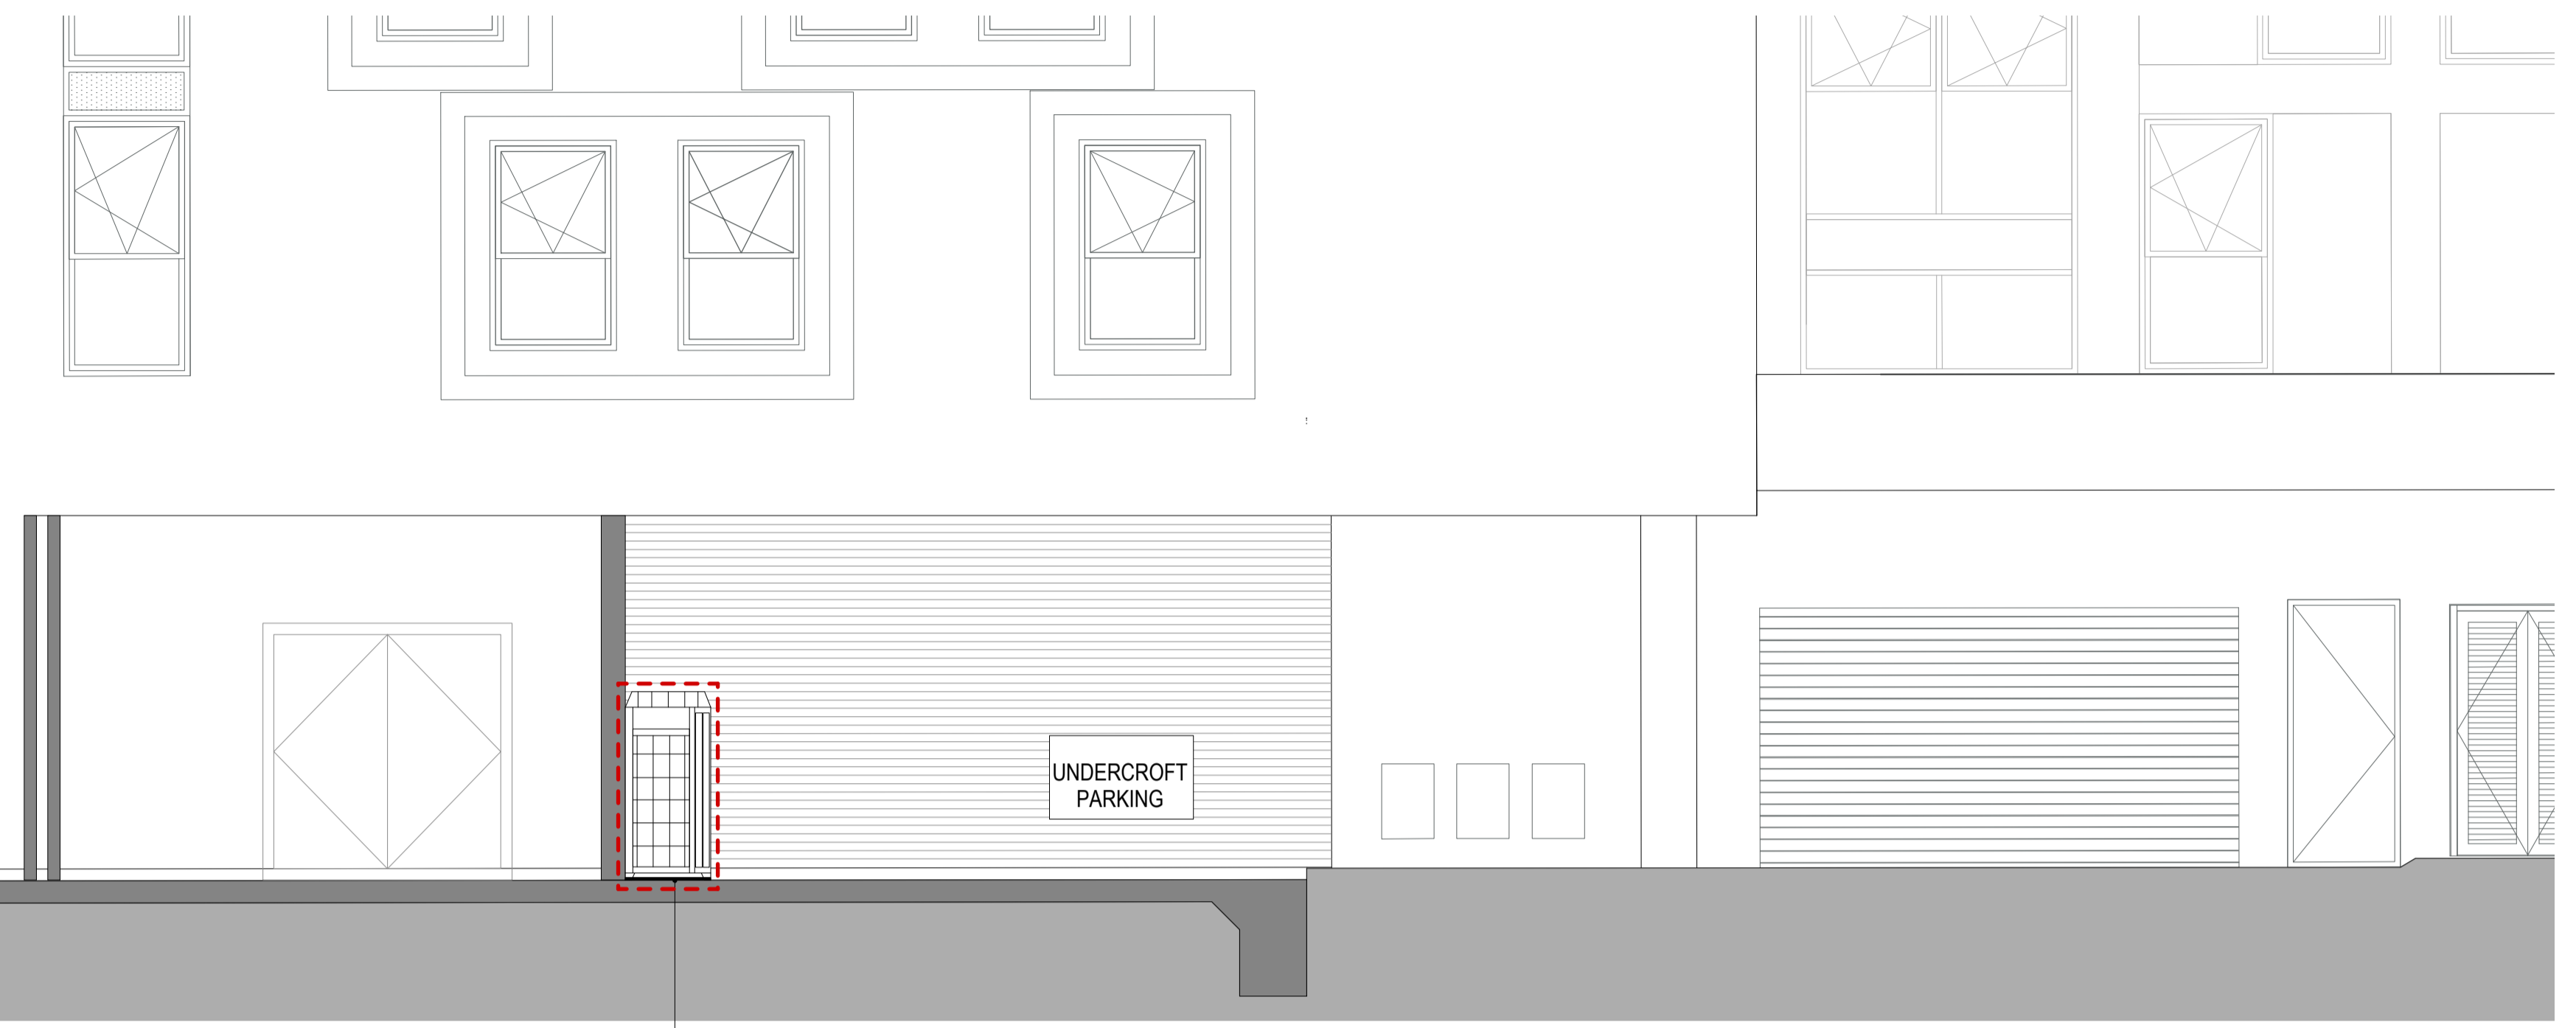

2 SERVICE YARD WEST ELEVATION




Rigid, corrosion protected steel base mounting frame for floor mounting unit.
Unit: 1240(w) x 765(d) x 1690(h)

SERVICE YARD

Proposed location of condenser unit.
Condenser unit to be floor mounted.
1240(w) x 765(d) x 1690(h)

1 SERVICE YARD SOUTH ELEVATION

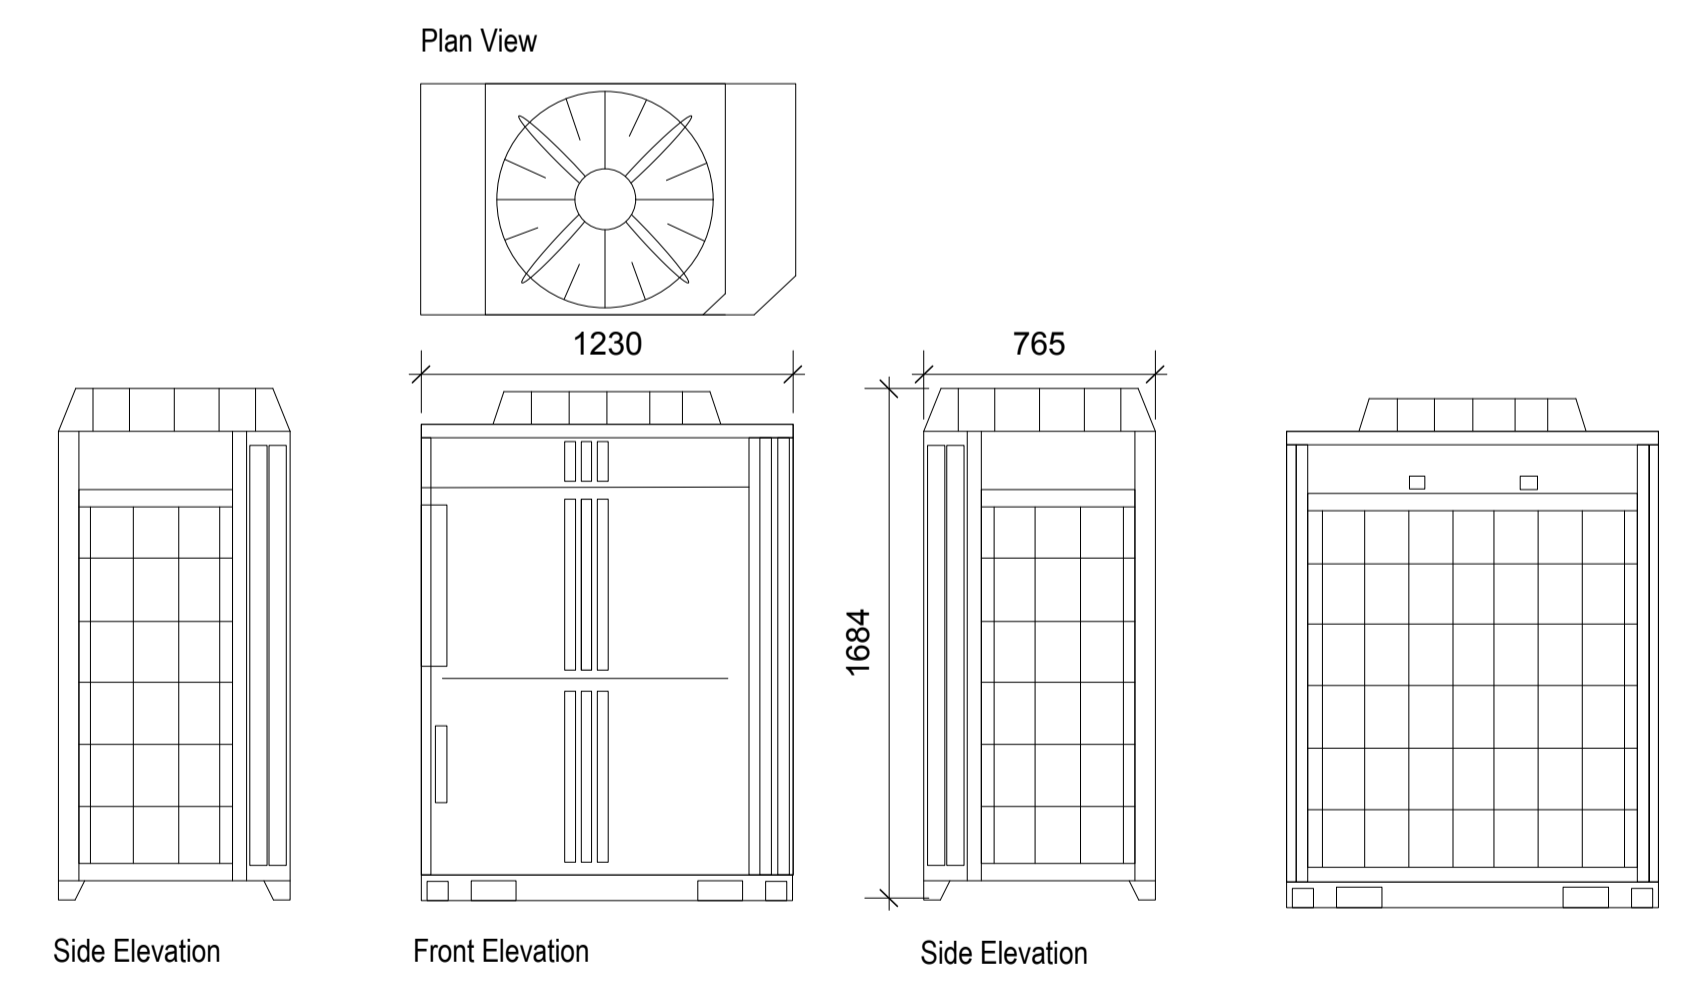

3 CONDENSER UNIT ELEVATIONS 1:25

PLANNING ISSUE

Rev	Date	Description	By	Chkd	App

THE COPYRIGHT DESIGN AND PATENTS ACT 1988 THIS DRAWING IS THE COPYRIGHT OF TIGG COLL ARCHITECTS LTD AND MUST NOT BE COPIED OR REPRODUCED IN WHOLE OR PART, BY ANY METHOD WHATSOEVER, WITHOUT THE PRIOR WRITTEN APPROVAL OF TIGG COLL ARCHITECTS LTD

ALL SETTING OUT MUST BE CHECKED ONSITE
ALL LEVELS MUST BE CHECKED ONSITE
ALL DIMENSIONS MUST BE CHECKED ONSITE
DO NOT SCALE FROM THIS DRAWING
THIS DRAWING MUST NOT BE USED ONSITE UNLESS ISSUED FOR CONSTRUCTION

TIGG+COLL ARCHITECTS
UNIT L17, THE OLD LABORATORIES
THE OLD GAS WORKS, 2 MICHAEL ROAD
LONDON, SW6 2AD
E:INFO@TIGGCOLLARCHITECTS.COM
T: 020 3170 6125
TIGGCOLLARCHITECTS.COM

Project		Nido West Hampstead, Blackburn Road	
Title		Proposed Condenser Unit Location Elevations	
Date	Scale [A1] 1:50	Drawing no.	Rev.
04.02.16	Scale [A3] 1:100	190-PL-1200	-