


[illegible]

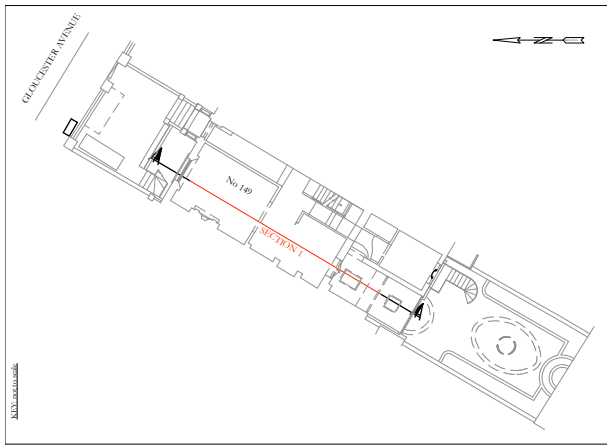

EXISTING WALLS

NEW PROPOSED WALLS

WOOD

JOINERY

TILED

CARPET

UNDERFLOOR HEATING

MECHANICAL LEGEND		ELECTRICAL LEGEND	
	EXTRACTOR		SINGLE 13A SOCKET
	COLD W FEED		TWIN 13A SOCKET
	HOT W FEED		SINGLE 5A SOCKET
	GAS		RAZOR SOCKET
	WATER TAP		FUSE SPUR
	AUTO WATERING		COOKER SWITCH
	U/F HEATING SENSOR		SMOKE DETECTOR
	THERMOSTAT		HEAT DETECTOR
	SOIL PIPE		CAT6/DATA SOCKET
	RAIN WATER PIPE		BT POINT
	INSPECTION CHAMBER		COAXIAL AERIAL SOCKET
ALARM LEGEND			SPEAKER POINT
	SENSOR		SWITCH
	DOOR CONTACT		DIMMER
	ALARM		WALL LIGHT
			RECESSED LIGHT
			PENDANT
			SPOTLIGHT
			LED STRIP

JOB TITLE 149 Gloucester Avenue

DRAWING NO.

GA/ 006
Rev E



DATE 26/01/2016

SCALE 1:50 @ A3

DRAWING TITLE

Proposed lower ground
floor plan

 
Indicative Drawings only.
Do not Scale
All dimensions to be
checked and approved.

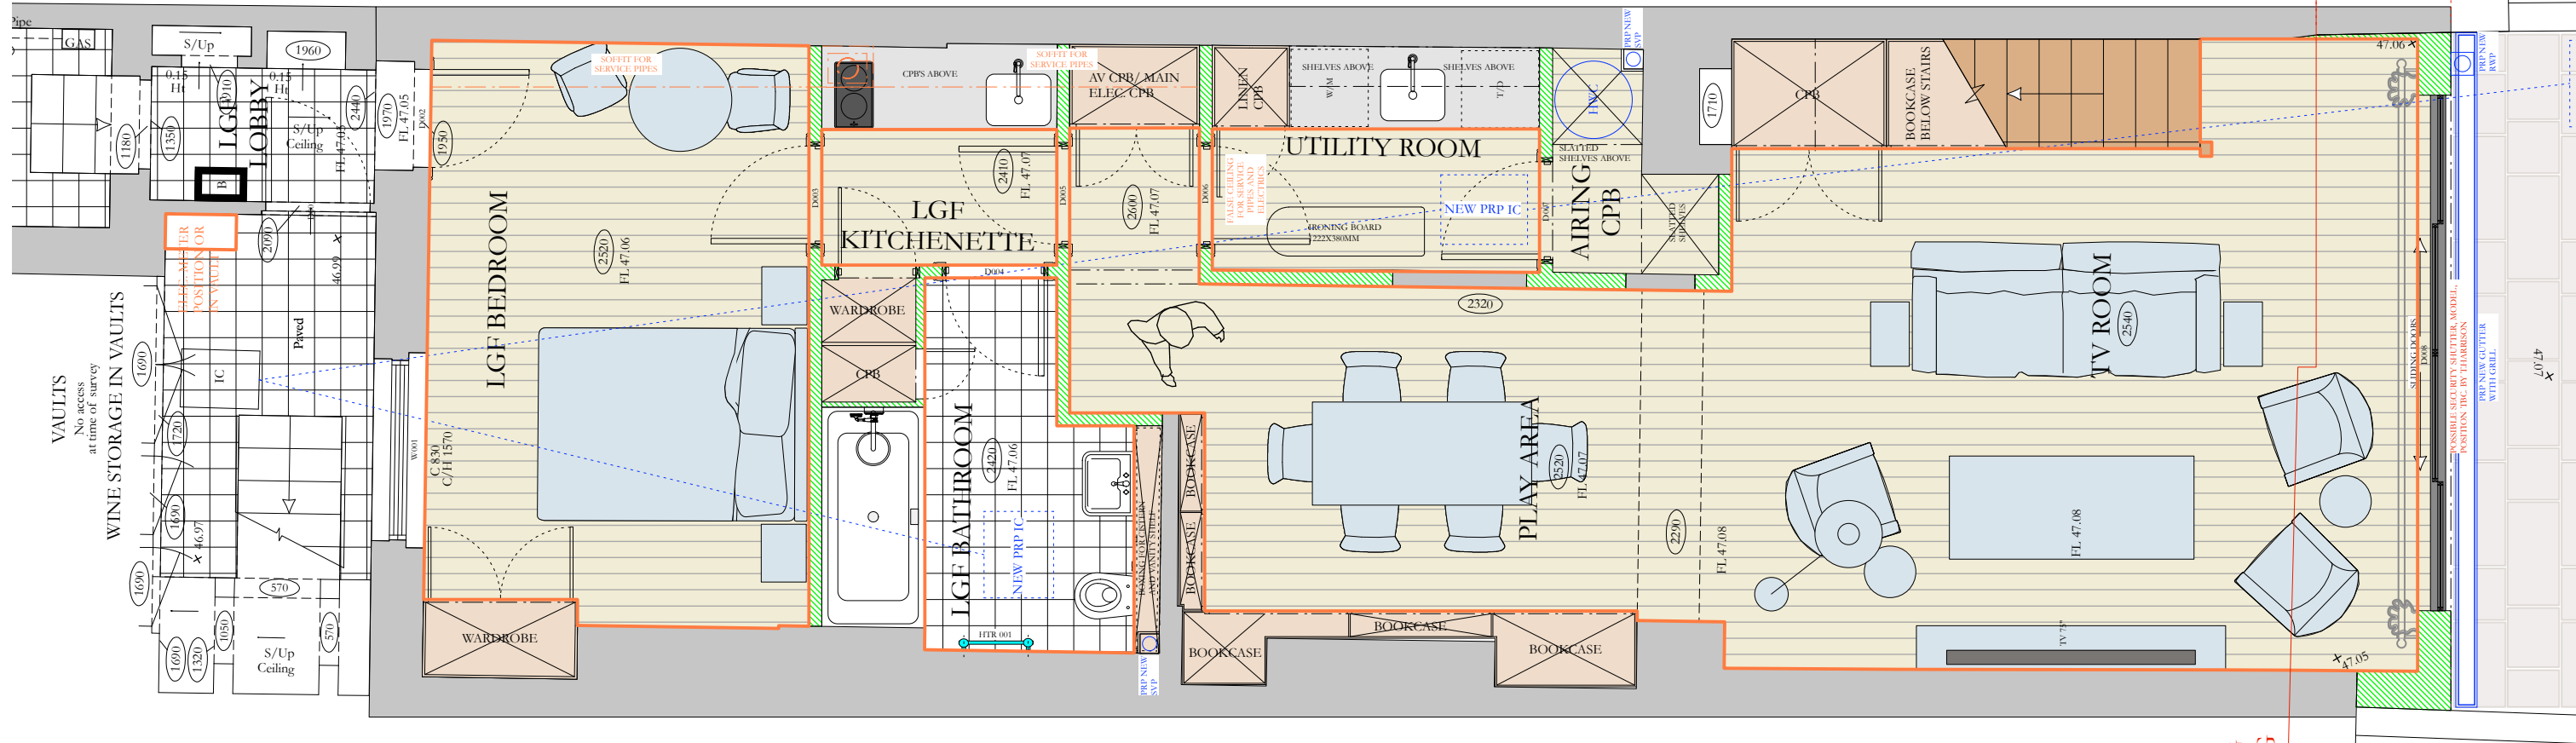

William Nickerson
Architectural and Interior Design

No. 9 Goldhawk Mews
London
W12 8PA

Tel: 0208 749 7900
Mobile: 07973 655 583
willie@willienickerson.com

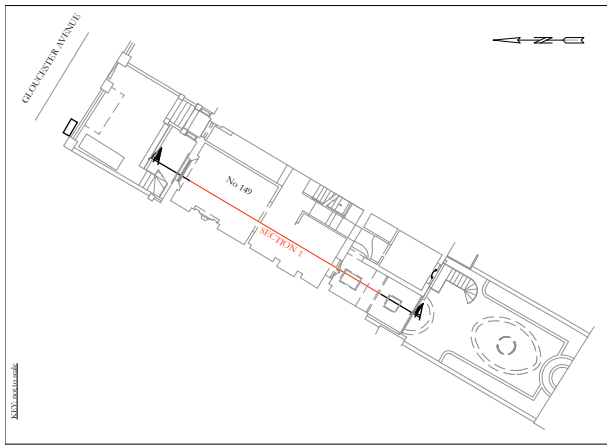

General notes;
- All switches and dimmers 40mm from architraves or as noted
- All sockets or as noted 40mm above skirtings
- 1050mm to the centre of all switches and dimmers or as noted

EXISTING WALLS

NEW PROPOSED WALLS

WOOD

JOINERY

TILED


CARPET

UNDERFLOOR HEATING

MECHANICAL LEGEND		ELECTRICAL LEGEND	
	EXTRACTOR		SINGLE 13A SOCKET
	COLD W FEED		TWIN 13A SOCKET
	HOT W FEED		SINGLE 5A SOCKET
	GAS		RAZOR SOCKET
	WATER TAP		FUSE SPUR
	AUTO WATERING		COOKER SWITCH
	U/F HEATING SENSOR		SMOKE DETECTOR
	THERMOSTAT		HEAT DETECTOR
	SOIL PIPE		CAT6/DATA SOCKET
	RAIN WATER PIPE		BT POINT
	INSPECTION CHAMBER		COAXIAL AERIAL SOCKET
ALARM LEGEND			SPEAKER POINT
	SENSOR		SWITCH
	DOOR CONTACT		DIMMER
	ALARM		WALL LIGHT
	DOORBELL		RECESSED LIGHT
			PENDANT
			SPOTLIGHT
			LED STRIP

JOB TITLE 149 Gloucester Avenue	
DRAWING NO. GA/ 006B Rev B	
DATE	26/01/2016
SCALE	1:50 @ A3
DRAWING TITLE Proposed electrical lower ground floor plan	

Indicative Drawings only.
Do not Scale
All dimensions to be checked and approved.

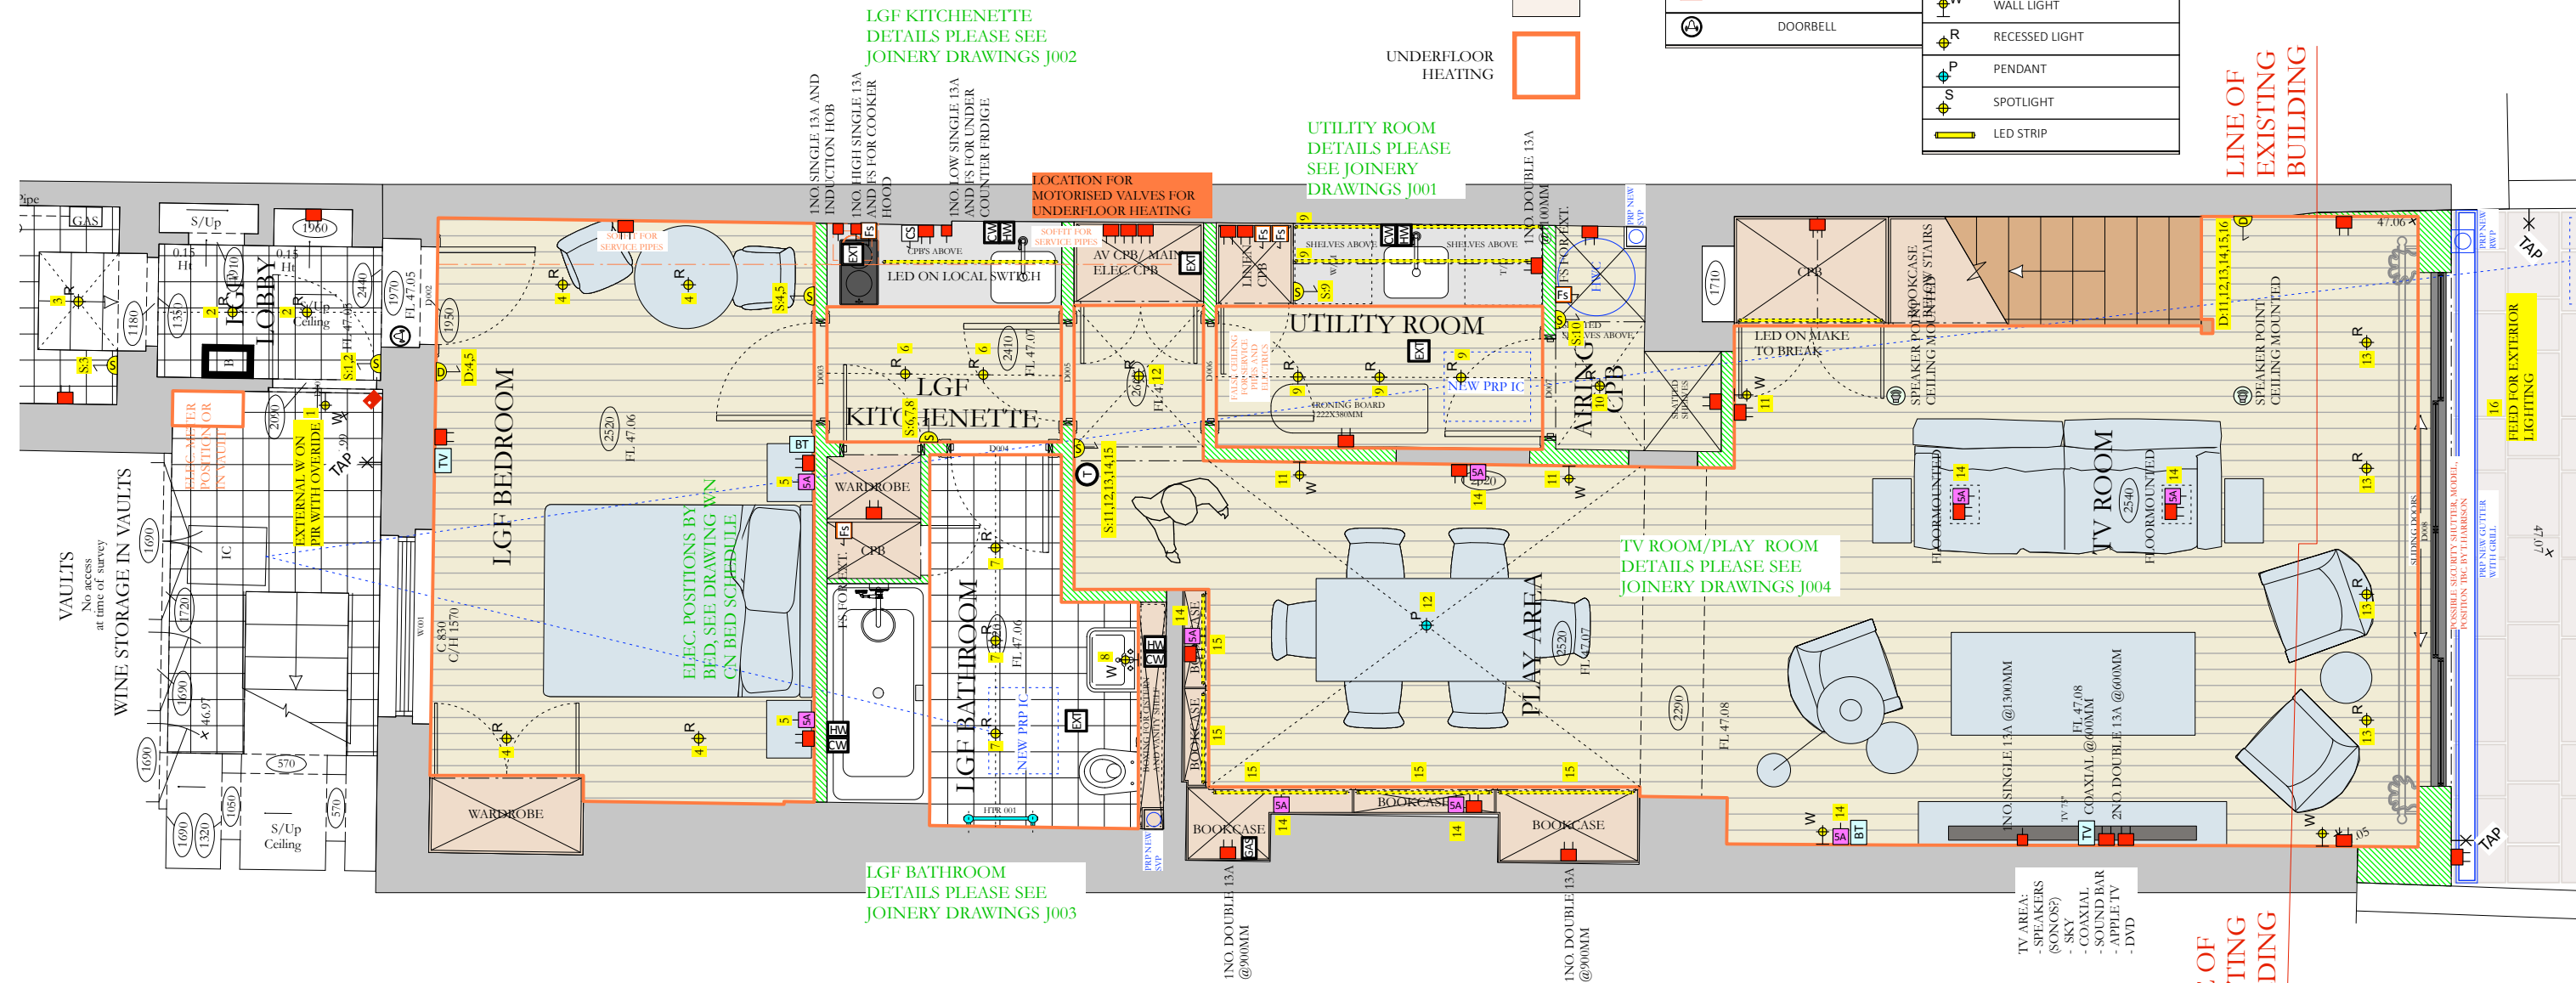


LINE OF EXISTING BUILDING

LINE OF EXISTING BUILDING

William Nickerson
Architectural and Interior Design

No. 9 Goldhawk Mews
London
W12 8PA

Tel: 0208 749 7900
Mobile: 07973 655 583
willie@willienickerson.com

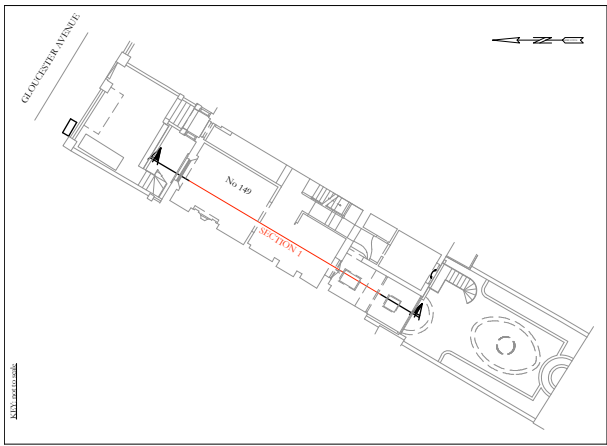

EXISTING WALLS

NEW PROPOSED WALLS

WOOD

JOINERY

TILED

CARPET

UNDERFLOOR HEATING

MECHANICAL LEGEND		ELECTRICAL LEGEND	
	EXTRACTOR		SINGLE 13A SOCKET
	COLD W FEED		TWIN 13A SOCKET
	HOT W FEED		SINGLE 5A SOCKET
	GAS		RAZOR SOCKET
	WATER TAP		FUSE SPUR
	AUTO WATERING		COOKER SWITCH
	U/F HEATING SENSOR		SMOKE DETECTOR
	THERMOSTAT		HEAT DETECTOR
	SOIL PIPE		CAT6/DATA SOCKET
	RAIN WATER PIPE		BT POINT
	INSPECTION CHAMBER		COAXIAL AERIAL SOCKET
ALARM LEGEND			SPEAKER POINT
	SENSOR		SWITCH
	DOOR CONTACT		DIMMER
	ALARM		WALL LIGHT
	DOORBELL		RECESSED LIGHT
			PENDANT
			SPOTLIGHT
			LED STRIP

William Nickerson
Architectural and Interior Design

No. 9 Goldhawk Mews
London
W12 8PA

Tel: 0208 749 7900
Mobile: 07973 655 583
willie@willienickerson.com

JOB TITLE 149 Gloucester Avenue


DRAWING NO.
GA/ 007
Rev G


DATE 25/02/2016

SCALE 1:50 @ A3

DRAWING TITLE
Proposed upper ground floor plan,


Indicative Drawings only.
Do not Scale
All dimensions to be checked and approved.

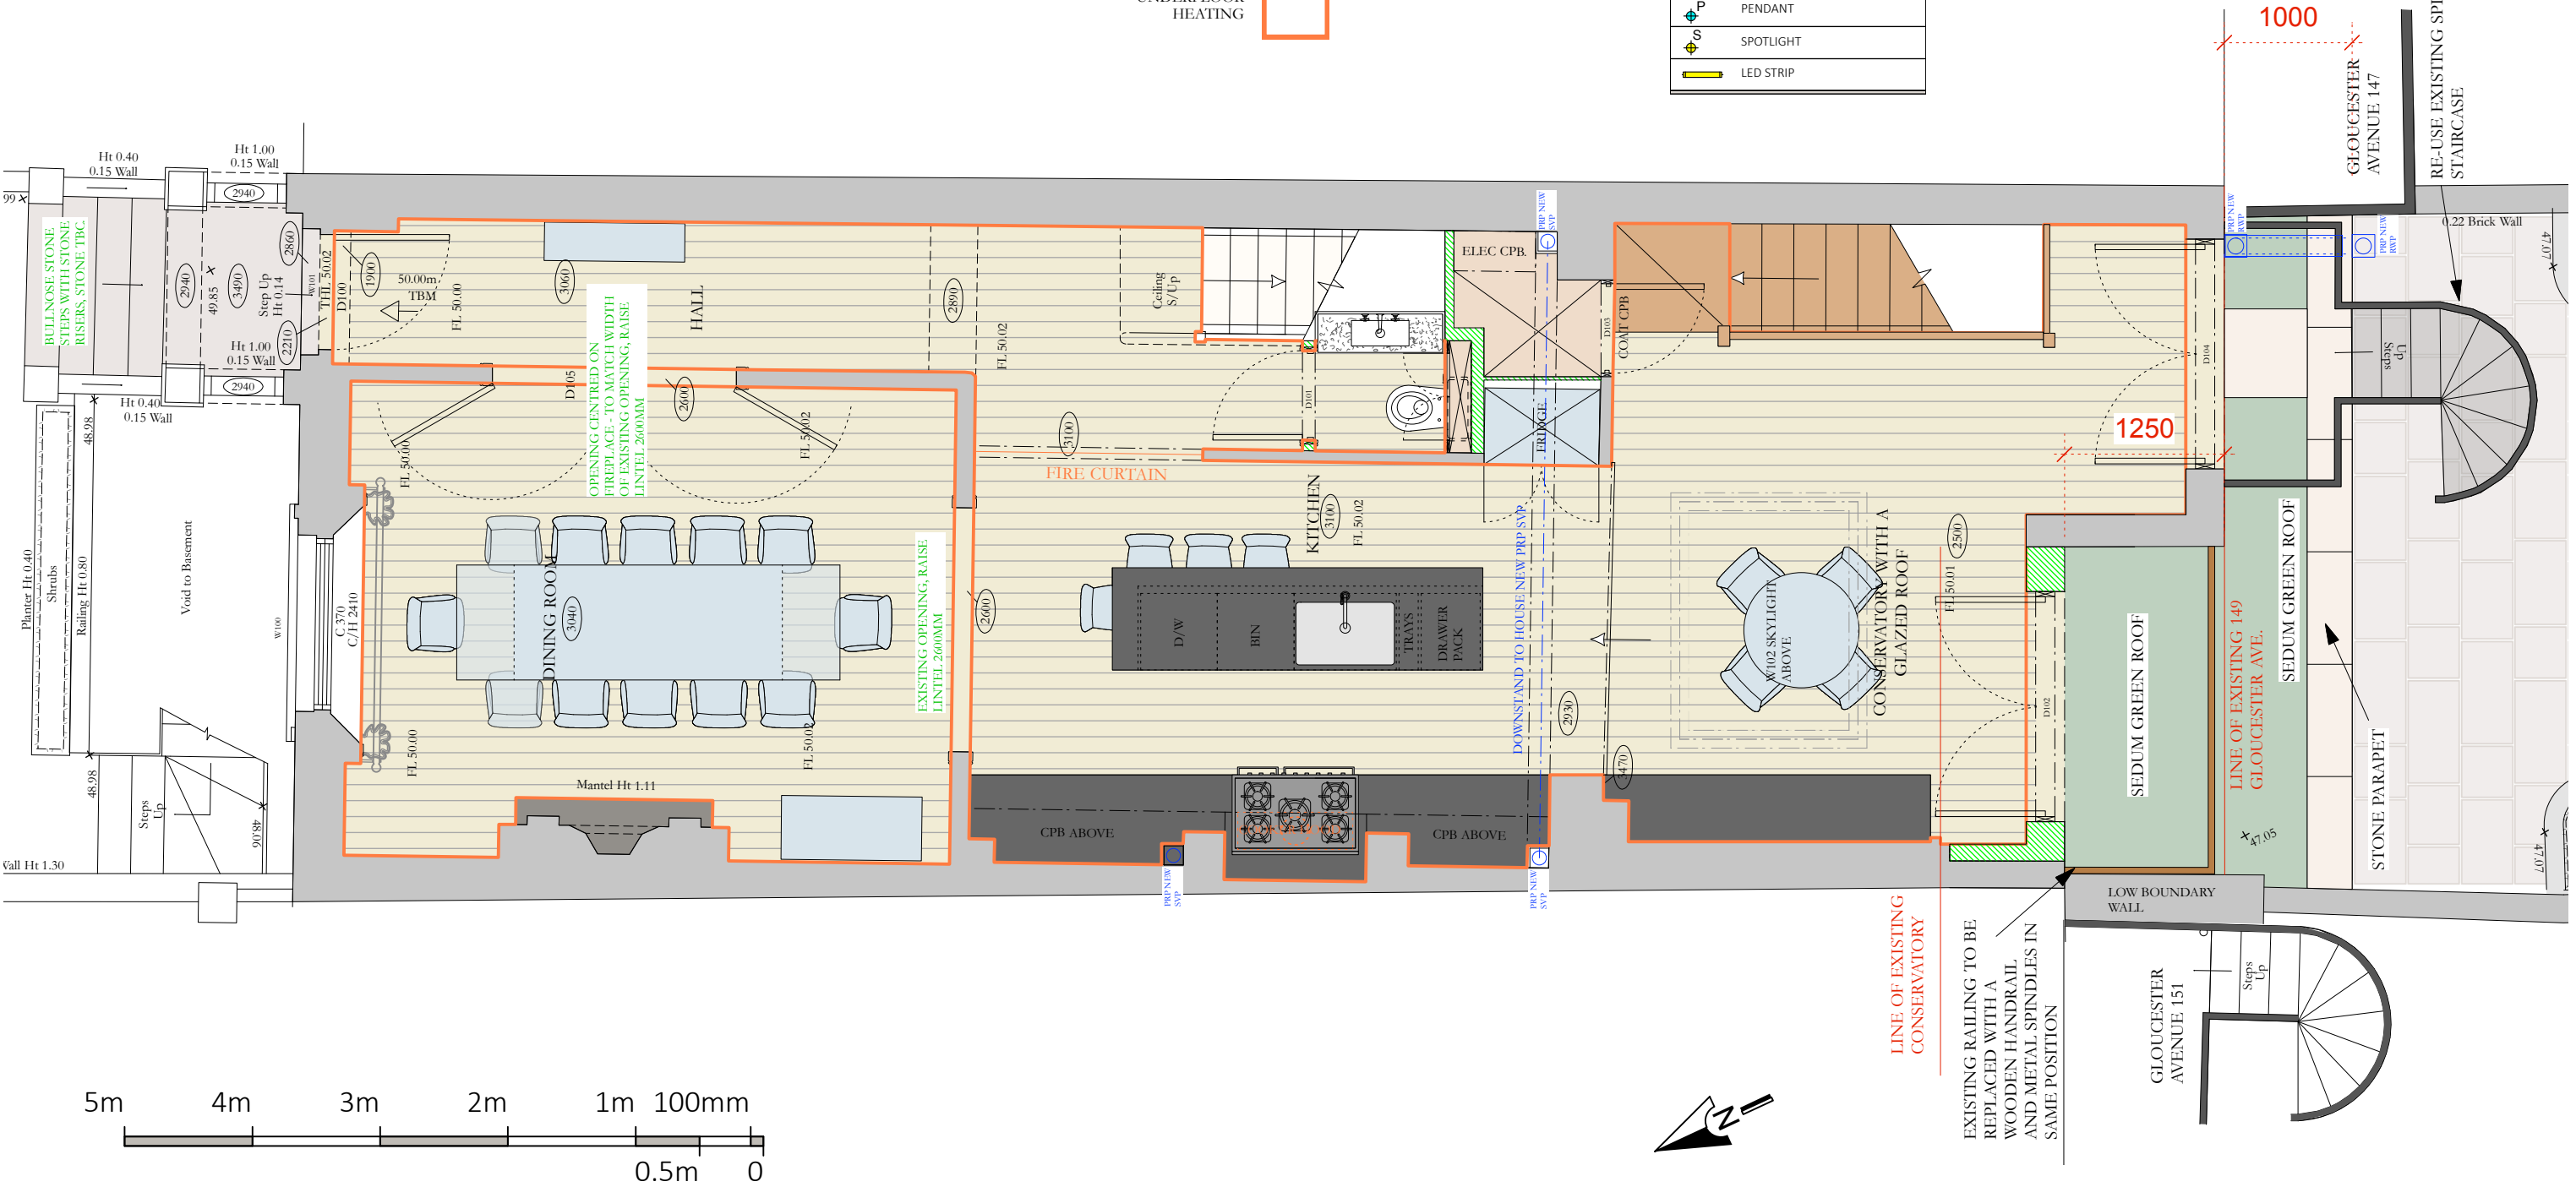

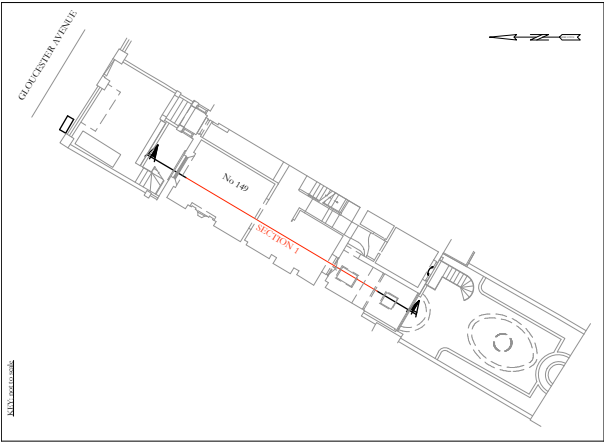

JOB TITLE 149 Gloucester Avenue	
DRAWING NO. GA/ 007B Rev C	
DATE	25/02/2016
SCALE	1:100 @ A3
DRAWING TITLE Proposed site layout	


Indicative Drawings only.
Do not Scale
All dimensions to be
checked and approved.

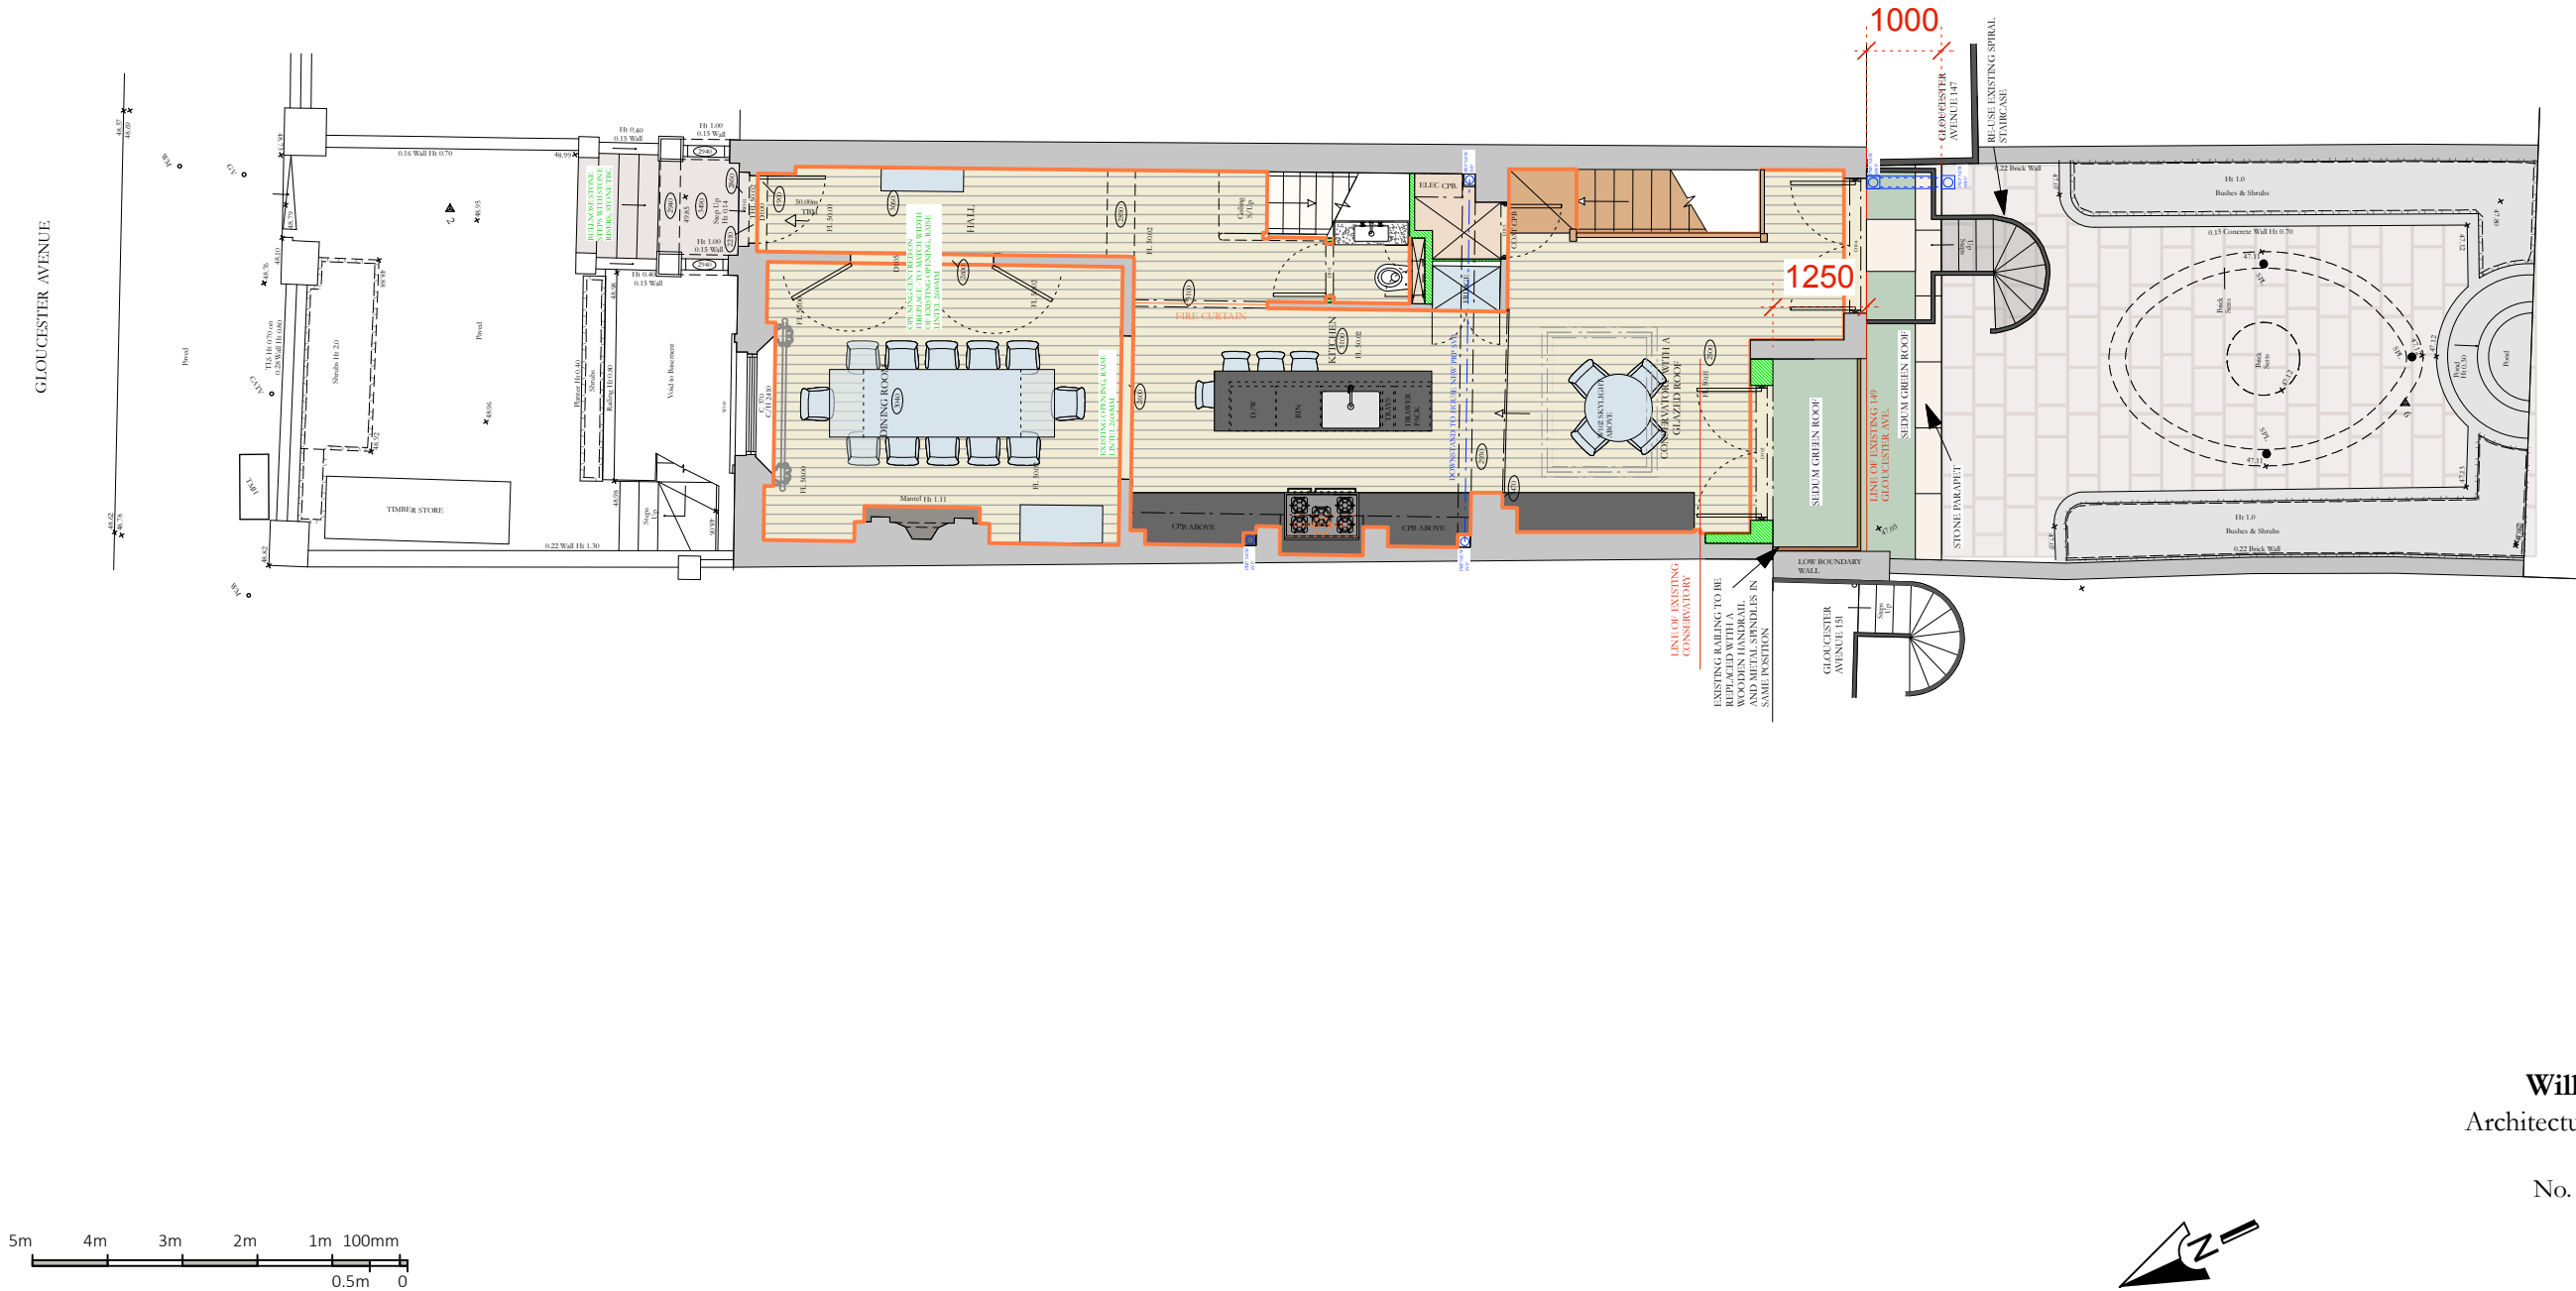

William Nickerson
Architectural and Interior Design

No. 9 Goldhawk Mews
London
W12 8PA

Tel: 0208 749 7900
Mobile: 07973 655 583
willie@willienickerson.com

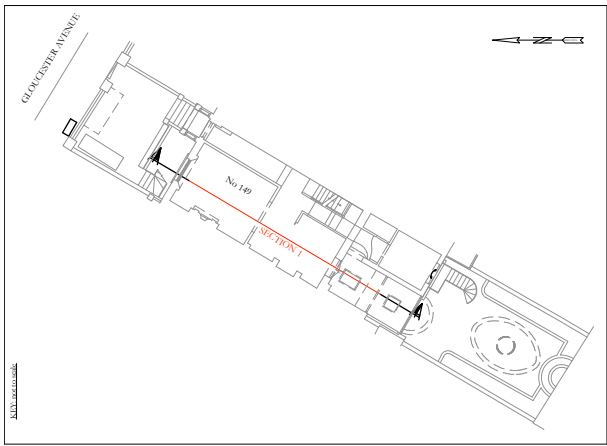

General notes:
- All switches and dimmers 40mm from architraves or as noted
- All sockets or as noted 40mm above skirtings
- 1050mm to the centre of all switches and dimmers or as noted

EXISTING WALLS

NEW PROPOSED WALLS

WOOD

JOINERY

TILED

CARPET

UNDERFLOOR HEATING

MECHANICAL LEGEND		ELECTRICAL LEGEND	
	EXTRACTOR		SINGLE 13A SOCKET
	COLD W FEED		TWIN 13A SOCKET
	HOT W FEED		SINGLE 5A SOCKET
	GAS		RAZOR SOCKET
	WATER TAP		FUSE SPUR
	AUTO WATERING		COOKER SWITCH
	U/F HEATING SENSOR		SMOKE DETECTOR
	THERMOSTAT		HEAT DETECTOR
	SOIL PIPE		CAT6/DATA SOCKET
	RAIN WATER PIPE		BT POINT
	INSPECTION CHAMBER		COAXIAL AERIAL SOCKET
ALARM LEGEND			SPEAKER POINT
	SENSOR		SWITCH
	DOOR CONTACT		DIMMER
	ALARM		WALL LIGHT
	DOORBELL		RECESSED LIGHT
			PENDANT
			SPOTLIGHT
			LED STRIP


William Nickerson
Architectural and Interior Design



No. 9 Goldhawk Mews
London
W12 8PA

Tel: 0208 749 7900
Mobile: 07973 655 583
willie@willienickerson.com

JOB TITLE	149 Gloucester Avenue
DRAWING NO.	GA/ 007C Rev C
DATE	25/02/2016
SCALE	1:50 @ A3
DRAWING TITLE	Proposed electrical upper ground floor plan

Indicative Drawings only.
Do not Scale
All dimensions to be checked and approved.

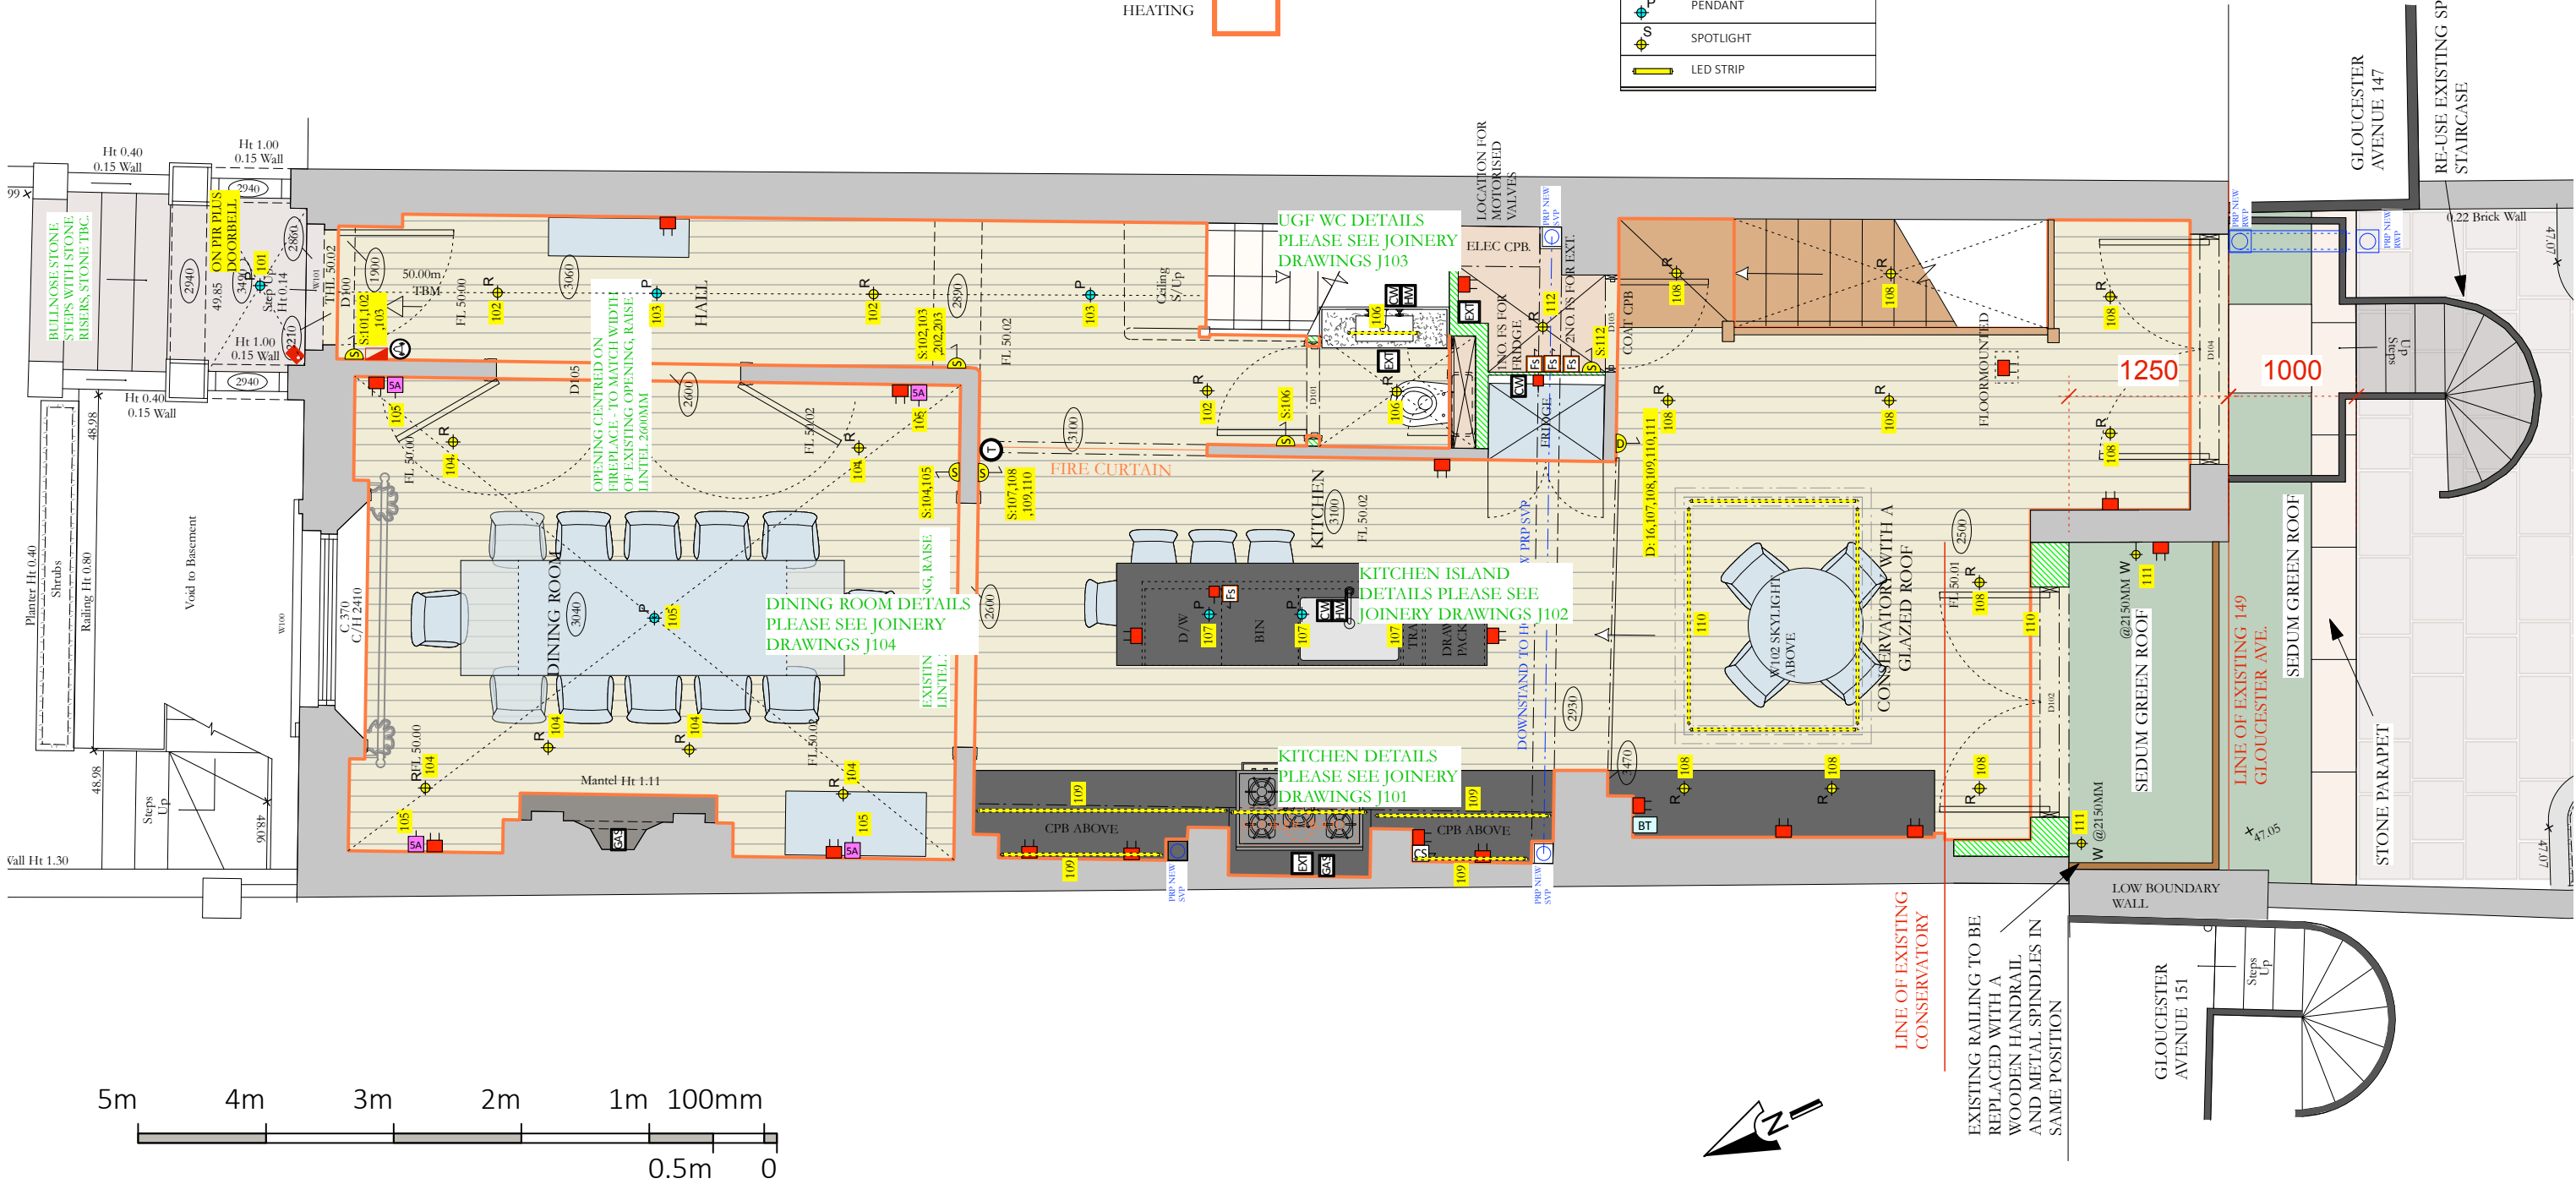

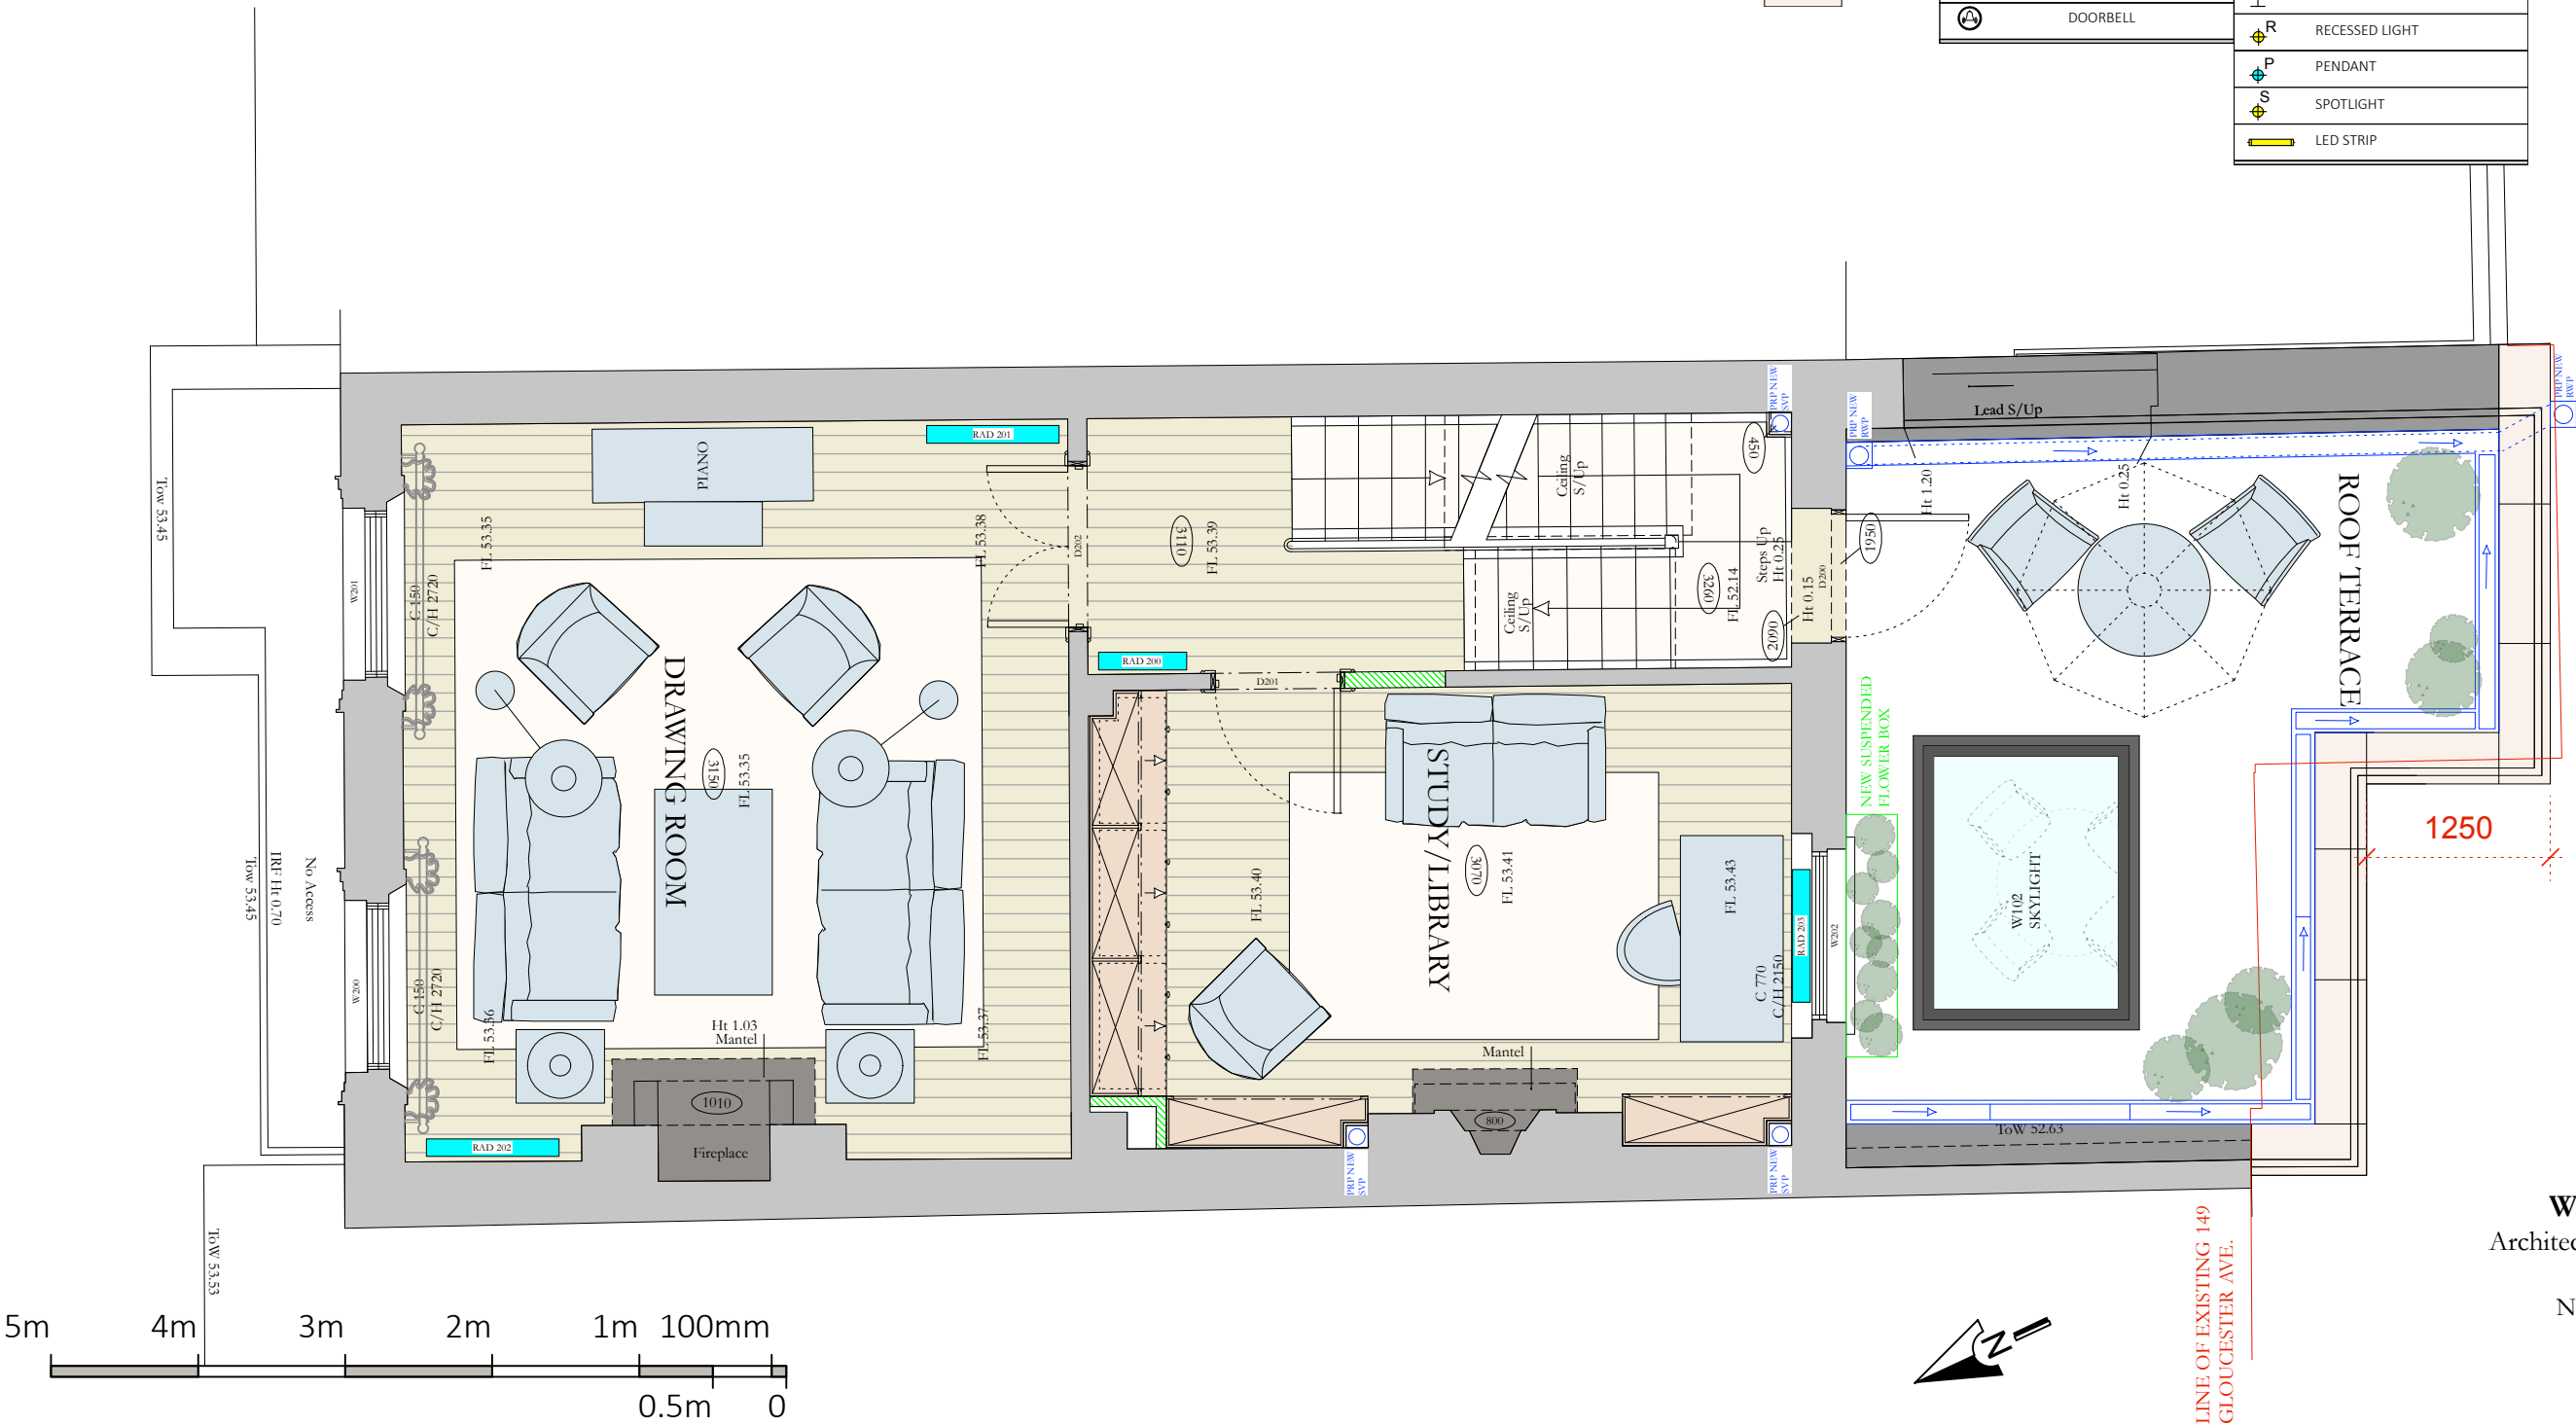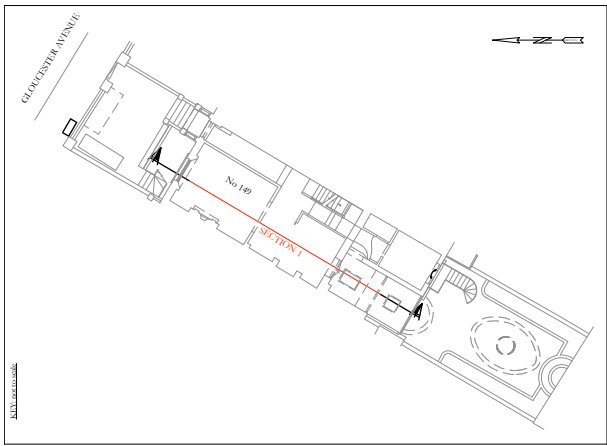

EXISTING WALLS	
NEW PROPOSED WALLS	
WOOD	
JOINERY	
TILED	
CARPET	

MECHANICAL LEGEND		ELECTRICAL LEGEND	
	EXTRACTOR		SINGLE 13A SOCKET
	COLD W FEED		TWIN 13A SOCKET
	HOT W FEED		SINGLE 5A SOCKET
	GAS		RAZOR SOCKET
	WATER TAP		FUSE SPUR
	AUTO WATERING		COOKER SWITCH
	U/F HEATING SENSOR		SMOKE DETECTOR
	THERMOSTAT		HEAT DETECTOR
	SOIL PIPE		CAT6/DATA SOCKET
	RAIN WATER PIPE		BT POINT
	INSPECTION CHAMBER		COAXIAL AERIAL SOCKET
ALARM LEGEND			SPEAKER POINT
	SENSOR		SWITCH
	DOOR CONTACT		DIMMER
	ALARM		WALL LIGHT
	DOORBELL		RECESSED LIGHT
			PENDANT
			SPOTLIGHT
			LED STRIP


JOB TITLE 149 Gloucester Avenue	
DRAWING NO. GA/ 008 Rev G	
DATE	25/02/2016
SCALE	1:50 @ A3
DRAWING TITLE Proposed first floor plan	

Indicative Drawings only.
Do not Scale
All dimensions to be
checked and approved.

William Nickerson
Architectural and Interior Design

No. 9 Goldhawk Mews
London
W12 8PA

Tel: 0208 749 7900
Mobile: 07973 655 583
willie@willienickerson.com

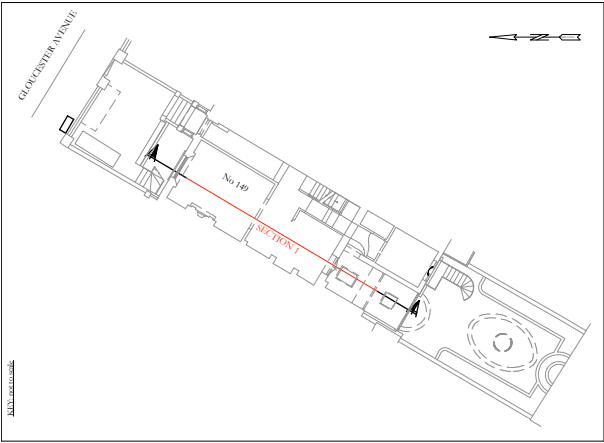

General notes:
- All switches and dimmers 40mm from architraves or as noted
- All sockets or as noted 40mm above skirtings
- 1050mm to the centre of all switches and dimmers or as noted

EXISTING WALLS

NEW PROPOSED WALLS

WOOD

JOINERY


TILED

CARPET

MECHANICAL LEGEND		ELECTRICAL LEGEND	
	EXTRACTOR		SINGLE 13A SOCKET
	COLD W FEED		TWIN 13A SOCKET
	HOT W FEED		SINGLE 5A SOCKET
	GAS		RAZOR SOCKET
	WATER TAP		FUSE SPUR
	AUTO WATERING		COOKER SWITCH
	U/F HEATING SENSOR		SMOKE DETECTOR
	THERMOSTAT		HEAT DETECTOR
	SOIL PIPE		CAT6/DATA SOCKET
	RAIN WATER PIPE		BT POINT
	INSPECTION CHAMBER		COAXIAL AERIAL SOCKET
ALARM LEGEND			SPEAKER POINT
	SENSOR		SWITCH
	DOOR CONTACT		DIMMER
	ALARM		WALL LIGHT
	DOORBELL		RECESSED LIGHT
			PENDANT
			SPOTLIGHT
			LED STRIP

JOB TITLE 149 Gloucester Avenue	
DRAWING NO. GA/ 008B Rev D	
DATE	25/02/2016
SCALE	1:50 @ A3
DRAWING TITLE Proposed electrical first floor plan	


Indicative Drawings only.
Do not Scale
All dimensions to be checked and approved.

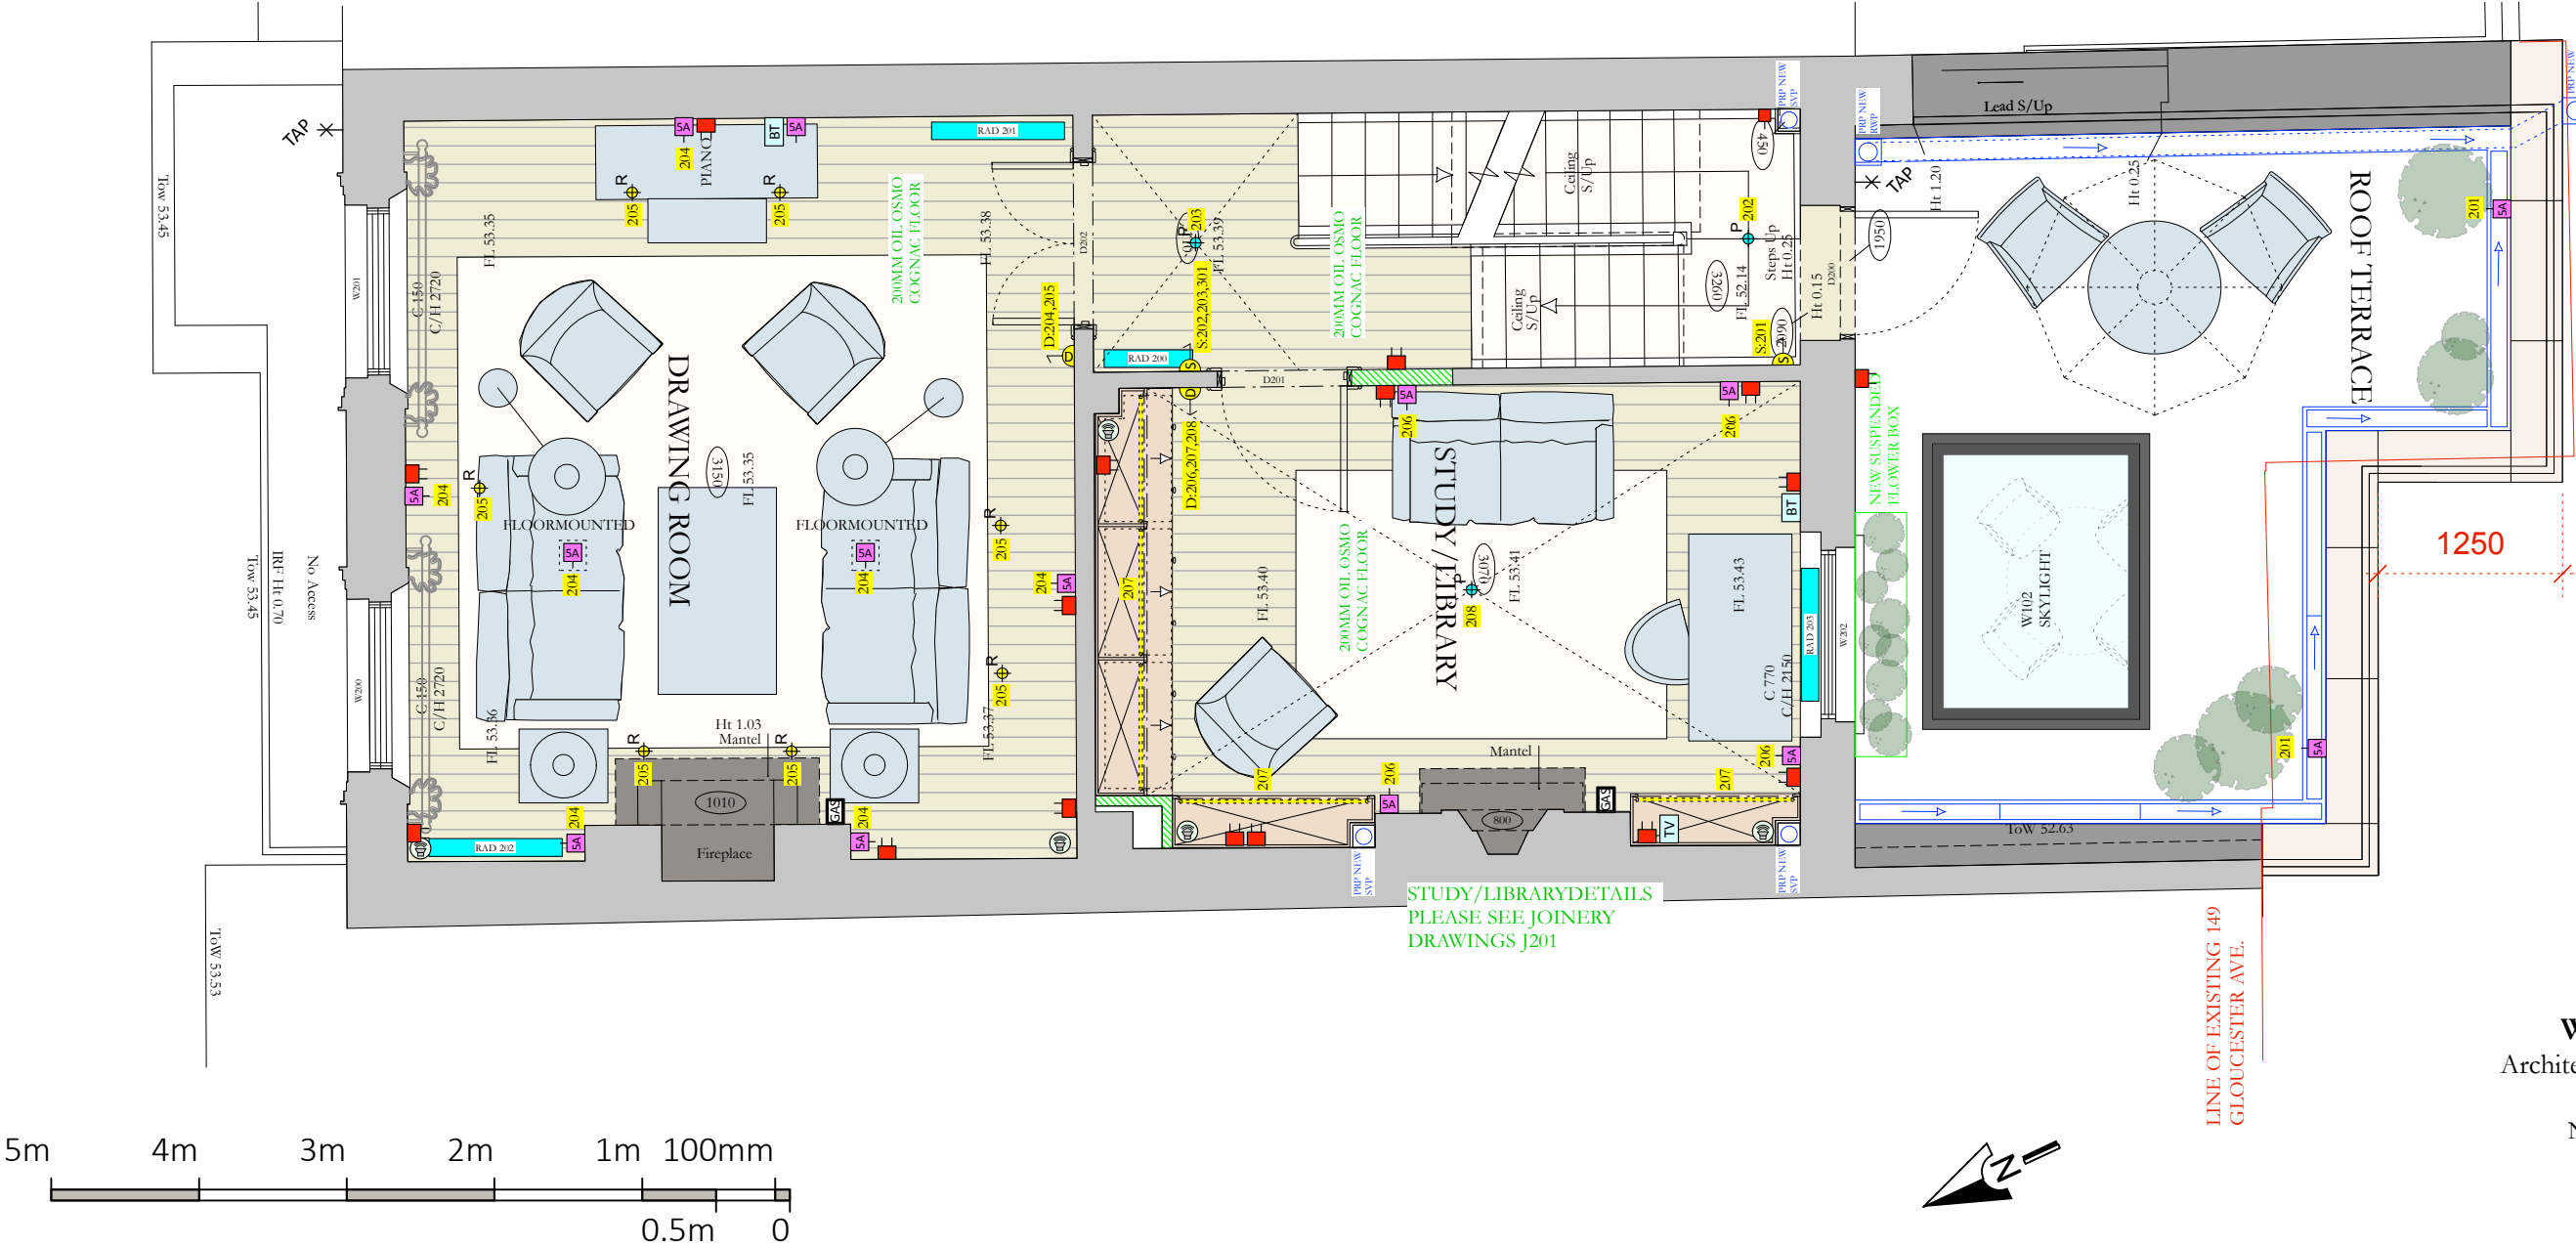

William Nickerson
Architectural and Interior Design

No. 9 Goldhawk Mews
London
W12 8PA

Tel: 0208 749 7900
Mobile: 07973 655 583
willie@willienickerson.com

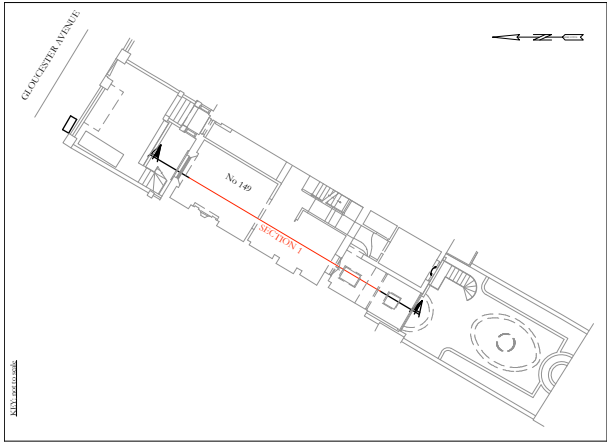

PROPOSED ALTERATIONS



EXISTING WALLS



JOB TITLE 149 Gloucester Avenue


DRAWING NO.
GA/ 011

DATE 28/09/2015

SCALE 1:50 @ A3

DRAWING TITLE
Proposed alterations lower
ground floor plan



Indicative Drawings only.
Do not Scale
All dimensions to be
checked and approved.

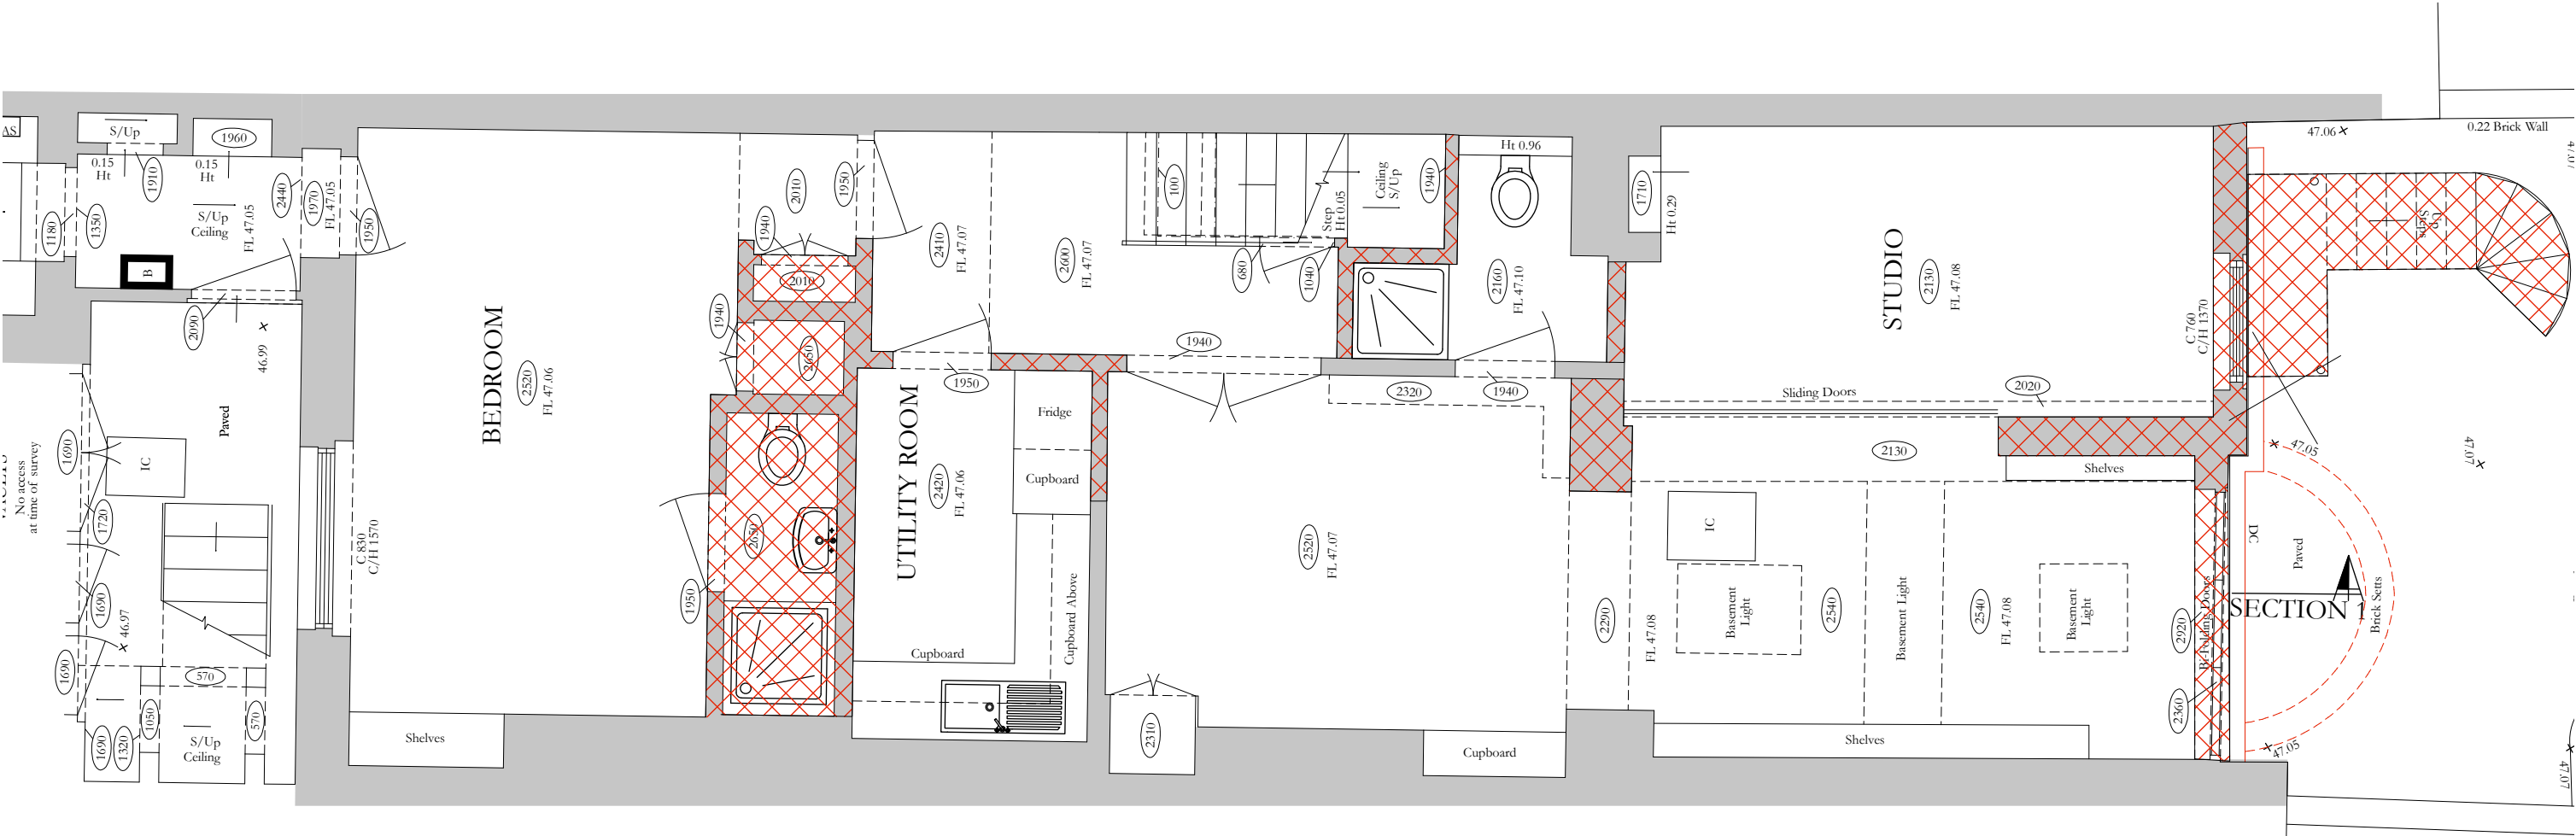

William Nickerson
Architectural and Interior Design


No. 9 Goldhawk Mews
London
W12 8PA

Tel: 0208 749 7900
Mobile: 07973 655 583
willie@willienickerson.com

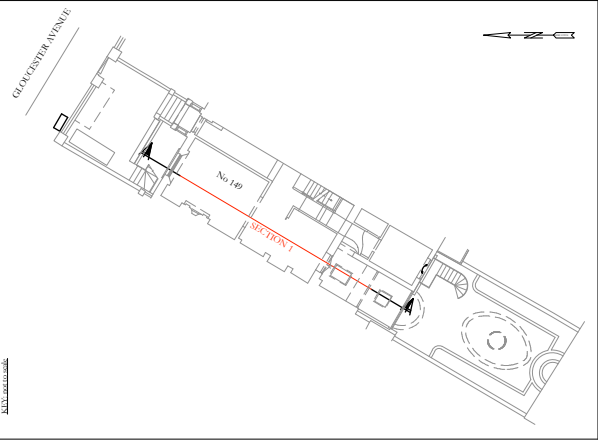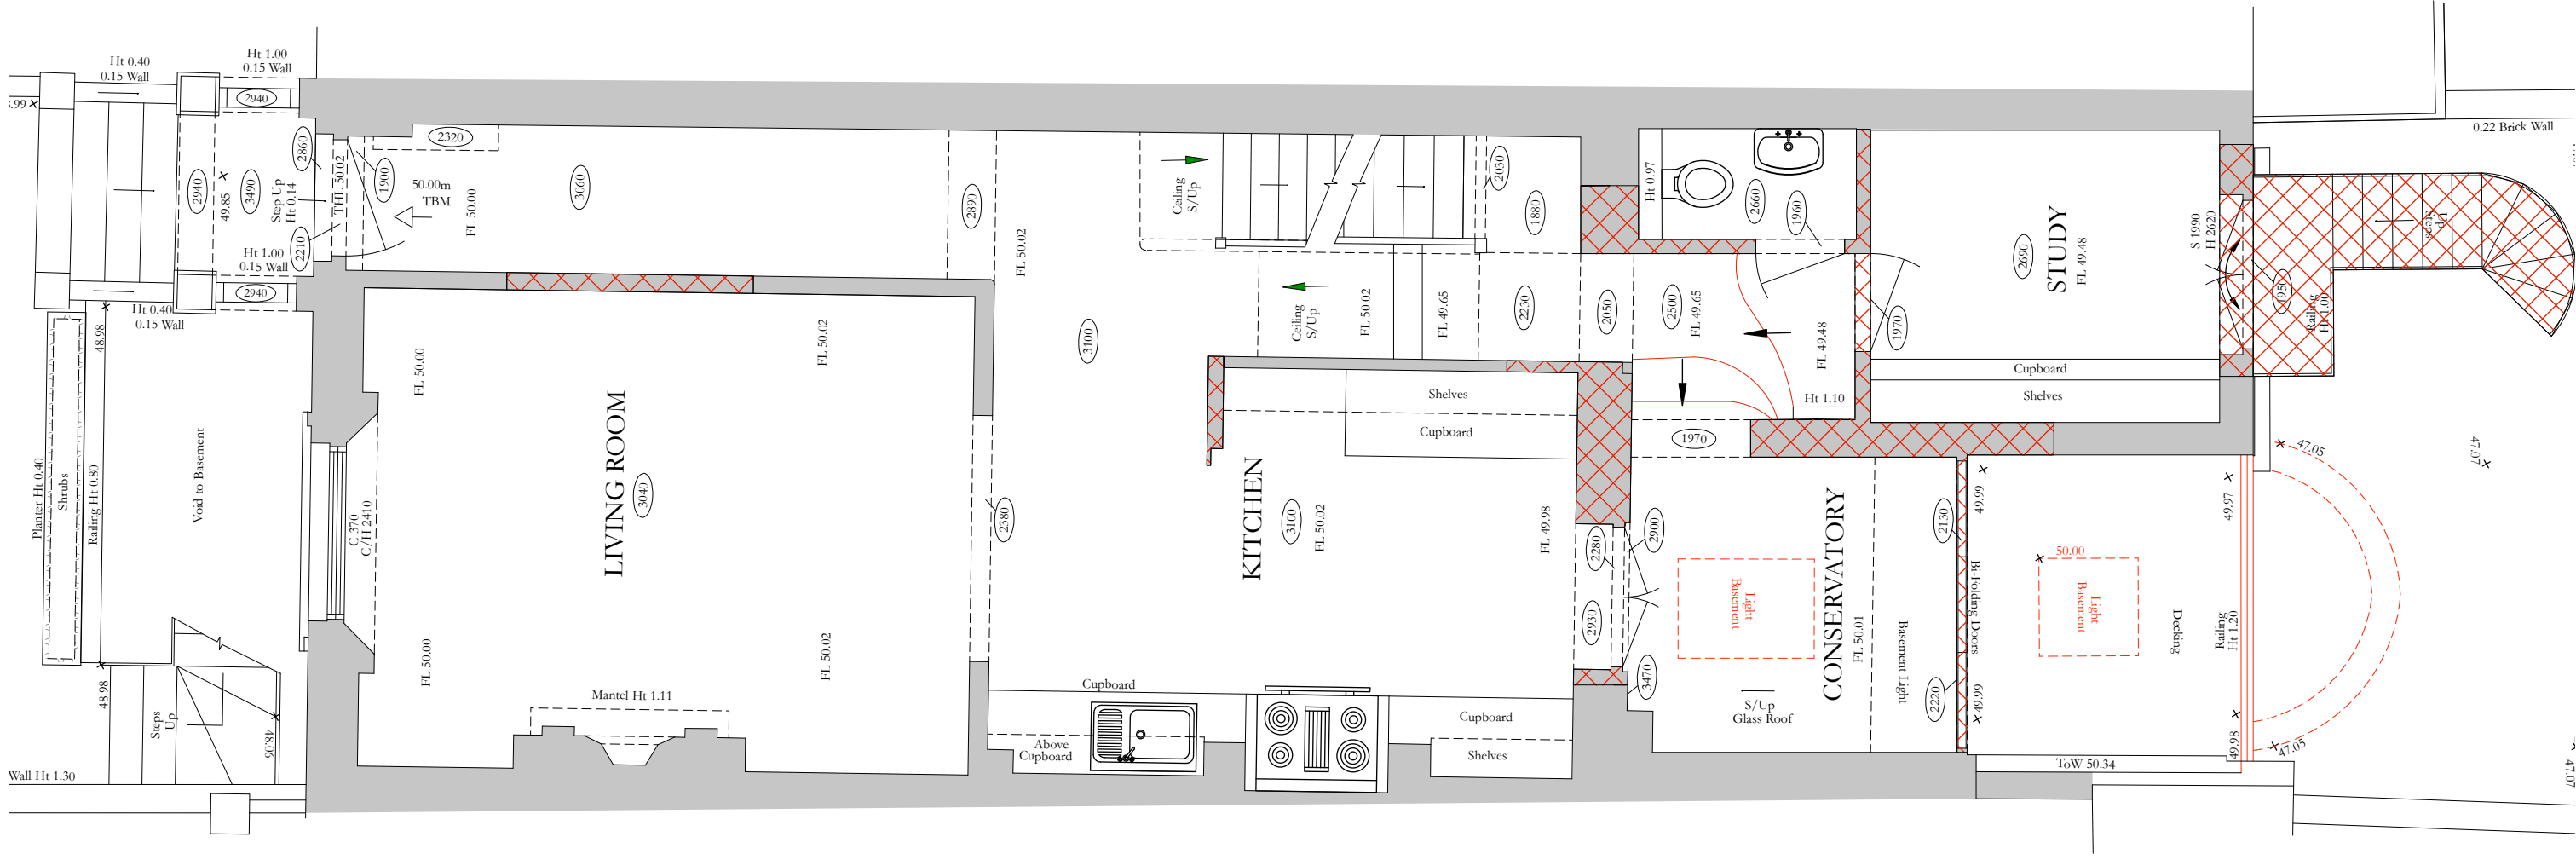


PROPOSED ALTERATIONS

 EXISTING WALLS



JOB TITLE 149 Gloucester Avenue	
DRAWING NO. GA/ 012 Rev B	
DATE	25/02/2016
SCALE	1:50 @ A3
DRAWING TITLE Proposed alterations upper ground floor plan	


 
Indicative Drawings only.
Do not Scale
All dimensions to be
checked and approved.



William Nickerson
Architectural and Interior Design

No. 9 Goldhawk Mews
London
W12 8PA

Tel: 0208 749 7900
Mobile: 07973 655 583
willie@willienickerson.com

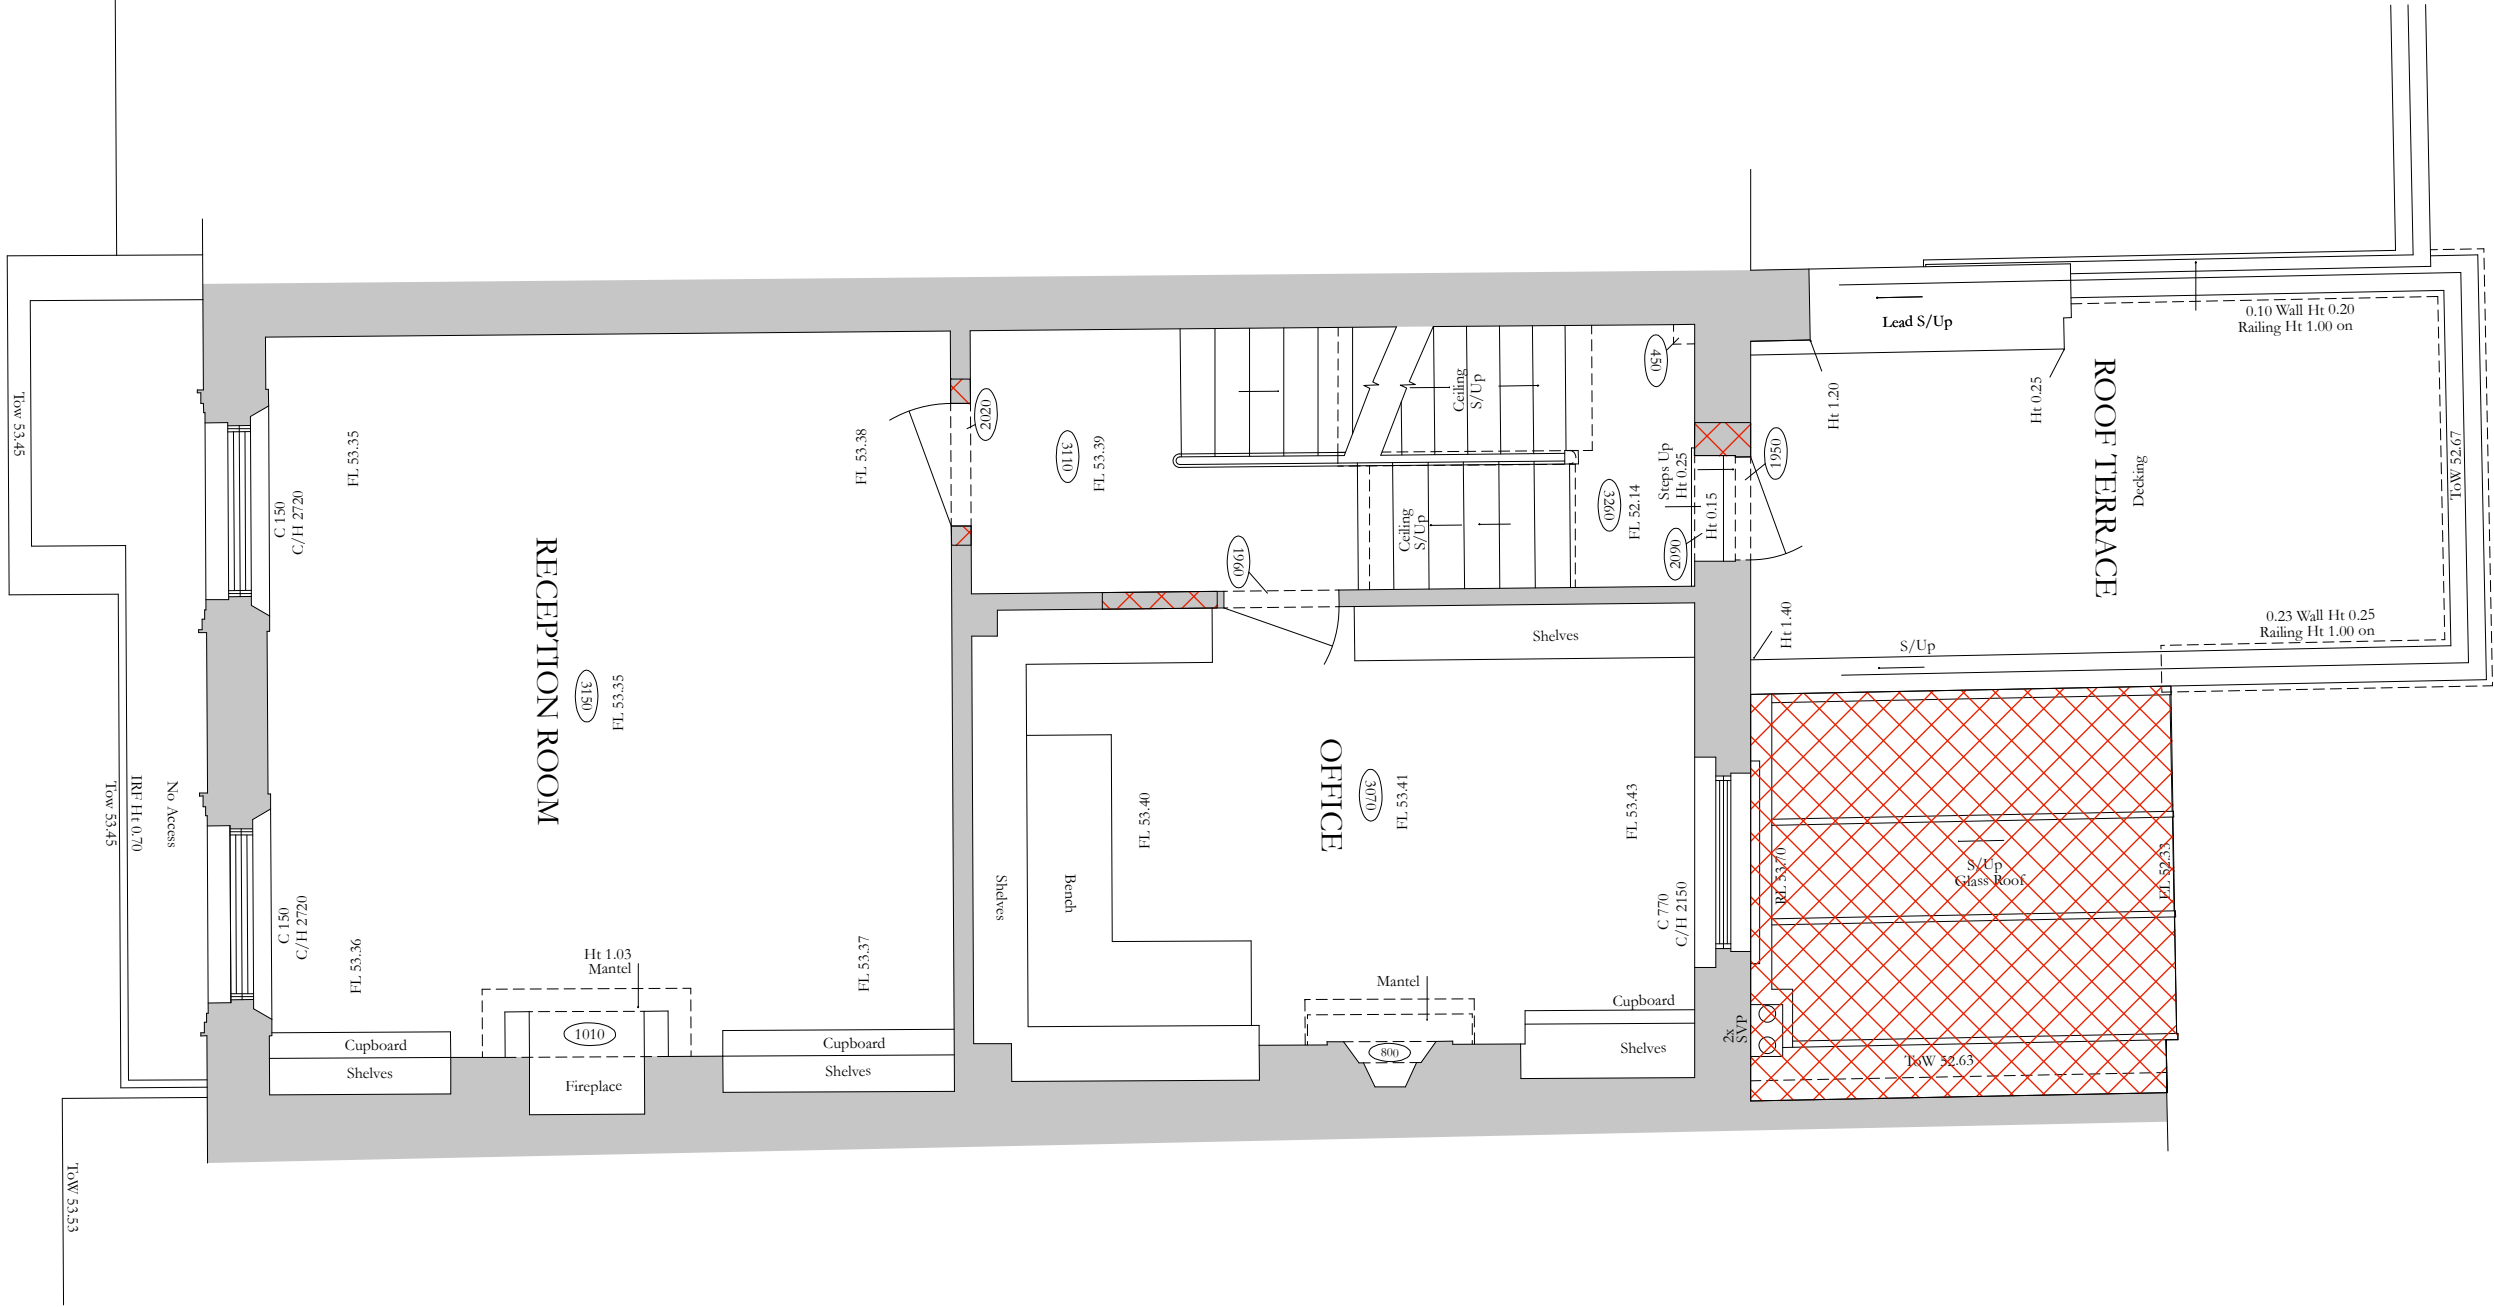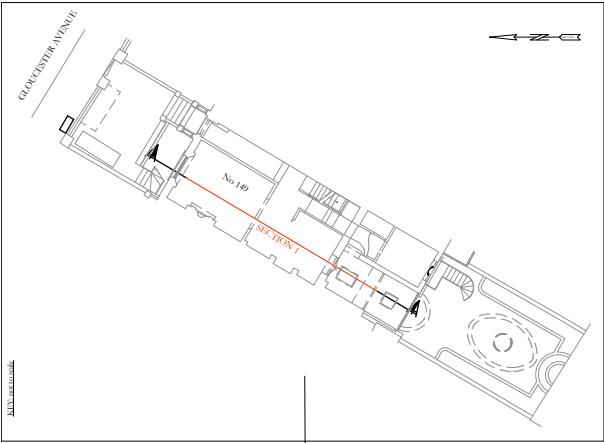


PROPOSED ALTERATIONS

EXISTING WALLS

JOB TITLE 149 Gloucester Avenue	
DRAWING NO. GA/ 013 Rev A	
DATE	26/01/2016
SCALE	1:50 @ A3
DRAWING TITLE Proposed alterations first floor plan	


Indicative Drawings only.
Do not Scale
All dimensions to be checked and approved.

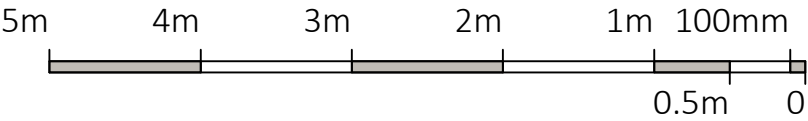

William Nickerson
Architectural and Interior Design


No. 9 Goldhawk Mews
London
W12 8PA

Tel: 0208 749 7900
Mobile: 07973 655 583
willie@willienickerson.com

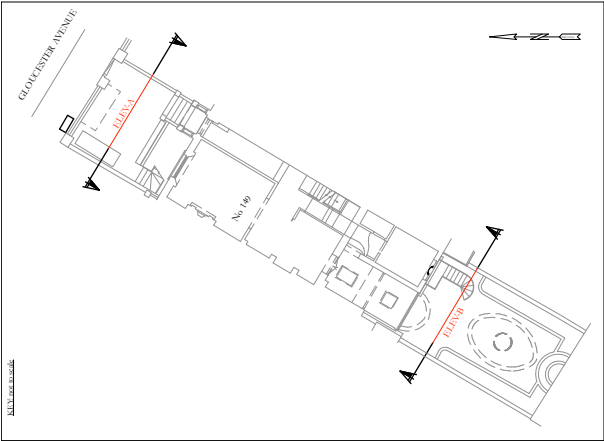

JOB TITLE 149 Gloucester Avenue	
DRAWING NO. GA/ 019B Rev B	
DATE	25/02/2016
SCALE	1:100 @ A3
DRAWING TITLE Proposed rear elevation with neighbouring properties	

 Indicative Drawings only.
Do not Scale
All dimensions to be
checked and approved.



William Nickerson
Architectural and Interior Design

No. 9 Goldhawk Mews
London
W12 8PA

Tel: 0208 749 7900
Mobile: 07973 655 583
willie@willienickerson.com



JOB TITLE 149 Gloucester Avenue	
DRAWING NO.	GA/ 020 Rev A
DATE	25/02/2016
SCALE	1:50/1:100 @ A3
DRAWING TITLE	Proposed section

Indicative Drawings only.
Do not Scale
All dimensions to be
checked and approved.

William Nickerson
Architectural and Interior Design


No. 9 Goldhawk Mews
London
W12 8PA

Tel: 0208 749 7900
Mobile: 07973 655 583
willie@willienickerson.com

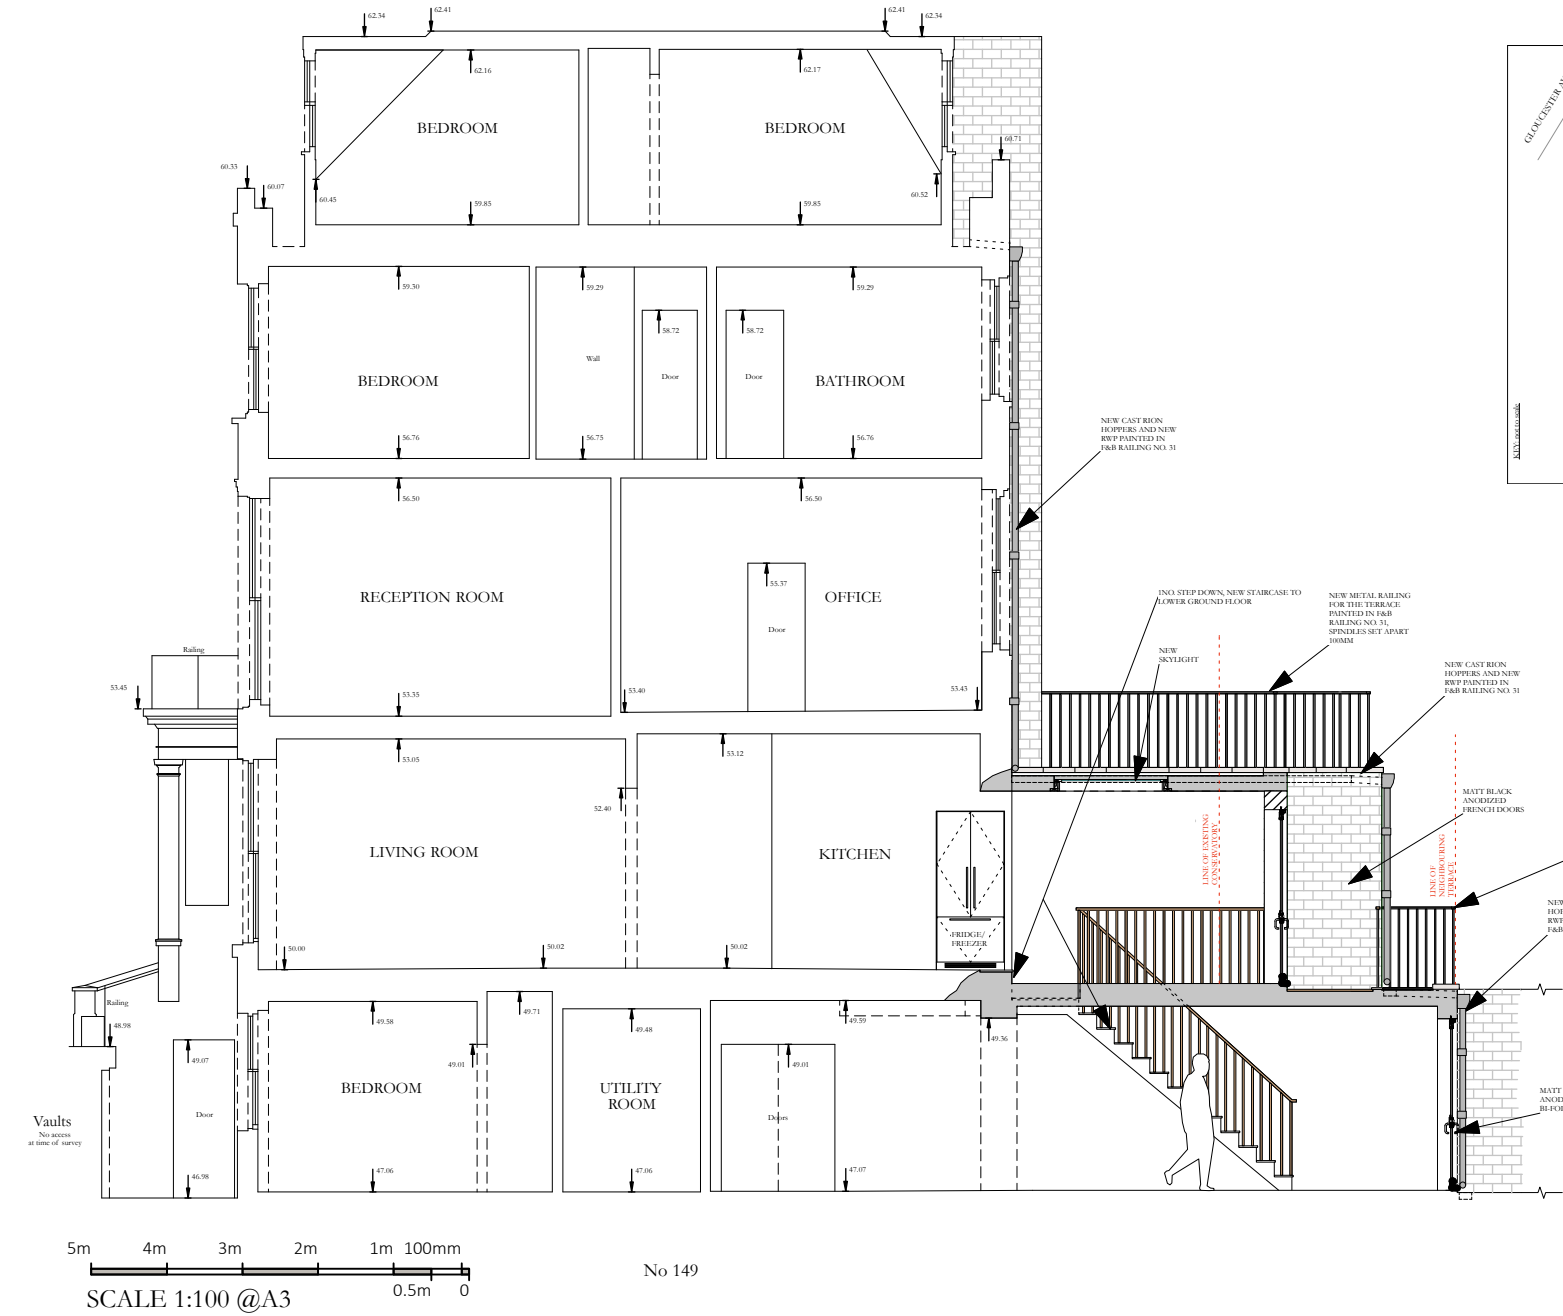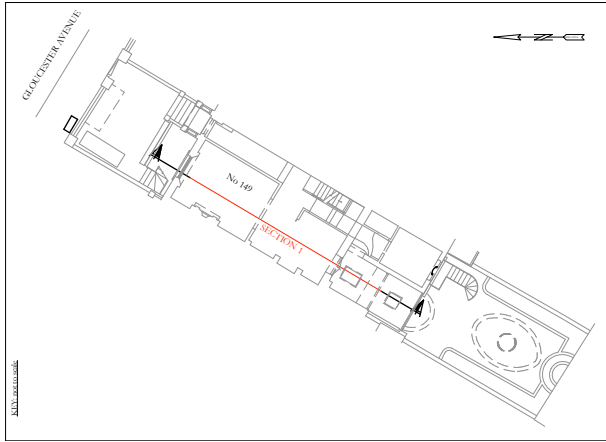


No 149

SECTION 1

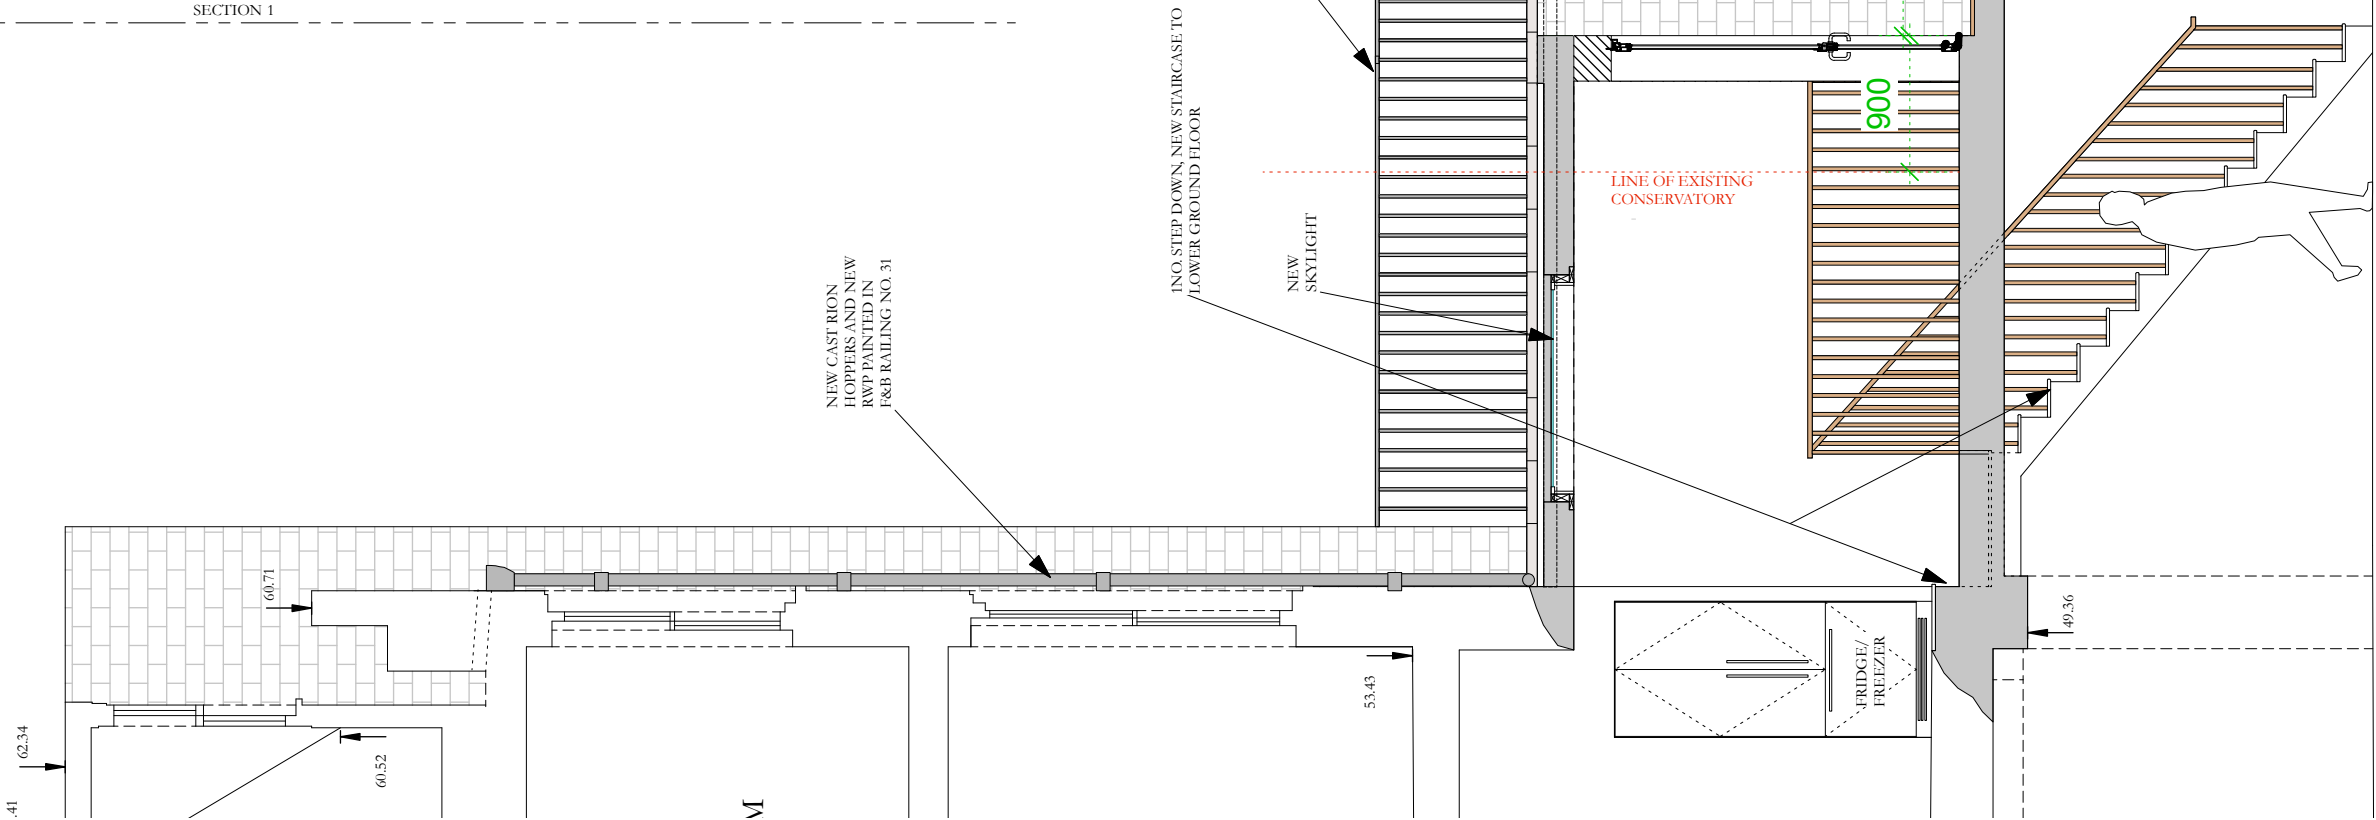

5m 4m 3m 2m 1m 100mm
SCALE 1:50 @A3


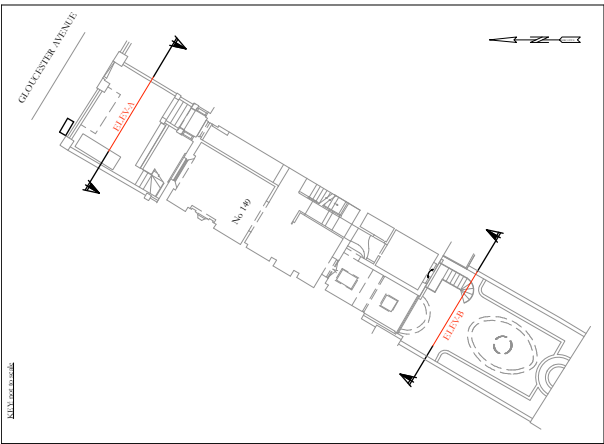


JOB TITLE 149 Gloucester Avenue	
DRAWING NO. GA/ 021	
DATE	28/09/2015
SCALE	1:50 @ A3
DRAWING TITLE Existing rear elevation indicating proposed alterations	

PROPOSED ALTERATIONS





Indicative Drawings only.
Do not Scale
All dimensions to be
checked and approved.

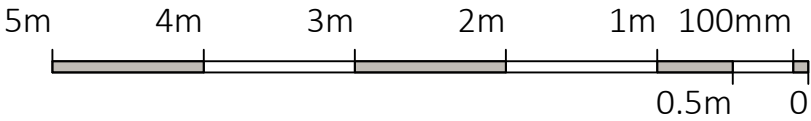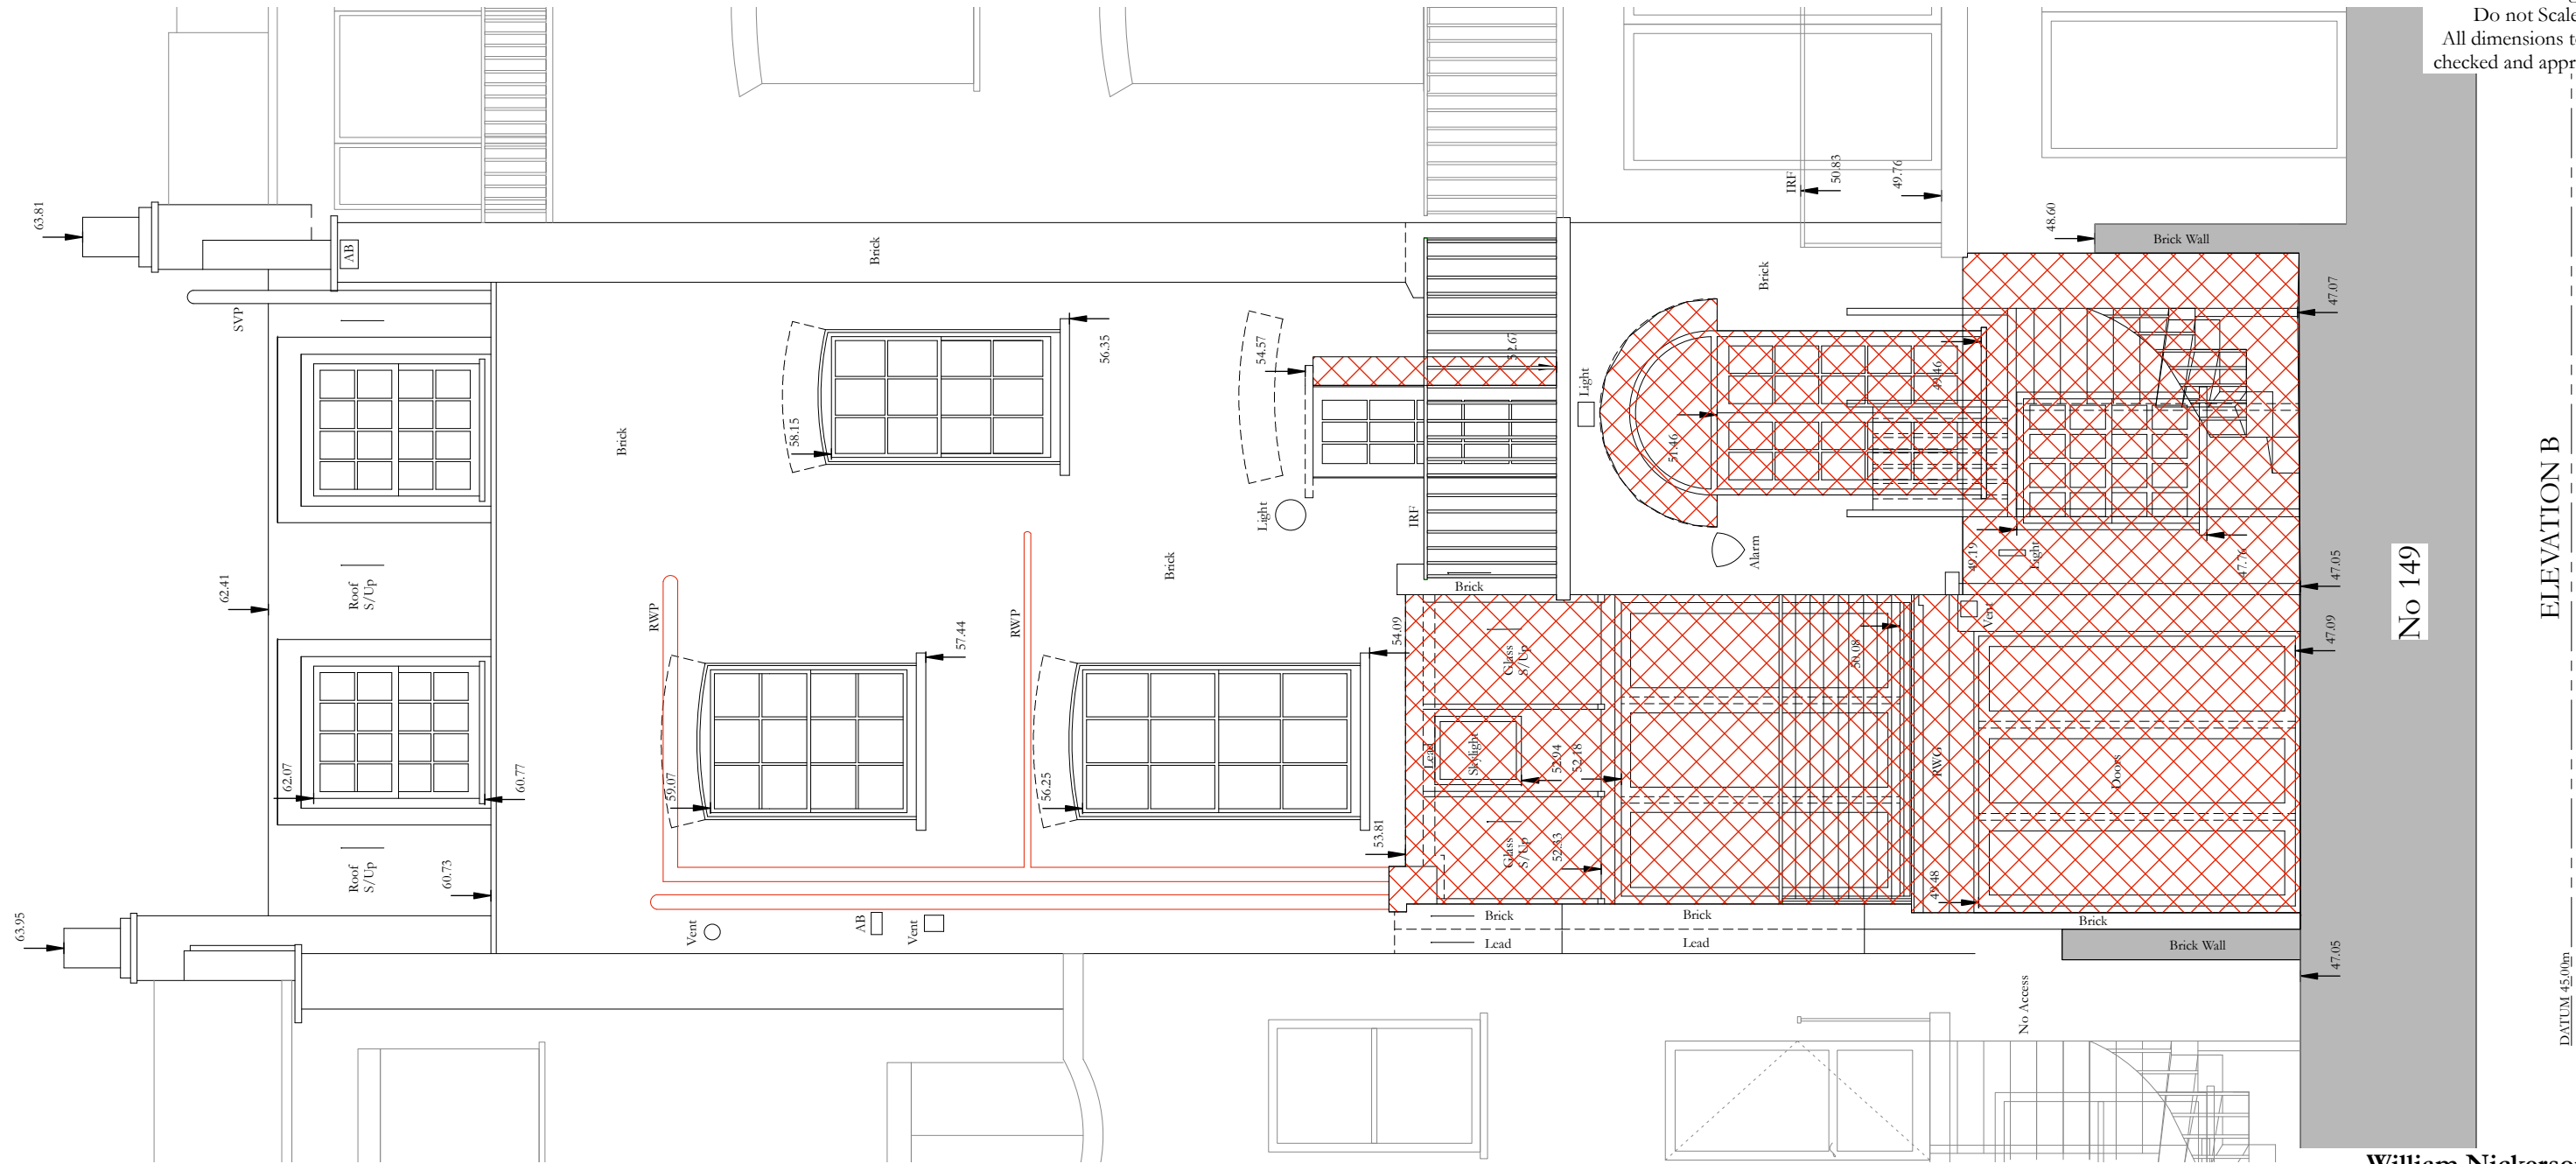

William Nickerson
Architectural and Interior Design

No. 9 Goldhawk Mews
London
W12 8PA

Tel: 0208 749 7900
Mobile: 07973 655 583
willie@willienickerson.com

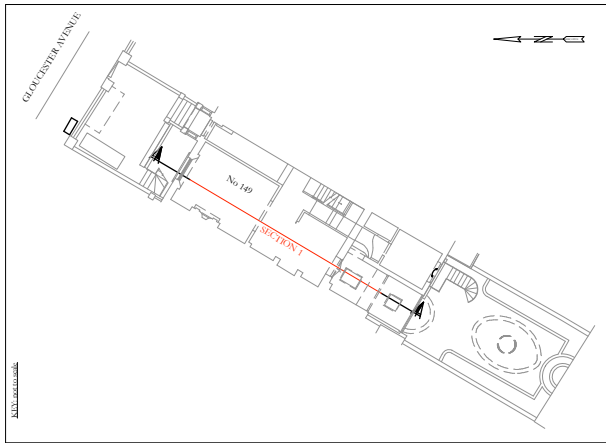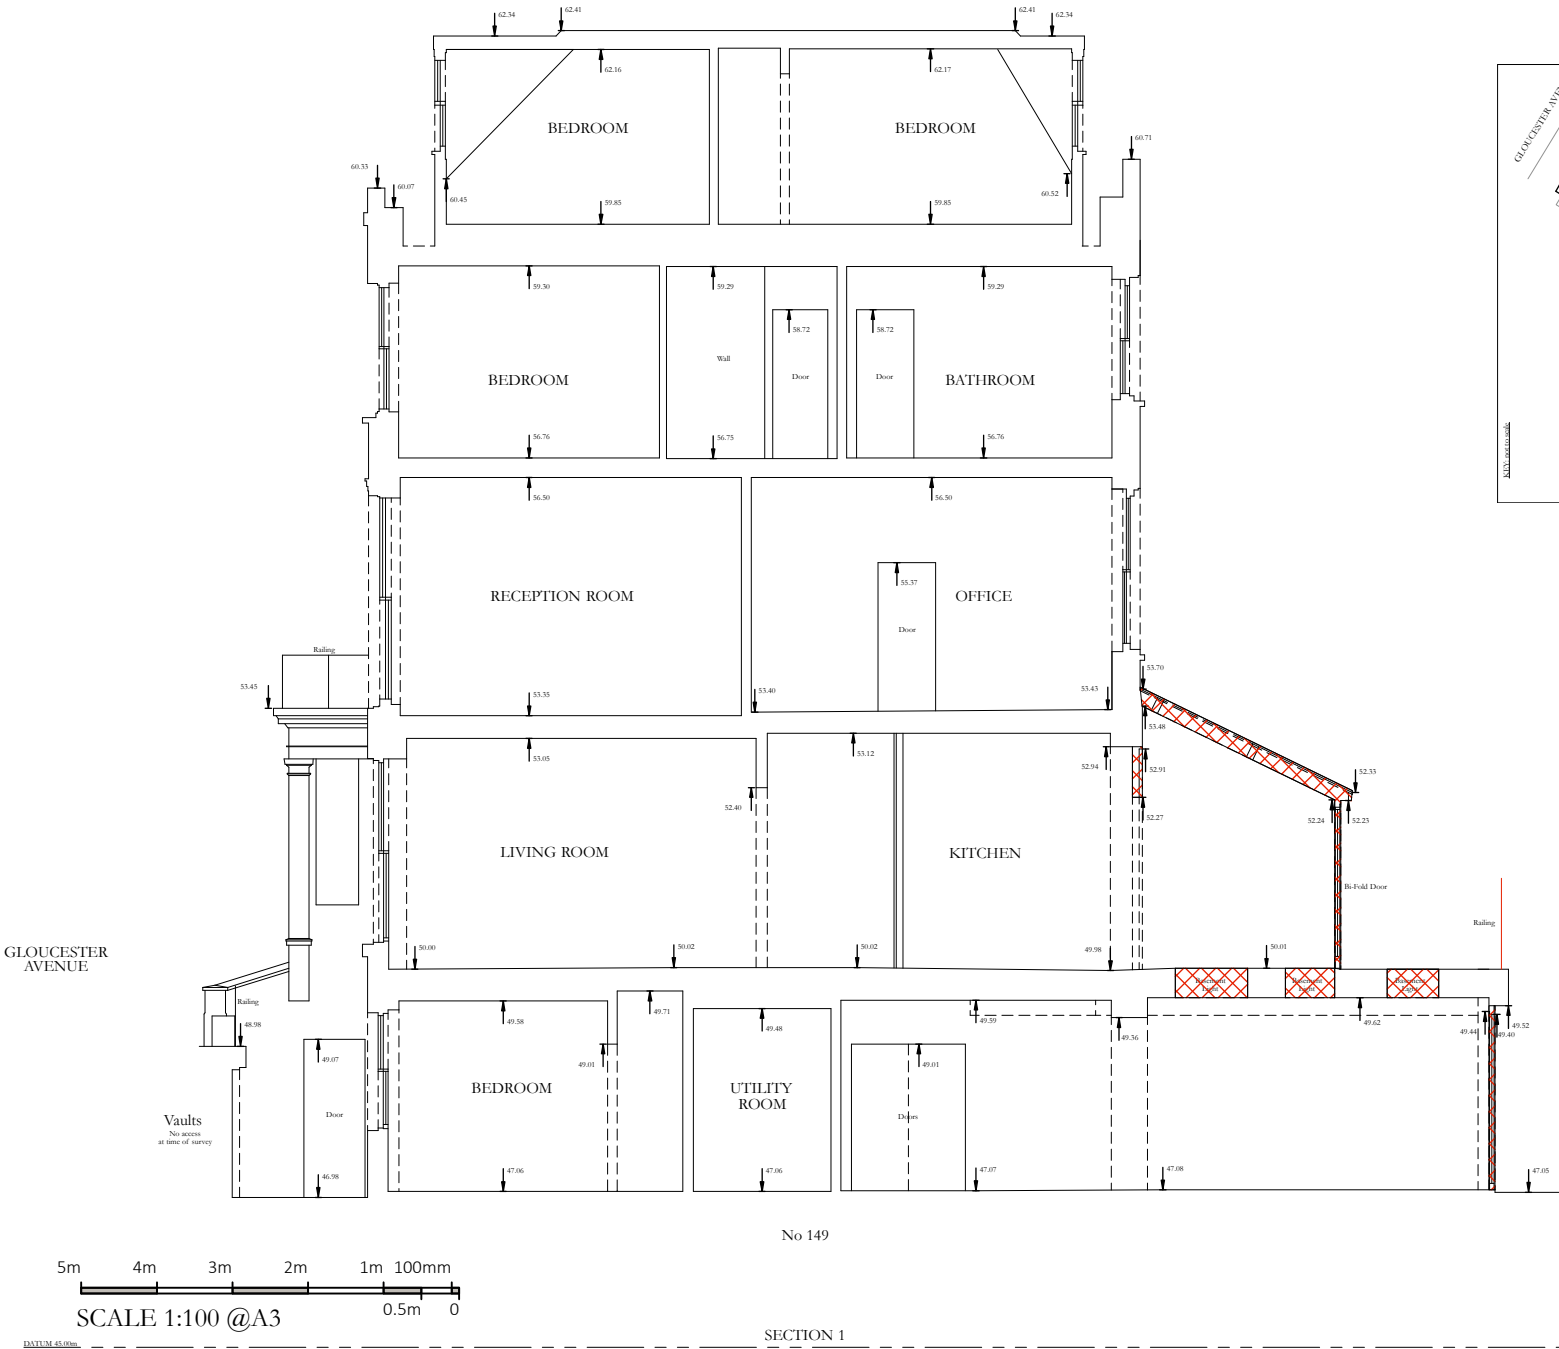

William Nickerson
Architectural and Interior Design



No. 9 Goldhawk Mews
London
W12 8PA

Tel: 0208 749 7900
Mobile: 07973 655 583
willie@willienickerson.com

PROPOSED ALTERATIONS



Indicative Drawings only.
Do not Scale
All dimensions to be
checked and approved.

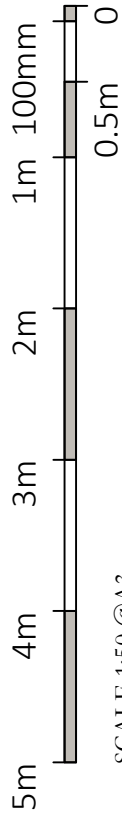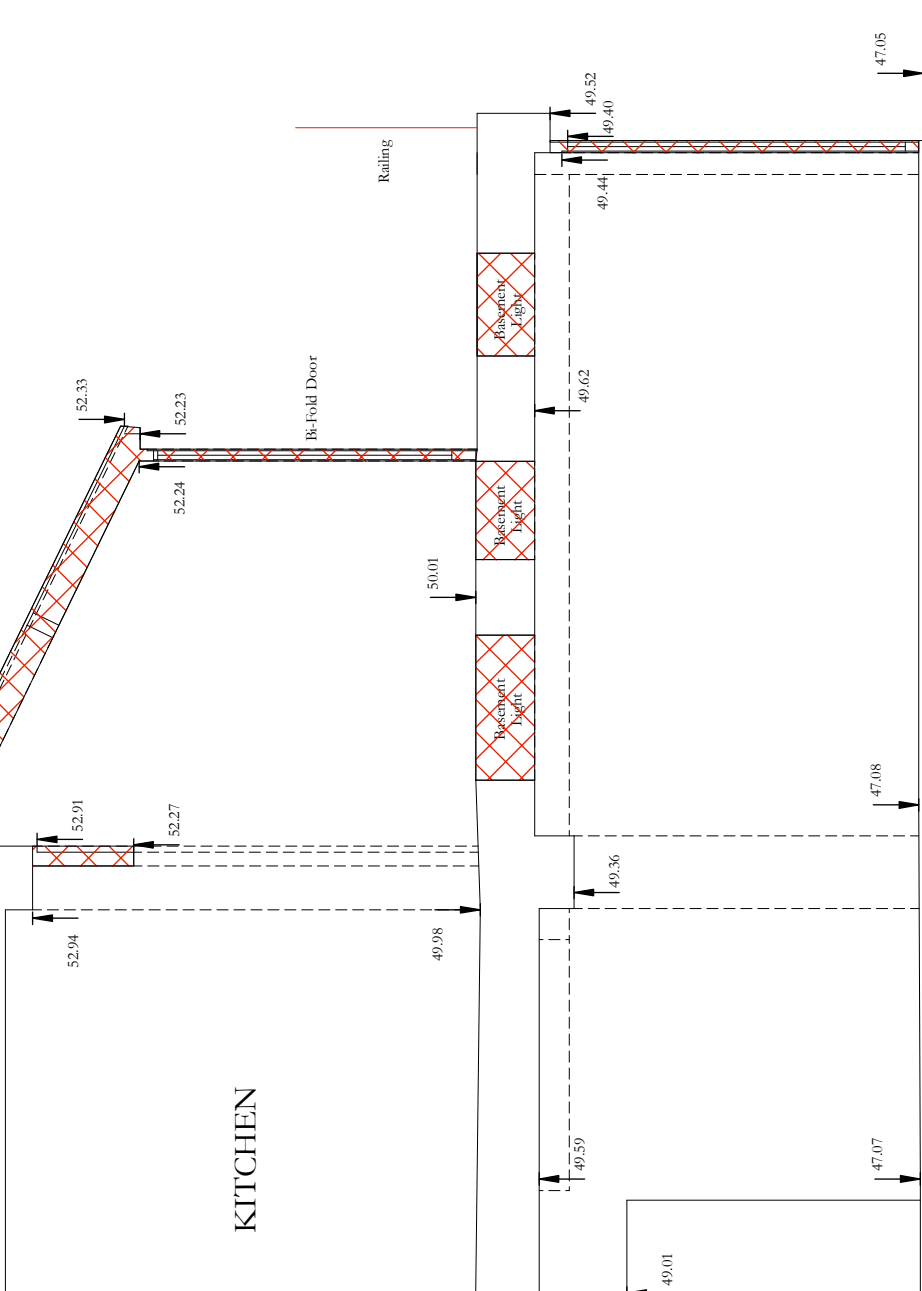

SCALE 1:50 @A3