




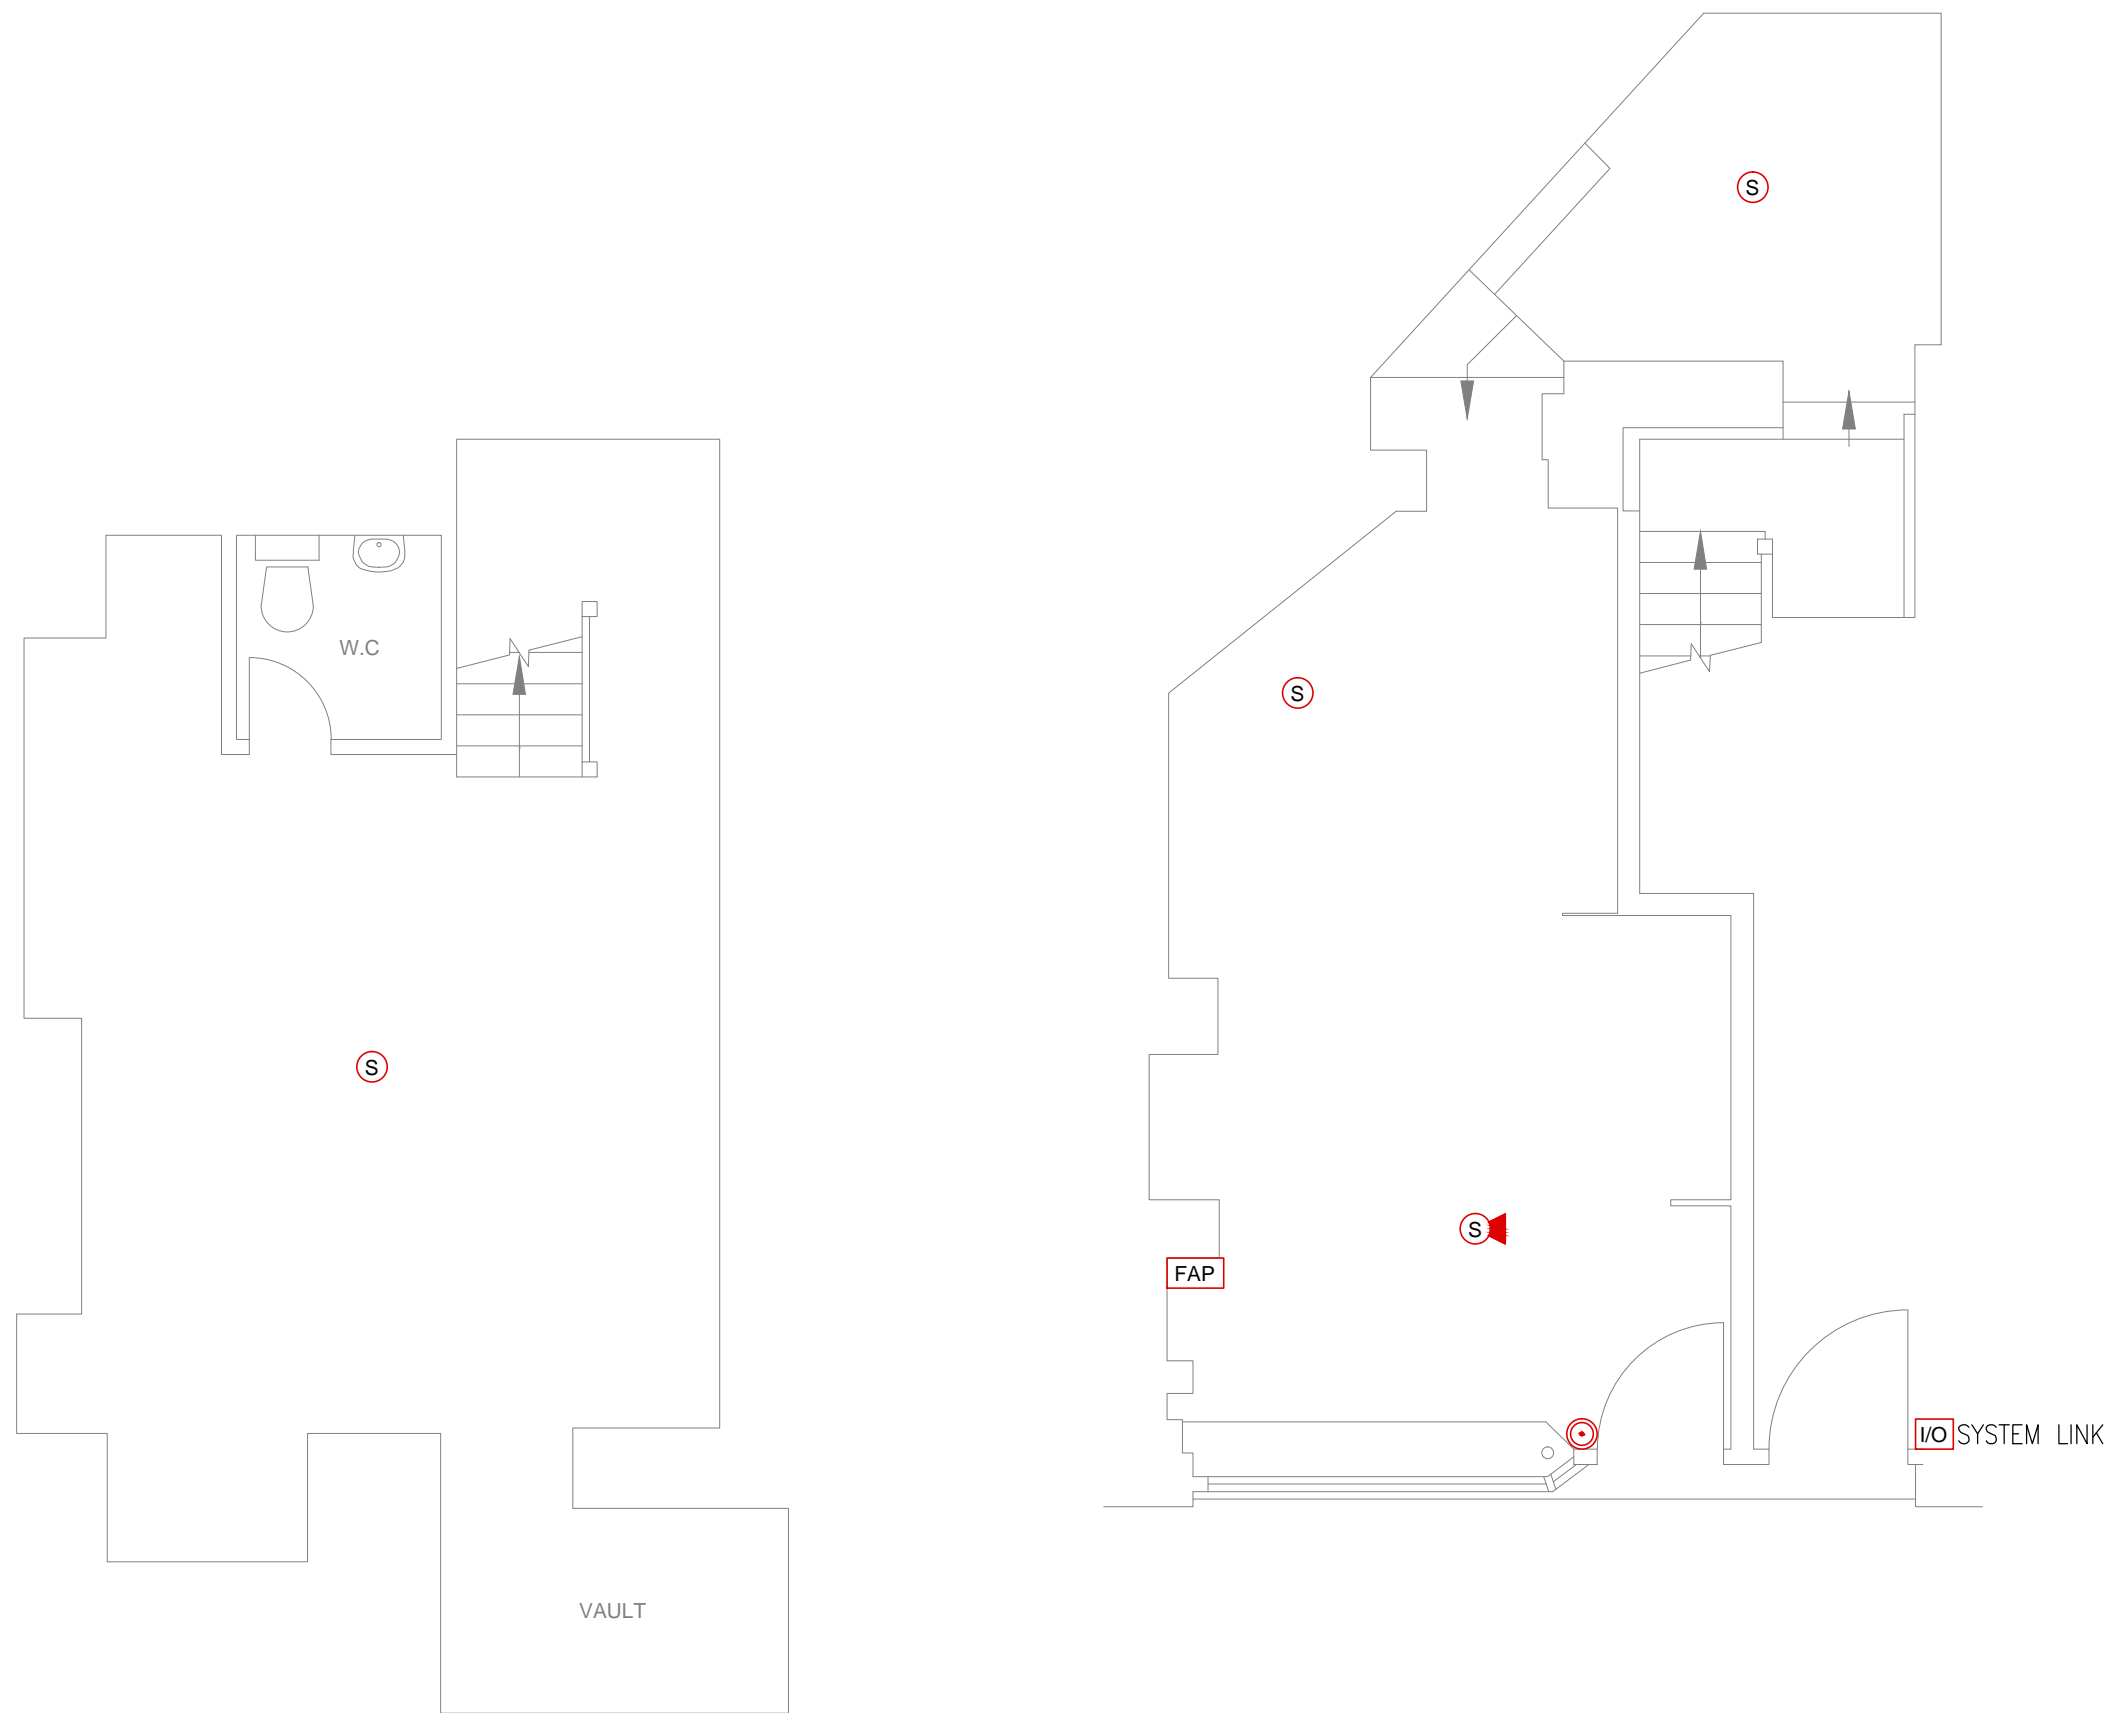


REFERENCE DRAWINGS		DATE	REV
DRAWING No.	23081-ED1	xx/10/19	-
DRAWING TITLE			
EXISTING PLANS			

FIRE ALARM LEGEND

-  MANUAL CALL POINT
-  SMOKE SENSOR
-  c/w SOUNDER
-  FIRE ALARM PANEL
-  INPUT/OUTPUT DEVICE



Rev	Date	Details	Chkd

ESSENTIAL GROUP
Essential Group, Security House, Unit 3 Weald Hall Ind. Estate,
Weald Hall Lane, Thornwood, Essex. CM16 6NR
Tel: 0844 800 5725
www.essentialsecuritysystems.co.uk

Client



Drawing Status
WORKING DRAWING

Date	Scale	Drawn	Checked	Approved
29.01.2016	1:50 @ A3	OCS/SG	MS	MS

Project Title
SCREENFACE
48 MONMOUTH STREET
LONDON
WC2H 9EP

Drawing Title
BASEMENT & GROUND FLOOR
FIRE ALARM LAYOUT

Drawing Number	Rev
ES-E-002	-