











REFERENCE DRAWINGS

DRAWING No.	DATE	REV
23081-ED1	xx/10/19	-
DRAWING TITLE		
EXISTING PLANS		

LEGEND

-  PANIC ALARM BUTTON
-  DUAL TECH MOTION DETECTOR
-  DOOR CONTACT
-  SHOCK DETECTOR
-  REMOTE KEYPAD
-  SIREN
-  I.P. CAMERA
-  MONITOR & NETWORK VIDEO RECORDER
- IS DENOTES INTERNAL SIREN
- ES DENOTES EXTERNAL SIREN

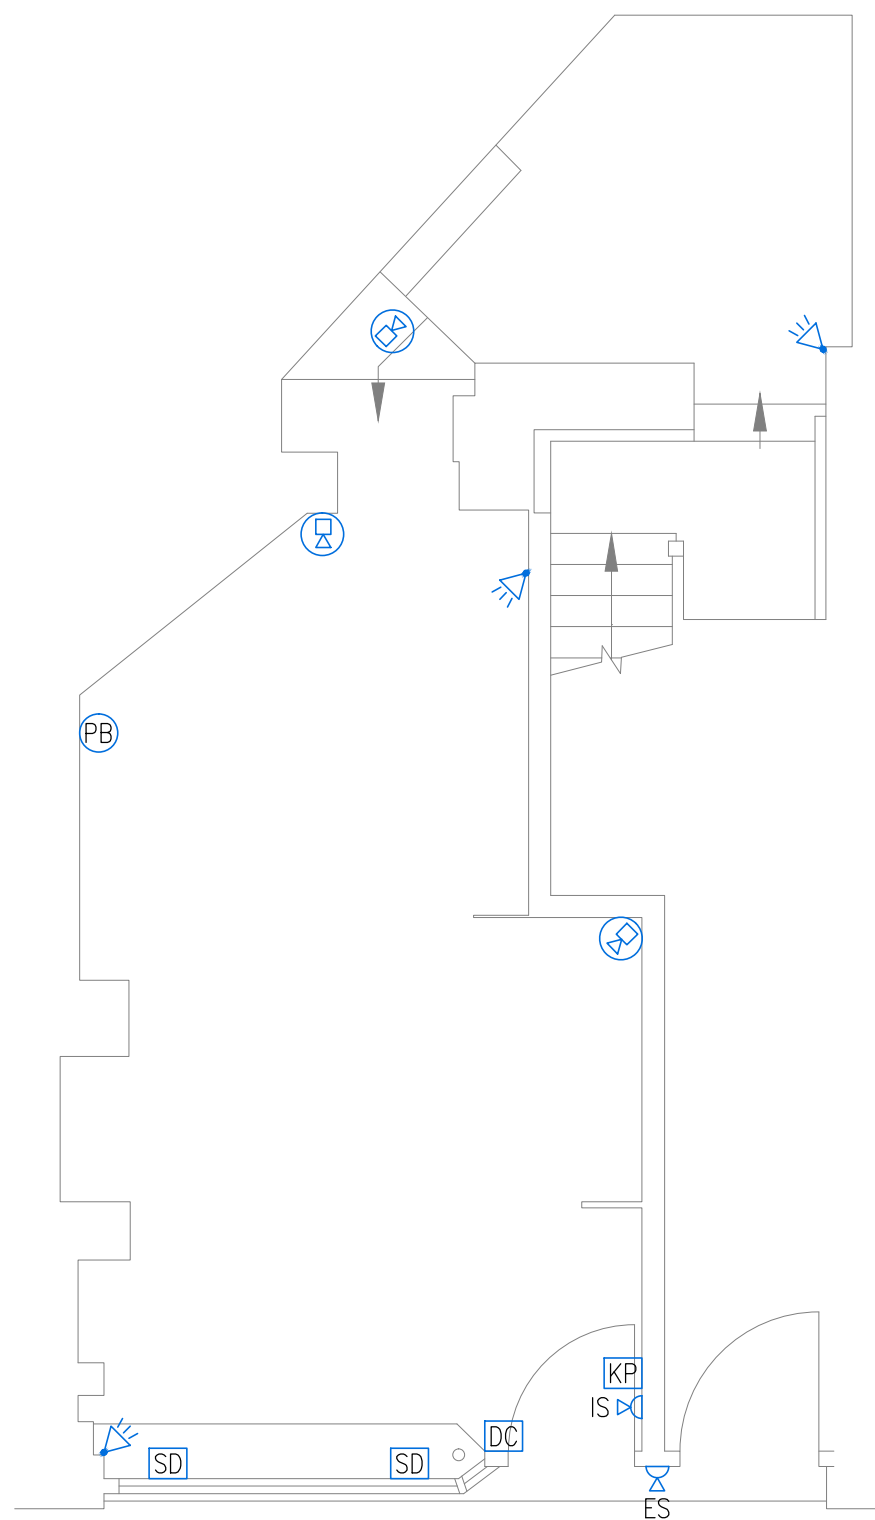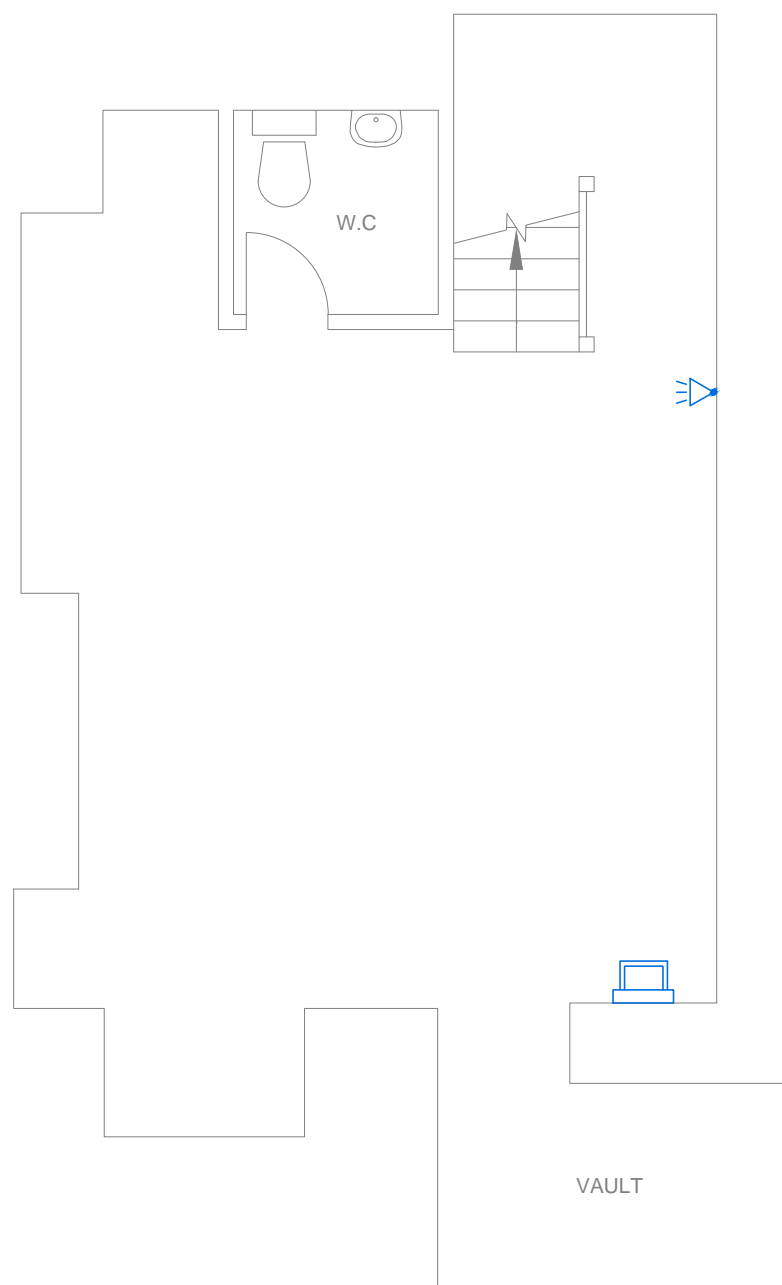

Rev	Date	Details	Chkd



Essential Group, Security House, Unit 3 Weald Hall Ind. Estate,
Weald Hall Lane, Thornwood, Essex. CM16 6NR

Tel: 0844 800 5725
www.essentialsecuritysystems.co.uk



Client



Drawing Status

WORKING DRAWING

Date	Scale	Drawn	Checked	Approved
29.01.2016	1:50 @ A3	OCS/SG	MS	MS

Project Title

SCREENFACE
48 MONMOUTH STREET
LONDON
WC2H 9EP

Drawing Title

BASEMENT & GROUND FLOOR
SECURITY LAYOUT

Drawing Number	Rev
ES-E-003	-