
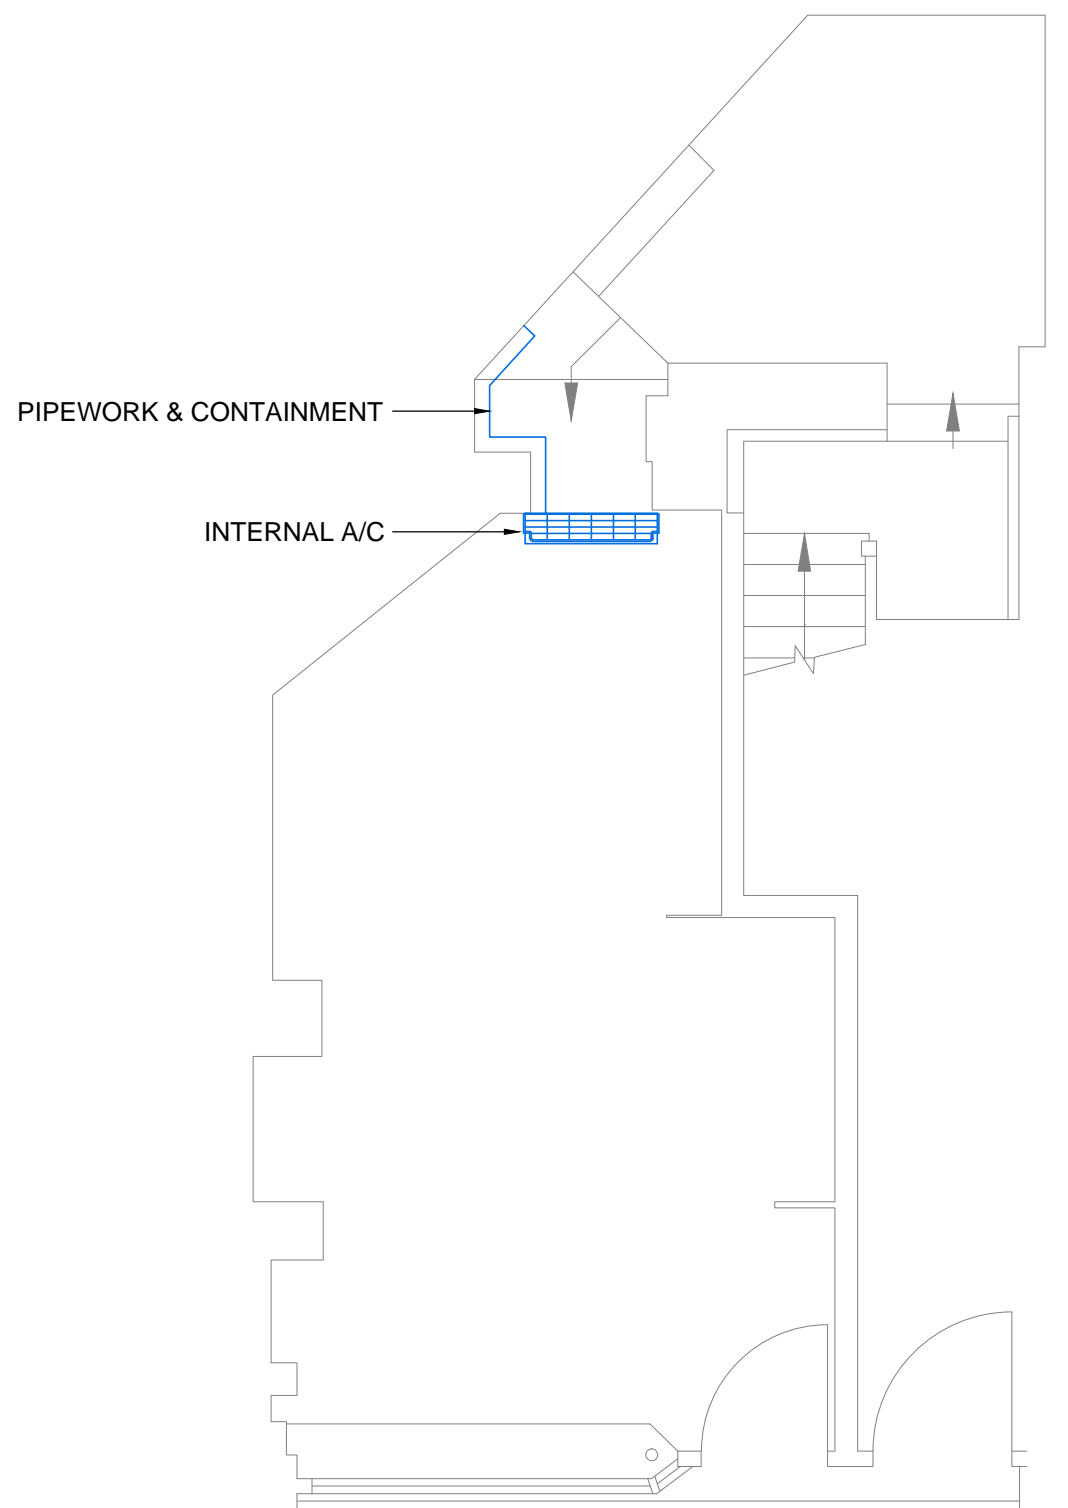


REFERENCE DRAWINGS

| DRAWING No. | DATE | REV |
|----------------|----------|-----|
| 23081-ED1 | xx/10/19 | - |
| DRAWING TITLE | | |
| EXISTING PLANS | | |

LEGEND

PIPEWORK

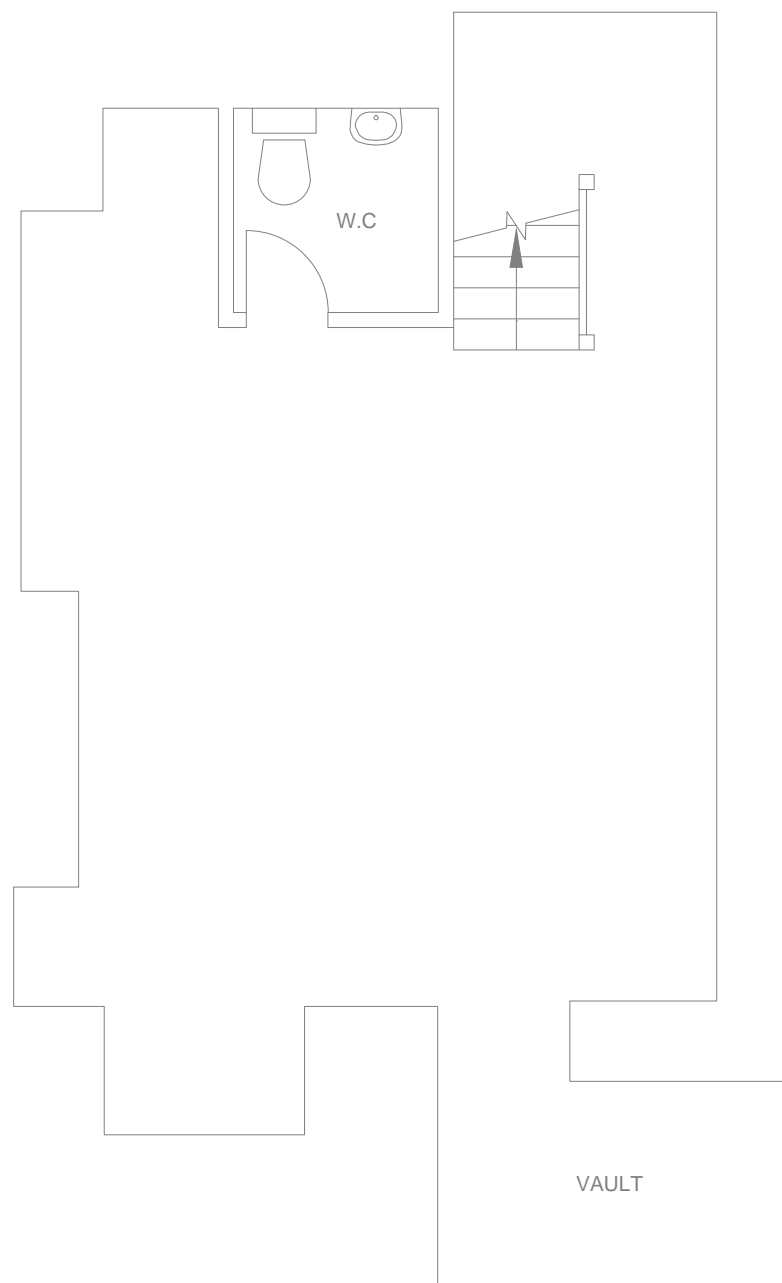

| Rev | Date | Details | Chkd |
|-----|------|---------|------|
|-----|------|---------|------|



Essential Group, Security House, Unit 3 Weald Hall Ind. Estate,
Weald Hall Lane, Thornwood, Essex. CM16 6NR

Tel: 0844 800 5725
www.essentialsecuritysystems.co.uk



Client



Drawing Status

WORKING DRAWING

| Date | Scale | Drawn | Checked | Approved |
|------------|-----------|--------|---------|----------|
| 15.01.2016 | 1:50 @ A3 | OCS/TF | MS | MS |

Project Title

SCREENFACE
48 MONMOUTH STREET
LONDON
WC2H 9EP

Drawing Title

BASEMENT & GROUND FLOOR
MECHANICAL LAYOUT

Drawing Number

ES-M-001

Rev

-