



**Disclaimer:**  
This drawing is a conceptual drawing and not a contract document. It is intended to provide a visual representation of the proposed design and is not intended to be used for construction or other purposes without the written consent of the architect. The architect shall not be responsible for any errors or omissions in this drawing or for any consequences arising from its use. The client shall be responsible for obtaining all necessary permits and approvals for the project. The architect shall not be responsible for any delays or cost overruns in the project. The architect shall not be responsible for any damage to the property or any other loss arising from the project.

**Notes:**  
1. External lighting will be controlled via timetask and daylight sensing and manually from concierge desk.  
2. External lighting LUX levels are indicated on this layout in the form of numbers.  
3. Spotlight (S) will have a narrow beam and will be controlled on the tree and will be time controlled.  
4. Round bulkheads (C) will be wall mounted and no light distribution to the adjacent areas is anticipated.

Rev.	Date	Designed	CAD	Checked
0	25.09.15	MMC	LSE	MP
1	07.10.15	MMC	LSE	MP
2	18.11.15	MMC	WA	MP
4	17.03.16	MMC	MK	KG

**Revised Information:**  
This drawing has been generated using a Computer Aided Drafting (CAD) system. The drawing is not to be used for construction or other purposes without the written consent of the architect. The architect shall not be responsible for any errors or omissions in this drawing or for any consequences arising from its use. The client shall be responsible for obtaining all necessary permits and approvals for the project. The architect shall not be responsible for any delays or cost overruns in the project. The architect shall not be responsible for any damage to the property or any other loss arising from the project.

Ref	Description
C	Thorn Love LED Wall mounted, 15W
D	ThornLuz ProtonLuz LED bulkhead, 20W
EX	Concert EX65, Emergency bulkhead
F	Broadbeak Quad LED with grill, 4W
G	Mirage LED IP65, 4000K, 23W
S	Mini LED Spotlight

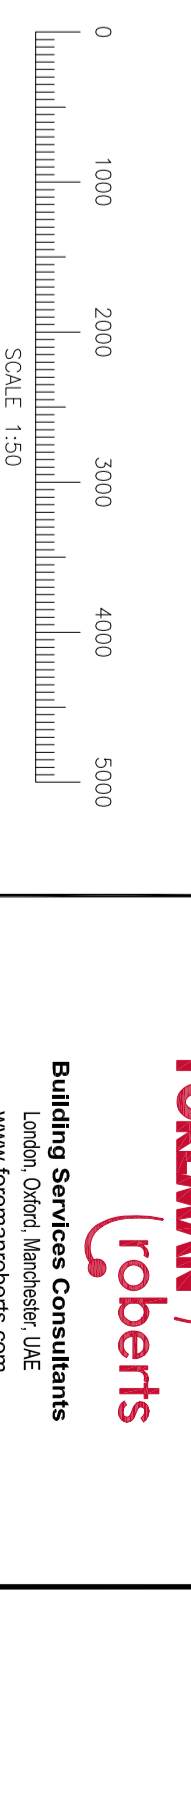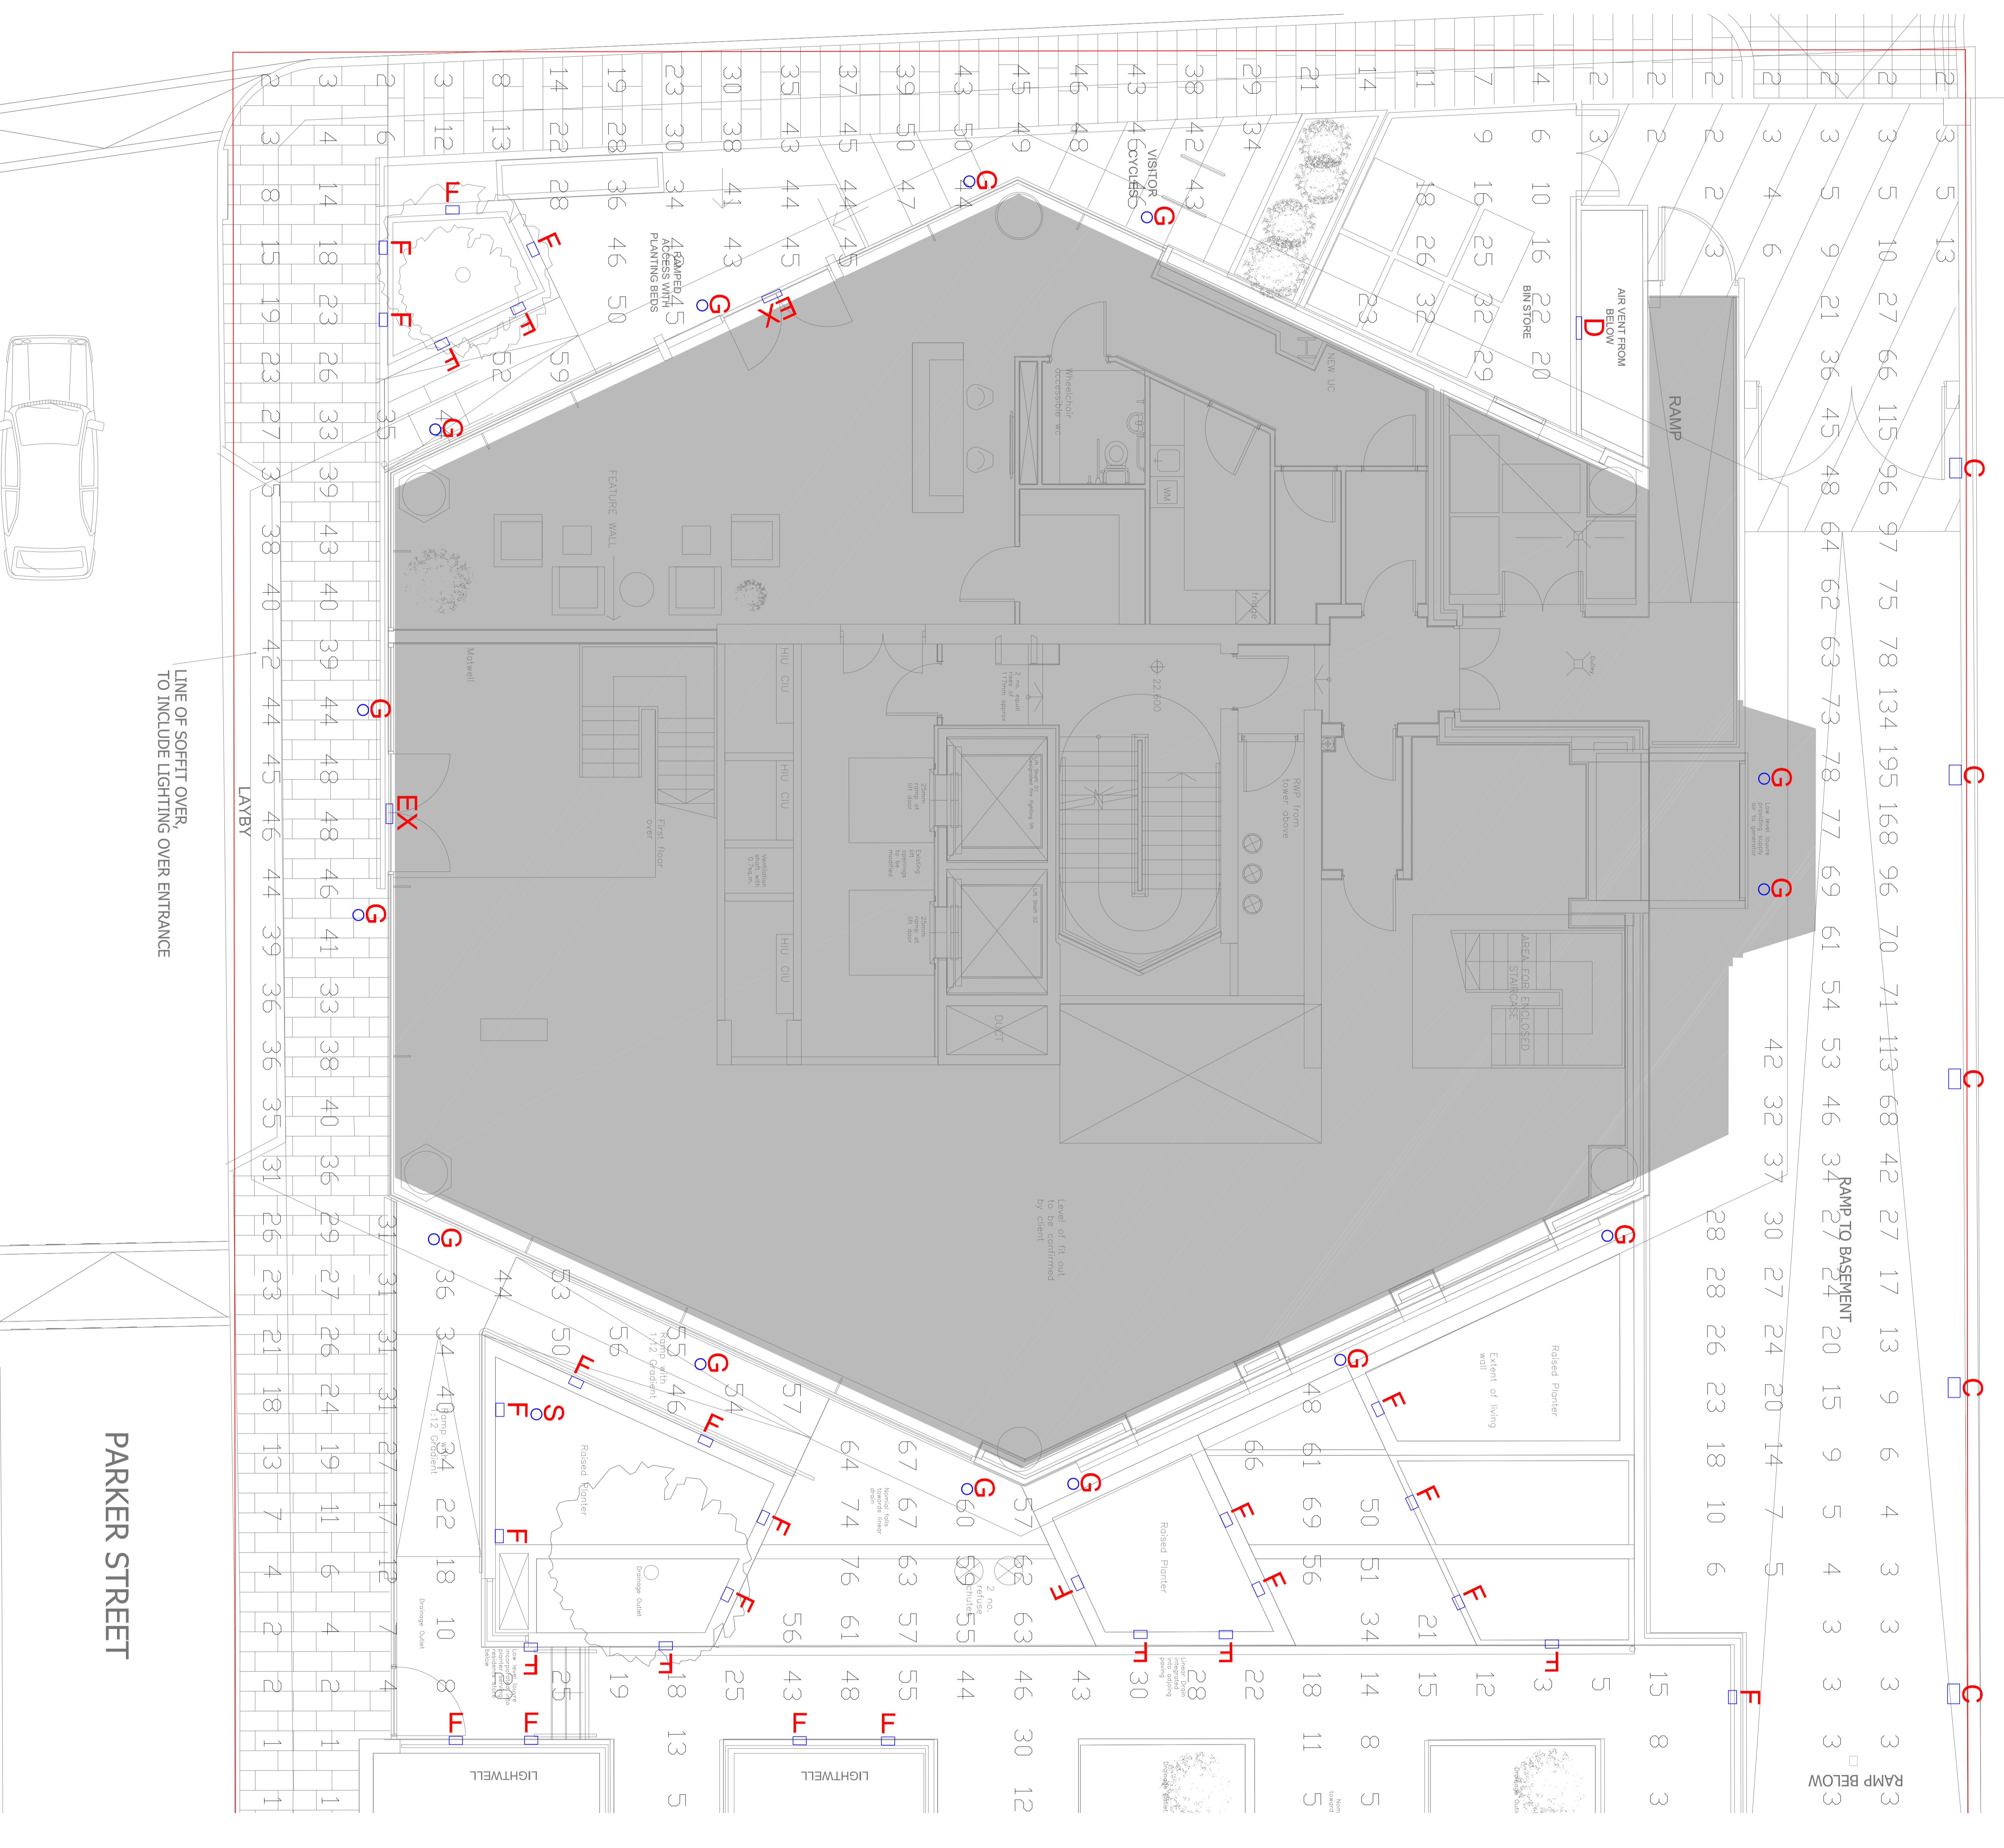

**FOR INFORMATION**

Date	Drawing No.
SEPT 2015	BT-97-G-01
Drawn	Project No.
MMC	L136396
Checked	Revision
MP	4
Particulars	Page Number
BT-97-G-01-A0	1/50

**Project Title:** PARKER TOWER  
**Drawing Title:** External Works BLOCK 1 EXTERNAL LIGHTING LAYOUT

**Building Services Consultants:**  
**FOREMAN roberts**  
www.foremanroberts.com  
Workshop 5, 54 Broomfield St, Auckland 1023  
Tel: 09 308 8900  
Fax: 09 308 8901  
Mobile: 09 308 8902