 





Proposed condenser unit enclosure

**Note**

Use figured dimensions only. All dimensions are to be checked on site and any discrepancies, errors or omissions are to be reported to the architect prior to commencement of works.

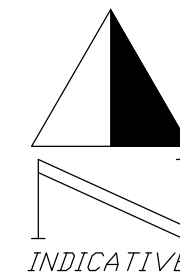

ALL DIMENSIONS APPROXIMATE

READ IN CONJUNCTION WITH DRAWINGS AND SPECIFICATIONS PRODUCED BY STRUCTURAL ENGINEER, M&E CONSULTANT AND VARIOUS SPECIALIST SUB CONTRACTORS & SUPPLIERS

**FOR PLANNING**

| A | 24.01.16 | Enclosure position moved to client reqs | JM |



Outline of the Root Protection Area as identified in the accompanying Tree Survey

**BB PARTNERSHIP LTD**

CHARTERED ARCHITECTS

Studios 33-34, 10 Hornsey St, London. N7 8EL  
Tel 020 7336 8555 - e-mail - architect@bbpartnership.co.uk

© 2015 BB PARTNERSHIP LIMITED

project  
55 Lancaster Grove  
London NW3

drawing  
EXTERNAL CONDENSER UNITS  
Proposed Site Plan

ALL RIGHTS RESERVED

date  
Dec '15

 
scale  
1:200

drawn  
JM

drwg. no  
FIS\_41


rev.  
A

CHECK ALL DIMENSIONS ON SITE



**Note**

Use figured dimensions only. All dimensions are to be checked on site and any discrepancies, errors or omissions are to be reported to the architect prior to commencement of works.

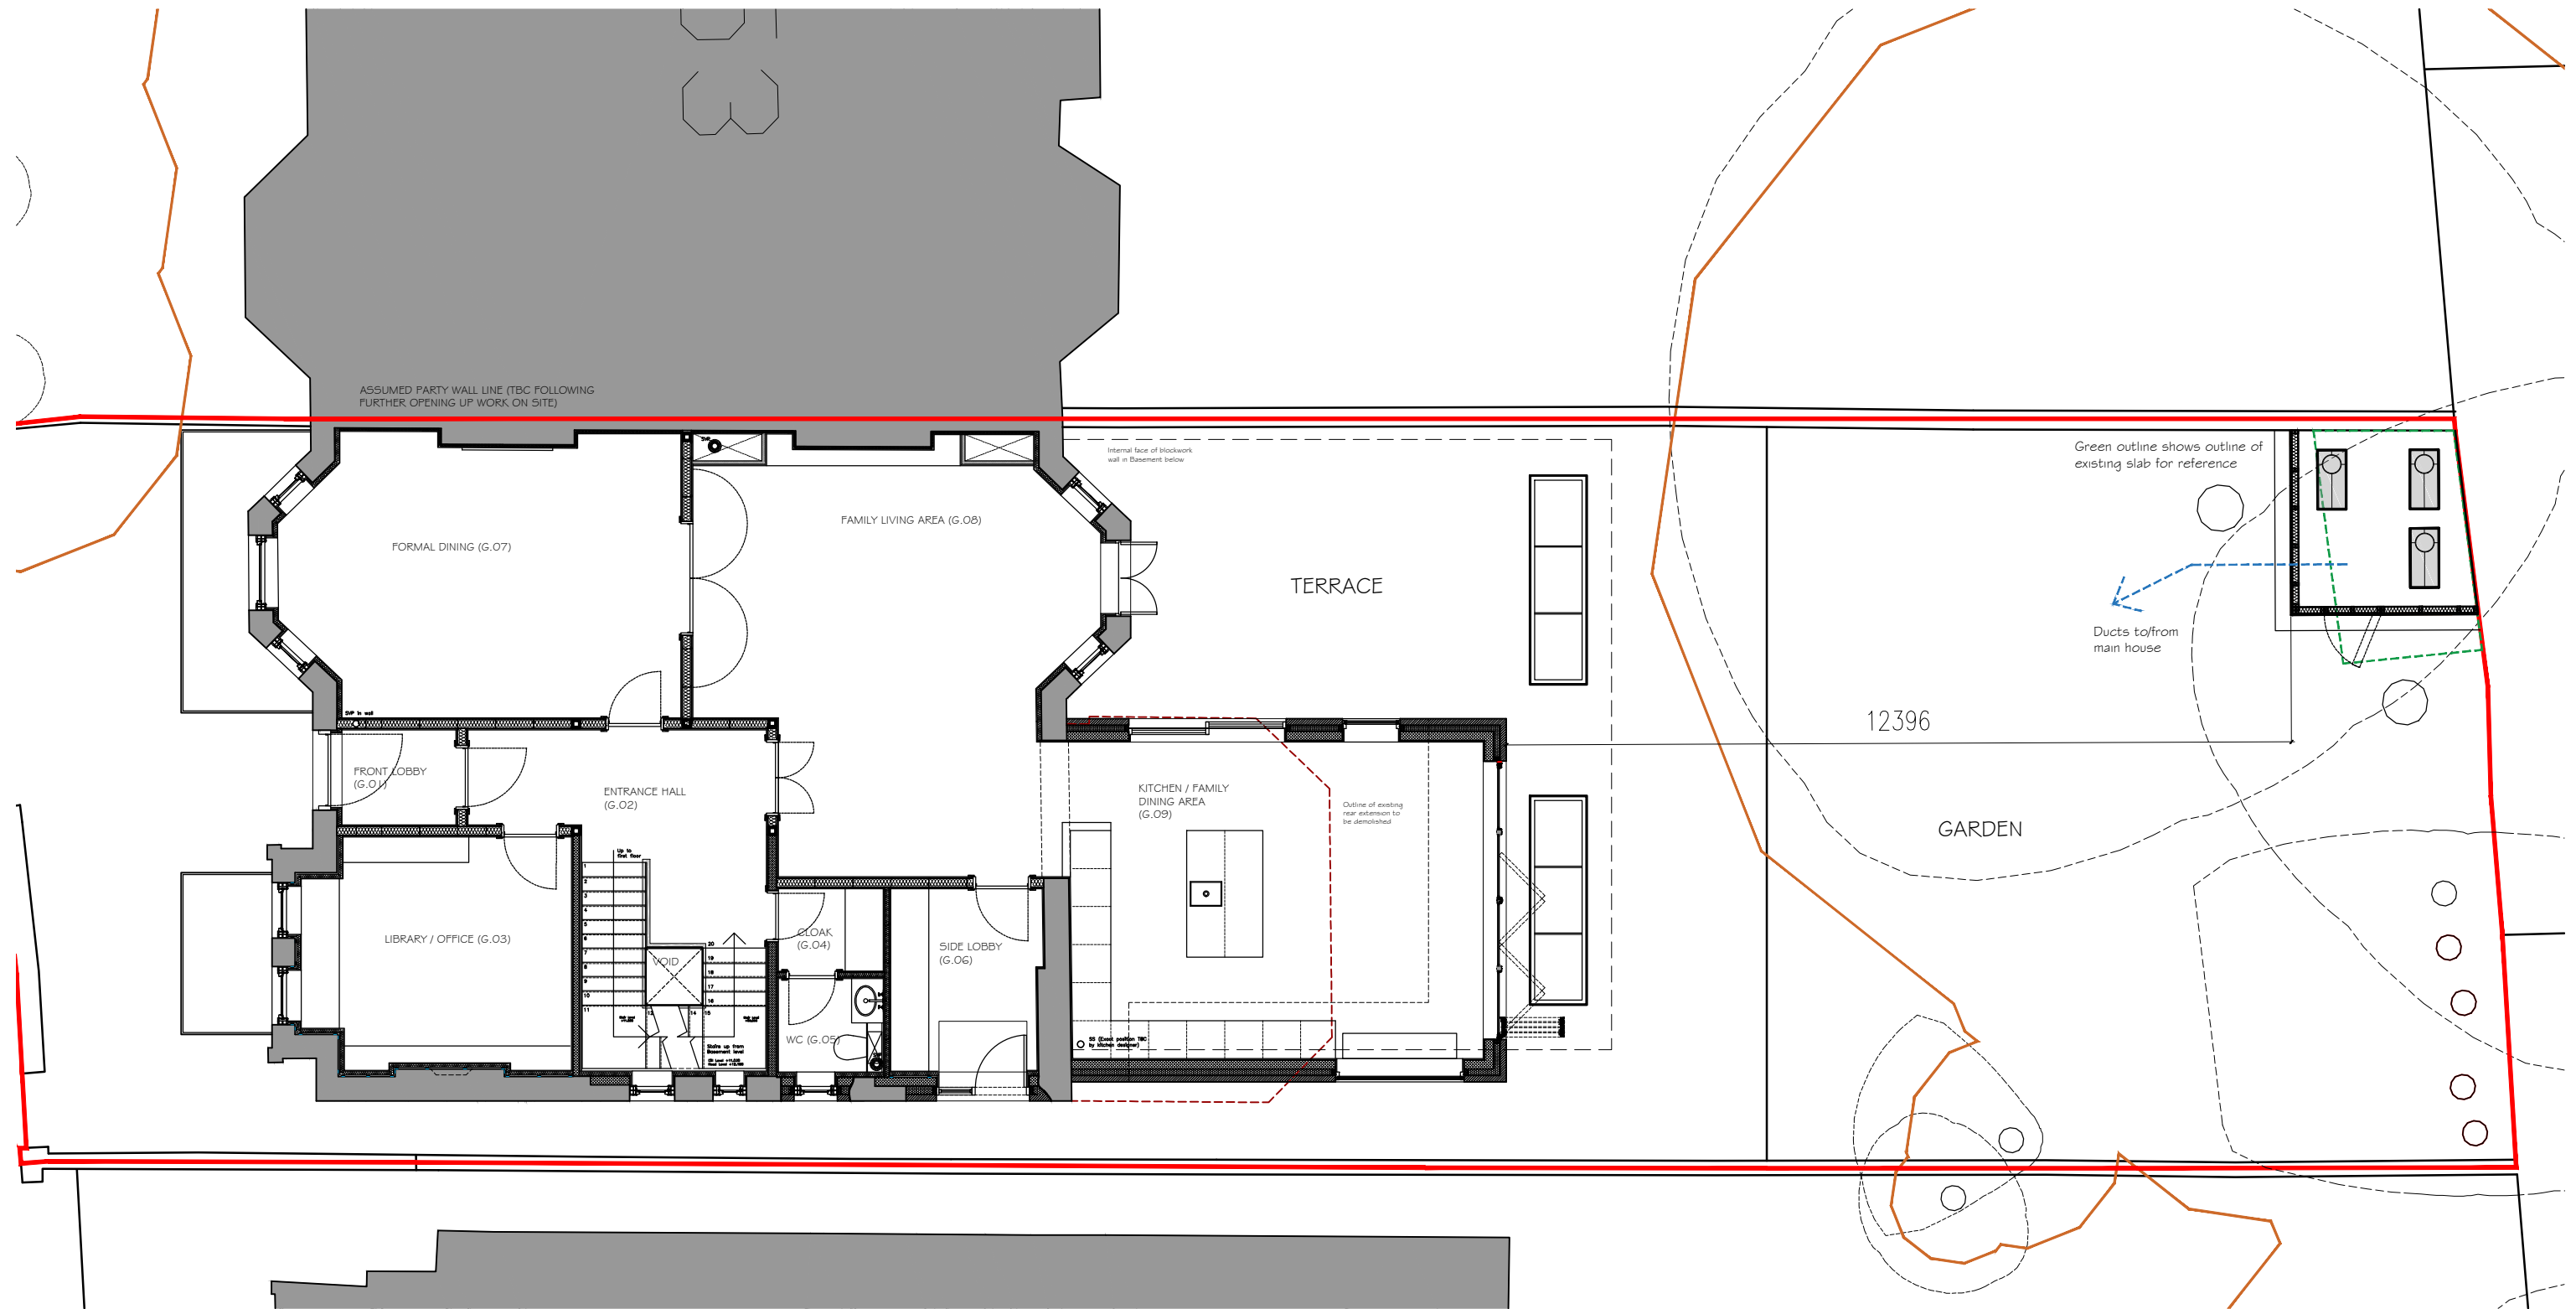


The ground floor plan shown is that of the approved scheme from August 2015 (reference 2015/1037/P).

**FOR PLANNING**

| A | 24.01.16 | Enclosure position moved to client reqs | JM |

**ALL DIMENSIONS APPROXIMATE**

READ IN CONJUNCTION WITH DRAWINGS AND SPECIFICATIONS PRODUCED BY STRUCTURAL ENGINEER, M&E CONSULTANT AND VARIOUS SPECIALIST SUB CONTRACTORS & SUPPLIERS

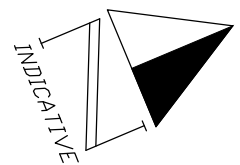


Outline of the Root Protection Area as identified in the accompanying Tree Survey

**BB PARTNERSHIP LTD**  
 CHARTERED ARCHITECTS  
 Studios 33-34, 10 Hornsey St, London. N7 8EL  
 Tel 020 7336 8555 - e-mail - architect@bbpartnership.co.uk


project  
 55 Lancaster Grove  
 London NW3  
 drawing  
 EXTERNAL CONDENSER UNITS  
 Proposed Ground Floor Plan

date Dec '15	scale 1:100	drawn JM
drwg. no FIS_42		rev. A

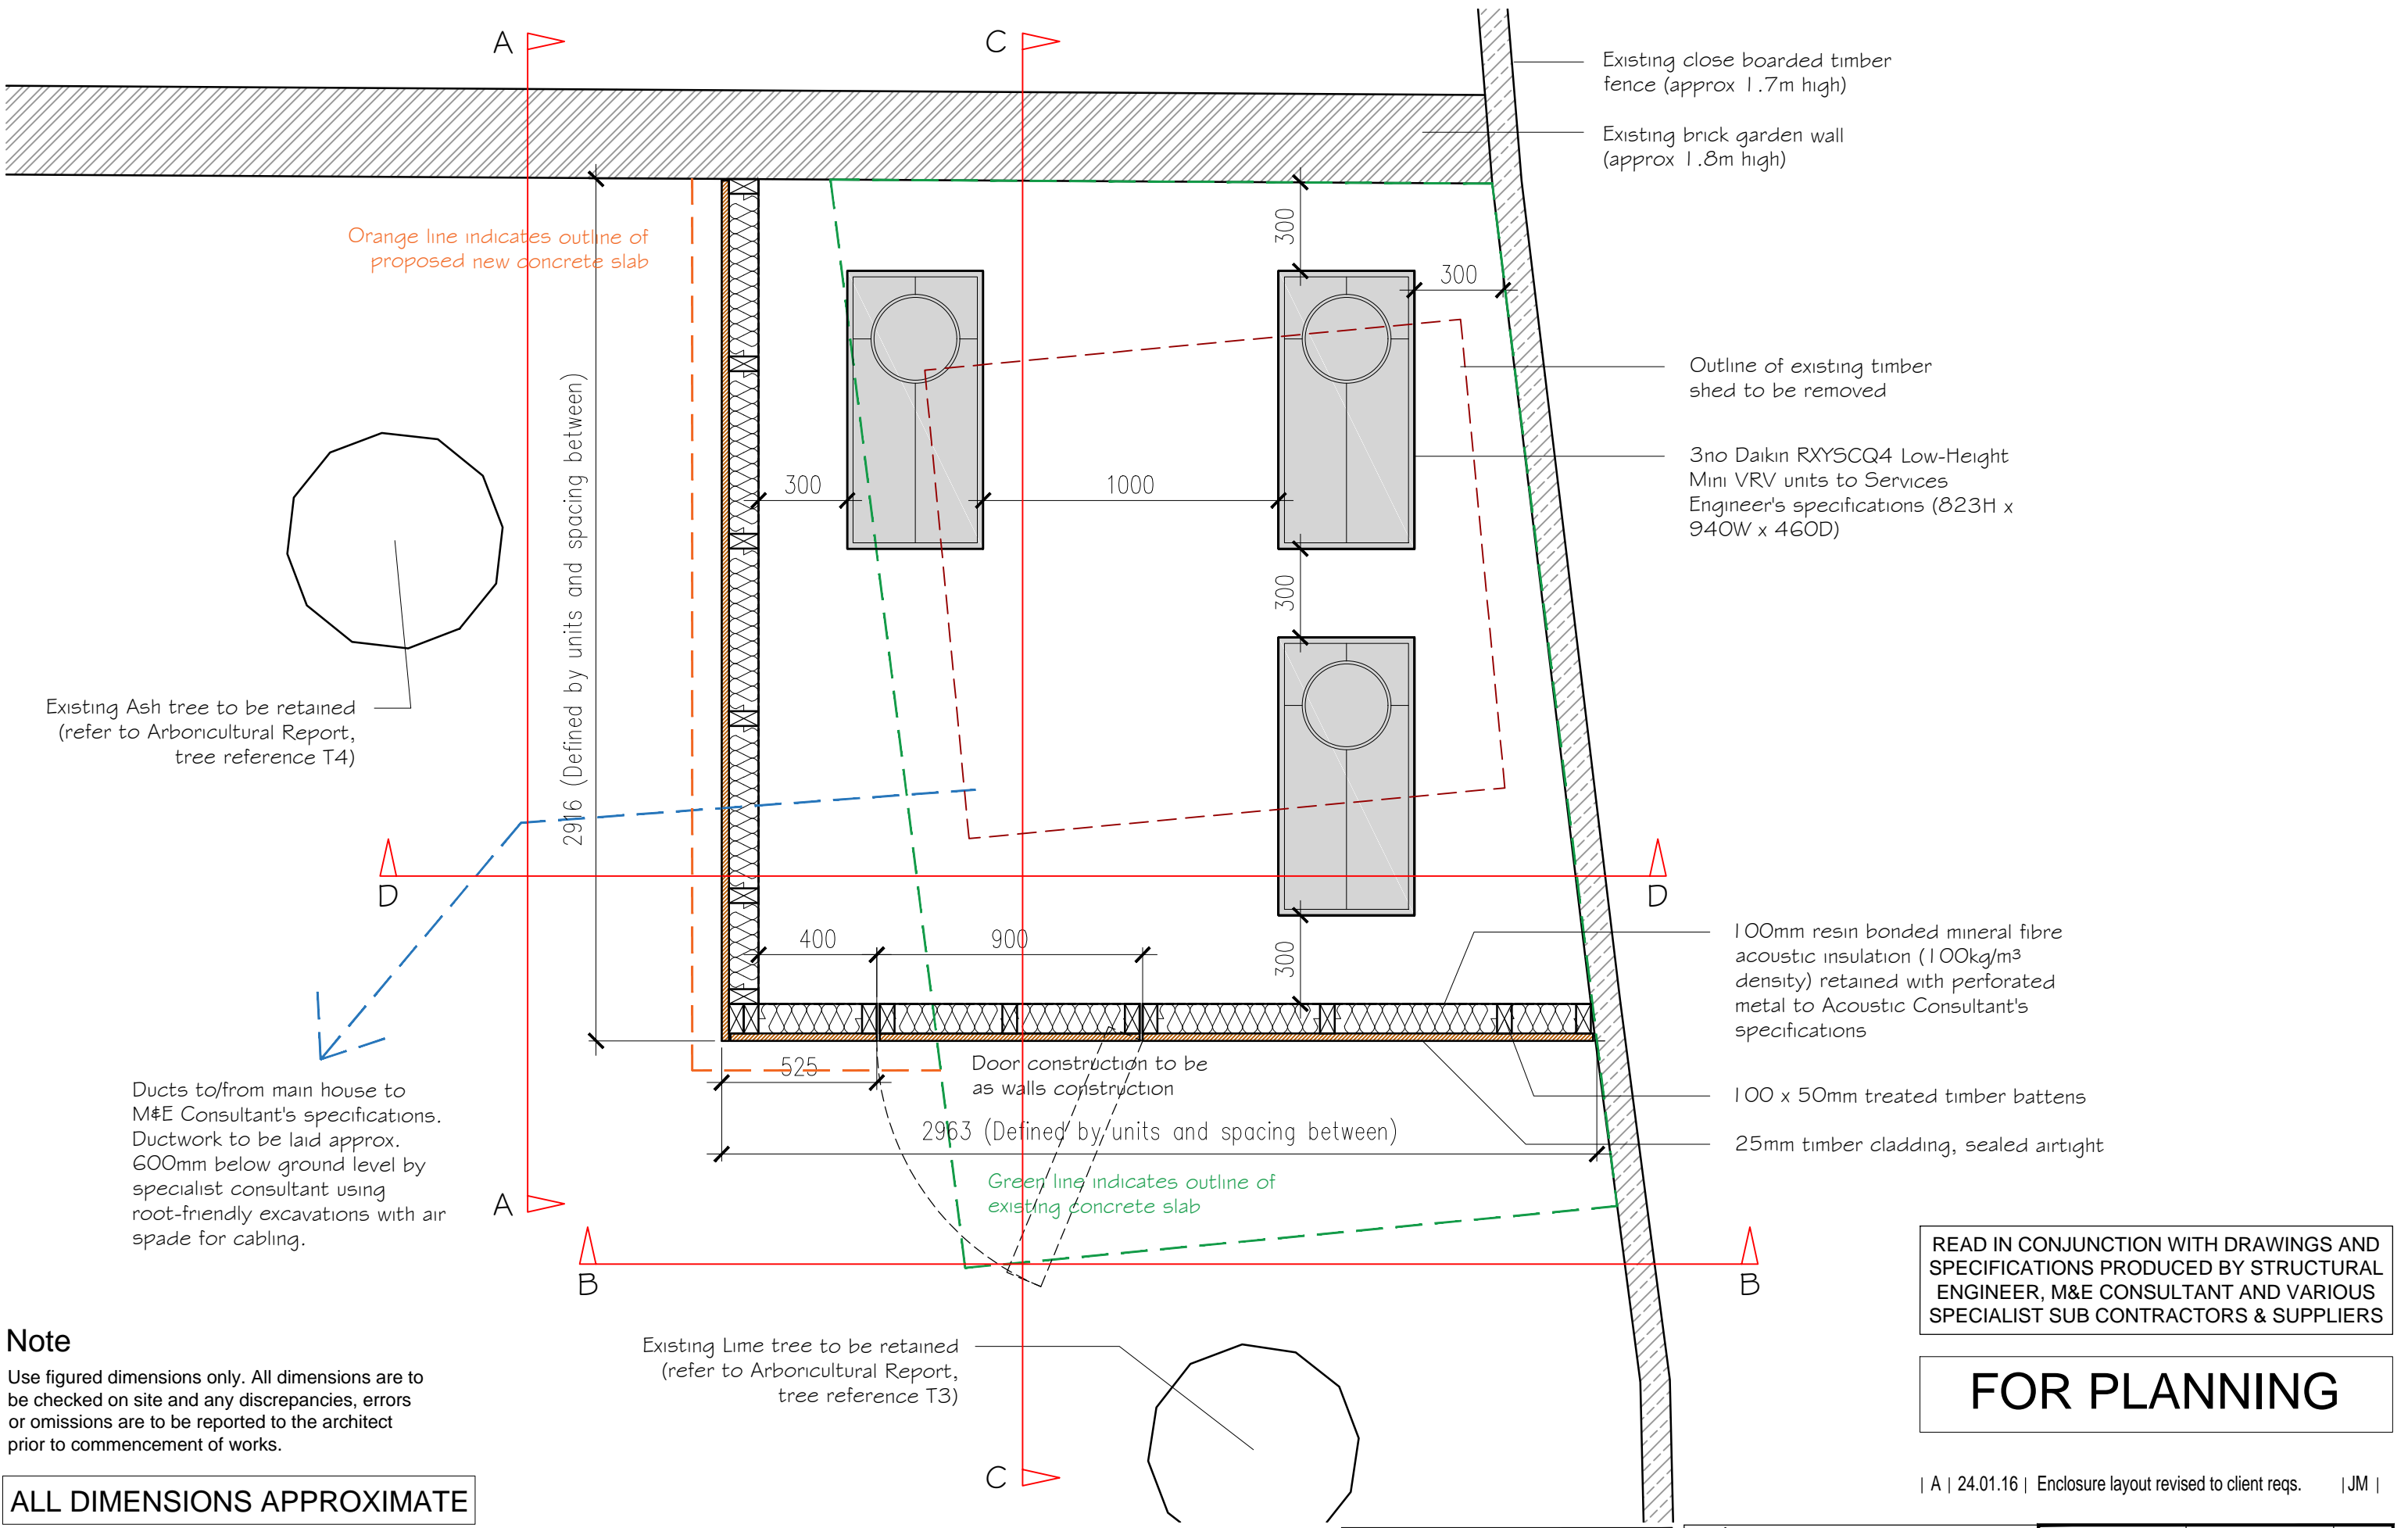

**Note**  
 Use figured dimensions only. All dimensions are to be checked on site and any discrepancies, errors or omissions are to be reported to the architect prior to commencement of works.

ALL DIMENSIONS APPROXIMATE

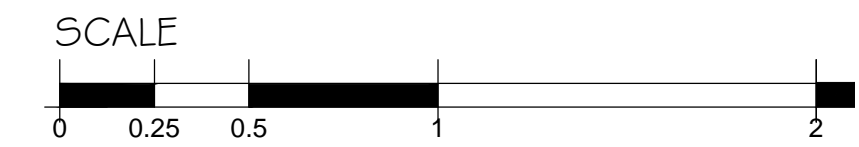

READ IN CONJUNCTION WITH DRAWINGS AND SPECIFICATIONS PRODUCED BY STRUCTURAL ENGINEER, M&E CONSULTANT AND VARIOUS SPECIALIST SUB CONTRACTORS & SUPPLIERS

**FOR PLANNING**


| A | 24.01.16 | Enclosure layout revised to client reqs. | JM |

**BB PARTNERSHIP LTD**  
 CHARTERED ARCHITECTS  
 Studios 33-34, 10 Hornsey St, London. N7 8EL  
 Tel 020 7336 8555 - e-mail - architect@bbpartnership.co.uk

project 55 Lancaster Grove London NW3	date Dec '15	scale 1:20 @ A3	drawn JM
drawing EXTERNAL CONDENSER UNITS Condenser Units Enclosure Plan	drwg. no FIS_45		rev. A

## Note

Use figured dimensions only. All dimensions are to be checked on site and any discrepancies, errors or omissions are to be reported to the architect prior to commencement of works.

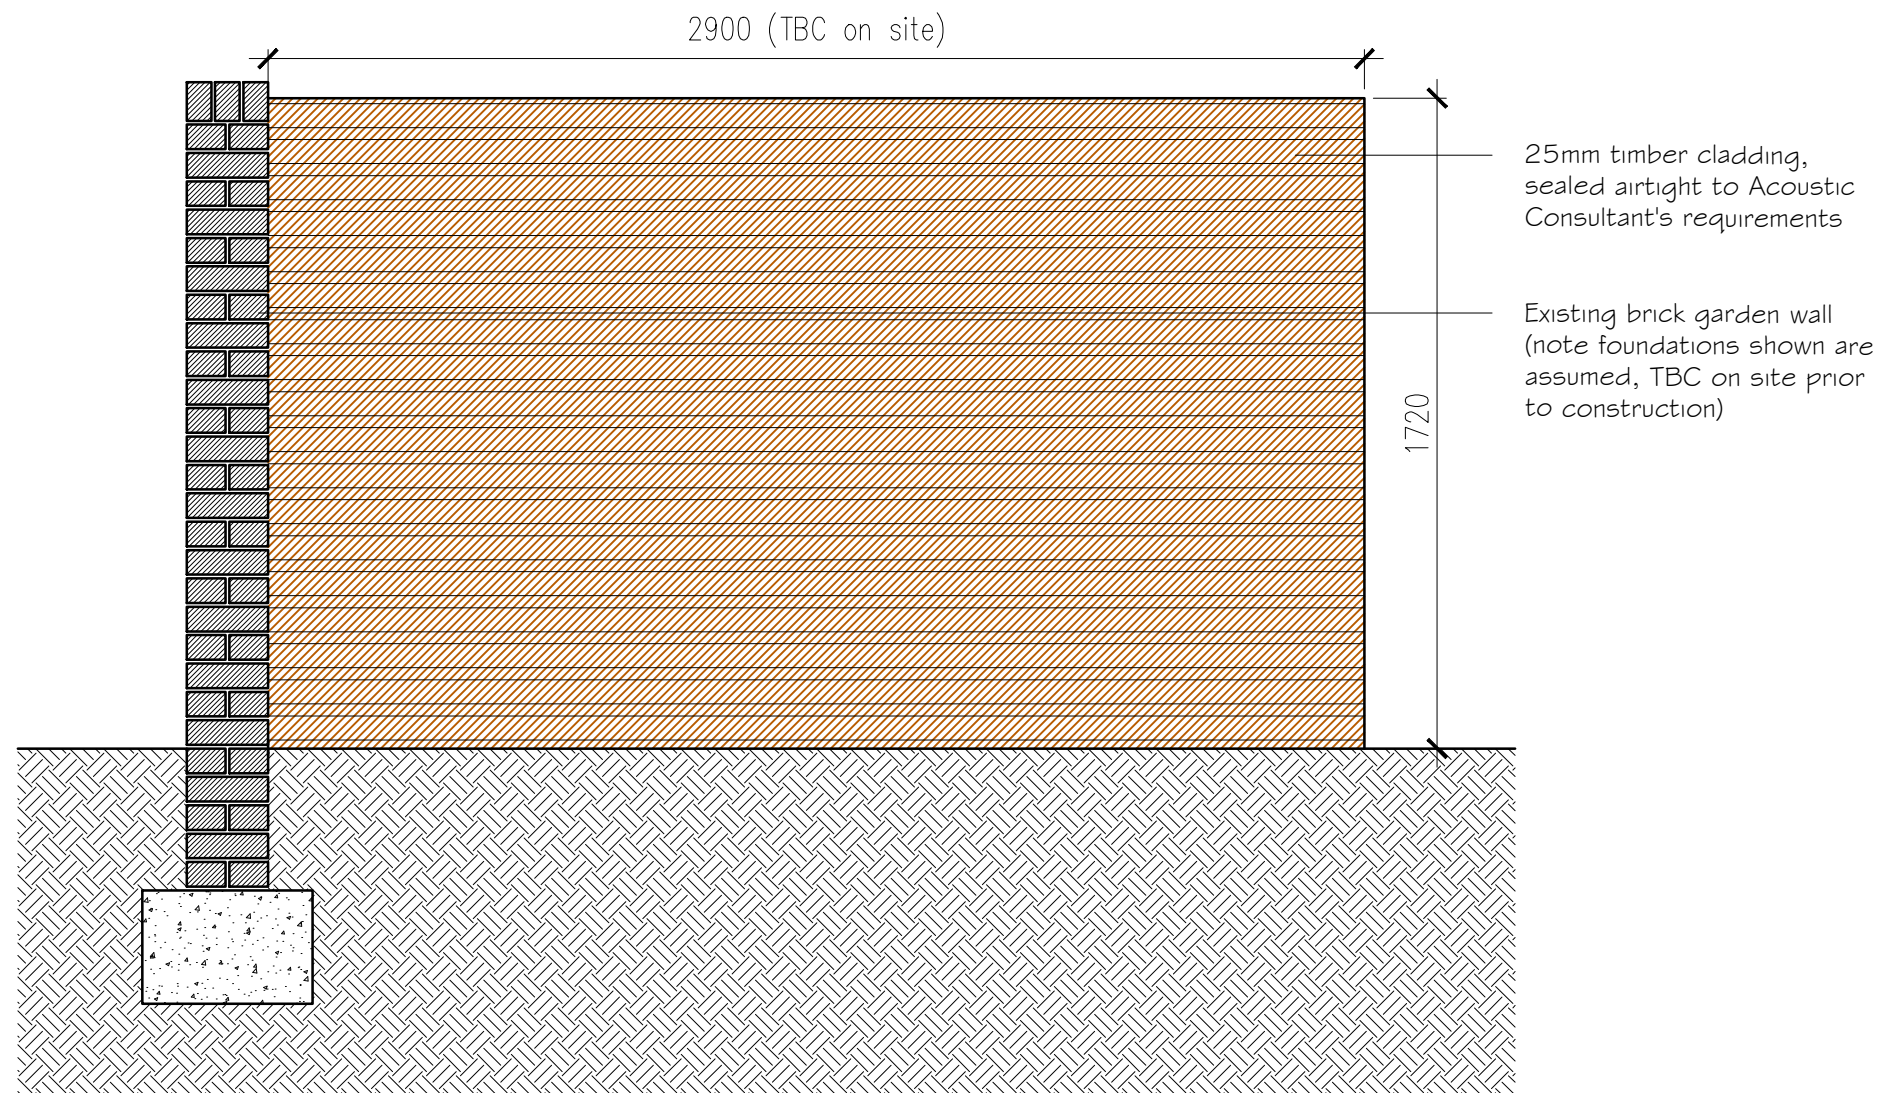


Proposed Enclosure for Plant Equipment  
Section A-A

ALL DIMENSIONS APPROXIMATE

READ IN CONJUNCTION WITH DRAWINGS AND SPECIFICATIONS PRODUCED BY STRUCTURAL ENGINEER, M&E CONSULTANT AND VARIOUS SPECIALIST SUB CONTRACTORS & SUPPLIERS

FOR PLANNING

 SCALE



**BB PARTNERSHIP LTD**

CHARTERED ARCHITECTS

Studios 33-34, 10 Hornsey St, London. N7 8EL  
Tel 020 7336 8555 - e-mail - architect@bbpartnership.co.uk

© 2015 BB PARTNERSHIP LIMITED

project  
55 Lancaster Grove  
London NW3

drawing  
EXTERNAL CONDENSER UNITS  
Proposed Section A-A

ALL RIGHTS RESERVED

date  
Jan '16

scale  
1:20 @ A3

drawn  
JM


drwg. no  
FIS\_46

rev.  
A

CHECK ALL DIMENSIONS ON SITE

## Note

Use figured dimensions only. All dimensions are to be checked on site and any discrepancies, errors or omissions are to be reported to the architect prior to commencement of works.

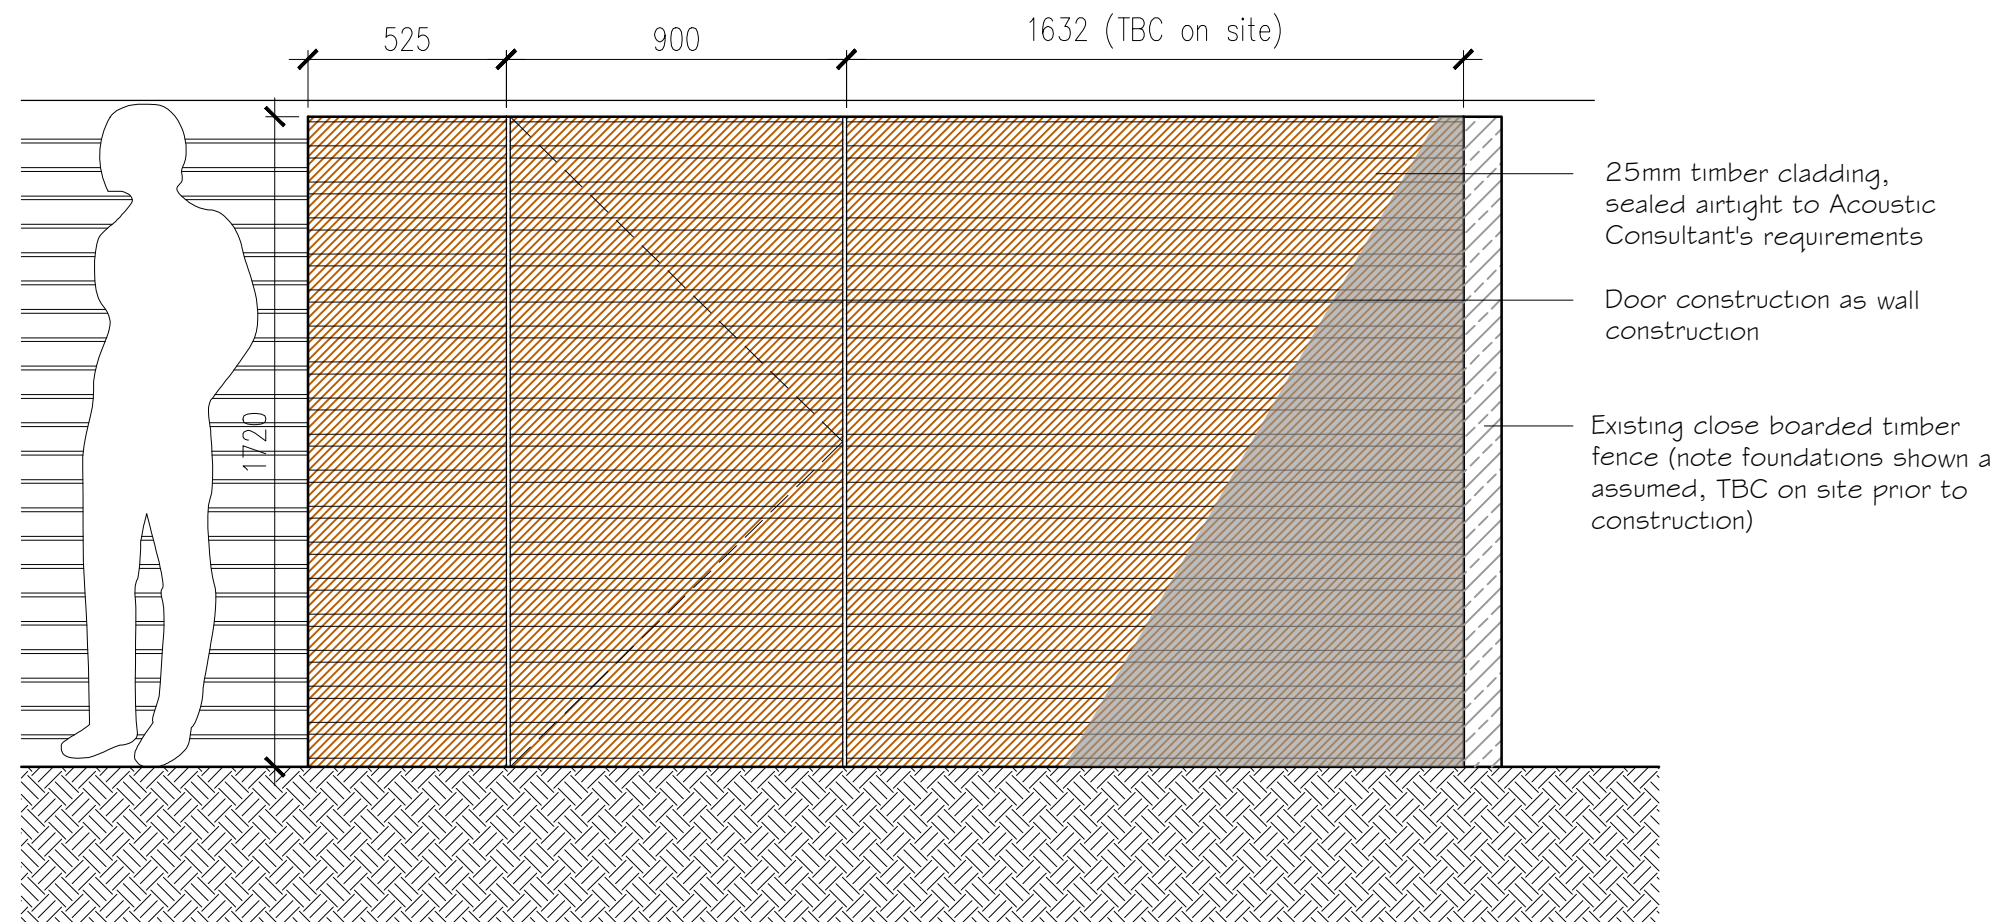


Proposed Enclosure for Plant Equipment  
Section B-B

ALL DIMENSIONS APPROXIMATE

READ IN CONJUNCTION WITH DRAWINGS AND SPECIFICATIONS PRODUCED BY STRUCTURAL ENGINEER, M&E CONSULTANT AND VARIOUS SPECIALIST SUB CONTRACTORS & SUPPLIERS

FOR PLANNING

 SCALE



**BB PARTNERSHIP LTD**

CHARTERED ARCHITECTS

Studios 33-34, 10 Hornsey St, London. N7 8EL  
Tel 020 7336 8555 - e-mail - architect@bbpartnership.co.uk

© 2015 BB PARTNERSHIP LIMITED

project  
55 Lancaster Grove  
London NW3

drawing  
EXTERNAL CONDENSER UNITS  
Proposed Section B-B

ALL RIGHTS RESERVED

date  
Jan '16

scale  
1:20 @ A3

drawn  
JM


drwg. no  
FIS\_47

rev.  
A

CHECK ALL DIMENSIONS ON SITE

## Note

Use figured dimensions only. All dimensions are to be checked on site and any discrepancies, errors or omissions are to be reported to the architect prior to commencement of works.

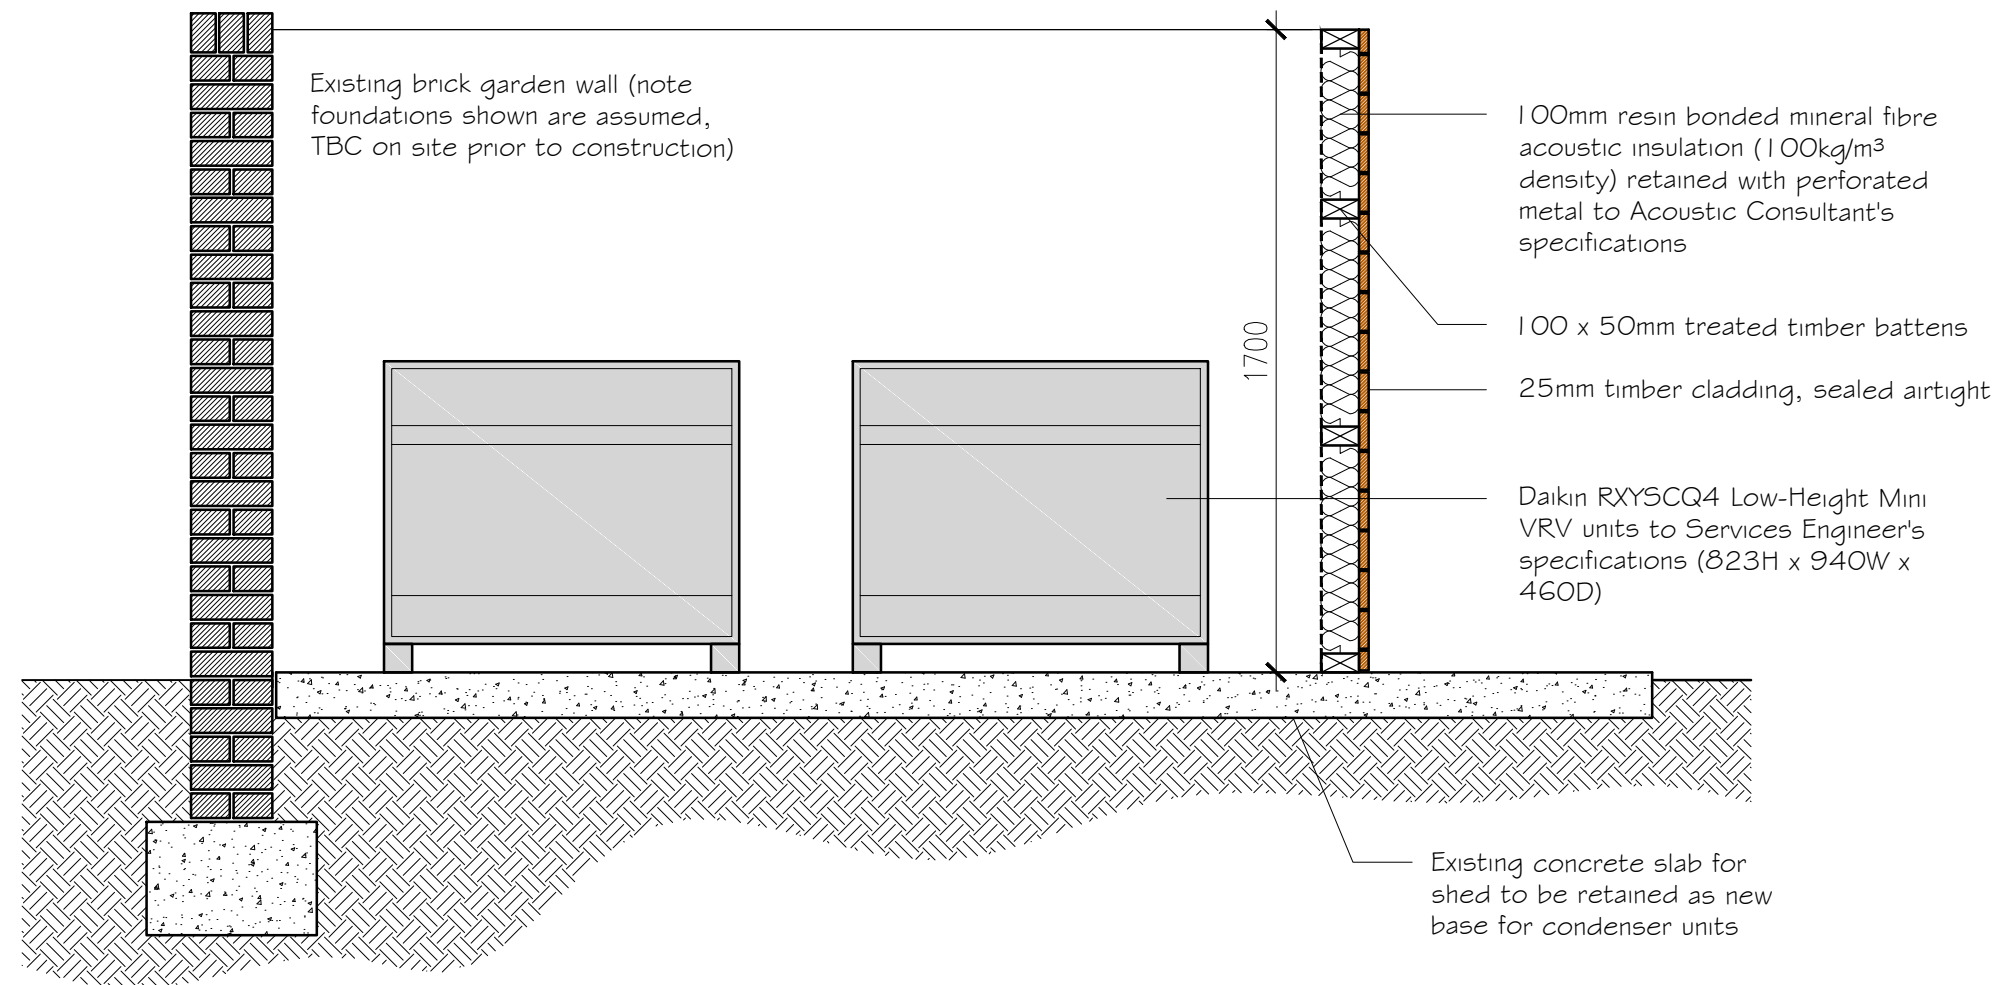


Proposed Enclosure for Plant Equipment  
Section C-C

ALL DIMENSIONS APPROXIMATE

READ IN CONJUNCTION WITH DRAWINGS AND SPECIFICATIONS PRODUCED BY STRUCTURAL ENGINEER, M&E CONSULTANT AND VARIOUS SPECIALIST SUB CONTRACTORS & SUPPLIERS

FOR PLANNING

 SCALE



**BB PARTNERSHIP LTD**

CHARTERED ARCHITECTS

Studios 33-34, 10 Hornsey St, London. N7 8EL  
Tel 020 7336 8555 - e-mail - architect@bbpartnership.co.uk

© 2015 BB PARTNERSHIP LIMITED

project  
55 Lancaster Grove  
London NW3

drawing  
EXTERNAL CONDENSER UNITS  
Proposed Section C-C

ALL RIGHTS RESERVED

date  
Jan '16

scale  
1:20 @ A3

drawn  
JM


drwg. no  
FIS\_48

rev.  
A

CHECK ALL DIMENSIONS ON SITE

## Note

Use figured dimensions only. All dimensions are to be checked on site and any discrepancies, errors or omissions are to be reported to the architect prior to commencement of works.

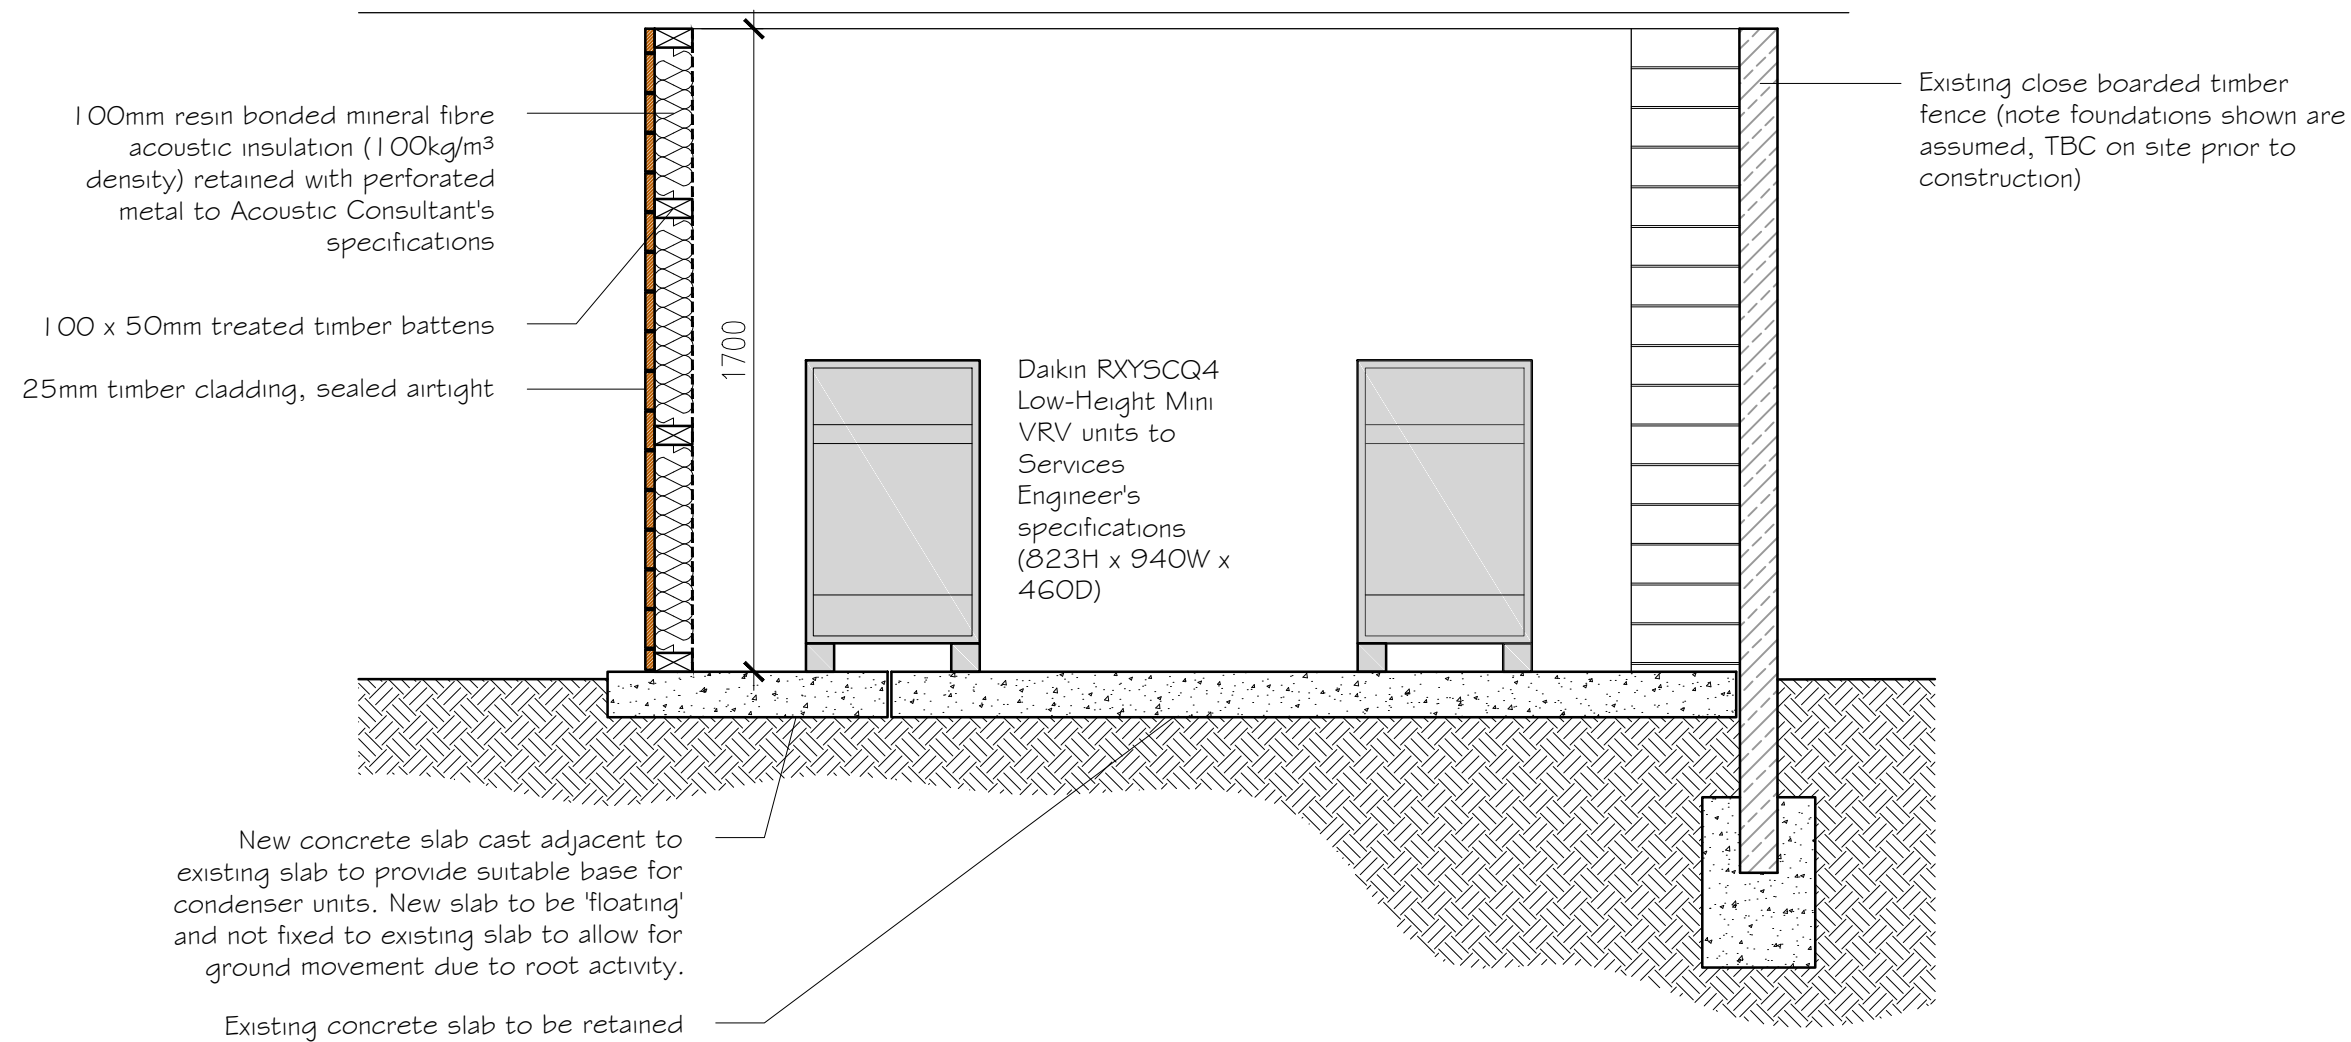


Proposed Enclosure for Plant Equipment  
Section D-D

ALL DIMENSIONS APPROXIMATE

READ IN CONJUNCTION WITH DRAWINGS AND SPECIFICATIONS PRODUCED BY STRUCTURAL ENGINEER, M&E CONSULTANT AND VARIOUS SPECIALIST SUB CONTRACTORS & SUPPLIERS

FOR PLANNING

 SCALE



**BB PARTNERSHIP LTD**

CHARTERED ARCHITECTS

Studios 33-34, 10 Hornsey St, London. N7 8EL  
Tel 020 7336 8555 - e-mail - architect@bbpartnership.co.uk

© 2015 BB PARTNERSHIP LIMITED

project  
55 Lancaster Grove  
London NW3

drawing  
EXTERNAL CONDENSER UNITS  
Proposed Section D-D

ALL RIGHTS RESERVED

date  
Jan '16

scale  
1:20 @ A3

drawn  
JM

drwg. no  
FIS\_49

rev.  
A

CHECK ALL DIMENSIONS ON SITE