




01. Proposed Floor Plan

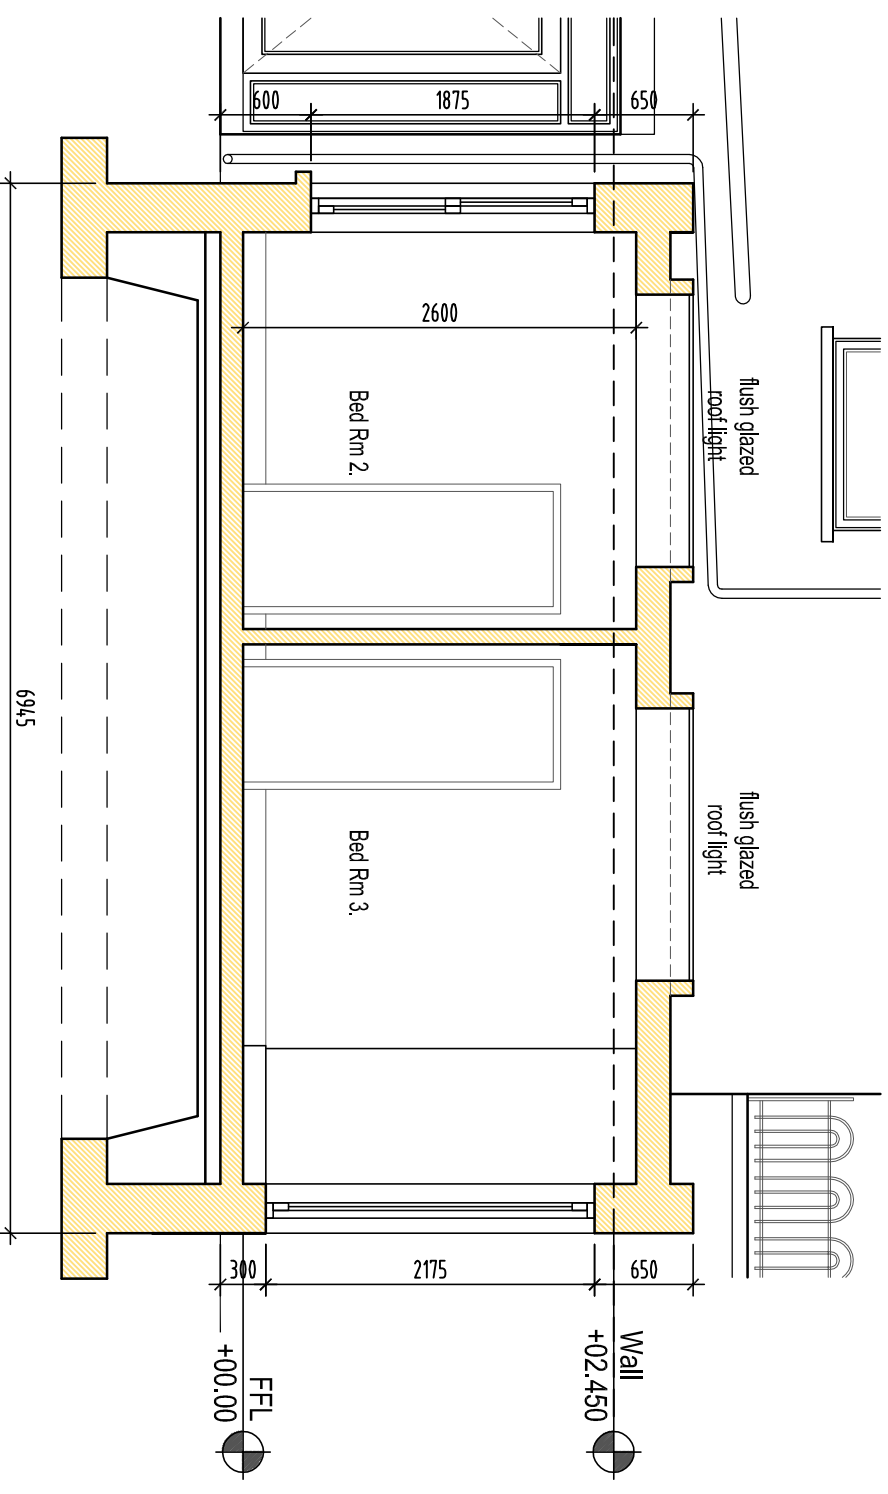


Proposed Section A-A

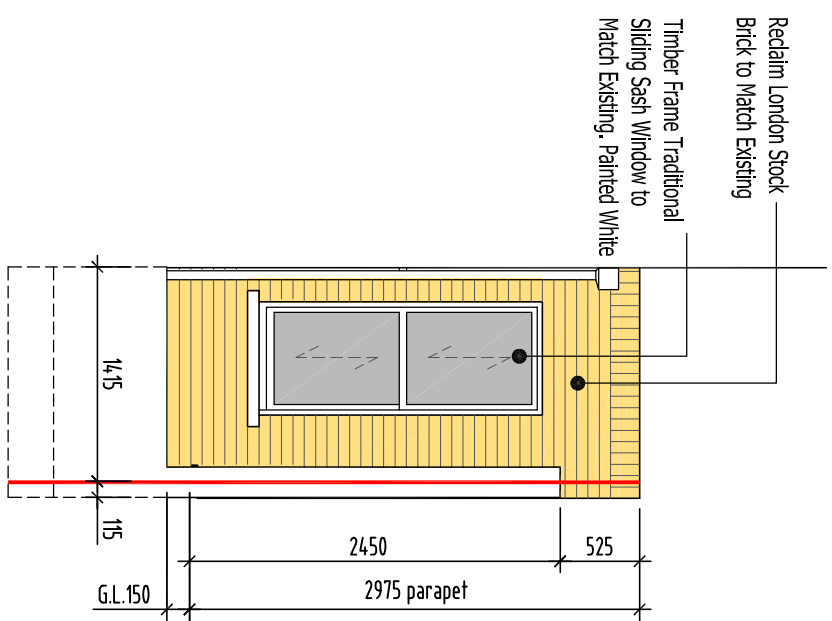

02. Proposed Front Elevation

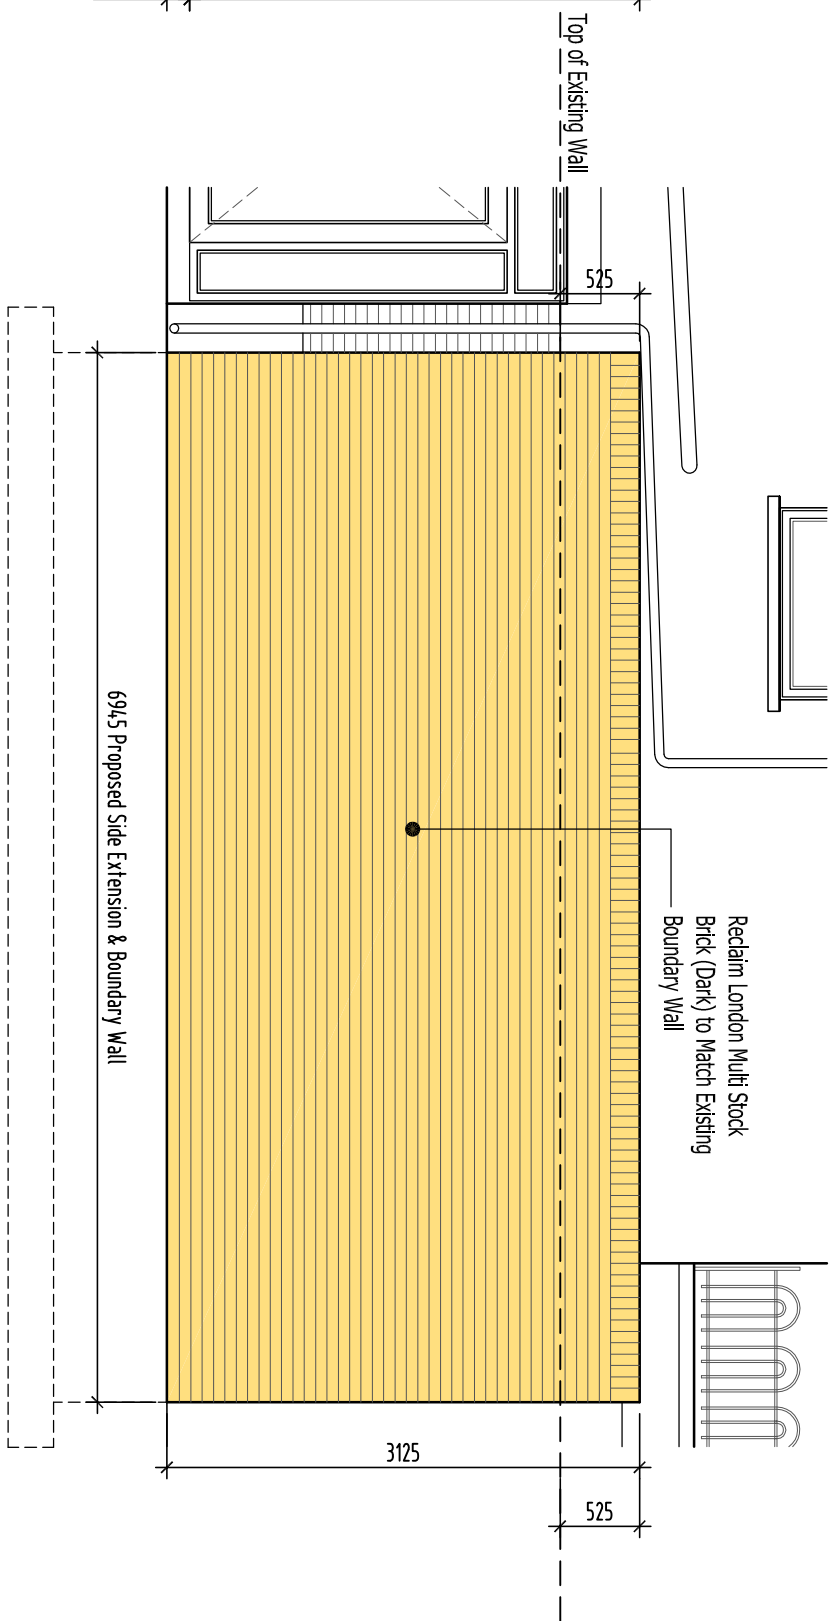

03. Proposed Side Elevation

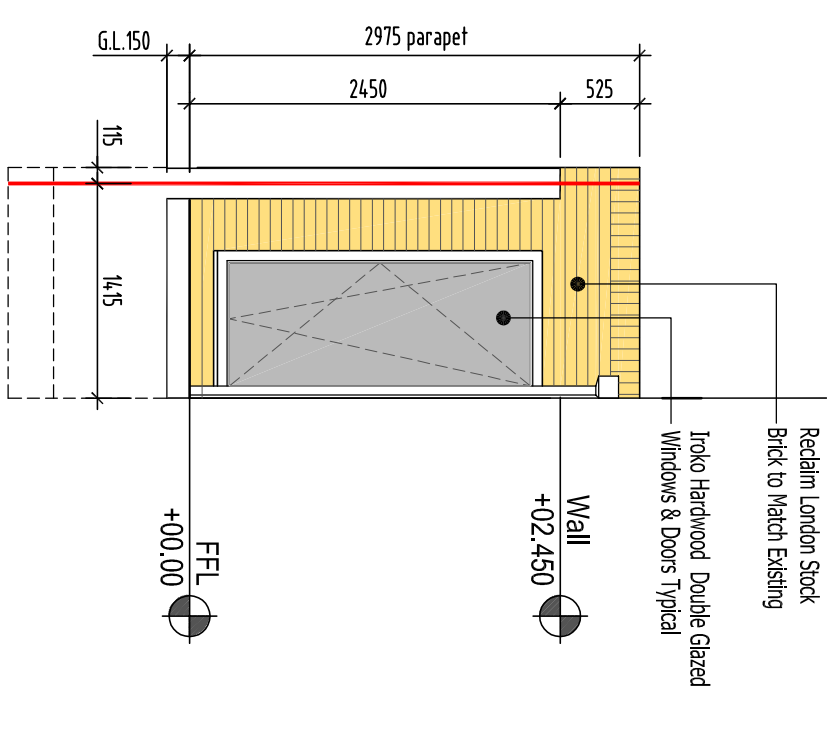

04. Proposed Rear Elevation

NOTES	Rev:	Date:	Note:	Initial:	Rev:	Date:	Note:	Initial:
1. Copyright reserved.	-	18.03.16	Issued for Planning					
2. Work to figured dimensions only. Do not scale drawing.								
3. For Structural, Mechanical & Electrical details, refer to Engineers drawings.								
4. Proprietary items shall be fixed in strict accordance with the Manufacturer's Instructions.								
5. Sizes of proprietary items shall be checked with Manufacturer.								
6. The Contractor is responsible for checking all levels and dimensions on site and shall refer all discrepancies to the Architect.								

Project:	16 102 - Proposed Side Extension to Flat 2, 68 Priory Road, NW6 3RE For Karl Noonan & Sophie Molloy
Drawing Title:	Proposed Plan, Section & Elevation Details
Drawing No.:	16102 - P - 005
Drawn By:	Des Smyth
Rev:	1
Status:	PLANNING
Scale:	1:50 @ A3
Date:	MARCH 2016