

## DOOR SCHEDULE

DOOR REF	LOCATION	DOOR TYPE	STRUCTURAL OPENING	FRAME MATERIAL/TYPE	CLEAR OPENING	DOOR LEAF	FRAME COLOUR	HANDING	WALL THICKNESS (mm)	FIRE RATING	VISION PANEL SIZE	VISION PANEL GLAZING	DOOR MATERIAL	DOOR FINISH	DOOR COLOUR	INTERLOCK	SECURITY RATING	CLOSER	MAG LOCK	FURNITURE		
																				HANDLE	LOCK	
D1	MAIN ENTRANCE TO CORRIDOR	SINGLE	1000 x 2090	ALUMINIUM/KAS	901 x 2035	925 x 2040	WHITE	RIGHT	101	N/A	1250 x 200	CLEAR	GRP	GRP	T.B.C	T.B.C	N/A	YES	TBC	PULL HANDLE/PUSH PLATE	TBC	
D2	CORRIDOR TO RECEIVE/SHIP	SINGLE	1000 x 2090	ALUMINIUM/KAS	901 x 2035	925 x 2040	WHITE	RIGHT	101	30 MINS	1250 x 200	CLEAR	GRP	GRP	T.B.C	T.B.C	N/A	YES	TBC	PULL HANDLE/PUSH PLATE	TBC	
D3	CORRIDOR TO CHANGE 1	SINGLE	1000 x 2090	ALUMINIUM/KAS	901 x 2035	925 x 2040	WHITE	RIGHT	101	30 MINS	1250 x 200	OBSCURED	GRP	GRP	T.B.C	T.B.C	N/A	YES	TBC	PULL HANDLE/PUSH PLATE	TBC	
D4	CHANGE 1 TO CHANGE 2	SINGLE	900 x 2090	ALUMINIUM/KAS	801 x 2035	825 x 2040	WHITE	LEFT	101	N/A	1250 x 200	OBSCURED	GRP	GRP	T.B.C	WITH DOOR 5	N/A	YES	YES	PULL HANDLE/PUSH PLATE	TBC	
D5	CHANGE 2 TO GMP CLEAN ROOM	SINGLE	? x ?	GRP/KMS	CHECK ON SITE	TBC	WHITE	RIGHT	** 595 - CHECK **	N/A	1250 x 200	OBSCURED	GRP	GRP	T.B.C	WITH DOOR 4	N/A	YES	YES	PULL HANDLE/PUSH PLATE	TBC	
D6	CORRIDOR TO OFFICE	SINGLE	1000 x 2090	ALUMINIUM/KAS	901 x 2035	925 x 2040	WHITE	LEFT	101	30 MINS	1250 x 200	CLEAR	GRP	GRP	T.B.C	T.B.C	N/A	YES	TBC	PULL HANDLE/PUSH PLATE	TBC	
D7	CORRIDOR TO Q.C CONTROL ROOM	SINGLE	1000 x 2090	ALUMINIUM/KAS	901 x 2035	925 x 2040	WHITE	RIGHT	101	30 MINS	1250 x 200	CLEAR	GRP	GRP	T.B.C	T.B.C	N/A	YES	TBC	PULL HANDLE/PUSH PLATE	TBC	
D8	STAIR TO 2nd LOBBY	SINGLE	938 x 2085	GRP	787 x ????	834 x ????	WHITE	BI-SWING	101	30 MINS	600 x 200	CLEAR	GRP	GRP	WHITE	N/A	N/A	N/A	N/A	PUSH PLATE TO BOTH SIDES	N/A	
D9	2nd LOBBY TO Q.C CONTROL ROOM	SINGLE	1010 x 2100	STEEL	??? x ????	??? x ????	WHITE	LEFT	BY OTHERS	30 MINS	N/A	N/A	N/A	STEEL	PPC	WHITE	N/A	SR2 (NOT CERTIFIED)	YES	BY OTHERS	LEVER HANDLE	ACCESS CONTROL
D10	OUTSIDE TO MAIN ENTRANCE	SINGLE	1010 x 2400	STEEL	??? x ????	??? x ????	WHITE	LEFT	BY OTHERS	N/A	N/A	N/A	N/A	STEEL	PPC	T.B.C	N/A	SR2 (NOT CERTIFIED)	YES	BY OTHERS	LEVER HANDLE	ACCESS CONTROL
D11	CORRIDOR CUPBOARD	DOUBLE	? x ?	? x ?	? x ?	? x ?	WHITE	DOUBLE	** SITE CHECK **	N/A	N/A	N/A	? x ?	? x ?	T.B.C	T.B.C	N/A	YES	N/A	PULL HANDLE	TBC	
D12	RECEIVE/SHIP TO TECH. MAINTENANCE	SINGLE	1000 x 2090	ALUMINIUM/KAS	901 x 2035	925 x 2040	WHITE	LEFT	101	N/A	1250 x 200	CLEAR	GRP	GRP	T.B.C	T.B.C	N/A	YES	N/A	PULL HANDLE/PUSH PLATE	TBC	
D13	2nd LOBBY TO CLEANER STORE	SINGLE	? x ?	? x ?	? x ?	? x ?	WHITE	RIGHT	** SITE CHECK **	N/A	N/A	N/A	? x ?	? x ?	T.B.C	T.B.C	N/A	YES	N/A	LEVER HANDLE	YES	
ED1	CORRIDOR TO DATA CENTRE PLANT	SINGLE	EXISTING	EXISTING	EXISTING	EXISTING	BY OTHERS	RIGHT	EXISTING	EXISTING	EXISTING	EXISTING	EXISTING	EPOXY PAINT	BY OTHERS	BY OTHERS	BY OTHERS	BY OTHERS	BY OTHERS	BY OTHERS	BY OTHERS	BY OTHERS
ED2	CORRIDOR TO DATA CENTRE	SINGLE	EXISTING	EXISTING	EXISTING	EXISTING	BY OTHERS	RIGHT	EXISTING	EXISTING	EXISTING	EXISTING	EXISTING	EPOXY PAINT	BY OTHERS	BY OTHERS	BY OTHERS	BY OTHERS	BY OTHERS	BY OTHERS	BY OTHERS	BY OTHERS
ED3	DISTRIBUTION BOARD CUPBOARD	DOUBLE	EXISTING	EXISTING	EXISTING	EXISTING	BY OTHERS	DOUBLE	EXISTING	EXISTING	EXISTING	EXISTING	EXISTING	EPOXY PAINT	BY OTHERS	BY OTHERS	BY OTHERS	BY OTHERS	BY OTHERS	BY OTHERS	BY OTHERS	BY OTHERS

## VISION PANEL SCHEDULE


PANEL REF	LOCATION	OPENING SIZE W x H	FRAME COLOUR	WALL THICKNESS	FIRE RATED	GLAZING TYPE
VP-01	RECEIVING/SHIPPING TO OUTSIDE	SITE MEASURE	WHITE STEEL	T.B.A	N/A	CRYSTAL ETCH
VP-02	GMP CLEANROOM TO CORRIDOR	900 x 1000	WHITE STEEL	T.B.A	N/A	CLEAR
VP-03	GMP CLEANROOM TO CORRIDOR	900 x 1000	WHITE STEEL	T.B.A	N/A	CLEAR
VP-04	GMP CLEANROOM TO CORRIDOR	900 x 1000	WHITE STEEL	T.B.A	N/A	CLEAR
VP-05	OFFICE TO OUTSIDE	SITE MEASURE	WHITE STEEL	T.B.A	N/A	CRYSTAL ETCH
VP-06	Q.C ROOM TO OUTSIDE	SITE MEASURE	WHITE STEEL	T.B.A	N/A	CRYSTAL ETCH

## TRANSFER HATCH SCHEDULE

HATCH REF	LOCATION	INTERNAL SIZE W x L x H
PH-01	RECEIVING TO GMP CLEANROOM	450 x 450 x 450
PH-02	RECEIVING TO GMP CLEANROOM	450 x 450 x 600
PH-03	GMP CLEANROOM TO CORRIDOR	450 x 450 x 450
PH-04	GMP CLEANROOM TO CORRIDOR	450 x 450 x 600

### NOTE :-

CRYSTAL ETCH WINDOW FILM APPLIED TO INSIDE FACE OF EXISTING GLAZING & EXTERNAL FACE OF NEW SINGLE GLAZED VISION PANELS VP-01, VP-05 & VP-06. CRYSTAL ETCH FILM APPLIED TO INTERNAL VISION PANELS DURING MANUFACTURE.

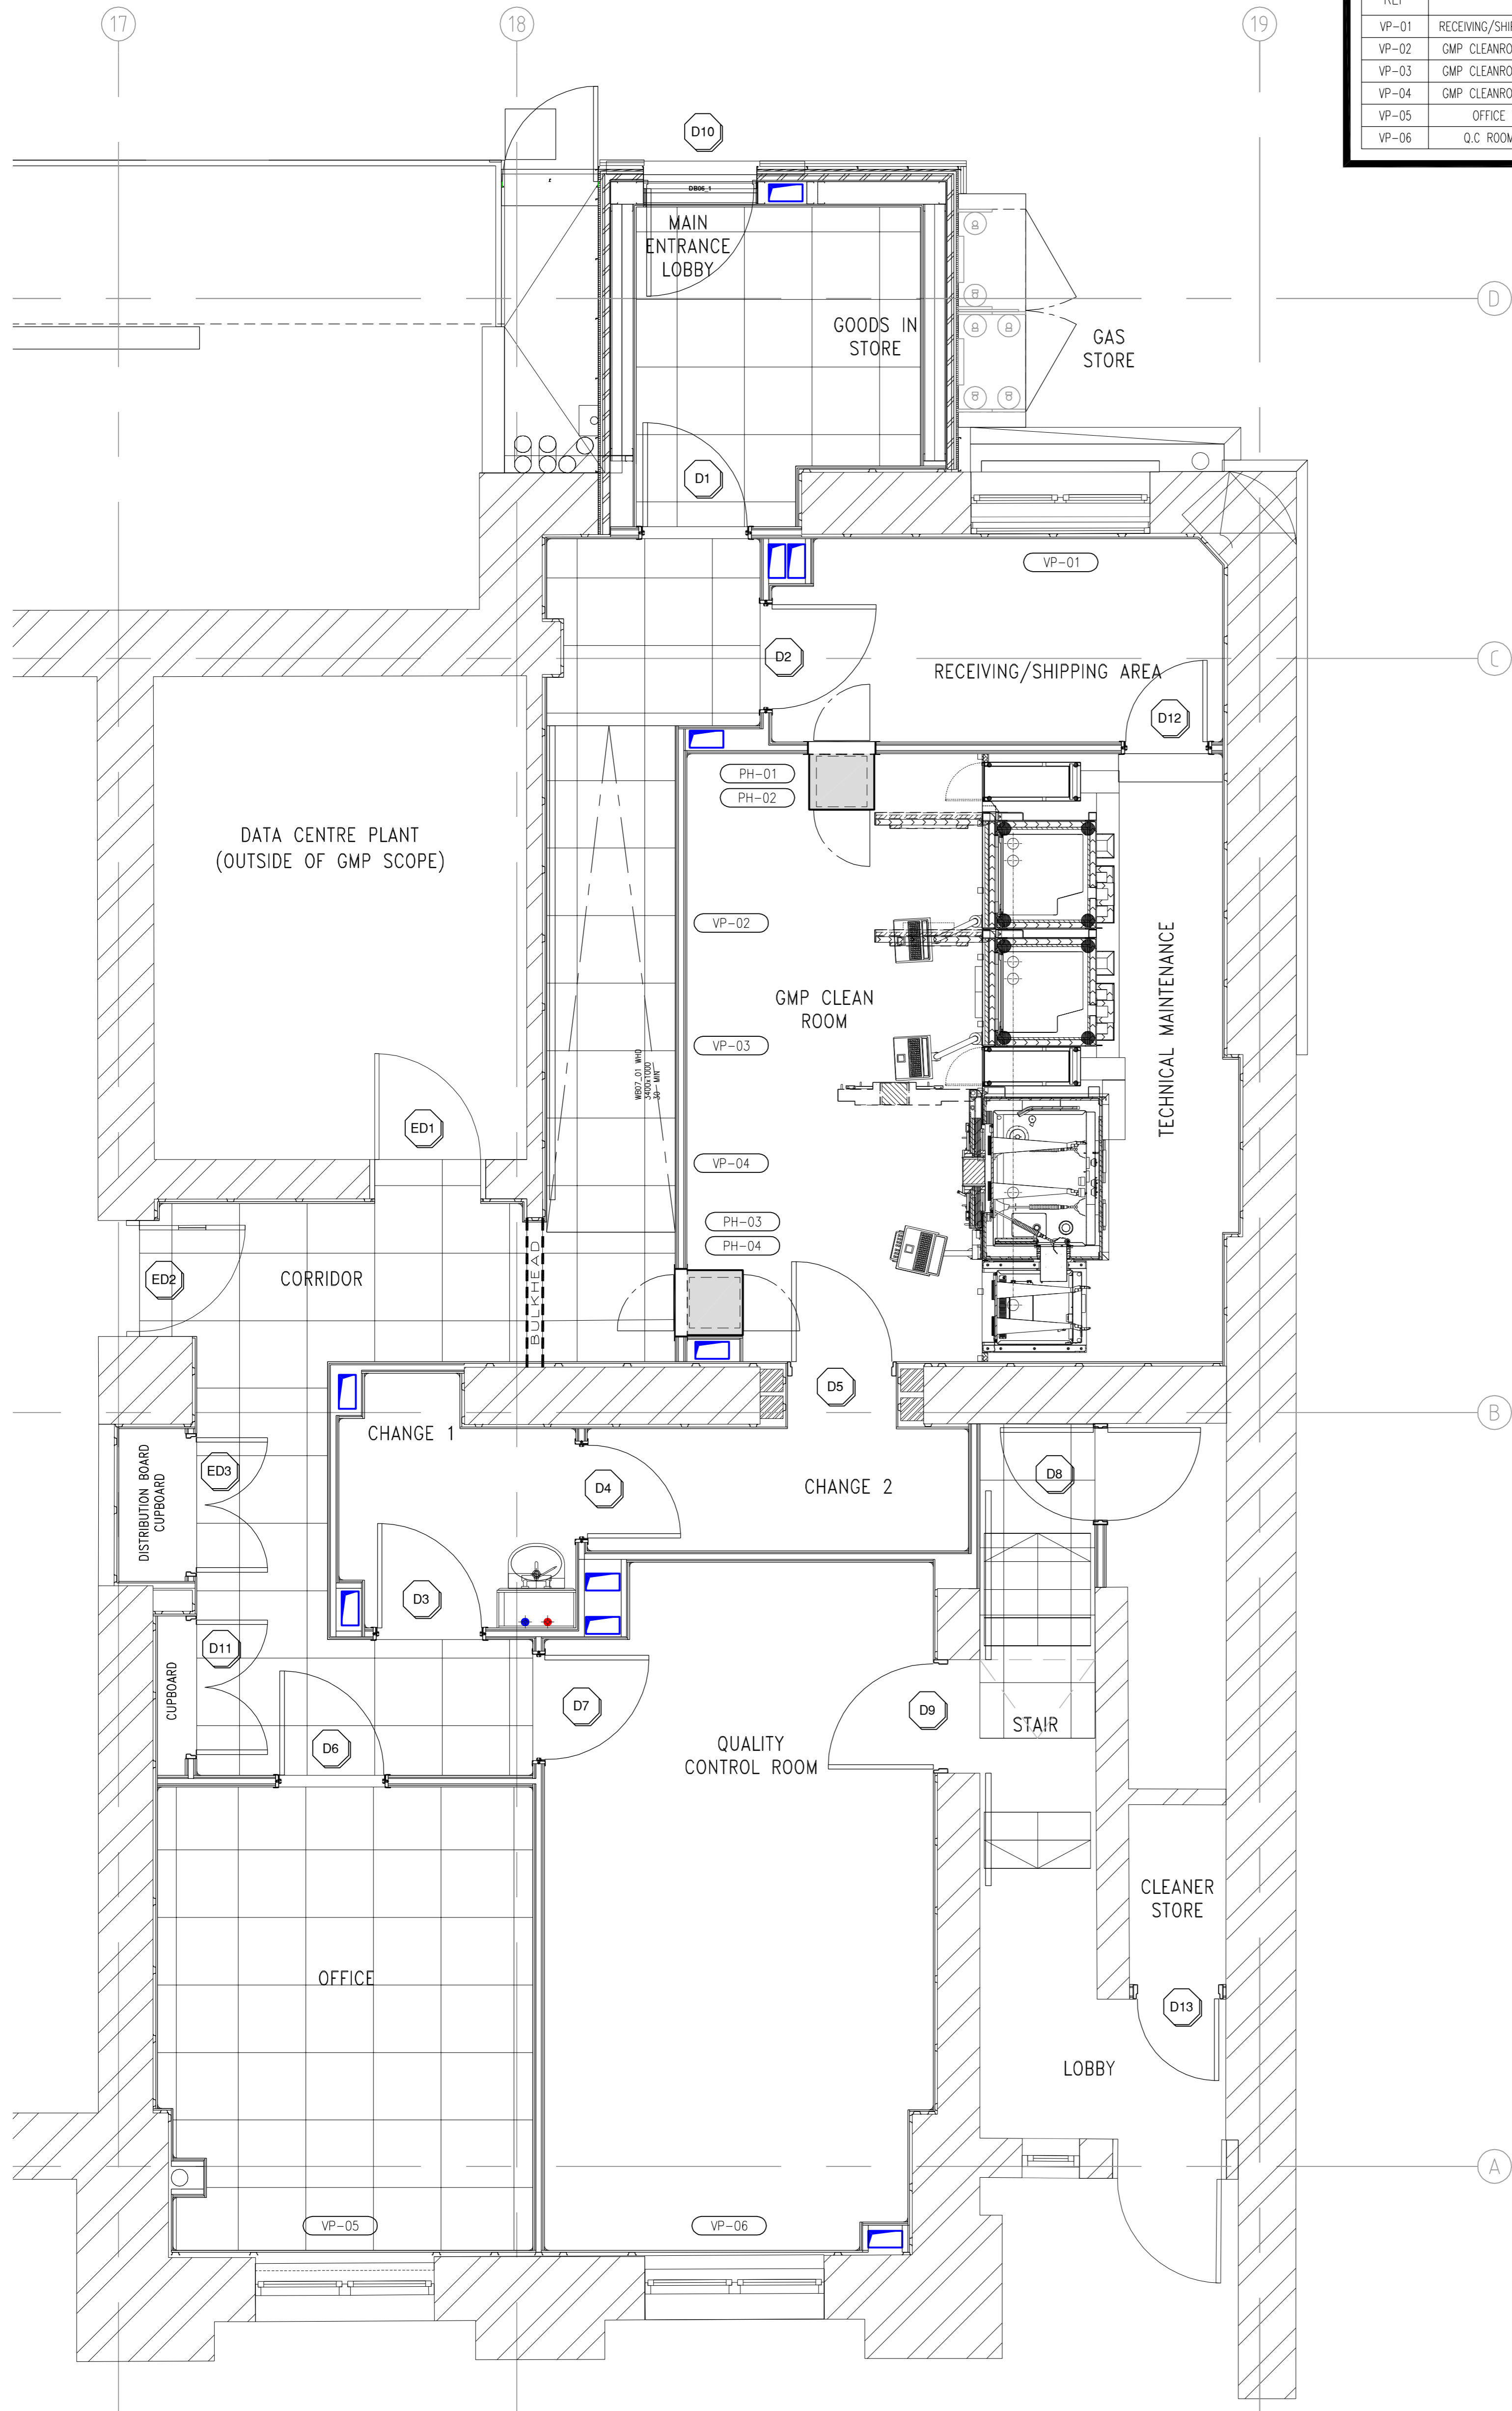

THIS DRG IS TO BE READ IN CONJUNCTION WITH BASSAIRE DRG. Nos.

- MCN1644-C-008 MAIN ENTRANCE WALL PLAN & ELEVATIONS
- MCN1644-D-009 RECEIVING/SHIPPING WALL PLAN & ELEVATIONS
- MCN1644-C-010 CORRIDOR WALL PLAN & ELEVATIONS
- MCN1644-C-011 GMP CLEANROOM WALL PLAN & ELEVATIONS
- MCN1644-C-012 TECHNICAL MAINTENANCE SPACE WALL PLAN & ELEVATIONS
- MCN1644-C-013 CHANGE ROOM 1 WALL PLAN & ELEVATIONS
- MCN1644-C-014 CHANGE ROOM 2 WALL PLAN & ELEVATIONS
- MCN1644-C-015 OFFICE WALL PLAN & ELEVATIONS
- MCN1644-C-016 Q.C LAB WALL PLAN & ELEVATIONS
- MCN1644-C-017 ENTRANCE LOBBY WALL PLAN & ELEVATIONS

P3	REVISED TO SUIT CLIENT COMMENTS	25.04.16	MMc	RS	PA
P2	REVISED TO SUIT CLIENT COMMENTS	14.04.16	MMc	RS	PA
P1	FIRST ISSUE	04.04.16	MMc	RS	PA
REV	AMENDMENT	DATE	DRN	CHKD	APPD

UNIT 31A  
CHADKIRK BUSINESS PARK  
VALE ROAD, ROMILEY  
STOCKPORT, SK6 3NE  
www.bassaire.co.uk  
TEL: (0161) 427 2711  
FAX: (0161) 427 2733

**BASSAIRE**  
IS CLEAN AIR

COPYRIGHT © The details on this drawing are copyright of Bassaire Ltd. This is a confidential document & must not be used, copied or divulged in any way without consent from Bassaire Ltd.

SCALE: **1:33**  
SIZE: **A1**  
DRAWN: **MMc**

CUSTOMER: **UCL**

PROJECT: **GMP LAB  
KATHLEEN LONSDALE BUILDING**

TITLE: **DOOR, VISION PANEL & HATCH DETAILS**

DRG. No. **MCN1644-C-005** REV **P3**