


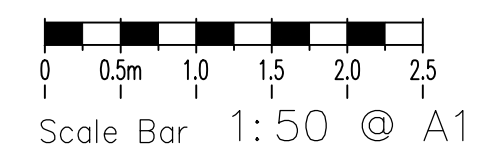

TPS.LLP : 29b Montague Street, London

Tender Issue Drawings

LEGEND



Taylor Project Services



THE
BEDFORD
ESTATES

29a Montague Street
London
WC1B 5BL
Tel: 0171 636 2885
Fax: 0171 255 1729

29B MONTAGUE STREET
LONDON
WC1B 5BL

LOWER GROUND FLOOR HIGH LEVEL ELECTRICAL SERVICES LAYOUT

LEGEND

0	MAY.16	TENDER ISSUE
Rev	Date	Description

No.1 Cornhill
London EC3V 3ND
Tel 020 7743 6602 Fax 020 7743 6603 Mobile 07778 667683



9a Montague Street
London
WC1B 5BL
Tel: 0171 636 2885
Fax: 0171 258 1729

GROUND FLOOR HIGH LEVEL ELECTRICAL SERVICES LAYOUT

Drawing No. TPS/29B/E/HL/G

LEGEND

	SWITCHED SOCKET OUTLET
	DATA SOCKET - BLANK PLATE
	GALVANISED SKIRTING TRUNKING

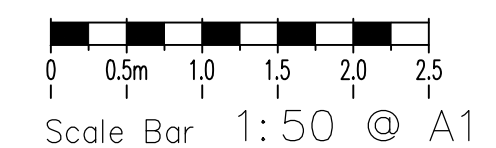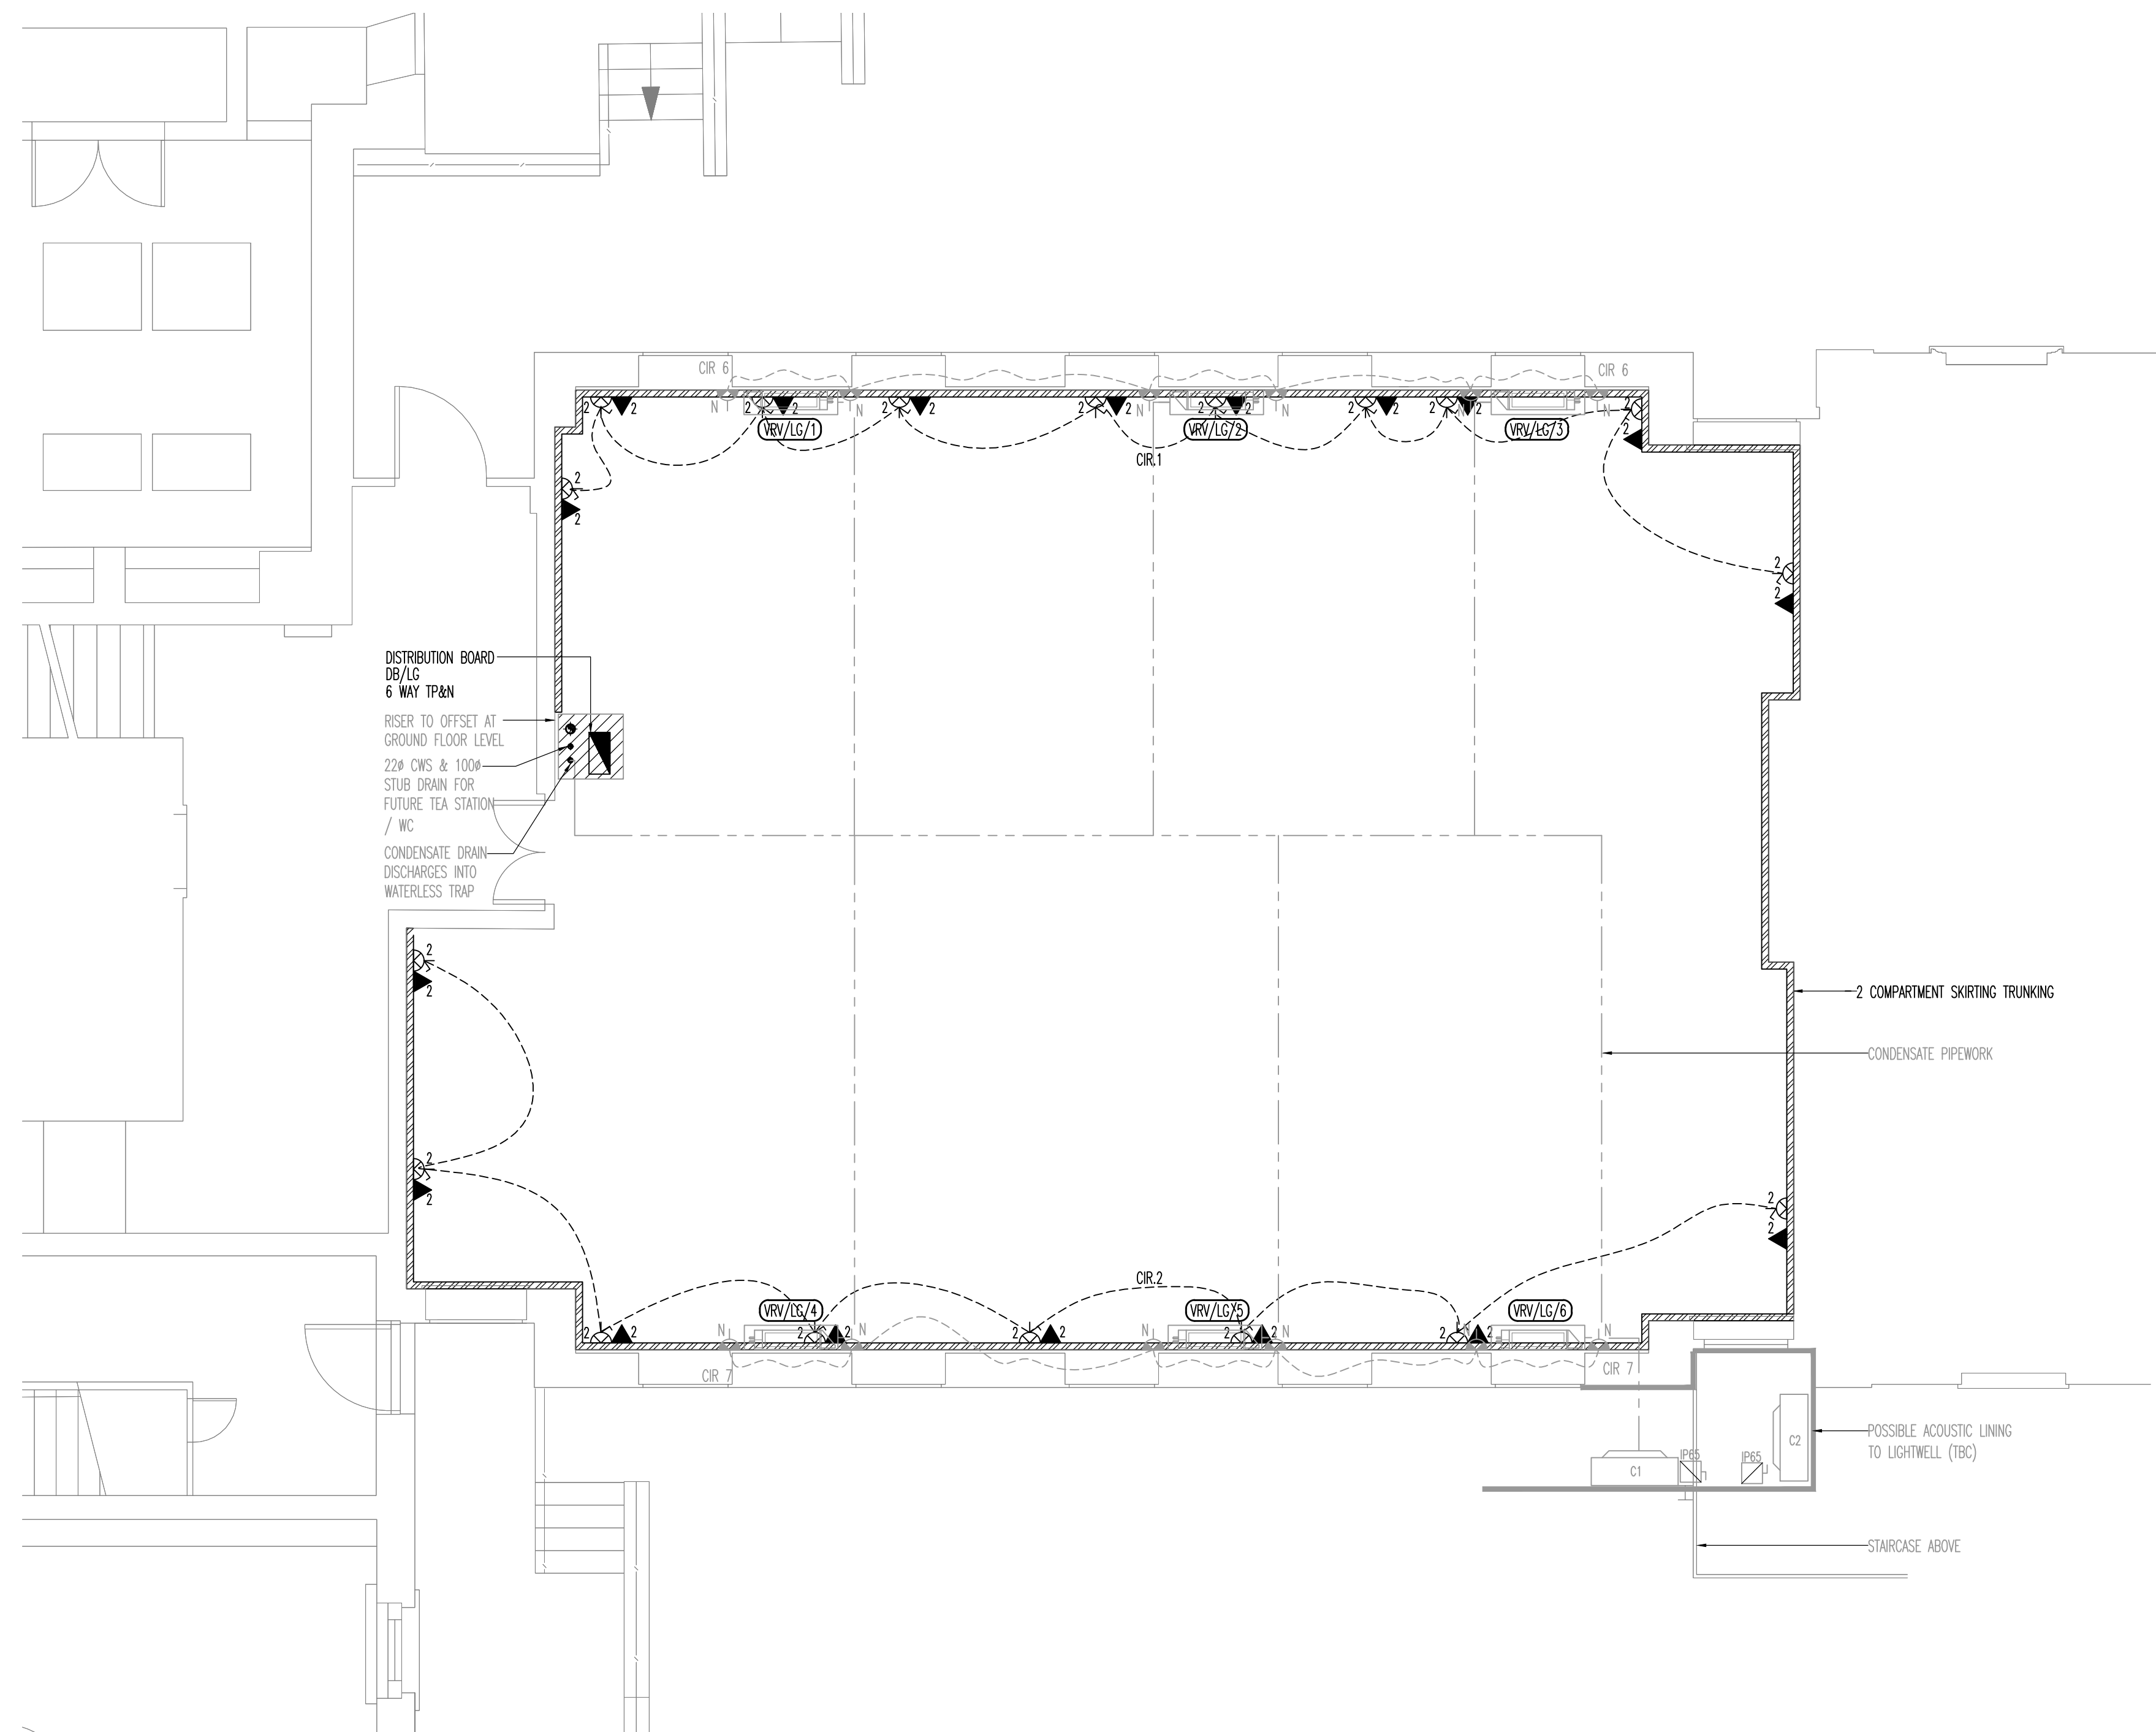

0	MAY.16	TENDER ISSUE
Rev	Date	Description

No.1 Cornhill
London EC3V 3ND
Tel 020 7743 6602 Fax 020 7743 6603 Mobile 07778 667683

Client

 THE
BEDFORD
ESTATES

29a Montague Street
London
WC1B 5BL
Tel: 0171 636 2885
Fax: 0171 255 1729

Drawing Title



LOWER GROUND FLOOR
LOW LEVEL
SMALL POWER
LAYOUT

Drawing Status	TENDER
----------------	--------

Revision	0									
Drawing No.	TPS/29B/E/LL/LG									

LEGEND

- | | |
|---|------------------------------|
|  | SWITCHED SOCKET OUTLET |
|  | DATA SOCKET - BLANK PLATE |
|  | GALVANISED SKIRTING TRUNKING |

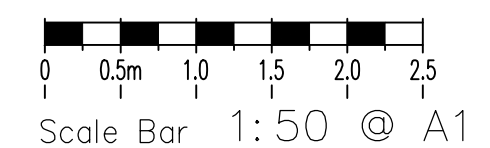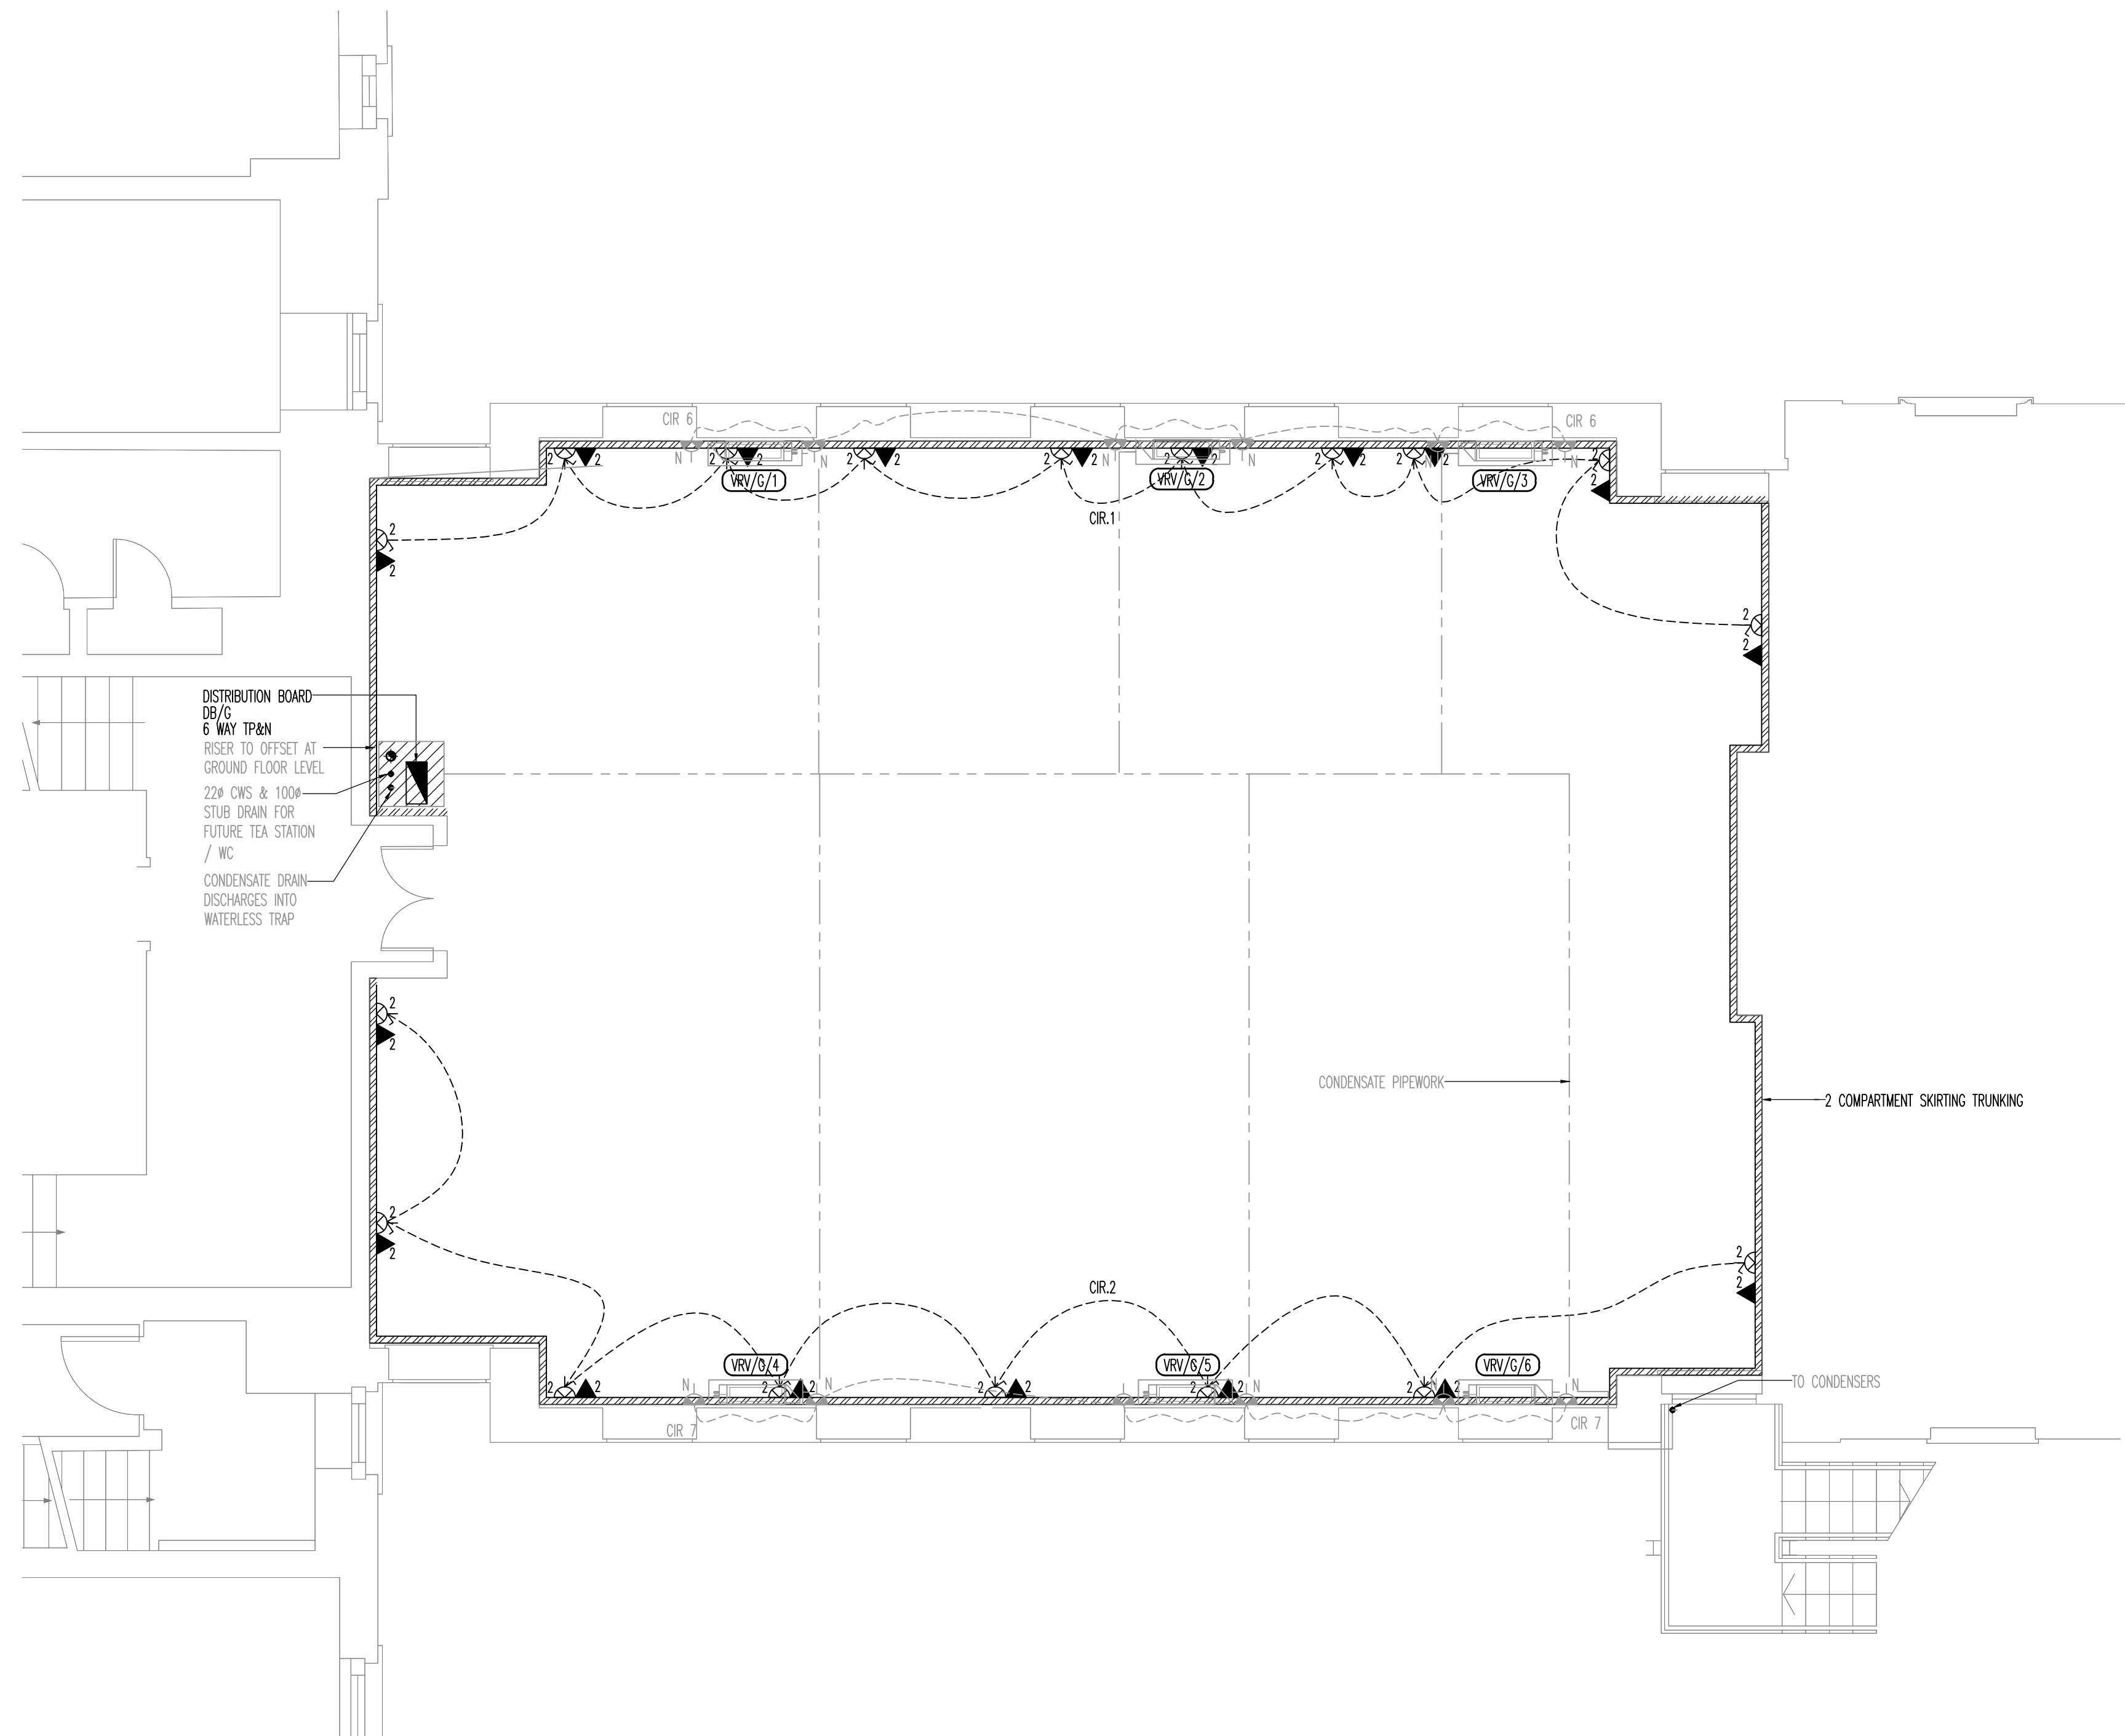

0	MAY.16	TENDER ISSUE
Rev	Date	Description

TPS
Taylor Project Services

No.1 Cornhill
London EC3V 3ND
Tel 020 7743 6602 Fax 020 7743 6603 Mobile 07778 667683

Client



THE
BEDFORD
ESTATES

Montague Street
London
WC1B 5BL
Tel: 0171 636 2885
Fax: 0171 258 1729

Project

29B MONTAGUE STREET
LONDON
WC1B 5BL

Drawing Title

GROUND FLOOR
LOW LEVEL
SMALL POWER
LAYOUT

Scale	1:50	Date	04.05.16
-------	------	------	----------

Drawn L.R.	Checked G.N.T.
------------	----------------


Drawing Status TENDER

[illegible]

Drawing No. TPS/29B/E/LL/G

GENERAL NOTES

1. FINAL LOCATION/POSITION OF PIPEWORK AND ASSOCIATED ROUTING TO BE AGREED ON SITE.
2. HEATING RADIATORS TO BE ISOLATED AND REMOVED AS NECESSARY.
3. FINAL LAYOUTS TO BE DETERMINED IN CONJUNCTION WITH CURRENT SPACE PLANNING.

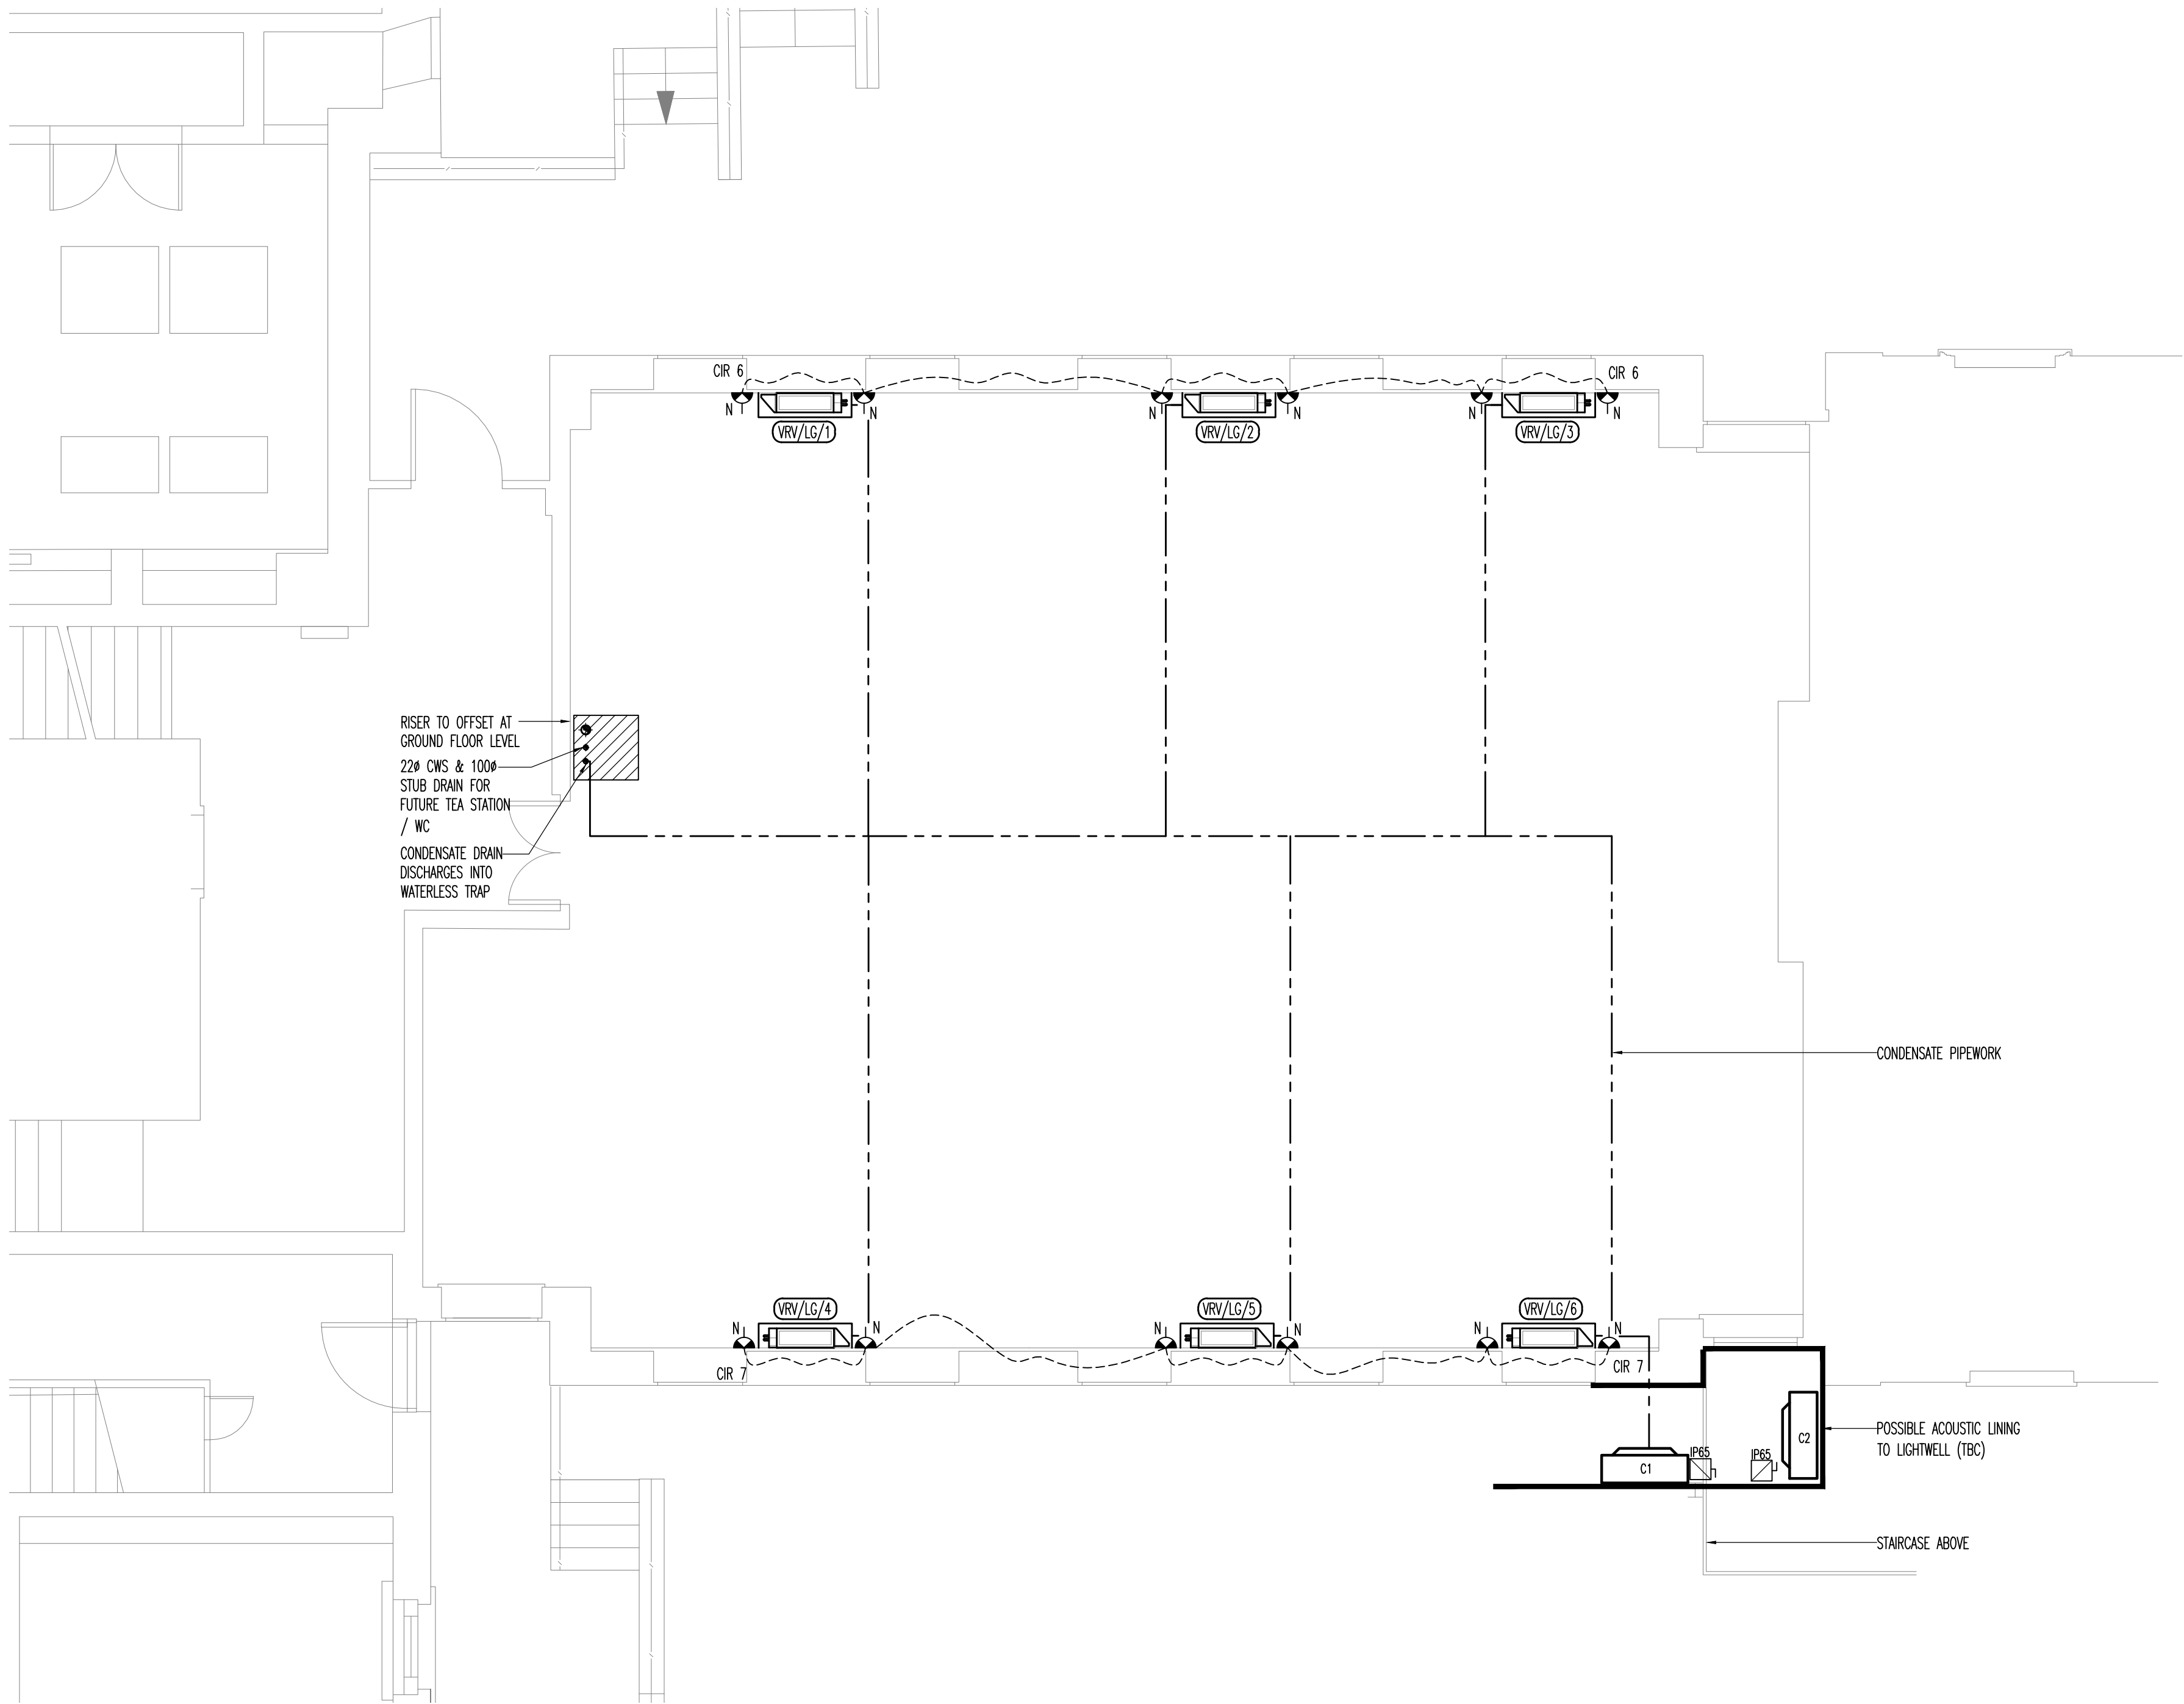

TENDER ISSUE

0	MAY.16	TENDER ISSUE
Rev	Date	Description

TPS

Taylor Project Services

No.1 Cornhill
London EC3V 3ND
Tel 020 7743 6602 Fax 020 7743 6603 Mobile 07776 667683

Client

THE BEDFORD ESTATES

29a Montague Street
London
WC1B 5BL
Tel 0171 636 2888
Fax 0171 255 1729

Project

29B MONTAGUE STREET
LONDON
WC1B 5BL

Drawing Title

LOWER GROUND FLOOR
VRV LAYOUT

Scale	1:50	Date	04.05.16
Drawn	L.R.	Checked	G.N.T.

Drawing Status


TENDER

Revision	0																		
----------	---	--	--	--	--	--	--	--	--	--	--	--	--	--	--	--	--	--	--

Drawing No.

TPS/29B/M/LG

1. FINAL LOCATION/POSITION OF PIPEWORK AND ASSOCIATED ROUTING TO BE AGREED ON SITE.
2. HEATING RADIATORS TO BE ISOLATED AND REMOVED AS NECESSARY.
3. FINAL LAYOUTS TO BE DETERMINED IN CONJUNCTION WITH CURRENT SPACE PLANNING.

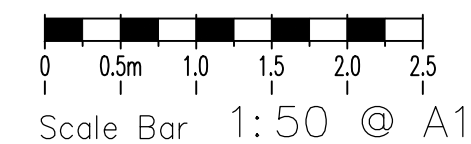

0	MAY.16	TENDER ISSUE
Rev	Date	Description

No.1 Cornhill
London EC3V 3ND
Tel 020 7743 6602 Fax 020 7743 6603 Mobile 07778 667683


9a Montague Street
London
WC1B 5BL
Tel: 0171 636 2885
Fax: 0171 255 1729

29B MONTAGUE STREET
LONDON
WC1B 5BL

GROUND FLOOR VRV LAYOUT

Drawing No. TPS/29B/M/G

1. FINAL LOCATION/POSITION OF PIPEWORK AND ASSOCIATED ROUTING TO BE AGREED ON SITE.
2. HEATING RADIATORS TO BE ISOLATED AND REMOVED AS NECESSARY.
3. FINAL LAYOUTS TO BE DETERMINED IN CONJUNCTION WITH CURRENT SPACE PLANNING.

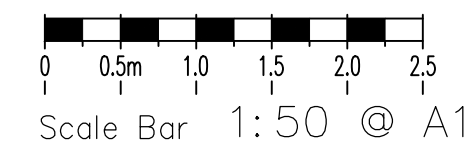

0	MAY.16	TENDER ISSUE
Rev	Date	Description

No.1 Cornhill
London EC3V 3ND
Tel 020 7743 6602 Fax 020 7743 6603 Mobile 07778 667683


9a Montague Street
London
WC1B 5BL
Tel: 0171 636 2885
Fax: 0171 255 1729

GROUND FLOOR
HEATING LAYOUT (OPTION)

TENDER

TPS/29B/MH/G

1. FINAL LOCATION/POSITION OF PIPEWORK AND ASSOCIATED ROUTING TO BE AGREED ON SITE.
2. HEATING RADIATORS TO BE ISOLATED AND REMOVED AS NECESSARY.
3. FINAL LAYOUTS TO BE DETERMINED IN CONJUNCTION WITH CURRENT SPACE PLANNING.

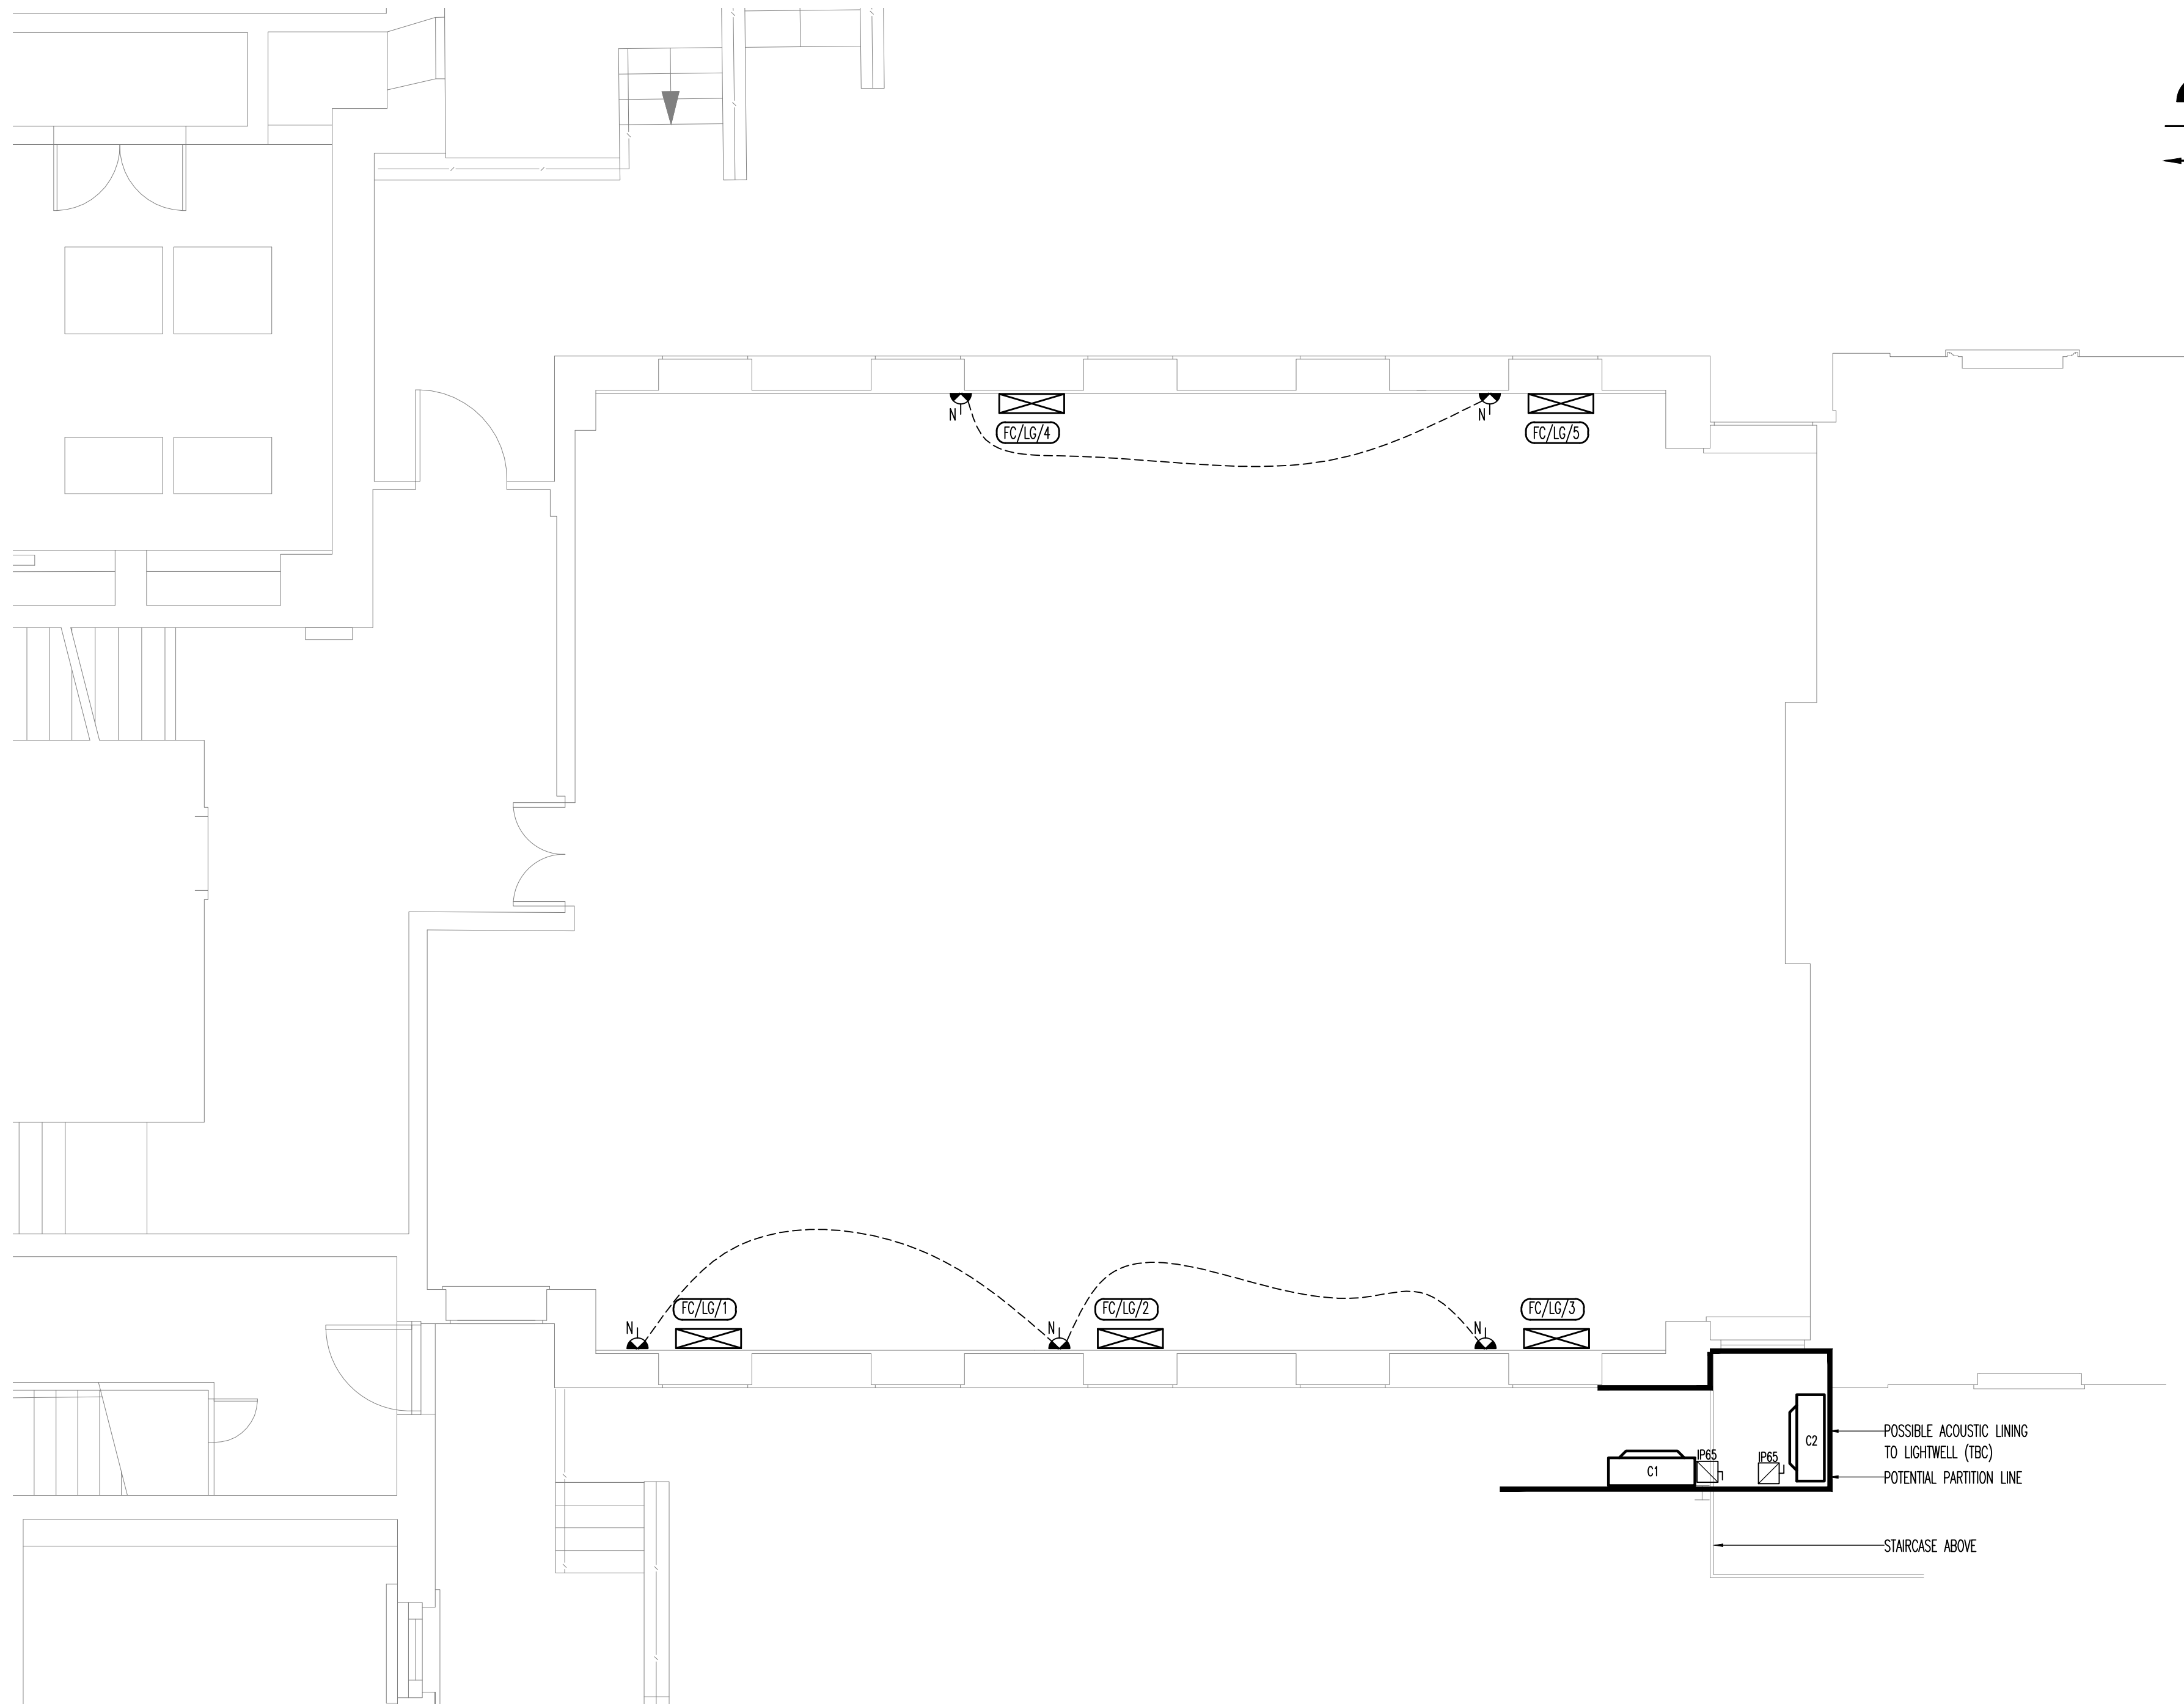

TPS

Taylor Project Services

No.1 Cornhill
London EC3V 3ND
Tel 020 7743 6602 Fax 020 7743 6603 Mobile 07778 667683

Project


29B MONTAGUE STREET
LONDON
WC1B 5BL

Scale	1:50	Date	04.05.16
Drawn	L.R.	Checked	G.N.T.


Revision	0								
----------	---	--	--	--	--	--	--	--	--

Drawing No. TPS/29B/MH/LG


GENERAL NOTES

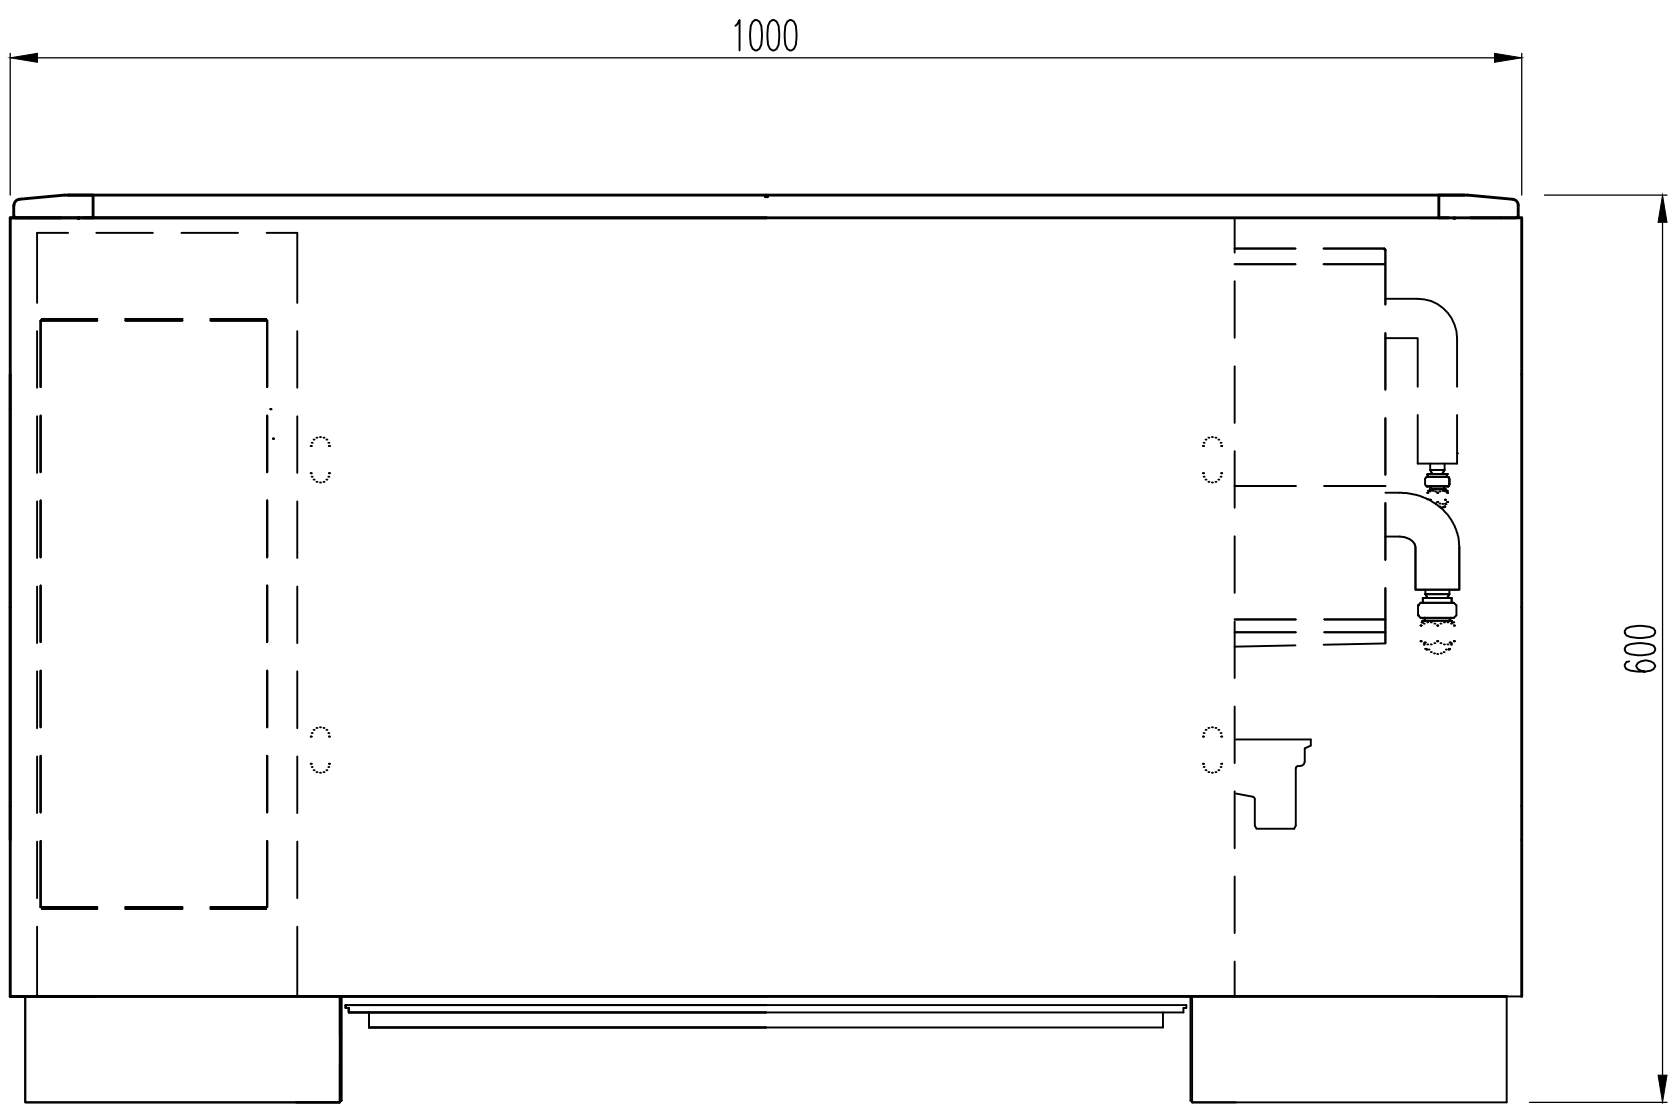

FRONT VIEW

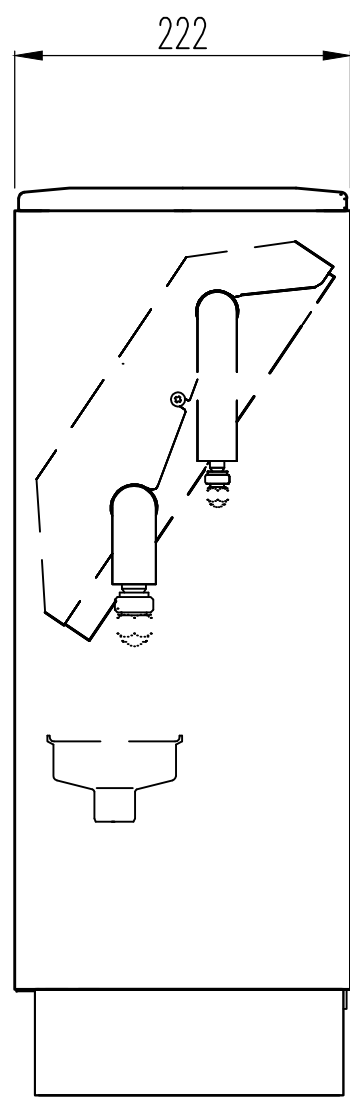

SECTION

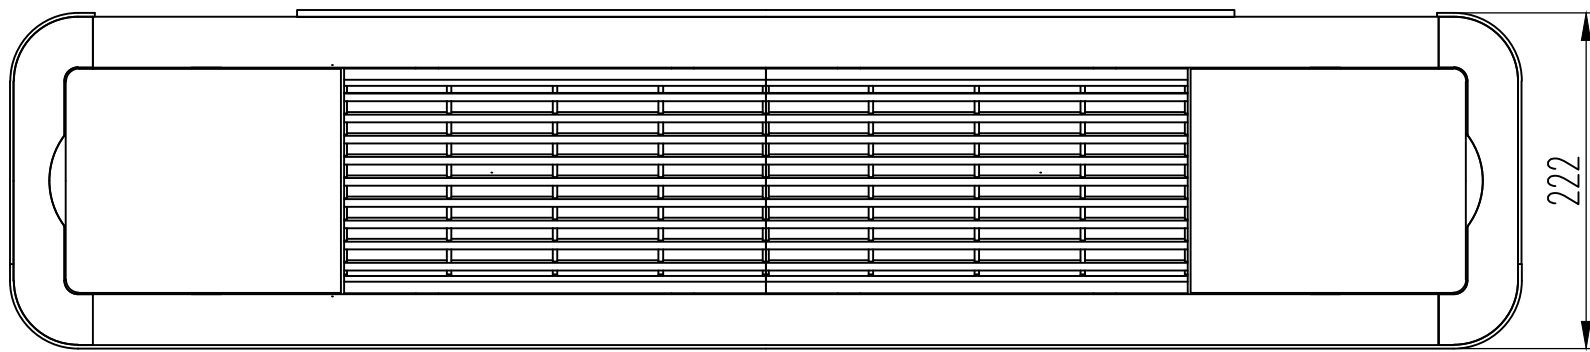

PLAN

TENDER ISSUE		
0	MAY.16	TENDER ISSUE
Rev	Date	Description
TPS Taylor Project Services No.1 Cornhill London EC3V 3ND Tel 020 7743 6602 Fax 020 7743 6603 Mobile 07778 667683		
Client THE BEDFORD ESTATES 29a Montague Street London WC1B 5BL Tel: 0171 636 2888 Fax: 0171 255 1729		
Project 29B MONTAGUE STREET LONDON WC1B 5BL		
Drawing Title VRV CASING DETAIL		
Scale 1:5		Date 04.05.16
Drawn R.J.L.		Checked G.N.T.
Drawing Status TENDER		
Revision 0		
Drawing No. TPS/29B/M&E/1		