


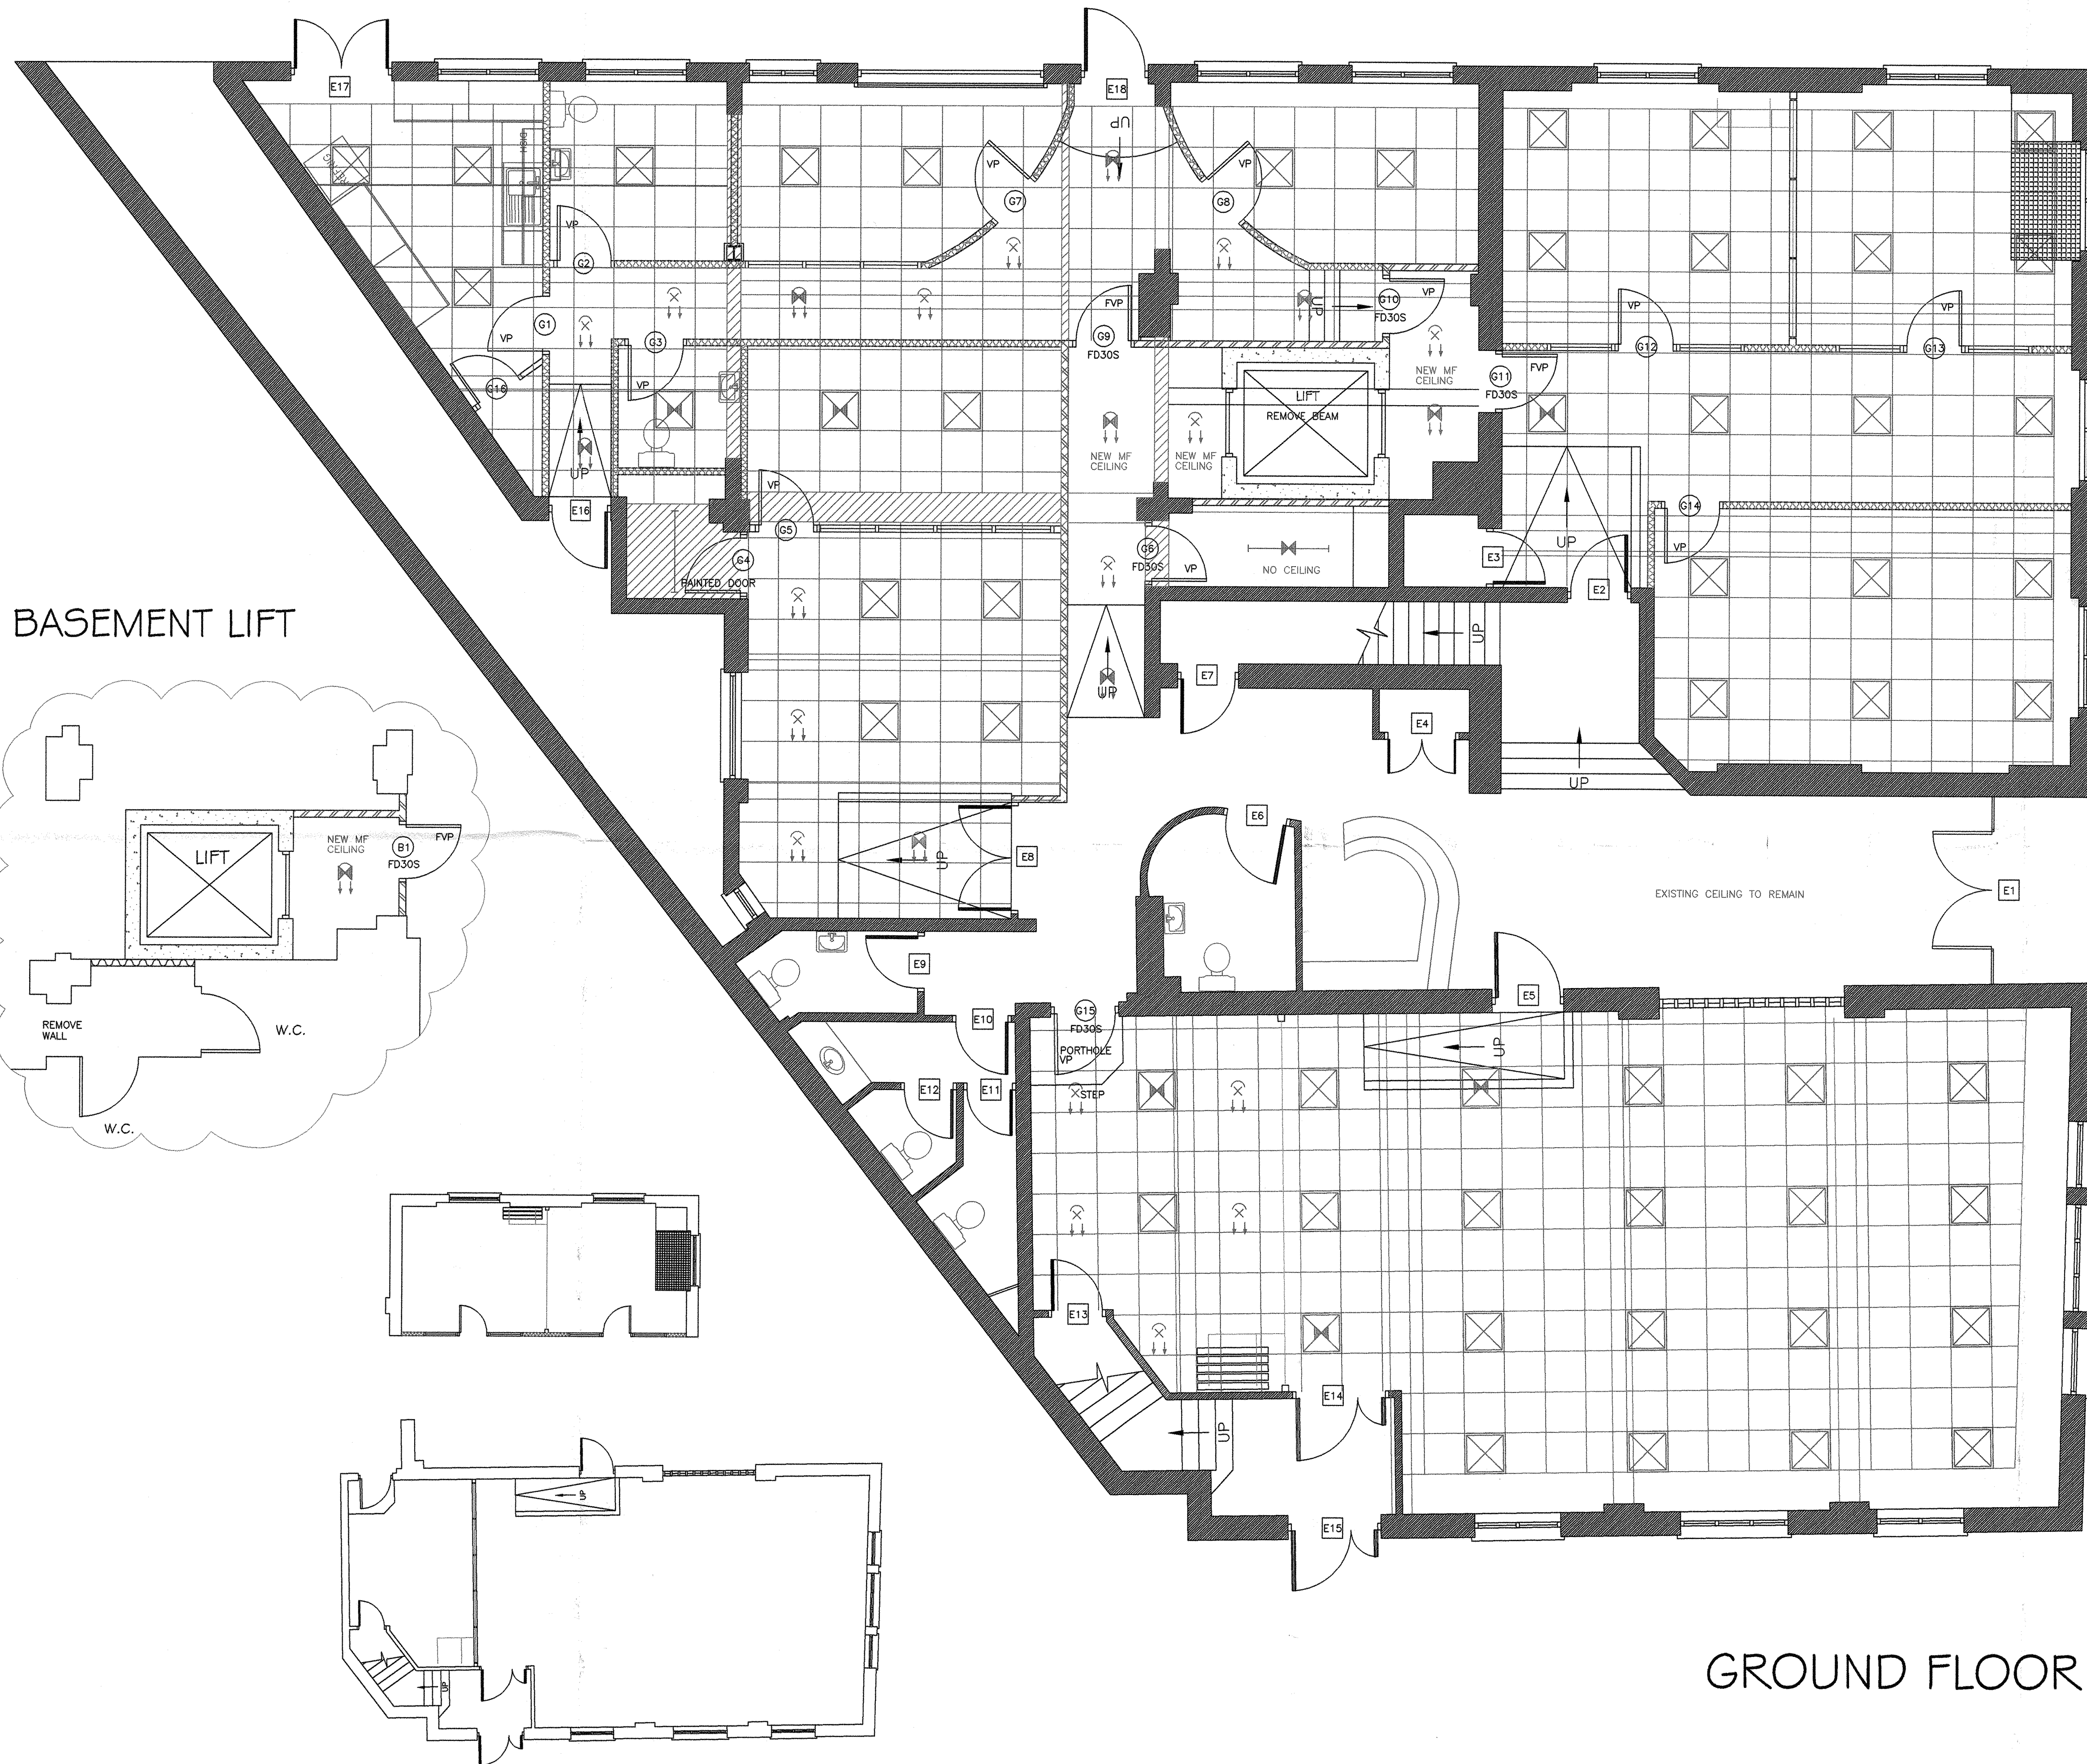

- KEY:
- NEW DOOR HEAD HEIGHT GLAZED PARTITION (KOMFIRE 100)
 - NEW SOLID PARTITION (KOMFIRE 100)
 - NEW SOUND RATED SOLID PARTITION (KOMFIRE 100)
 - NEW HALF HOUR FIRE RATED SOLID PARTITION (KOMFIRE 100)
 - NEW DOOR
 - EXISTING DOOR
 - BEAM ABOVE CEILING LEVEL
 - BEAM BELOW CEILING LEVEL
 - NEW 600mm x 600mm VIVID WHITE CEILING GRID WITH LAY-IN MINERAL FIBRE TILES
 - RELOCATED SURFACE MOUNTED SINGLE TUBE LUMINAIRE FITTING
 - NEW 1200mm x 600mm 4 TUBE LUMINAIRE FITTING
 - NEW 600mm x 600mm 4 TUBE LUMINAIRE FITTING
 - LUMINAIRE FITTING INSTALLED WITH EMERGENCY POWER BACKUP
 - NEW 18W COMPACT DOWN LIGHTER
 - NEW RUNNING MAN FIRE EXIT SIGNAGE
 - FREE ISSUE 3 COMPARTMENT FLOOR BOX TO CONTAIN 1 DOUBLE SWITCHED SOCKET OUTLET AND 4 NETWORK POINTS
 - FREE ISSUE 3 COMPARTMENT FLOOR BOX TO CONTAIN 2 DOUBLE SWITCHED SOCKET OUTLETS AND 4 NETWORK POINTS
 - NEW TELEPHONE/ DATA NETWORK POINT
 - EXISTING TELEPHONE/ DATA NETWORK POINT
 - NEW DOUBLE SWITCHED SOCKET OUTLET
 - EXISTING DOUBLE SWITCHED SOCKET OUTLET
 - NEW SINGLE SWITCHED SOCKET OUTLET
 - EXISTING SINGLE SWITCHED SOCKET OUTLET
 - NEW LIGHT SWITCH
 - EXISTING LIGHT SWITCH
 - NEW SWITCHED SPUR
 - FIRE ALARM BELL
 - SMOKE DETECTOR
 - FIRE ALARM CALL POINT

REV	DESCRIPTION	DATE
1	ADDITIONAL DOOR INTO CHAMBER ROOM	28/10/02
2	TOTAL REDRAW	17/12/02
3	REVISED POWER LAYOUT/INCLUDED W.C.	14/01/03
4	INCLUDED HIDDEN BEAMS	17/01/03
5	ENLARGED TABLE SIZES/OPTIONAL LAYOUTS	23/01/03
6	INCLUDED DOOR NOTES	27/01/03

This drawing is a copyright and must not be reproduced or copied partially or wholly without written permission.

CLIENT: GCC
 SITE: GROUND FLOOR, 44 WICKLOW STREET, LONDON WC1
 DESCRIPTION: PROPOSED CEILING LAYOUT

Date: 19/09/02
 Scale: 1:50
 Drg. no. A3442GC
 Survey data by Ralco

Rev 6

Ralco Projects Limited
 Fennels Lodge,
 St Peter's Close,
 Loudwater,
 High Wycombe,
 BUCKS. HP11 1JT
 Tel: 01628 529696

ralco
 PROJECTS LIMITED
 Interior Designers and Contractors.

GROUND FLOOR