

Project Name - Kings Cross T1 Service Road

Detail - Exterior Lighting

Scheme Number - 5910 / 2

Date - 25.04.16

Perpared By - Katy Smith

Contact Name - Eddie Mackie


Customer -

Contact -

Tel -

Email -



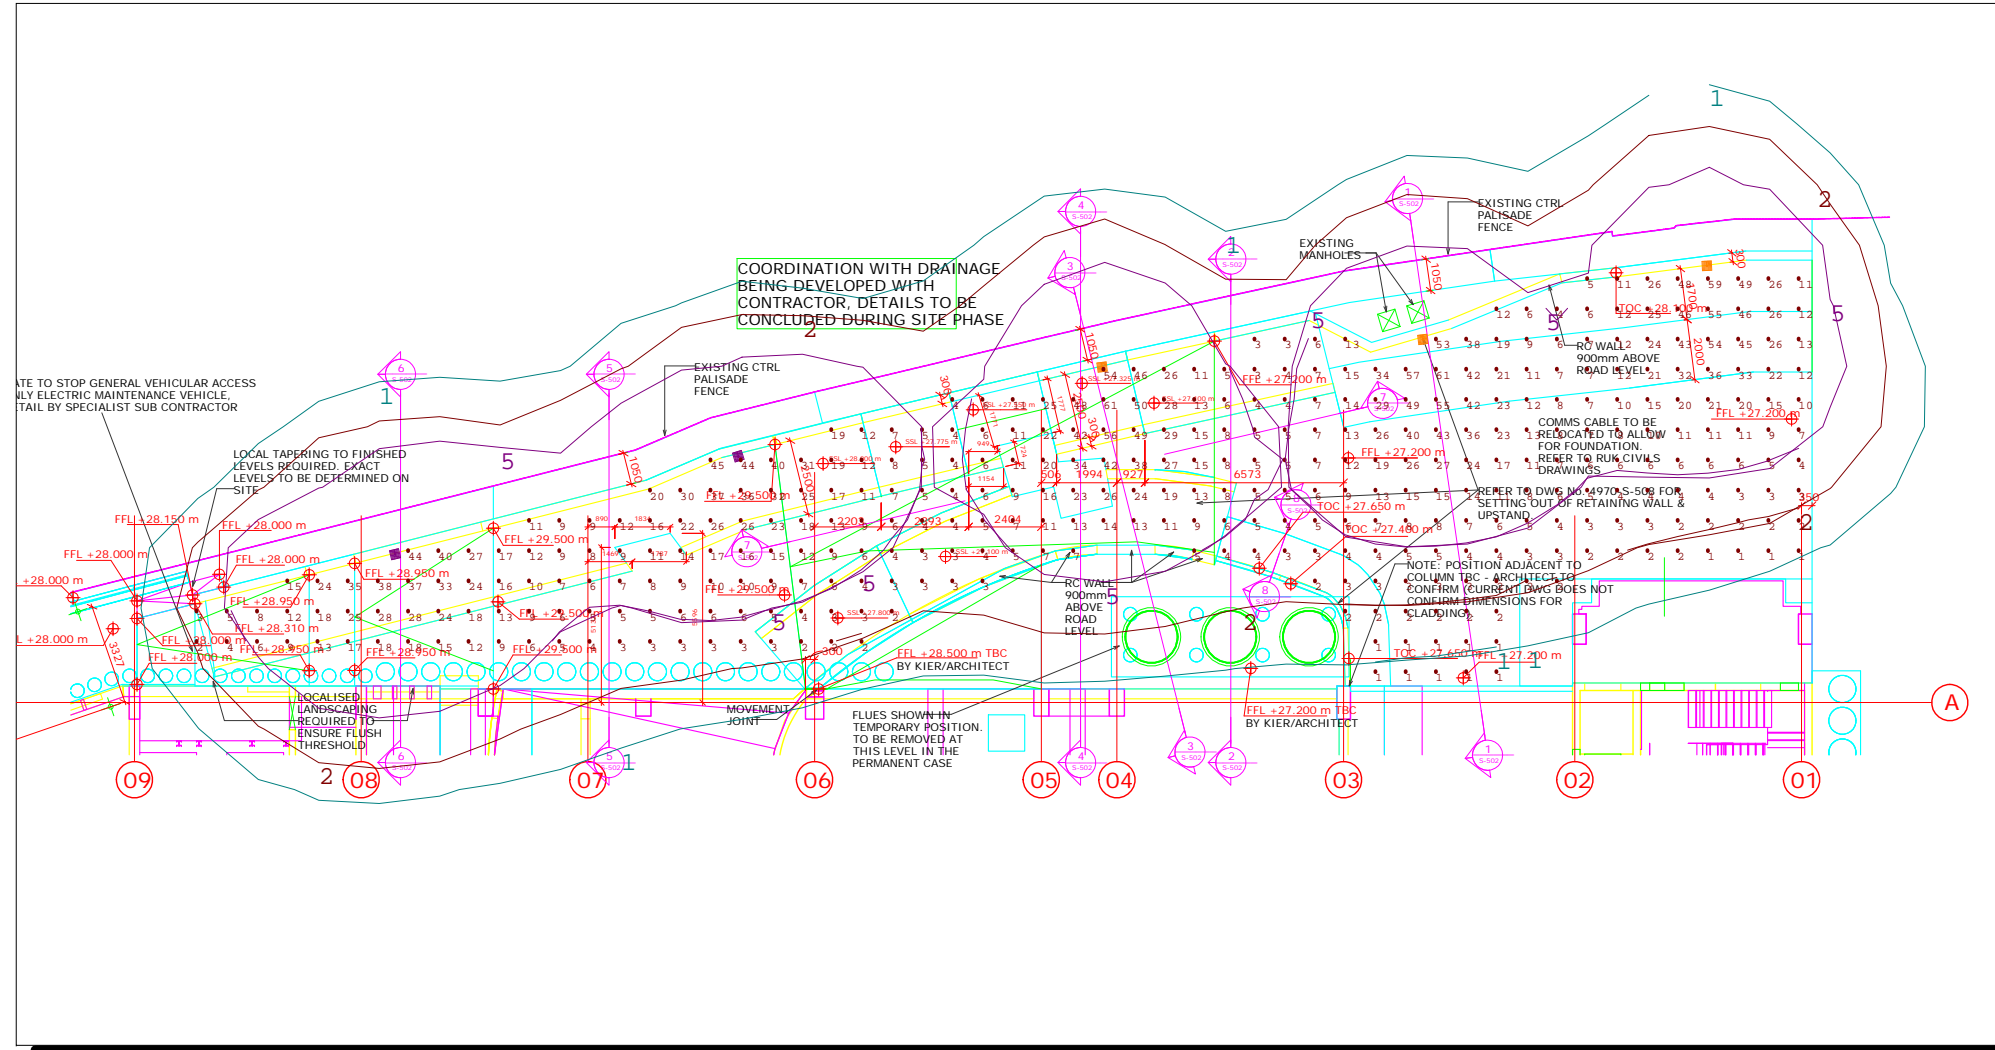

OLV334

Luminaire Schedule						
Symbol	Qty	Label	Total Lamp	Dimensions	Description	Height
	3	D	N.A.	0.800	WE-EF OLV334 [A60.3K] 12LED 24W (132-0540)	2.6m
	2	E	N.A.	0.800	WE-EF OLV334 [R65.3K] 12LED 24W (132-0538)	2.6m

Calculation Summary					
Label	Avg	Max	Min	Min/Avg	Min/Max
Iso Lines	3.63	59	0	N.A.	N.A.
Road	13.85	61	1	0.07	0.02

Notes:
 - Grid values in Lux
 - Grid intervals: 1m
 - Contour values in Lux
 - Contour intervals: 1, 2 & 5 Lux

Drawing Title:	Kings Cross T1 Service Road		
Drawing Number:	5910 / 2		
Customer:			
Designed By:	Katy Smith		
Date:	25.04.16	Scale:	1:250 @ A3



WE-EF LIGHTING Ltd
 Suite 2C
 East Bridgford
 Business Park
 Kneeton Road
 East Bridgford
 Nottingham
 NG13 8PJ
 Tel: 0844 880 5346
 Fax: 0844 880 5347
 e-mail: info.uk@we-ef.