




① tv-toilet vent, ② wt-water tank, ③ sw-stairwell, ④ old daikin air-source heat pumps, ⑤ new daikin rzqg-18/7v1 air-source heat pump, ⑥ new daikin ryyq-t centralised group layout air-source heat pumps x 4

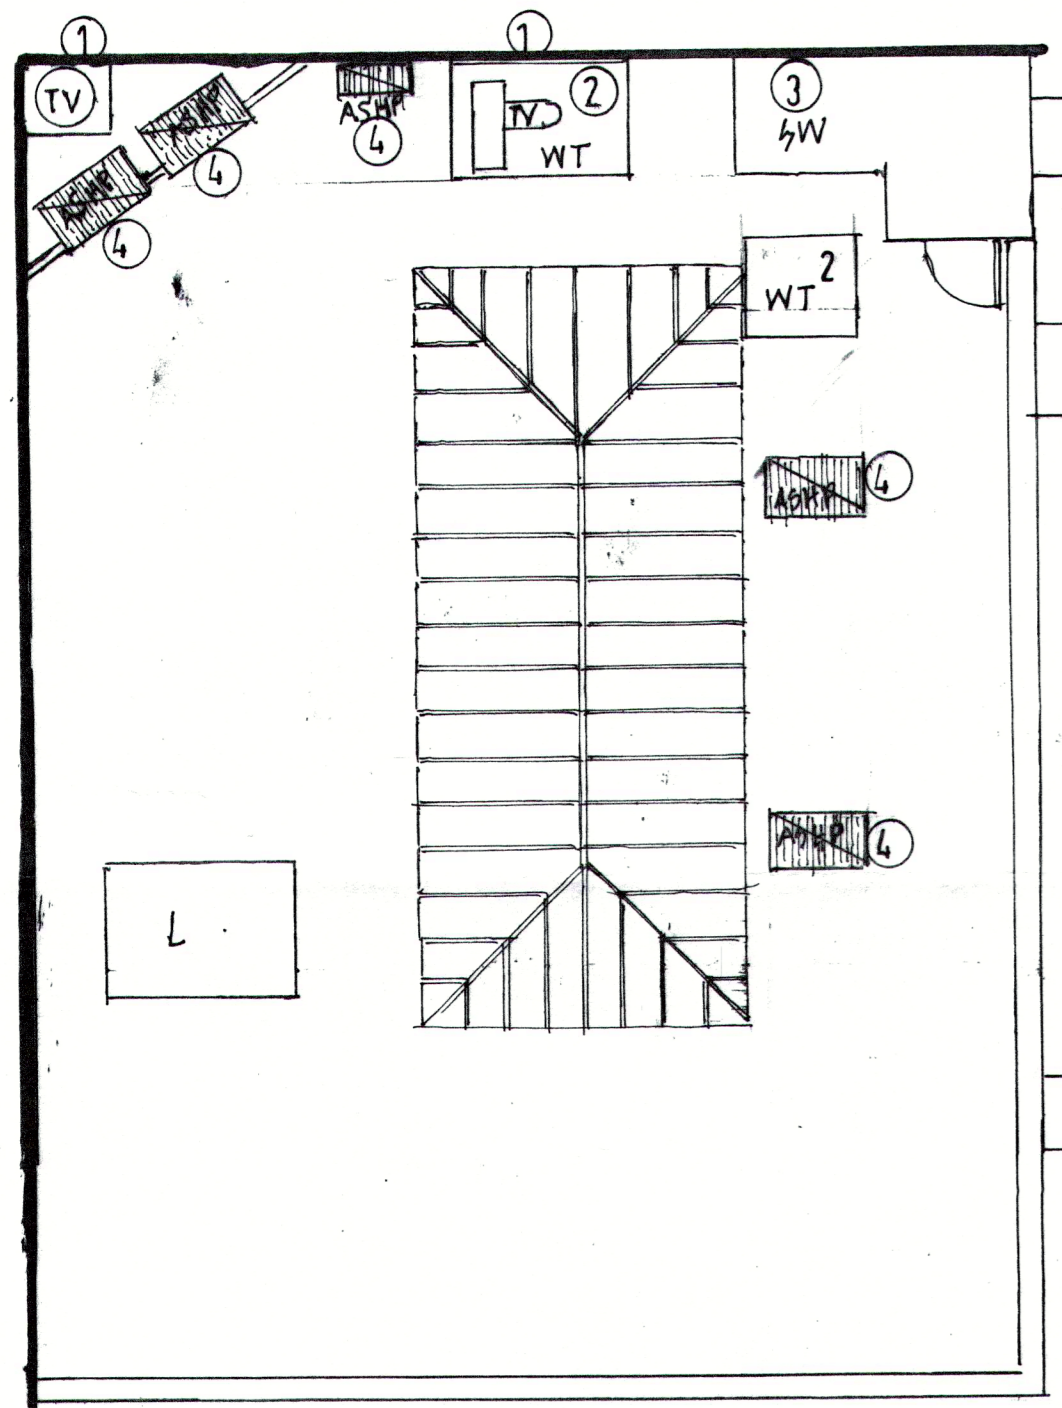


EXISTING ROOF PLAN

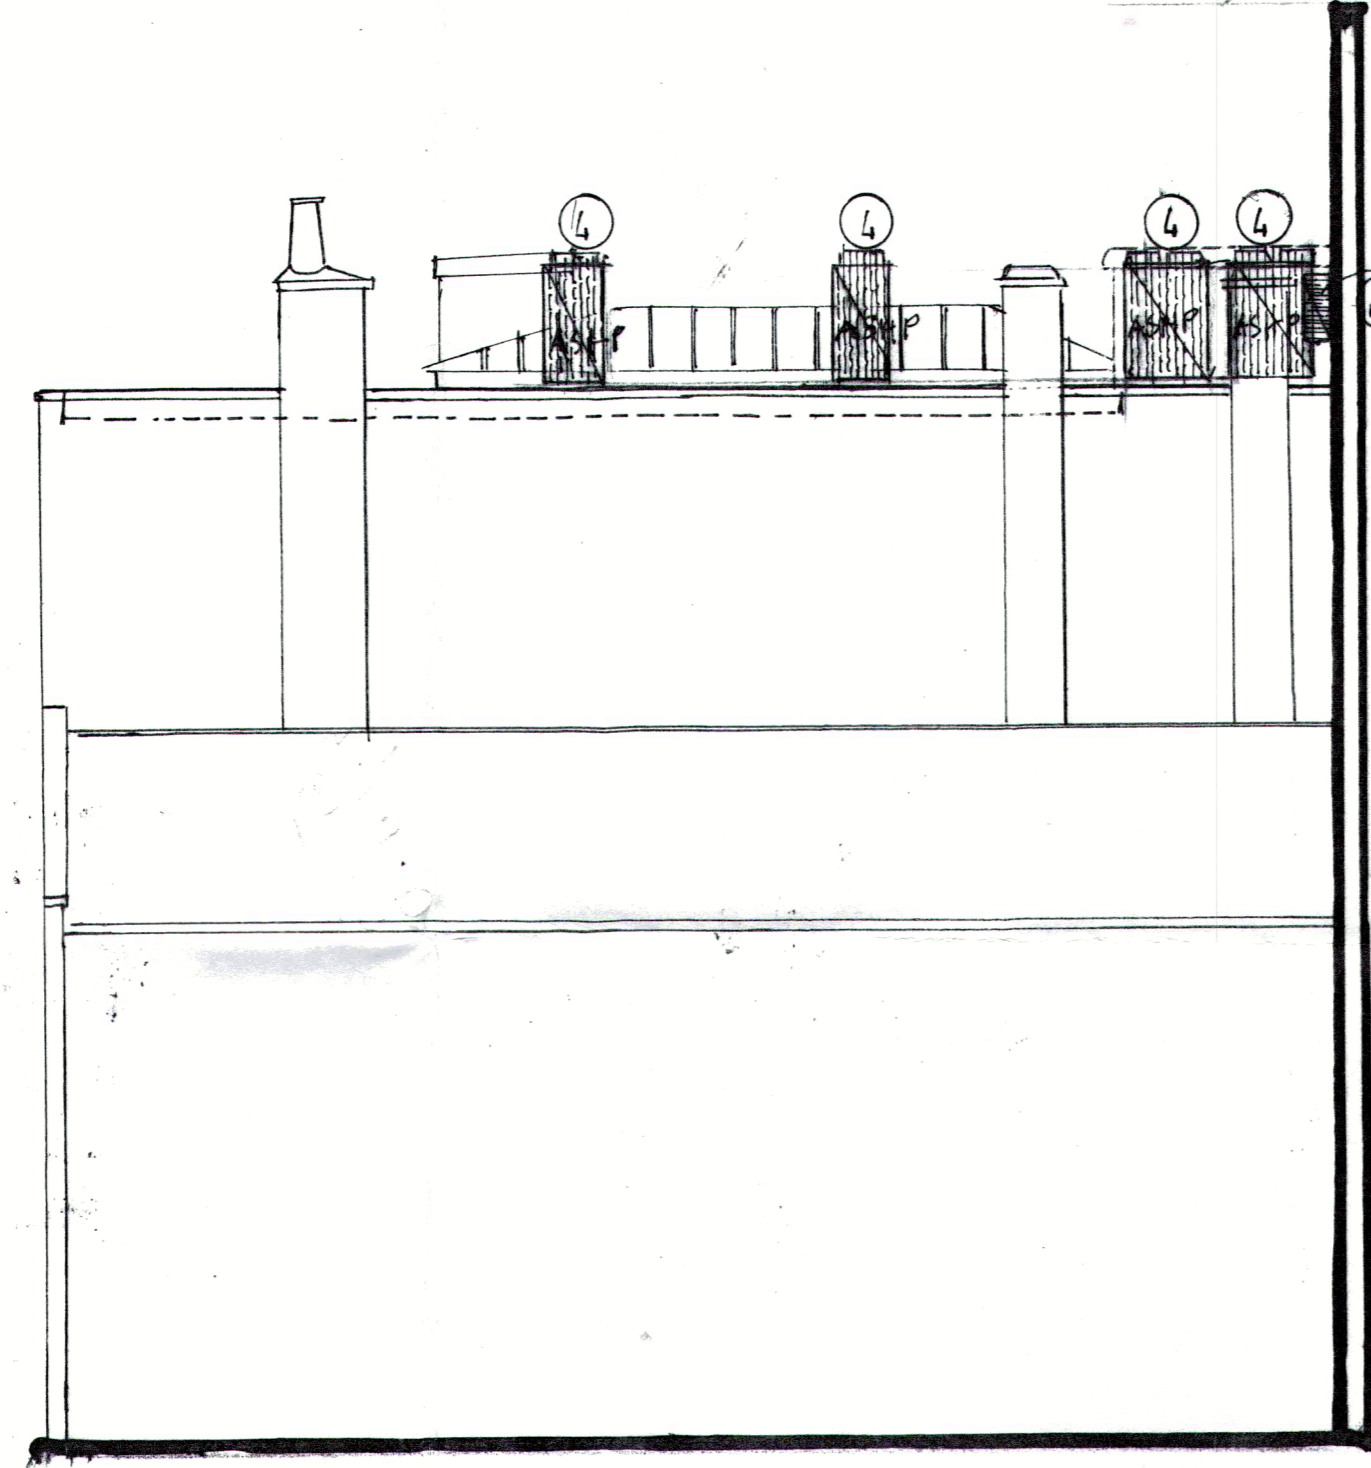


EXISTING SOUTHEAST FACING ELEVATION

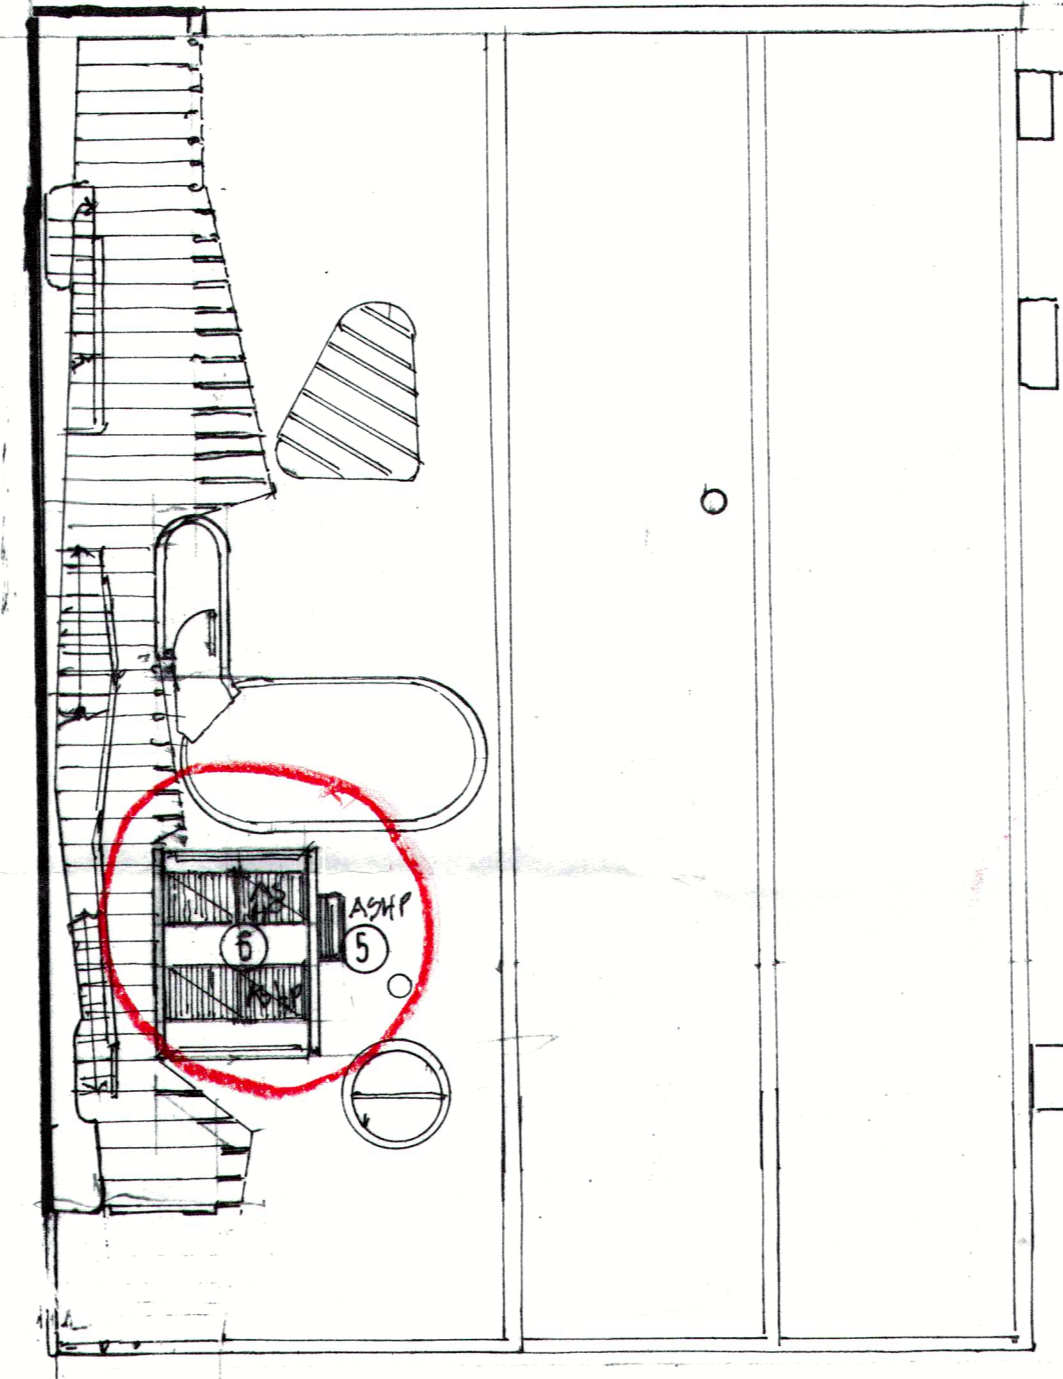

PROPOSED ROOF PLAN

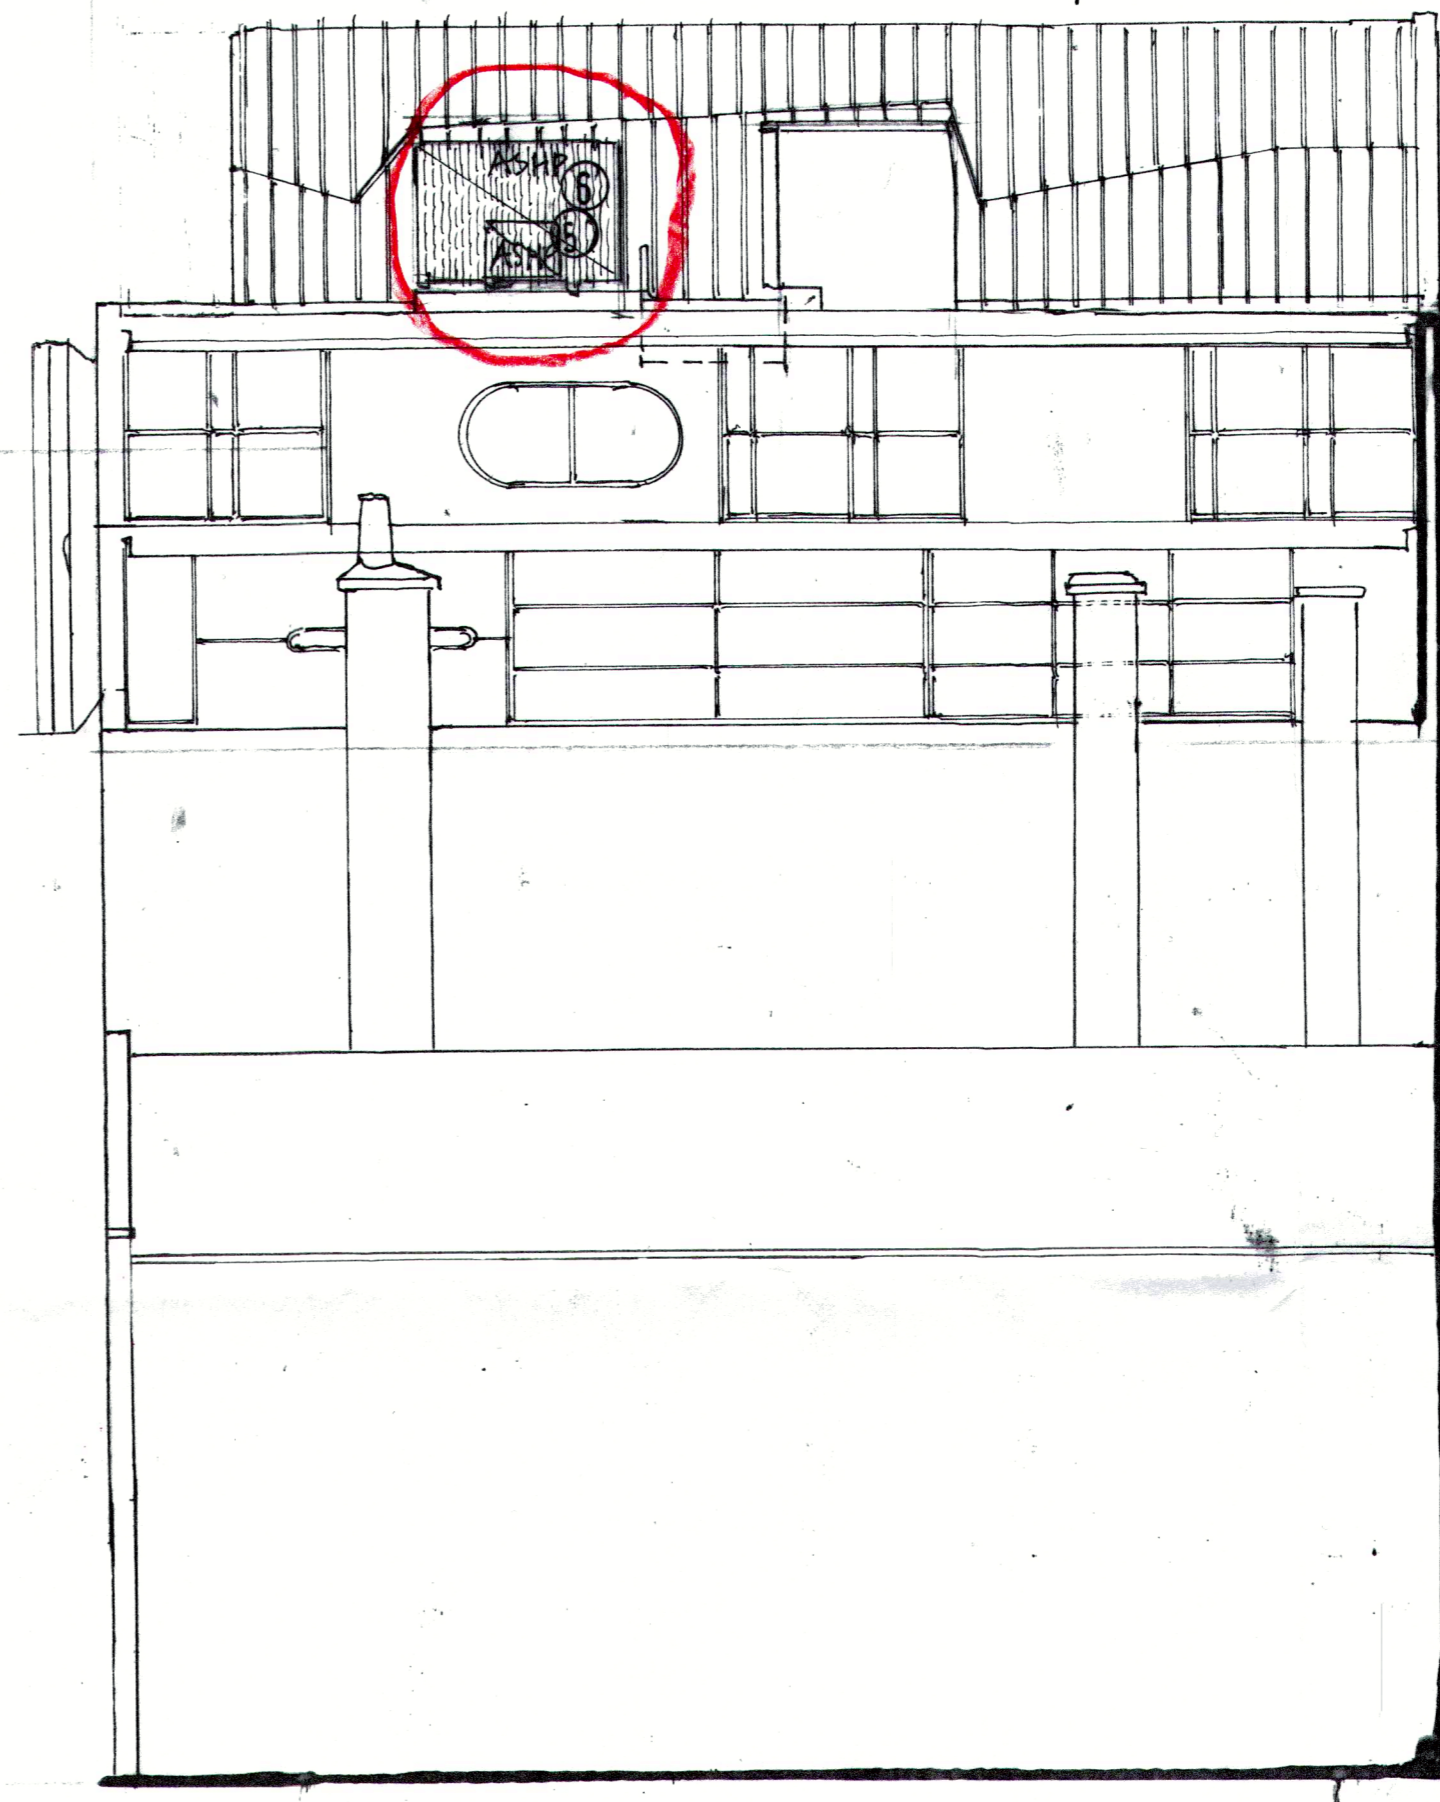

PROPOSED SOUTH EAST FACING ELEVATION

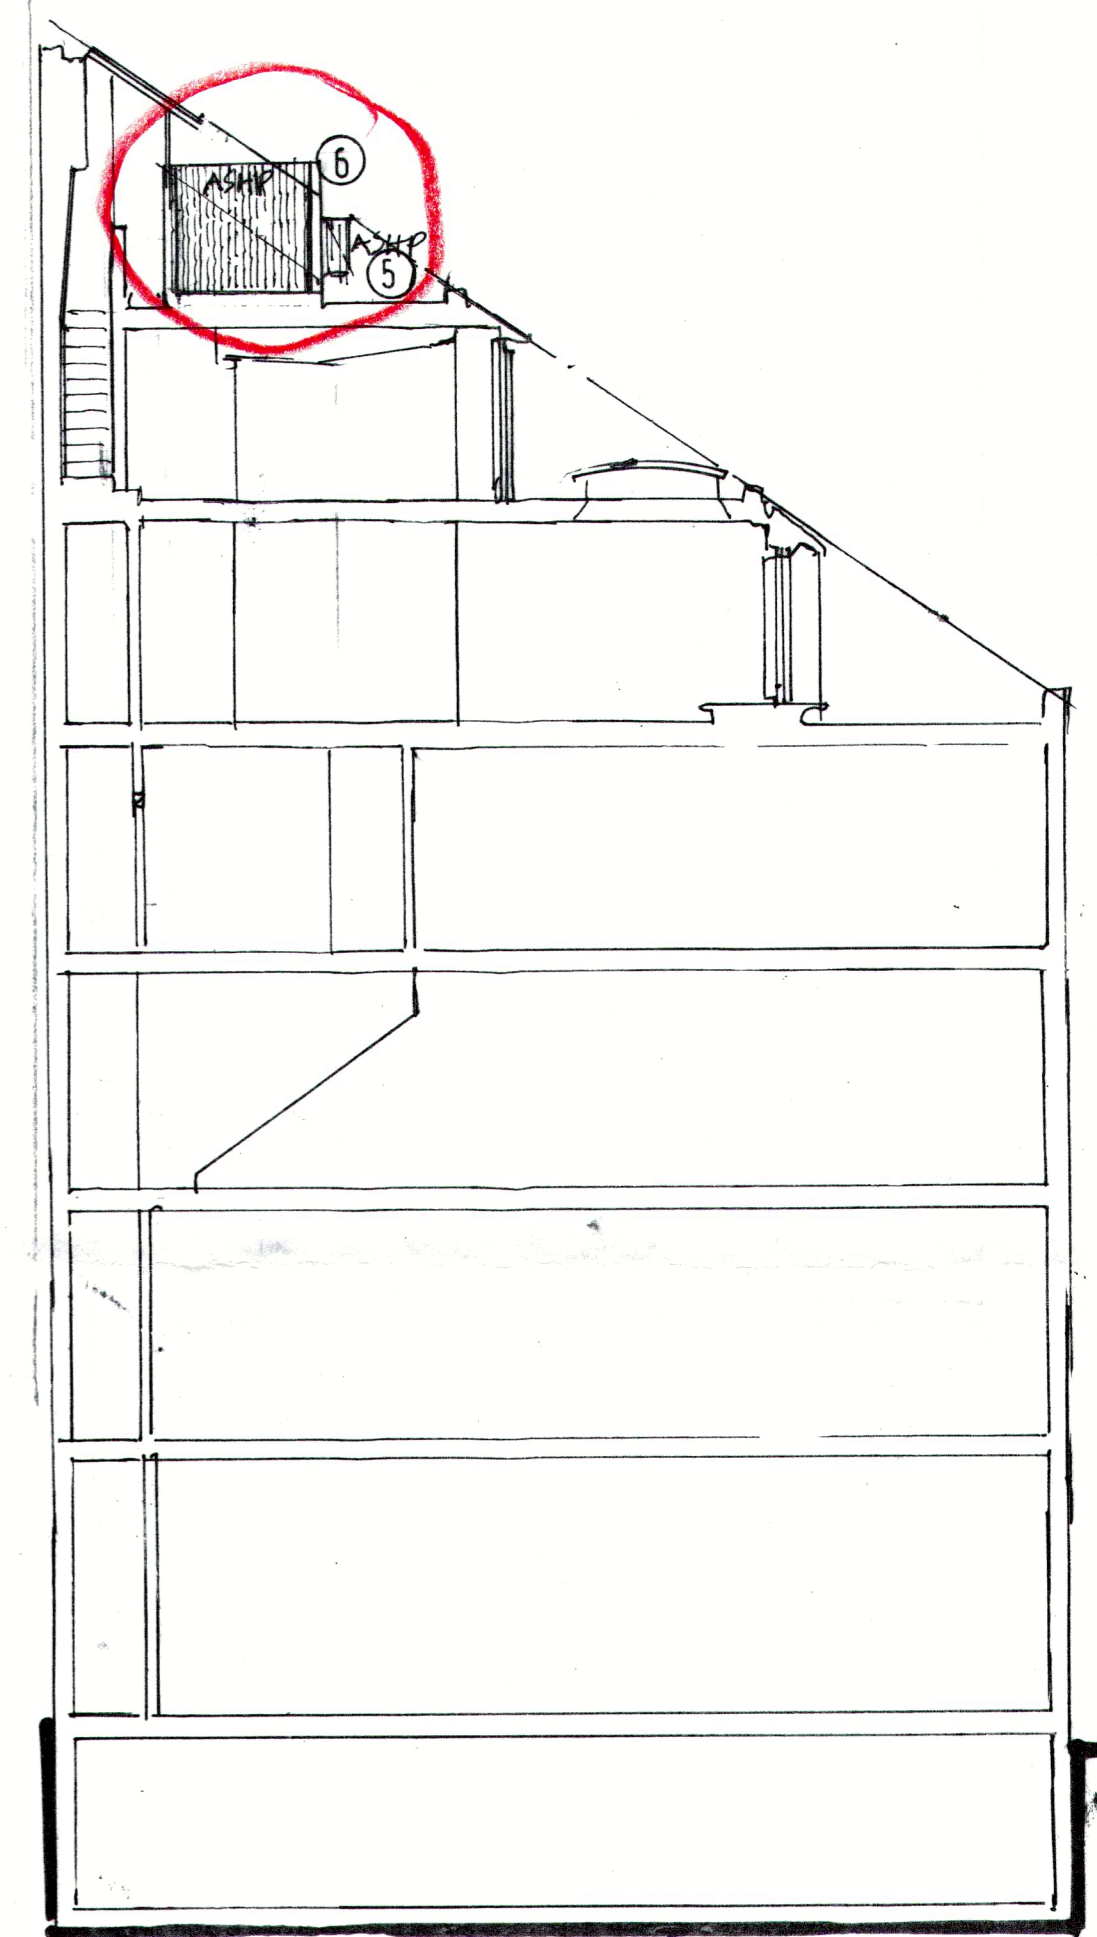

PROPOSED TYPICAL SECTION

KEY A 16 JUNE 2016 SETBACK 3RD FLOOR AIRSOURCE FROM PALADE

PETER SALTER hons.FRIBA . 01584 872 032 psalter1@btinternet.com 8 SMARTS PLACE LONDON WC2 existing and proposed location for air-source heat pumps	
scale 1:100 client	FAB A