

Which? HQ

Address
**2 Marylebone Road &
1-9 Albany Street**



Client
Which?
2 Marylebone Road
London, NW1 4DF
Tel: +44 (0)20 7770 7000 Fax: +44 (0)20 7770 7601

Architect
Kohn Pedersen Fox Associates (International) PA
Architects & Planning Consultants
7a Langley Street
London WC2H 9JA, United Kingdom
Tel: +44 (0)20 31195300 Fax: +44 (0)20 74971175


(EXT-K) FIXED EXTERNAL DOME CAMERA
(EFF-K) FULLY FUNCTIONAL EXTERNAL CAMERA

CCTV NUMBERS
C10- MARYLEBONE ROAD FRONT DOOR
C13- ALBANY STREET
C14- ALBANY STREET
C15- ALBANY STREET
C16- PETO PLACE NORTH
C17- PETO PLACE
C19- PETO PLACE ENTRANCE
C20- PETO PLACE SOUTH

SEE EXTERNAL CAMERA EQUIPMENT
SCHEDULE (ASK-116) FOR INFO RELATING
TO EACH CCTV CAMERA.

0m 1m 2m 4m

00 CCTV APPLICATION 06.07.16
No. Issue Date

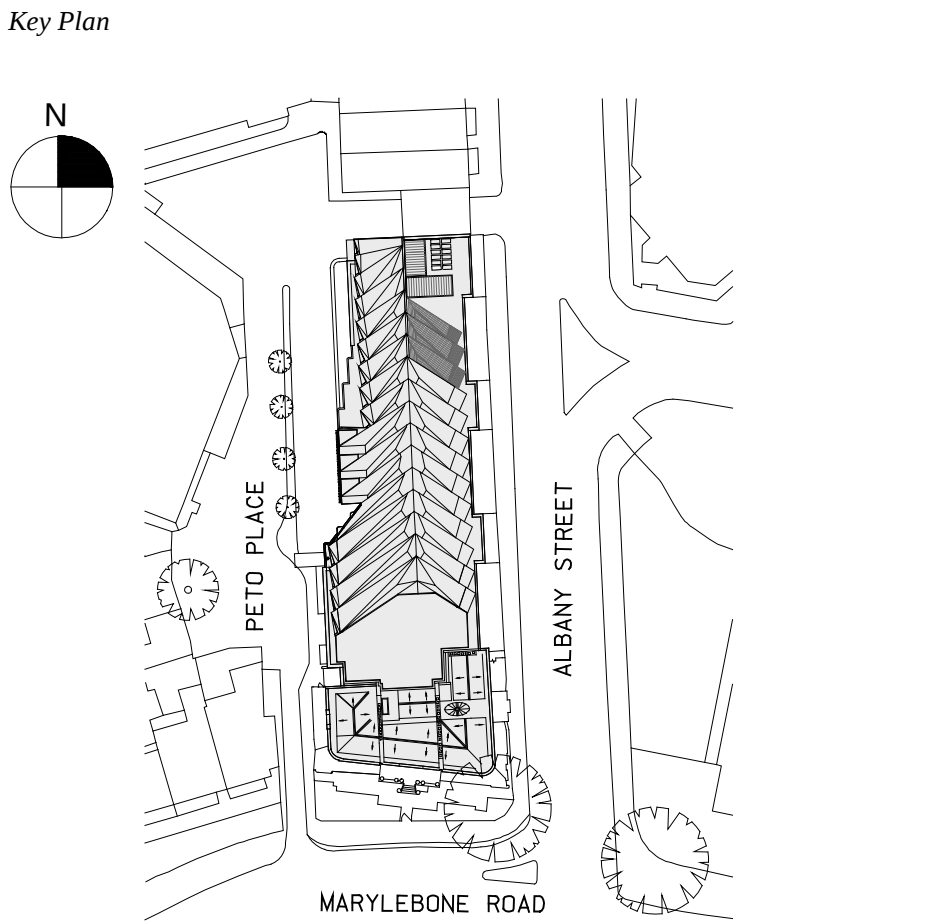

Date
18.04.13
Scale
1:100 @ A0
Project No.
859
Drawn By
-

GROUND FL. PROPOSED
EXTERNAL CCTV LAYOUT
+29.750m

A-141

© ##### KOHN PEDERSEN FOX ASSOCIATES (INTERNATIONAL) PA. All rights reserved.

1 2 3 4 5 6 7 8 9 10 11 12 13 14 15 16 17 18 19 20 21

6000 6000 3015 2427 1453 4772 728 5700 6000 1500 4200 3300 2400 2400 3600 3900 1800 5700 7775 6500

PETO PLACE

2
A-231

1
A-232

1
A-231

ALBANY STREET A4201

1 Ground Floor Plan - Proposed
SCALE: 1:100 @ A0



OSWALDSTON TERRACE