




- 1 THIS DRAWING TO BE READ IN CONJUNCTION
- 2 WITH ARCHITECTURAL AND OTHER RELATED DRAWINGS
- 3 DO NOT SCALE THIS DRAWING
- 4 PARTIES MUST CHECK FOR COORDINATION ALL RELEVANT
- 5 DISCREPANCIES TO THE ENGINEER
- 6 ALL MEASUREMENTS TO BE VERIFIED ON SITE
- 7 ALL PLANT AND EQUIPMENT TO BE INSTALLED IN
- 8 ACCORDANCE WITH MANUFACTURERS
- 9 RECOMMENDATIONS INCLUDING ADEQUATE
- 10 SPACE FOR MAINTENANCE AND REPLACEMENT

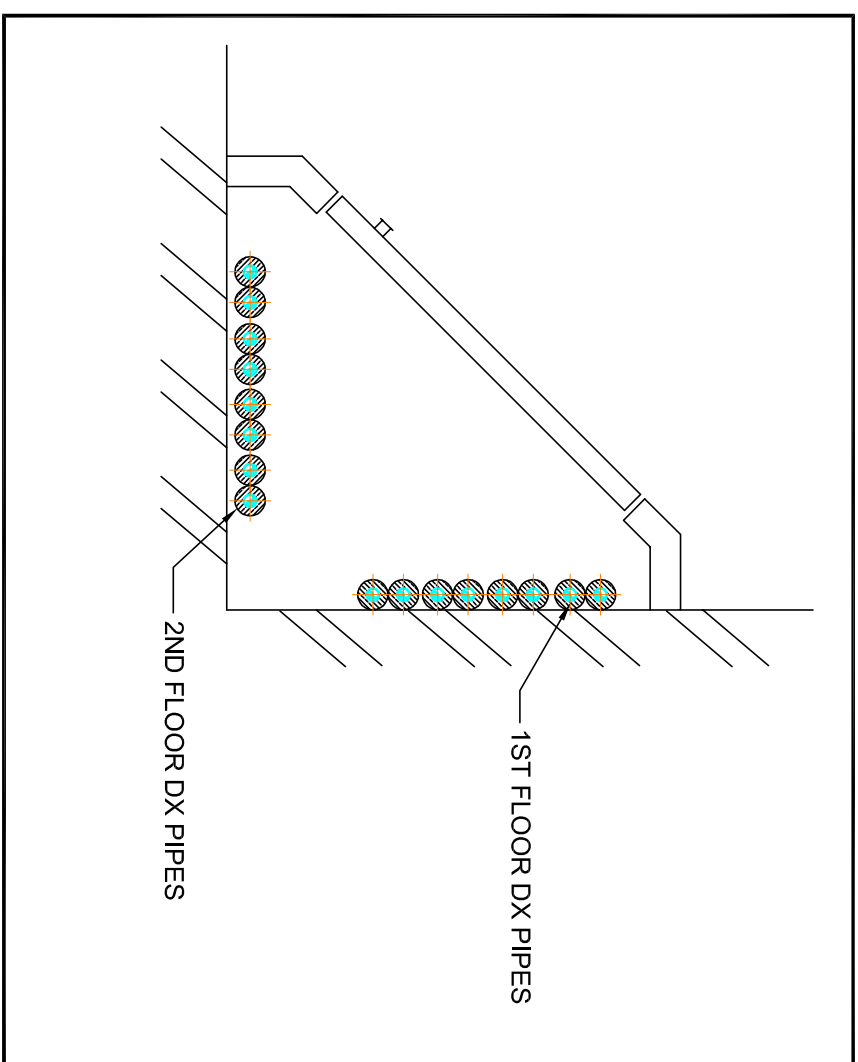



**PIPEWORK IN CUPBOARD RISER**  
**TYPICAL DETAIL**  
**1:10@A1**

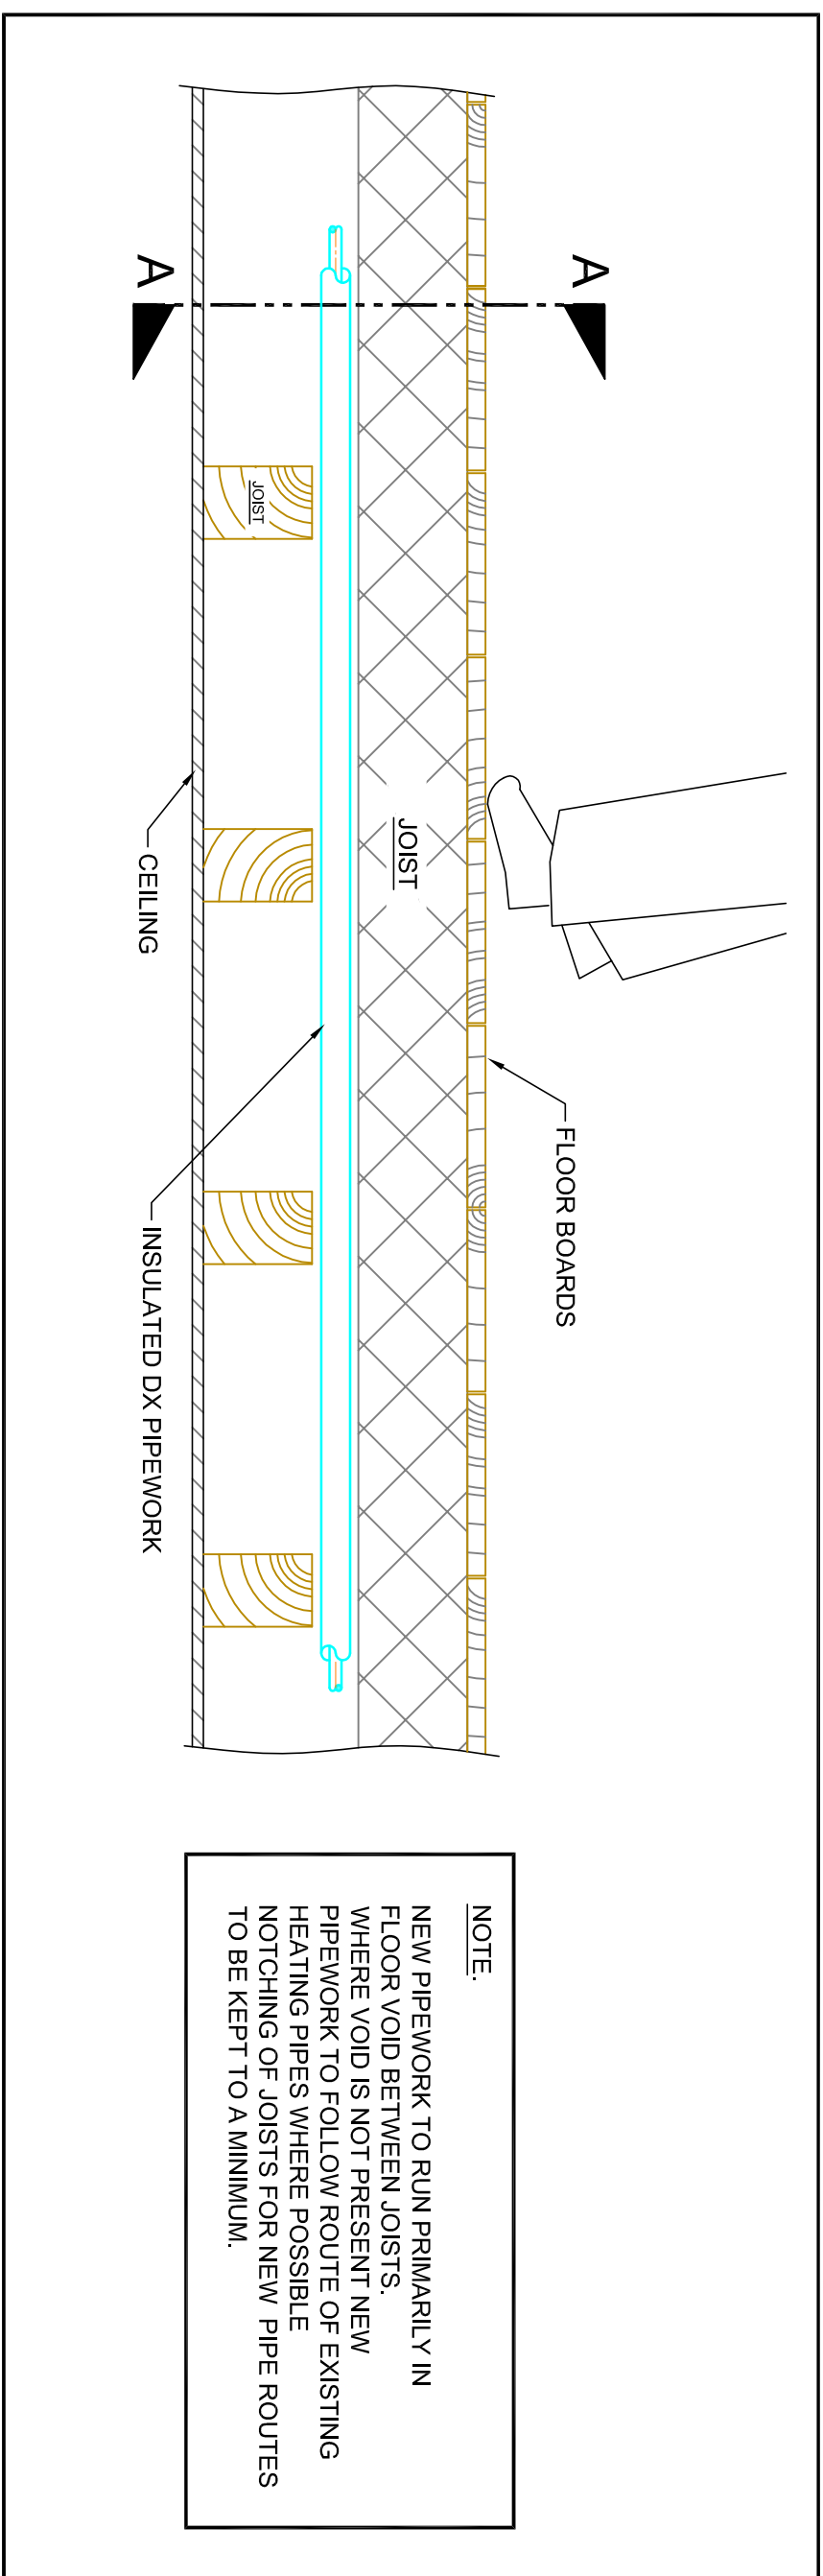

**PIPEWORK IN FLOOR**  
**TYPICAL DETAIL**  
**1:10@A1**

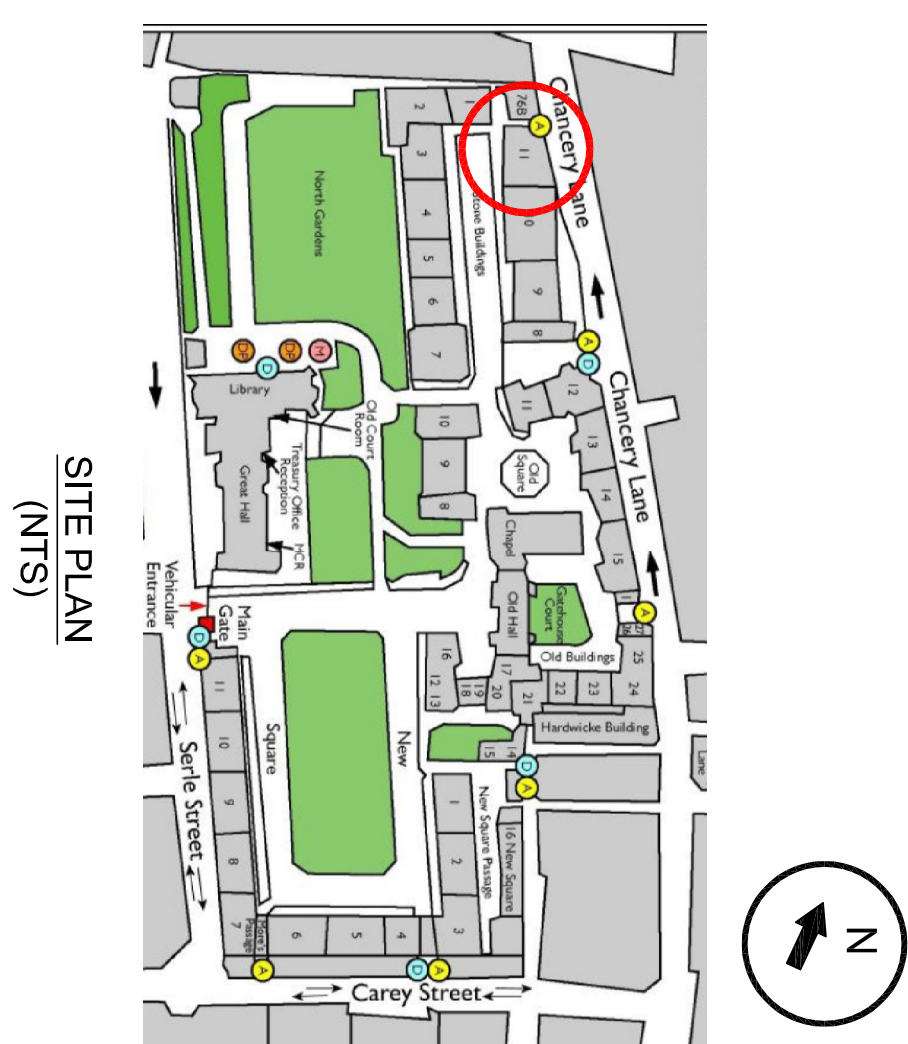

SITE PLAN  
(NTS)

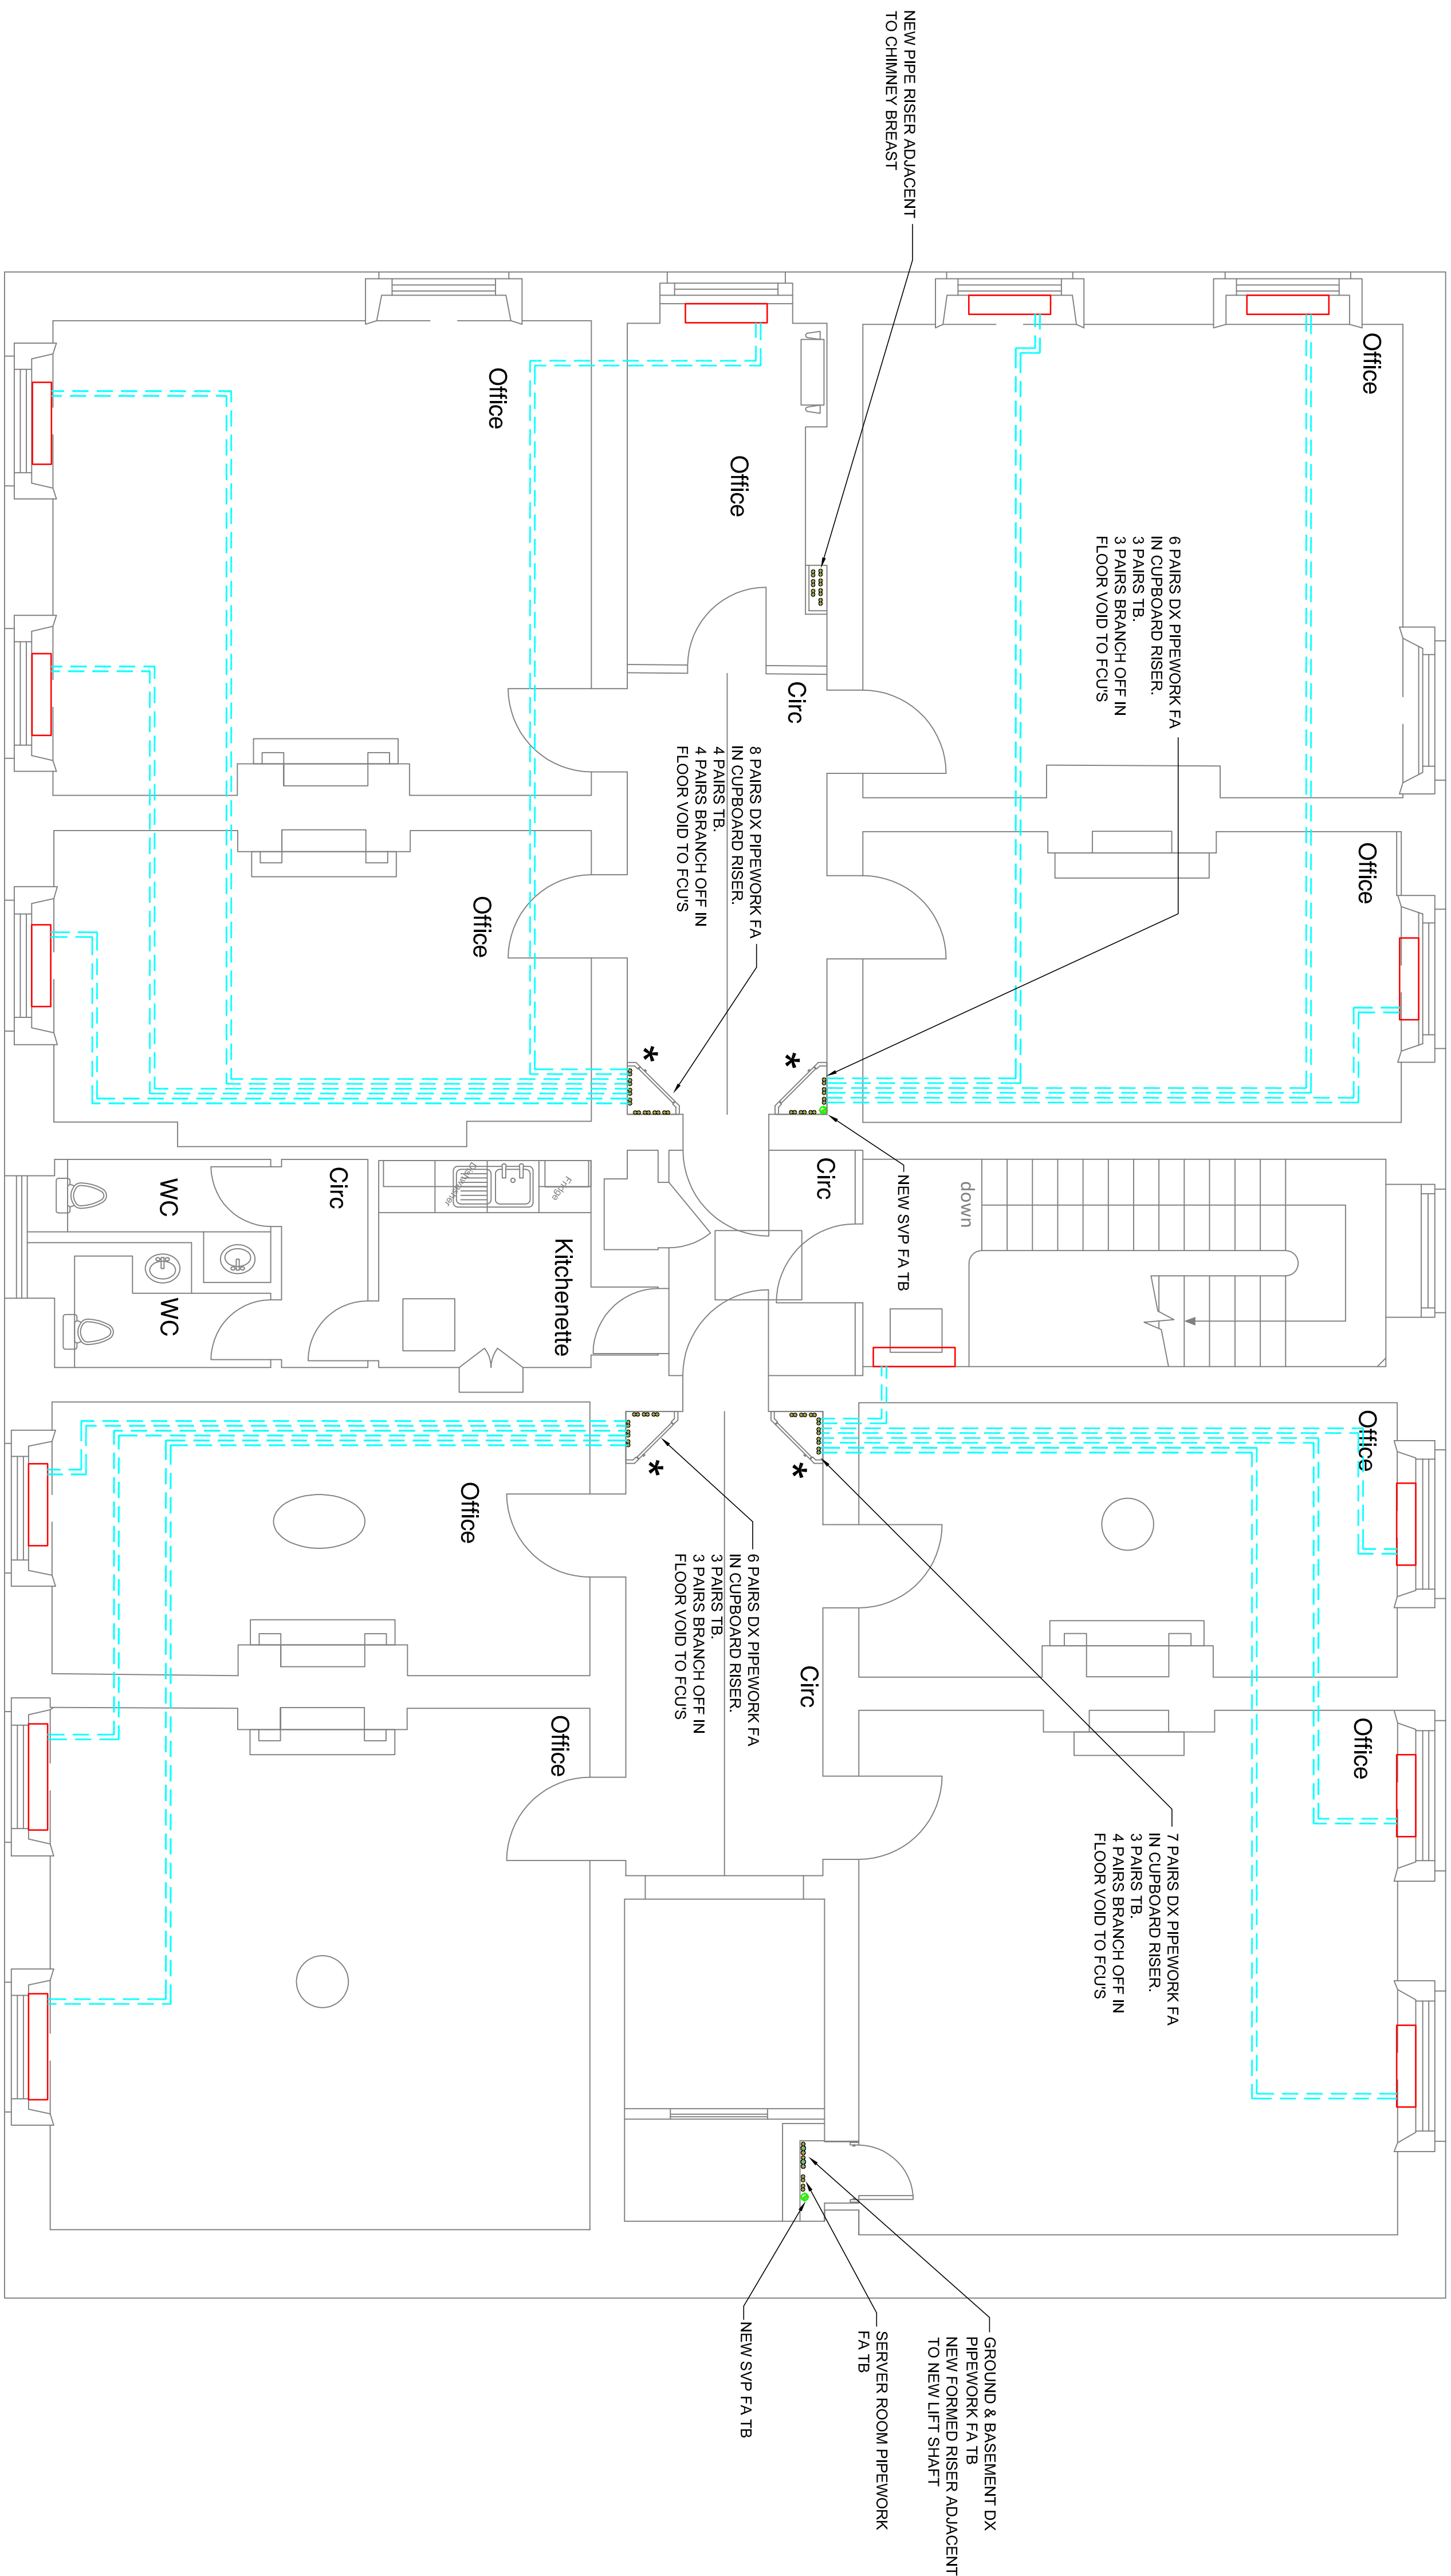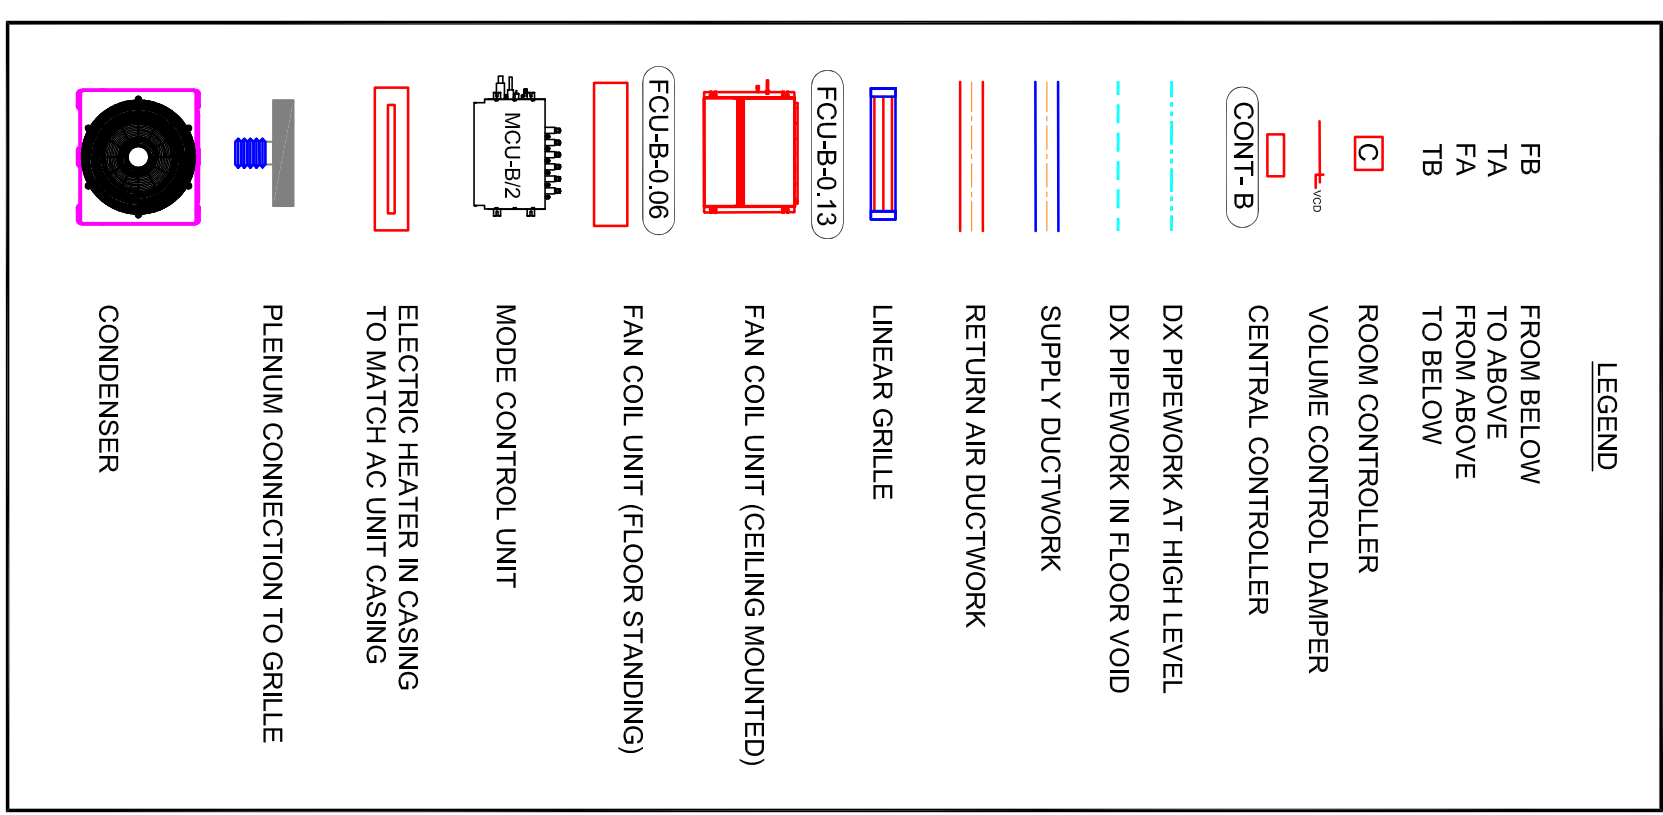

### FAN COIL UNIT PLAN

Dwg No:			Rev	
151113/M/503			P0	
Scale	Date	Drawn	Checked	
1:50@A1	JUN 16	WJ	PL	

**centre** line  
Building Services Consultants

THE HONOURABLE SOCIETY  
OF LINCOLNS INN

Project  
LINCOLNS INN  
11 STONE BUILDINGS  
LONDON, WC2A 3TG

Title  
SECOND FLOOR  
AC LAYOUT



P0	27.06.16	WJ	FOR INFORMATION
Rev	Date	Drawn	Issue

**FOR INFORMATION**

