


PWX002203R1

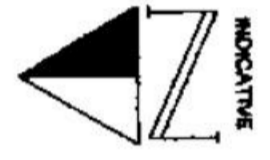

THE CHARLTON BROWN PARTNERSHIP  
ARCHITECTS

The Old Chapel, Highgate Hill, Hampstead, London NW8 5LE Telephone: 020 7106 6200 Fax: 020 7106 6201

DEVONSHIRE HOUSE SCHOOL, 60 FITZJOHN'S AV., N10 6NS  
PROPOSED SITE PLAN

651/AP 01A

Date: May 2000 Scale: 1:100 This drawing is copyright



**SURVEYED BY**  
**PREMIER SURVEYS LIMITED**  
 THE OLD ESTATE OFFICE  
 THE SQUARE  
 WILDMERE ROAD  
 GUILDFORD  
 SURREY GU2 8QR  
 Fax: 01483 481126  
 Tel: 01483 481124

**LEGEND**

	SURVEY STATION		WATER
	BANK		GAS
	LEVEL HEIGHT		CABLE TELEVISION
	LEVEL POSITION		STORM DRAINAGE
	REINFORCEMENT BAR		FENCE
	SLOPE		
	GUTTER		

**ABBREVIATIONS (Where Applicable)**


AC	AIR CONNECTION UNIT	IC	INSULATION COVER
AN	ARCH WINDOW	IL	INSULATION
AW	ARCH WINDOW	LP	LEAD PIPE
AV	AIR VALVE	SP	SPRINKLER
B	BENCH MARK	SS	STEEL
BP	BREAK BLANK POINT	NS	NON-SURVEYED
BS	BELL AND HOWELL	NP	NO FURTHER INFORMATION
BSW	BRICK WALL	SP	STREET NAME PLATE
CB	CAMERA	DM	DOWN PIPE
CD	CABLE DUCT	P	POST
CE	CLEANING EYE	PL	PLASTER LIGHT
CL	COVER LEVEL	RD	RADIATOR
CM	CABLE NUMBER	RS	RICHMOND
CONC	CONCRETE	RS	RICHMOND
CP	CONC. PAVING SLAB	RSJ	ROLLED STEEL JOIST
CS	CABLE SLOPE UP	RSW	REINFORCED WALL
CTV	CABLE TELEVISION	RSP	RADIATOR
D	DOWN PIPE	SC	STOP COCK
DP	DOWN PIPE	SH	SHOWER PAN
EP	ELECTRICAL POINT	SL	SLIP LEVEL
ES	ELECTRICITY IC	SW	SWITCH
ESB	ELECTRICAL BOX	SWP	SWITCH PLATE
EP	ELECTRICITY POINT	TCB	TELEPHONE CALL BOX
EP	ELECTRICITY POINT	TC	TELEPHONE CABLE
F	FLOOR	TCU	TELEPHONE CONTROL UNIT
PH	FIRE HYDRANT	UL	UNDER LIFT
FG	FLOOR INTO GROUND	UP	UPPER
FL	FLOOR LEVEL	W	WATER
FP	FIRE PILLAR	WV	WATER VALVE
G	GULLY	WM	WATER METER
GV	GAS VALVE	WV	WATER VALVE
H	HEAVY		
HD	HEATING DUCT		
HV	HEATING VALVE		

**FENCE TYPES AND DETAILS**

BSF	BARRIERS	RF	POST & RAIL
CBF	CLOSED BOARD	RF	POST & RAIL
CLF	CORRAL	RF	POST & RAIL
CPF	CHESTNUT PALING	RF	POST & RAIL
OPF	OPEN BOARD	RF	POST & RAIL

**LEVEL DATUM**

DATUM USED: NEWLYN  
 BENCH MARK: OSBM, HENDERSON COURT  
 VALUE: 104.54m

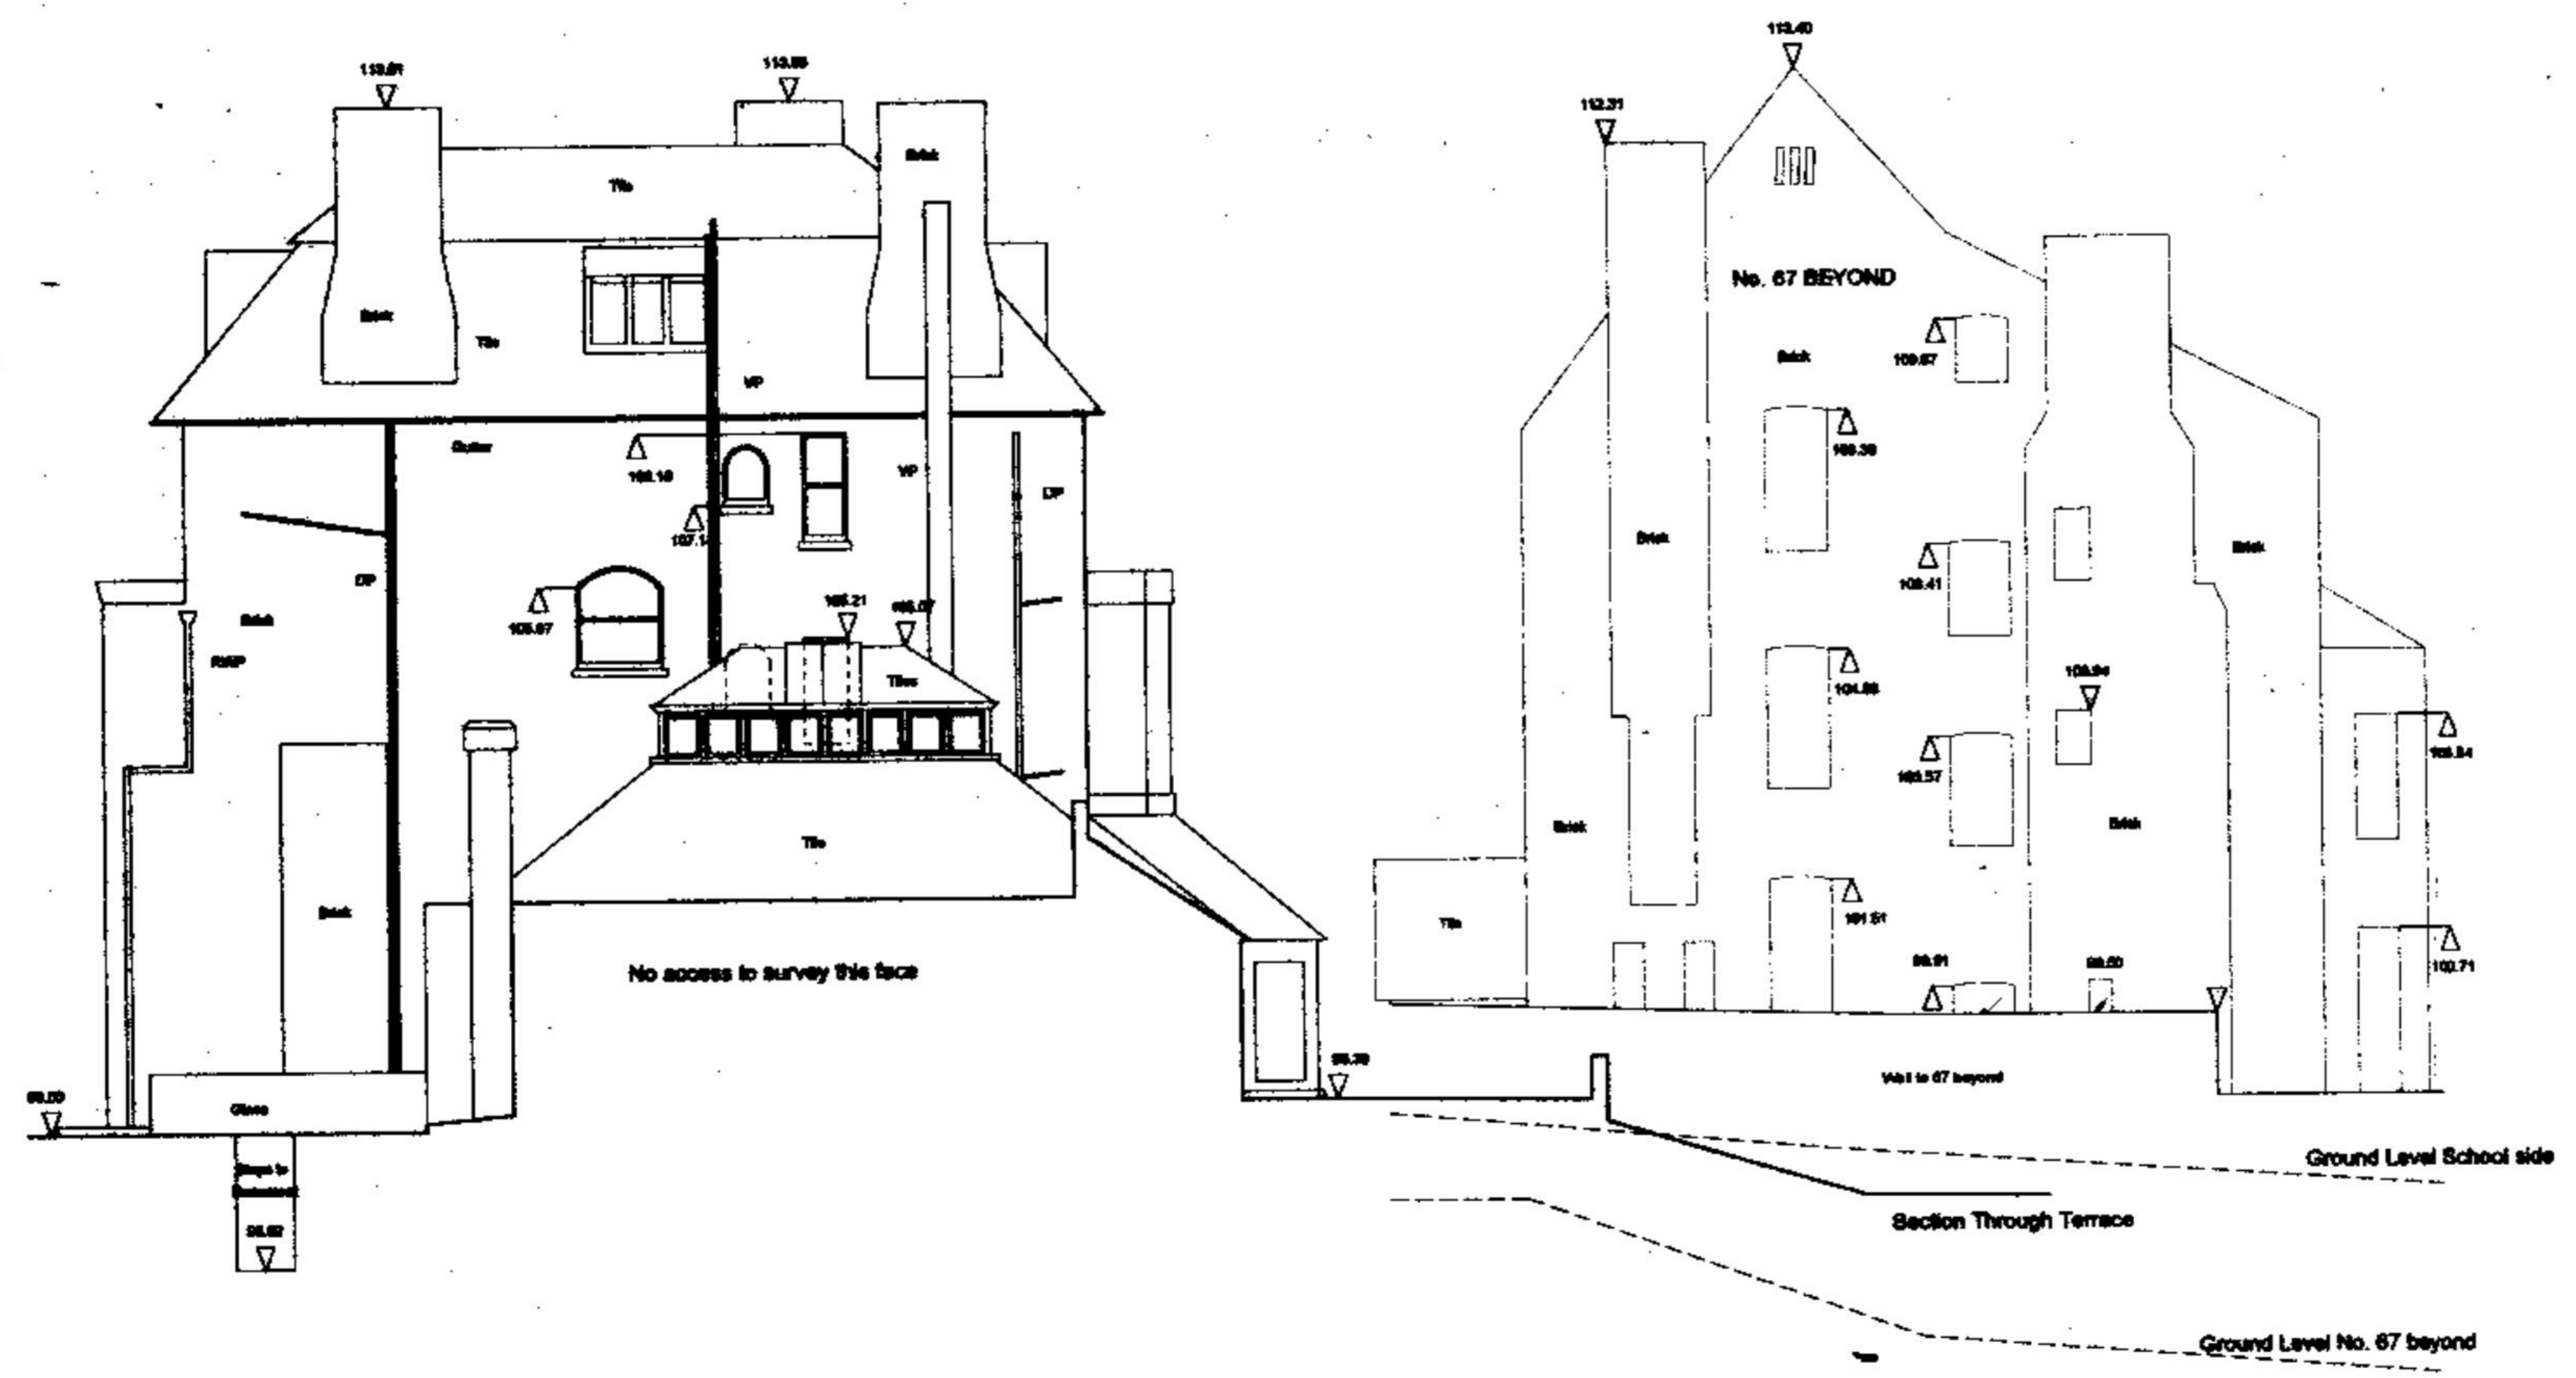

**CLIENT**  
 THE CHARLTON BROWN PARTNERSHIP  
 THE OLD CHAPEL  
 SHEPHERD'S WALK  
 HAMPSTEAD  
 LONDON NW3 6UE

**JOB TITLE**  
 THE DEVONSHIRE HOUSE SCHOOL  
 69 FITZJOHNS AVENUE  
 LONDON NW3

**DRAWING TITLE**  
 SIDE (NORTH) ELEVATION



**SCALE**  
 1/100

**DATE**  
 MAY 99

**SHEET NO.**  
 A2

**Drawing No.**  
 651/805

PWX000 2203

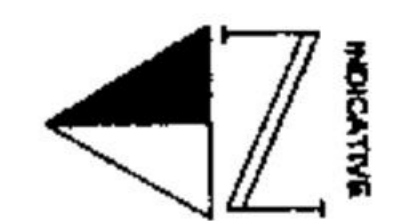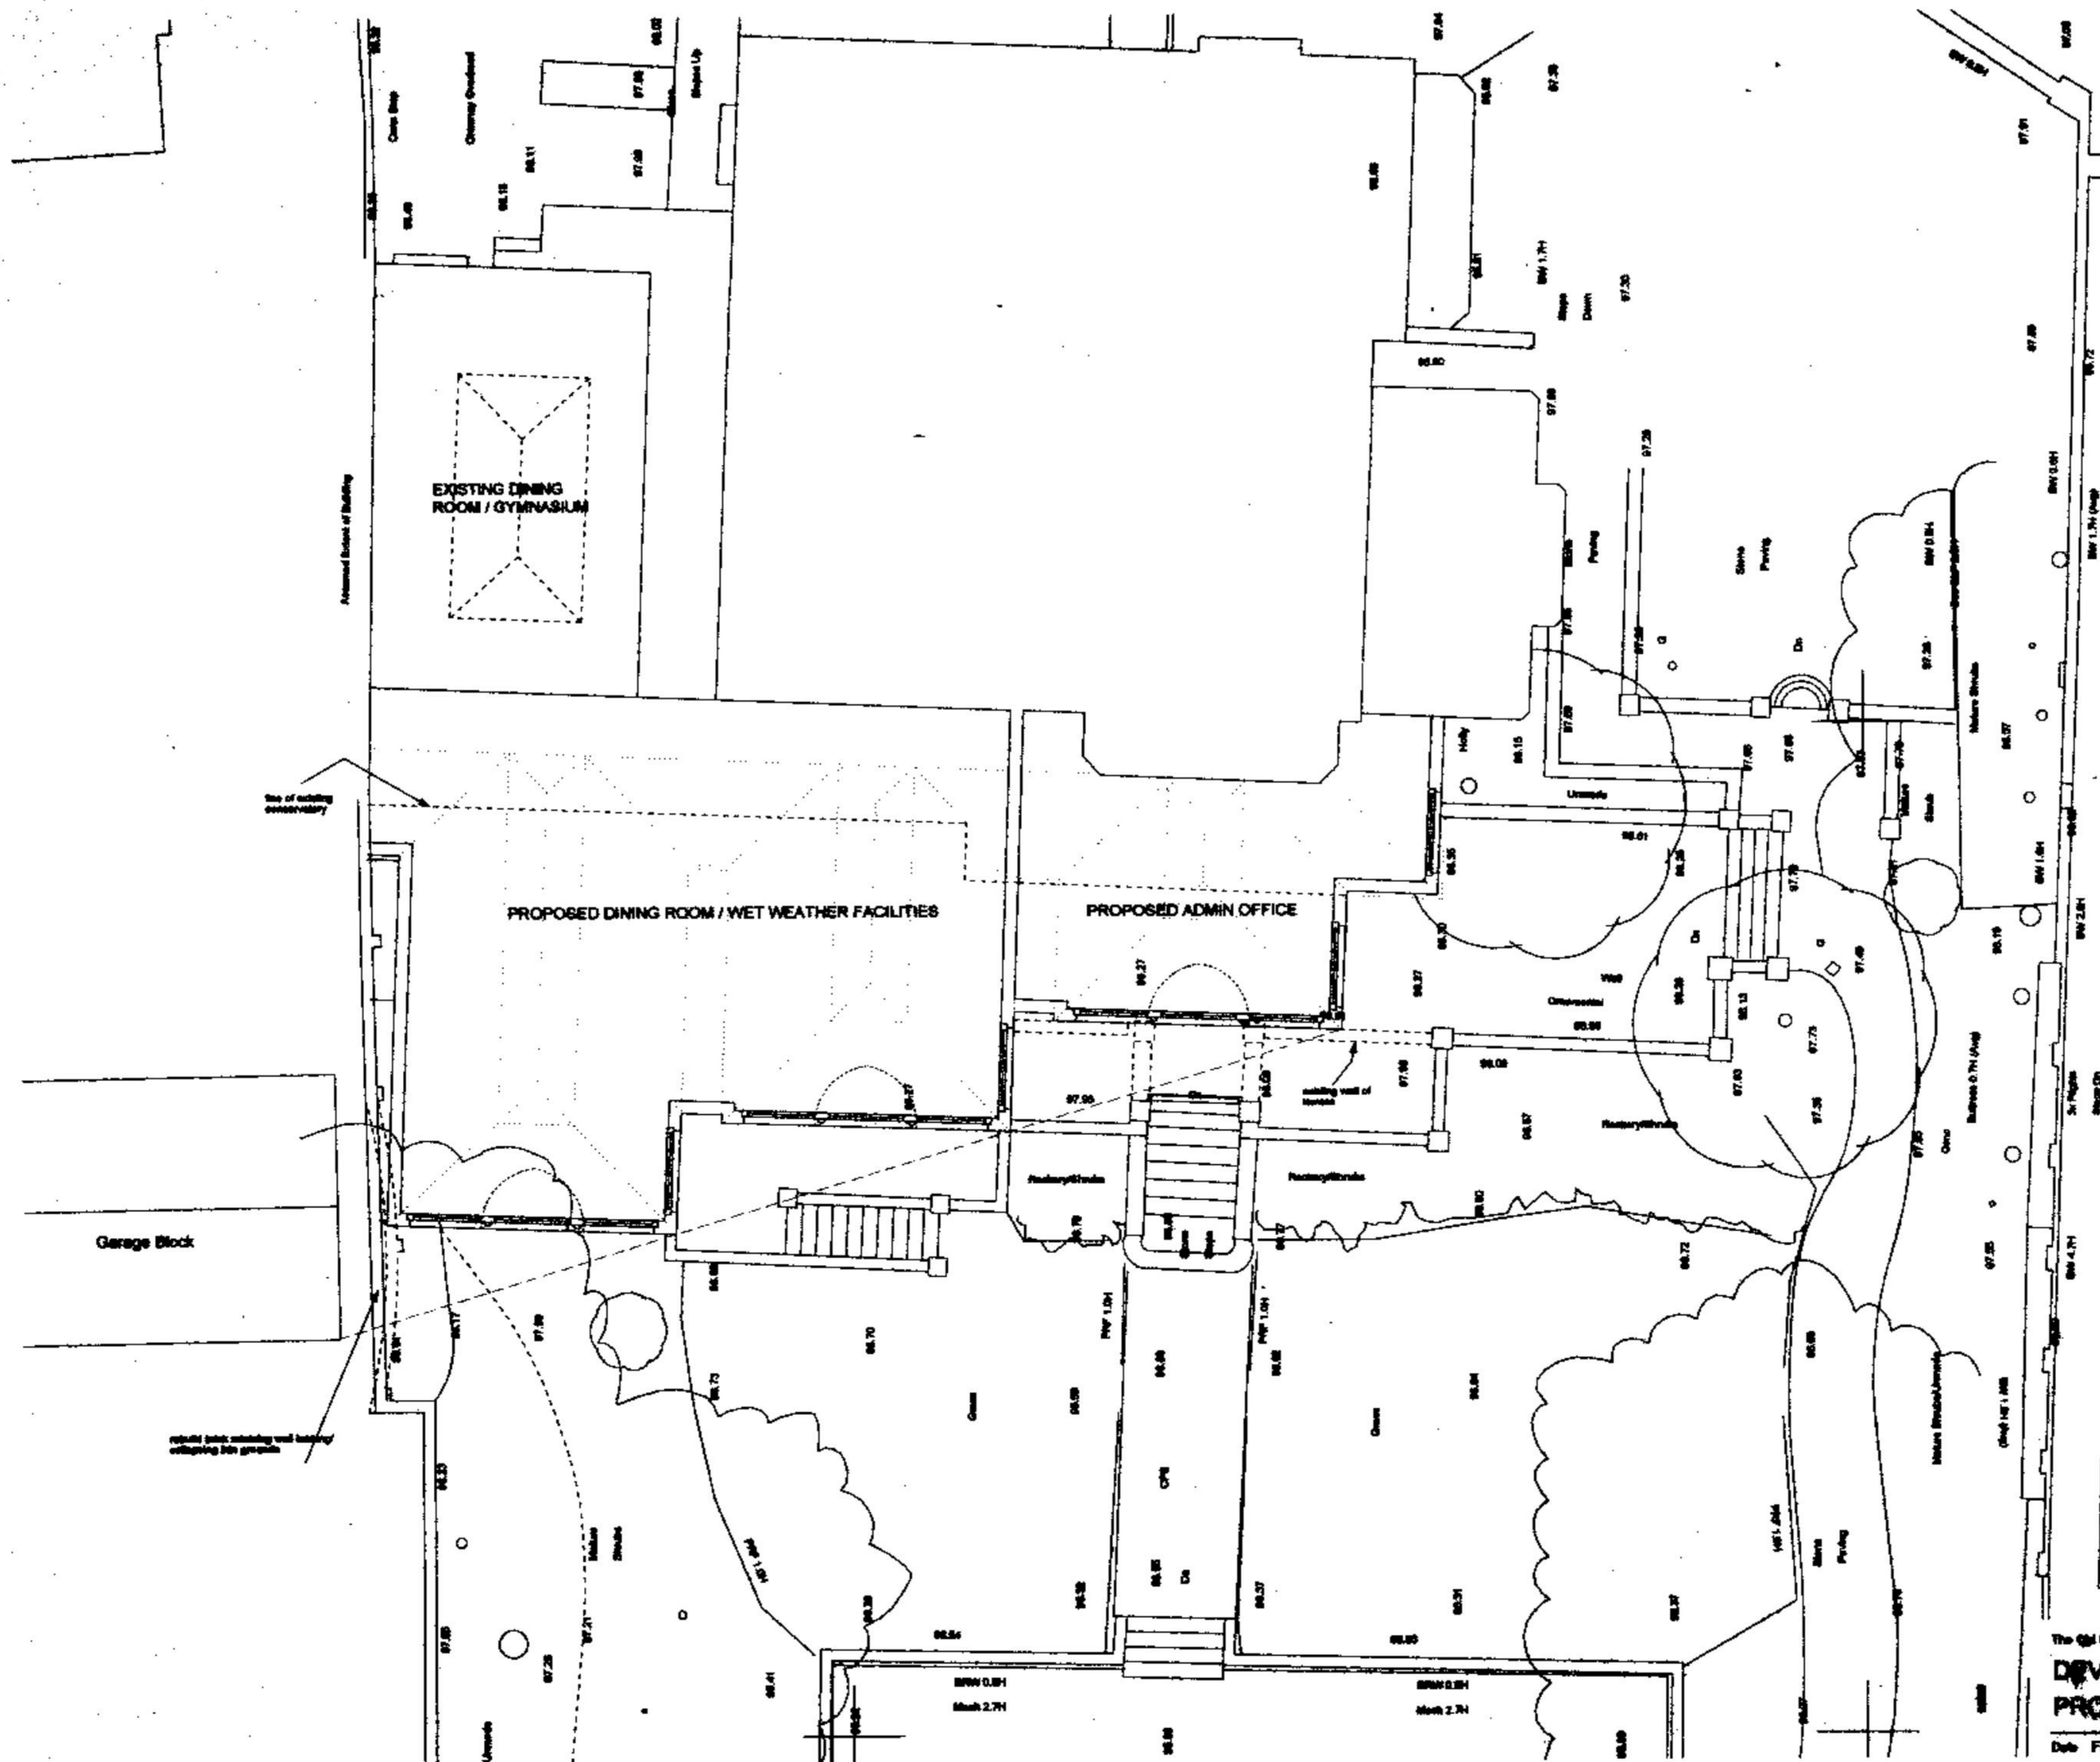

PWX000 2203



THE CHARLTON BROWN PARTNERSHIP  
ARCHITECTS

The Old Chapel, St. Andrew's Church, Uxbridge, London, NW9 5BE Telephone: 0171 706 1204 Fax: 0171 498 8008  
**DEVONSHIRE HOUSE SCHOOL, 69 FITZJOHN'S AV., NW3**  
**PROPOSED GROUND FLOOR PLAN** 651/AP 02  
 Date: FEB 2000 Scale: 1:100 This drawing is copyright. Revisions: