



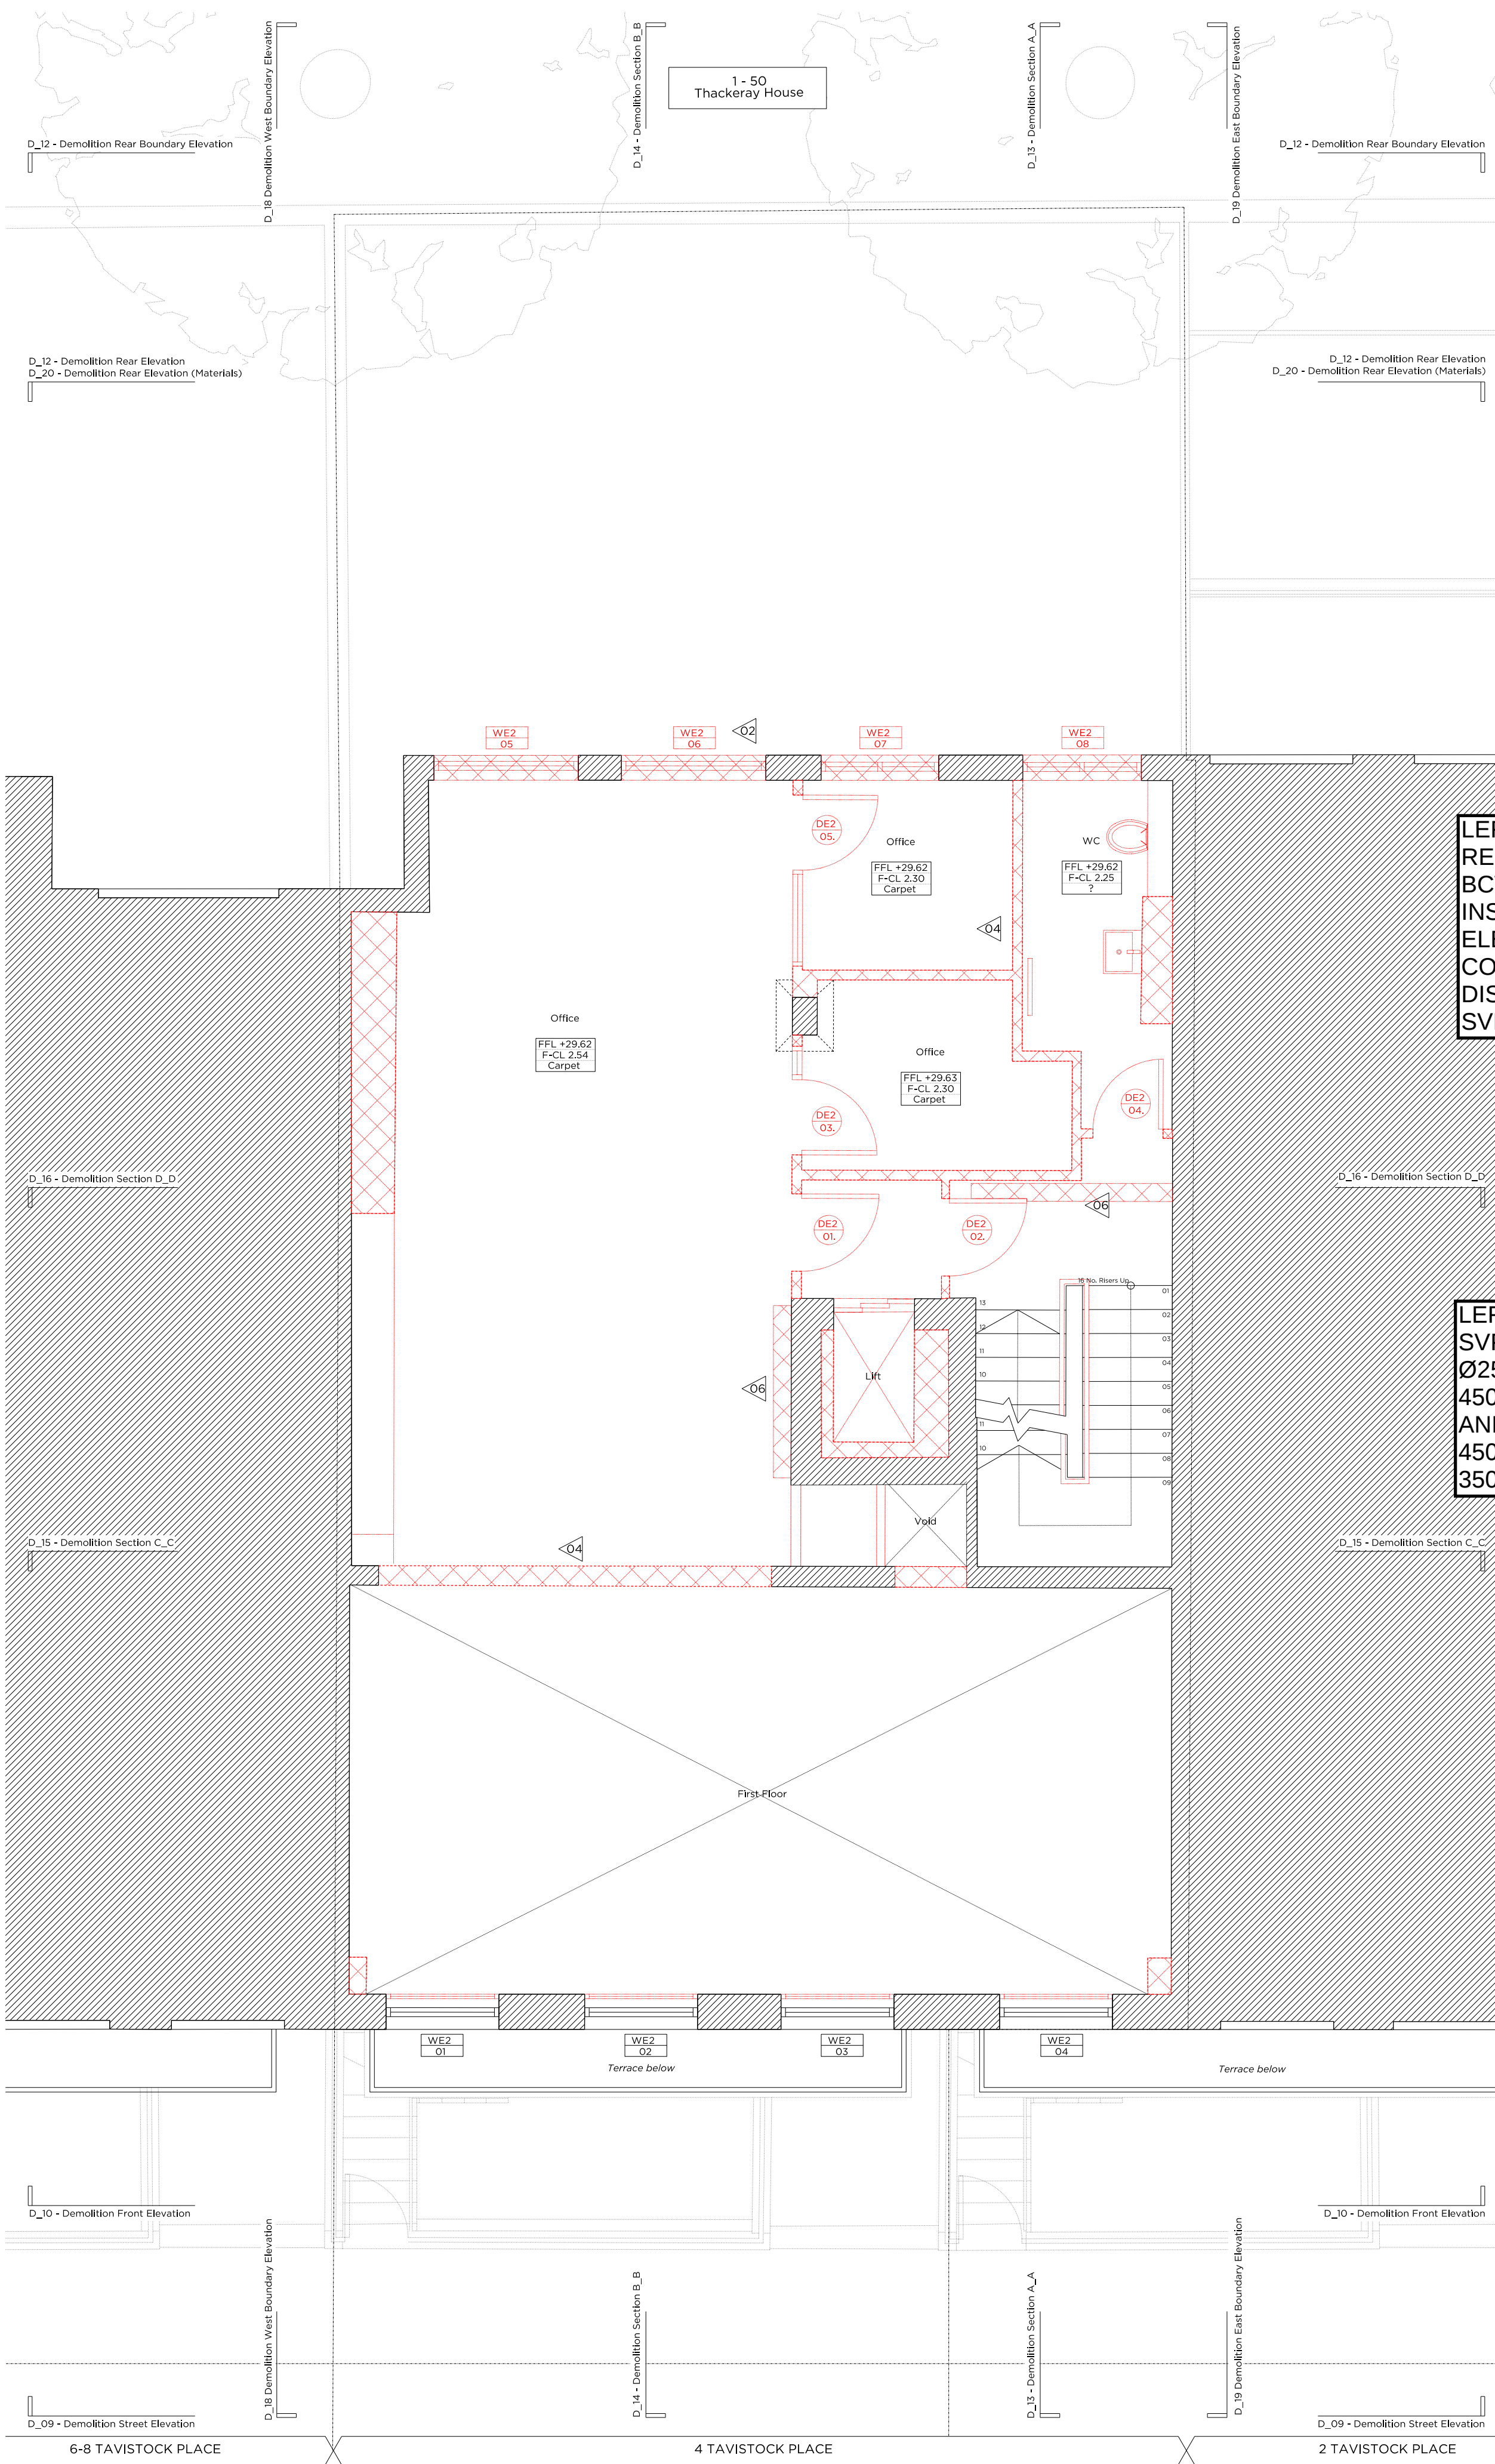

Demolition Second Floor Plan

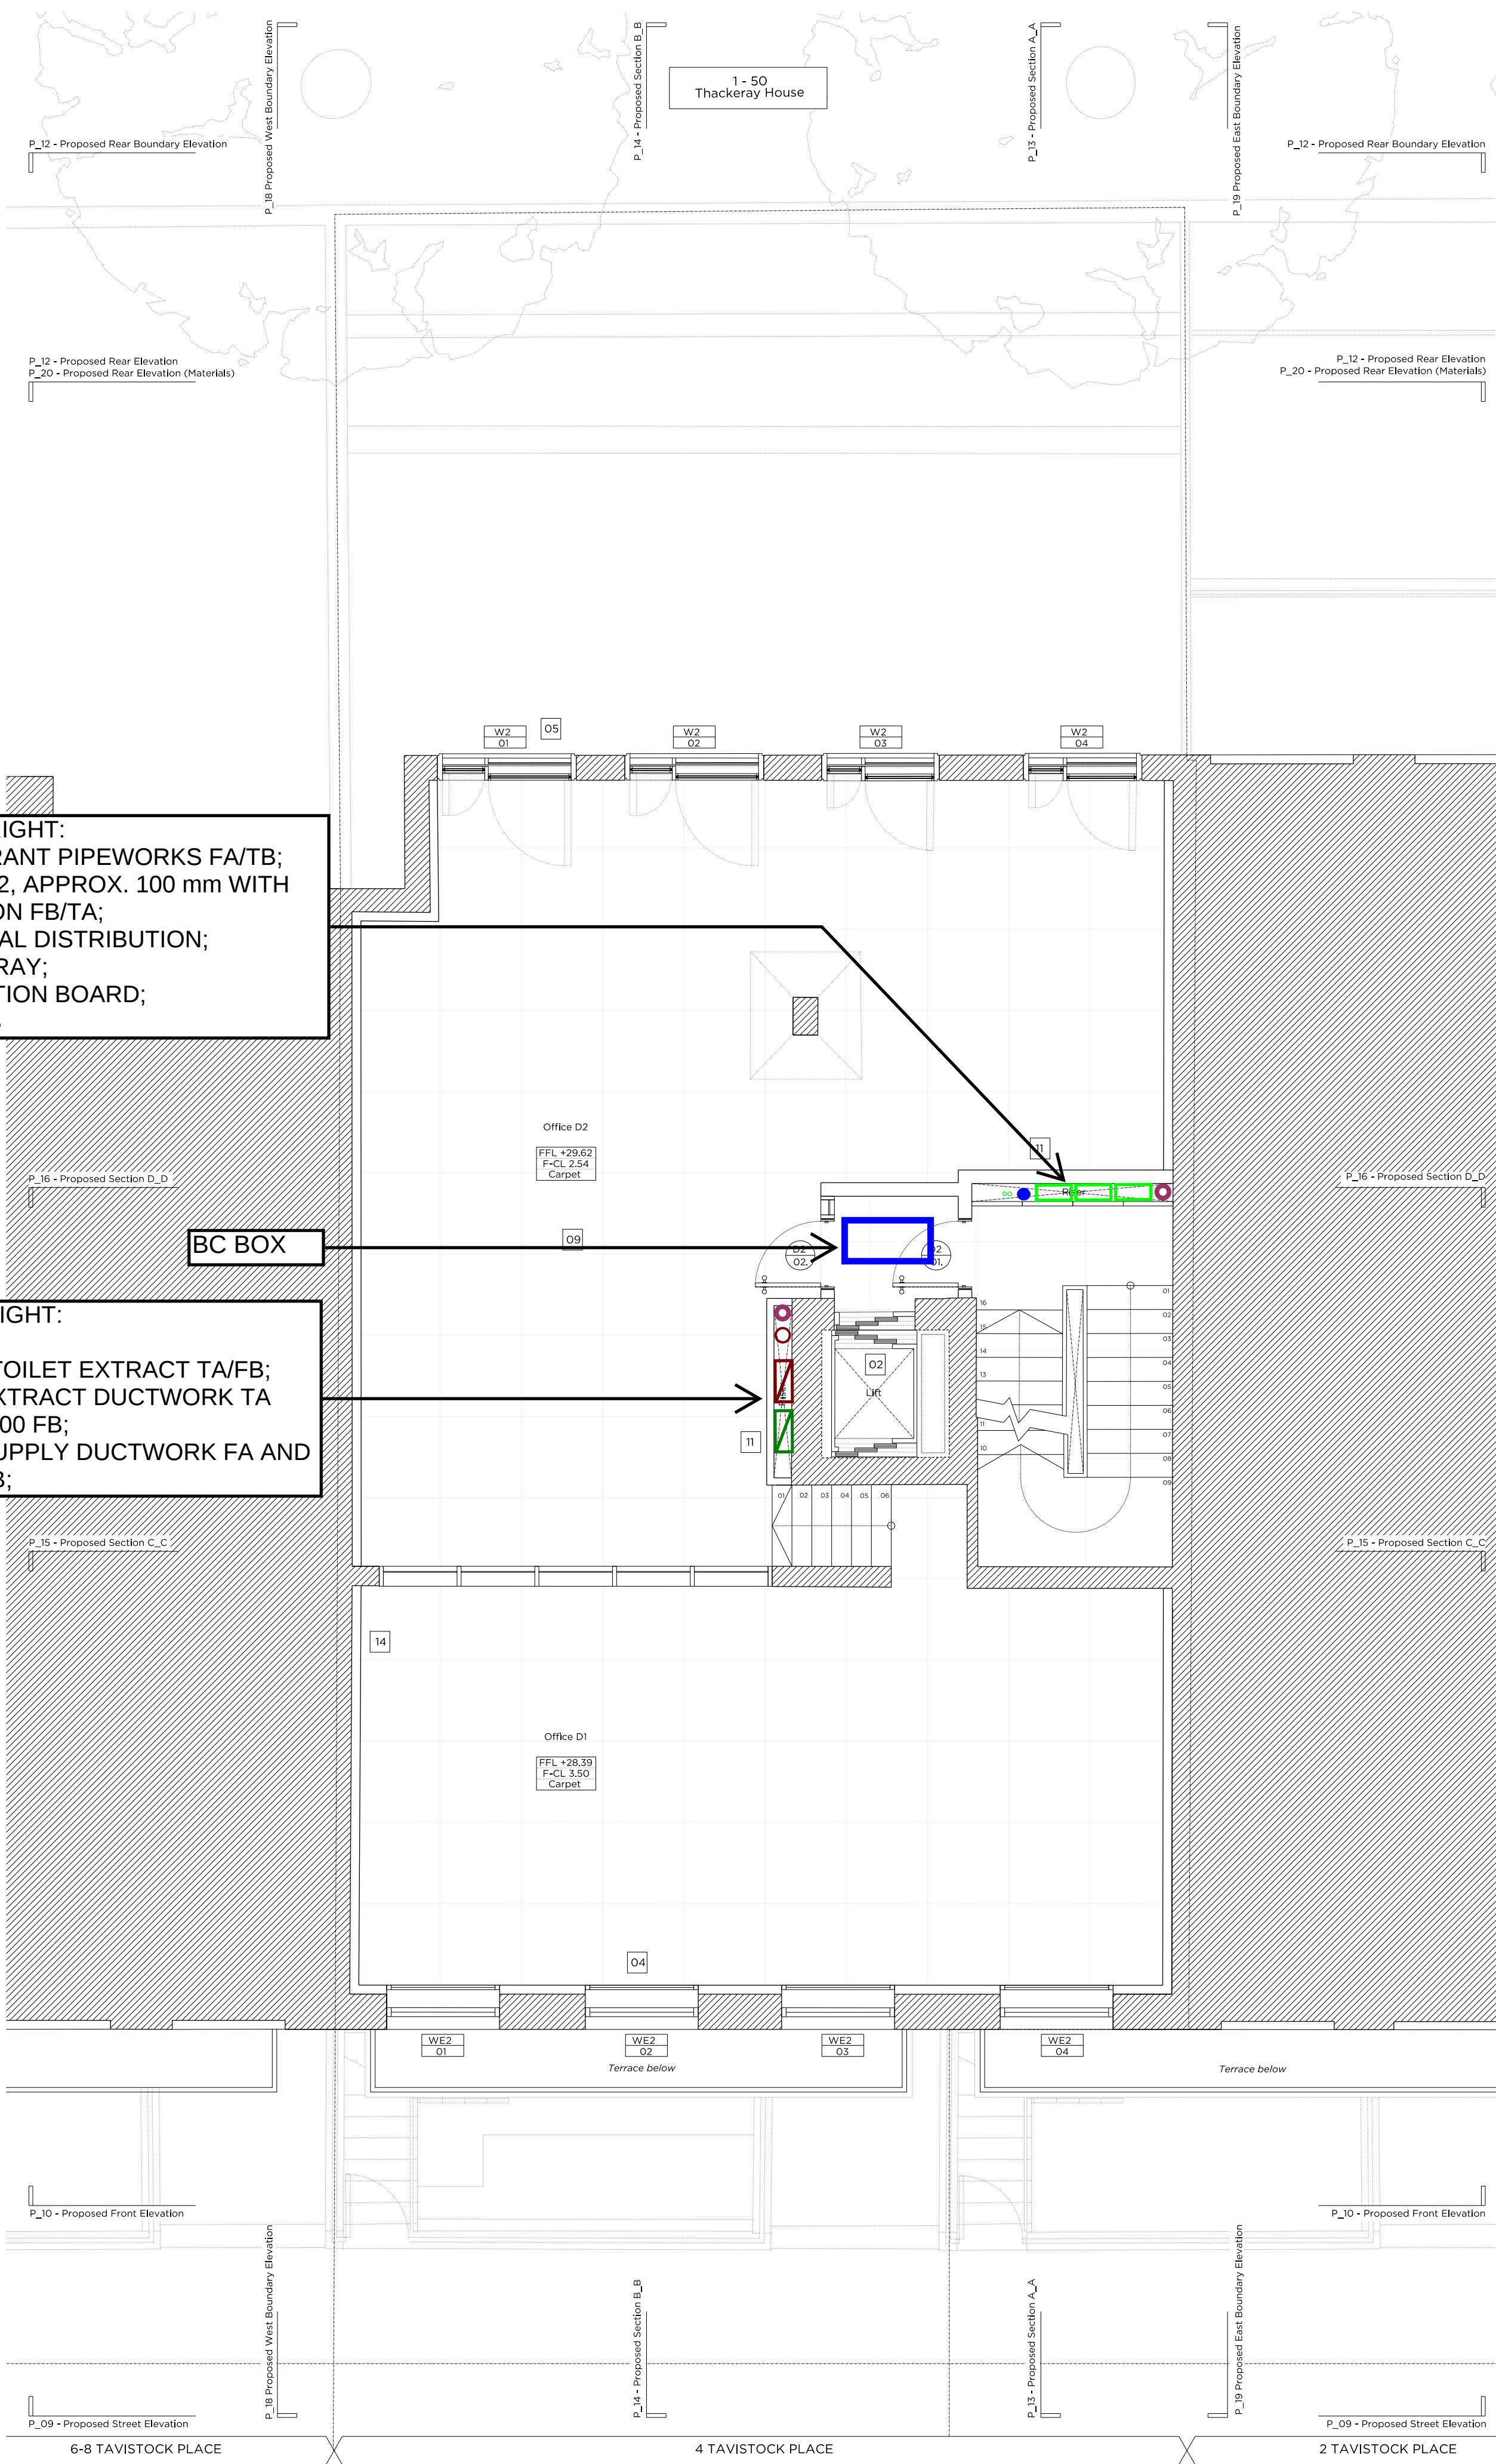

Proposed Second Floor Plan

Legend

- Electrical Meter
- Distribution Board/Consumer Unit
- Lighting Dimming Rack
- Satellite
- AV Rack
- FAP Fire Alarm Panel
- IAP Intruder Alarm Panel
- Electric Meter
- B Boiler
- WH Water Heater
- Radiator
- Towel Rail Wet/Electric
- UFHW Wet Under Floor Heating
- UFHE Electric Under Floor Heating
- Trench Heater
- WS Water Softener
- Combined Booster & Break Tank
- Water Meter
- Gas Meter
- Extract Fan
- VRF Condenser
- FCU Fan Coil Unit (FCU)
- FCU Pipework
- FCU Supply Ductwork
- FCU Extract Ductwork
- Service Trench
- HM Heating Manifold
- MVHR Mechanical Ventilation Heat Recovery Unit (MVHR)
- MVHR Supply/ Intake
- MVHR Extract/Exhaust
- Noise Attenuator
- Cooker Hood
- Grille/Diffuser
- Shadow Gap
- Ceiling Mounted Extract Air Valve
- Louvre
- AB Air Brick
- AC Acoustic Louvre
- AE Acoustic Enclosure
- LTHW Flow/Return
- MCW (BCWS)
- SVP
- Flue (single)
- Flue (twin)
- Hose Union Bib Tap
- Dry Riser

CUNDALL

Project: 4 Tavistock Place II
Project No: 1013779 Drawing Title: Second Floor Services Layout
Drawing No: 1013779-ME-02-01 Rev A
Drawn By: VFG Check By: IM Verified By: -
Date: 2016-08-30