

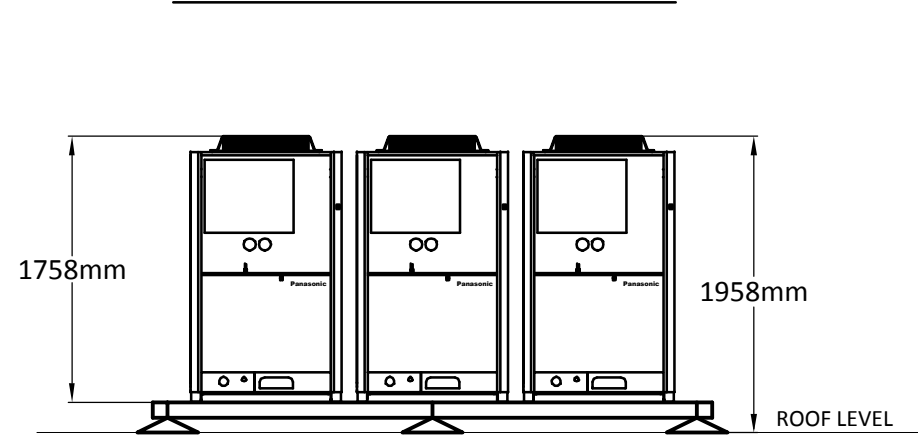


PLANT HEIGHTS ABOVE ROOF

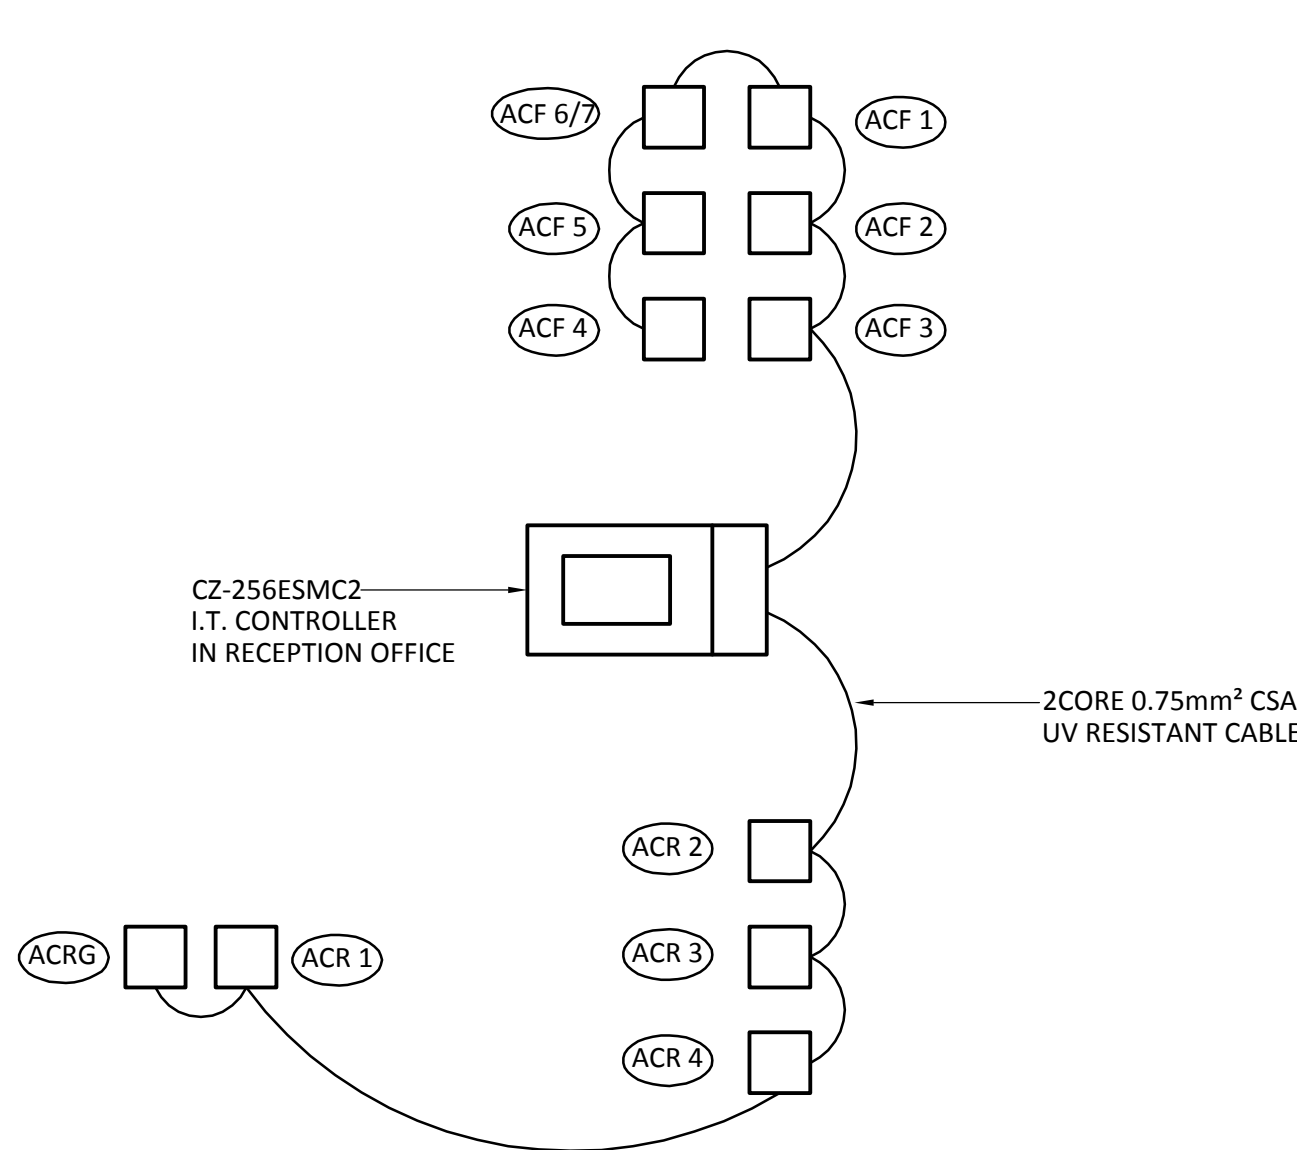

AC UNIT ELEVATION (1:50@ A1)

ROOF TOP REFRIGERATION
PIPEWORK SUPPORT
(NTS)

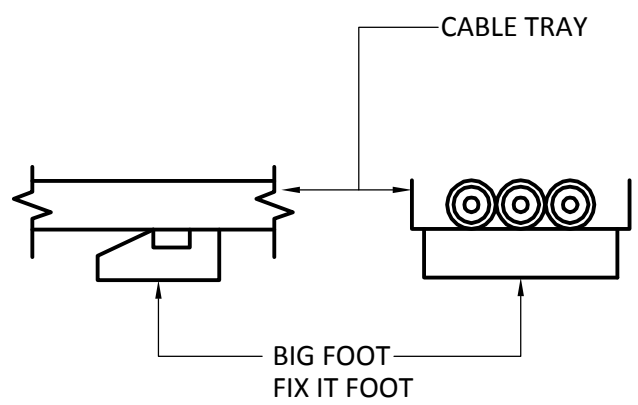

AC DATA CABLE SCHEMATIC (NTS)

NOTE:

ALL CABLES TO BE NEATLY SERVED ON CABLE TRAY/CONTAINMENT

EXISTING ROOFSCAPE PHOTOS

PHOTO A



PHOTO B



PHOTO C


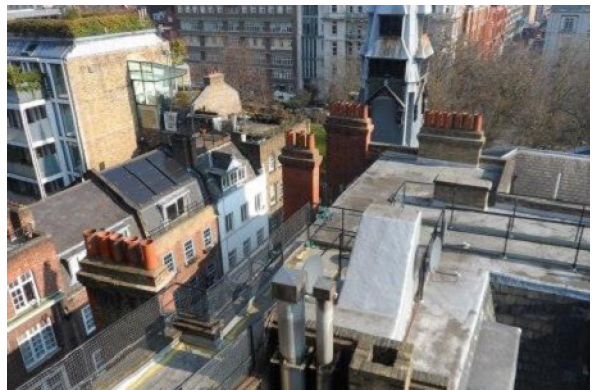



PHOTO D



PHOTO E

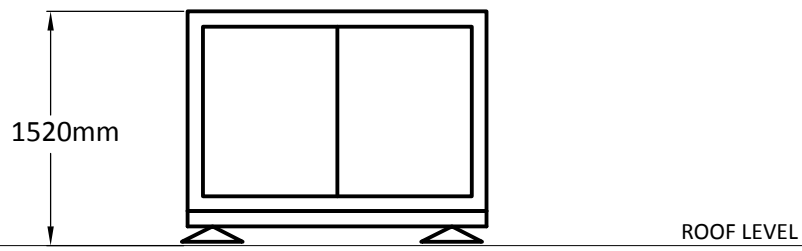

BOOSTER SET GRP HOUSING ELEVATION (1:50@ A1)

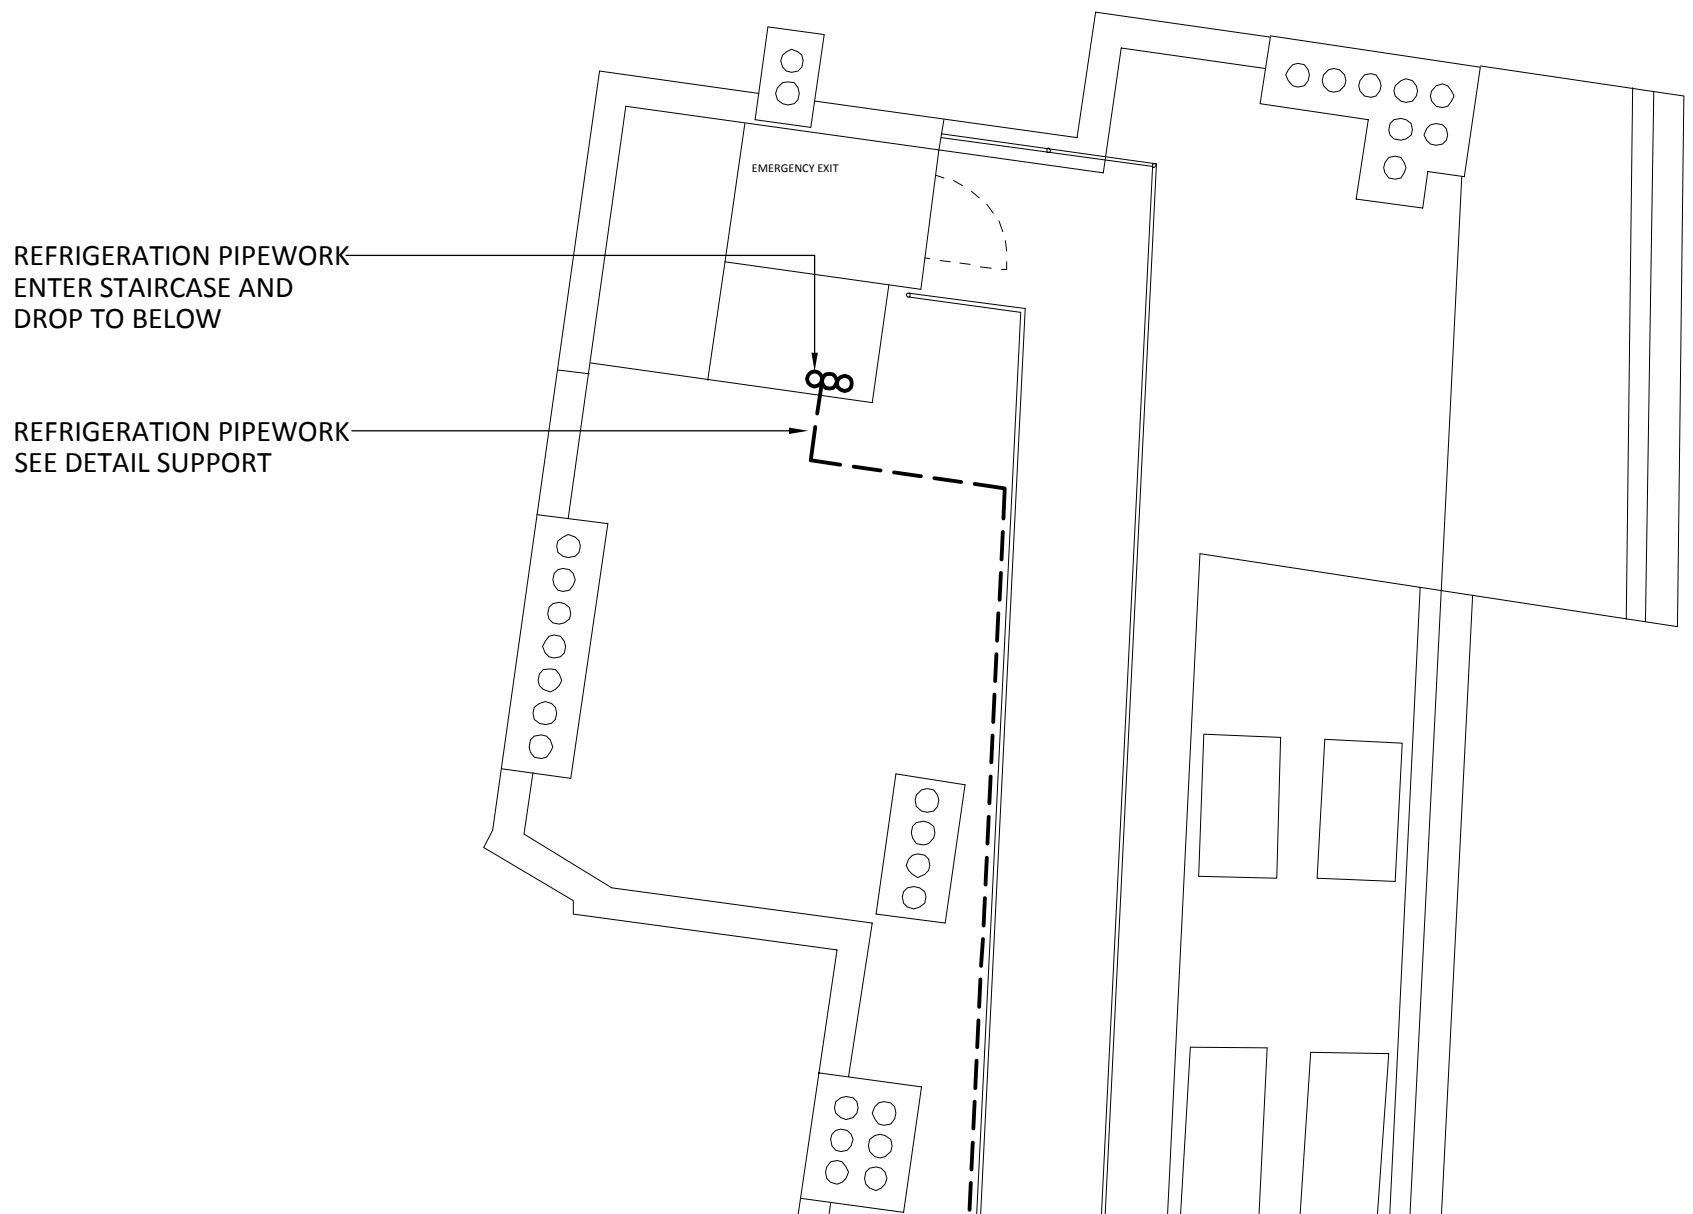

5No. AC CONDENSERS ON BIG FOOT SUPPORT FRAME 270Kg EACH CONDENSER

PHOTO D

PHOTO C

PHOTO E

REFRIGERATION PIPEWORK ENTER STAIRCASE AND DROP TO BELOW

REFRIGERATION PIPEWORK PASS THROUGH PARAPET DROP ON EXTERNAL WALL

6No. AC CONDENSERS ON BIG FOOT SUPPORT FRAME 270Kg EACH CONDENSER

DIMENSIONS OF BIG FOOT FRAME

DIMENSIONS OF BIG FOOT FRAME

REFRIGERATION PIPEWORK SEE DETAIL SUPPORT

SUPPLY & FIT ALUMINIUM, CHEQUER PLATE RAMPED WALKWAY OVER AC PIPES / CABLES PAINTED WITH BLACK & YELLOW CHEVRONS

mmØ DIVERT EXISTING COLD WATER SERVICE TO NEW BOOSTER SET THEN CONNECT BOOSTER TO EXISTING DOWN SERVICE SEE SCHEMATIC

VISUALS OF EQUIPMENT

PROPOSED ROOF TOP
COMBINED MECHANICAL LAYOUT



BOOSTER PUMP HOUSING COLOUR RAL AIRCRAFT GREY 00A05

DO NOT SCALE FROM THIS DRAWING
DRAWING TO BE READ IN CONJUNCTION WITH SPECIFICATION


Rev.	Date	Description	Drawn	Orig.	Chk'd
P1	17/05/16	ISSUED FOR INFORMATION	SAM	PJD	-
P2	27/09/16	AC CONDENSER LOCATIONS REAR ROOF REVISED.	E.V.	PJD	PL

Client
GLH

Project
BLOOMSBURY PARK HOTEL LONDON

Drawing Title
PROPOSED ROOF TOP
COMBINED MECHANICAL LAYOUT

Davies M&E Partnership Ltd.
Cestrian House, Lightfoot Street, Hoole, Chester, CH2 3AD.
Tel: 01244 315568
Email - cad@daviespartnership.co.uk
www.daviespartnership.co.uk
Building Services Mechanical / Electrical Consultants.

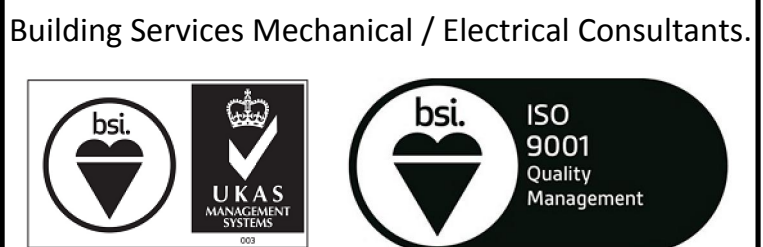

Date	Scale	Eng.
MAY. 16	1:100 @ A1 1:200 @ A3	PJD
Status	Drw. No.	Rev.
I	16036/RCM	P2