


Appendix D . Proposed drainage layout

Detailed Unexploded Ordnance (UXO) Threat
assessment by 1st Line Defence Solutions



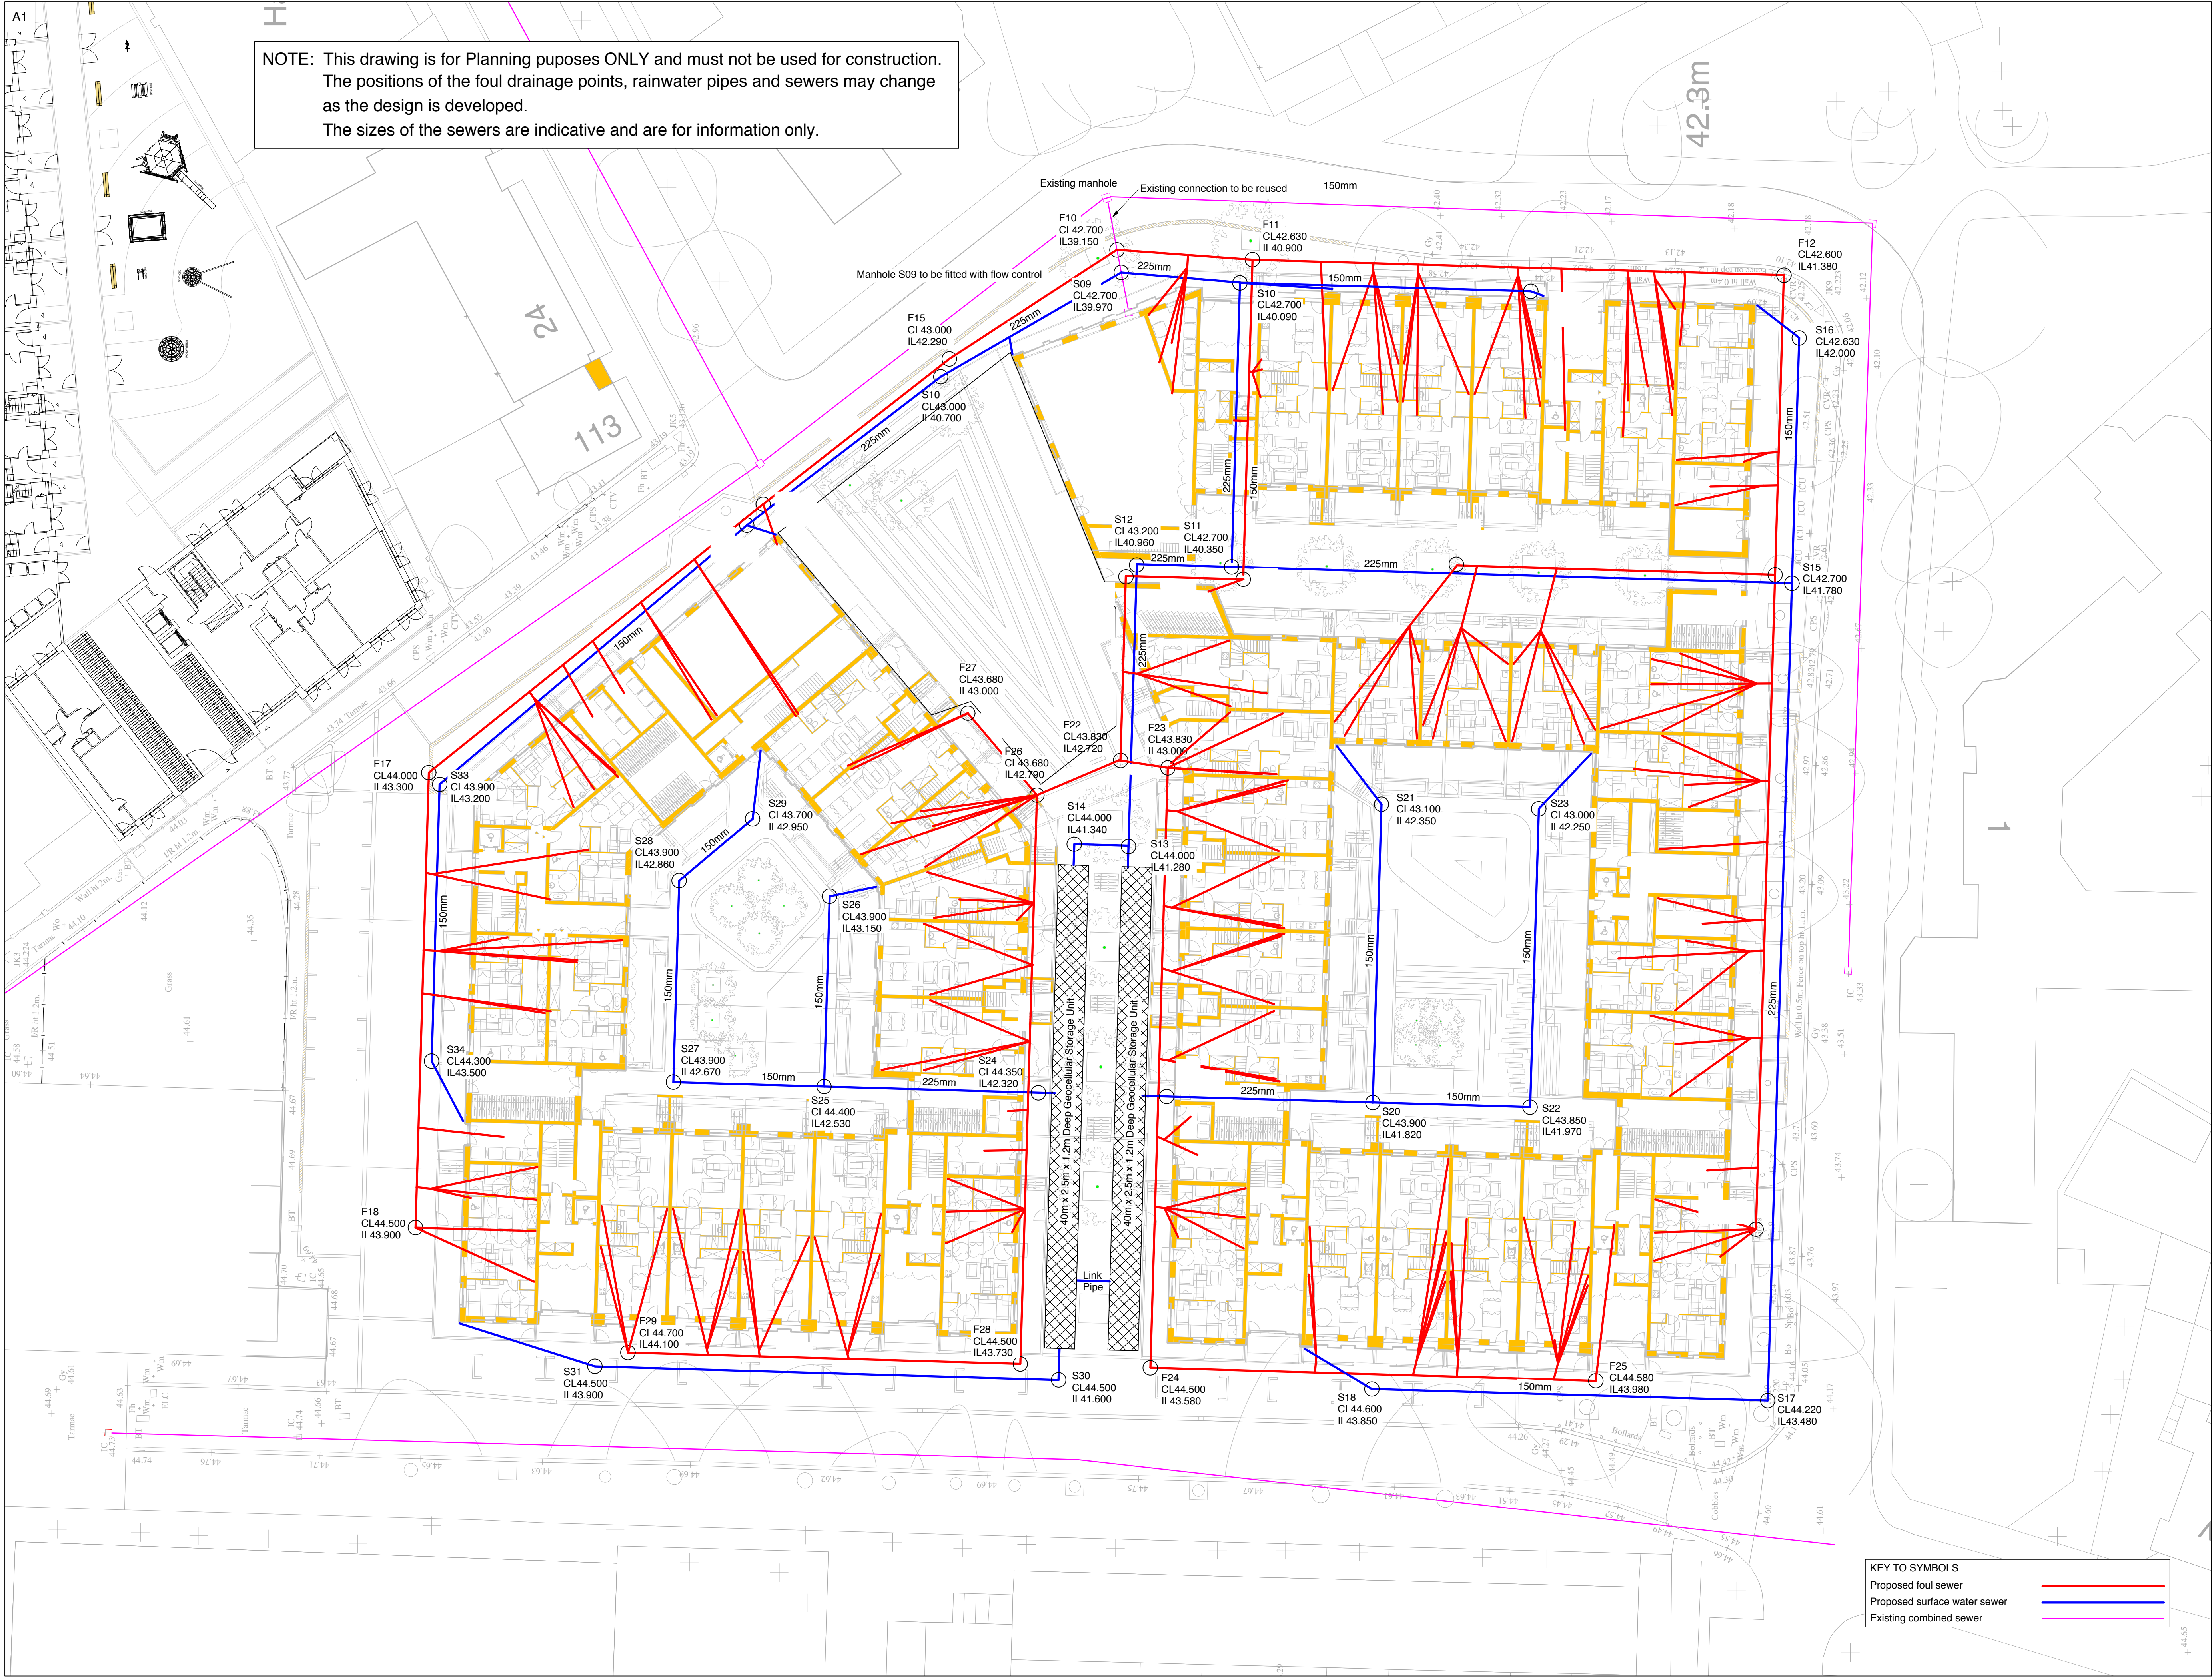

This drawing has been prepared for the sole benefit of the client named below. The liability of Momentum Consulting Engineers Ltd, its directors and employees in respect to this information will not extend to any other project.

This drawing shall not be reproduced in any form without prior permission being granted.

This drawing is to be read in conjunction with all other relevant contract documents and other consultants information.

Do not scale from this drawing. Responsibility is not accepted for errors made by others when scaling from this drawing.

The dimensional accuracy of the digital data contained within this drawing may not be a true representation of the actual dimensional setting out. Responsibility is not accepted for errors made by others when using digital data from this drawing.

Work only to figured dimensions.

Unless indicated otherwise all levels are in metres and all dimensions are in millimeters. All levels and dimensions should be checked on site by the persons carrying out the work and any discrepancies notified to Momentum before proceeding with relevant works.

Where information on this drawing is not clear please contact us.

NOT FOR CONSTRUCTION

7	23.09.16	MDW
6	16.09.16	MDW
5	15.08.16	MDW
4	31.08.16	MDW
3	23.08.16	MDW
2	23.08.16	MDW
1	15.08.16	MDW
Revision	Date of Issue	By

Issue History

Work Stage - ACE / (RIBA)

RIBA Stage 2

Issue Status

Planning

Project Title

Bacton Low Rise II

Client

London Borough of Camden

Architect

Karakusevic Carson Architects

Drawing Title

Indicative Drainage Layout

Scale

1:500

Drawn

MDW

Checked

90 Walcot Street
Bath BA1 5BG
01225 444194

103 The Timber Yard
London N1 6ND
0207 739 6939

www.momentumengineering.com

Drawing Reference

2880 600 7