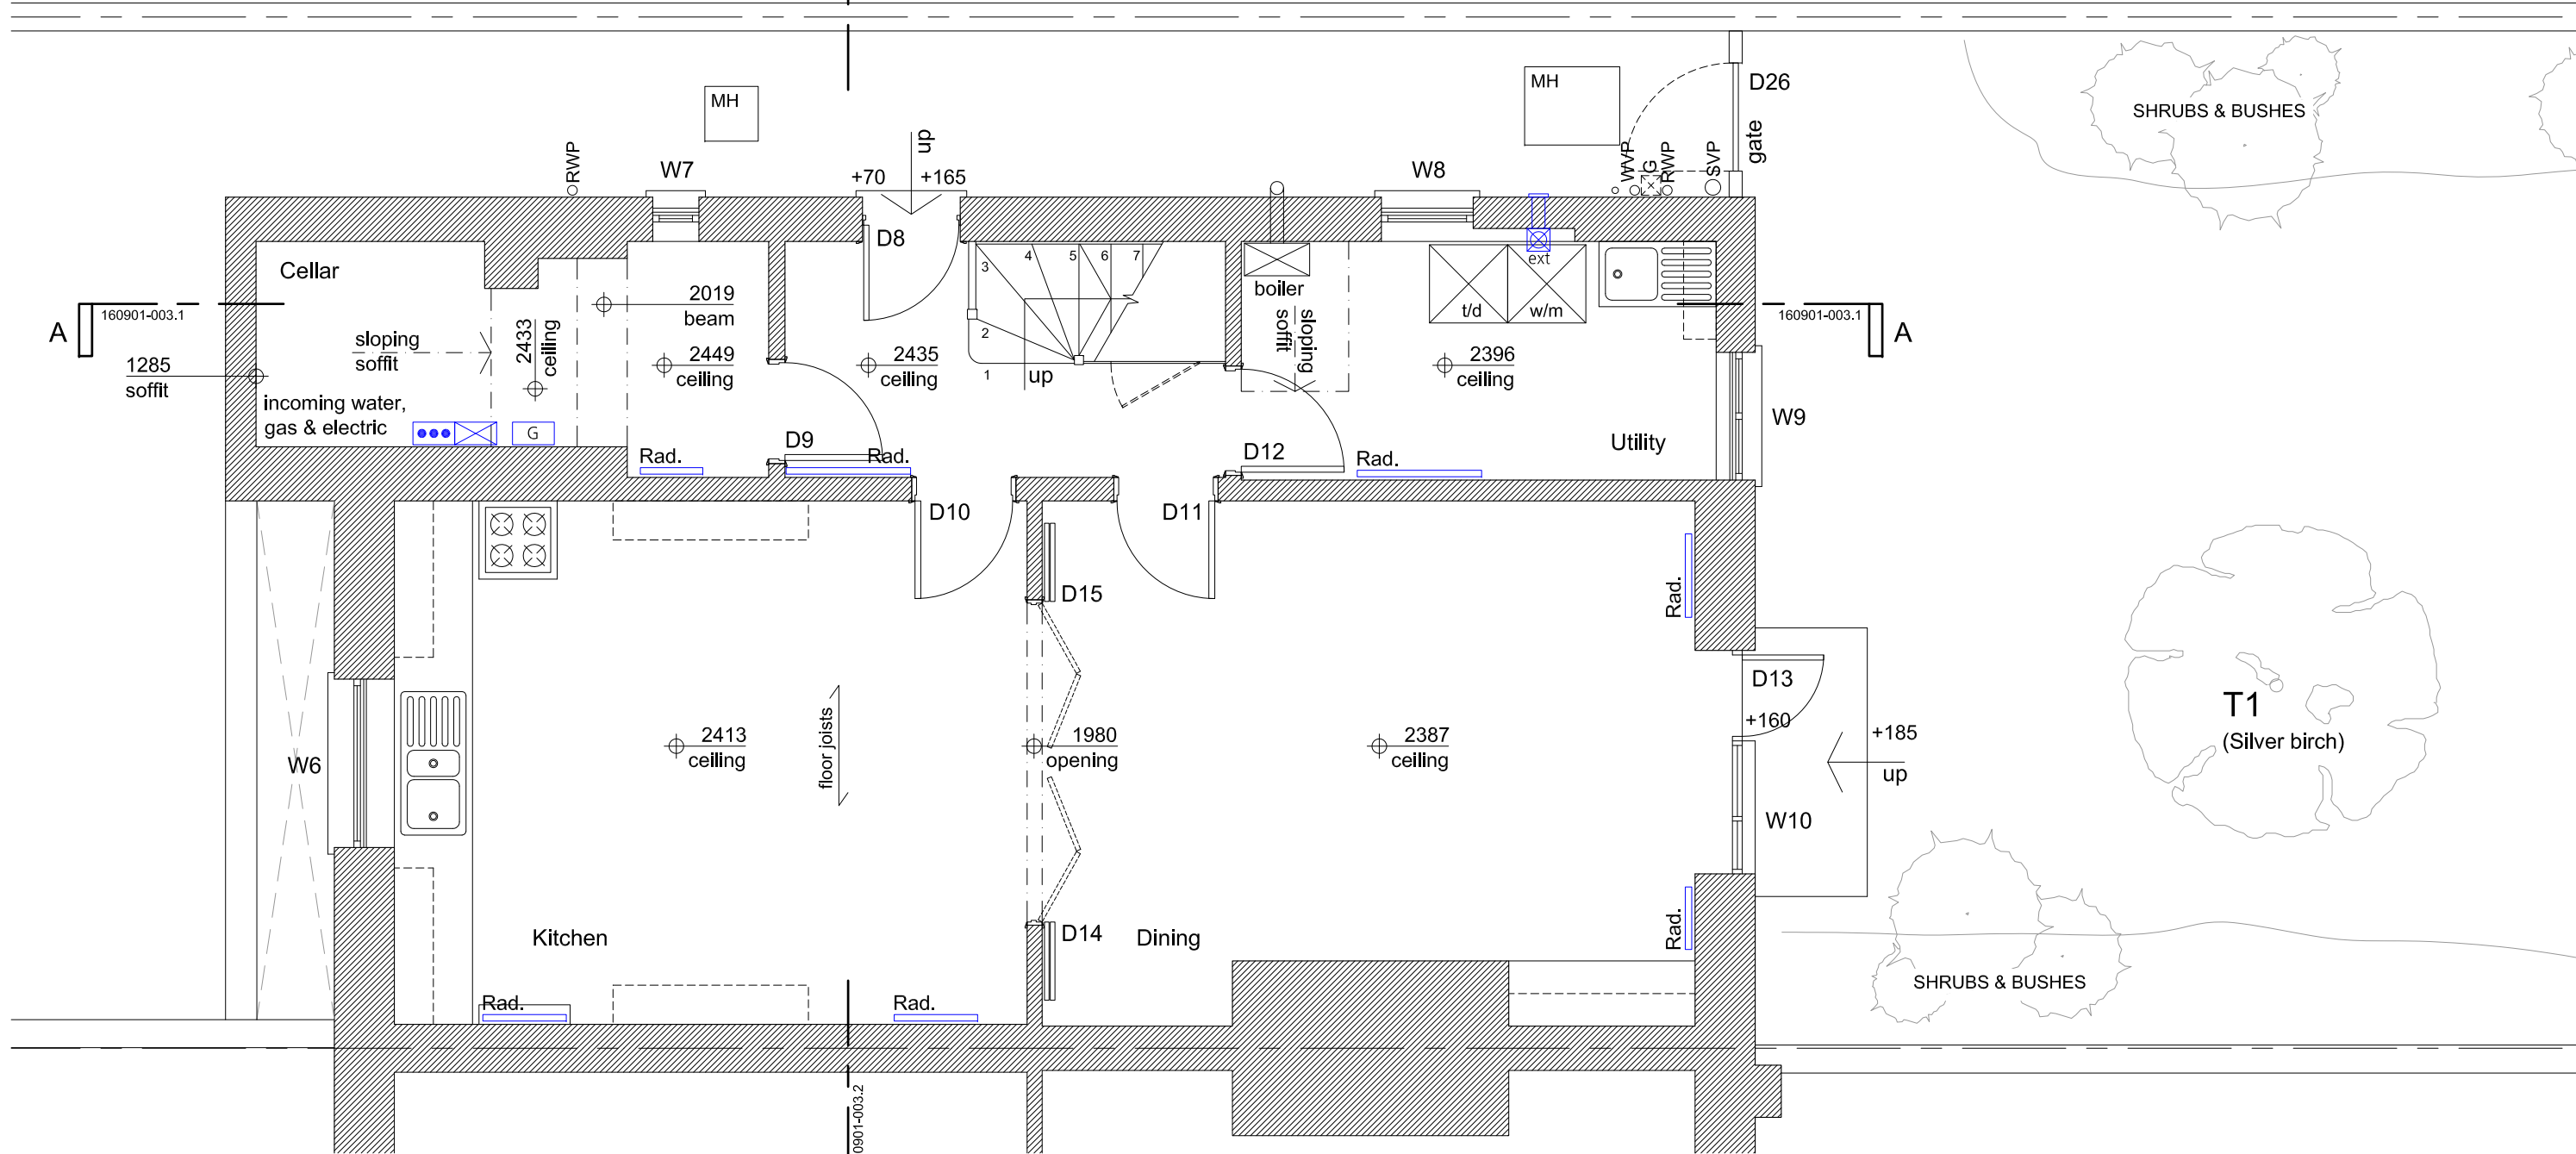




 
 
 

B
160901-003.2



**Lower Ground Floor Plan
as Existing**

Scale 1:50 @ A3

KEY

-  Existing Electrical mains / meter
-  Existing Electrical distribution / switchgear
-  Gas Meter
-  Telecom box
-  Existing Ceiling mounted smoke detector
-  Existing Extractor fan



Notes:
1. All sizes to be taken and checked on site by the contractor prior to preparation of shop drawings or fabrication of parts.
2. This drawing should not be scaled. Any discrepancies to be brought to the immediate attention of the designer.
COPYRIGHT OF DESIGN AND DRAWING RESERVED

Project	1 PROVOST RD, LONDON NW3 4ST
Client	MISHAL HUSAIN & MEEKAL HASHMI
Title	LOWER GROUND FLOOR PLAN AS EXISTING
Project No.	160901
Scale	1:50 @ A3
Drawn	CAD

Issue Purpose

PLANNING

Dwg. No.	160901-001.1
Date	SEPT 2016
Revision	

absolute detail

t + f 01628 528492

m 07824 641414

e alison@absolutedetail.me

w absolutedetail.me