


DRAWING TO BE READ IN CONJUNCTION WITH HIGH LEVEL SERVICES CO-ORDINATION DRAWING


*LAYOUT OF SERVICES SHOWN NOTIONALLY - IT MUST BE CO-ORDINATED WITH MECHANICAL, SPRINKLERS, LIGHTING ETC

NOTE:
Partition Installers to locate their stud positions to avoid mechanical plant passing through & work inconjunction with mechanical engineers details

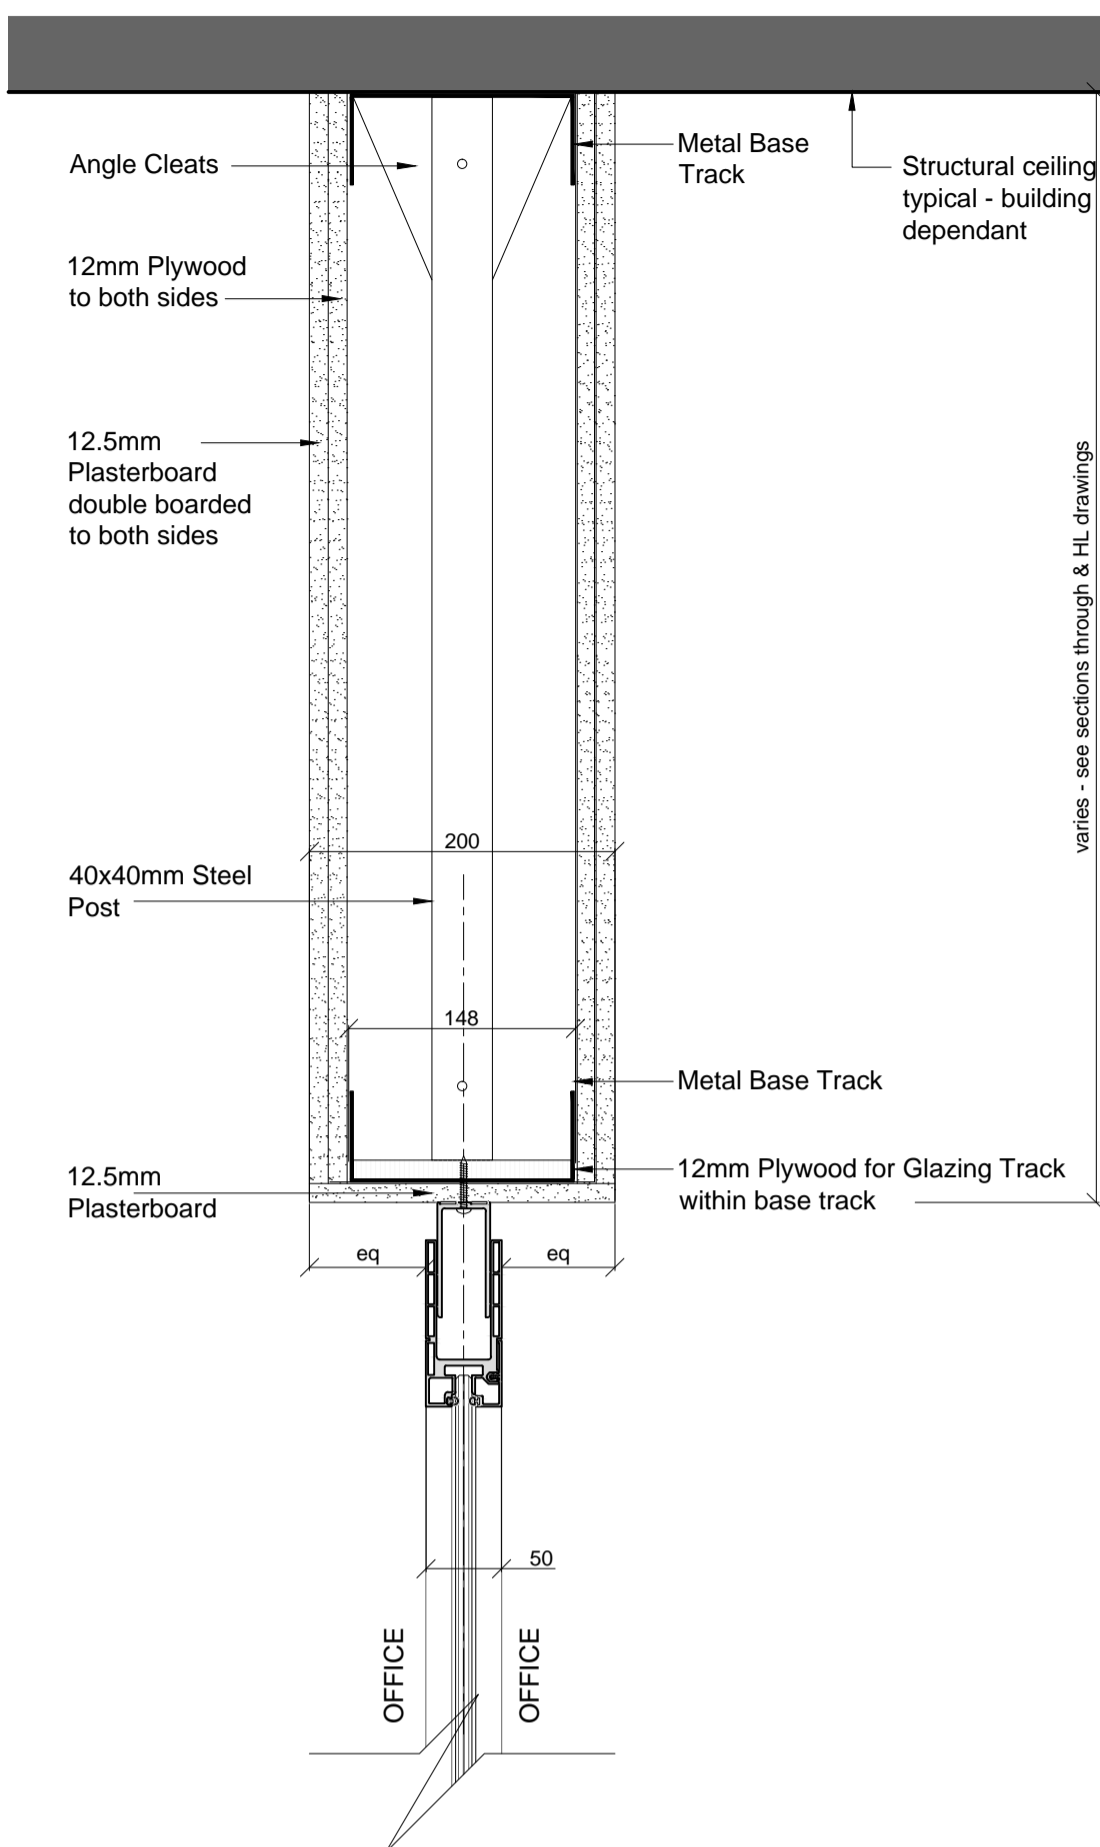


DETAIL P1
*showing partition cross partitions (centred)

TYPICAL BULKHEAD TO STRUCTURAL CEILING
SCALE 1:5

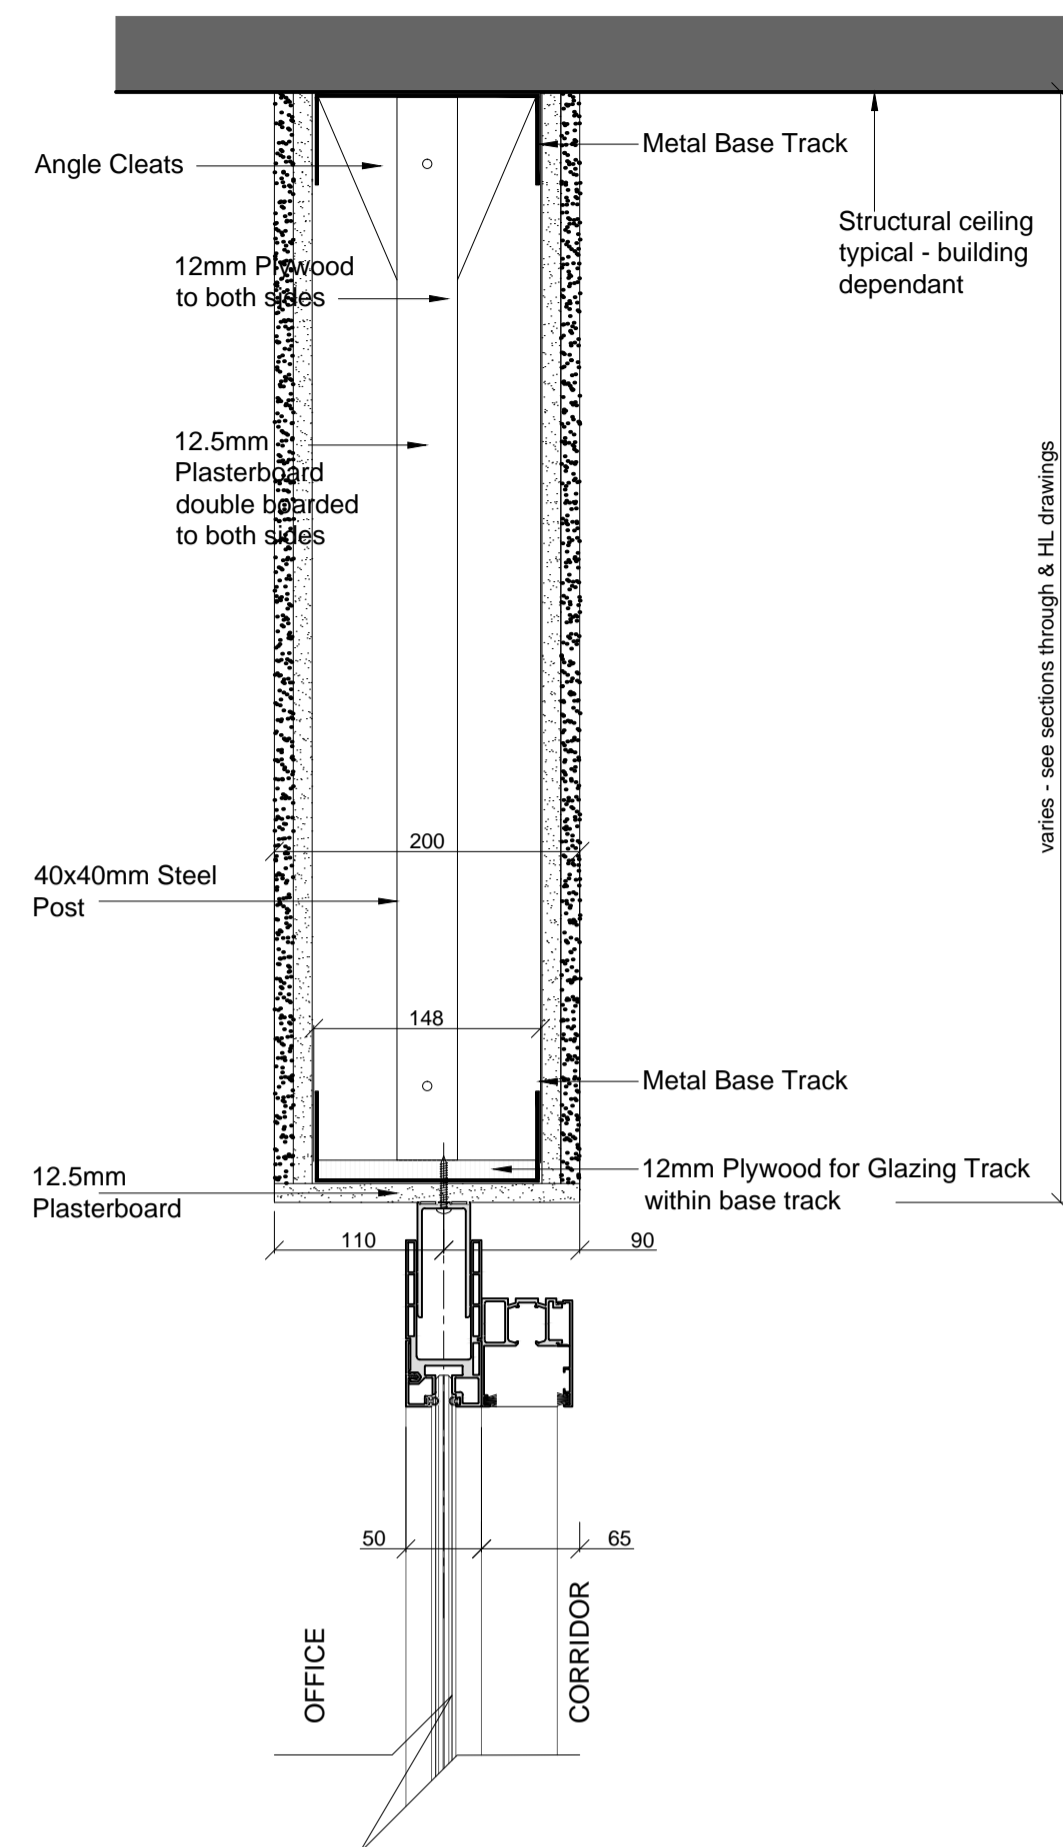


DETAIL P2
*showing partition corridor partitions (65mm offset with sliding doors on corridor side)

TYPICAL BULKHEAD TO STRUCTURAL CEILING
SCALE 1:5

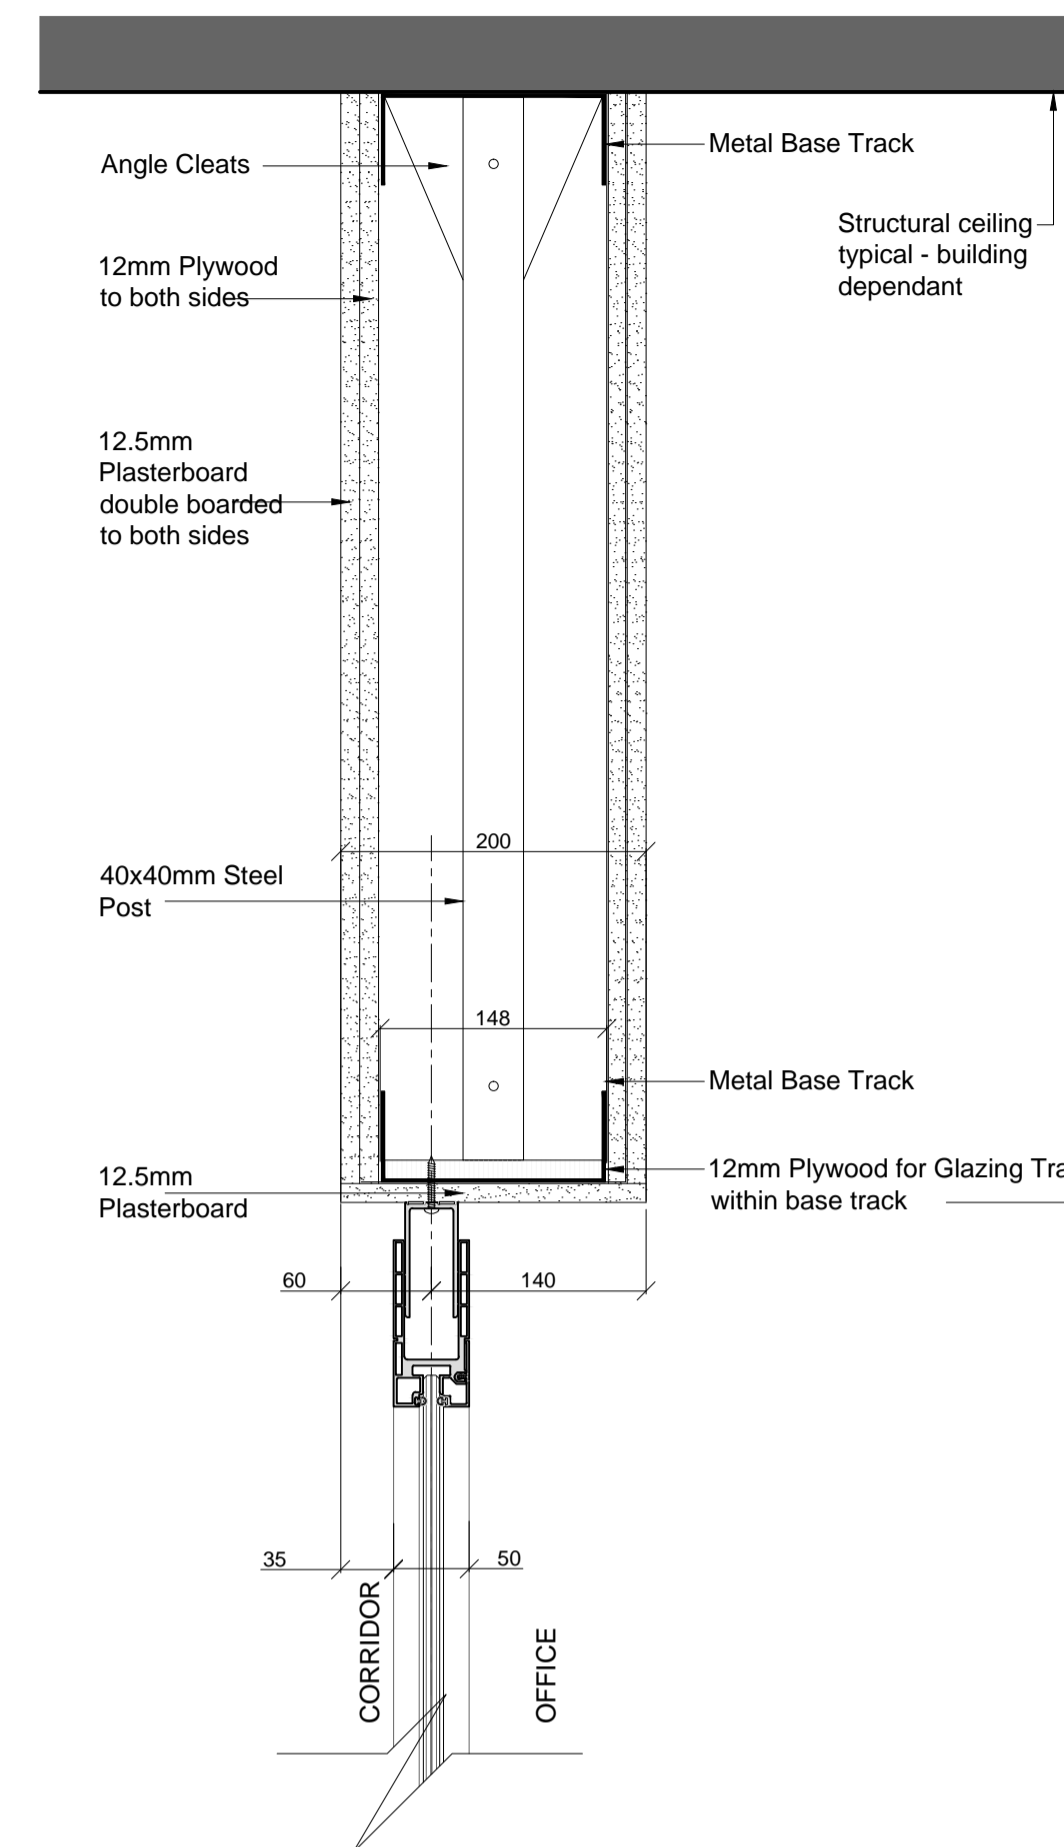


DETAIL P3
*showing partition corridor partitions (35mm offset with NO sliding door on corridor side)


TYPICAL BULKHEAD TO STRUCTURAL CEILING
SCALE 1:5

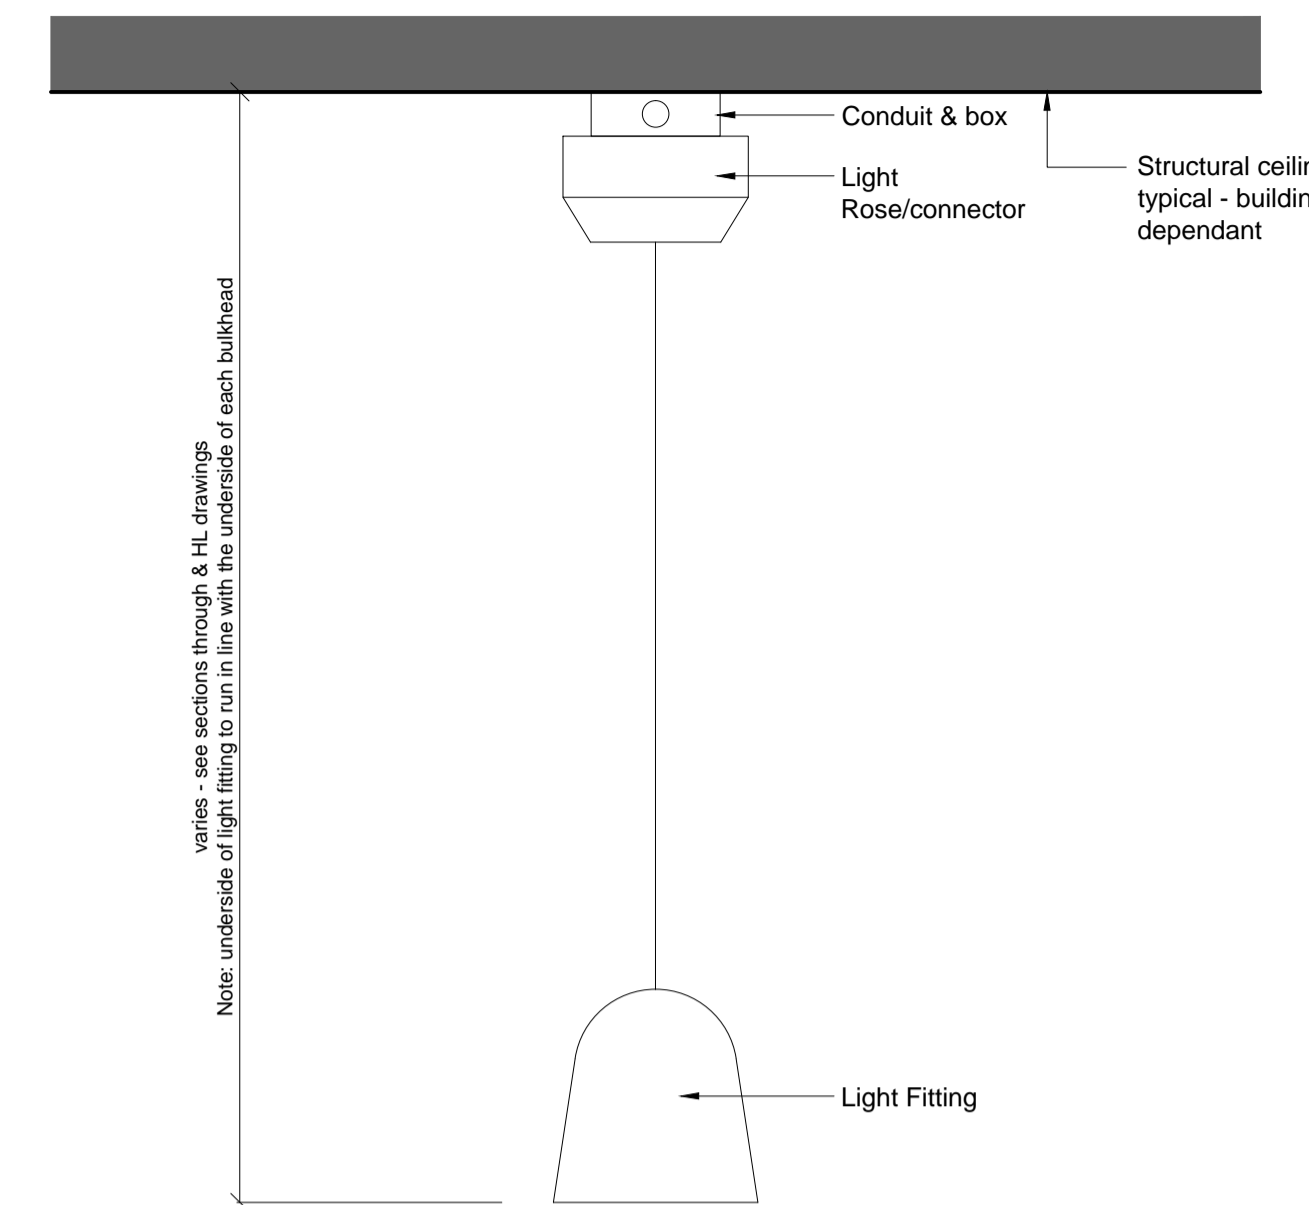


DETAIL P4
TYPICAL PENDANT LIGHT TO STRUCTURAL CEILING
SCALE 1:5

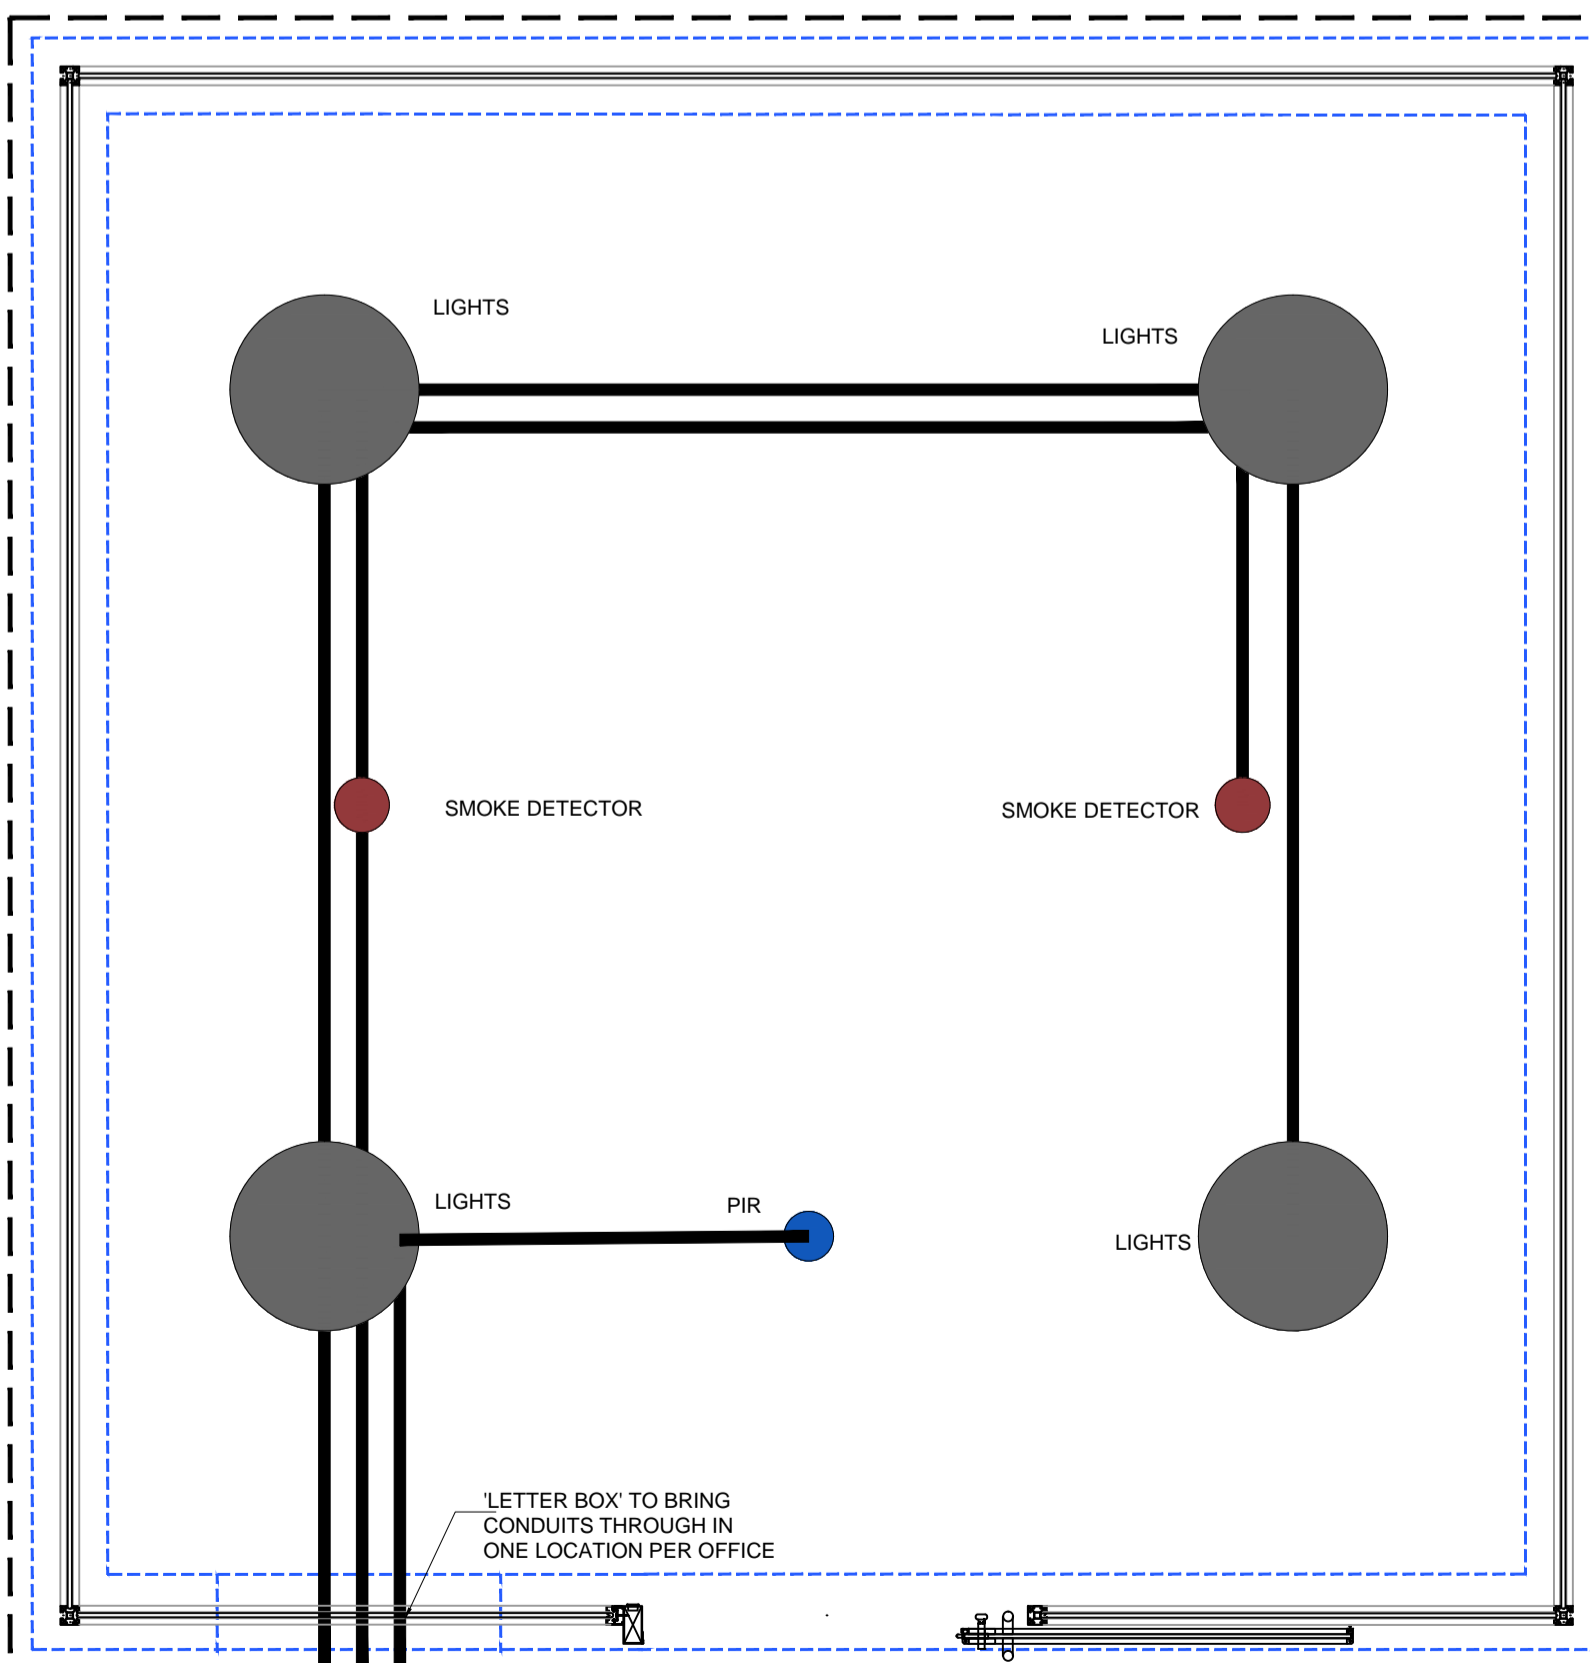


TYPICAL OFFICE IN PLAN VIEW TO SHOW CONDUIT ROUTES/CONCEPT
SCALE 1:20

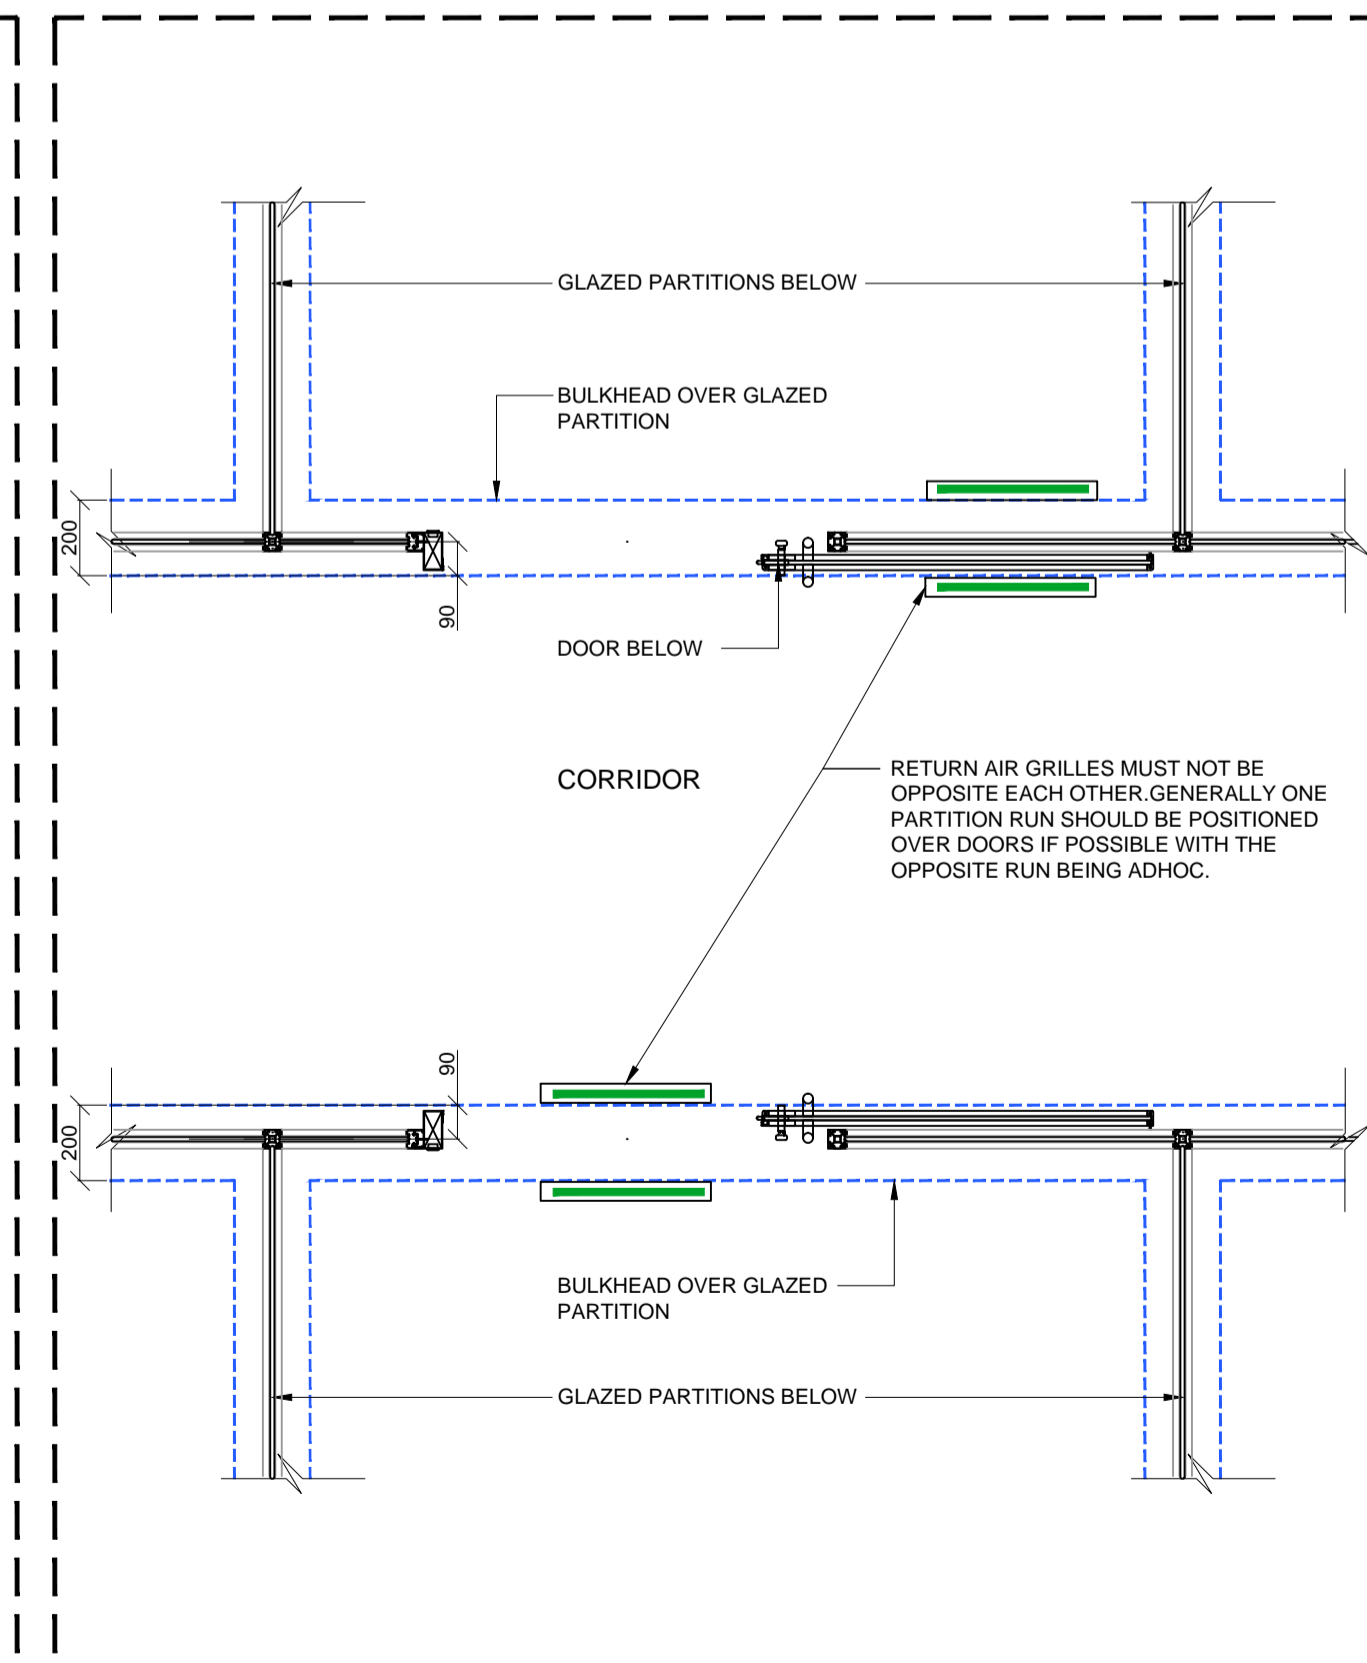

TYPICAL OFFICE BULKHEAD PLAN (sliding door arrangement)
SCALE 1:20

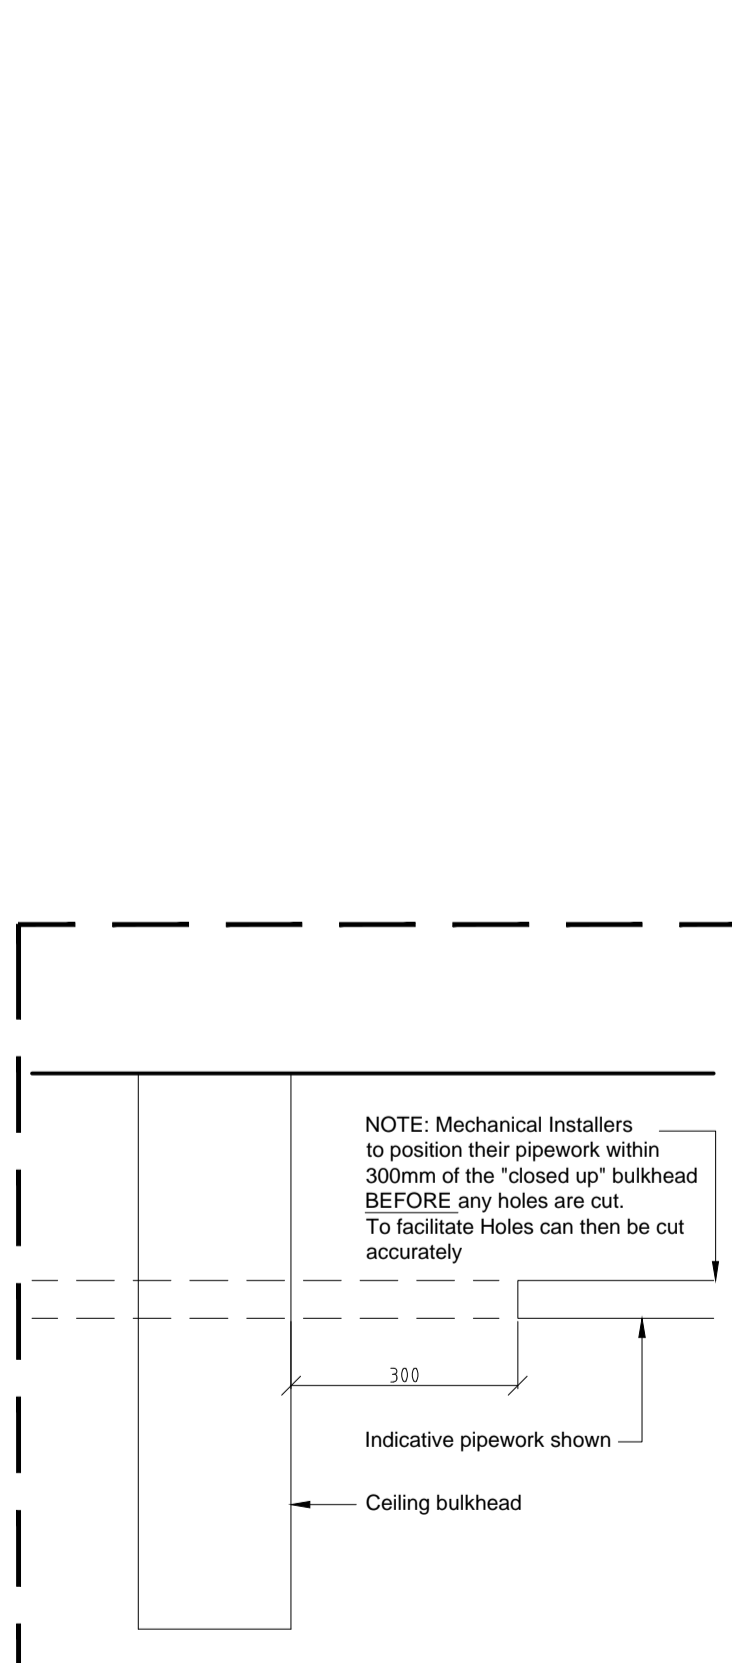

TYPICAL PIPEWORK PENETRATIONS
SCALE 1:10

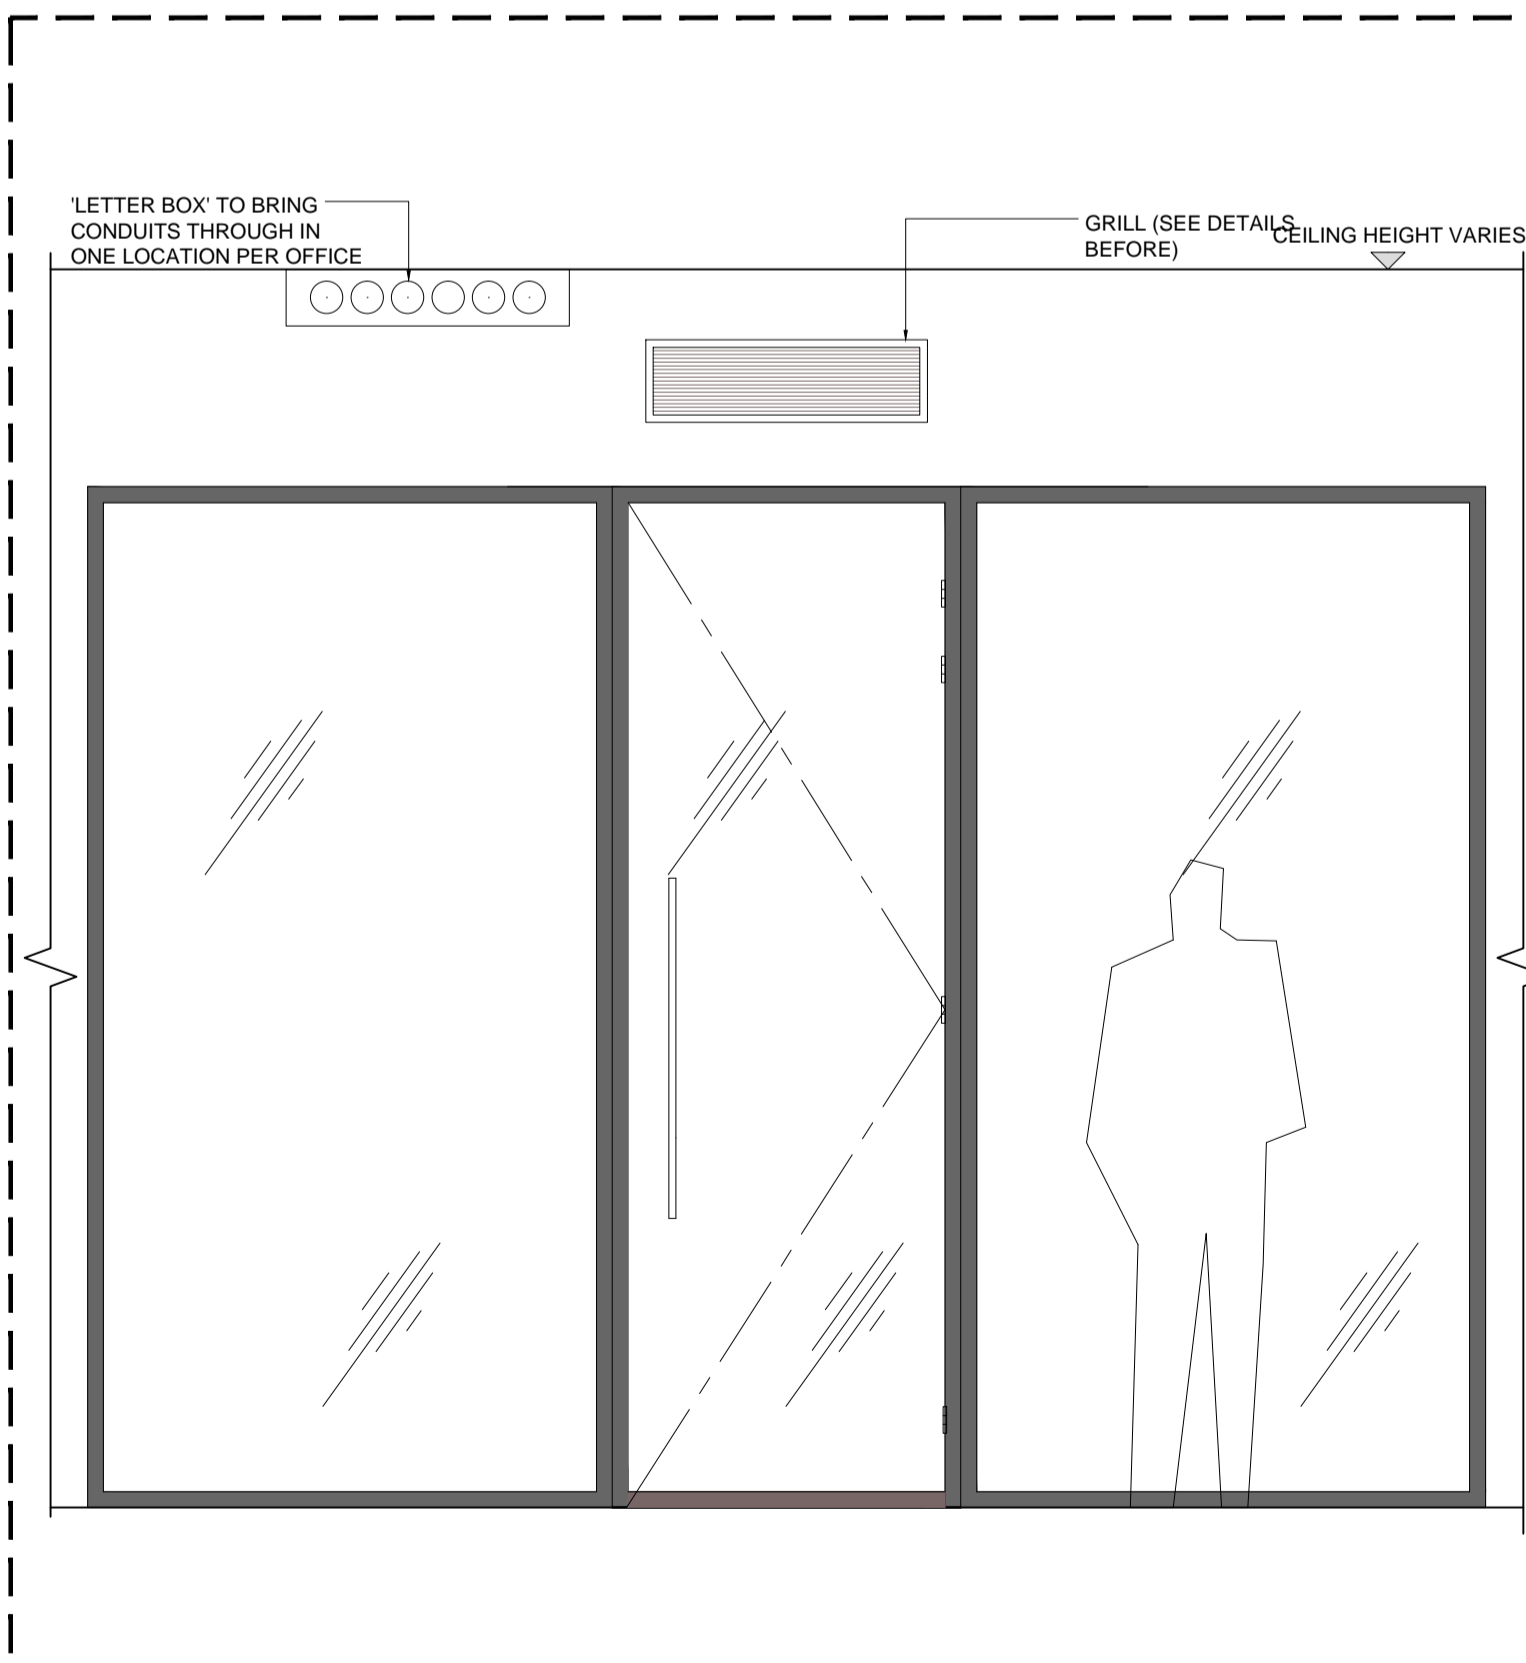

CORRIDOR ELEVATION OF OFFICE ENTRANCE
SCALE 1:20

Drawing first produced AN 24.06.16

Pre-Design - Construction - As Built
PRE DESIGN

Client
WeWork

Client Contact
Rob Gregory

Account Manager
Claire Elliott / Glenda Puntel / Martin Leeper

Scale **VARIES @ A1** Drawn by **AN** First Drawing Date **21/06/2016**

Contract Number **1041** Building **01** Floor **ALL** Detail **MS03** Revision **/**

ltb. 1st Floor
322 High Holborn
London WC1V 7PB
T: +44 (0)20 7553 9500