

- LEGEND:
- SF = SUPPLY FAN
 - EF = EXTRACT FAN
 - EG = EXTRACT GRILLE
 - SG = SUPPLY GRILLE
 - ATT = ATTENUATOR
 - L = LOUVRE
 - VCD = VOLUME CONTROL DAMPER

Rev:	Date:	Details:
L	01/04/16	Ventilation layout revised
K	30/03/16	AC Riser relocated
J	10/03/16	WC Extract & notes added
I	23/02/16	Roof layout & duct sizes revised
H	04/02/16	Cellarking condenser removed
G	06/01/16	Vent locations to Bed 3 & staff kitchen revised
F	03/12/15	Attenuators added
E	05/11/15	Extract duct revised & BW holes shown
D	28/10/15	Revised to suit received comments
C	15/10/15	Revised to suit site survey
B	13/10/15	AHU's & EF01 removed. New supply fan added kitchen canopy
A	03/08/15	Fan modes updated



Unit 19, Merlin Park
Mildenhall,
Suffolk,
IP28 7RD

Tel: 01638 716151 Fax: 01638 716141

This drawing is the copyright of A & K Air Conditioning Limited and is protected by the Design Copyright Act 1968. This drawing must not be copied or otherwise reproduced without the express written consent of A & K Air Conditioning Limited.

All dimensions unless stated, in mm

Drawn: R Butcher	Date: 09/07/2015
Checked:	Date:
Scale: 1:50 @ A1	

Drawing Description:

Third Floor Ventilation Layout


Client:

Wingrove

Project:

Fitzroy Tavern

Drawing No.	Rev. / Issue:
4631 - 05	L

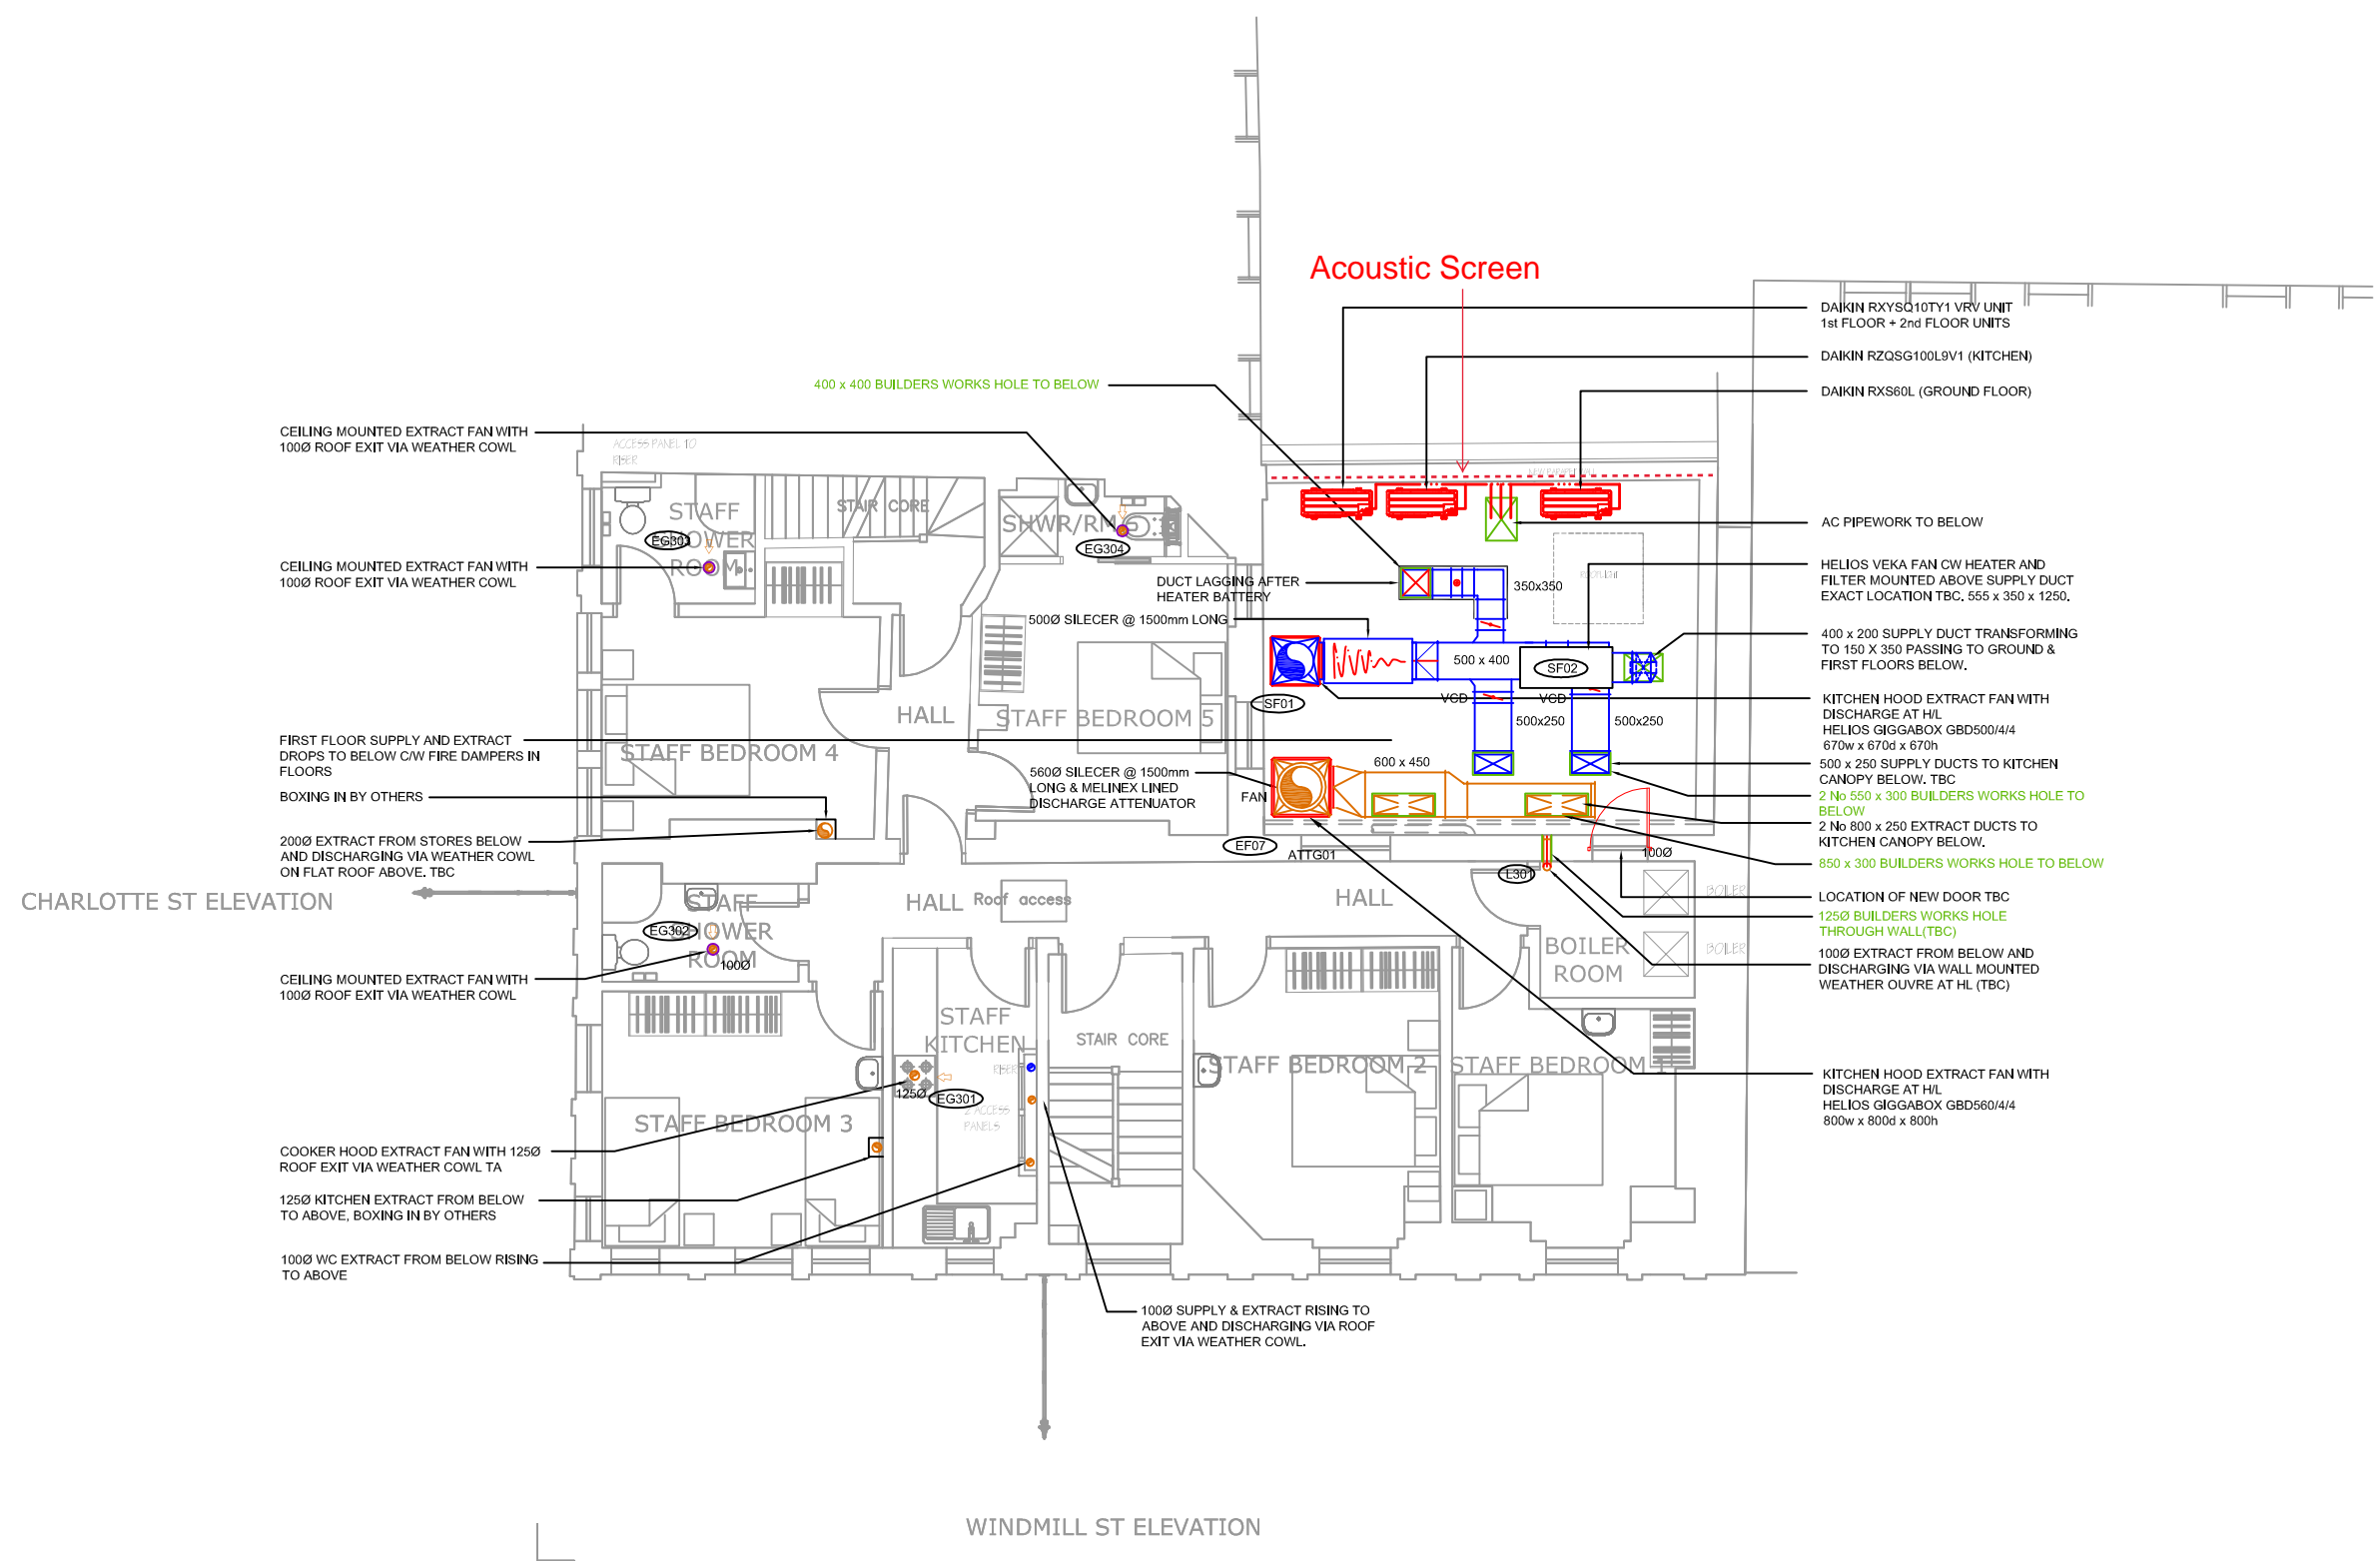

Third floor