


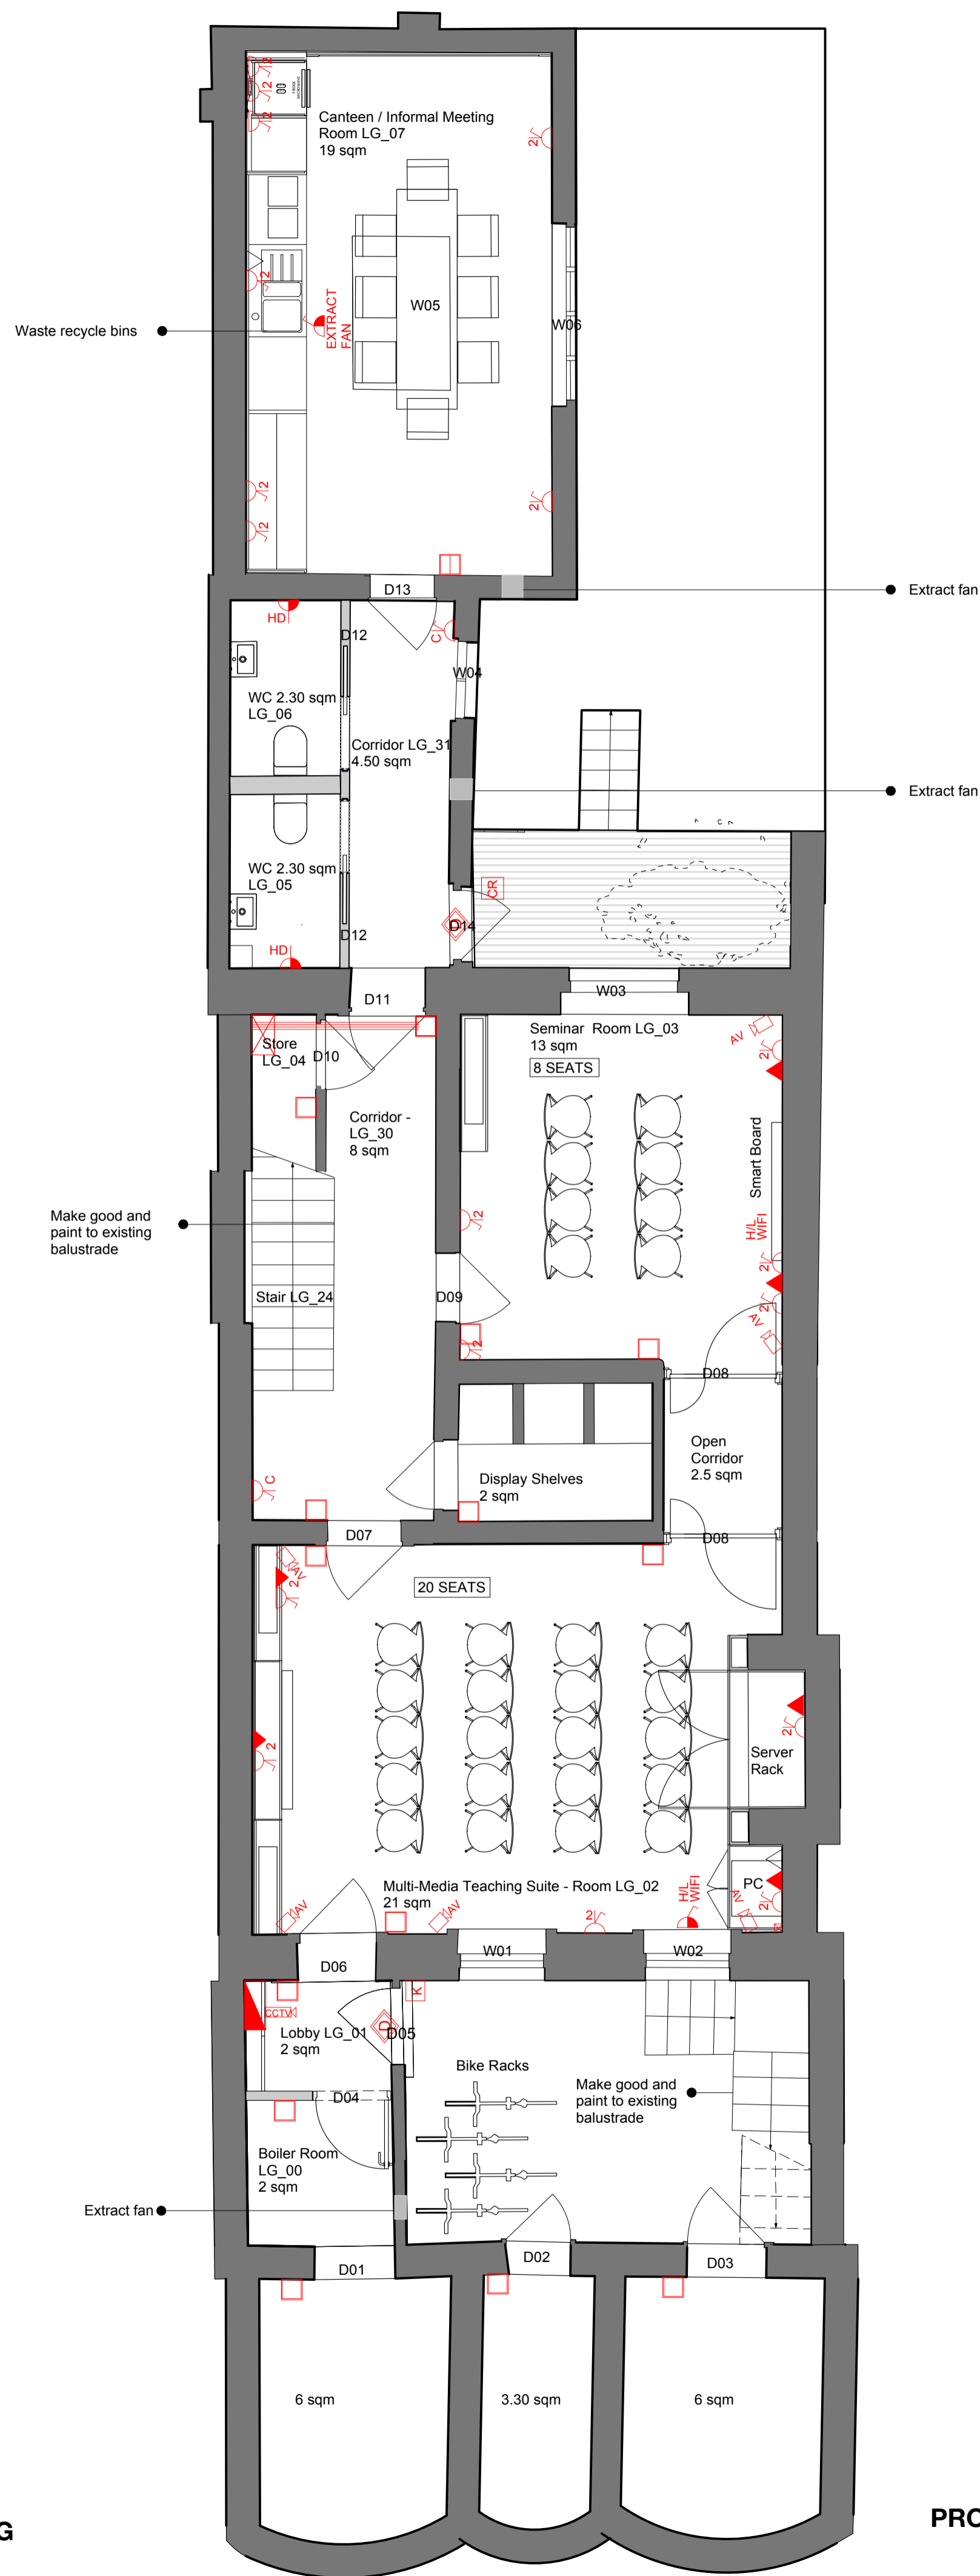
















EXISTING



PROPOSED

KEY

-  SIMPLE SWITCH
-  DOUBLE SWITCH
-  RECESSED SINGLE SWITCHED CLEANER SOCKET OUTLET WITH BRONZE FINISH
-  RECESSED TWIN SWITCHED SOCKET OUTLET WITH BRONZE FINISH
-  RECESSED SINGLE DATA OUTLET WITH BRONZE FINISH
-  RECESSED TWIN DATA OUTLET WITH BRONZE FINISH
-  MEDIA OUTLET (HDMI & VGA) WITH BRONZE FINISH. REFER TO ISD SPECIFICATION FOR DETAILS
-  SWITCHED FUSE SPUR OUTLET WITH BRONZE FINISH
-  UNSWITCHED FUSE SPUR OUTLET WITH BRONZE FINISH
-  MAGNETIC DOOR CONTACT
-  SINGLE METAL FLOOR SOCKET OUTLET WITH HINGED COVER PLATE
-  2 GANG FLOOR SOCKET WITH HINGED COVER PLATE
-  CCTV CAMERA
-  FLOOR BOX TYPE 1 WITH 2 SOCKETS, 1No. HDMI PORT & 1No. VGA PORT
-  FLOOR BOX TYPE 2 WITH 2 SOCKETS & 4 DATA OUTLETS
-  FLOOR BOX TYPE 3 WITH 2 SOCKETS, 2No. DATA PORTS & 2No. MEDIA
-  SPEAKERS

Copyright Hawkins Brown Architects LLP
 No implied license exists. This drawing should not be used to calculate areas for the purposes of valuation. Do not scale this drawing. All dimensions to be checked on site by the contractor and such dimensions to be their responsibility. All work must comply with relevant British Standards and Building Regulations requirements. Drawing errors and omissions to be reported to the architect.

Revisions
 P2 - Revision for planning
 28.09.16

Hawkins\Brown
 159 St John Street London EC1V 4QJ 020 7336 8030t
 mail@hawkinsbrown.com www.hawkinsbrown.com

Project
Confucius Institute
 15 Woburn Square
 London


Drawing
Lower Ground Floor
 Existing - Proposed

Scale	Date
1:50 @A1	27.05.16
Drawn by	Checked by
LP	MT
Job Number	Status
1656	PL


Drawing No. & Revision
 1656_DWG_36_200_P2

No implied license exists. This drawing should not be used to calculate areas for the purposes of valuation. Do not scale this drawing. All dimensions to be checked on site by the contractor and such dimensions to be their responsibility. All work must comply with relevant British Standards and Building Regulations requirements. Drawing errors and omissions to be reported to the architect.

Revisions

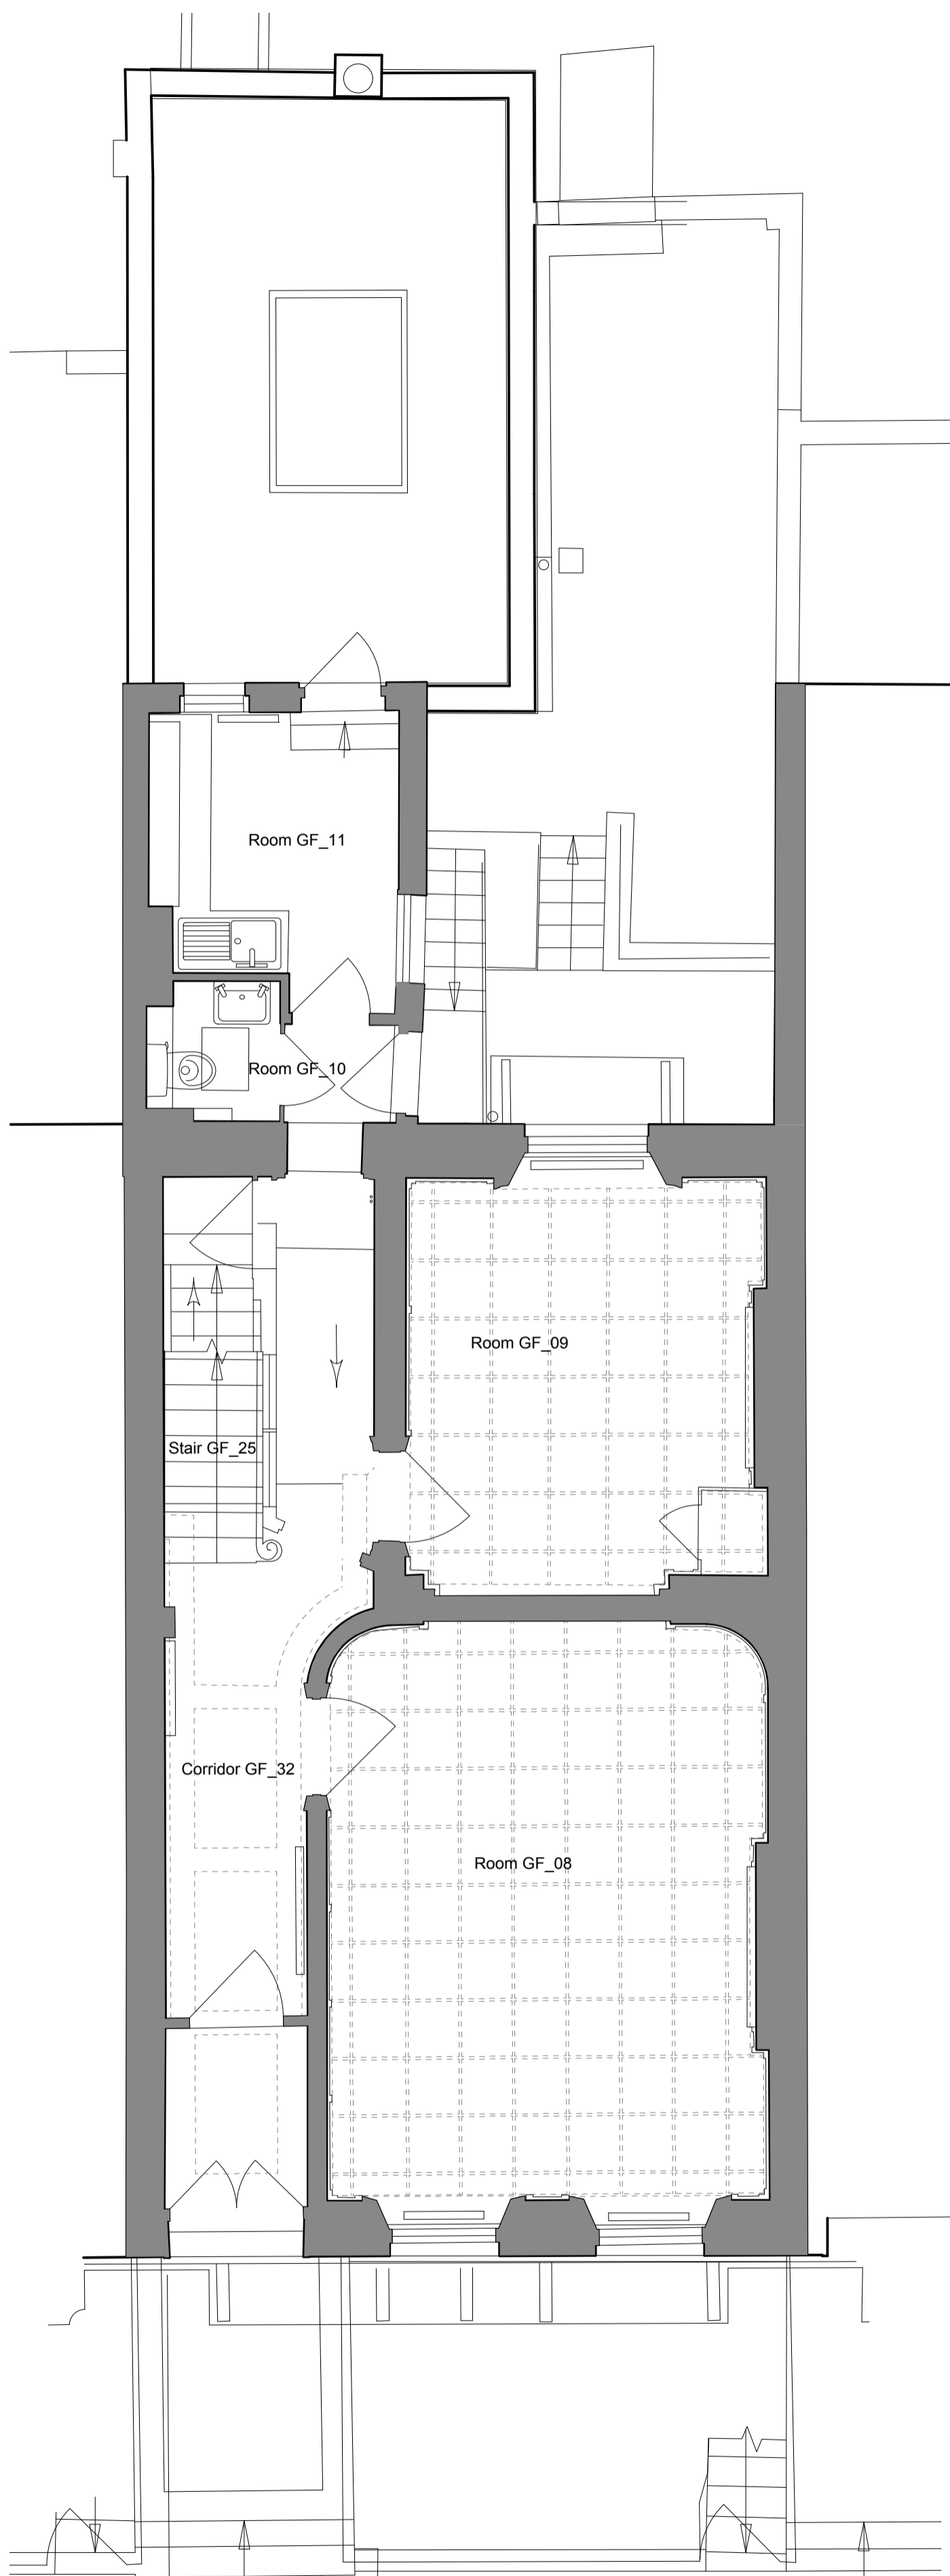



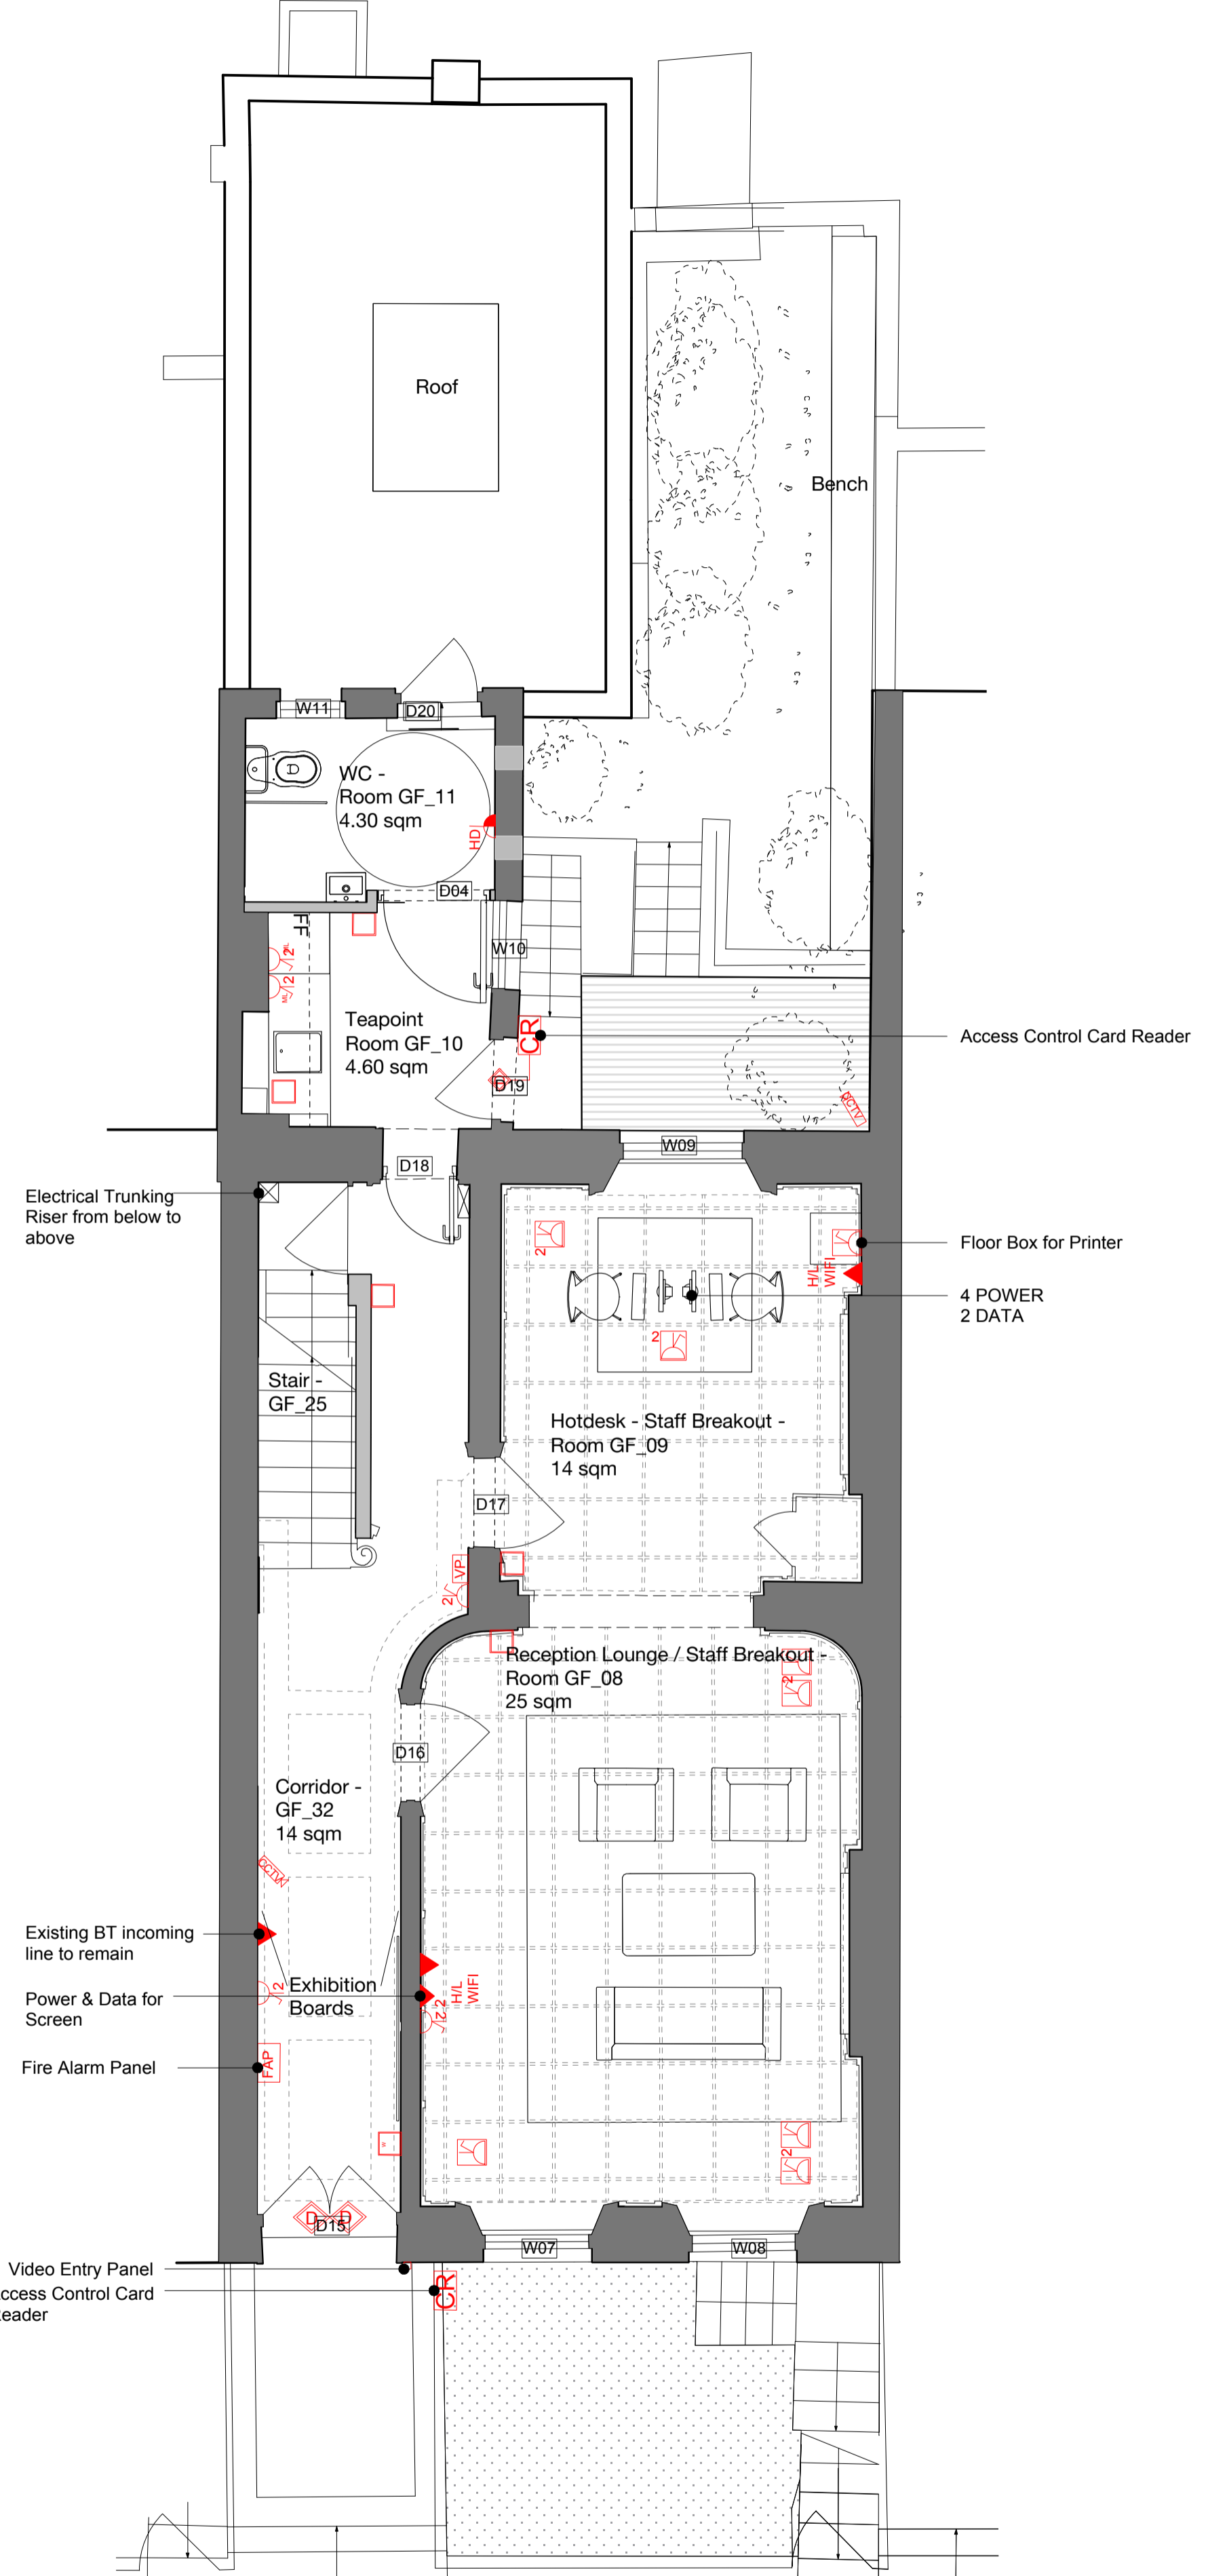














EXISTING



PROPOSED

KEY

-  SINGLE SWITCH
-  DOUBLE SWITCH
-  RECESSED SINGLE SWITCHED CLEANER SOCKET OUTLET WITH BRONZE FINISH
-  RECESSED TWIN SWITCHED SOCKET OUTLET WITH BRONZE FINISH
-  RECESSED SINGLE DATA OUTLET WITH BRONZE FINISH
-  RECESSED TWIN DATA OUTLET WITH BRONZE FINISH
-  MEDIA OUTLET (HDMI & VGA) WITH BRONZE FINISH. REFER TO ISD SPECIFICATION FOR DETAILS
-  SWITCHED FUSE SPUR OUTLET WITH BRONZE FINISH
-  UNSWITCHED FUSE SPUR OUTLET WITH BRONZE FINISH
-  MAGNETIC DOOR CONTACT
-  SINGLE METAL FLOOR SOCKET OUTLET WITH HINGED COVER PLATE
-  2 GANG FLOOR SOCKET WITH HINGED COVER PLATE
-  CCTV CAMERA
-  FLOOR BOX TYPE 1 WITH 2 SOCKETS, 1No. HDMI PORT & 1No. VGA PORT
-  FLOOR BOX TYPE 2 WITH 2 SOCKETS & 4 DATA OUTLETS
-  FLOOR BOX TYPE 3 WITH 2 SOCKETS, 2No. DATA PORTS & 2No. MEDIA
-  SPEAKER

Hawkins\Brown

159 St John Street London EC1V 4QJ 020 7336 8030t
 mail@hawkinsbrown.com www.hawkinsbrown.com

Project
Confucius Institute
 15 Woburn Square
 London


Drawing
Ground Floor
 Small Power&Data Layouts

Scale	Date
1:50 @A1	27.05.16
Drawn by	Checked by
LP	MT
Job Number	Status
1656	PL

Drawing No. & Revision
 1656_DWG_36_201

No implied license exists. This drawing should not be used to calculate areas for the purposes of valuation. Do not scale this drawing. All dimensions to be checked on site by the contractor and such dimensions to be their responsibility. All work must comply with relevant British Standards and Building Regulations requirements. Drawing errors and omissions to be reported to the architect.



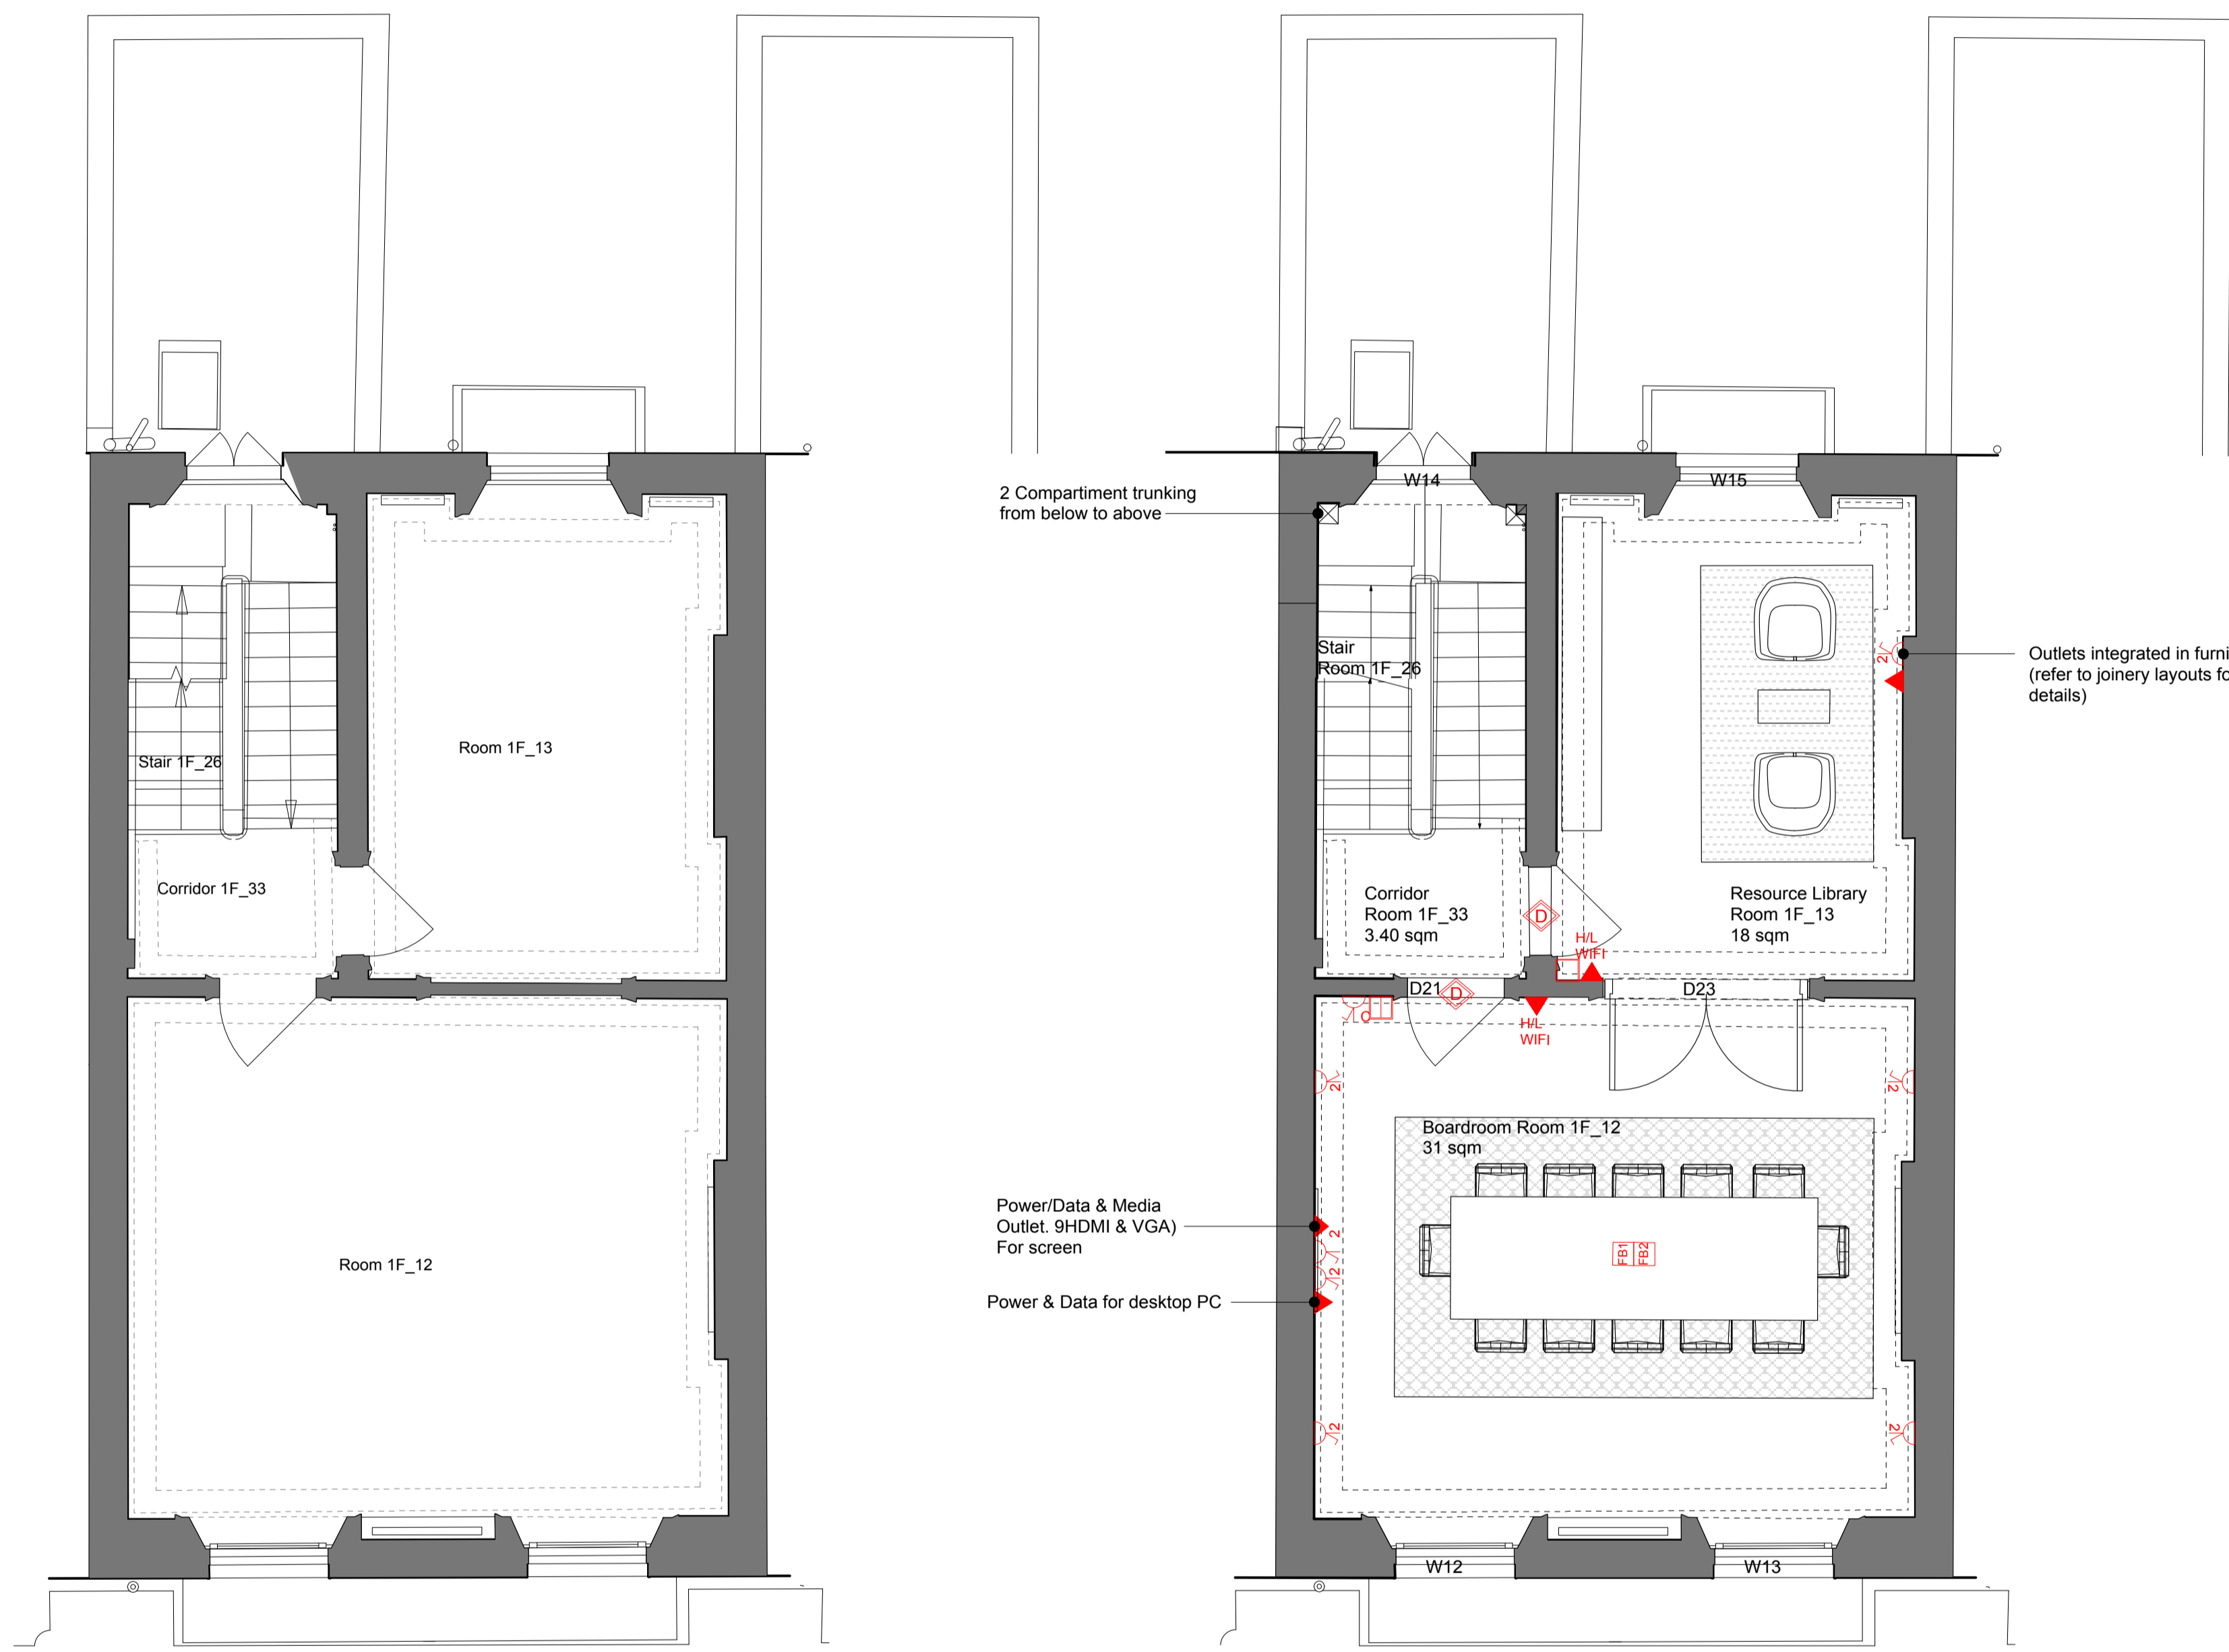














Revisions



EXISTING

PROPOSED

KEY

-  SINGLE SWITCH
-  DOUBLE SWITCH
-  RECESSED SINGLE SWITCHED CLEANER SOCKET OUTLET WITH BRONZE FINISH
-  RECESSED/DADO MOUNTED TWIN SWITCHED SOCKET OUTLET WITH BRONZE FINISH
-  RECESSED SINGLE DATA OUTLET WITH BRONZE FINISH
-  RECESSED TWIN DATA OUTLET WITH BRONZE FINISH
-  MEDIA OUTLET (HDMI & VGA) WITH BRONZE FINISH. REFER TO ISD SPECIFICATION FOR DETAILS
-  SWITCHED FUSE SPUR OUTLET WITH BRONZE FINISH
-  UNSWITCHED FUSE SPUR OUTLET WITH BRONZE FINISH
-  MAGNETIC DOOR CONTACT
-  SINGLE METAL SOCKET OUTLET WITH HINGED COVER PLATE
-  2 GANG SOCKET WITH HINGED COVER PLATE
-  CCTV CAMERA
-  FLOOR BOX TYPE 1 WITH 2 SOCKETS, 1No. HDMI PORT & 1No. VGA PORT
-  FLOOR BOX TYPE 2 WITH 2 SOCKETS & 4 DATA OUTLETS
-  FLOOR BOX TYPE 3 WITH 2 SOCKETS, 2No. DATA PORTS & 2No. MEDIA
-  SPEAKER

Hawkins\Brown

159 St John Street London EC1V 4QJ 020 7336 8030t
 mail@hawkinsbrown.com www.hawkinsbrown.com

Project
Confucius Institute
 15 Woburn Square
 London



Drawing
First Floor
 Small Power&Data Layouts

Scale	Date
1:50 @A1	27.05.16
Drawn by	Checked by
LP	MT
Job Number	Status
1656	PL

Drawing No. & Revision
 1656_DWG_36_202

No implied license exists. This drawing should not be used to calculate areas for the purposes of valuation. Do not scale this drawing. All dimensions to be checked on site by the contractor and such dimensions to be their responsibility. All work must comply with relevant British Standards and Building Regulations requirements. Drawing errors and omissions to be reported to the architect.


Revisions

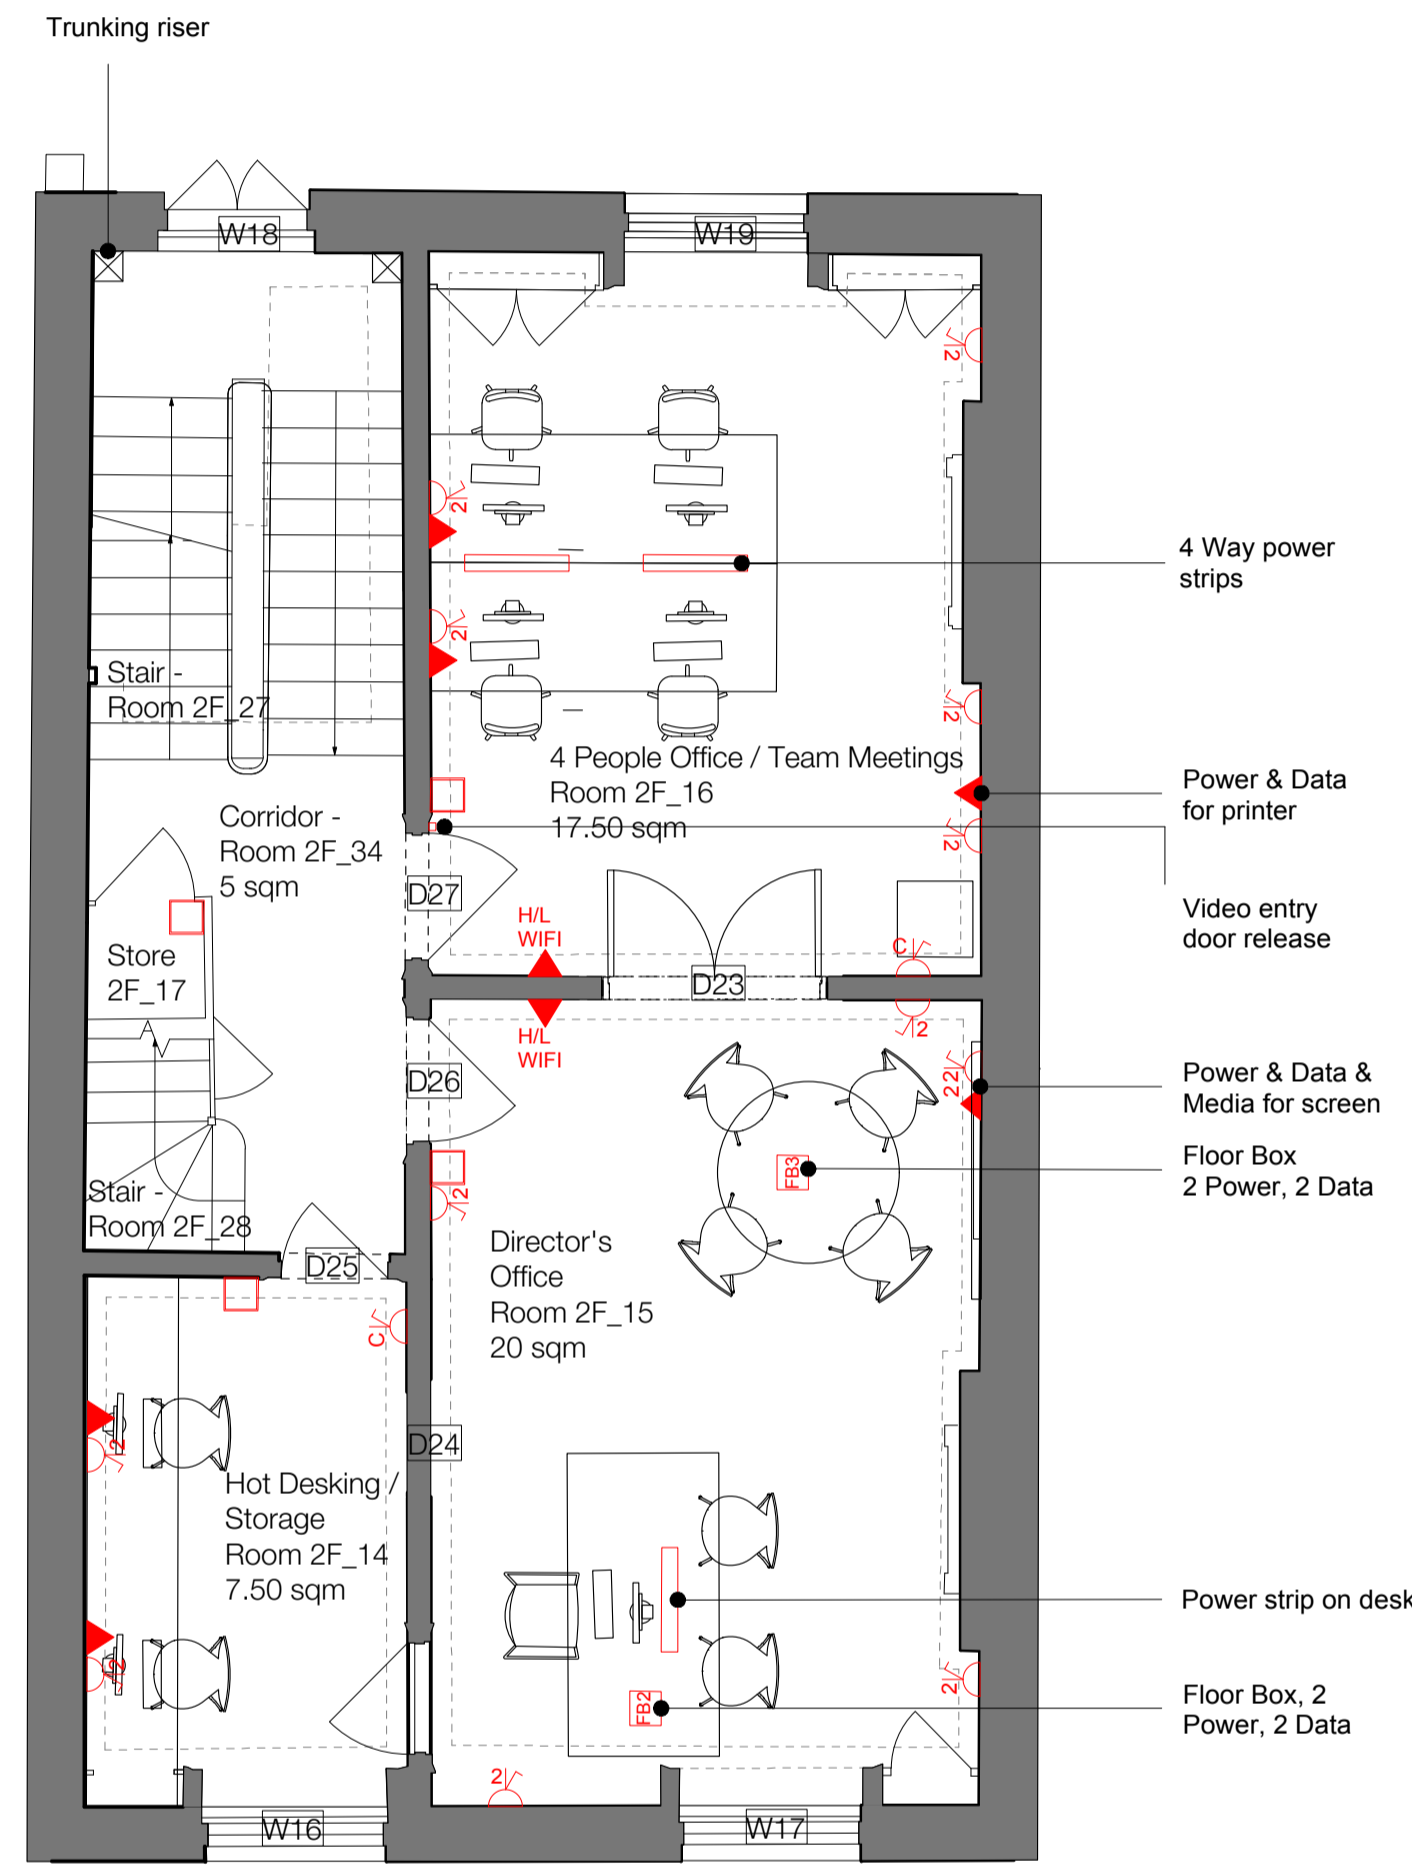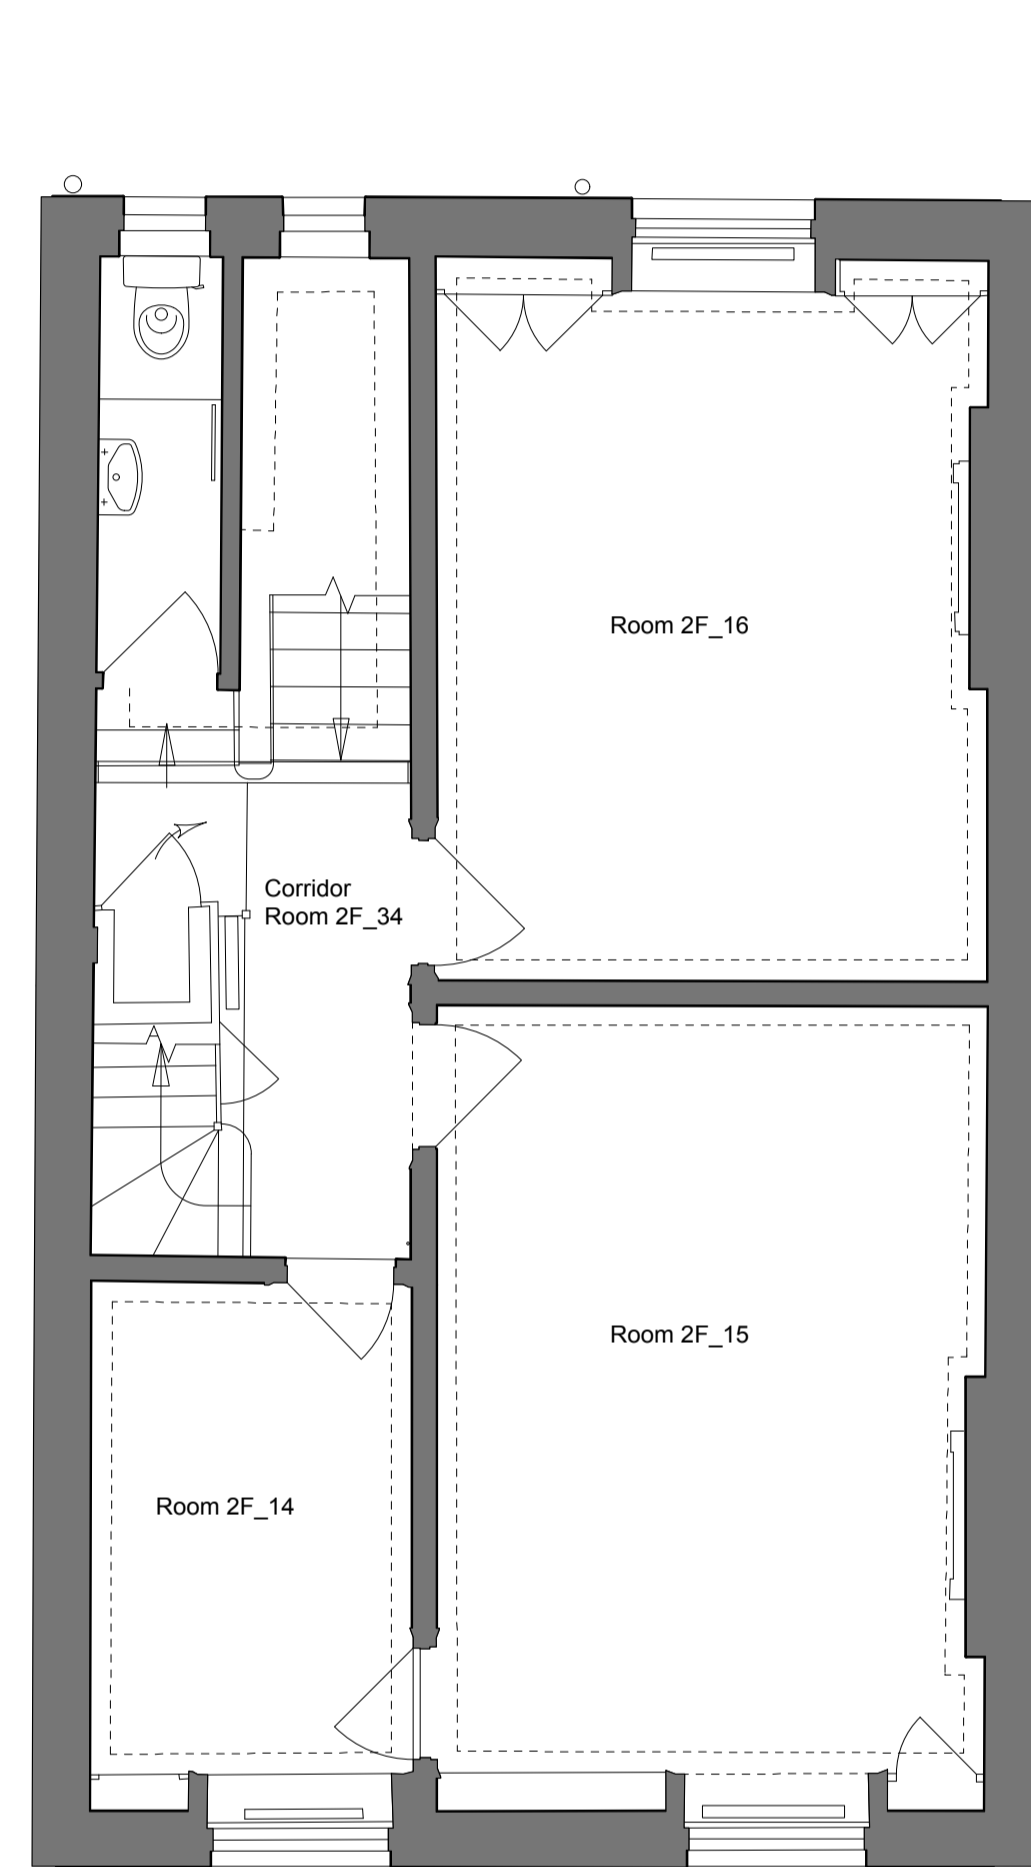

KEY

- SINGLE SWITCH
- DOUBLE SWITCH
- RECESSED SINGLE SWITCHED CLEANER SOCKET OUTLET WITH BRONZE FINISH
- RECESSED/DADO MOUNTED TWIN SWITCHED SOCKET OUTLET WITH BRONZE FINISH
- RECESSED SINGLE DATA OUTLET WITH BRONZE FINISH
- RECESSED TWIN DATA OUTLET WITH BRONZE FINISH
- MEDIA OUTLET (HDMI & VGA) WITH BRONZE FINISH. REFER TO ISD SPECIFICATION FOR DETAILS
- SWITCHED FUSE SPUR OUTLET WITH BRONZE FINISH
- UNSWITCHED FUSE SPUR OUTLET WITH BRONZE FINISH
- MAGNETIC DOOR CONTACT
- SINGLE METAL SOCKET OUTLET WITH HINGED COVER PLATE
- 2 GANG SOCKET WITH HINGED COVER PLATE
- CCTV CAMERA
- FLOOR BOX TYPE 1 WITH 2 SOCKETS, 1No. HDMI PORT & 1No. VGA PORT
- FLOOR BOX TYPE 2 WITH 2 SOCKETS & 4 DATA OUTLETS
- FLOOR BOX TYPE 3 WITH 2 SOCKETS, 2No. DATA PORTS & 2No. MEDIA
- SPEAKER

4 Way power strips
 Power & Data for printer
 Video entry door release
 Power & Data & Media for screen
 Floor Box 2 Power, 2 Data
 Power strip on desk
 Floor Box 2 Power, 2 Data

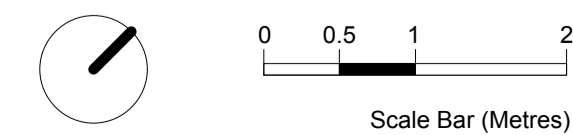

Hawkins\Brown

159 St John Street London EC1V 4QJ 020 7336 8030t
 mail@hawkinsbrown.com www.hawkinsbrown.com

Project
Confucius Institute
 15 Woburn Square
 London


Drawing
Second Floor
 Small Power&Data Layouts

Scale	Date
1:50 @A1	27.05.16
Drawn by	Checked by
LP	MT
Job Number	Status
1656	PL


Drawing No. & Revision
1656_DWG_36_204

No implied license exists. This drawing should not be used to calculate areas for the purposes of valuation. Do not scale this drawing. All dimensions to be checked on site by the contractor and such dimensions to be their responsibility. All work must comply with relevant British Standards and Building Regulations requirements. Drawing errors and omissions to be reported to the architect.

Revisions

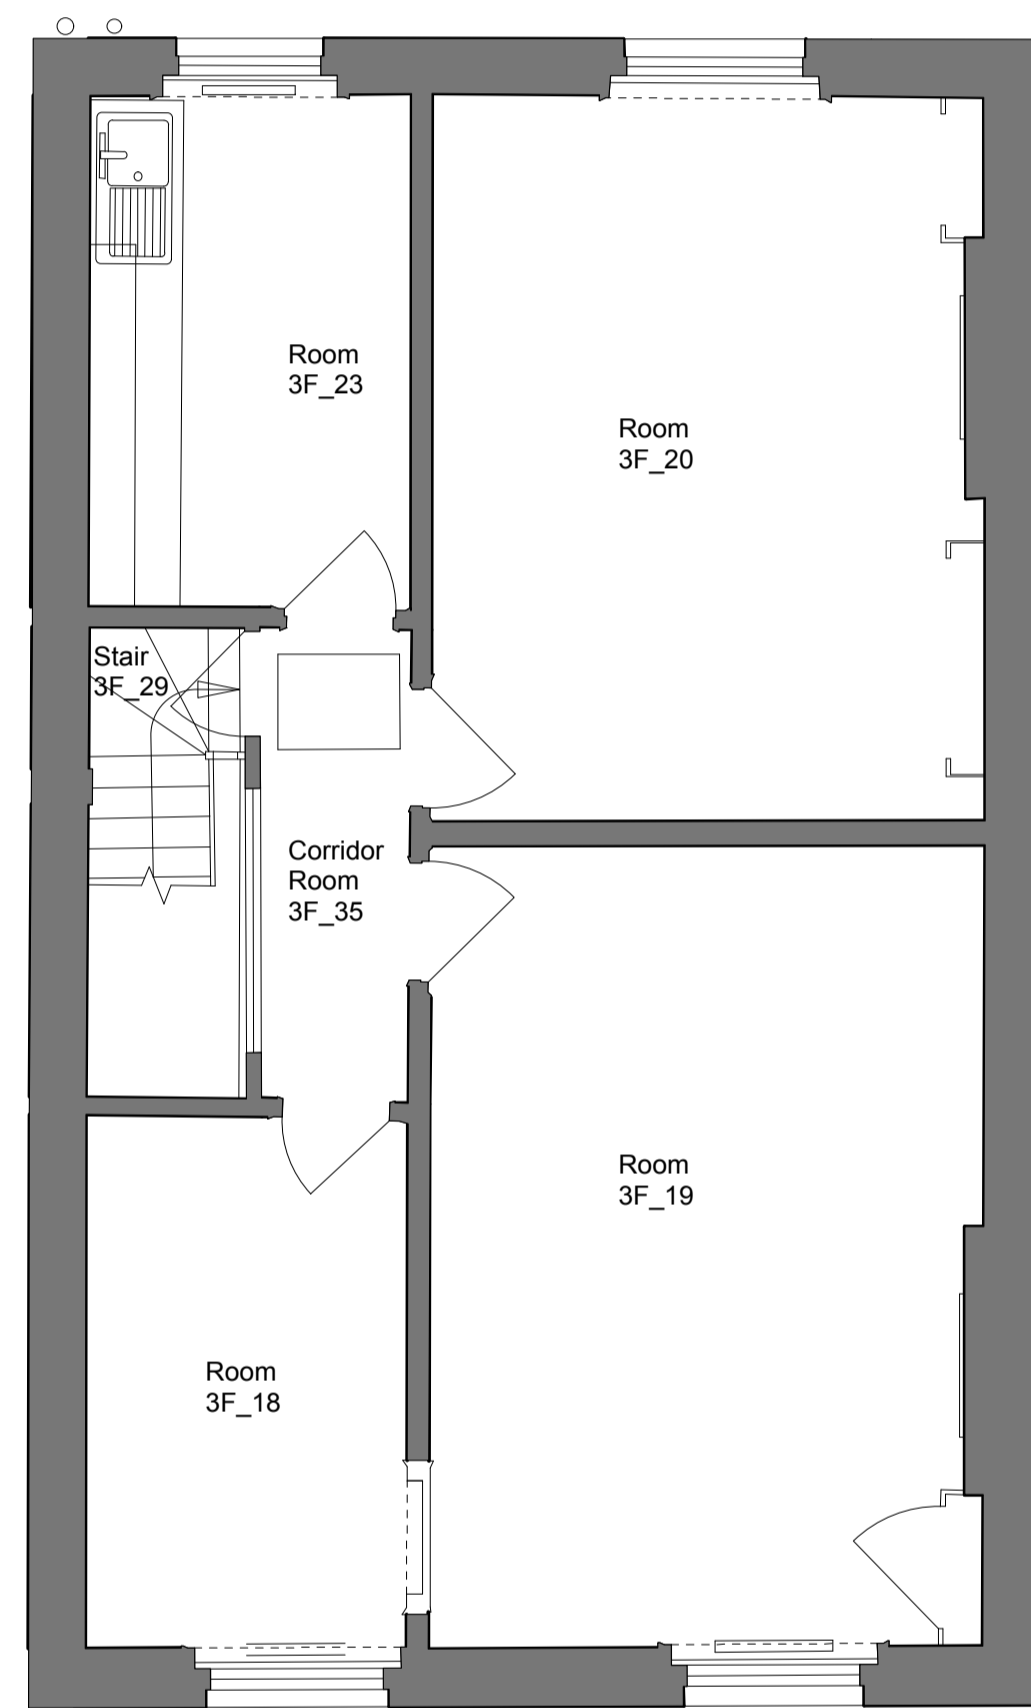



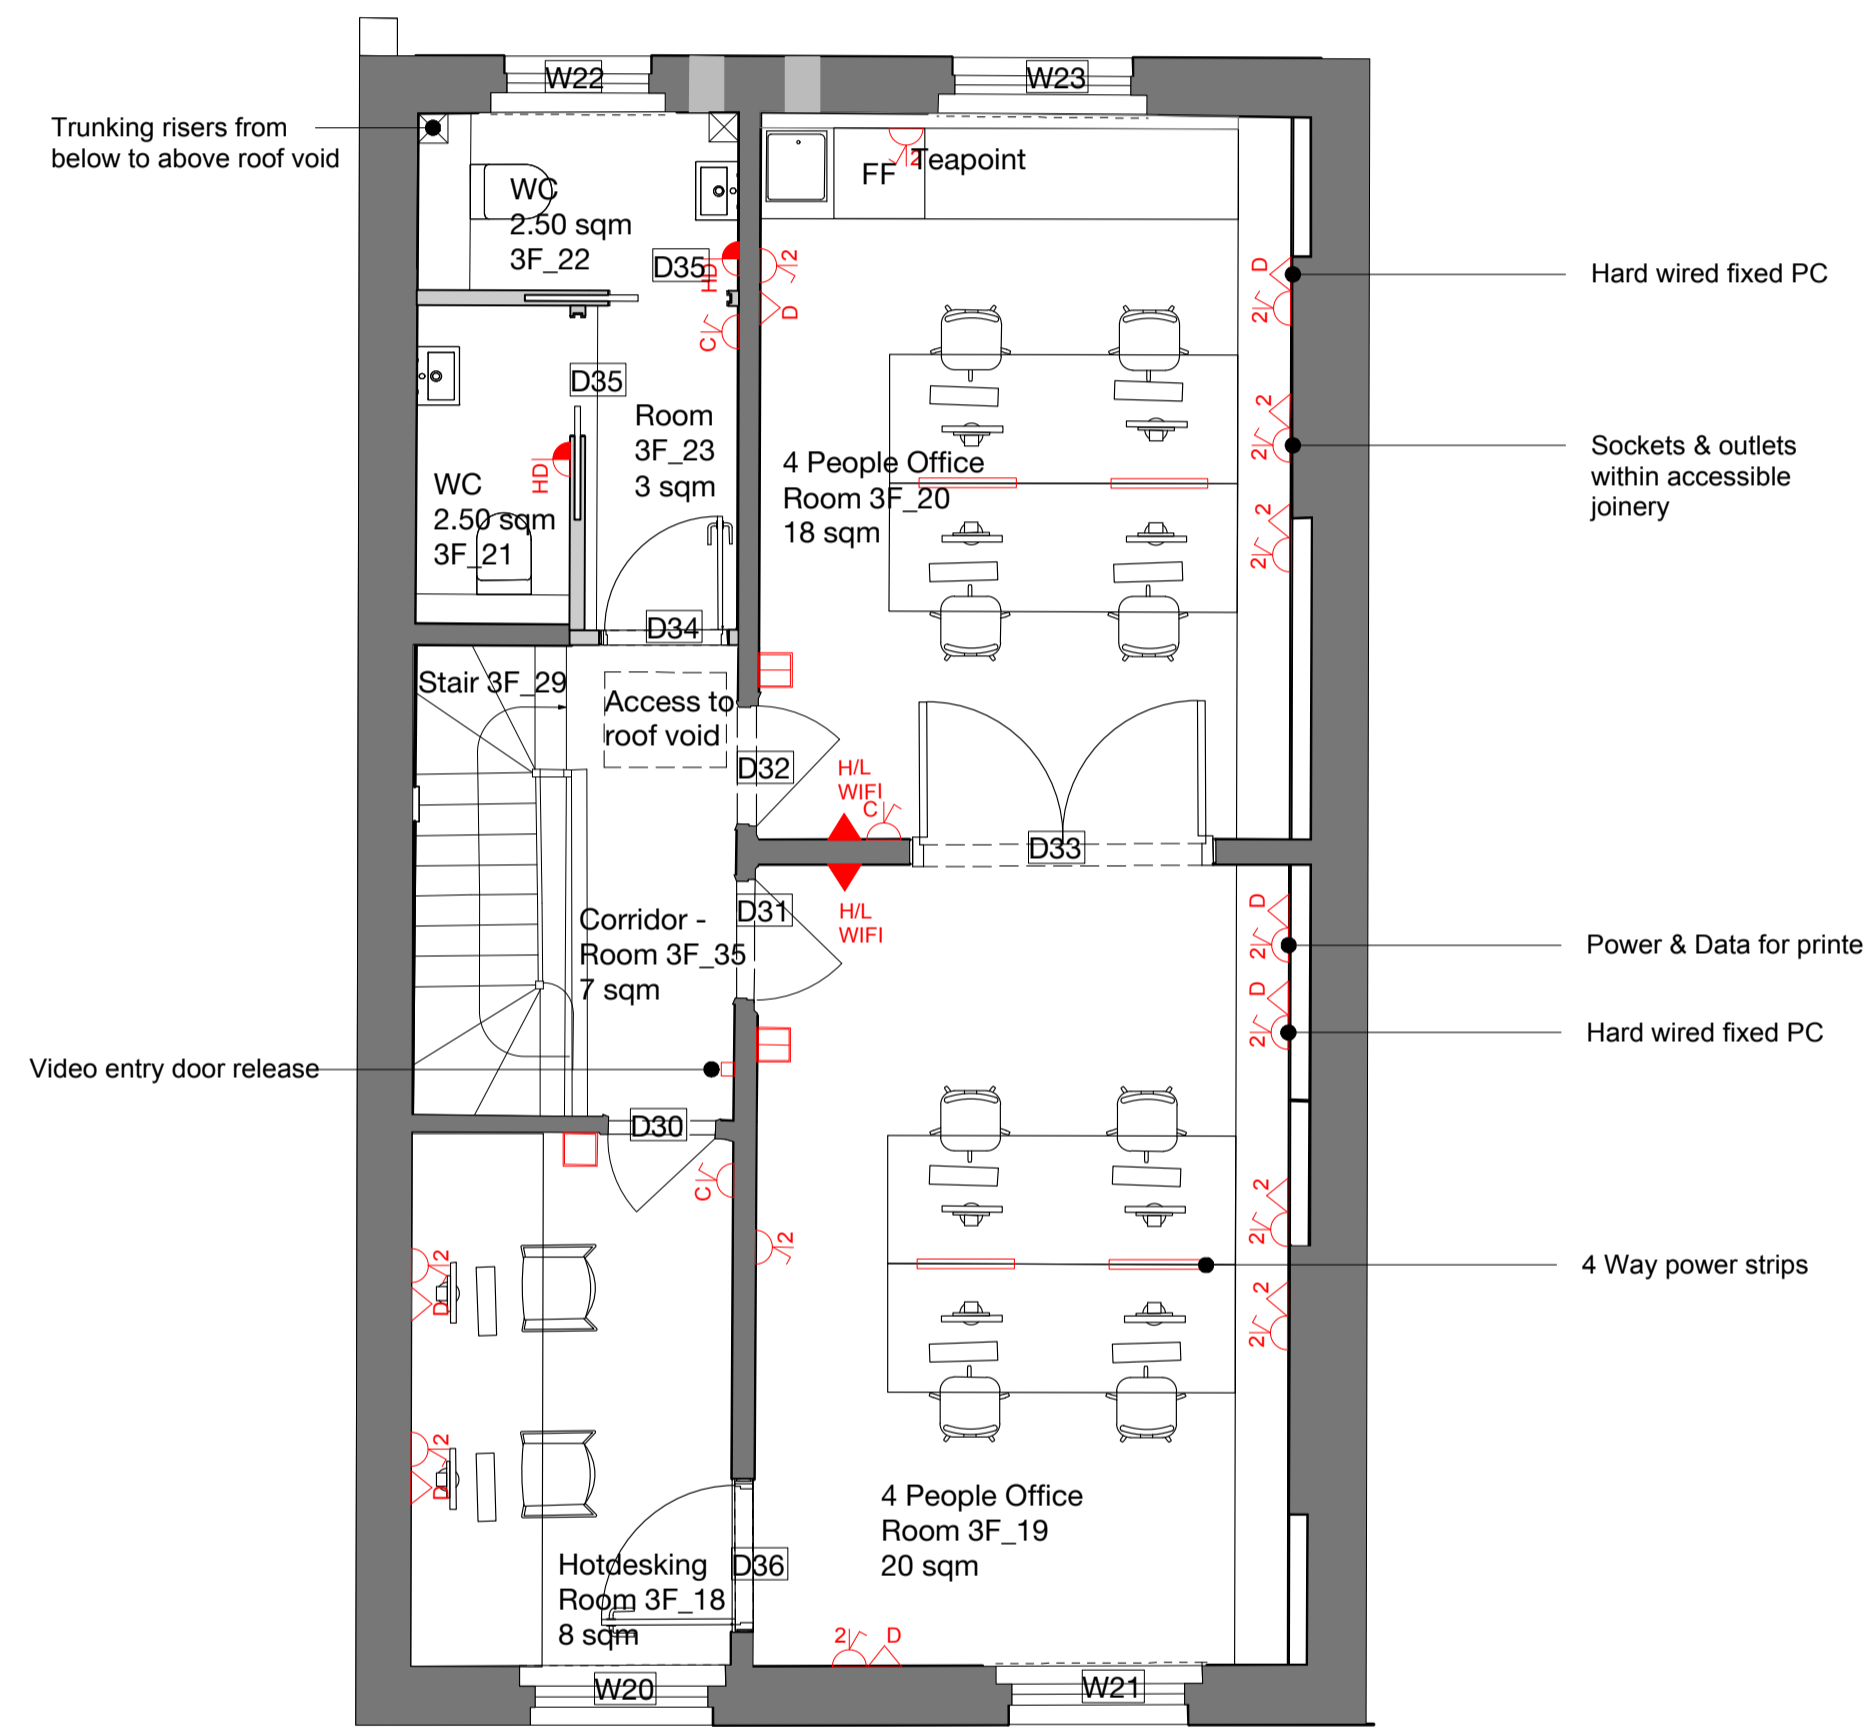














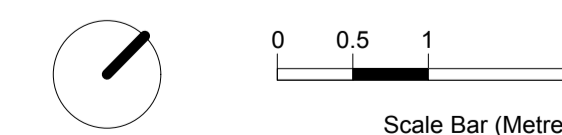
EXISTING



PROPOSED

KEY

-  SINGLE SWITCH
-  DOUBLE SWITCH
-  RECESSED SINGLE SWITCHED CLEANER SOCKET OUTLET WITH BRONZE FINISH
-  RECESSED TWIN SWITCHED SOCKET OUTLET WITH BRONZE FINISH
-  RECESSED SINGLE DATA OUTLET WITH BRONZE FINISH
-  RECESSED TWIN DATA OUTLET WITH BRONZE FINISH
-  MEDIA OUTLET (HDMI & VGA) WITH BRONZE FINISH. REFER TO ISD SPECIFICATION FOR DETAILS
-  SWITCHED FUSE SPUR OUTLET WITH BRONZE FINISH
-  UNSWITCHED FUSE SPUR OUTLET WITH BRONZE FINISH
-  MAGNETIC DOOR CONTACT
-  SINGLE METAL FLOOR SOCKET OUTLET WITH HINGED COVER PLATE
-  2 GANG FLOOR SOCKET WITH HINGED COVER PLATE
-  CCTV CAMERA
-  FLOOR BOX TYPE 1 WITH 2 SOCKETS, 1No. HDMI PORT & 1No. VGA PORT
-  FLOOR BOX TYPE 2 WITH 2 SOCKETS & 4 DATA OUTLETS
-  FLOOR BOX TYPE 3 WITH 2 SOCKETS, 2No. DATA PORTS & 2No. MEDIA
-  SPEAKER



Hawkins\Brown

159 St John Street London EC1V 4QJ 020 7336 8030t
 mail@hawkinsbrown.com www.hawkinsbrown.com

Project
Confucius Institute
 15 Woburn Square
 London

Drawing
Third Floor
 Small Power&Data Layouts

Scale	Date
1:50 @A1	27.05.16
Drawn by	Checked by
LP	MT
Job Number	Status
1656	PL

Drawing No. & Revision
 1656_DWG_36_205