


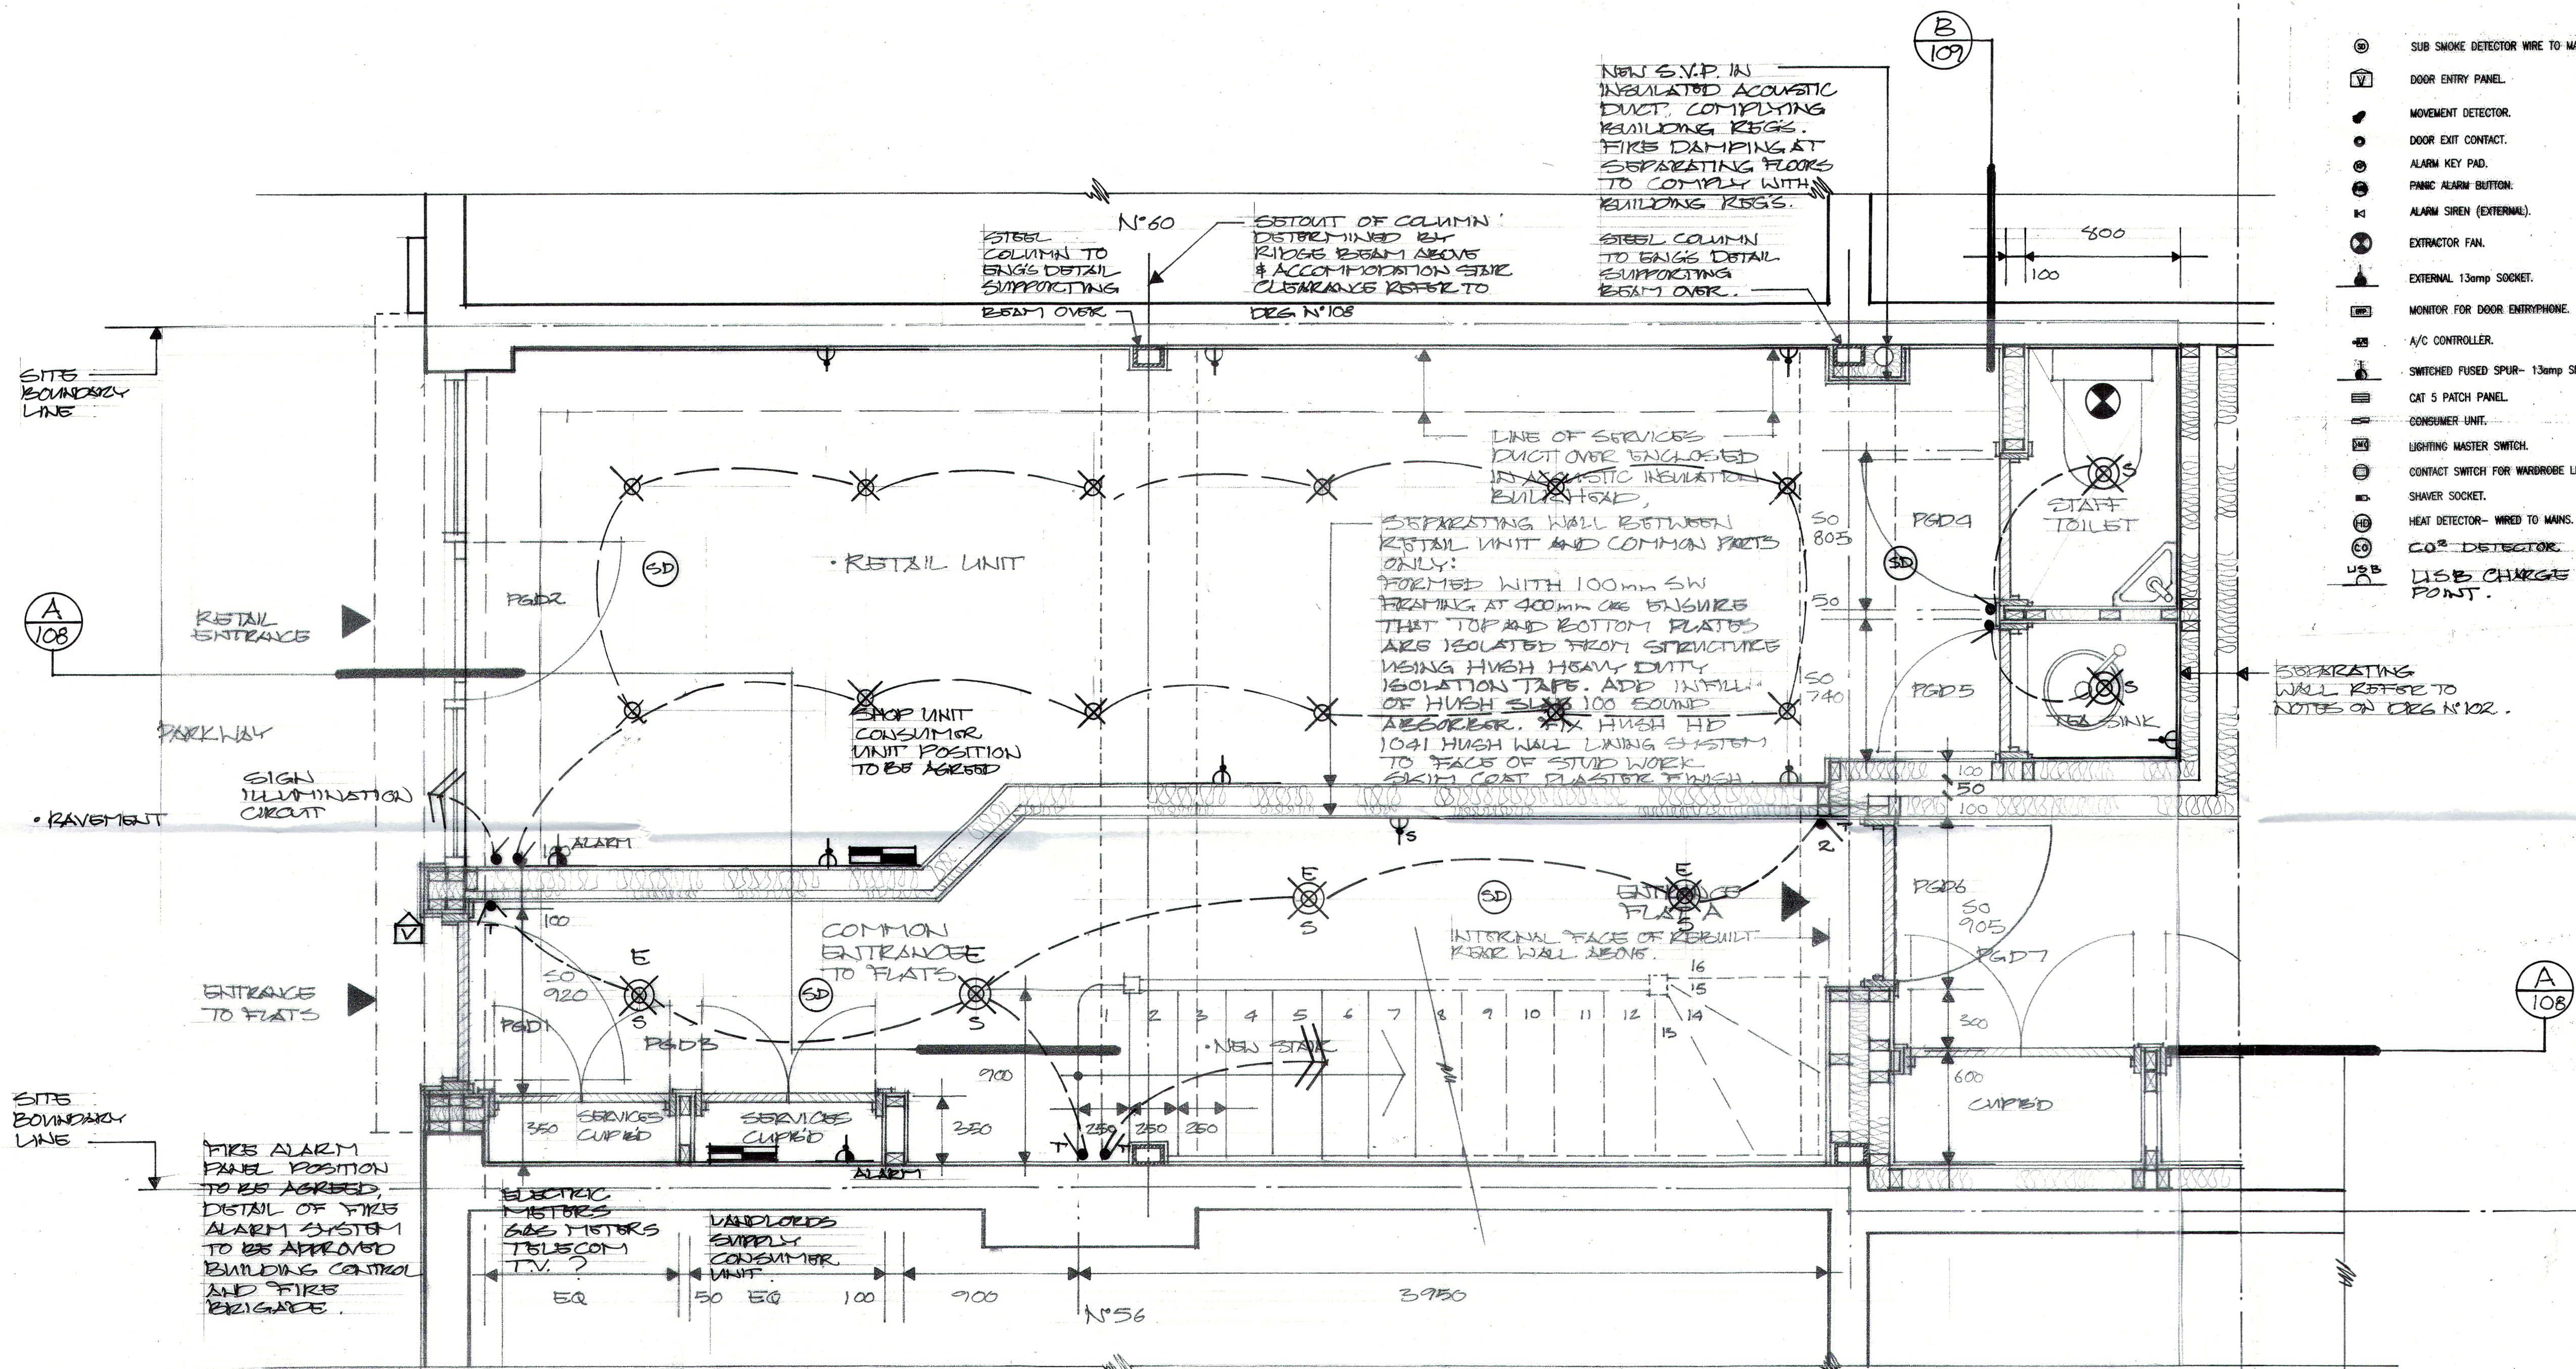

DETAIL PLAN FRONT SECTION OF GROUND FLOOR

NOTE: CEILING LIGHTS, RECESSED LOW VOLTAGE DOWNLIGHTERS (LED TYPE LOW ENERGY FITTINGS) ALL TO BE ENCLOSED IN FIRE RESISTING RECESS 60 MIN FIRE RESISTANCE. LIGHTS IN SHOP UNIT & FLAT B TO ALSO HAVE AN ACOUSTIC ENCLOSURE TO COMPLY WITH BUILDING REGULATIONS FOR SEPARATING FLOORS.

REFER TO DEG N°101 FOR REAR SECTION OF GROUND FLOOR PLAN

- ⊙ SUB SMOKE DETECTOR WIRE TO MAINS.
- Ⓜ DOOR ENTRY PANEL.
- Ⓜ MOVEMENT DETECTOR.
- Ⓜ DOOR EXIT CONTACT.
- Ⓜ ALARM KEY PAD.
- Ⓜ PANIC ALARM BUTTON.
- Ⓜ ALARM SIREN (EXTERNAL).
- Ⓜ EXTRACTOR FAN.
- Ⓜ EXTERNAL 13amp SOCKET.
- Ⓜ MONITOR FOR DOOR ENTRYPHONE.
- Ⓜ A/C CONTROLLER.
- Ⓜ SWITCHED FUSED SPUR - 13amp SPUR.
- Ⓜ CAT 5 PATCH PANEL.
- Ⓜ CONSUMER UNIT.
- Ⓜ LIGHTING MASTER SWITCH.
- Ⓜ CONTACT SWITCH FOR WARDROBE LIGHTING.
- Ⓜ SHAVR SOCKET.
- Ⓜ HEAT DETECTOR - WIRED TO MAINS.
- Ⓜ CO2 DETECTOR.
- Ⓜ USB CHARGE POINT.

ELECTRICAL LEGEND

- Ⓜ RECESSED FLOOR LIGHT.
 - Ⓜ EXTERNAL LIGHT.
 - Ⓜ LIGHT SWITCH - 2-TWO/1WAY.
 - Ⓜ LIGHT SWITCH - 3-TWO/2WAY.
 - Ⓜ SURFACE MOUNTED LIGHT FITTING.
 - Ⓜ BULKHEAD LIGHTS.
 - Ⓜ SURFACE MOUNTED FLUORESCENT.
 - Ⓜ LOW VOLTAGE DOWNLIGHTER.
 - Ⓜ WALL MOUNTED LIGHT FITTING.
 - Ⓜ SURFACE MOUNTED SPOTLIGHTS.
 - Ⓜ PICTURE LIGHT.
 - Ⓜ 5amp SOCKET FOR LAMPS.
 - Ⓜ 13amp SOCKET FOR LAMPS.
 - Ⓜ DIRECTIONAL DOWNLIGHTER.
 - Ⓜ BRICK LIGHTS.
 - Ⓜ CONTACT SWITCH LIGHTING.
 - Ⓜ HOOKER PLUMB LIGHTING.
- WIRING TO INDICATE LIGHTING GROUPINGS AND SWITCHING ONLY. EXACT WIRING TO BE DETERMINED BY ELECTRICIAN.
- E
- ELECTRICAL LEGEND:
- Ⓜ TWIN 13amp SOCKET OUTLET.
 - Ⓜ TWIN 5amp SOCKET OUTLET.
 - Ⓜ SPUR SOCKET: W/M=WASHING MACHINE, D=DRIER, A/C=AIR CONDITIONING, WOB=WARDROBE LIGHTING.
 - Ⓜ TELEPHONE POINT.
 - Ⓜ DATA TELEPHONE POINT.
 - Ⓜ TV SOCKET.
 - Ⓜ CEILING SPEAKER.
 - Ⓜ WALL SPEAKER.
 - Ⓜ I.R. SENSOR.
 - Ⓜ SUB WOOFER.

REFER TO DEG N°101 FOR REAR SECTION OF GROUND FLOOR PLAN

13.10.16. ELECTRIC'S ADDSD. B
13.06.16. NOTES ADDED. A

DATE	REVISIONS	REV

THIS DRAWING IS THE COPYRIGHT OF THE ARCHITECT AND SHOULD NOT BE REPRODUCED WITHOUT WRITTEN CONSENT. DO NOT SCALE FROM THIS DRAWING. ONLY FIGURED DIMENSIONS SHOULD BE REFERRED TO. ANY DISCREPANCIES SHOULD BE REPORTED TO THE ARCHITECT IMMEDIATELY.

PROJECT
58 & 58A PARKWAY
LONDON NW1 7AH

DRAWING
DETAIL PLAN FRONT SECTION, GROUND FLOOR & POWER & LIGHTING

DATE
Aug 16

DELTA
ARCHITECTS

COMPUTER
17 BONNY STREET LONDON NW1 9PE
TEL: 020 7424 0122 FAX: 020 7424 0133
e-mail: info@transformation-architects.co.uk

SCALE
1:20

DWG. No. 0001.000

REV. B