


GROUND FLOOR
SCALE 1:100

Wall mounted air conditioning unit connected to external condenser


Construct new 100mm thick partition with softwood skirtings to match existing. Install new 1/2 HRFR self closing door in SW frame to match existing.

Construct new 100mm thick partition with softwood skirtings to match existing. Install new 1/2 HRFR self closing door in SW frame to match existing.

Existing door and hinges to be removed

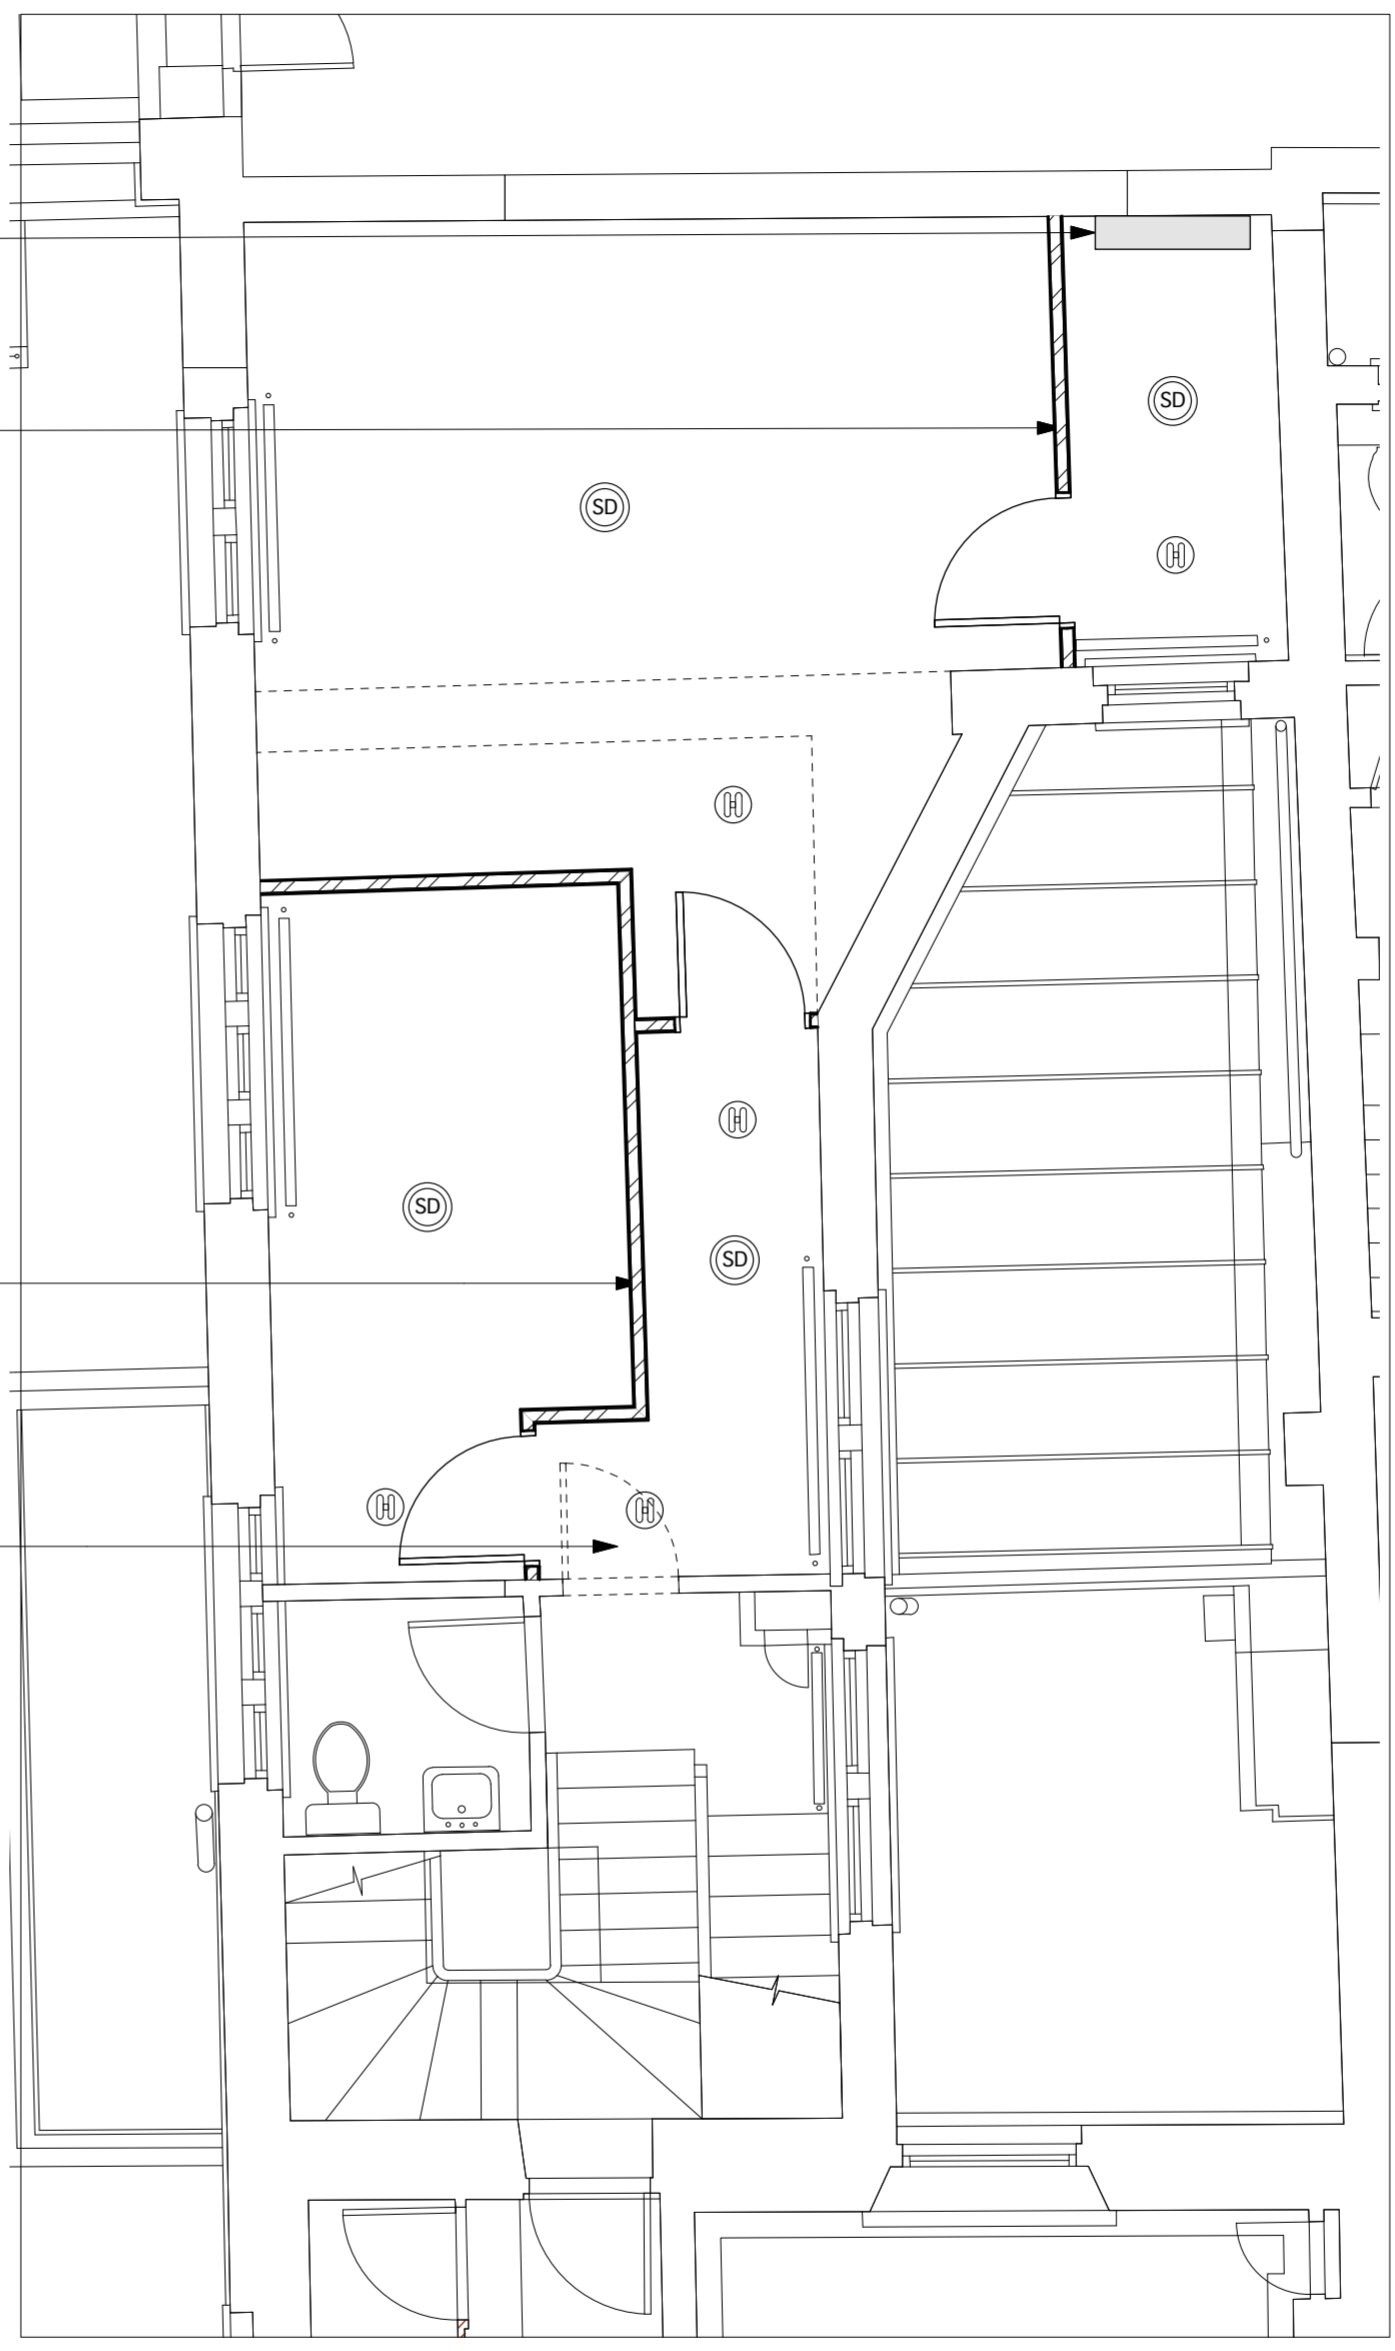

GROUND FLOOR
SCALE 1:50

 

SCALE BAR

NOTE

Partitions

All new partitions to be constructed to achieve 1/2HRFR including doors which are to be fitted with combined fire / smoke seals and self closing device. Skirtings, door frames and achtraves to match existing adjacent finishes.

Fire Alarm

(SD) Install new smoke detection connected to existing fire alarm system, to all new rooms formed with sounders to reach required db level. A Certificate confirming the system's compliance with the relevant standard will be provided by a competent person on completion of the work.

Emergency Lighting

(EM) (HI) Install emergency lighting designed to provide light levels in accordance with BS 5266 part 1 and to local authority requirements providing 3 hour continuous duration. Luminaires shall be self contained inverter packs in selected general luminaires along with illuminated exit signs to all exits. A Certificate confirming the system's compliance with the relevant standard will be provided by a competent person on completion of the work.

Cabling

All new cabling works to be concealed within floor void to avoid the use of plastic trunking.

REVISIONS:		
REV.	DESCRIPTION	DATE
A	Notes amended	Oct 16

Lacayo Wolfe
Design Consultants

11 Jerusalem Passage LONDON EC1V 4JP Telephone: 020 7336 6779 Facsimile: 020 7336 6799

PROJECT NO: **2059**

PROJECT: **23 BLOOMSBURY SQUARE**

CLIENT: **BRITISH STUDY CENTRES**

DRAWING: **GROUND FLOOR**

DRAWING NO: LW/2059-A2-G01	DATE: SEPT '16
DRAWN: LVT	SCALE: As shown
	REV: A

CONTRACTORS MUST VERIFY ALL DIMENSIONS ON SITE BEFORE COMMENCING ANY WORK. FIGURED DIMENSIONS TAKE PRECEDENCE OVER SCALED DIMENSIONS. THE COPYRIGHT OF THIS DRAWING IS RESERVED AND THE DRAWING MUST NOT BE DISCLOSED WITHOUT AUTHORITY.