


THIRD FLOOR  
SCALE 1:100

Form new door opening and install new 1/2 HRFR self closing door in SW frame to match existing.

Construct new 100mm thick partition with softwood skirtings to match existing

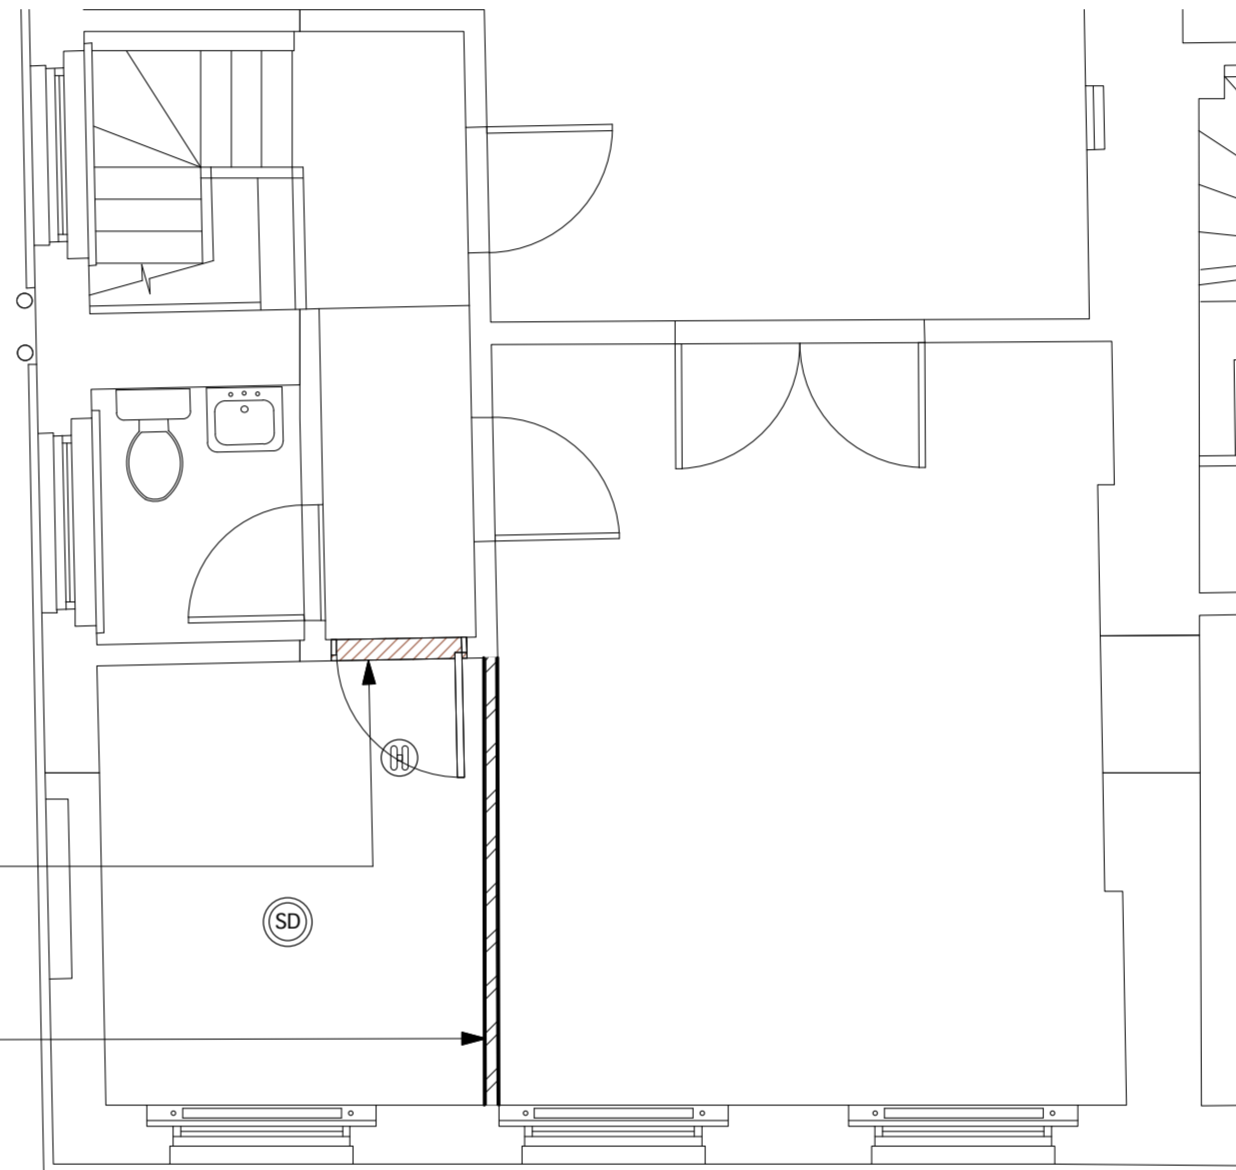

THIRD FLOOR  
SCALE 1:50

NOTE

Partitions

All new partitions to be constructed to achieve 1/2HRFR including doors which are to be fitted with combined fire / smoke seals and self closing device. Skirtings, door frames and achitraves to match existing adjacent finishes.

Fire Alarm

ⓈD Install new smoke detection connected to existing fire alarm system, to all new rooms formed with sounders to reach required db level. A Certificate confirming the system's compliance with the relevant standard will be provided by a competent person on completion of the work.

Emergency Lighting

EM ⓈH Install emergency lighting designed to provide light levels in accordance with BS 5266 part 1 and to local authority requirements providing 3 hour continuous duration. Luminaires shall be self contained inverter packs in selected general luminaires along with illuminated exit signs to all exits. A Certificate confirming the system's compliance with the relevant standard will be provided by a competent person on completion of the work.

Cablings

All new cabling works to be concealed within floor void to avoid the use of plastic trunking.

REVISIONS:			
A	Notes amended	Oct 16	
REV.	DESCRIPTION	DATE	BY

**Lacayo Wolfe**  
Design Consultants

11 Jerusalem Passage  
LONDON EC1V 4JP

Telephone:  
020 7336 6779

Facsimile:  
020 7336 6799


PROJECT NO: **2059**

PROJECT : **23 BLOOMSBURY SQUARE**

CLIENT: **BRITISH STUDY CENTRES**

DRAWING: **THIRD FLOOR**

DRAWING NO: <b>LW/2059-A2-301</b>	DATE: <b>SEPT '16</b>
DRAWN: <b>LVT</b>	SCALE: <b>As shown</b>
	REV: <b>A</b>

 

SCALE BAR

CONTRACTORS MUST VERIFY ALL DIMENSIONS ON SITE BEFORE COMMENCING ANY WORK. FIGURED DIMENSIONS TAKE PRECEDENCE OVER SCALED DIMENSIONS. THE COPYRIGHT OF THIS DRAWING IS RESERVED AND THE DRAWING MUST NOT BE DISCLOSED WITHOUT AUTHORITY.