


Proposed First Plan
1:50 Scale

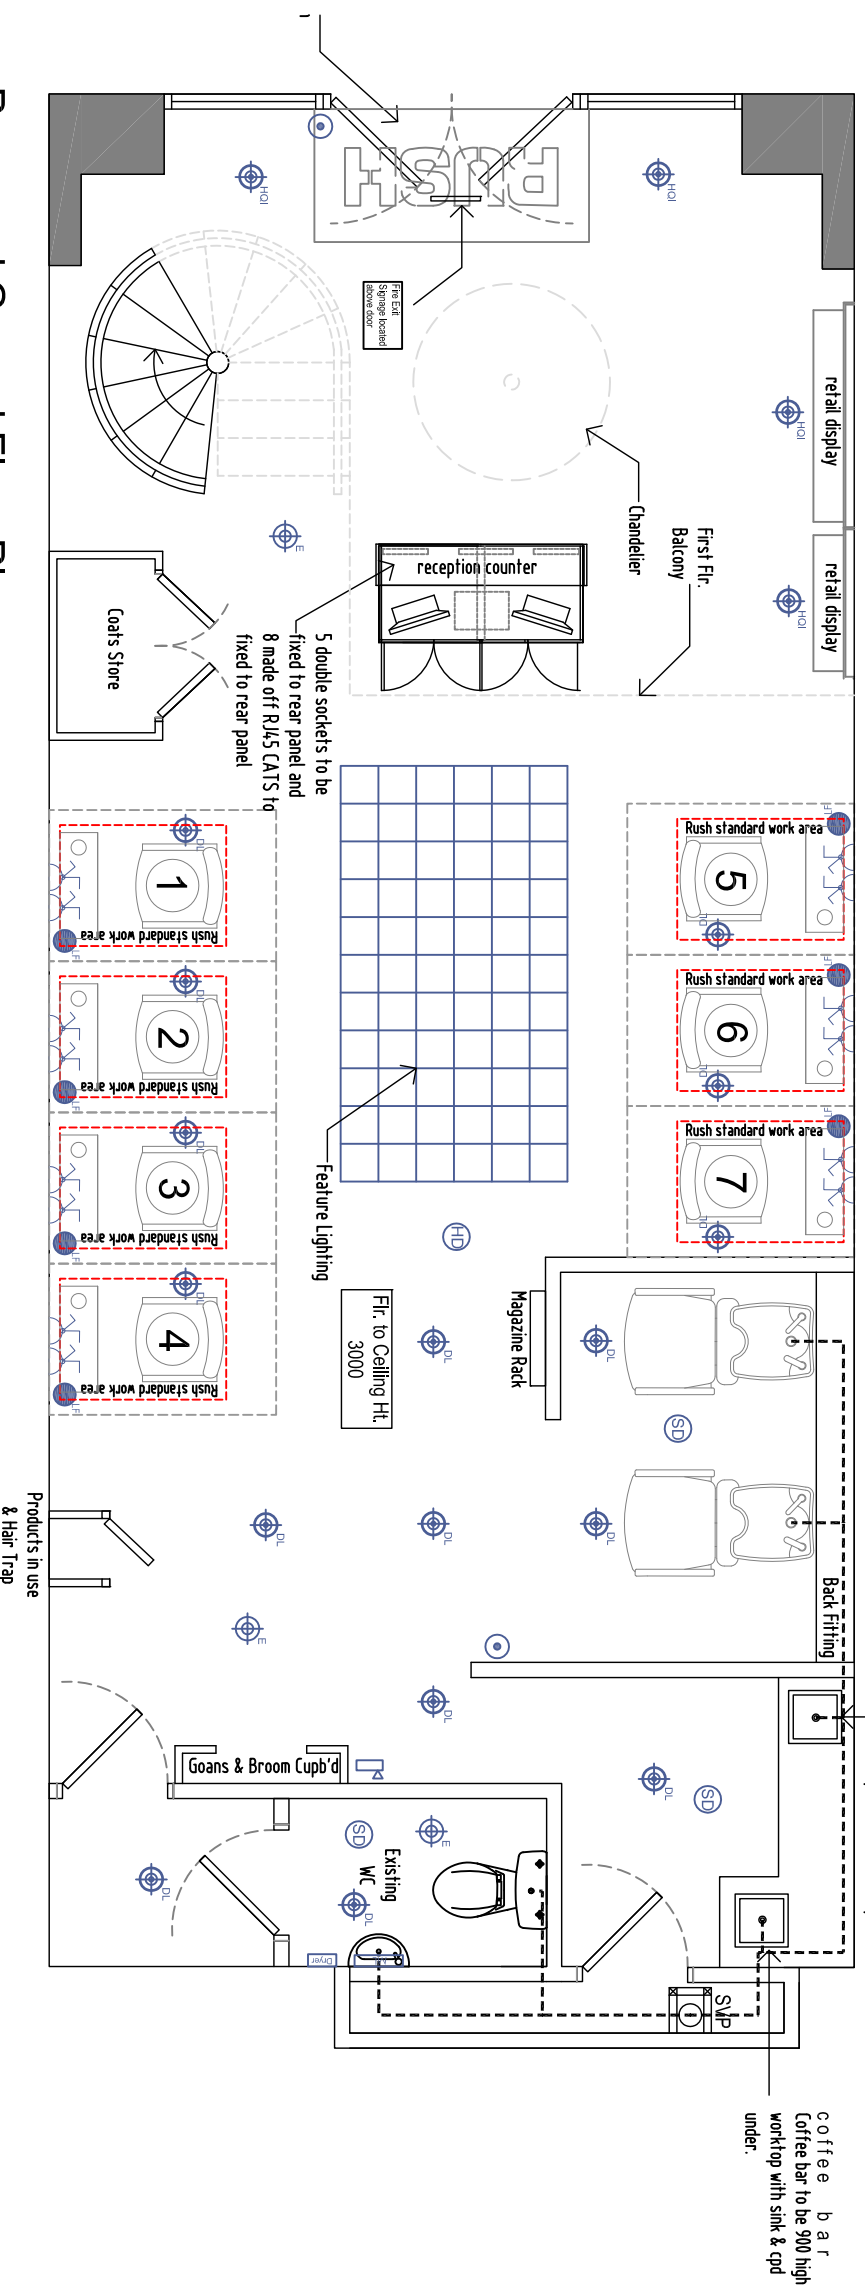

Proposed Ground Floor Plan
1:50 Scale

Item	Description	By	Date
Revisions:			

MG4 Designs Ltd
 T: 07951 856 304 • E: studio@mg4design.com
 WWW.MG4DESIGN.COM

Rush Hair Ltd,
 3rd Floor Central House,
 27 Park Street
 Croydon, CR0 1YD

Client:	Rush
Project:	Rush Hair Salon Holborn London
Title:	Proposed Lighting & Small Electrical Layout
Scale:	1:50 @ A3
Date:	17.09.16
Job No.:	523
Dwg No.:	03
Drawn:	PG/DC
Checked:-	