

BDP SHALL HAVE NO RESPONSIBILITY FOR ANY USE MADE OF THIS DOCUMENT OTHER THAN FOR THAT WHICH IT WAS PREPARED AND ISSUED.  
 ALL DIMENSIONS SHOULD BE CHECKED ON SITE.  
 DO NOT SCALE FROM THIS DRAWING.  
 ANY DRAWING ERRORS OR OMISSIONS SHOULD BE BROUGHT TO THE ATTENTION OF BUILDING DESIGN PARTNERSHIP AT THE ADDRESS SHOWN BELOW.

NOTES

CONTROL SCHEDULE

CIRCUIT No	LUMINAIRE GROUP
1	ALL LUMINAIRES REF X1
2	ALL LUMINAIRES REF X2
3	ALL LUMINAIRES REF X3
4	ALL LUMINAIRES REF X4
5	ALL LUMINAIRES REF X5
6	ALL LUMINAIRES REF X6
7	ALL LUMINAIRES REF X7


ALL LUMINAIRES TO BE FLICKER-FREE DIMMABLE DOWN TO 10% EACH TYPOLOGY OF LUMINAIRE TO BE CONNECTED TO A SEPARATE CIRCUIT.  
 AT THE COMMISSIONING STAGE THE DIMMING LEVELS AGREED TO BE SET AS PERMANENT AND LOCKED SO AS TO AVOID ACCIDENTAL CHANGE OF LIT INTENSITY.

X7 MEDIUM BEAM LED FLOODLIGHTS TO REPLACE EXISTING METAL HALIDE FLOODLIGHTS. X7 TO BE FITTED WITH BARNDOOR ACCESSORIES. FINAL POSITION SUBJECT FOCUSING ON SITE. ALL X7 MUST BE FOCUSED (ROTATED AND TILTED) TO COVER DOME EVENLY. FITTINGS TO BE CENTRALLY FIXED WITH A SINGLE BOLT TO THE CENTRE OF THE STIRRUP TO ALLOW FOR ROTATIONAL FOCUSING OF FITTING. ONCE FITTINGS ARE FOCUSED THEY MUST BE LOCKED IN POSITION SO AS NOT TO ALLOW TOOL-FREE ACCIDENTAL ADJUSTMENT.

X3 MEDIUM BEAM FLOODLIGHT TO BE AIMED AT DOME AND TO BE ROTATED BY 25° AND TILTED UPWARDS BY 35°. X3 TO BE FITTED WITH BARNDOOR ACCESSORIES. REFER TO SECTION 63ES001. FINAL POSITION SUBJECT TO MOCK-UP AND FOCUSING ON SITE. ALL X3 MUST BE FOCUSED (ROTATED AND TILTED) TO COVER DOME EVENLY BEFORE FINAL POSITIONS ARE DETERMINED. FITTINGS TO BE CENTRALLY FIXED WITH A SINGLE BOLT TO THE CENTRE OF THE STIRRUP TO ALLOW FOR ROTATIONAL FOCUSING OF FITTING. ONCE FITTINGS ARE FOCUSED THEY MUST BE LOCKED IN POSITION SO AS NOT TO ALLOW TOOL-FREE ACCIDENTAL ADJUSTMENT.

X4 NARROW BEAM FLOODLIGHT TO BE AIMED AT THE CROWN OF THE DOME. FLOODLIGHT TO BE TILTED UPWARDS BY 40°. REFER TO SECTION 63ES001. FINAL POSITION SUBJECT TO MOCK-UP AND FOCUSING ON SITE. FITTING TO BE CENTRALLY FIXED WITH A SINGLE BOLT TO THE CENTRE OF THE STIRRUP TO ALLOW FOR ROTATIONAL FOCUSING OF FITTING. ONCE FITTING IS FOCUSED IT MUST BE LOCKED IN POSITION SO AS NOT TO ALLOW TOOL-FREE ACCIDENTAL ADJUSTMENT.

ROOF PLAN

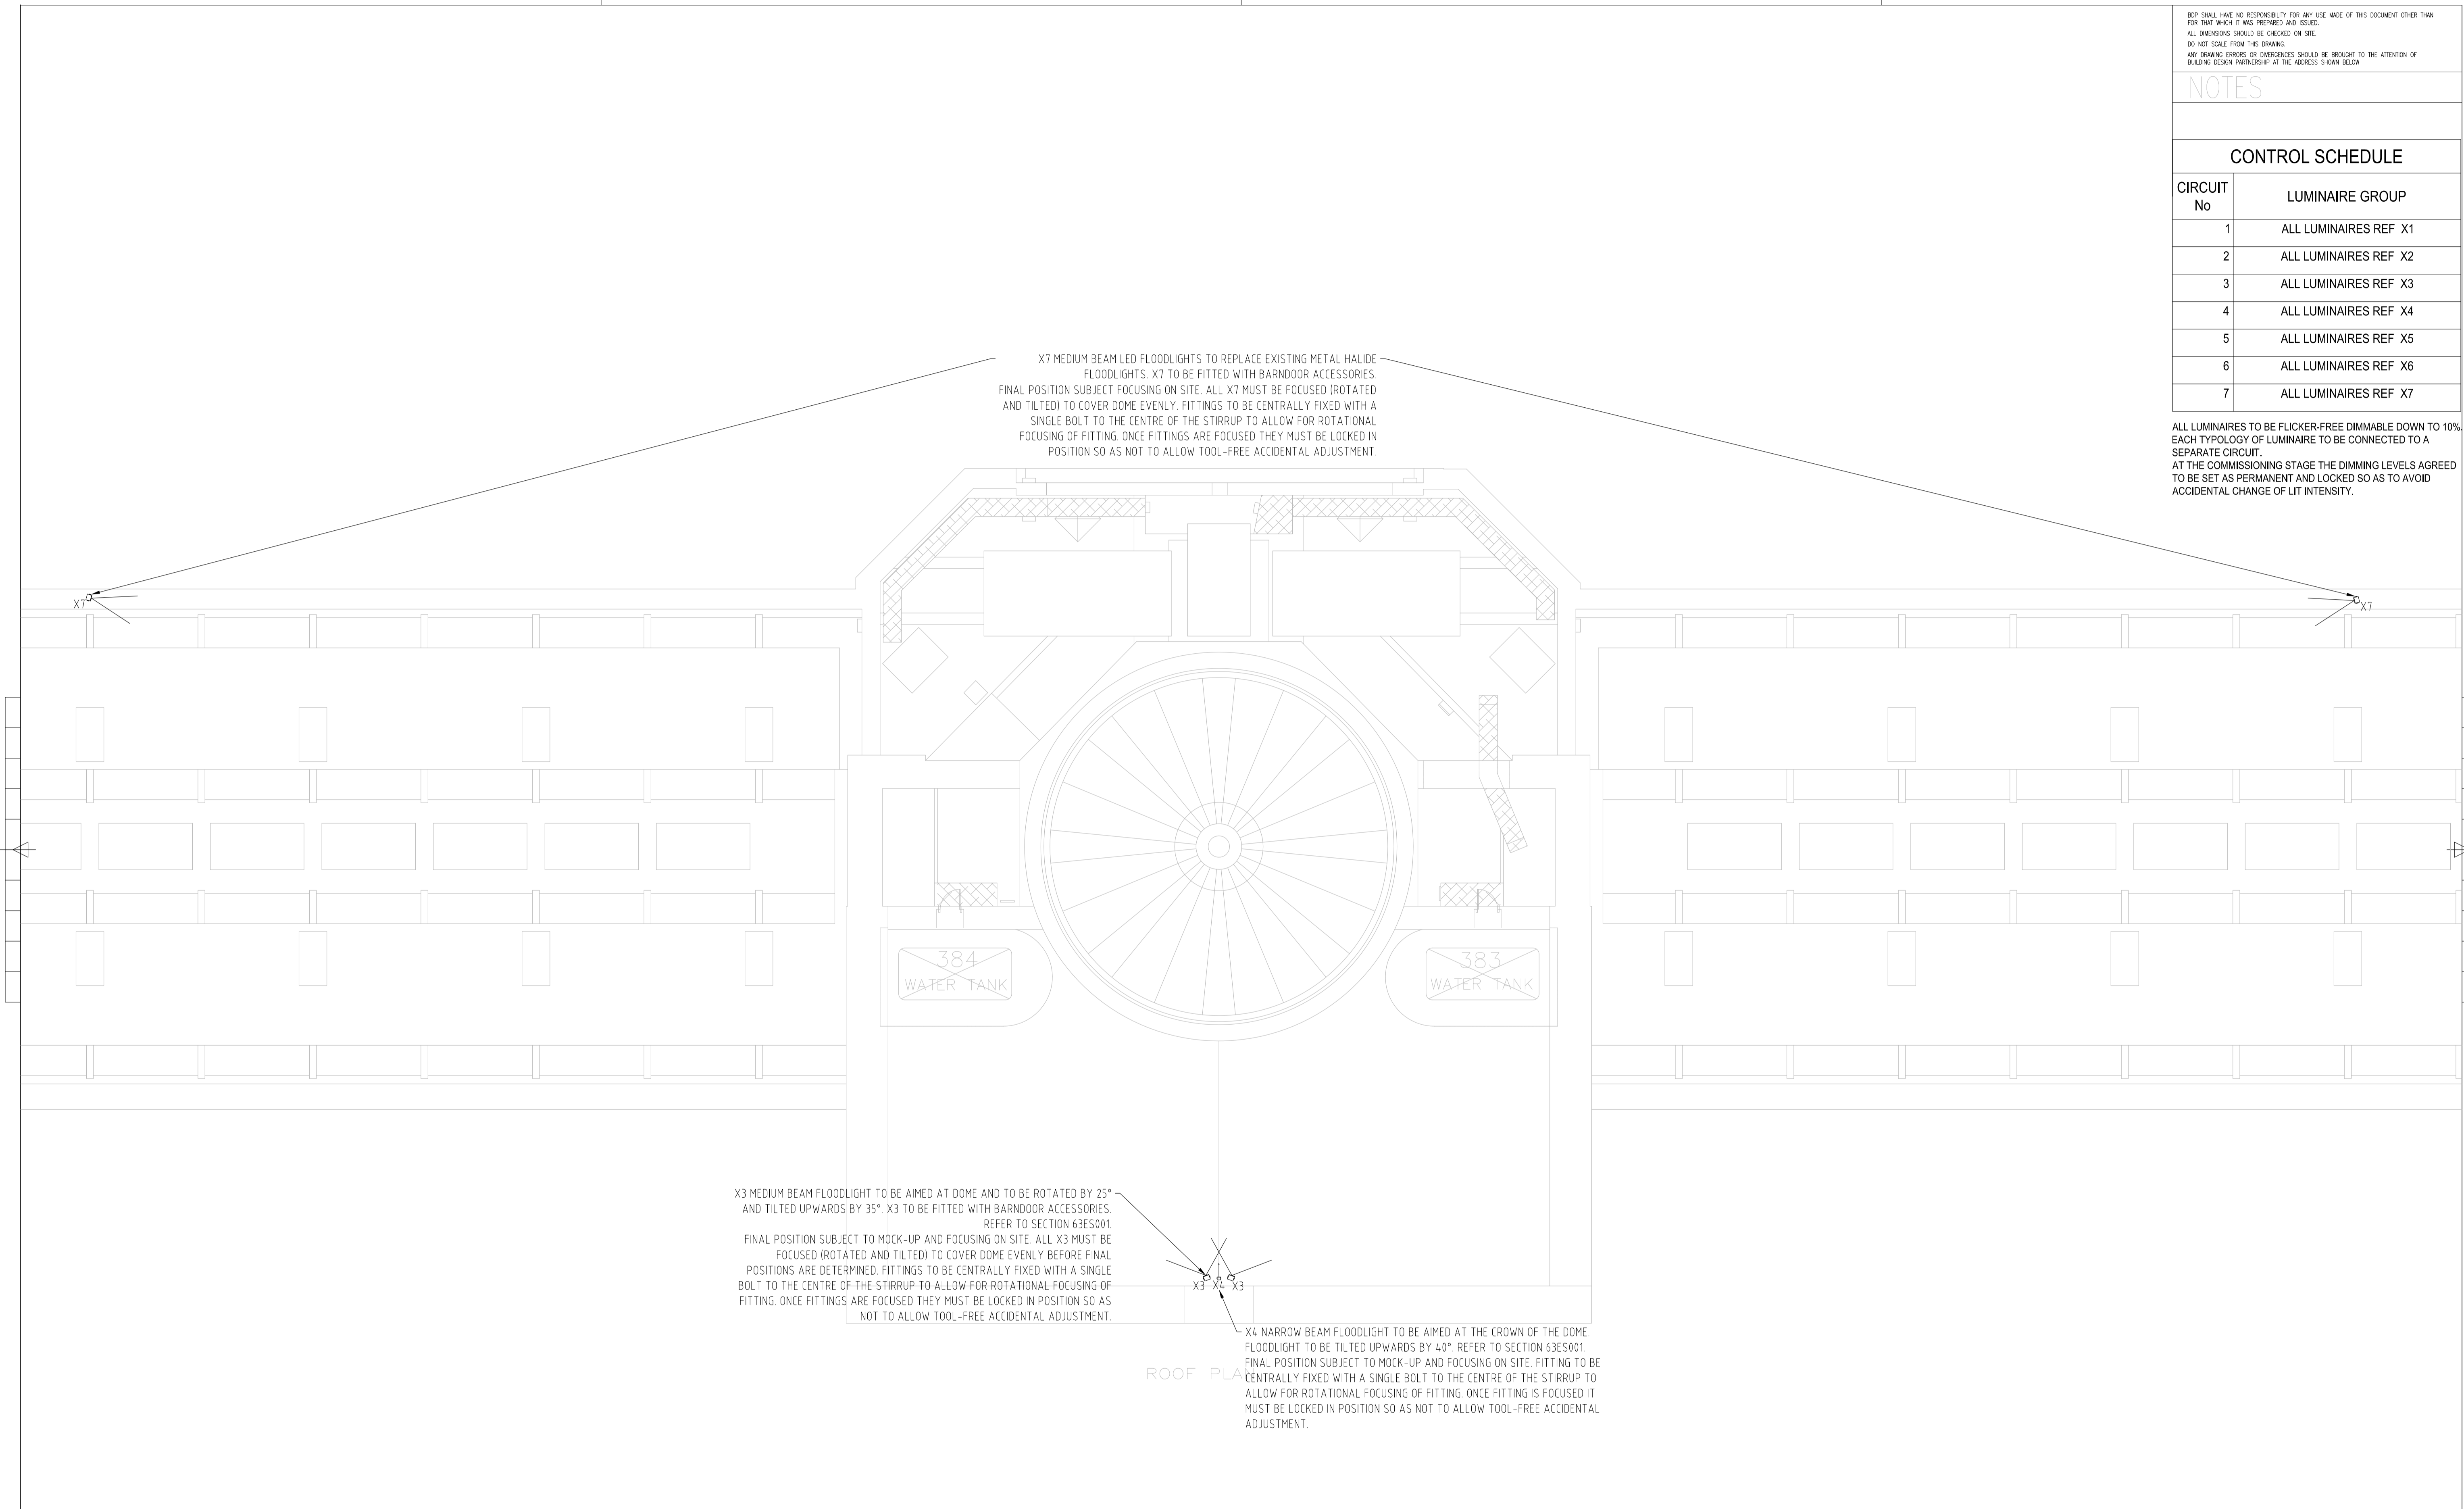

NO	REVISION / DESCRIPTION	DATE	BY	CHECKED	DATE



LK CB 04.11.16

16 Brewhouse Yard  
 Clerkenwell  
 London EC1V 4LJ  
 T +44 (0)20 7812 8000  
 F +44 (0)20 7812 8399  
 www.bdp.com



PROJECT		UCL PORTICO	
DRAWING TITLE	DATE	SCALE	© A1
HIGH LEVEL LIGHTING LAYOUTS - Roof Layout	04.11.2016	1:100	
DWG NUMBER	DWG NO.	REVISION	
P2007196	63EP003	-	