 




 
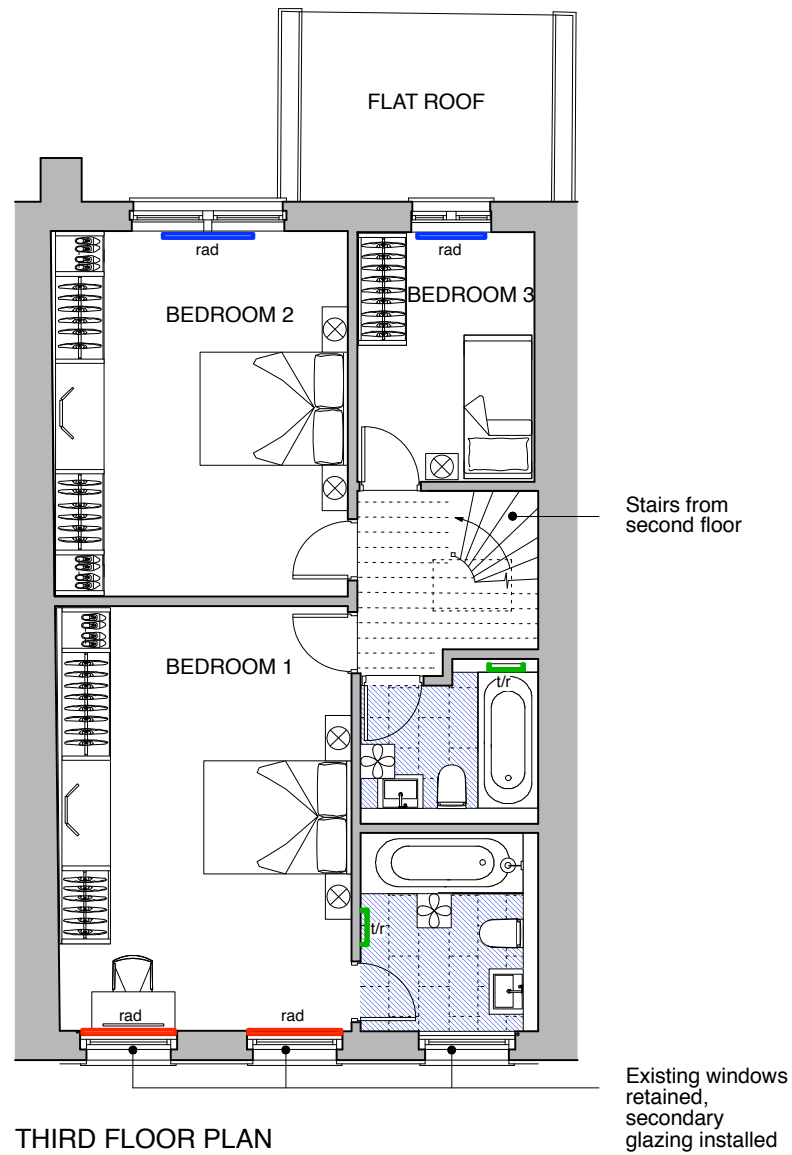


KEY LEGEND

-  Electric Heating Mat
-  Existing Radiators to be replaced with traditional Column Radiators and positioned to match existing
-  New Traditional Column Radiators
-  Tower Rails
-  Combi Boiler position
-  Extractor Fan position



NOTE
 Extractor fans at third floor level for 23 and 24 Montague to terminate at roof level.

GENERAL NOTES:
 DO NOT SCALE FROM THIS DRAWING.
 ALL DIMENSIONS MUST BE CHECKED ON SITE AND ANY DISCREPANCIES VERIFIED WITH THE ARCHITECT.

P1
 20.12.16 - Planning Issue

CLIENT
THE BEDFORD ESTATES

JOB TITLE
27 MONTAGUE STREET LONDON WC1B 5BH

DRAWING TITLE
PROPOSED SERVICES THIRD FLOOR PLAN

SCALE 1:100@A3	DATE 12.16
--------------------------	----------------------

FT ARCHITECTS LTD
 Hamilton House
 Mabledon Place
 Bloomsbury
 WC1H 9BB
 020 7953 0388
 www.ftarchitects.co.uk

DRAWING No. 319_30_05	REVISION P1
---------------------------------	-----------------------

