
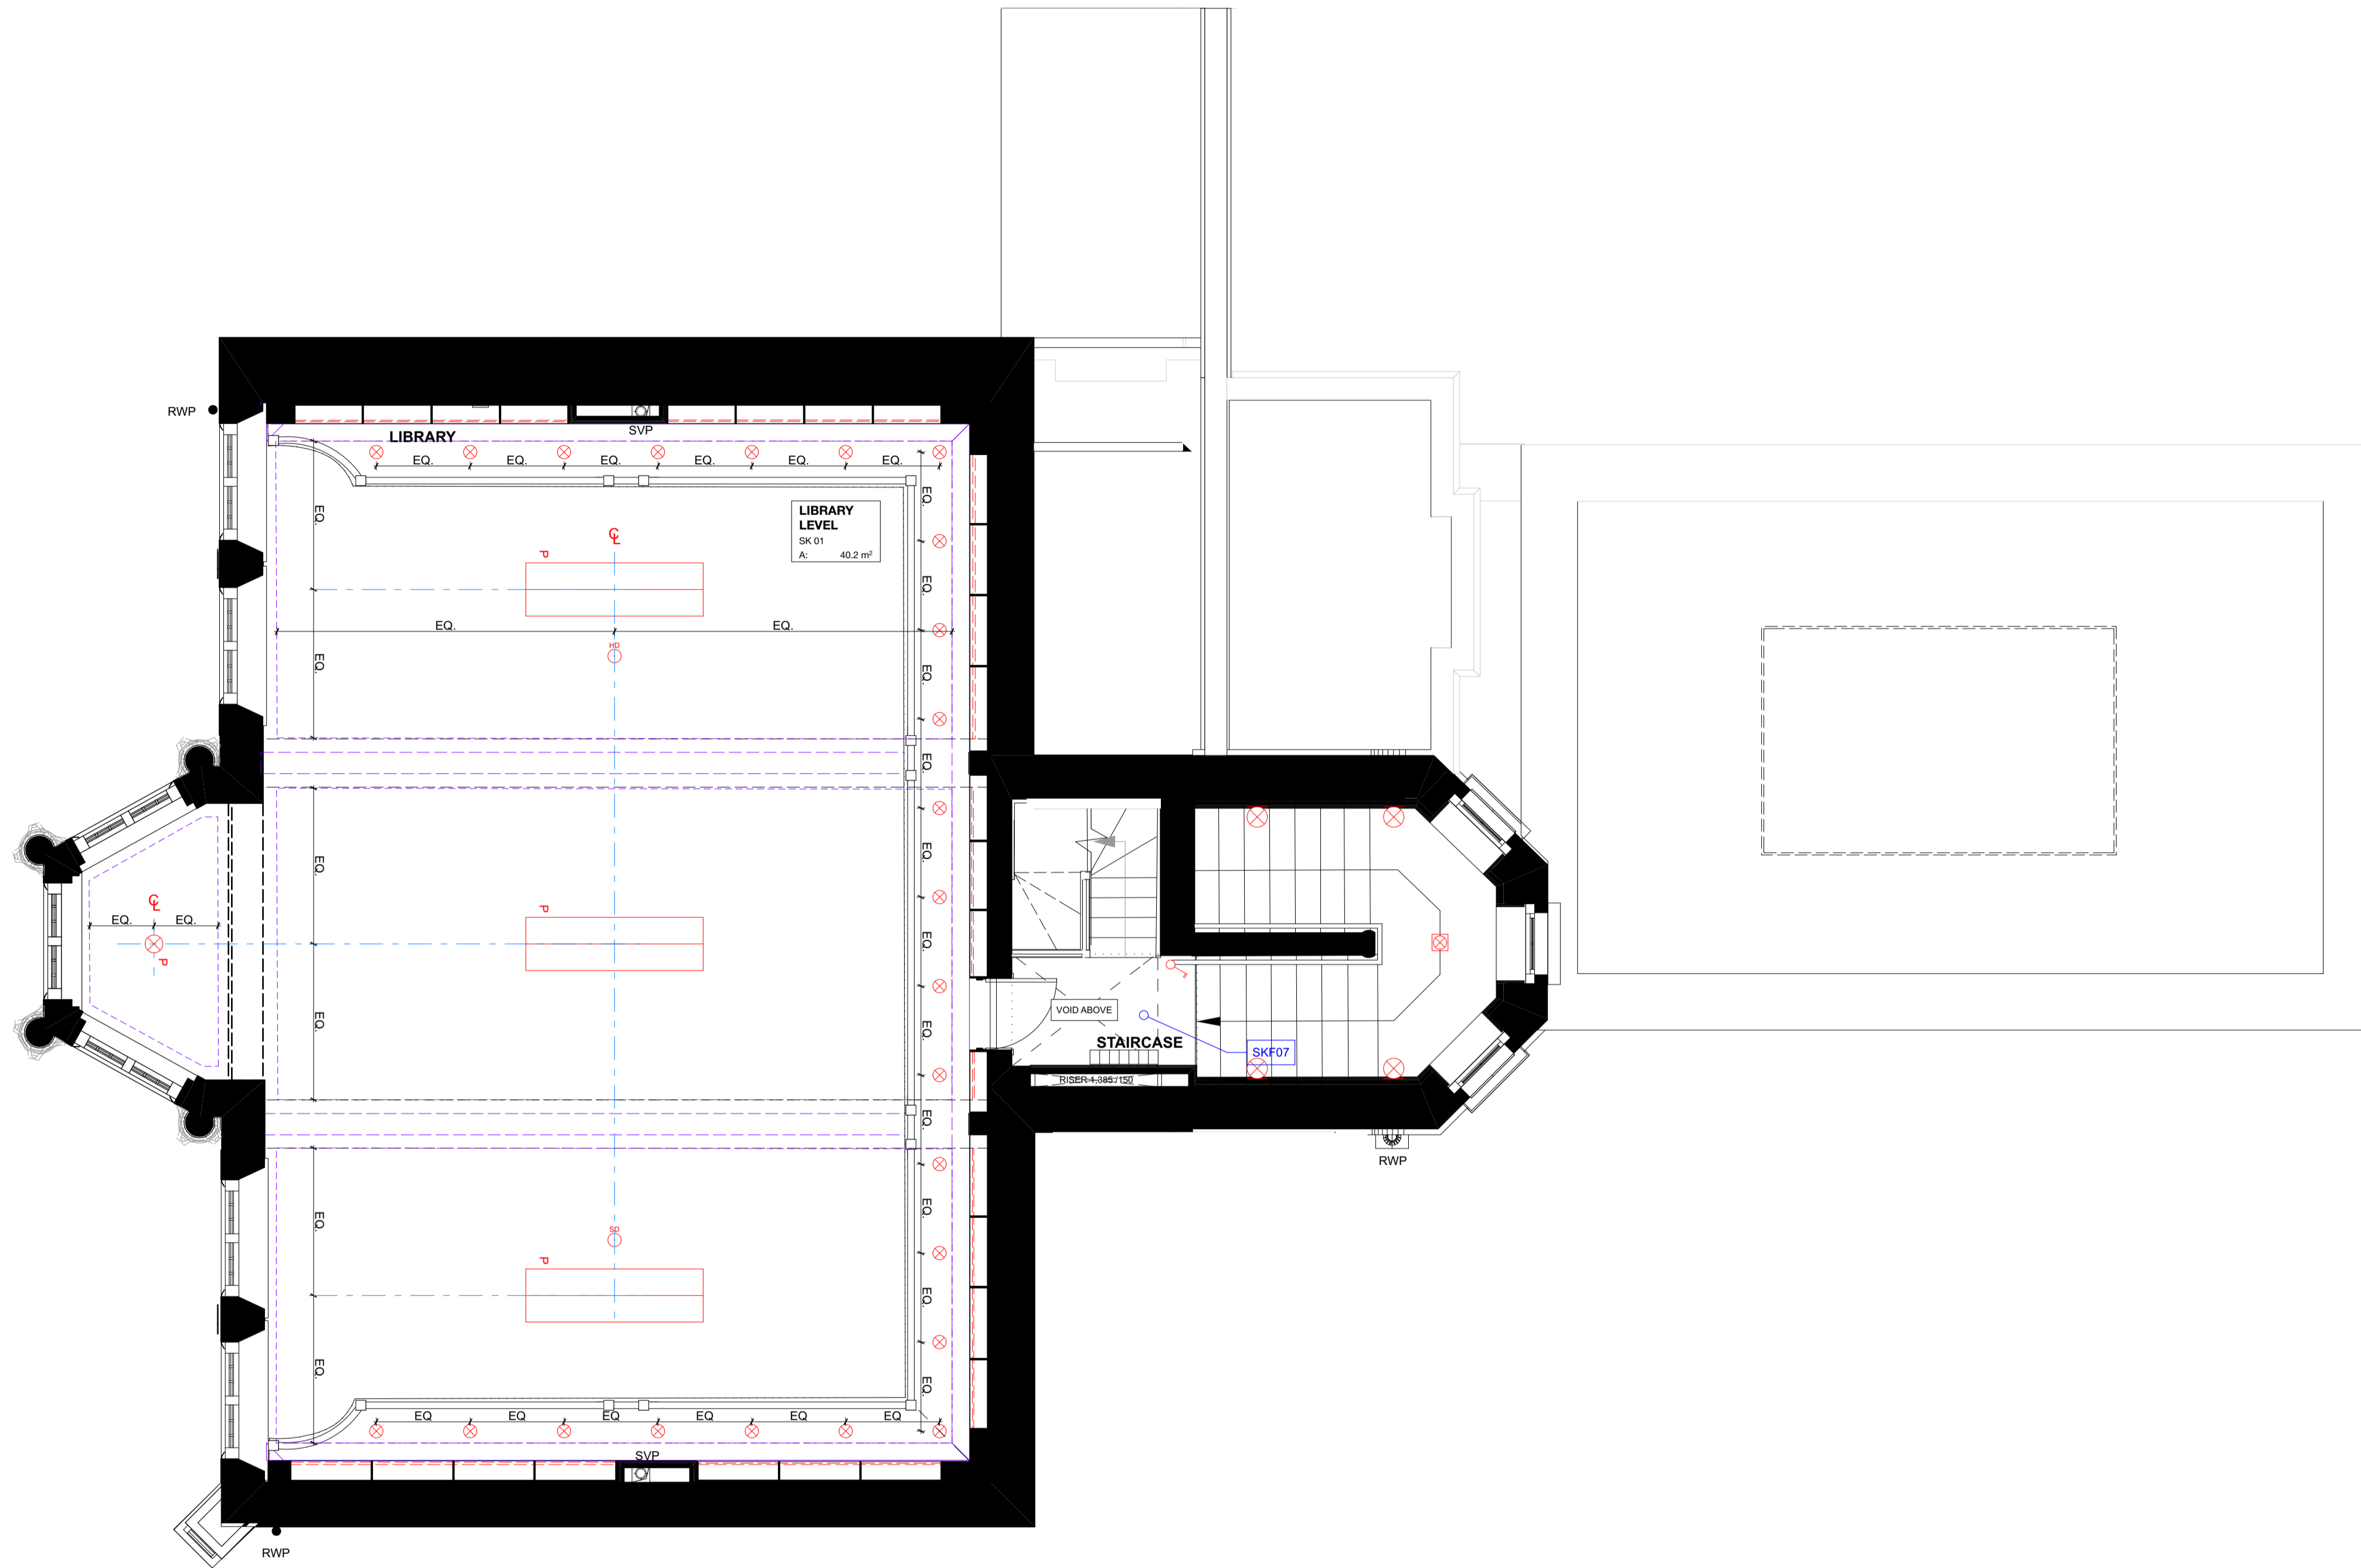


NOTE
 Refer to MKP drawings for Utility cupboard, kitchen and general electrical layouts.
 Wiring for pendant lights in Living, Dining and Master Bedroom.
 Wiring for speaker system in Living, Dining, kitchen and Master Bedroom, for future installation of speakers by customer.
 Please provide wiring for electrical Blind System

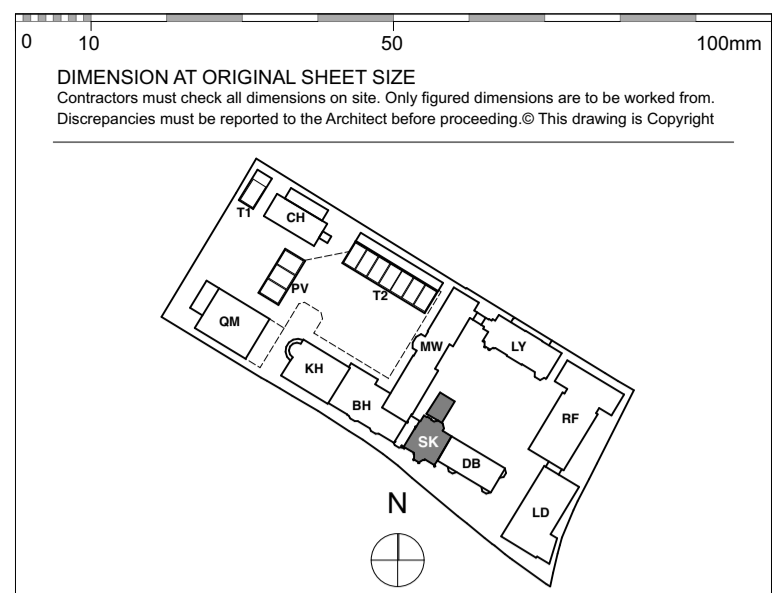

LEGEND
Lighting & Fire Alarm

Switch	PIR presence detector
2 way switch	Emergency Light
3 way switch	Fire Detector
Switch-dimmer	Fire Detector Sounder base & flashing beacon
Pendant light	Manual Fire alarm call point
Modular luminaire	Thermostat
Linear Luminaire	PopUp Socket and USB Port
Single directional downlights	450x450 Access Panel
Double directional downlights	
Wall light, internal	
Recessed low energy LED downlighter	
LED strip lighting to wardrobes & under wall units	
Wall light, external	
Recessed wall lights at floor level	
Wall light with sensor	
Double socket	
Shaver socket	
Shaver socket	
Video entryphone and intercom	
TV media plate. Refer to MAE specification	
BT phone & data point	
Floor recessed outlet	
Smoke detector	
Heat detector	
Extractor	
Air supply in	
Linear slot diffuser for supply & extract air	

CONSTRUCTION

REVISION	DRN	CHKD	DATE
C1 Issued for Construction	KGC	TW	12/12/2016



CLIENT
 MOUNT ANVIL LTD

PROJECT
 KIDDERPORE AVENUE

DRAWING
 Skeel Library
 Level MZ Proposed RCP and Small Power

SCALE 1:50 @ A1 DATE December 2016

DRAWING No. 15 230 DRAWN BY GC
 9000-DRG-23SK-MZ030 REV C1

A & Q PARTNERSHIP (LONDON) LTD
 THE LUX BUILDING, 2-4 HOXTON SQUARE, LONDON N1 6 NU
 Tel: 020 7613 2244 Fax: 020 7613 2642 Email: london@aqp.co.uk
 ARCHITECTURE DESIGN MASTERPLANNING INTERIORS