


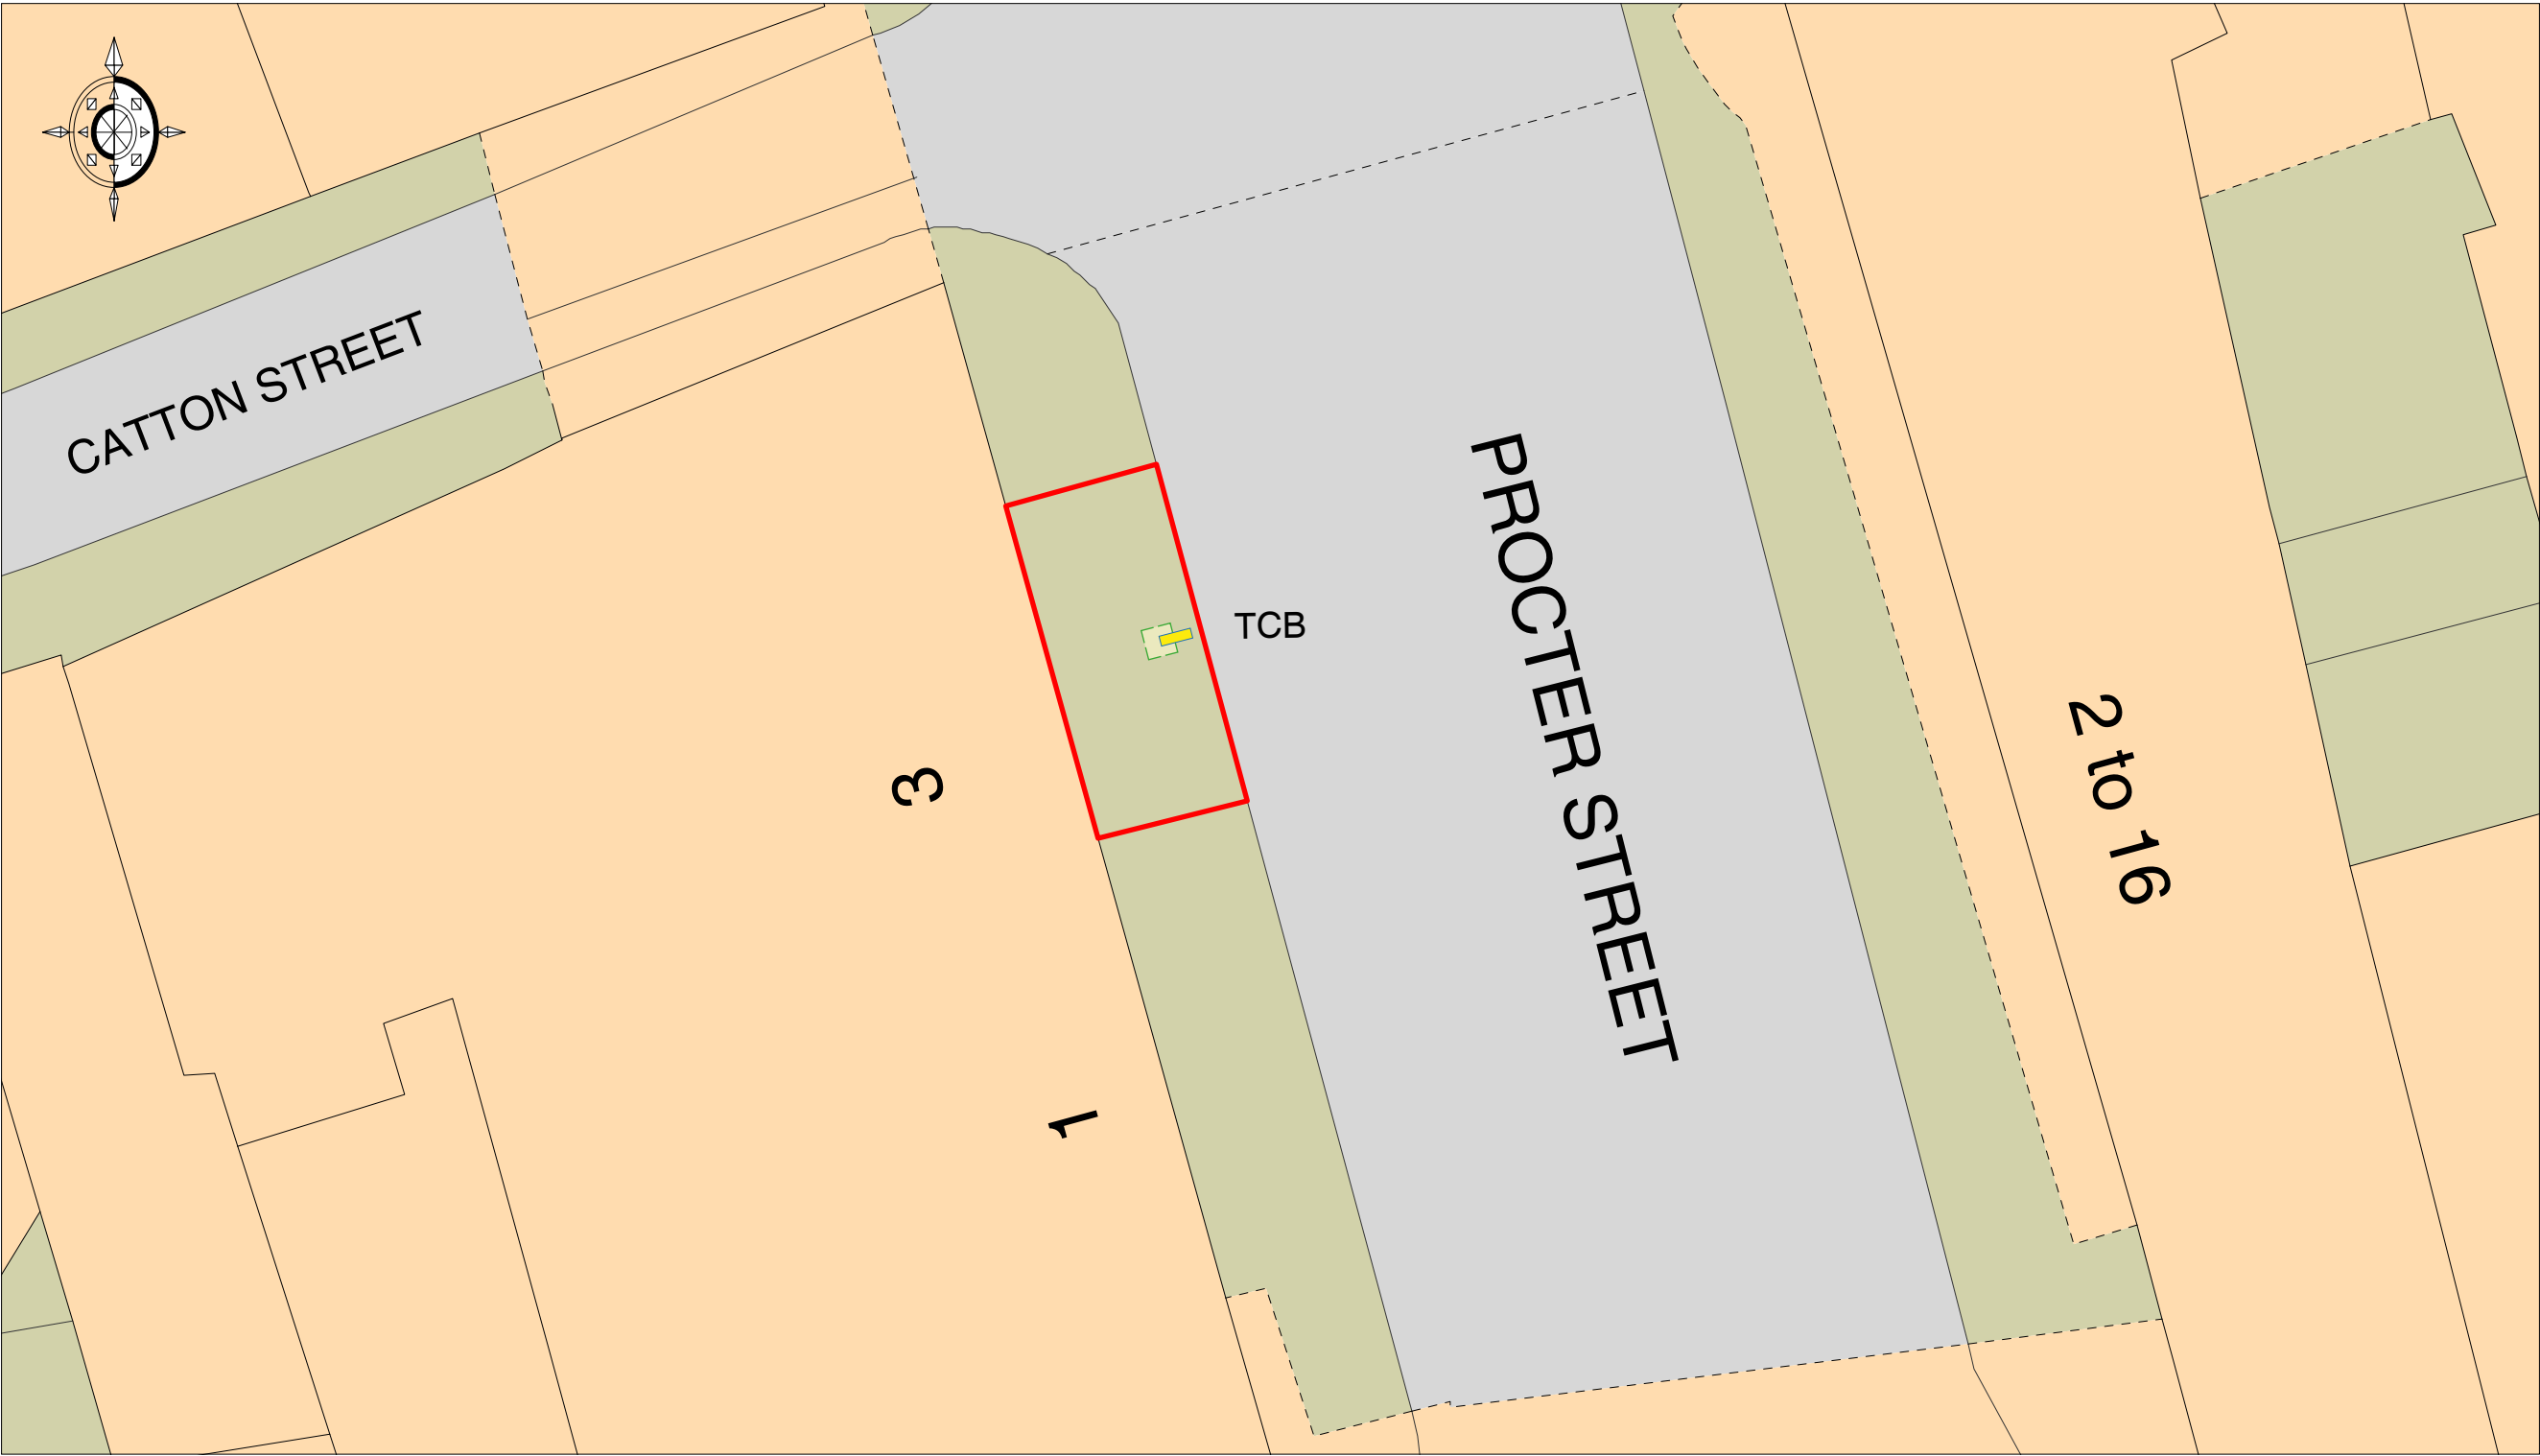

Ordnance Survey © Crown Copyright 2016. All rights reserved. Licence number 100022432. Plotted Scale - 1:200

-  Replacement of 1no. KX100 Telephone Kiosk with 1no. Link UK Unit
-  Link UK Unit
-  Site Location

Description:	Replacement of 1no. KX100 Telephone Kiosk with 1no. Link UK Unit	Dwg:	Existing & Proposed Site Plan	Dwg. No:	PY2808 - 001	Scale 1:200@A3
Site:	Procter Street (outside no 5-11 junction Catton Street) WC1V 6NX	Date:	10 January 2017			