


Proposed First Plan
1:50 Scale

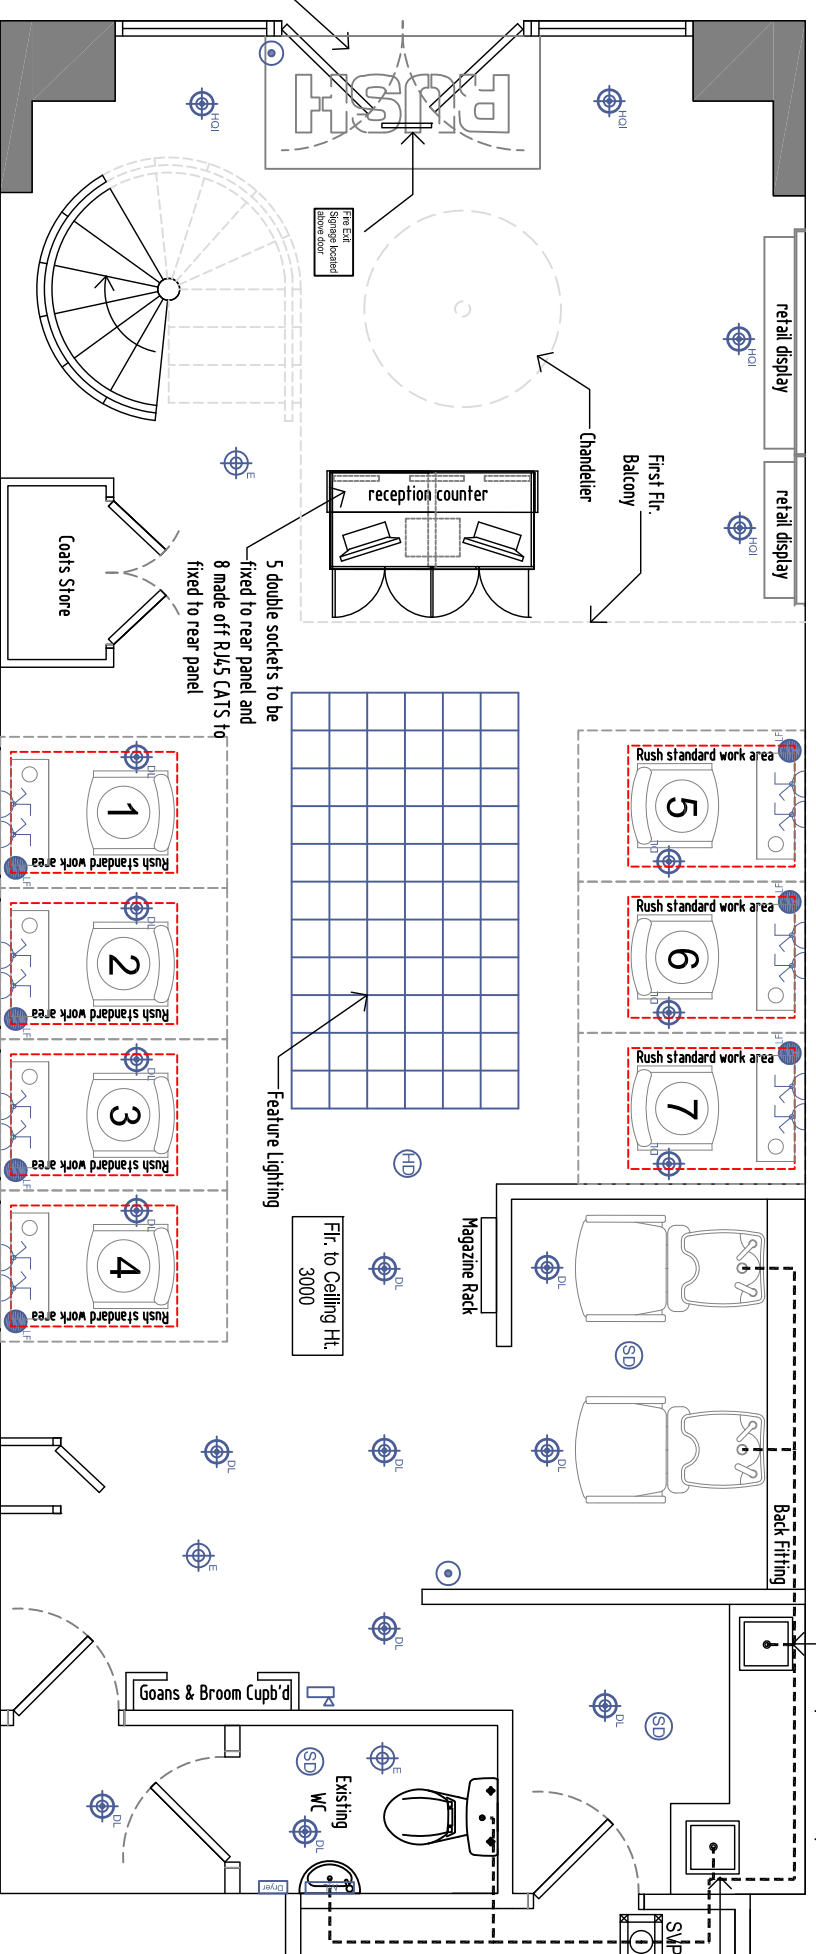

Proposed Ground Floor Plan
1:50 Scale

Mechanical & Electrical Legend	
	Fuse Spur
	Master BT Point
	Emergency Break Glass
	Alarm Sounder
	Heat Detector
	Smoke Detector
	DDA Emergency Pull Cord
	Audible DDA Emergency Beacon Button
	Hand Dry Unit
	Air Conditioning Unit
	Existing Ceiling Mounted Extract Fan
	Existing Radiators

Lighting Legend	
	Fluorescent Emergency Lighting
	Fluorescent Lighting
	19mm Daylight LED Lighting
	Hydrargyrum quartz iodide (H.O.I.) Lighting
	Emergency Lighting
	LED Spotlighting
	Dimmer Switch
	Light Feed
	Mirror Light
	Main Light Switch Panel

Item	Description	By	Date
Revisions:			

MG4 Designs Ltd
 T: 07951 856 304 • E: studio@mg4design.com
 WWW.MG4DESIGN.COM

Rush Hair Ltd,
 3rd Floor Central House,
 27 Park Street
 Croydon, CR0 1YD

Client:	Rush
Project:	Rush Hair Salon Hoborn London

Title:	Proposed Lighting & Small Electrical Layout
Scale:	1:50 @ A3
Date:	17.09.16
Job No.:	523
Dwg No.:	03
Drawn:	PG/DC
Checked:-	