

The logo of the London Underground, featuring a red circle with a white horizontal bar across the center containing the word "UNDERGROUND" in blue capital letters.

STATION LAYOUT

Produced on behalf of the
JNP Fire Compliance Manager
by the Fire Compliance Team for
London Underground Limited.

Total of 08 Drawings
N093-01 to 08

Drawing number:
N093-01s

Issue: 17 (2008/09)

Revision: C

Survey Date: 04:12:08

Date: 03:02:15

Drawn by: AL

Drawn by: MH

Information current at date shown. For the latest information please contact the JNP Fire Safety Unit (FSU)

Revision

N093-01 INFORMATION SHEET
N093-02 AXONOMETRIC
N093-03 STREET PLAN
N093-04 TICKET HALL
N093-05 BASEMENT
N093-06 PLATFORMS 1& 2 (SOUTH END)
N093-07 PLATFORMS 1& 2 (NORTH END)
N093-08 FIRST FLOOR PLAN

A, B, 1, 2, ...

2/731	STATION AREA/ROOM ID NUMBER
* 2/731	STATION AREA ID NUMBER NON-PUBLIC AREA. NO PLATE REQUIRED
* 2/011	STATION AREA ID NUMBER PUBLIC AREA. NO PLATE REQUIRED
	ARROWS ON ESCALATORS, STAIRS & RAMPS POINT UPWARDS
	PLATFORM BARRIER & SLIDING DOORS (JLE)
A,B,1,2....	STATION ENTRANCE LETTER/NUMBER
GLA / CG	GATE LINE ATTENDANT / COLLAPSIBLE GATES
UTB / PVAL	USED TICKET BIN / PEDESTAL VALIDATOR
S	STRETCHER
IC / LP	INSPECTION CHAMBER / LAMP POST
MH	MANHOLES TO ESC. MACHINE CHAMBERS & PLAT. INVERTS. STN STAFF TO SUPPLY KEY.
N/S / N/S N	METRO NEWSPAPER STAND (FIXED) / (NOMINAL)
PT	PUBLIC TELEPHONE
S/BIN	SAND BIN
S.MAP	SNAP MAP VENDING MACHINE
U	UTS GATE CONTROL & EMERGENCY BUTTON

© London Underground Limited.	Produced by JNP Building Control	Group.	Enquiries should be directed to 020 7088 4357 / 4761	03/02/2015	10:49:46
-------------------------------	----------------------------------	--------	--	------------	----------

Mornington Crescent

Axonometric

STATION LAYOUT

Not for construction purposes




Tube Lines
15 Westferry Circus
Canary Wharf
London E14 4HD

Total of 08 Drawings N093-01 to 08	Drawing number: N093-02s
Issue: 17 (2008/09)	Revision:
Survey Date: 04:12:08	Date:
Drawn by: AL	Drawn by:
Information current at date shown. For latest information contact Building Control 020 7088 4357/4356/4361	

MSLn (station)

Plotted by : bold3467 TLL

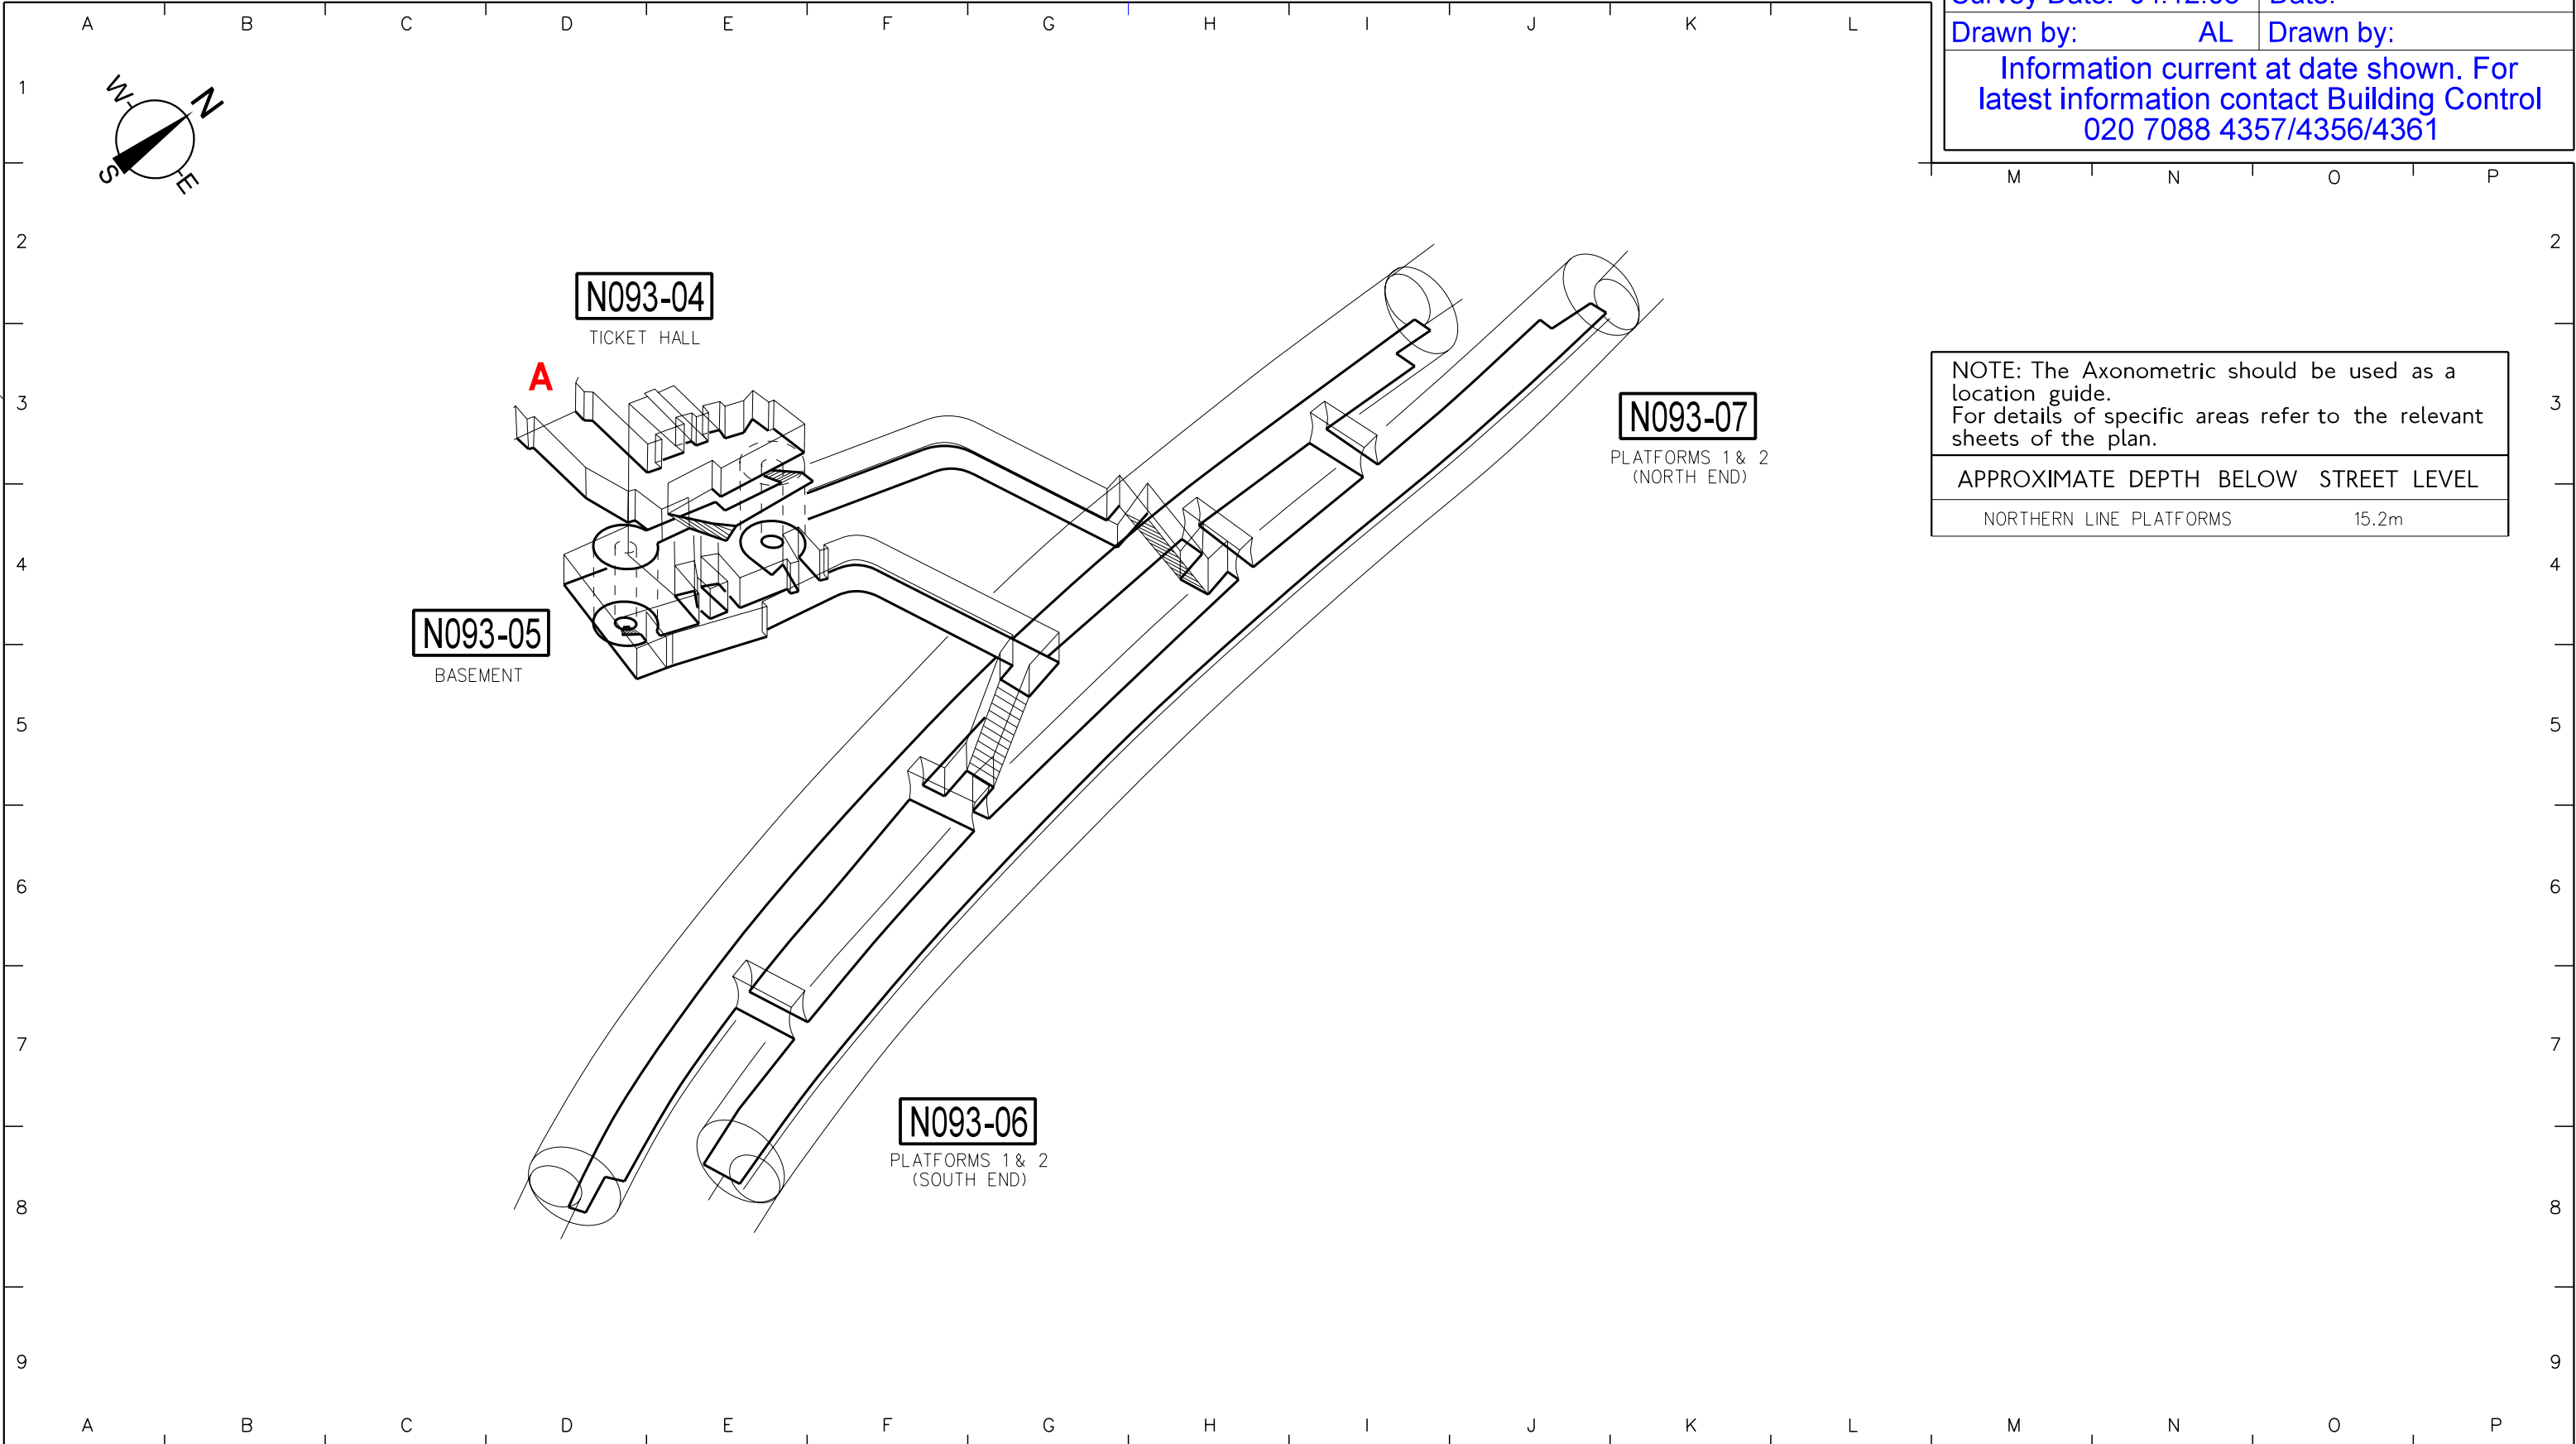

NOTE: The Axonometric should be used as a location guide.
For details of specific areas refer to the relevant sheets of the plan.

APPROXIMATE DEPTH BELOW STREET LEVEL	
NORTHERN LINE PLATFORMS	15.2m

10/02/2009
© Tube Lines Limited. Produced by Building Control, Tube Lines Limited. Enquiries should be directed to 020 7088 4357/4356/4361

Mornington Crescent

Street Plan


STATION LAYOUT

Not for construction purposes



Tube Lines
15 Westferry Circus
Canary Wharf
London E14 4HD

Total of 08 Drawings N093-01 to 08	Drawing number: N093- 03s
Issue: 17 (2008/09)	Revision:
Survey Date: 04:12:07	Date:
Drawn by: AL	Drawn by:
Information current at date shown. For latest information contact Building Control 020 7088 4357/4356/4361	

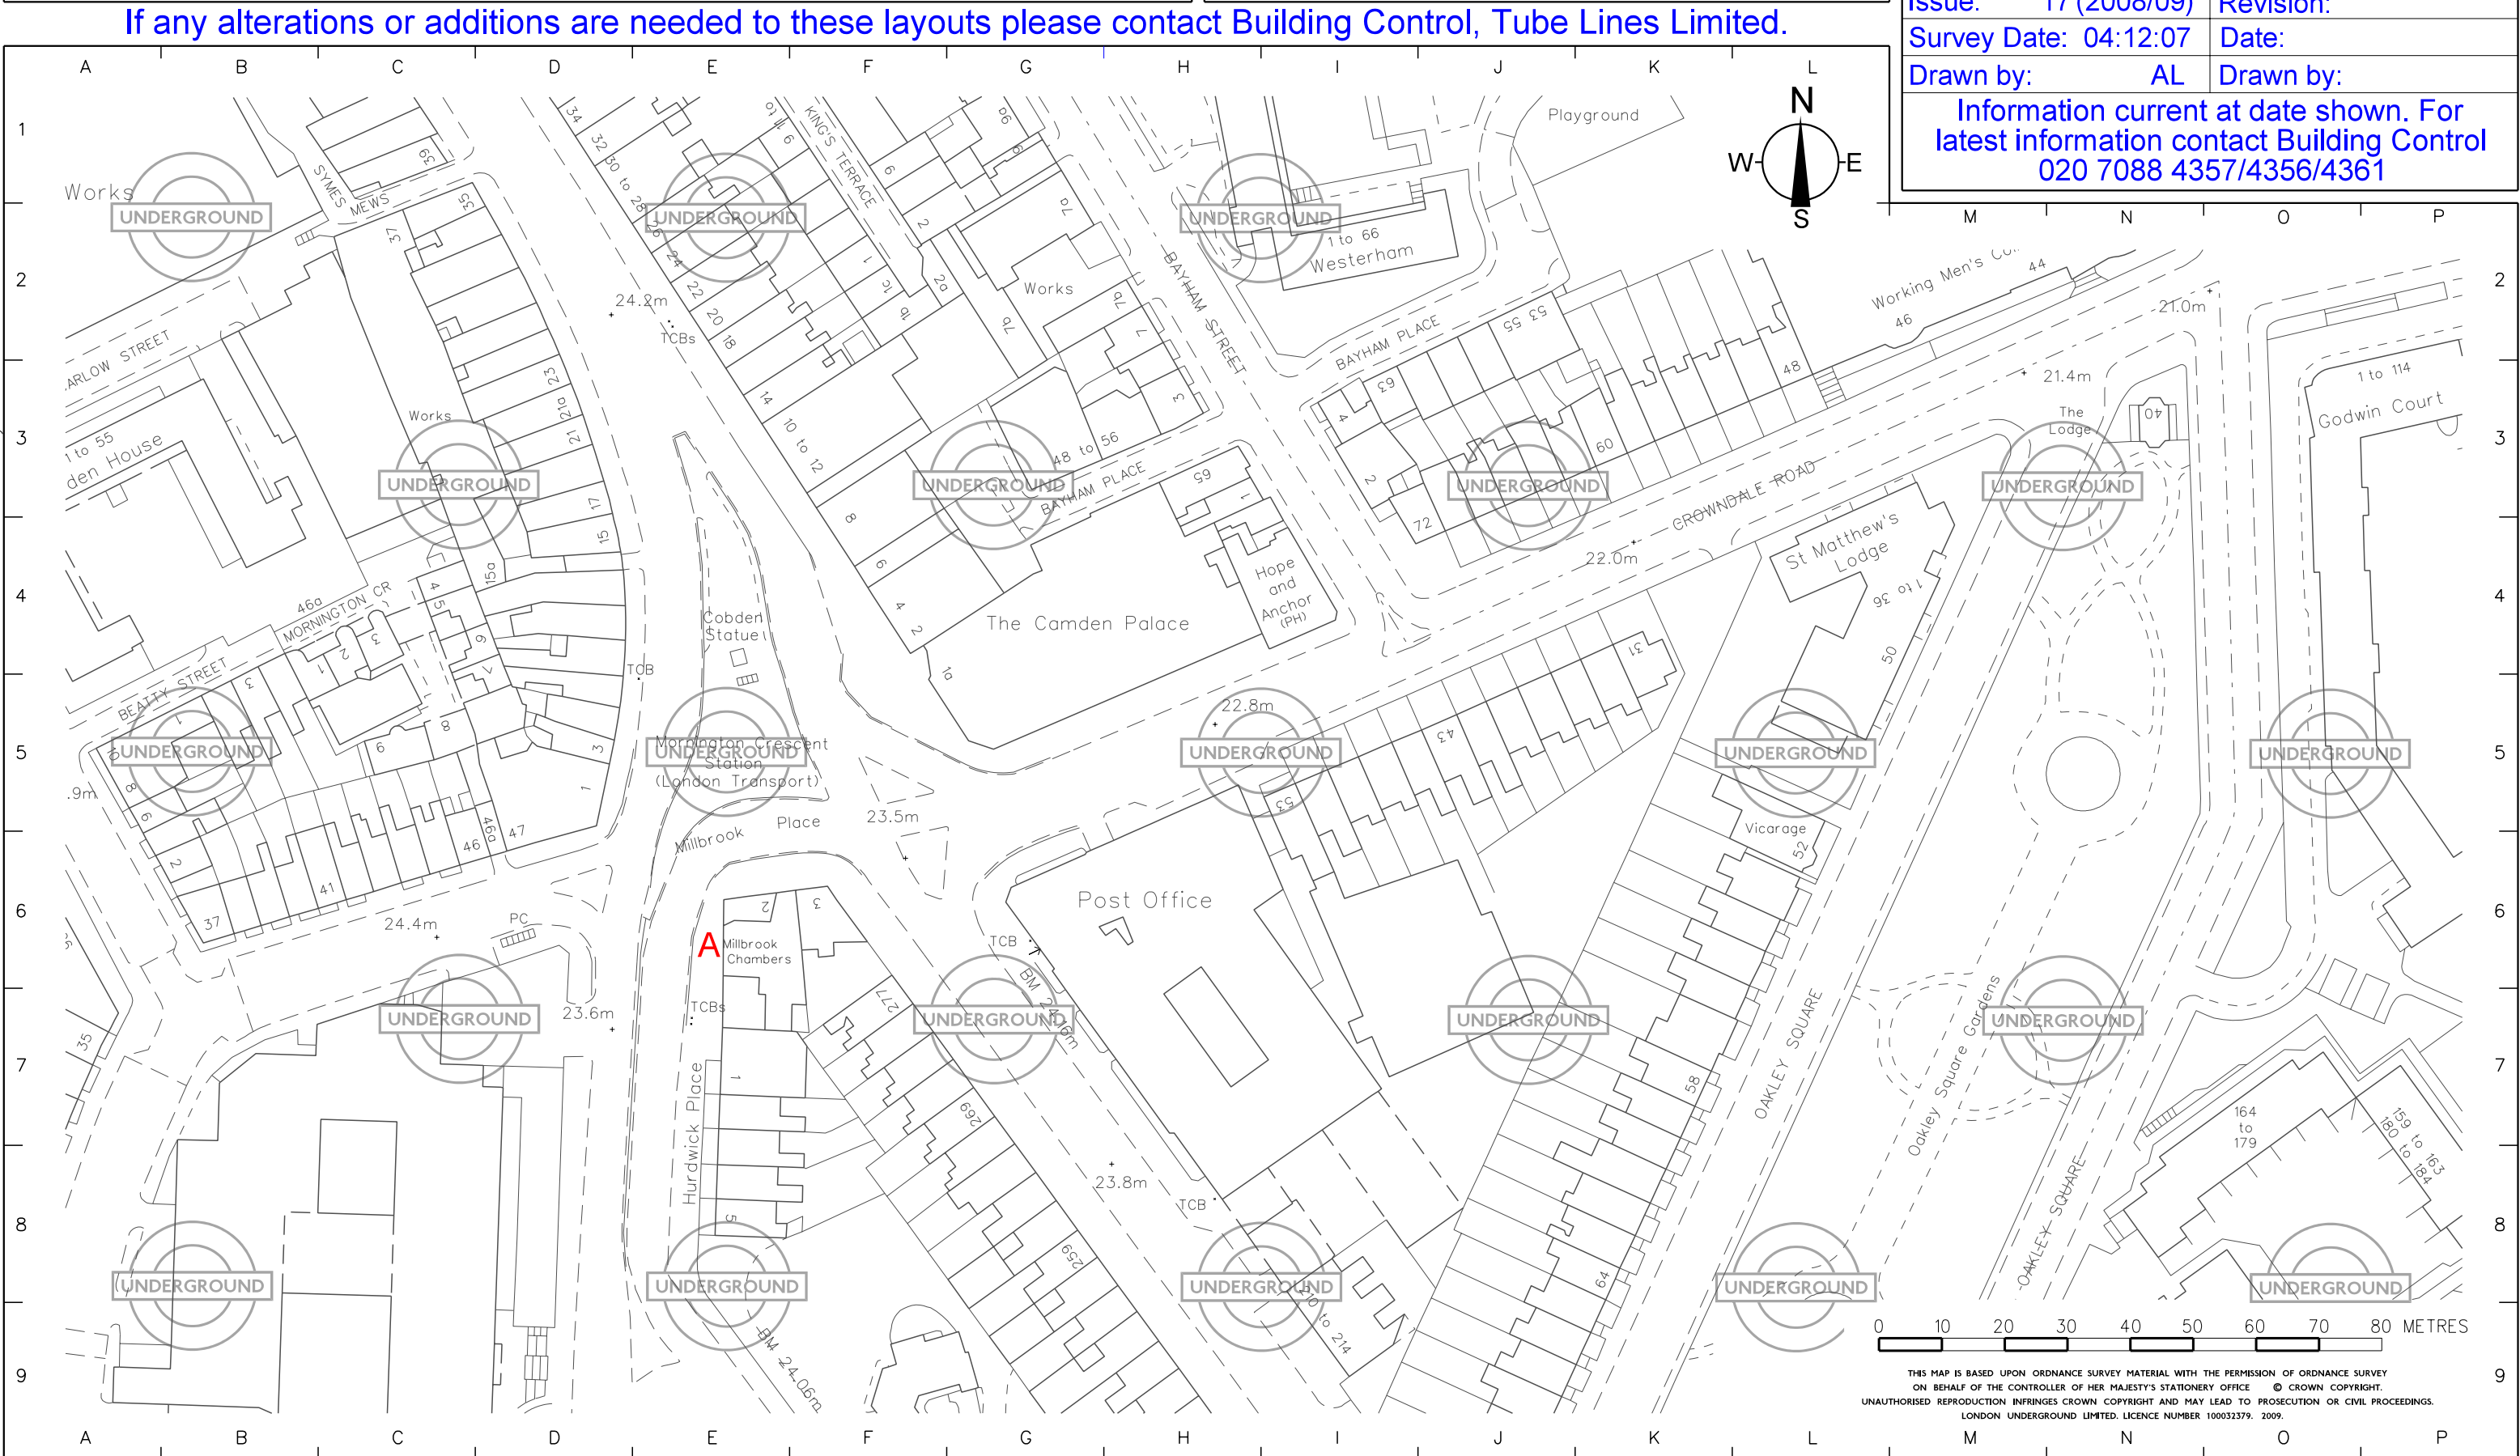

Mornington Crescent

Ticket Hall



STATION LAYOUT

Not for construction purposes

Produced on behalf of the
JNP Fire Compliance Manager
by the Fire Compliance Team for
London Underground Limited.

Total of 08 Drawings
N093-01 to 08

Drawing number:
N093- 04s

Issue: 17 (2008/09)

Revision:	B
-----------	---


Survey Date: 04:12:08

Date:	03:02:15
-------	----------

Drawn by:	AL
-----------	----

Drawn by:	MH
-----------	----

Information current at date shown. For the latest information please contact the JNP Fire Safety Unit (FSU)

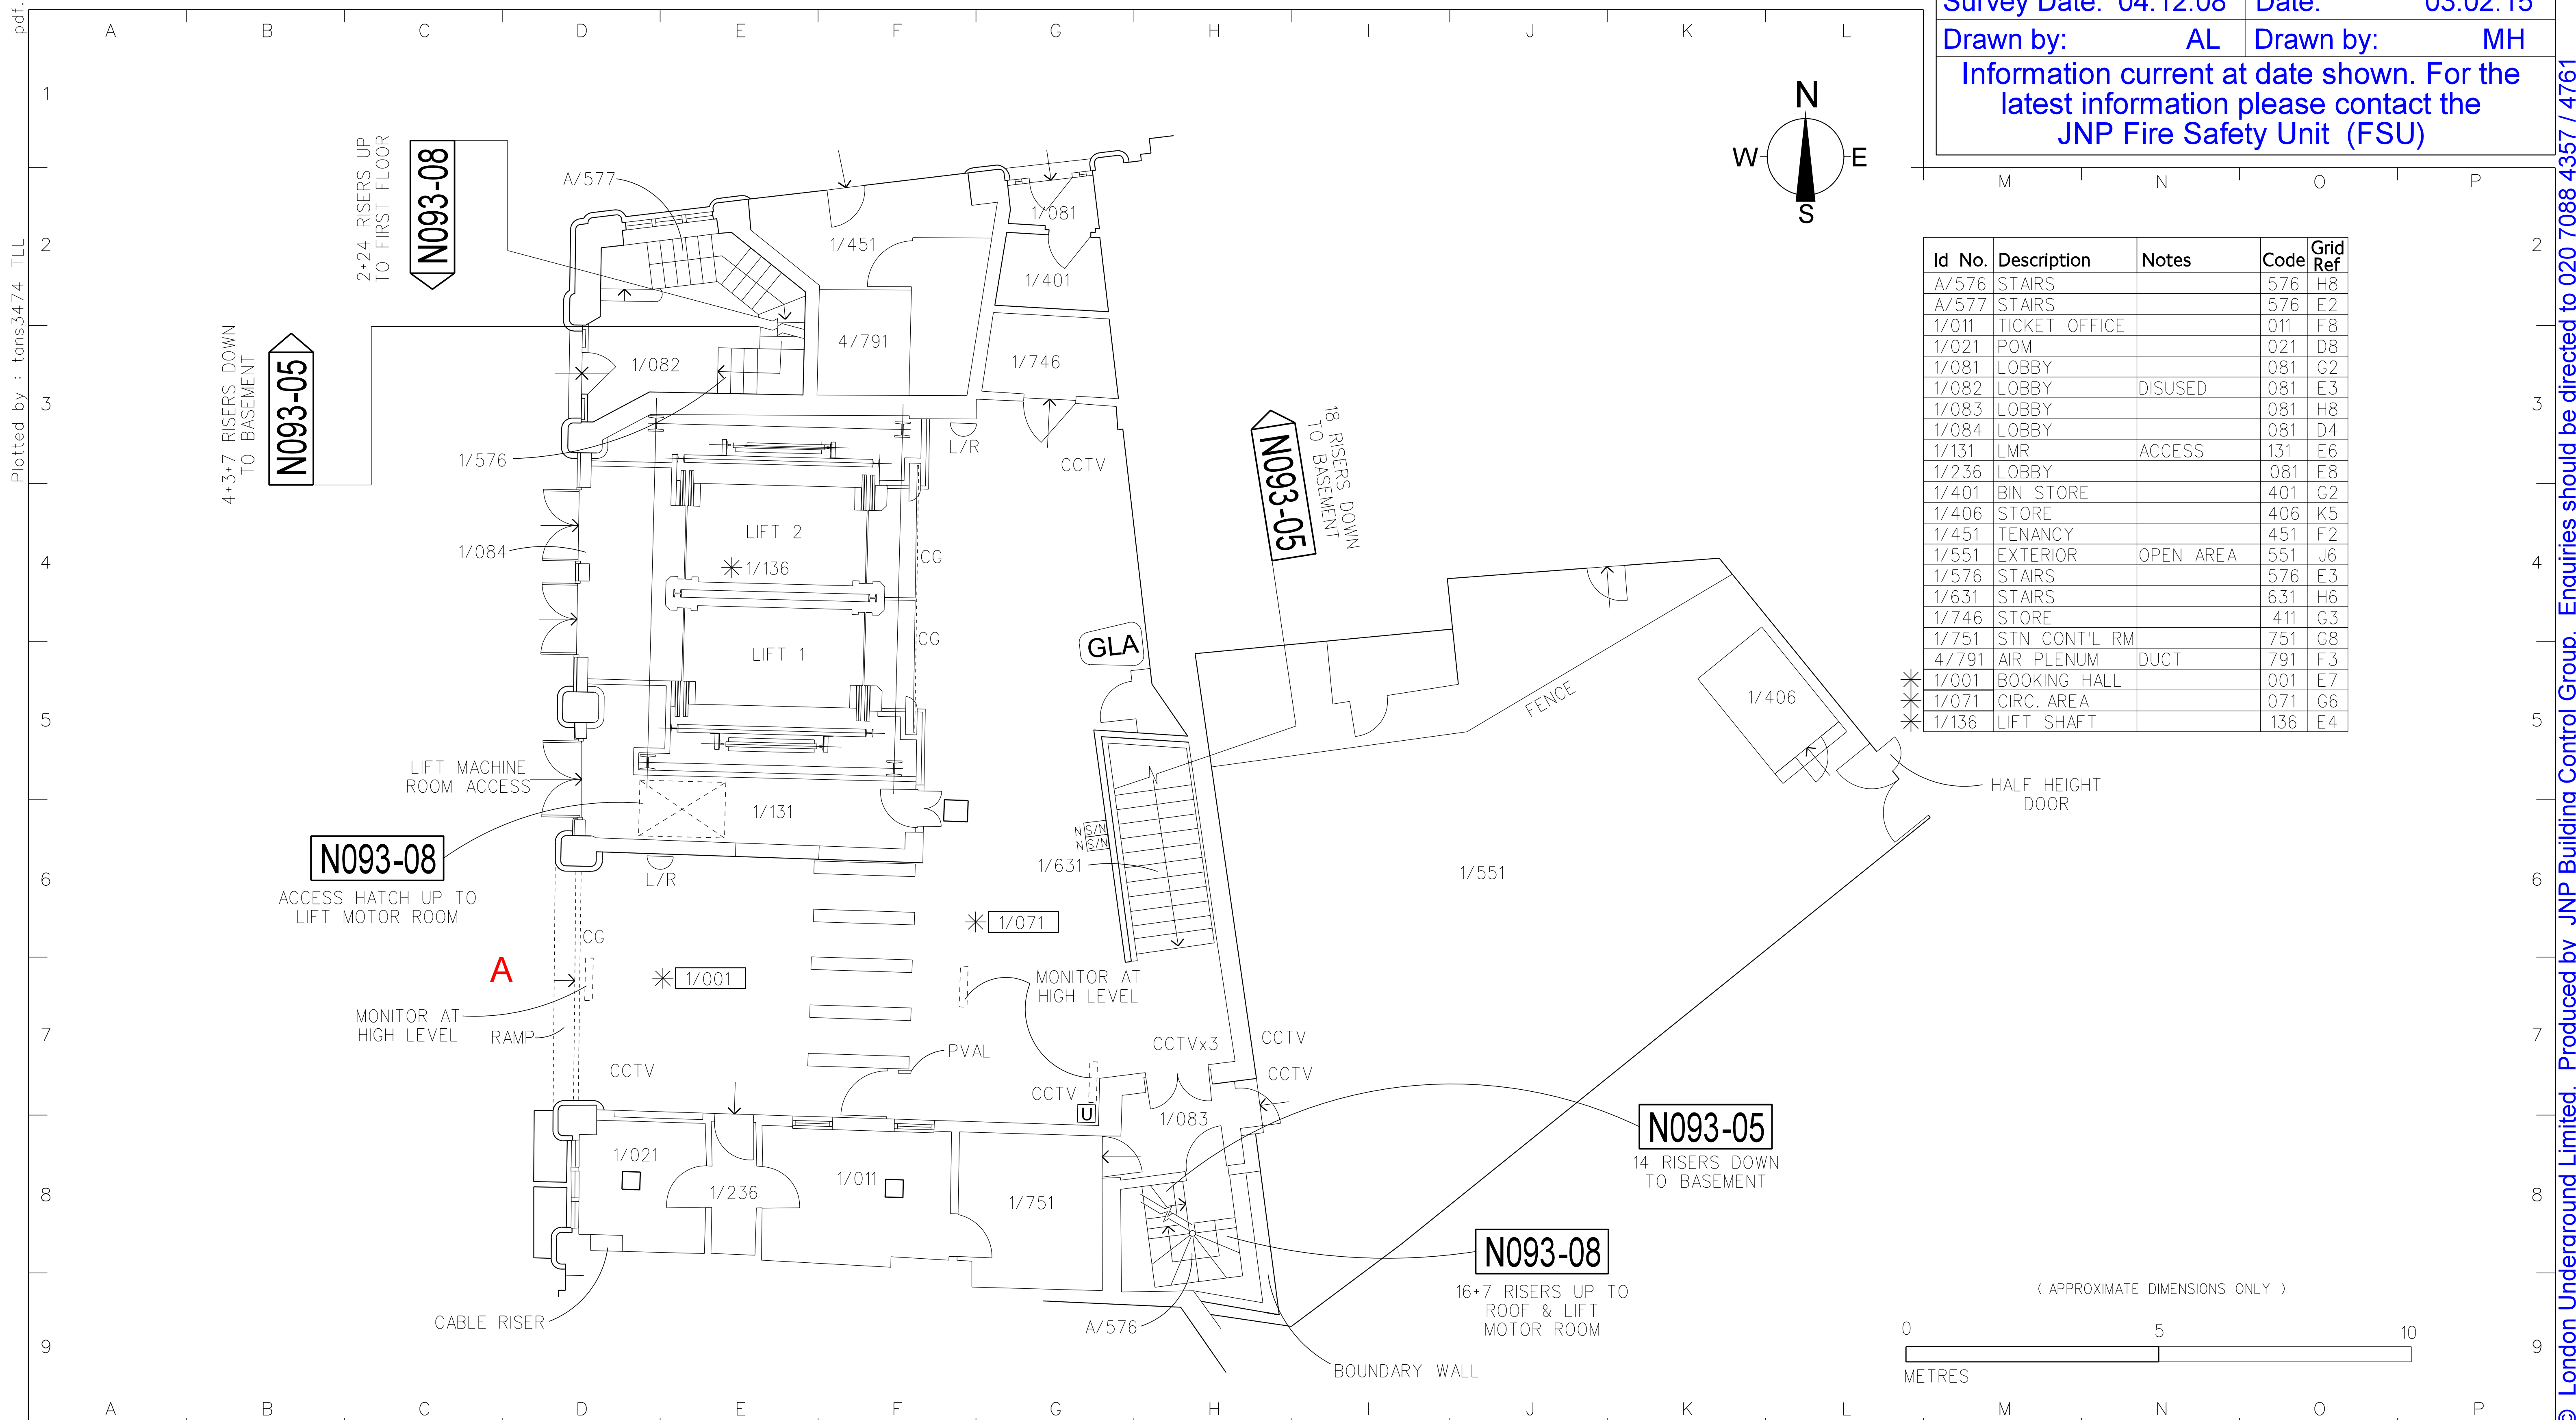


STATION LAYOUT

Not for construction purposes

 Tube Lines 15 Westferry Circus Canary Wharf London E14 4HD	
Total of 08 Drawings N093-01 to 08	Drawing number: N093-05s
Issue: 17 (2008/09)	Revision:
Survey Date: 04:12:08	Date:
Drawn by: AL	Drawn by:
Information current at date shown. For latest information contact Building Control 020 7088 4357/4356/4361	

A horizontal number line with four points labeled M, N, O, and P. M is at the left end, N is at the first tick mark, O is at the second tick mark, and P is at the third tick mark. The line extends to the right beyond P.

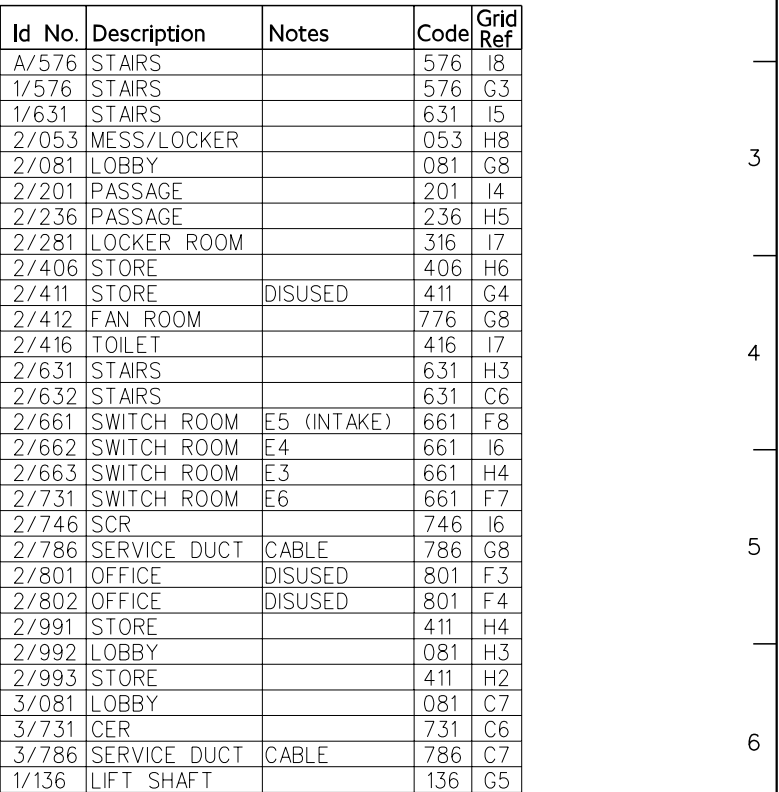

A horizontal number line is shown with tick marks at 0, 5, 10, and 15. The word "METRES" is written below the line. The line is divided into three equal segments of 5 metres each. The first segment (from 0 to 5) is shaded red, the second segment (from 5 to 10) is unshaded, and the third segment (from 10 to 15) is shaded blue.

Platforms 1 & 2 (South End)



Not for construction purposes

© London Underground Limited. Produced by JNP Building Control Group. Enquiries should be directed to 020 7088 4357 / 4761 03/02/2015 10:49:55


Drawing number:
N093- 06s

Revision: B

Date:	03:02:15
-------	----------


Drawn by:	MH
-----------	----

Information current at date shown. For the latest information please contact the JNP Fire Safety Unit (FSU)

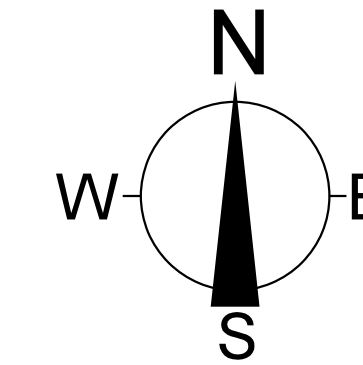

	ID No.	Description	Notes	Code	Grid Ref
	2/631	STAIRS		631	D4
	2/632	STAIRS		631	D6
	4/081	LOBBY		081	C6
	4/201	PASSAGE		201	E6
	4/202	PASSAGE		201	E4
	4/203	PASSAGE		201	D6
	4/204	PASSAGE		201	C6
	4/205	PASSAGE		201	D3
	4/206	PASSAGE		201	F3
	4/207	PASSAGE		201	F2
	4/601	STAIRS		601	G3
	4/602	STAIRS		601	F1
	4/661	CER		731	E6
	4/731	CER		731	D6
	4/787	VENT TUNNEL	CABLE	791	D7
	4/901	VENT TUNNEL	ACCESS PU/RM	791	D6
	5/201	PASSAGE		201	I6
	5/202	PASSAGE		201	H4
	5/712	RELAY ROOM		711	K9
	5/771	PUMP ROOM		771	G9
✱	5/261	PLATFORM 1		261	I6
✱	5/262	PLATFORM 2		261	J6
✱	1/136	LIFT SHAFT		136	D5

(APPROXIMATE DIMENSIONS ONLY)

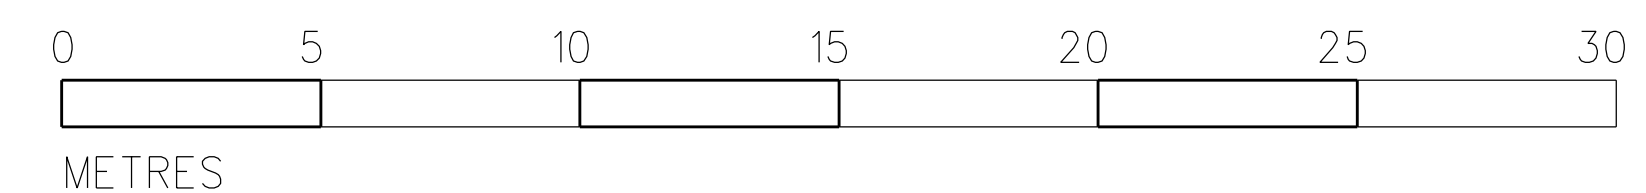

Mornington Crescent

Platforms 1 & 2 (North End)



STATION LAYOUT

Not for construction purposes

Produced on behalf of the
JNP Fire Compliance Manager
by the Fire Compliance Team for
London Underground Limited.

Total of 08 Drawings
N093-01 to 08

Drawing number:
N093-07s

Issue: 17 (2008/09)

Revision: **A**

Survey Date: 04:12:08


Date: 03:02:15

Drawn by: **AL**

Drawn by: **MH**

Information current at date shown. For the
latest information please contact the
JNP Fire Safety Unit (FSU)

Id No.	Description	Notes	Code	Grid Ref
4/602	STAIRS		601	I8
5/203	PASSAGE		201	H7
5/204	PASSAGE		201	G5
5/661	SWITCH ROOM	E1	661	G4
5/662	SWITCH ROOM	E2	661	F4
5/711	IMR		706	F3
*5/261	PLATFORM 1		261	H7
*5/262	PLATFORM 2		261	I6

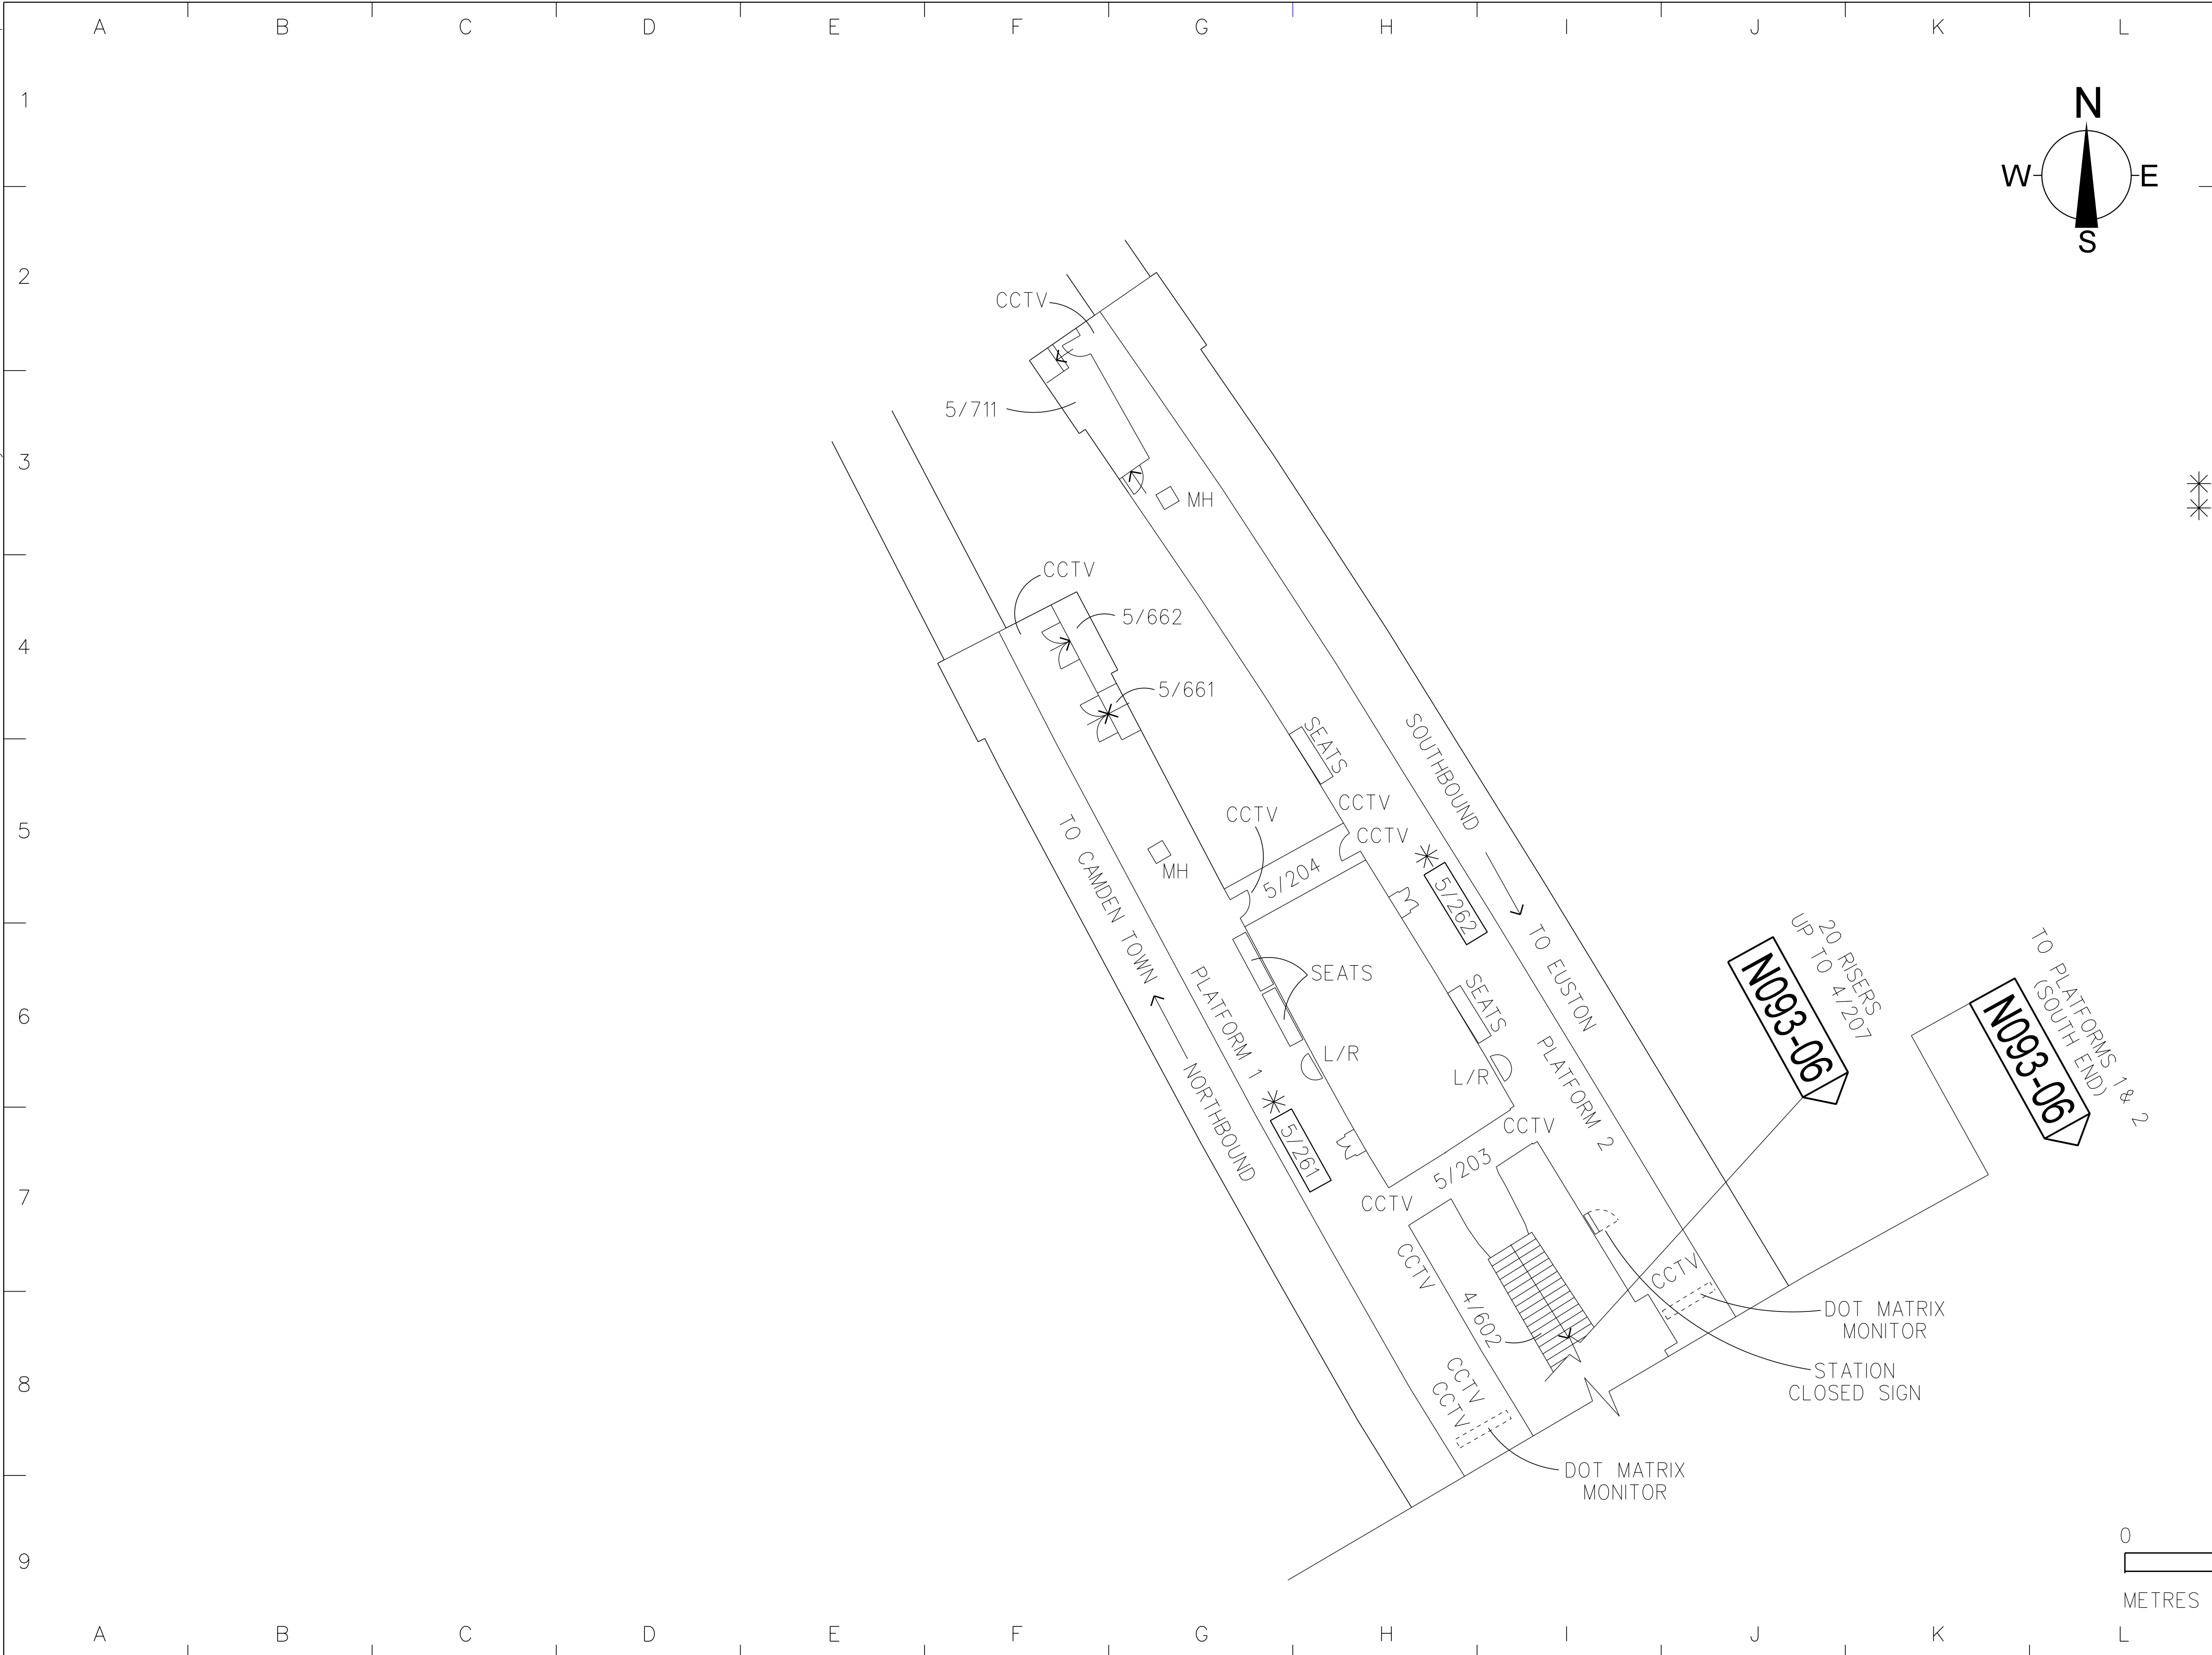


Mornington Crescent

First Floor Plan

STATION LAYOUT

Not for construction purposes

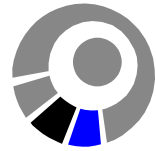

Tube Lines

15 Westferry Circus
Canary Wharf
London E14 4HD

Total of 08 Drawings
N093-01 to 08

Drawing number:
N093-08s

Issue: 17 (2008/09)

Revision:

Survey Date: 04:12:08

Date:


Drawn by:

AL

Drawn by:

Information current at date shown. For
latest information contact Building Control
020 7088 4357/4356/4361

If any alterations or additions are needed to these layouts please contact Building Control, Tube Lines Limited.

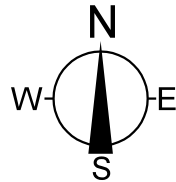

N093-04
24+2 RISERS DOWN
TO TICKET HALL

EGRESS ONLY

3 RISERS

EGRESS ONLY

N093-04
ACCESS HATCH
TO TICKET HALL

ISOLATORS

A/C UNITS

A/781

4xA/C UNITS

BARRIER

3 RISERS

LADDER (15 RUNGS)
UP TO ROOF

LADDER (14 RUNGS)
UP TO ROOF


OUTLINE OF BOUNDRY
WALL BELOW

N093-04

7+16 RISERS DOWN
TO TICKET HALL

ACCESS IN MACHINE CHAMBERS & SHAFTS
IS ALWAYS RESTRICTED & HAZARDOUS

Id No.	Description	Notes	Code	Grid Ref
A/082	LOBBY	ACES LAND'G	081	D2
A/131	LMR		131	D4
A/351	MESS ROOM	DISUSED	331	F2
A/416	TOILET	DISUSED	416	F3
A/576	STAIRS		576	G9
A/577	STAIRS		576	D3
A/781	TRANSFORMER		781	E7
A/801	OFFICE	DISUSED	801	E2
A/803	OFFICE		801	F4
4/791	VENT TUNNEL	DUCT	791	E3

 

MSn (station)

Plotted by : bald3467 TLL

10/02/2009

© Tube Lines Limited. Produced by Building Control, Tube Lines Limited. Enquiries should be directed to 020 7088 4357/4356/4361