

DRG. LOCATION -

© COPYRIGHT OF THIS DRAWING RESIDES WITH FAN RESCUE LTD

NOTES

1. DO NOT SCALE FROM THIS DRAWING, USE FIGURED DIMENSIONS ONLY, AND CHECK ALL DIMENSIONS ON SITE.

Rev	Date	CAD	Chkd	Description

Project
51 FAIRFAX ROAD

Drawing
KITCHEN VENTILATION SYSTEM




FAN RESCUE LTD


BATH HOUSE, PETERSFIELD ROAD
WHITEHILL, HAMPSHIRE
GU35 9BU
TEL: 01420 477 570
Email: enquiries@fanrescue.co.uk

Scale 1:50	Size A1	Engineer IN	Date 23.03.2017
---------------	------------	----------------	--------------------

Drawing No. FR-FAIRFAX-M001	Rev P1
---------------------------------------	------------------

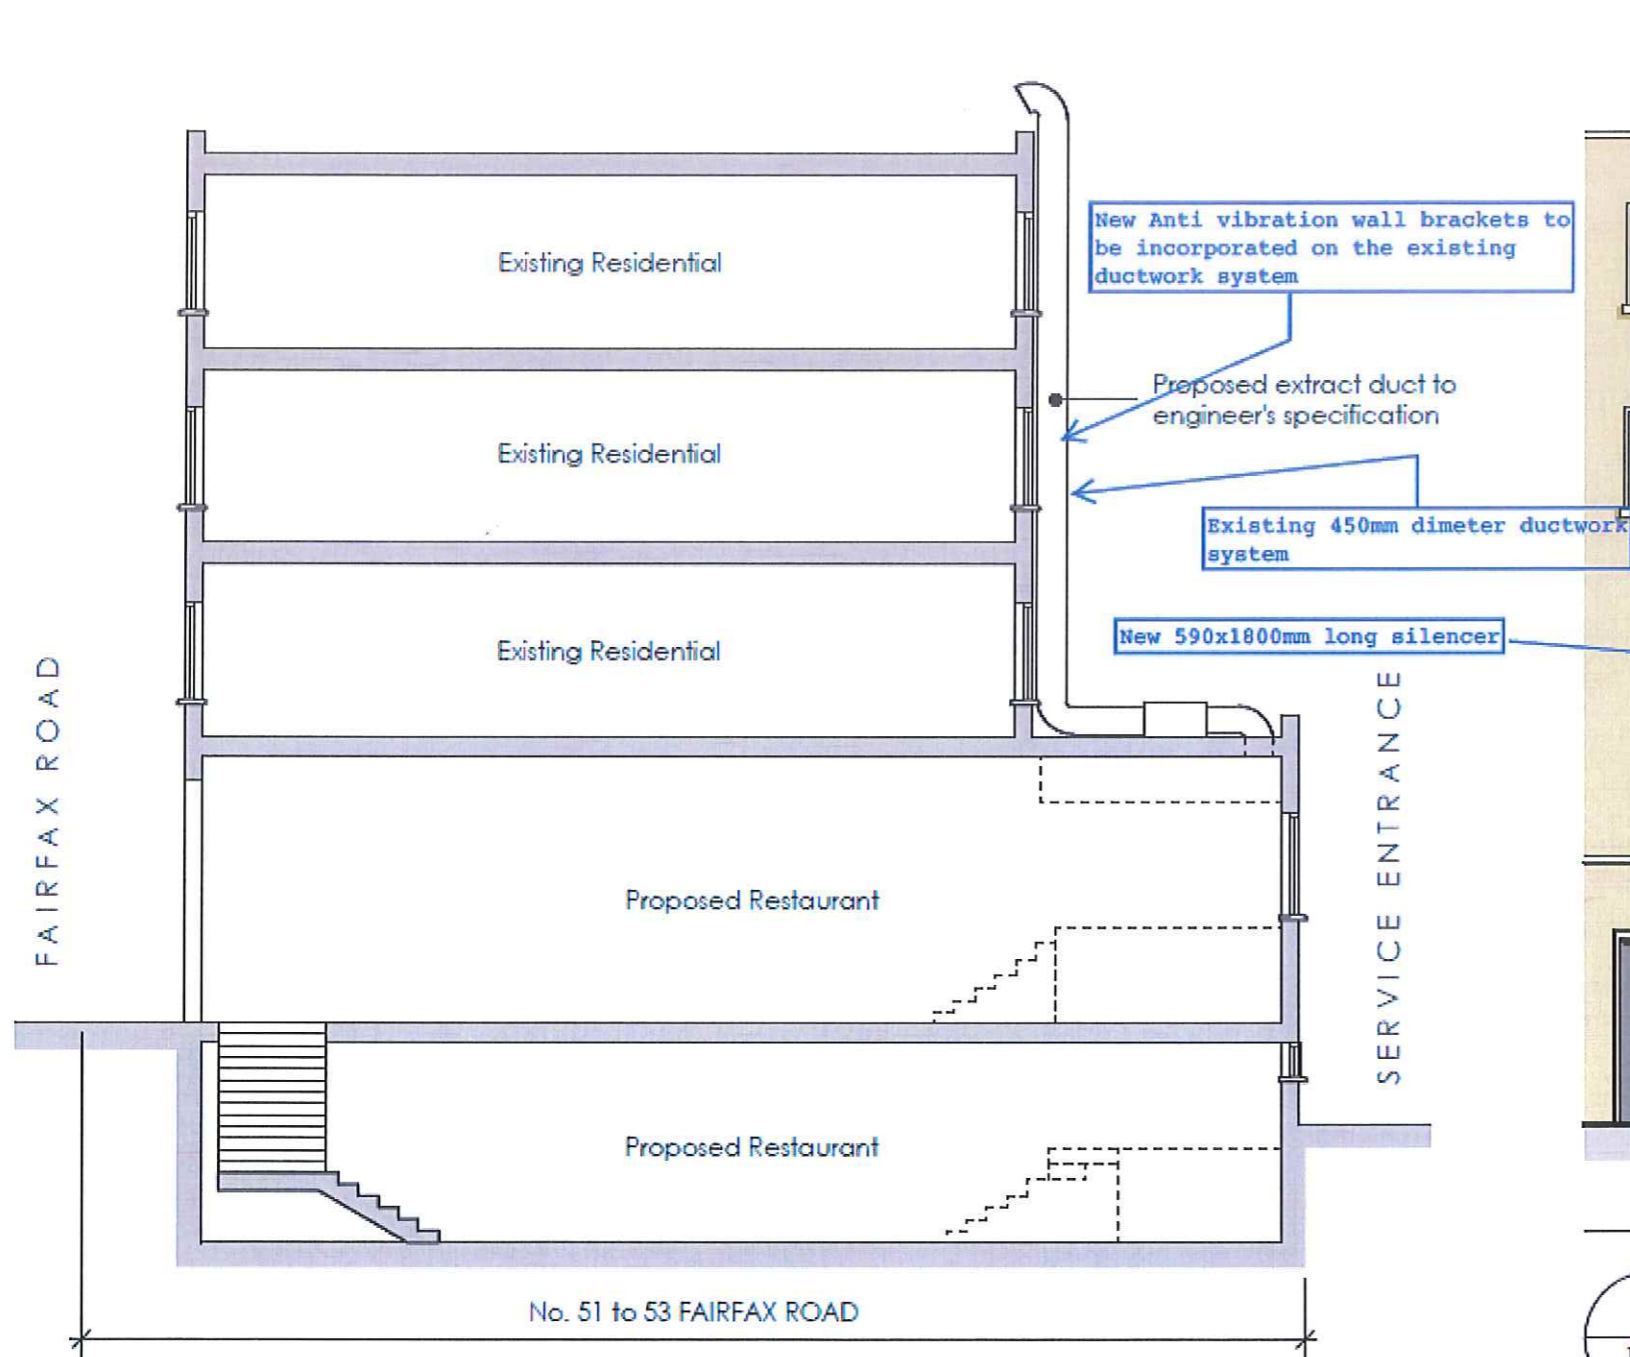

1
121
Proposed Section
scale 1:100 @ A3

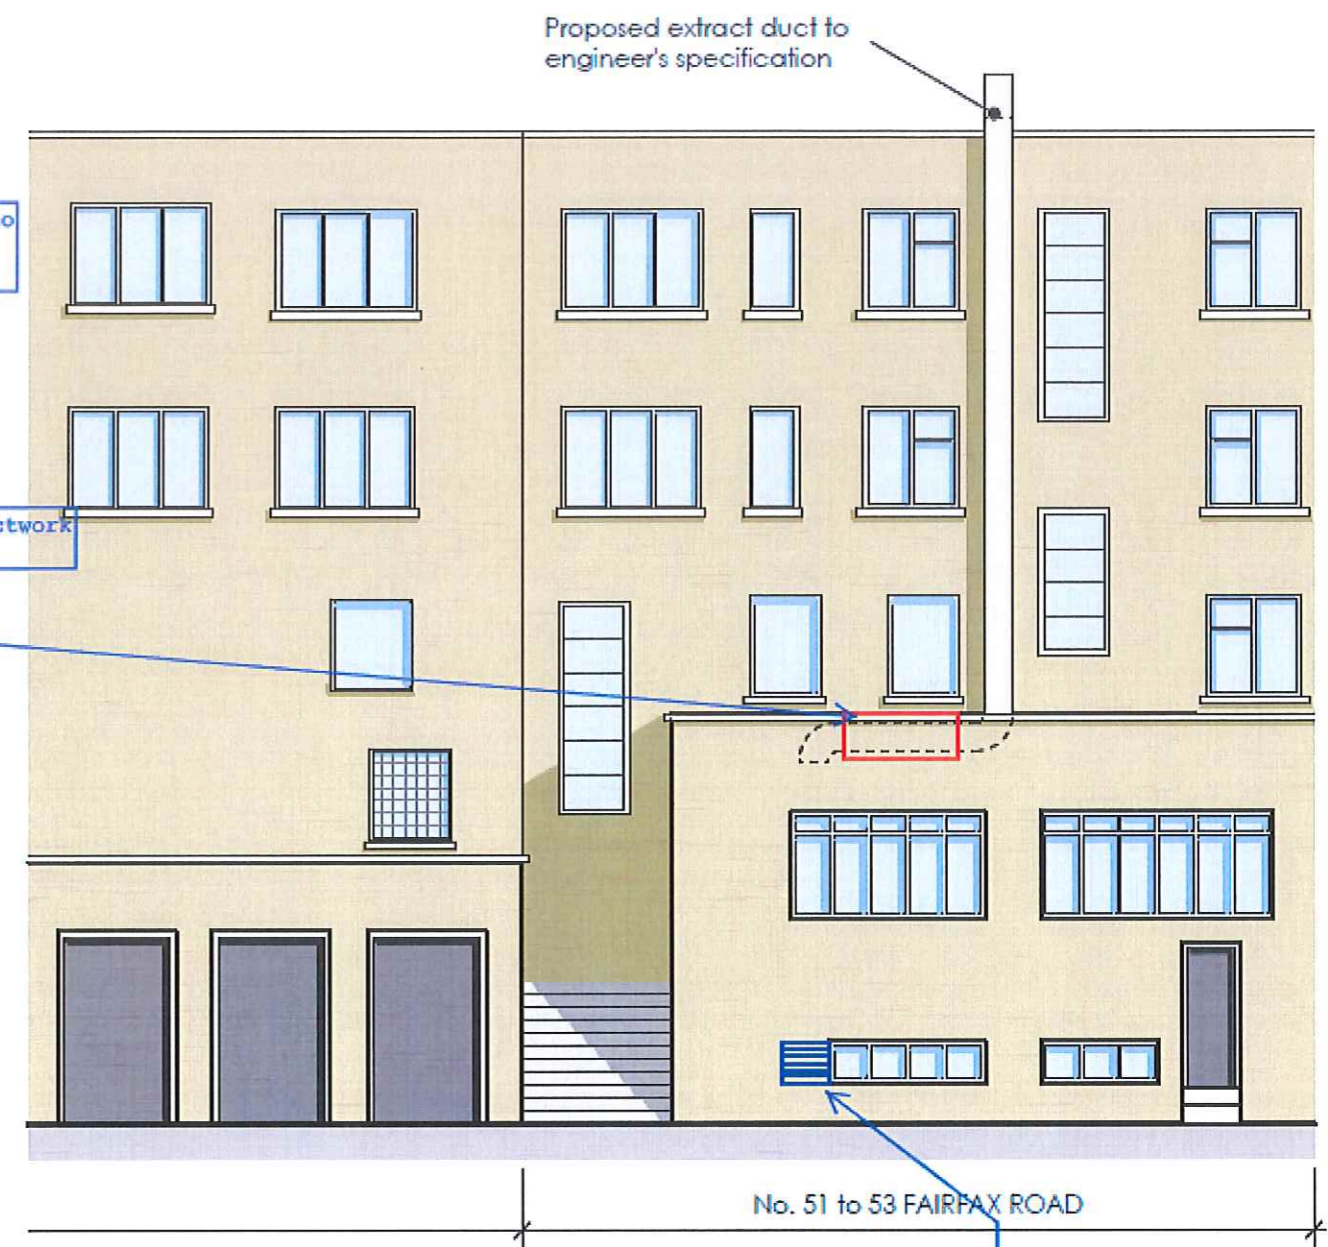

2
121
Proposed Rear Elevation
scale 1:100 @ A3

300x500mm weather louver grill to provide fresh air into the kitchen area, 1200mm long silencer will be fitted at the back of the grill to eliminate any noise out break from the kitchen area.

DRG. LOCATION -

© COPYRIGHT OF THIS DRAWING RESIDES WITH FAN RESCUE LTD

NOTES

1 DO NOT SCALE FROM THIS DRAWING. USE FIGURED DIMENSIONS ONLY, AND CHECK ALL DIMENSIONS ON SITE

Rev	Date	CAD/Chkd	Description

Project

51 FAIRFAX ROAD

Drawing

**KITCHEN VENTILATION
SYSTEM**



FAN RESCUE LTD

BATH HOUSE, PETERSFIELD ROAD
WHITEHILL, HAMPSHIRE
GU35 9BU
TEL: 01420 477 570
Email: enquiries@fanrescue.co.uk

Scale	Size	Engineer	Date
1:50	A1	IN	23.03.2017

Drawing No.	Rev
FR-FAIRFAX-M001	P1