

Foul Water Drainage
New runs for WC to discharge into existing manhole.

Existing SVP

Option 3

 



AGA Projects Ltd, 77 St John's Road, Westcliff-on-Sea, Essex SS0 7JY t: 020 8123 8753 www.agaprojects.co.uk


4 Gate Street, London WC2A

PROPOSED BASEMENT PLAN - OPTION 3

Drawing Nr: 170223/3/1 Scale: 1:50@A3 Date: 10 March 2017

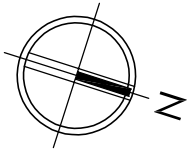

Gate Street

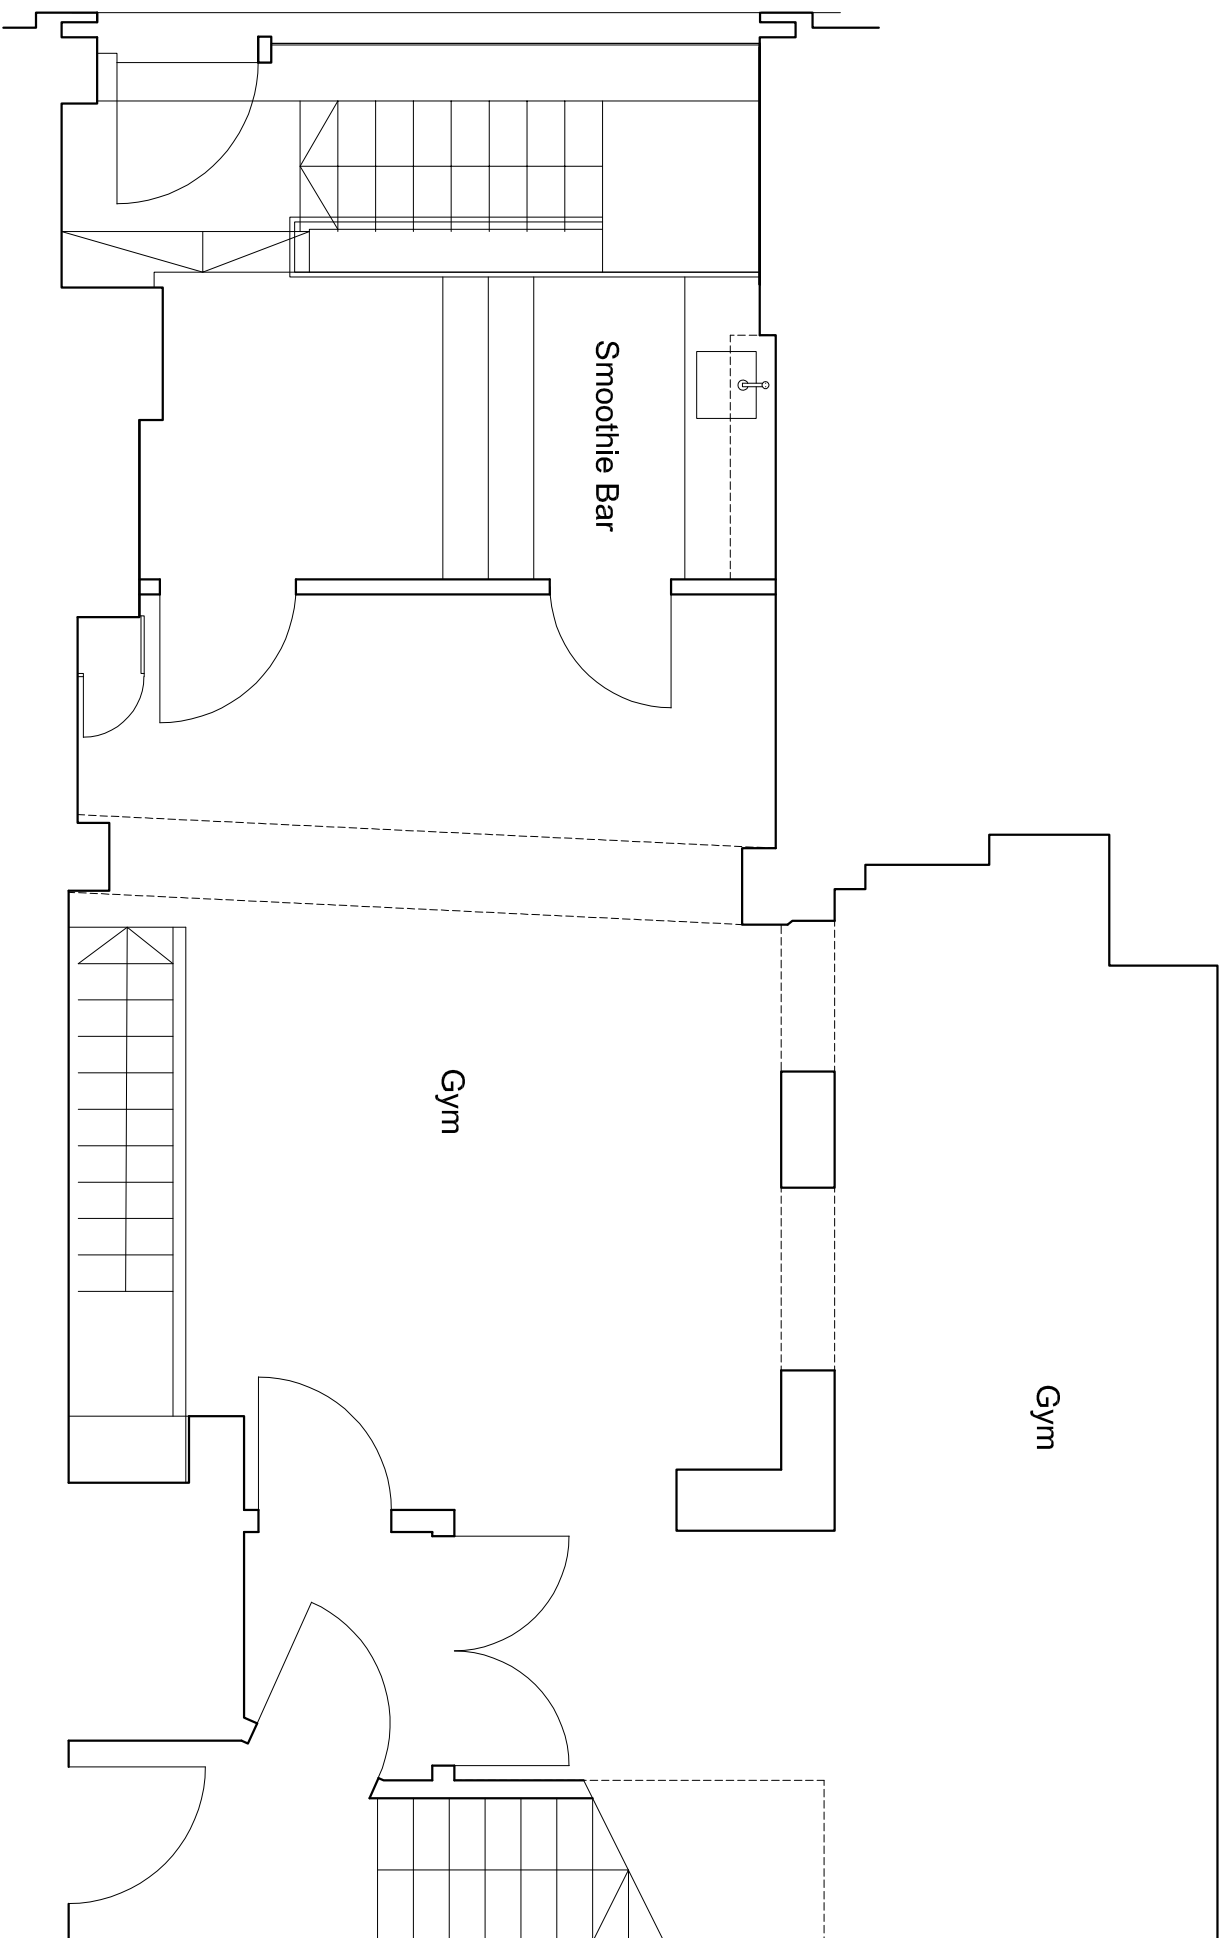



AGA Projects Ltd, 77 St John's Road, Westcliff-on-Sea, Essex SS0 7JY t: 020 8123 8753 www.agaprojects.co.uk

4 Gate Street, London WC2A

Option 3

PROPOSED GROUND FLOOR PLAN - OPTION 3

 Drawing Nr: 170223/3/2 Scale: 1:50@A3 Date: 10 March 2017

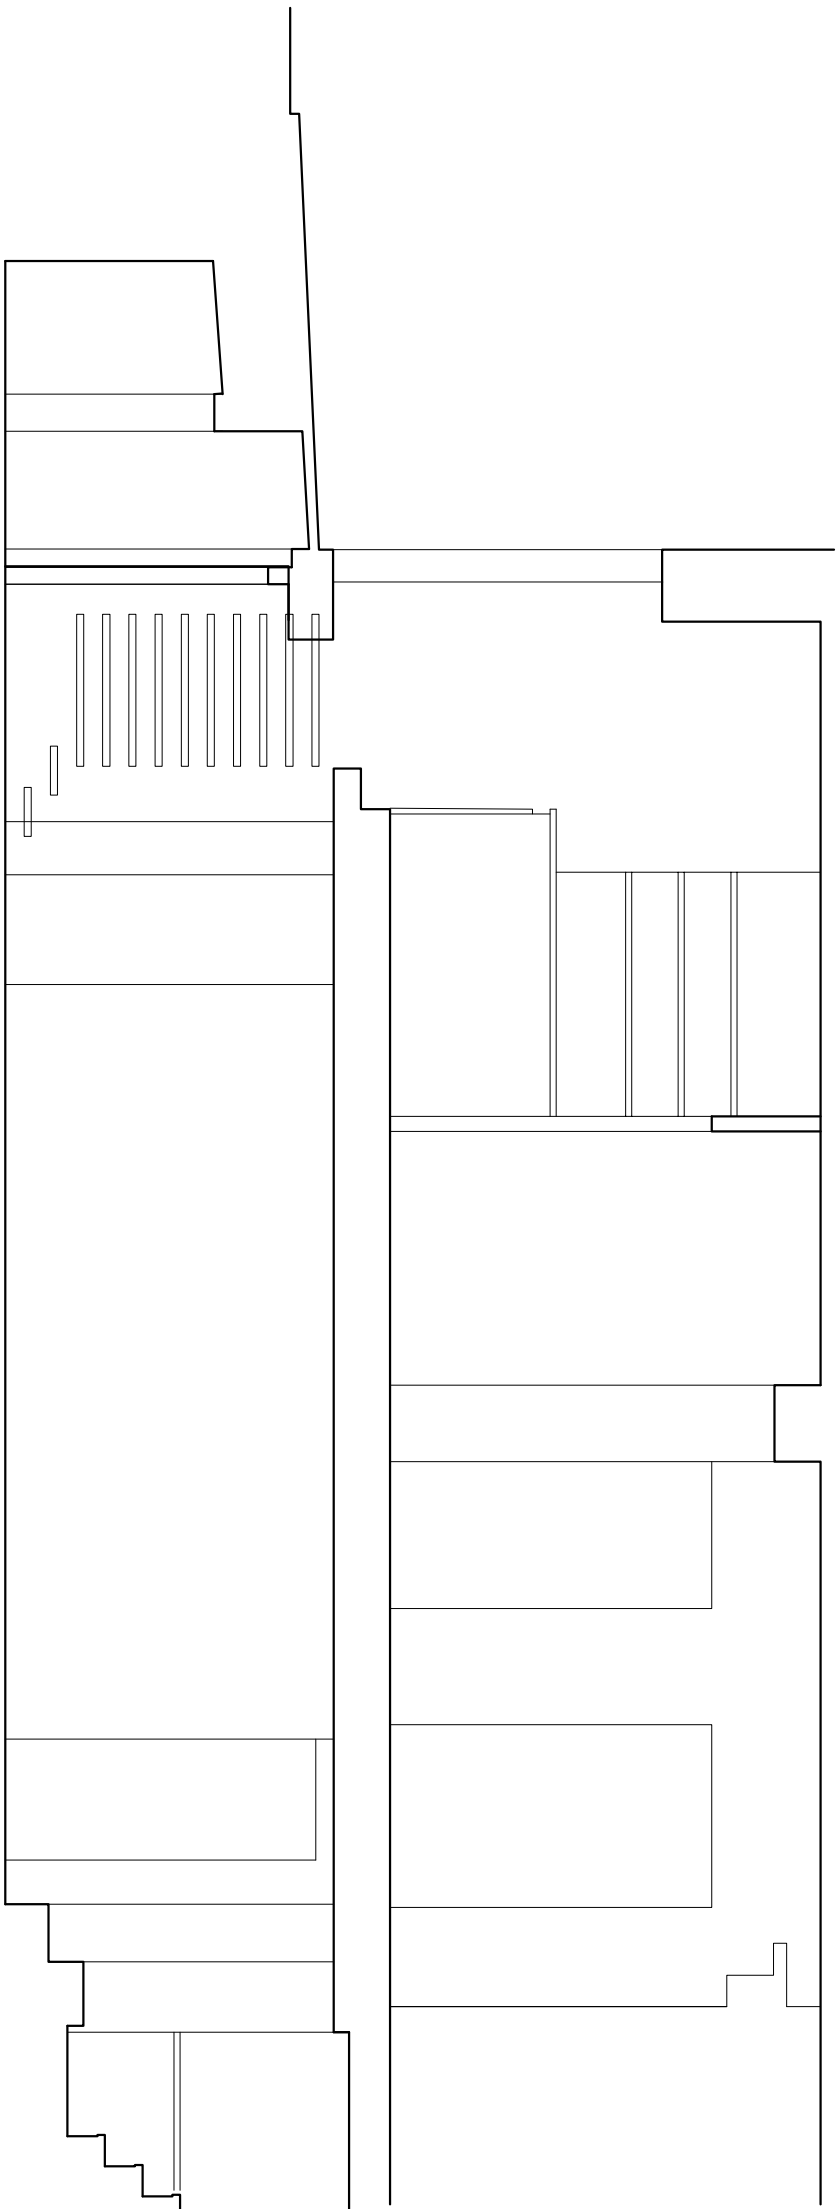

Option 3



AGA Projects Ltd, 77 St John's Road, Westcliff-on-Sea, Essex SS0 7JY t: 020 8123 8753 www.agaprojects.co.uk

4 Gate Street, London WC2A

PROPOSED SECTION - OPTION 3

Drawing Nr: 170223/3/3 Scale: 1:50@A3 Date: 10 March 2017