



- GENERAL NOTES
1. ALL DIMENSIONS ARE IN MILLIMETRES UNLESS INDICATED.
 2. DO NOT SCALE FROM THIS DRAWING.
 3. THIS DRAWING SHALL BE READ IN CONJUNCTION WITH THE PROJECT SPECIFICATION & ALL OTHER PROJECT DOCUMENTATION.

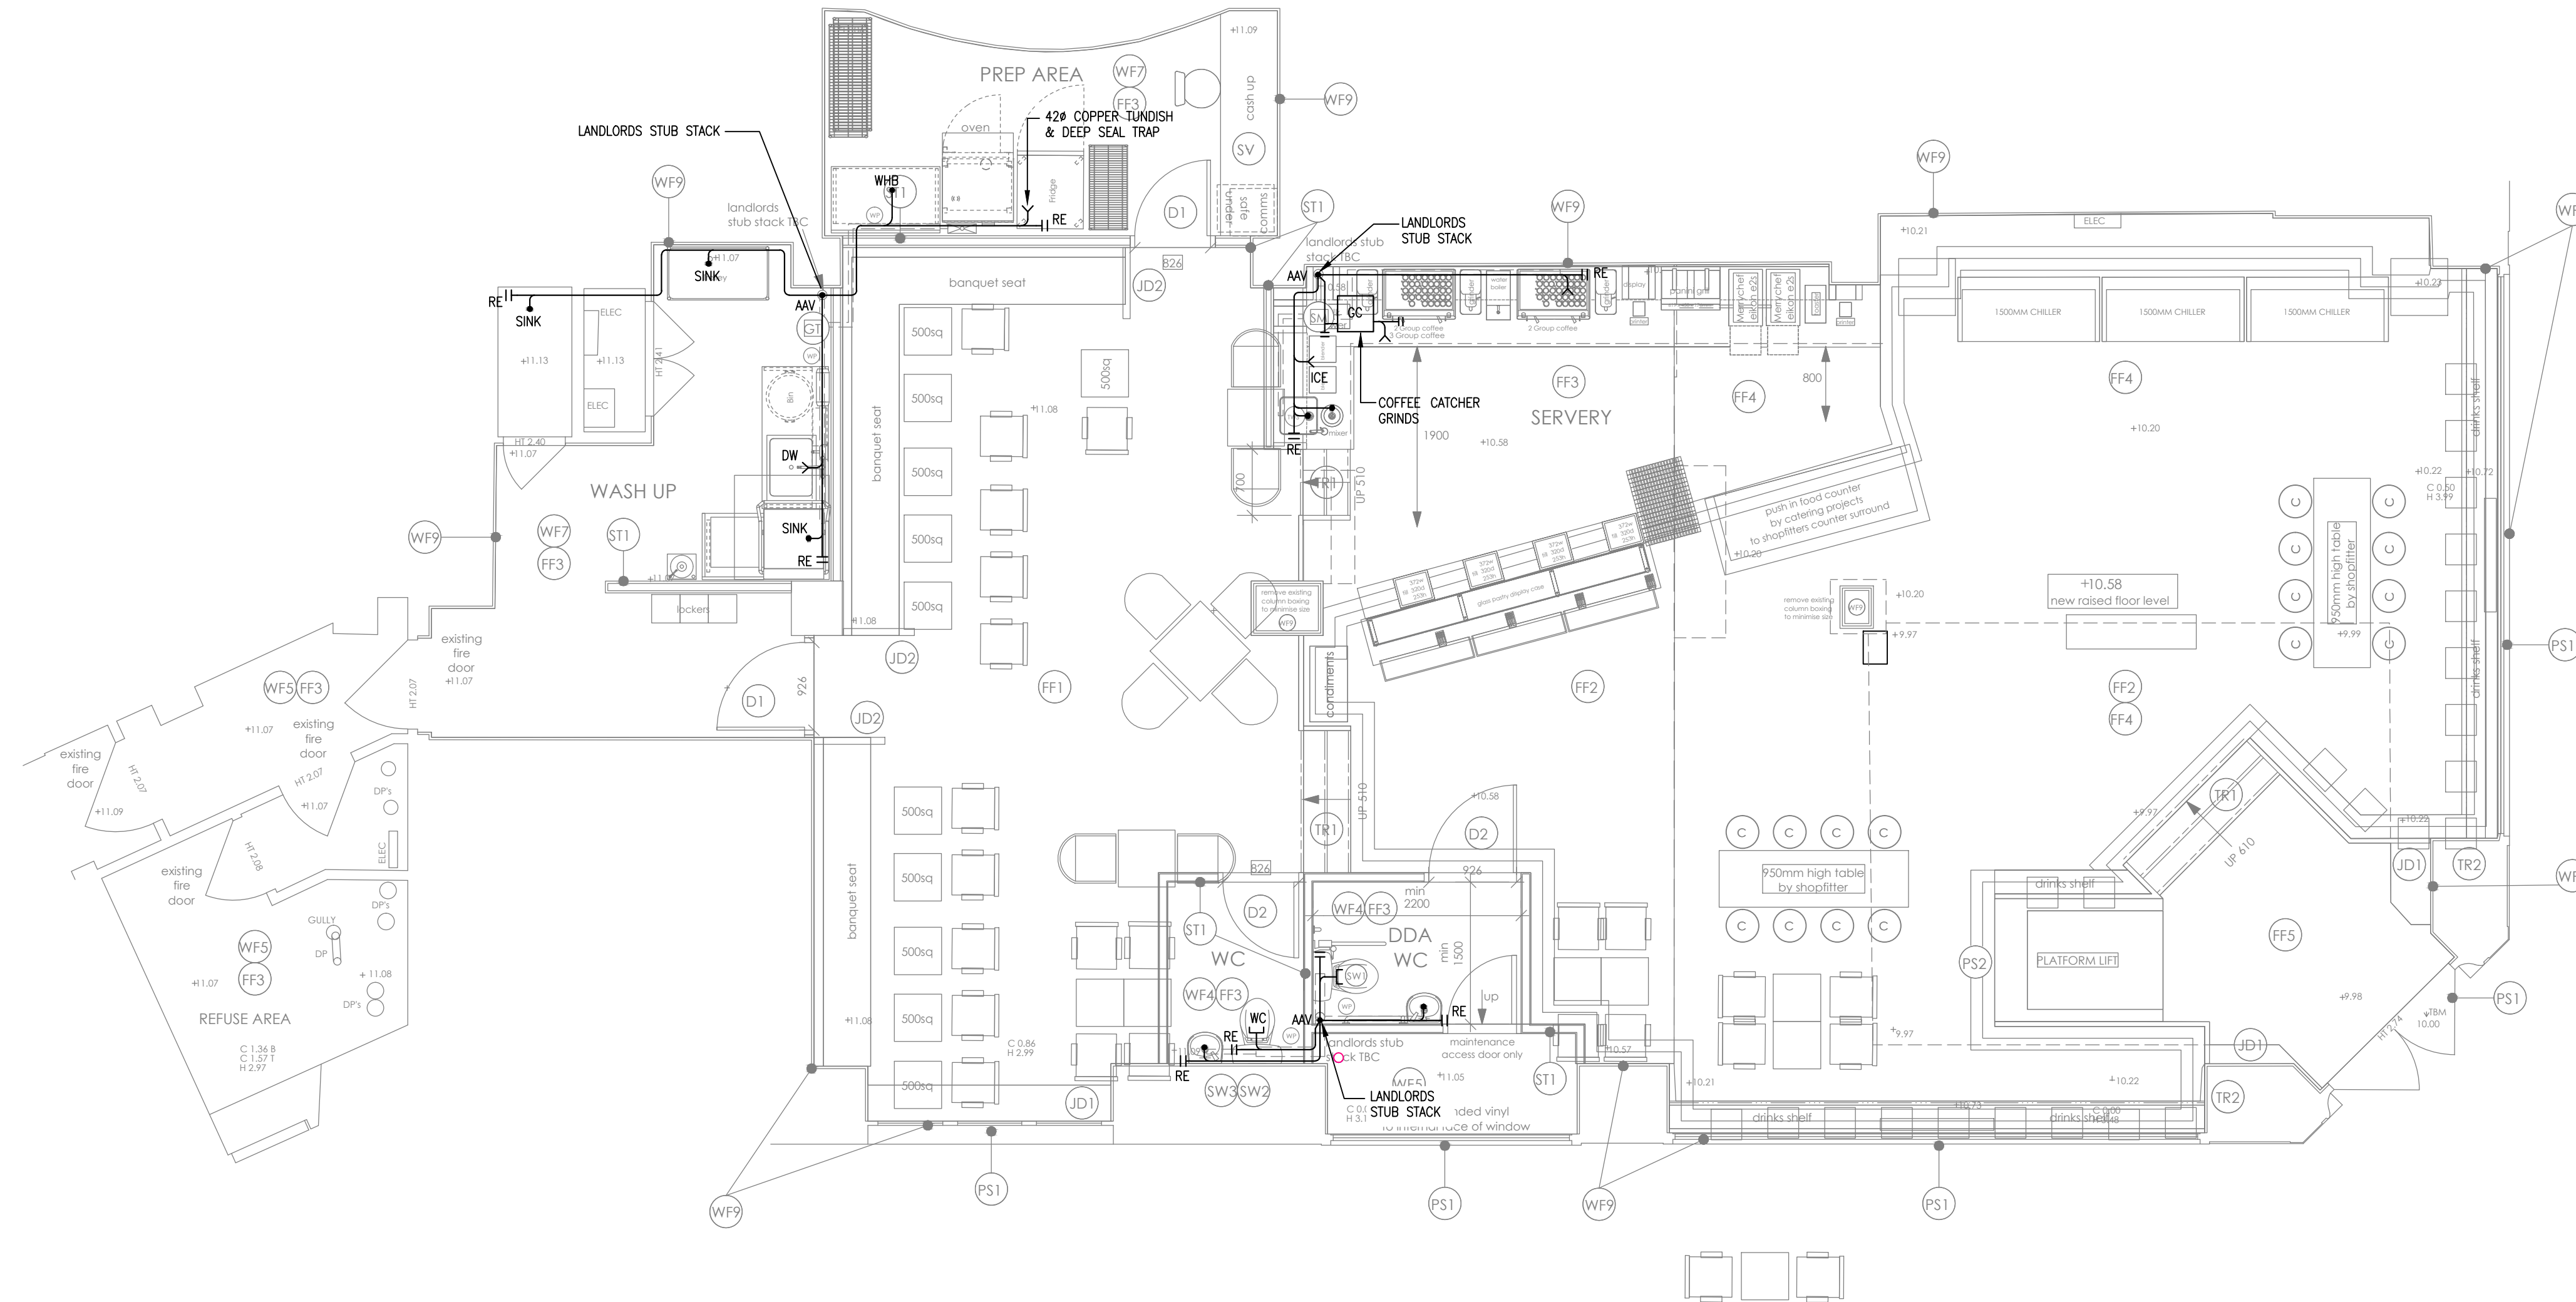

LEGEND

1. THE FOLLOWING TRAP SIZES & SEAL DEPTHS SHALL BE PROVIDED.
- | TRAP/UNDISH | SEAL |
|-------------|------------|
| WHB | 32mm 75mm |
| SINK | 40mm 75mm |
| DW | 40mm 75mm |
| WC PAN | 110mm 50mm |
| ICE BUCKET | 40mm 75mm |
- AAV AIR ADMITTANCE VALVE
2. FIRE STOPPING SHALL BE PROVIDED WHERE PIPES PENETRATE FIRE COMPARTMENTS.
 3. THE ENTIRE INSTALLATION SHALL FULLY COMPLY WITH THE REQUIREMENTS OF BUILDING REGULATIONS APPROVED DOCUMENT H.
 4. THIS DRAWING SHALL BE READ IN CONJUNCTION WITH CATERING PROJECTS CURRENT INFORMATION.
 5. ALL RANGE PIPES SERVING A NUMBER OF WHB'S OR SINKS SHALL BE 50mm.
 6. RODDING EYES SHALL BE PROVIDED AT EACH CHANGE IN DIRECTION & CONNECTION TO THE BELOW GROUND DRAINAGE SYSTEM.
 7. ALL HORIZONTAL WASTE PIPES CONNECTING MORE THAN ONE APPLIANCE SHALL BE 50mm.
 8. AAV'S SHALL BE INSTALLED AS REQUIRED TO ADEQUATELY VENT THE SYSTEM.
- WP WASTE PUMP TO BE BY GRUNDFOS OR EQUAL & APPROVED.
 GT GREASE TRAP PRO TRAP 40 BY EDIN CARE.
 GC COFFEE GRINDS CATCHER SEPARATOR PRO BY EDINCARE (BY SHOPFITTER).
 FC FIRE COLLAR

P1	PRELIMINARY ISSUE	PLR	PH	03.04.17		
REV	DESCRIPTION	DWN	CHK'D	DATE		
PRELIMINARY ISSUE						
THIS DRAWING IS CONFIDENTIAL AND MUST NOT BE DISCLOSED TO THIRD PARTIES, REPRODUCED OR USED, OR THE CONTENT THEREON COPIED OR REPRODUCED WITHOUT THE WRITTEN CONSENT OF VIRIDIAN CONSULTING ENGINEERS LTD.						
DWN	DATE	CHK'D	DATE	APP'D	DATE	SCALE
						1:50
CLIENT						
SOHO COFFEE CO						
PROJECT						
SOHO COFFEE CO 65 KINGS WAY LONDON						
TITLE						
PROPOSED ABOVE GROUND DRAINAGE LAYOUT						
						
Lloyds House 18 Lloyd Street Manchester M2 5WA Tel: 0161 478 6256 Email: general@viridian-consulting.co.uk						
DRAWING No. V1694(52)001						REV P1