

 



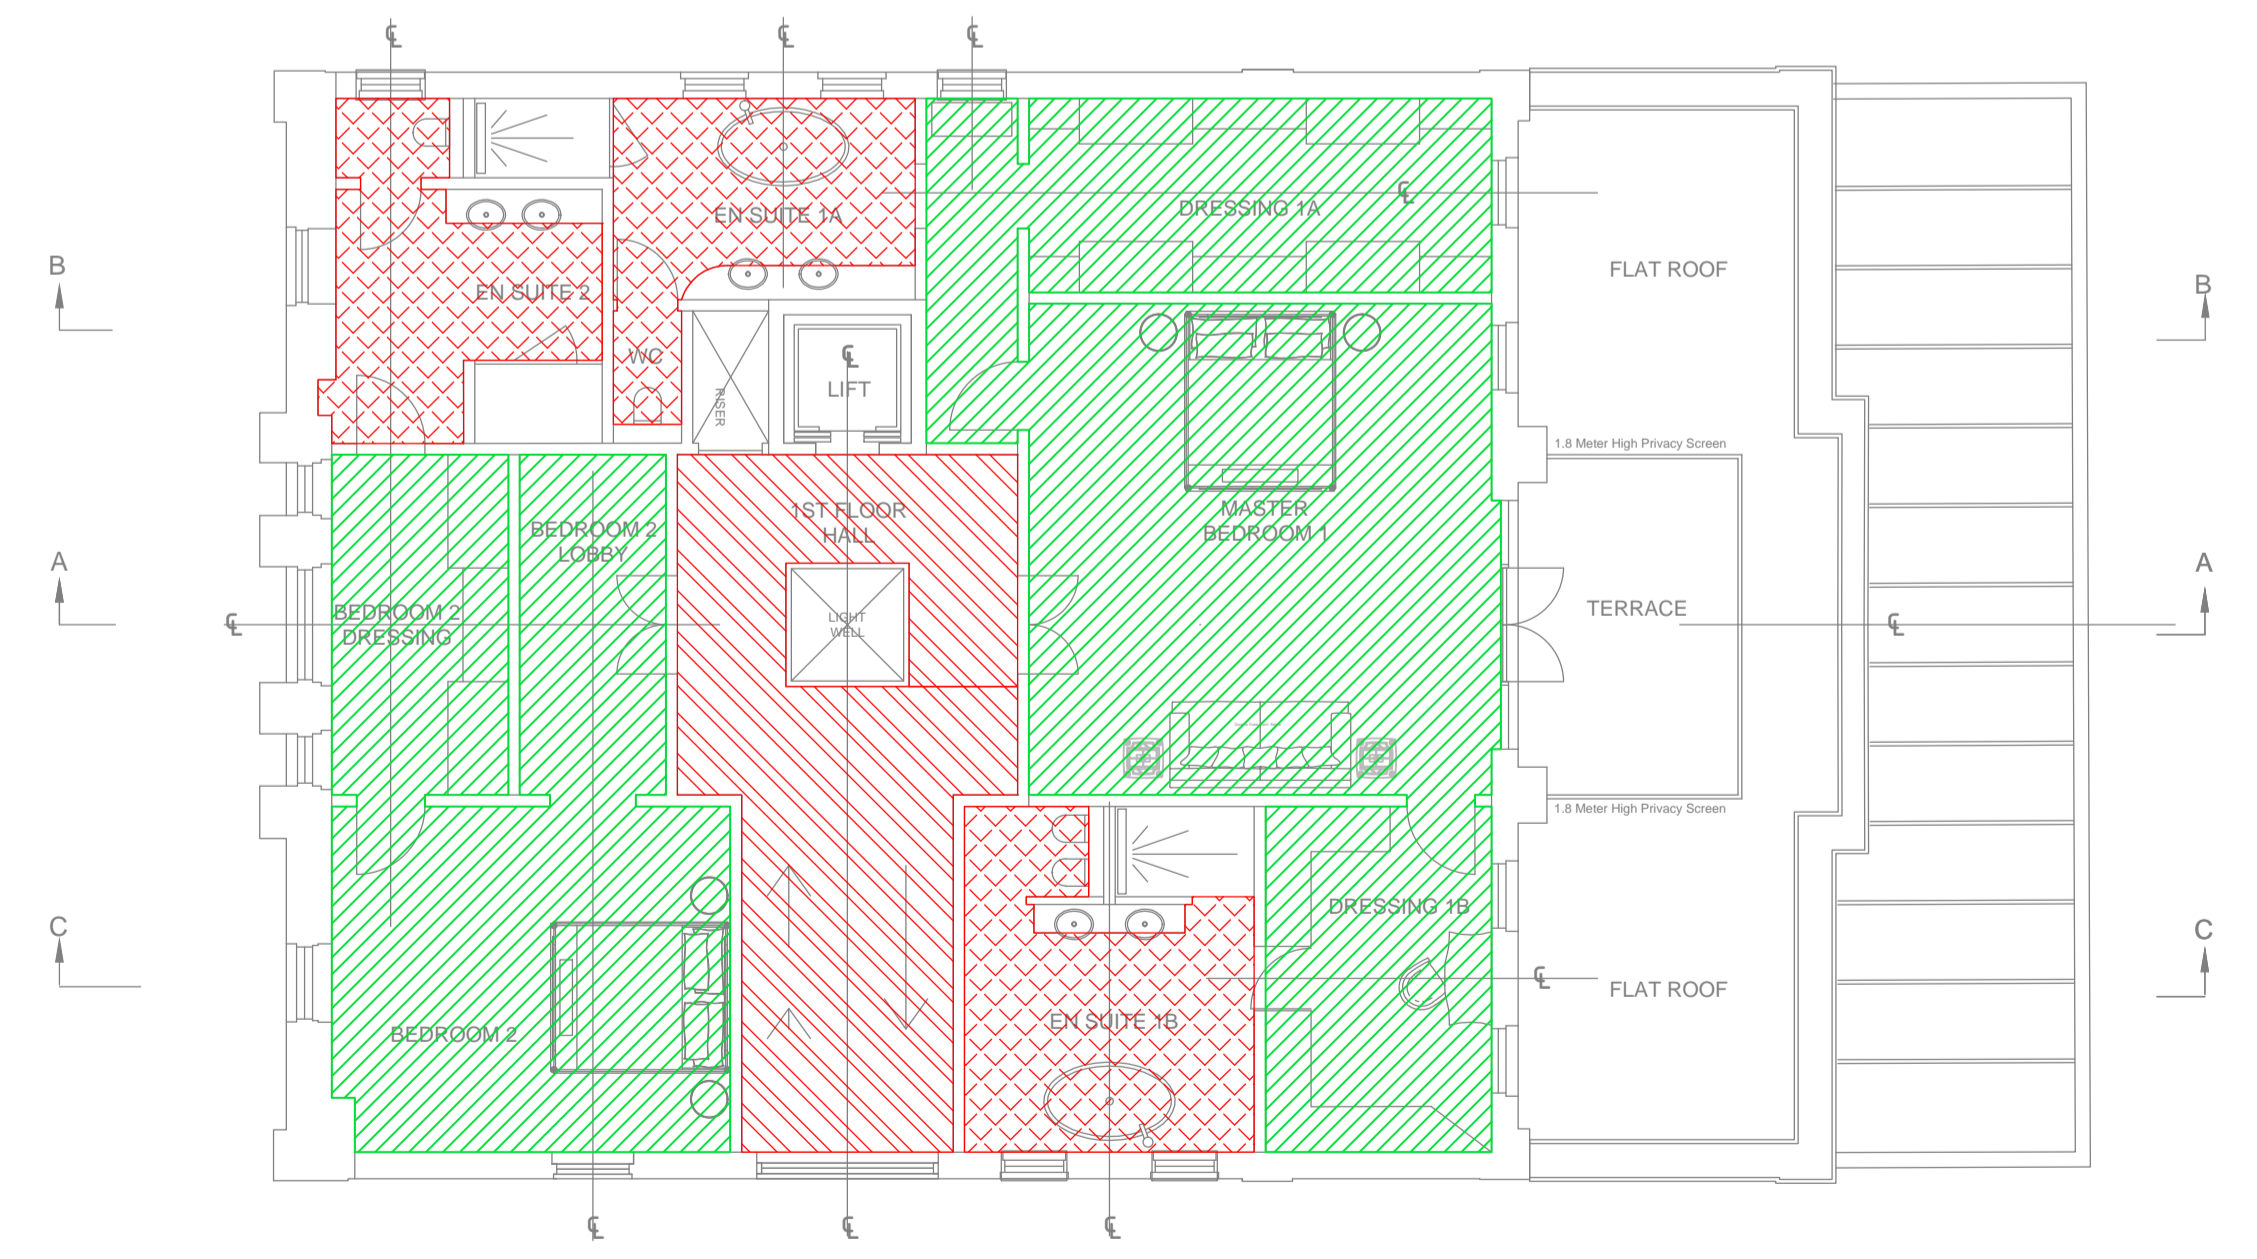


- Notes:
1. This drawing shall not be used for construction purposes
 2. Do not scale from this drawing either paper or digital form

- Systems Key:
-  Unheated space
 -  Comfort Conditioning with underfloor heating
 -  Underfloor heating only
 -  Electric underfloor heating
 -  Air Conditioning (cooling only)
 -  Specialist dedicated plant



SECOND FLOOR PLAN




FIRST FLOOR PLAN

Revision	Date	Details

Status
FOR PLANNING

P3r Engineers Ltd
 Consulting Building Services Engineers
 70 Cowcross Street
 London EC1M 6EJ
 Telephone 020 7490 7848
 www.p3r-engineers.co.uk



Project
45 Avenue Road, NW8

Drawing Title
1st & 2nd Floor - Servicing Zone Plans

Scale: 1:100@A1	Drawn by: KE	Checked by: MP
Date: Mar 2017	Drawing No. 1708-SK-102	Revision: P01