



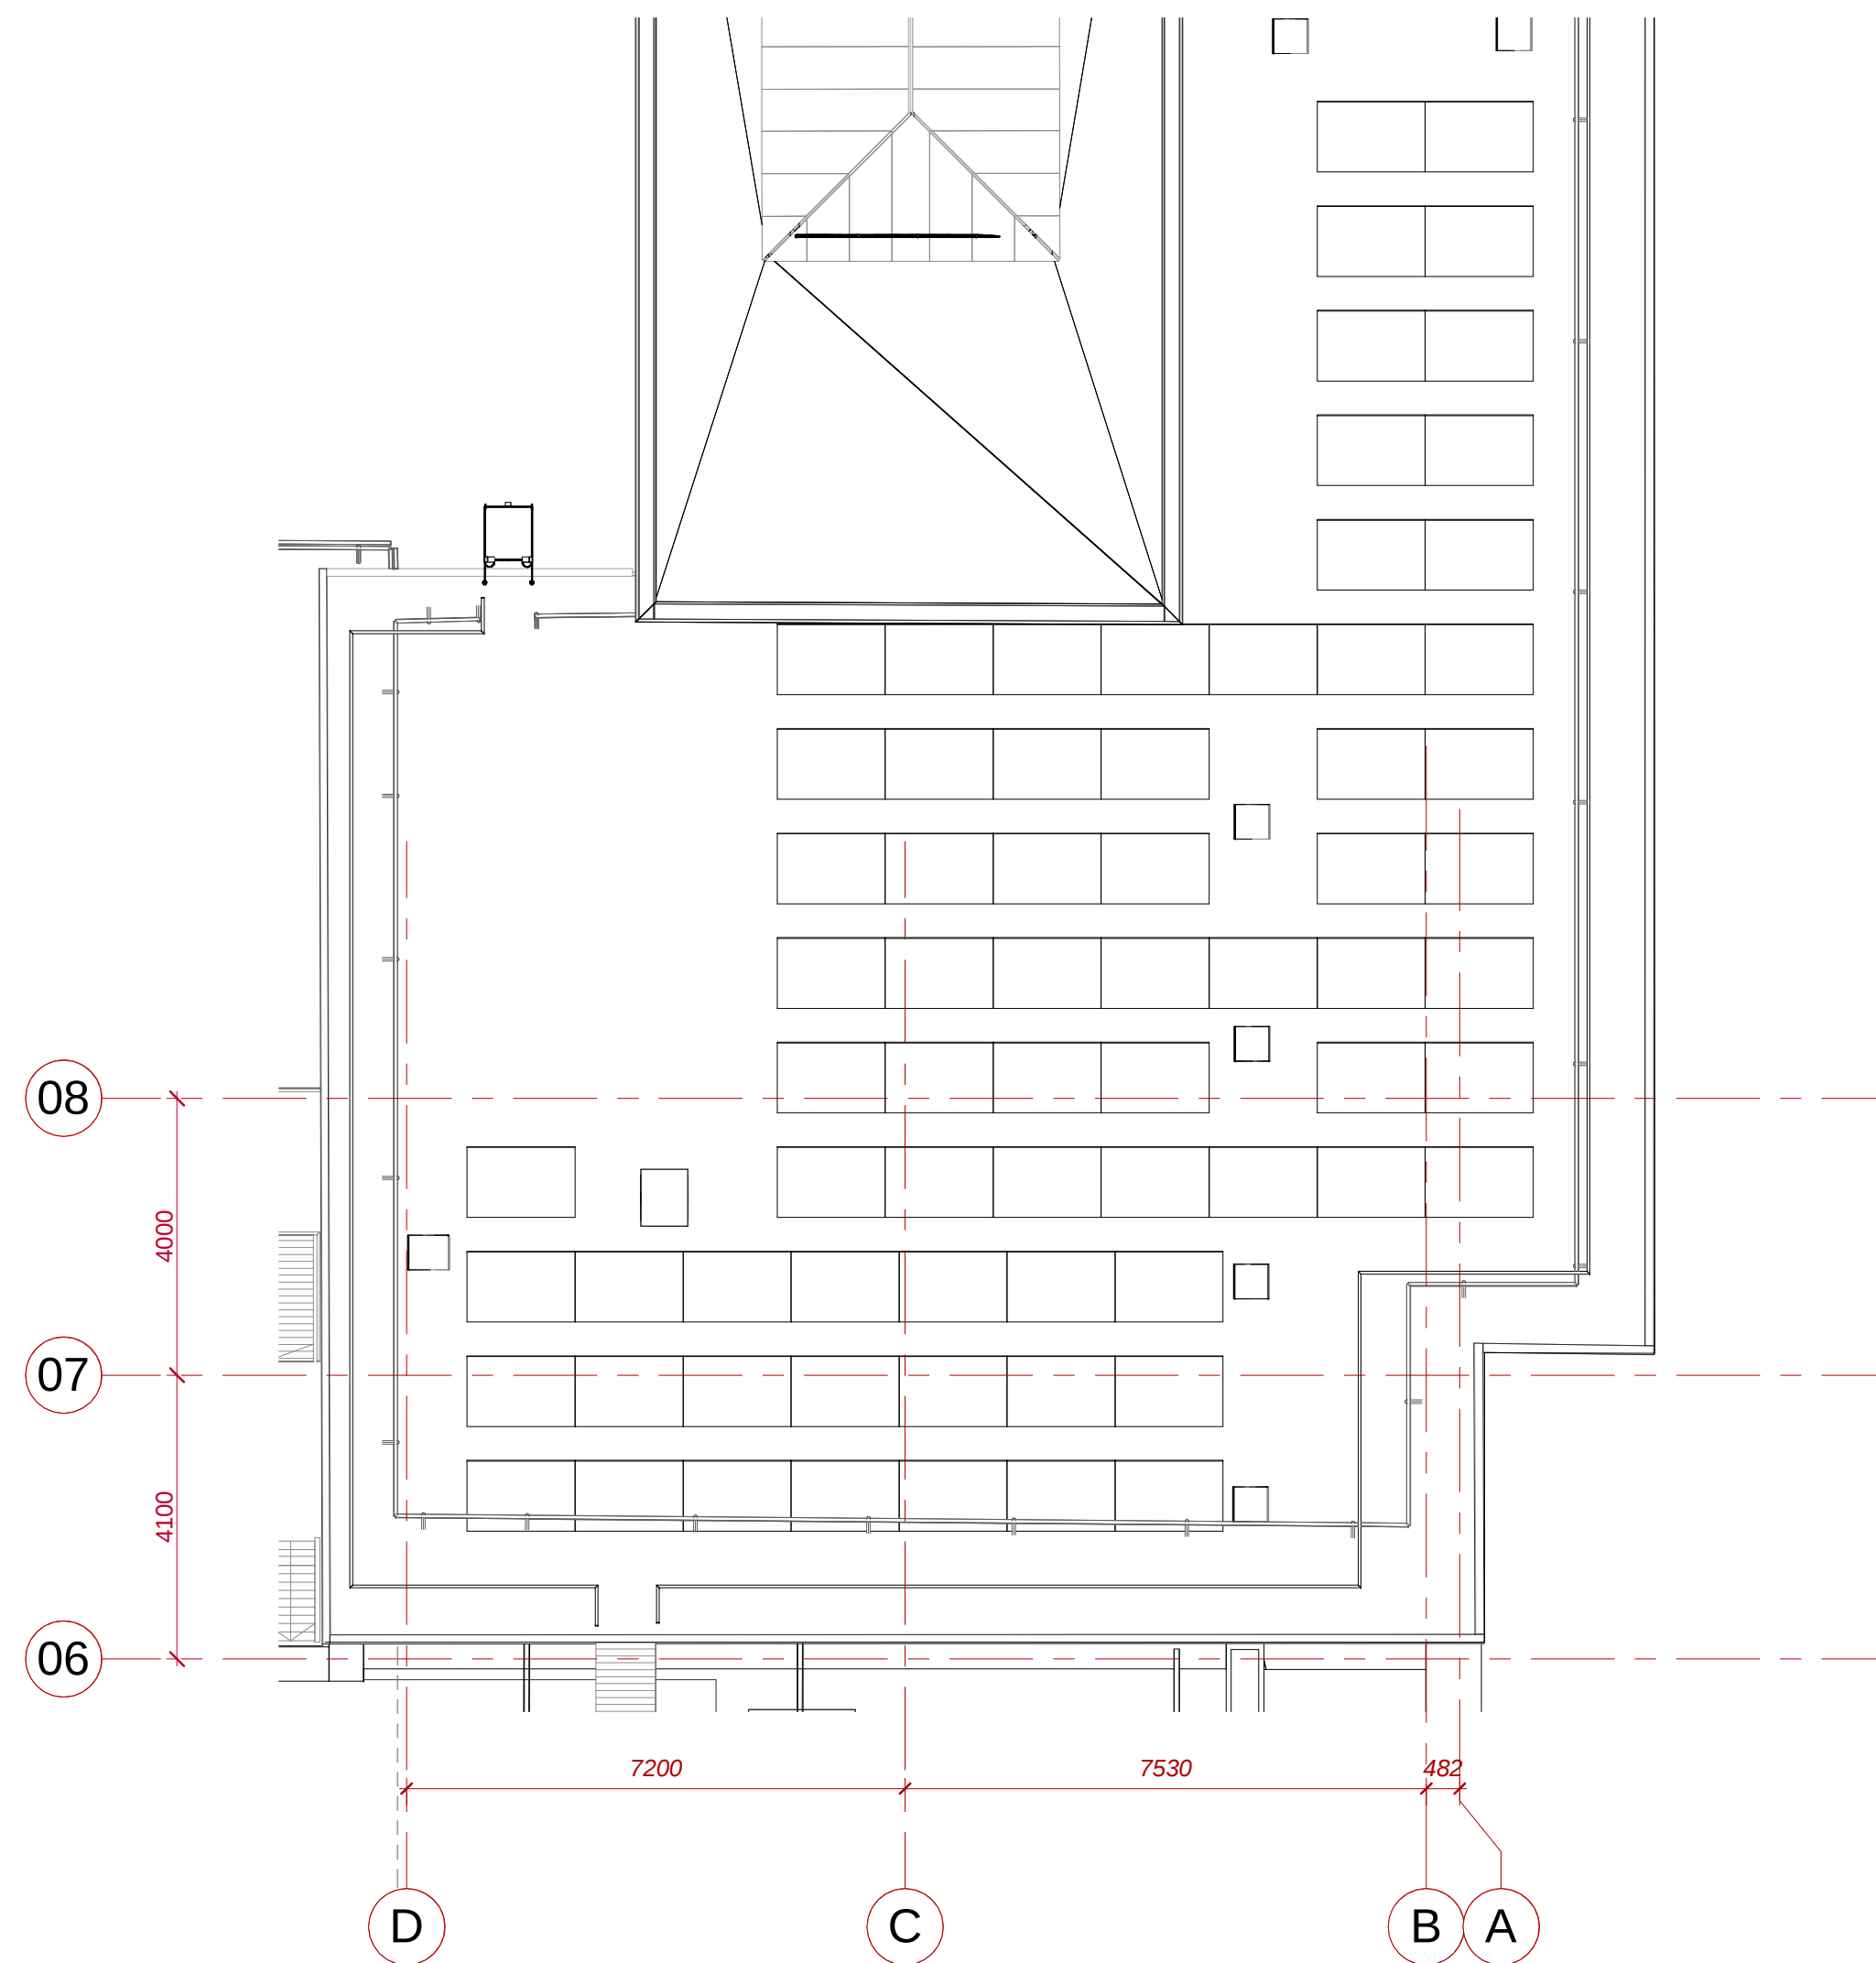

Photovoltaic Panel Layout on Bloomsbury Theater Roof

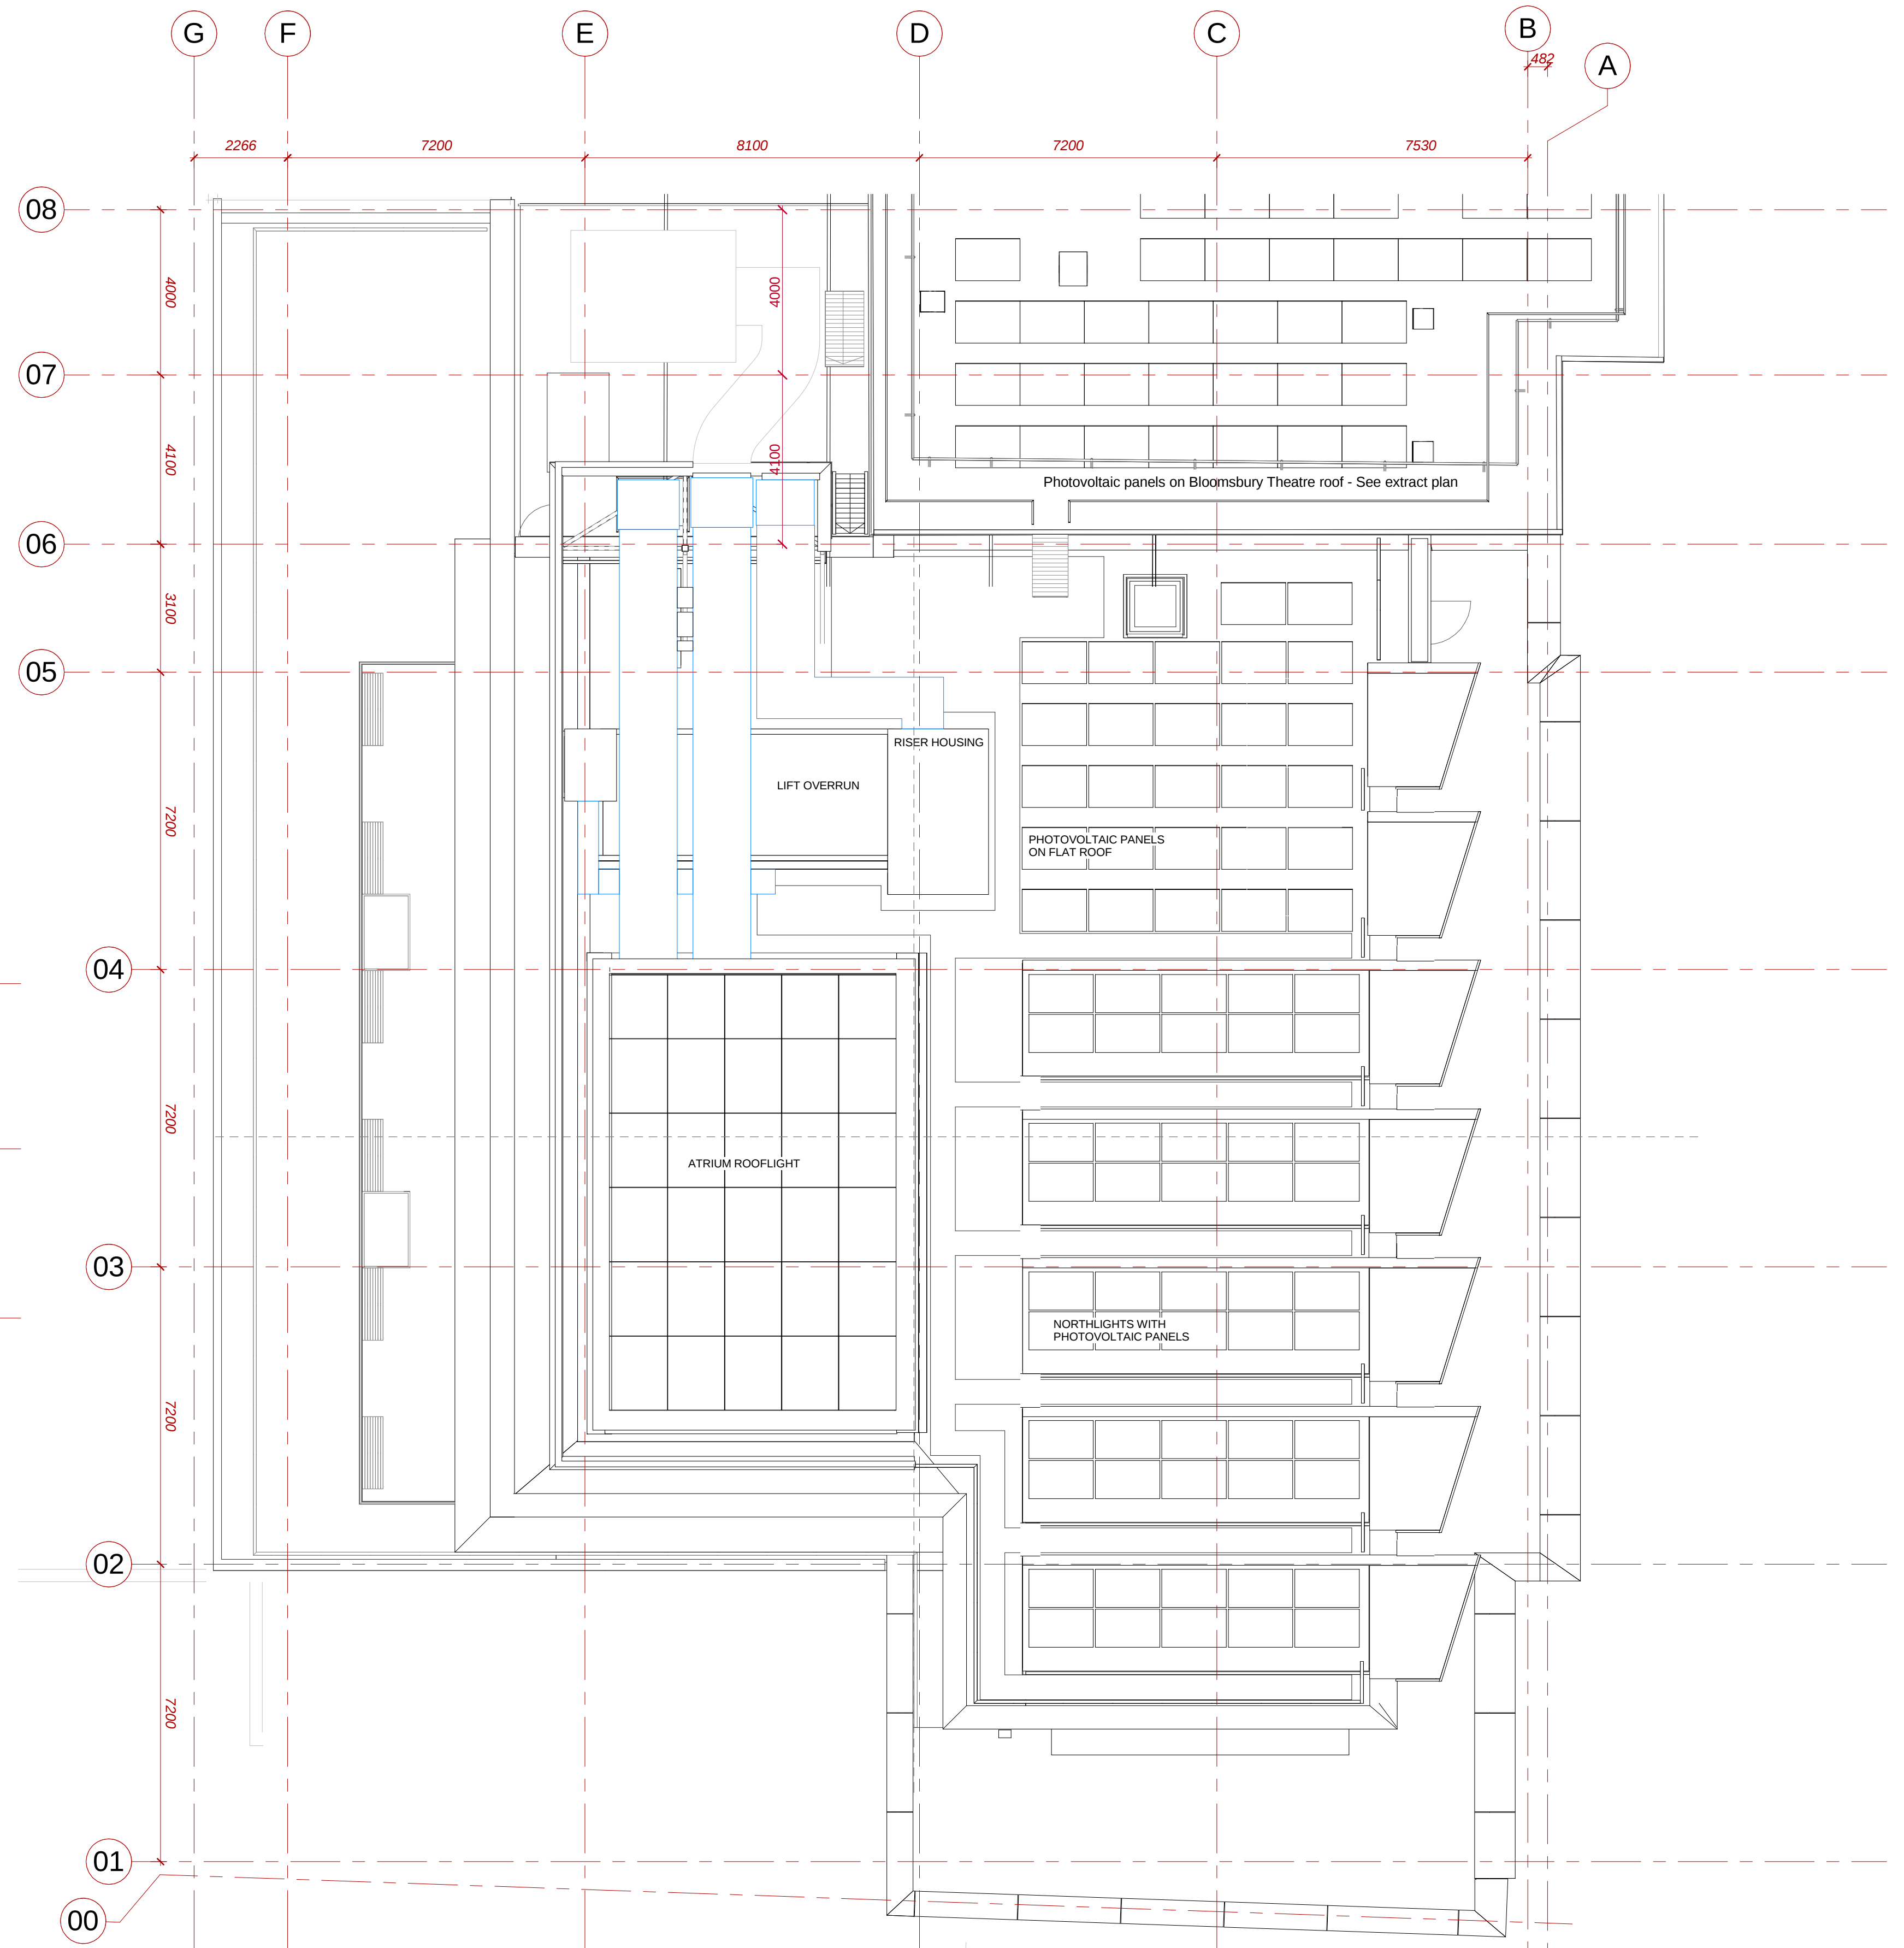

Rev	Date	Description
00	08/06/15	First issue planning application
P01	16/05/16	Planning update: General arrangement drawings updated to show minor amendments
P02	24/04/17	PV Layout revised. General arrangement drawings updated to reflect design development.

Nicholas Hare Architects 3 Barnsbury Square London N1 1JL telephone +44 (0)20 7619 1670 fax +44 (0)20 7619 1671 e-mail 689ucl@nicholas-hare.co.uk		project UCL New Student Centre for University College London title Roof plan
status For Planning To be read in conjunction with all relevant information - do not scale	scale 1:100 size A1	drawing number 031-689-NH-PL-015 rev. P02

